

ADDENDUM NO. 2

TO: PLANS AND SPECIFICATIONS FOR STATE OF MISSOURI

**Renovate Interior
General Headquarters Complex
Jefferson City, MO
PROJECT No.: R2410-01**

Bid Opening Date is: 1:30 PM, Tuesday, August 25, 2026 (Not Changed)

Bidders are hereby informed that the Construction Plans and/or Specifications are modified as follows:

SPECIFICATION CHANGES:

1. Not Applicable

DRAWING CHANGES:

1. P-101: Add Demolition Keynote 10.
2. P-104: Add Demolition Keynote 7.

GENERAL COMMENTS:


1. Bidders needing additional site inspection can schedule times on August 20th & 21st with Troy Wolken at (417) 252-4940 if access to the facility is required.
2. Please contact April Howser, Contract Specialist, at (573) 690-9874 or April.Howser@oa.mo.gov, for questions about bidding procedures, MBE\WBE\SDVE goals, and submittal requirements.
3. The deadline for technical questions was Tuesday, August 18, 2026, at noon.

ATTACHMENTS:


1. P-101 Plumbing Plan Basement
2. P-104 Partial Plumbing Plan First Floor

August 18, 2026 *issued date

END ADDENDUM NO. 2

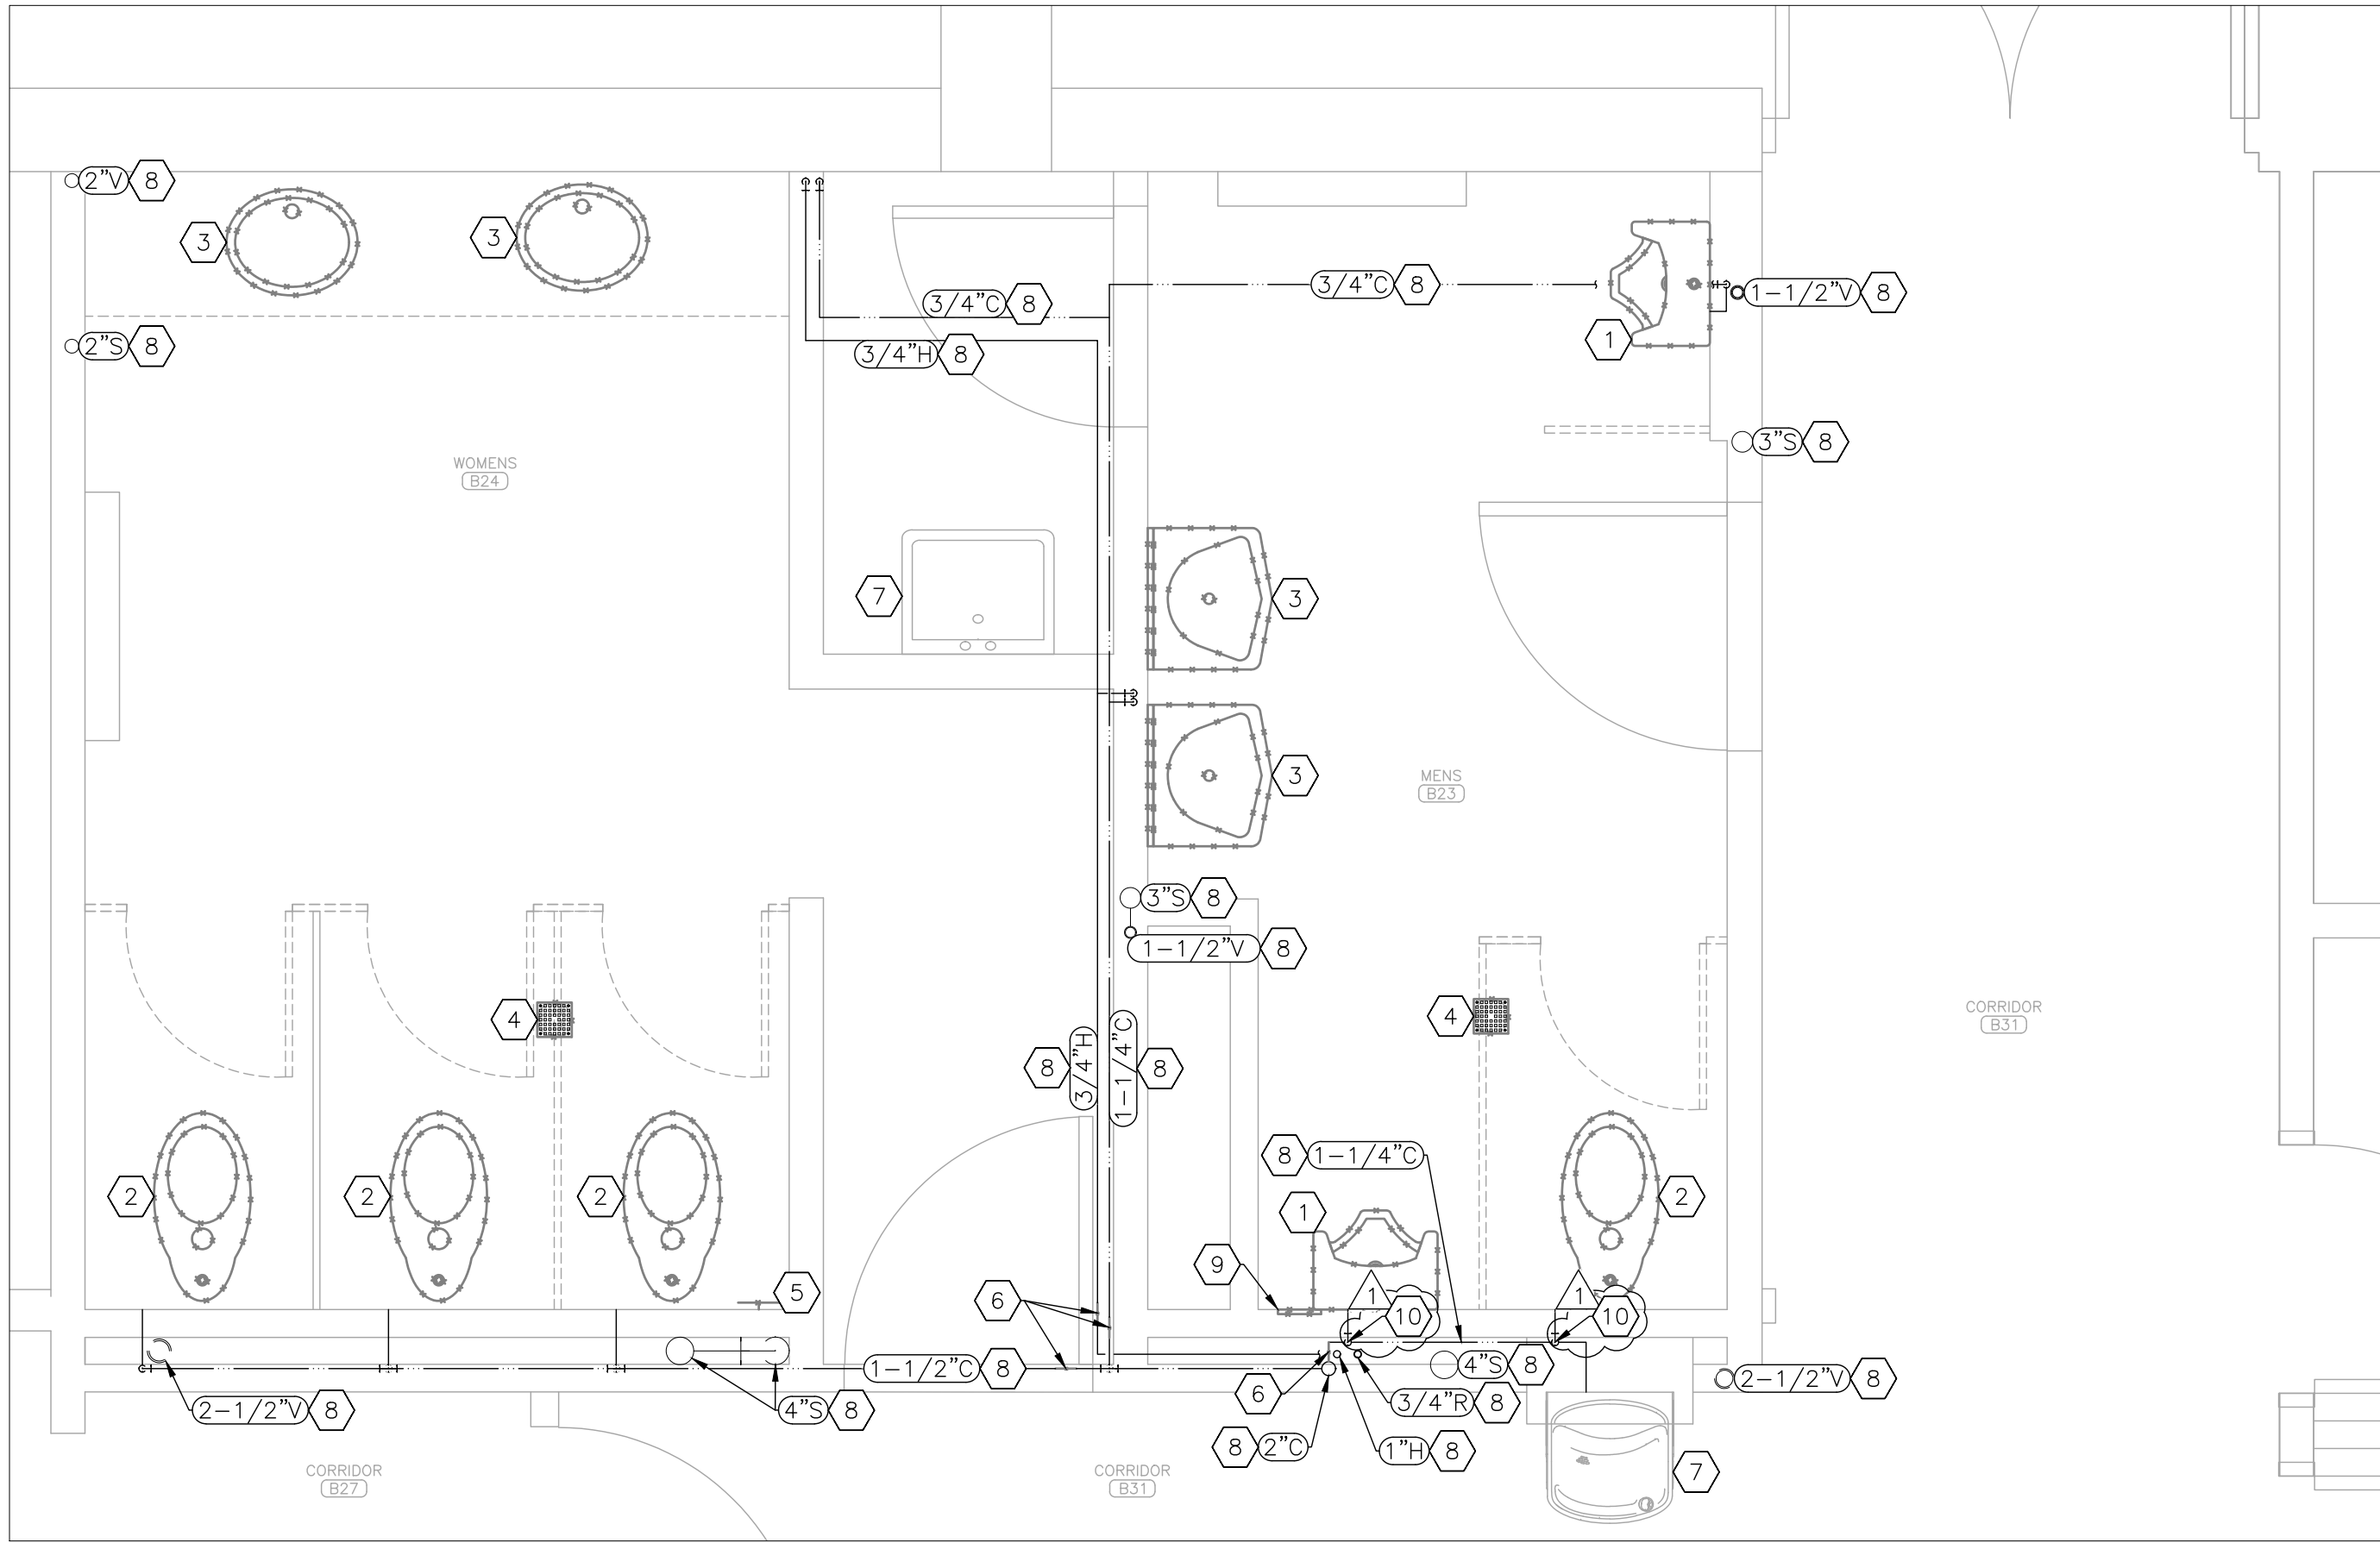

1 ALTERNATE NO. 1 – PLUMBING DEMOLITION PLAN – BASEMENT
SCALE: 1/2" = 1'-0"

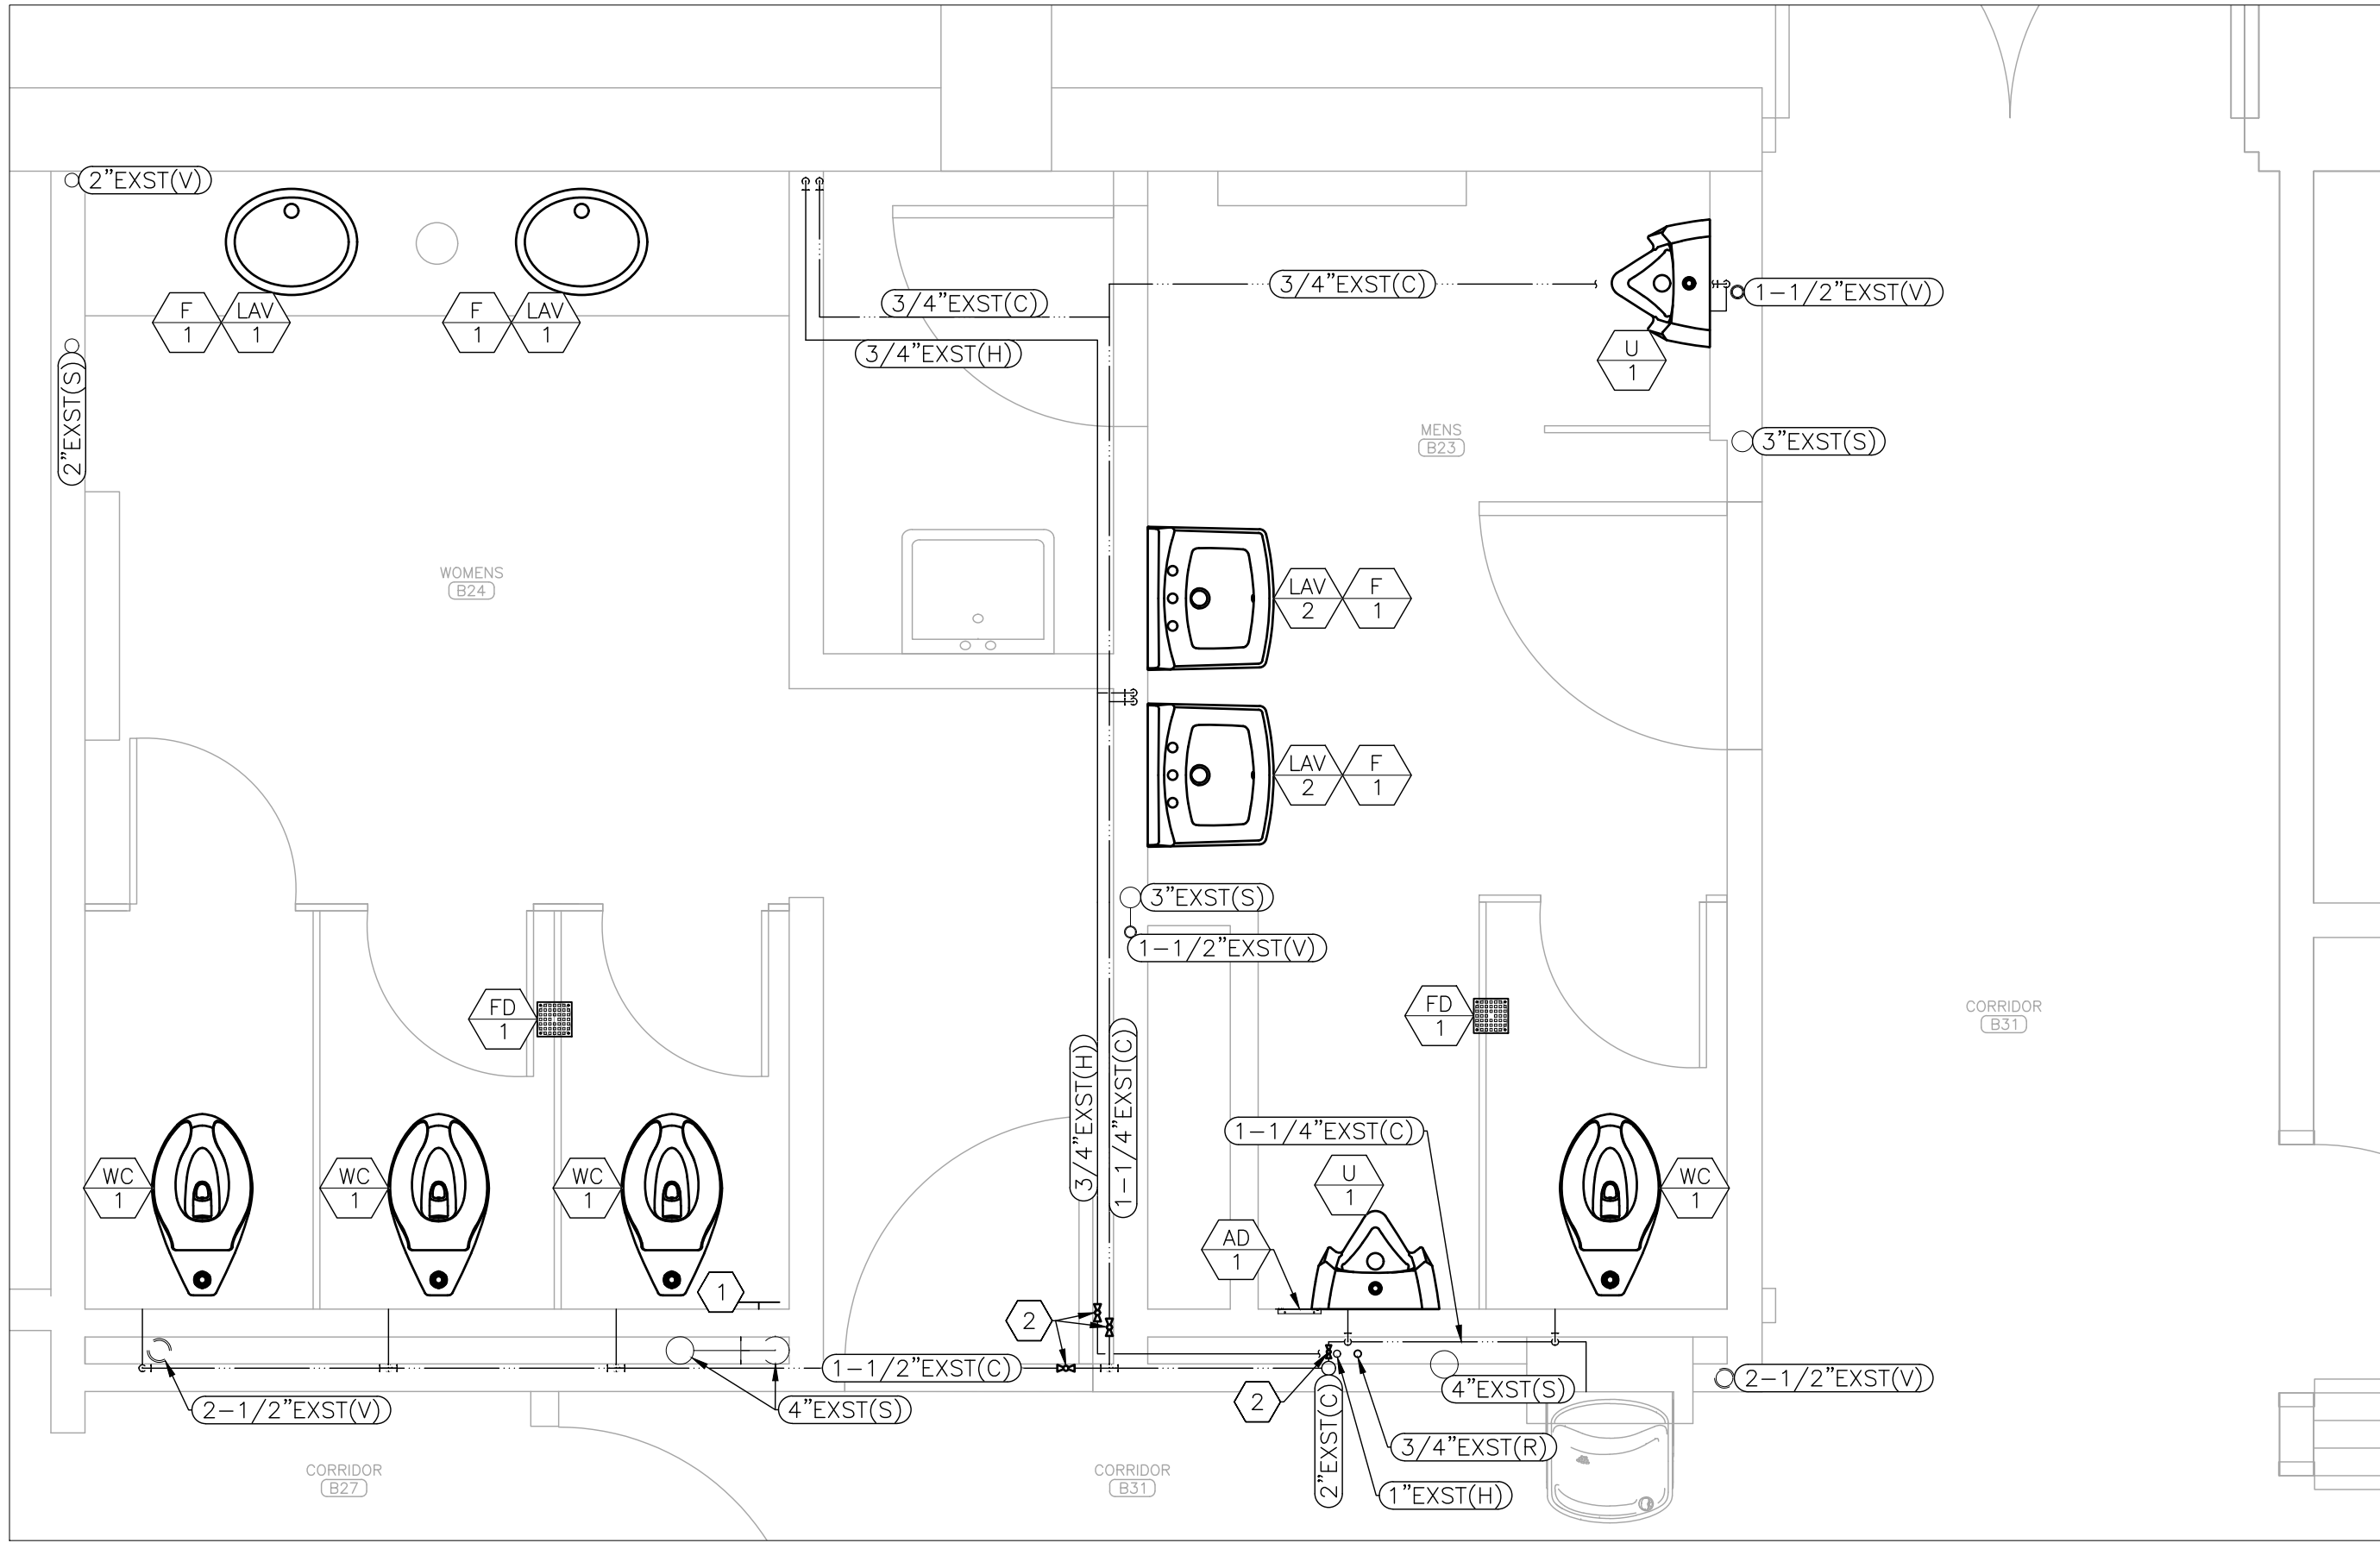

2 ALTERNATE NO. 1 – PLUMBING RENOVATION PLAN – BASEMENT
SCALE: 1/2" = 1'-0"

GENERAL DEMOLITION NOTES

- REFER TO SHEET G-002 FOR GENERAL CONSTRUCTION NOTES.
- PRIOR TO CORE DRILLING FOR ANY FLOOR PENETRATION, COORDINATE WITH GENERAL CONTRACTOR TO SCAN SLAB FOR REINFORCING BARS. REFER TO SHEET G-002 FOR ADDITIONAL INFORMATION.
- REFER TO APPENDIX B OF THE PROJECT MANUAL FOR ASBESTOS INSPECTION RESULTS FOR PLUMBING PIPE FITTINGS. PRIOR TO DEMOLITION ACTIVITIES, CONTRACTOR SHALL LABEL PLUMBING PIPE FITTINGS IDENTIFIED AS CONTAINING ASBESTOS.
- CONTRACTOR IS RESPONSIBLE FOR REPAIRING ANY DAMAGE TO ANY SURFACE IN THE AREA OF CONSTRUCTION THAT IS A RESULT OF CONSTRUCTION ACTIVITY. SURFACE SHALL BE REPAIRED AND FINISHED TO MATCH EXISTING CONDITIONS.

GENERAL RENOVATION NOTES

- FABRICATION, INSTALLATION, AND TESTING OF ALL PLUMBING SYSTEMS SHALL BE IN ACCORDANCE WITH ALL MANUFACTURER INSTALLATION GUIDELINES. REFER TO SHEET G-002 FOR APPLICABLE CODES.
- CONTRACTOR SHALL FIELD VERIFY FOR ANY UNFORESEEN CONFLICTS PRIOR TO FABRICATING PIPE. CONTRACTOR SHALL COORDINATE WITH OTHER DISCIPLINES TO ENSURE ADEQUATE SPACE IS AVAILABLE.
- ALL SINKS AND LAVATORIES SHALL BE PROVIDED WATER HAMMER ARRESTERS ON BOTH HOT AND COLD WATER SUPPLY PIPES. NEW DRINKING FOUNTAIN SHALL BE PROVIDED WITH A WATER HAMMER ARRESTER ON THE COLD WATER SUPPLY. REFER TO DETAIL 1 OF SHEET P-601.

ALTERNATE NO. 1

DEMOLITION NOTES – DETAIL 1

INDICATES KEYED NOTES

- DEMOLISH URINAL AND ASSOCIATED FLUSHOMETER. WATER SUPPLY AND SANITARY DRAIN LOCATIONS TO REMAIN.
- DEMOLISH WATER CLOSET AND ASSOCIATED FLUSHOMETER. WATER SUPPLY AND SANITARY DRAIN LOCATIONS TO REMAIN.
- DEMOLISH LAVATORY, FAUCET, RISERS, AND SUPPLY STOPS. HOT AND COLD WATER SUPPLY AND SANITARY DRAIN LOCATIONS TO REMAIN.
- DEMOLISH FLOOR DRAIN STRAINER. ASSOCIATED SANITARY DRAIN BODY AND PIPE TO REMAIN.
- DEMOLISH WALL CLEANOUT COVER. ASSOCIATED SANITARY CLEANOUT AND DRAIN PIPE TO REMAIN.
- DEMOLISH SECTION OF WATER SUPPLY PIPE FOR ISOLATION VALVE INSTALLATION. WORK SHALL BE PERFORMED OUTSIDE OF NORMAL BUSINESS HOURS.
- EXISTING DRINKING FOUNTAIN/SINK TO REMAIN.
- EXISTING PIPE, RISER, OR STACK TO REMAIN.
- COORDINATE WITH GENERAL CONTRACTOR TO CREATE PENETRATION FOR NEW ACCESS DOOR. PENETRATION TO BE SIZED AS NEEDED TO INSTALL BALL VALVE, BUT NO LESS THAN AS NEEDED FOR ACCESS DOOR INSTALLATION.
- LABEL PLUMBING PIPE FITTINGS AS CONTAINING ASBESTOS.


RENOVATION NOTES – DETAIL 2

INDICATES KEYED NOTES

- PROVIDE NEW STAINLESS STEEL WALL CLEANOUT COVER.
- PROVIDE AND INSTALL LEAD-FREE, QUARTER-TURN, FULL PORT BALL VALVES ON COLD WATER AND HOT WATER PIPES IN ACCESSIBLE LOCATION. WORK SHALL BE PERFORMED OUTSIDE OF NORMAL BUSINESS HOURS.

PLUMBING LEGEND

AA #	DEVICE SCHEDULE TAG
1-1/2"C	PIPE SIZE-TYPE: COLD,HOT,SANITARY,VENT
EXST	EXISTING
BALL VALVE	BALL VALVE
PLUMBING FIXTURE – NEW	PLUMBING FIXTURE – NEW
PLUMBING FIXTURE – EXISTING	PLUMBING FIXTURE – EXISTING
DOMESTIC COLD WATER (C) – EXISTING	DOMESTIC COLD WATER (C) – EXISTING
DOMESTIC HOT WATER (H) – EXISTING	DOMESTIC HOT WATER (H) – EXISTING
HOT WATER RECIRCULATION (R) – EXISTING	HOT WATER RECIRCULATION (R) – EXISTING
ABOVE GRADE SANITARY SEWER (S) – EXST	ABOVE GRADE SANITARY SEWER (S) – EXST
VENT (V) – EXISTING	VENT (V) – EXISTING
EXISTING MATERIALS TO BE REMOVED	EXISTING MATERIALS TO BE REMOVED

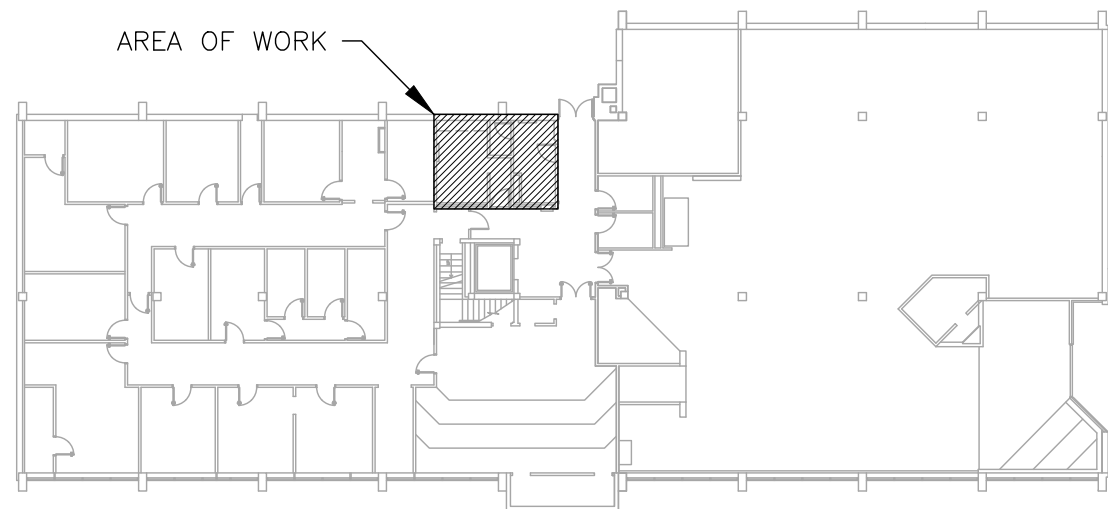

3 AREA MAP – BASEMENT

STATE OF MISSOURI
MIKE KEHOE,
GOVERNOR



Tracie L. Siebeneck - Engineer
MO# PE-2013019114

BID DOCUMENTS

OFFICE OF ADMINISTRATION
DIVISION OF FACILITIES
MANAGEMENT,
DESIGN AND CONSTRUCTION

DEPARTMENT OF
PUBLIC SAFETY
STATE HIGHWAY PATROL

RENOVATE INTERIOR

GENERAL HEADQUARTERS
1510 EAST ELM STREET
JEFFERSON CITY, MO 65101

PROJECT # R2410-01
SITE # 6001
ASSET # 8136001001

REVISION:ADDENDUM NO.2
DATE:08/18/2026
REVISION:
DATE:
REVISION:
DATE:
ISSUE DATE:06/18/2026

CAD DWG FILE:P_R2410-01
DRAWN BY: TS/AH
CHECKED BY: TS
DESIGNED BY: TS/AH


SHEET TITLE:

PLUMBING PLAN
BASEMENT


SHEET NUMBER:

P-101


20 OF 39 SHEETS
06/18/2026

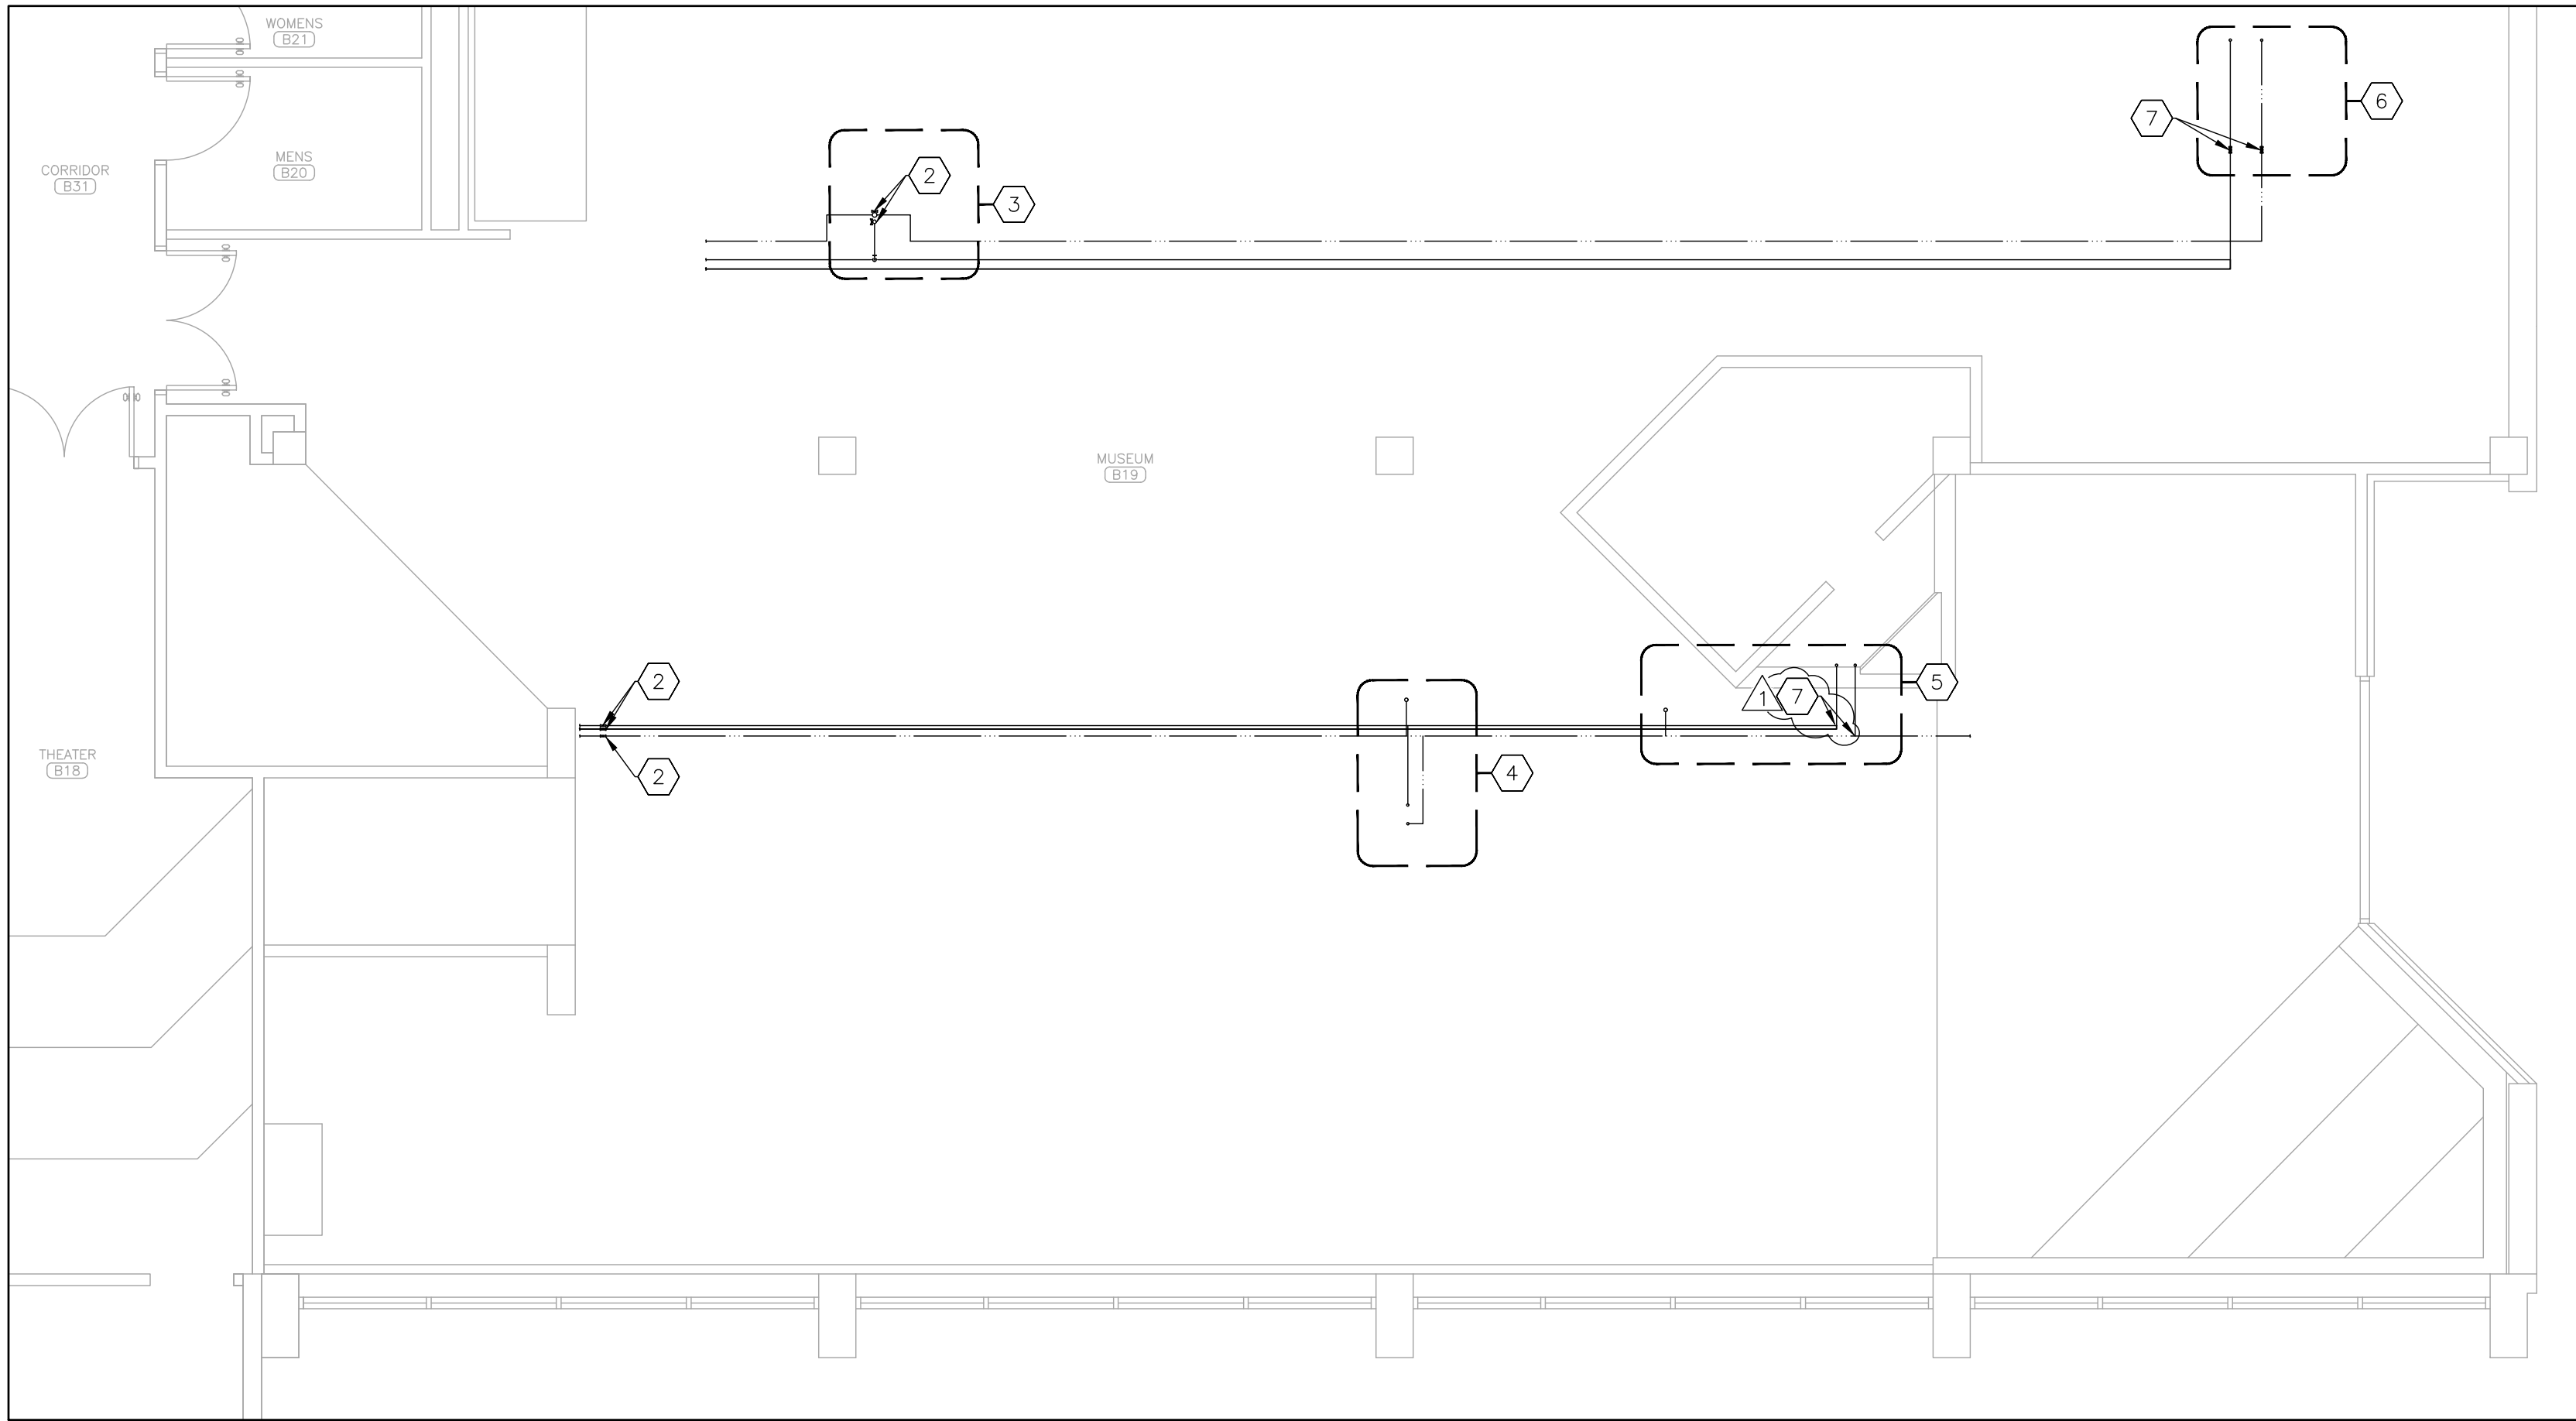

1 PLUMBING PLAN -- BASEMENT ISOLATION VALVES
SCALE: 3/16" = 1'-0"

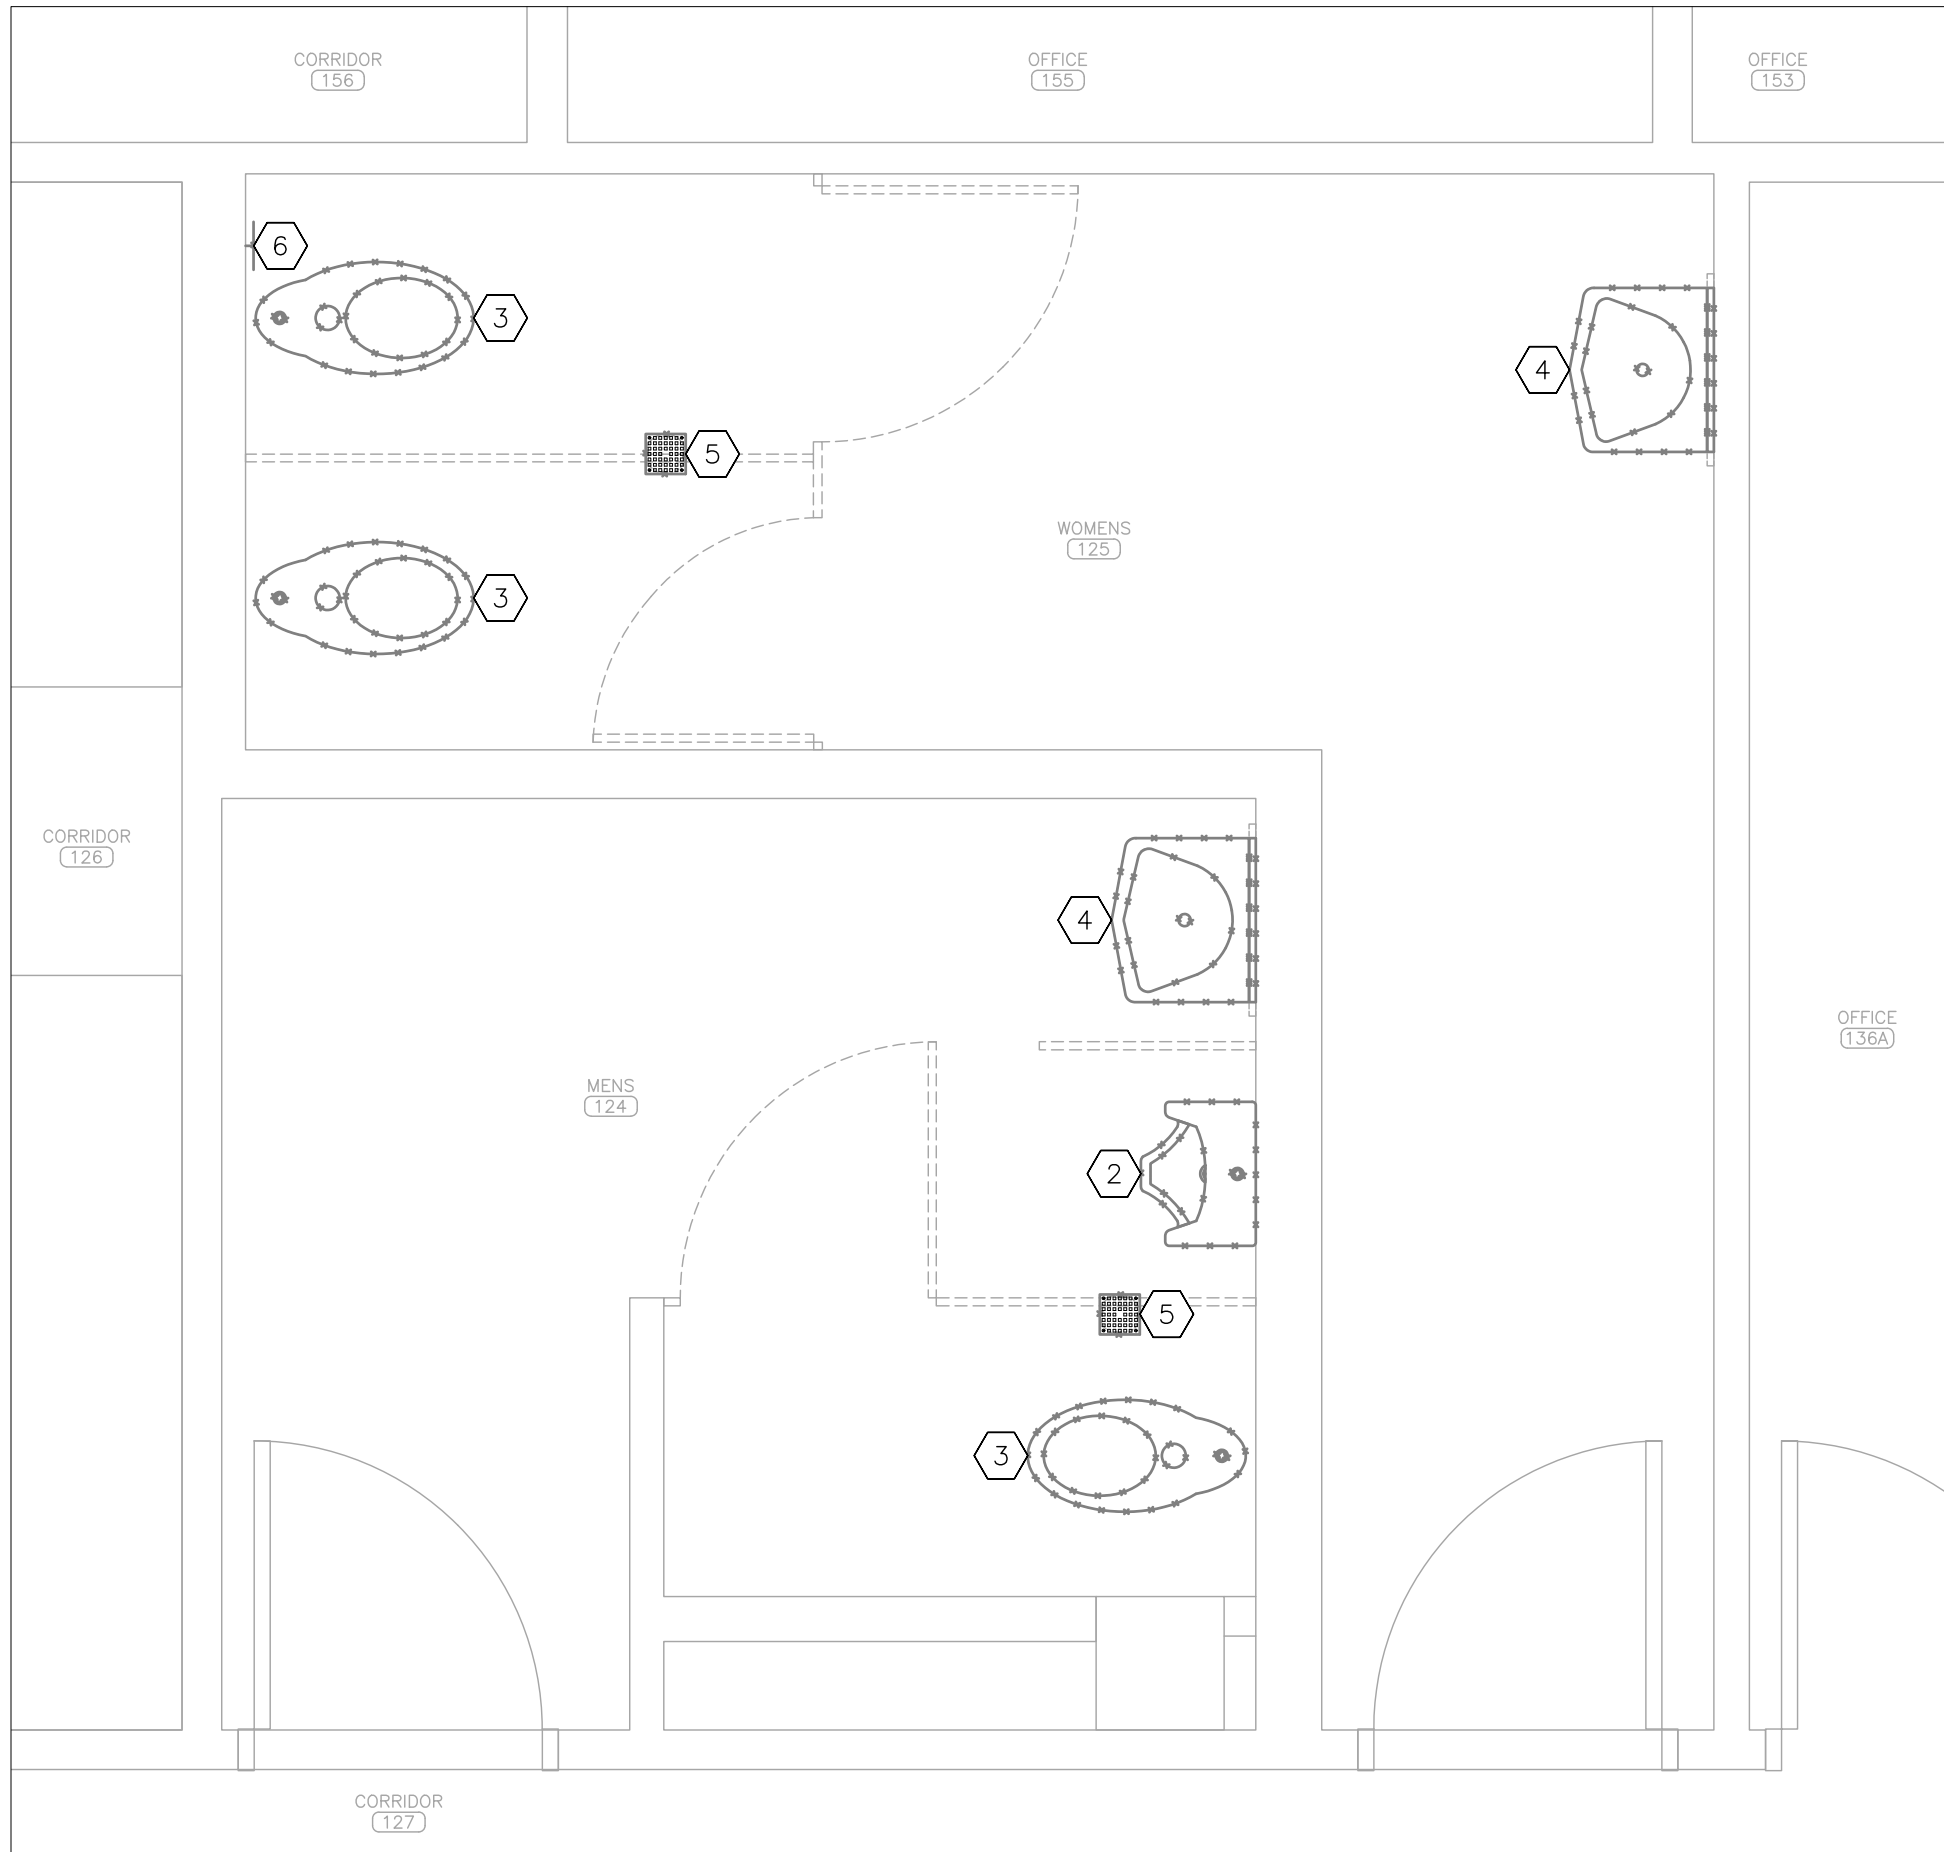

2 PLUMBING DEMOLITION PLAN -- PARTIAL FIRST FLOOR
SCALE: 1/2" = 1'-0"

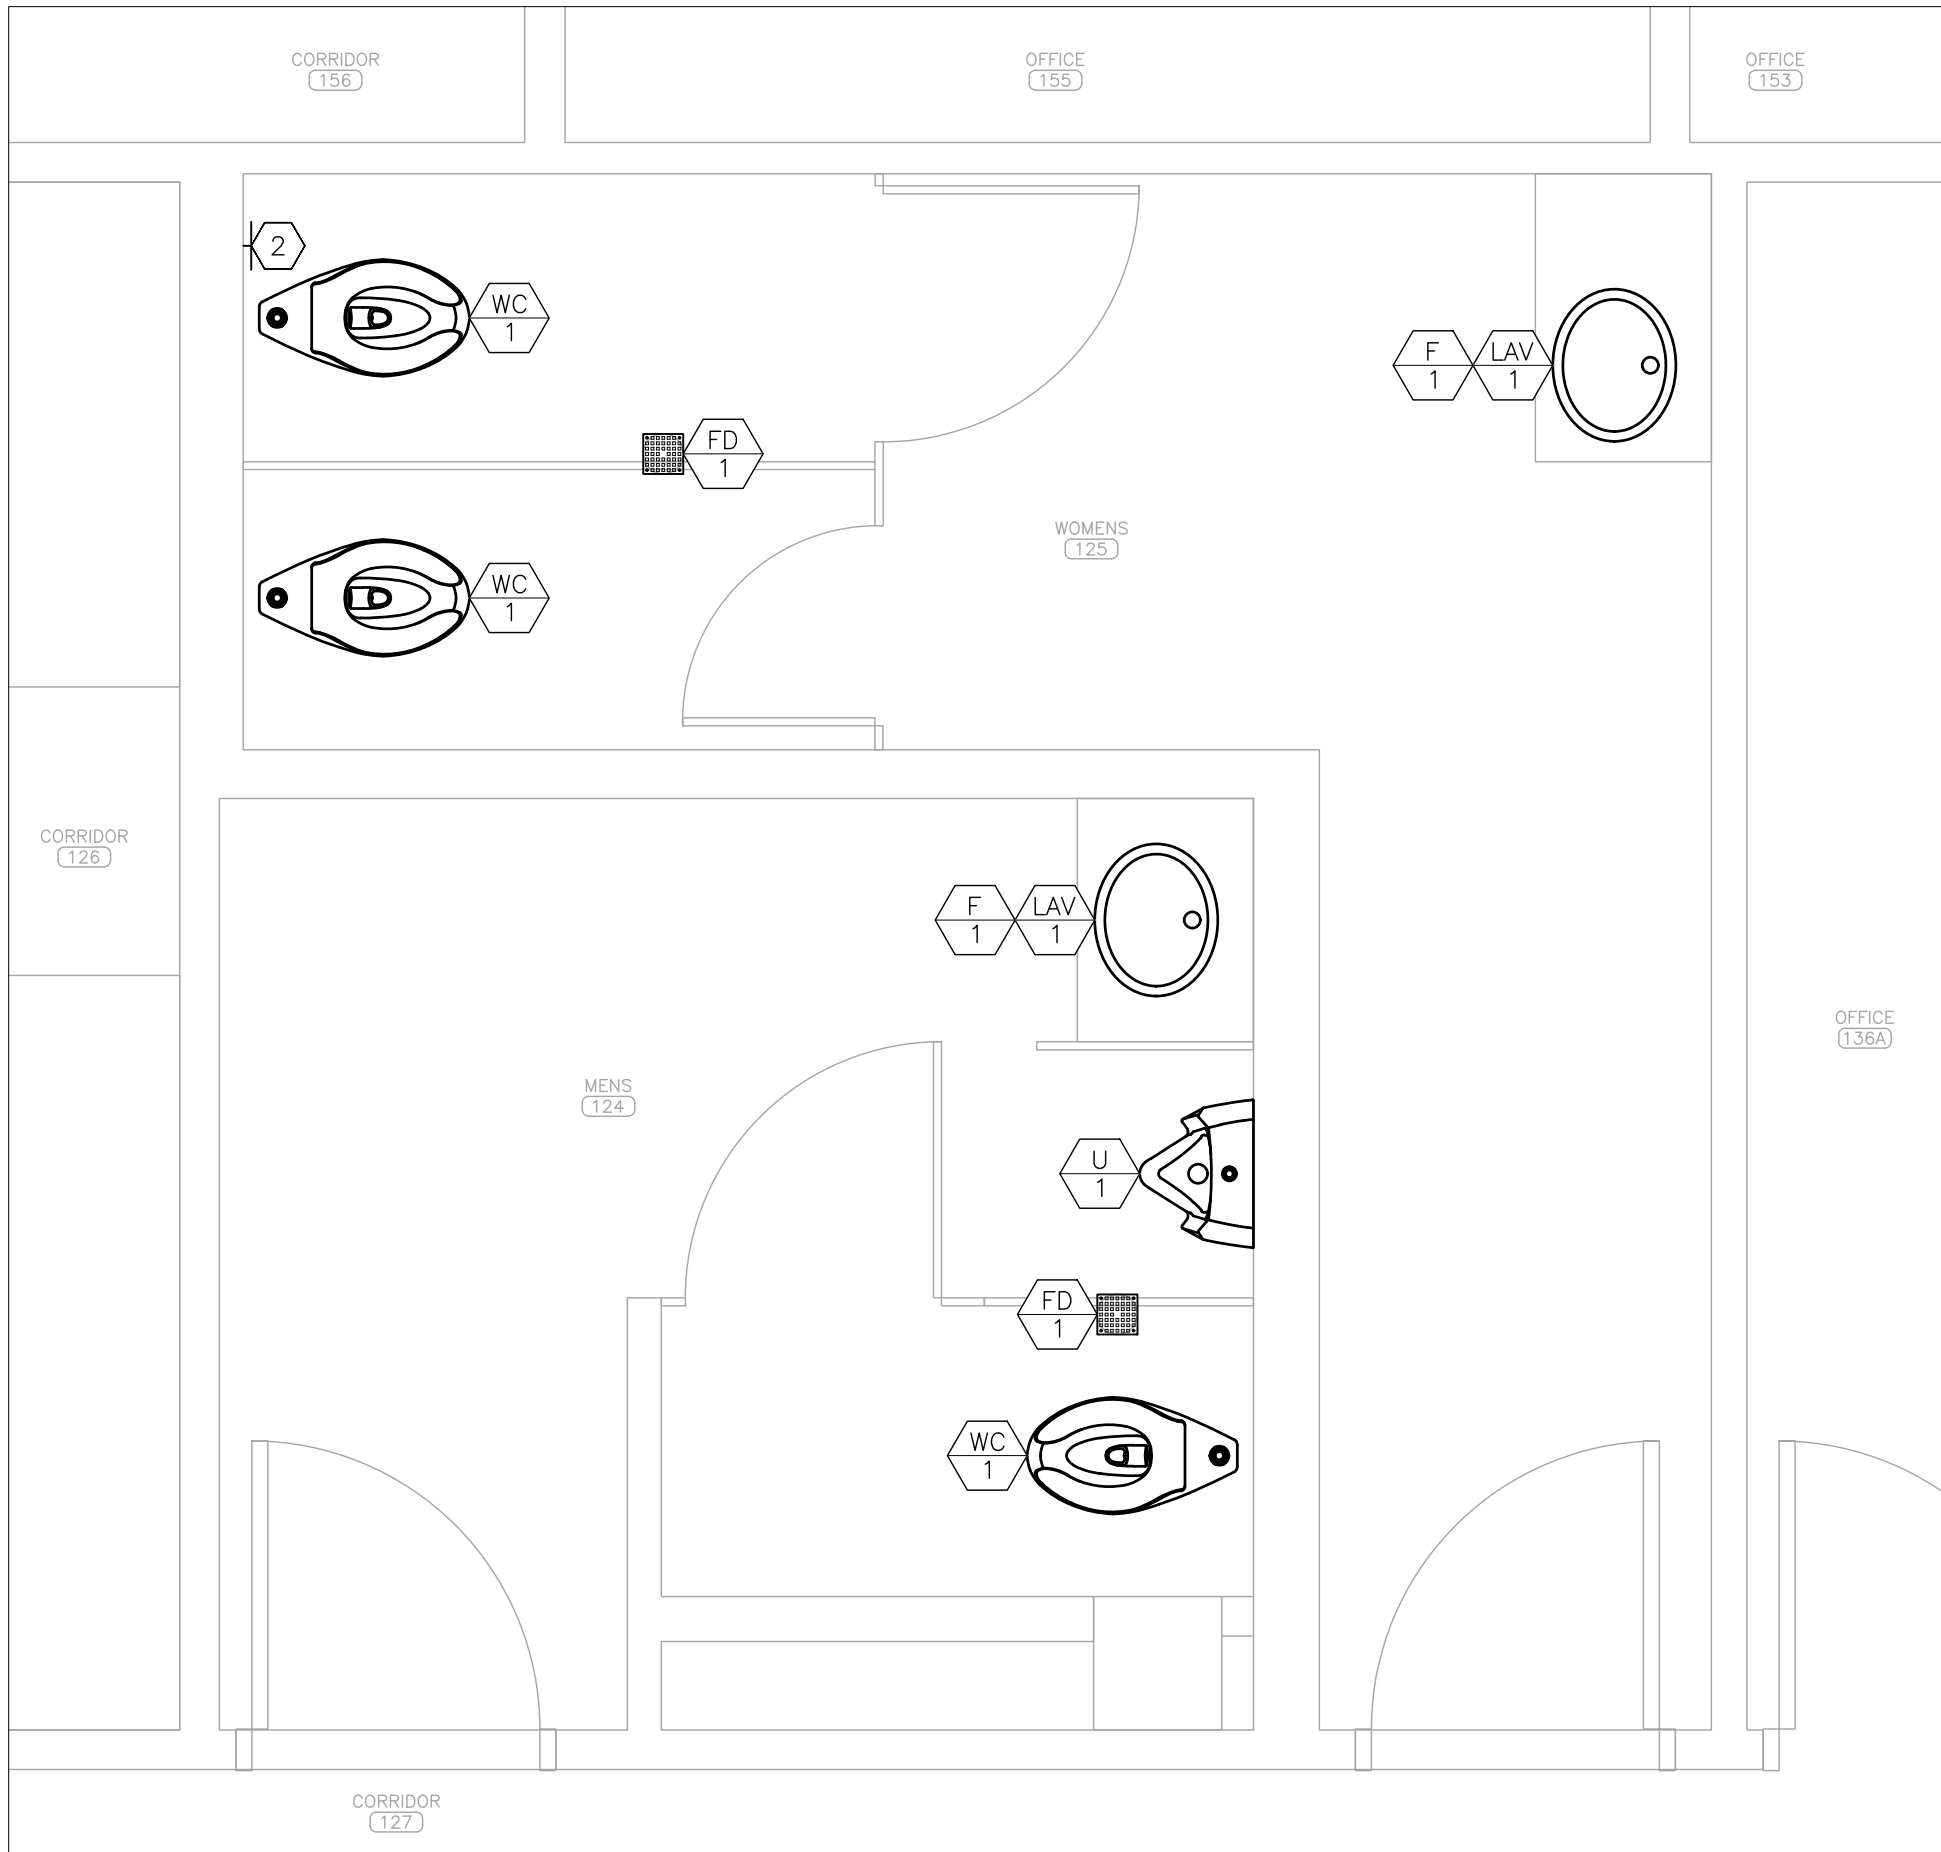

3 PLUMBING RENOVATION PLAN -- PARTIAL FIRST FLOOR
SCALE: 1/2" = 1'-0"

KEYNOTES -- DETAIL 1

INDICATES KEYED NOTES

- 1 REFER TO SHEET P-101 FOR GENERAL NOTES.
- 2 EXISTING COLD AND HOT WATER SUPPLY ISOLATION VALVES.
- 3 COLD AND HOT WATER SUPPLY PIPES SERVING FIRST FLOOR RESTROOMS 124 AND 125. REFER TO DETAILS 2 AND 3 THIS SHEET.
- 4 COLD AND HOT WATER SUPPLY PIPES SERVING FIRST FLOOR RESTROOM 134A. REFER TO DETAILS 1 AND 3 ON SHEET P-105.
- 5 COLD AND HOT WATER SUPPLY PIPES SERVING FIRST FLOOR RESTROOM 136A. REFER TO DETAILS 1 AND 3 ON SHEET P-105.
- 6 COLD AND HOT WATER SUPPLY PIPES SERVING FIRST FLOOR RESTROOM 142A. REFER TO DETAILS 2 AND 4 ON SHEET P-105.
- 7 DEMOLISH SECTION OF WATER SUPPLY PIPE FOR BALL VALVE INSTALLATION. PROVIDE AND INSTALL LEAD-FREE, QUARTER-TURN, FULL PORT BALL VALVES ON COLD WATER AND HOT WATER PIPES IN ACCESSIBLE LOCATION. WORK SHALL BE PERFORMED OUTSIDE OF NORMAL BUSINESS HOURS.

DEMOLITION NOTES -- DETAIL 2

INDICATES KEYED NOTES

- 1 REFER TO SHEET P-101 FOR GENERAL DEMOLITION NOTES.
- 2 DEMOLISH URINAL AND ASSOCIATED FLUSHOMETER. WATER SUPPLY AND SANITARY DRAIN LOCATIONS TO REMAIN.
- 3 DEMOLISH WATER CLOSET AND ASSOCIATED FLUSHOMETER. WATER SUPPLY AND SANITARY DRAIN LOCATIONS TO REMAIN.
- 4 DEMOLISH LAVATORY, FAUCET, RISERS, AND SUPPLY STOPS. HOT AND COLD WATER SUPPLY AND SANITARY DRAIN LOCATIONS TO REMAIN.
- 5 DEMOLISH FLOOR DRAIN STRAINER. ASSOCIATED SANITARY DRAIN BODY AND PIPE TO REMAIN.
- 6 DEMOLISH WALL CLEANOUT COVER. ASSOCIATED SANITARY CLEANOUT AND DRAIN PIPE TO REMAIN.
- 7 LABEL PLUMBING PIPE FITTINGS AS CONTAINING ASBESTOS.


RENOVATION NOTES -- DETAIL 3

INDICATES KEYED NOTES


- 1 REFER TO SHEET P-101 FOR GENERAL RENOVATION NOTES.
- 2 PROVIDE NEW STAINLESS STEEL WALL CLEANOUT COVER.

PLUMBING LEGEND

AA #	DEVICE SCHEDULE TAG
	BALL VALVE
	BALL VALVE LOCATED IN RISER
	PLUMBING FIXTURE -- NEW
	DOMESTIC COLD WATER (C) -- NEW
	DOMESTIC COLD WATER (C) -- EXISTING
	DOMESTIC HOT WATER (H) -- NEW
	DOMESTIC HOT WATER (H) -- EXISTING
	HOT WATER RECIRCULATION (R) -- EXISTING
	EXISTING MATERIALS TO BE REMOVED

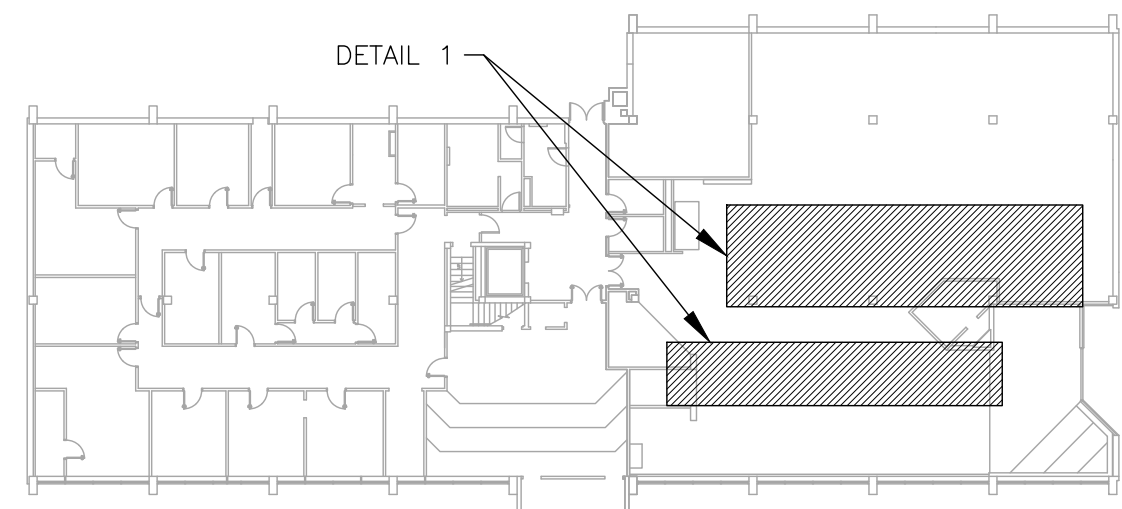

4 AREA MAP -- BASEMENT

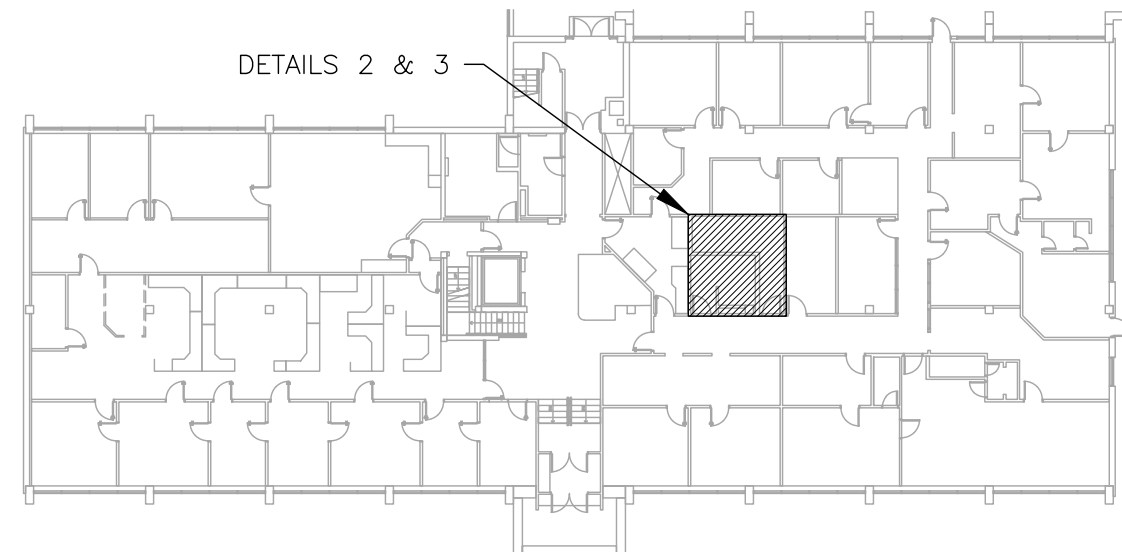

5 AREA MAP -- FIRST FLOOR

STATE OF MISSOURI
MIKE KEHOE,
GOVERNOR



Tracie L. Siebeneck - Engineer
MO# PE-2013019114

BID DOCUMENTS

OFFICE OF ADMINISTRATION
DIVISION OF FACILITIES
MANAGEMENT,
DESIGN AND CONSTRUCTION

DEPARTMENT OF
PUBLIC SAFETY
STATE HIGHWAY PATROL

RENOVATE INTERIOR

GENERAL HEADQUARTERS
1510 EAST ELM STREET
JEFFERSON CITY, MO 65101

PROJECT # R2410-01
SITE # 6001
ASSET # 8136001001

REVISION: ADDENDUM NO. 2
DATE: 08/18/2026
REVISION: _____
DATE: _____
REVISION: _____
DATE: _____
ISSUE DATE: 06/18/2026

CAD DWG FILE: P_R2410-01
DRAWN BY: TS/AH
CHECKED BY: TS
DESIGNED BY: TS/AH

SHEET TITLE:

PARTIAL
PLUMBING PLAN
FIRST FLOOR

SHEET NUMBER:

P-104

23 OF 39 SHEETS
06/18/2026