


RENOVATE INTERIOR GENERAL HEADQUARTERS BUILDING JEFFERSON CITY , MISSOURI

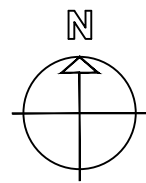

1 SITE LOCATION PLAN
SCALE: N.T.S.



OWNER: STATE OF MISSOURI
MIKE KEHOE,
GOVERNOR

DEPARTMENT OF
PUBLIC SAFETY/ STATE HIGHWAY PATROL

PROJECT
MANAGEMENT: OFFICE OF ADMINISTRATION
DIVISION OF FACILITIES MANAGEMENT,
DESIGN AND CONSTRUCTION

DESIGNER: STATE OF MISSOURI
OA-FMDC PROJECT DESIGN UNIT
301 W. HIGH STREET
JEFFERSON CITY, MO. 65101

PROJECT NUMBER: R2410-01

ASSET NUMBER: 8136001001

SHEET NUMBER:

G-001


1 OF 39 SHEETS
6/18/2026

- BUILDING CODE NOTES:**
1. NEW WORK INSTALLATION TO FOLLOW:
 - IBC - INTERNATIONAL BUILDING CODE; 2018
 - ADA STANDARDS FOR ACCESSIBLE DESIGN; 2010
 - IPC - INTERNATIONAL PLUMBING CODE; 2018
 - IMC - INTERNATIONAL MECHANICAL CODE; 2018
 - NFPA 70 - NATIONAL ELECTRIC CODE (NEC); 2017
 - NFPA 72 - NATIONAL FIRE ALARM AND SIGNALING CODE; 2016
 - NFPA 101 - LIFE SAFETY CODE; 2018


- SHEET INDEX:**
- G-001 - COVERSHEET
G-002 - SHEET INDEX & PHASING PLANS
A-101 - GHQ BASEMENT FLOOR PLAN
A-102 - GHQ FIRST FLOOR PLAN
A-103 - GHQ SECOND FLOOR PLAN
A-201 - RESTROOM ELEVATIONS
A-202 - RESTROOM ELEVATIONS
A-203 - RESTROOM ELEVATIONS
A-204 - FIRST FLOOR RESTROOM ELEVATIONS
A-205 - SECOND FLOOR RESTROOM ELEVATIONS
A-206 - SECOND FLOOR RESTROOM ELEVATIONS
A-401 - BASEMENT RESTROOM ENLARGED PLANS
A-402 - FIRST FLOOR RESTROOM ENLARGED PLANS
A-403 - FIRST FLOOR RESTROOM ENLARGED PLANS
A-404 - FIRST FLOOR RESTROOM ENLARGED PLANS
A-405 - SECOND FLOOR RESTROOM ENLARGED PLANS
A-406 - SECOND FLOOR RESTROOM ENLARGED PLANS
A-501 - DETAILS
A-601 - SCHEDULES
P-101 - PLUMBING PLAN - BASEMENT
P-102 - PARTIAL PLUMBING PLAN - FIRST FLOOR
P-103 - PARTIAL PLUMBING PLAN - SECOND FLOOR
P-104 - PARTIAL PLUMBING PLAN - FIRST FLOOR
P-105 - PARTIAL PLUMBING PLAN - FIRST FLOOR
P-106 - PARTIAL PLUMBING PLAN - SECOND FLOOR
P-601 - PLUMBING SCHEDULES AND DETAILS
M-101 - MECHANICAL PLAN - BASEMENT
M-102 - PARTIAL MECHANICAL PLAN - FIRST FLOOR
M-103 - PARTIAL MECHANICAL PLAN - SECOND FLOOR
M-104 - PARTIAL MECHANICAL PLAN - FIRST FLOOR
M-105 - PARTIAL MECHANICAL PLAN - FIRST FLOOR
M-106 - PARTIAL MECHANICAL PLAN - SECOND FLOOR
M-601 - MECHANICAL SCHEDULES AND DETAILS
E-101 - ELECTRICAL PLAN - BASEMENT
E-102 - PARTIAL ELECTRICAL PLAN - FIRST FLOOR
E-103 - PARTIAL ELECTRICAL PLAN - SECOND FLOOR
E-104 - PARTIAL ELECTRICAL PLAN - FIRST FLOOR
E-105 - PARTIAL ELECTRICAL PLAN - FIRST FLOOR
E-106 - PARTIAL ELECTRICAL PLAN - SECOND FLOOR

- GENERAL NOTES:**
1. DEMOLITION DRAWINGS AND PLANS ARE BASED ON FIELD TAKE-OFF AND ORIGINAL DRAWINGS. CONTRACTOR IS RESPONSIBLE FOR FIELD VERIFYING EXISTING CONDITIONS PRIOR TO BIDDING AND/OR CONSTRUCTION. MINOR DIFFERENCES BETWEEN WHAT IS SHOWN AND THE ACTUAL DIMENSIONS WILL NOT BE CONSIDERED BASIS FOR A CONTRACT CHANGE.
 2. LIMIT USE OF PROJECT SITE TO WORK IN AREAS INDICATED. DO NOT DISTURB PORTIONS OF PROJECT SITE BEYOND AREAS IN WHICH THE WORK IS INDICATED.
 3. PROTECT ALL FIXED EQUIPMENT, FURNITURE, AND FINISHES DURING CONSTRUCTION.
 4. OWNER WILL OCCUPY EXISTING BUILDING DURING THE ENTIRE CONSTRUCTION PERIOD. COOPERATE WITH OWNER DURING CONSTRUCTION OPERATIONS TO MINIMIZE CONFLICTS AND FACILITATE OWNER USAGE. PERFORM WORK SO AS NOT TO INTERFERE WITH OWNER'S DAY TO DAY OPERATIONS.
 5. PROVIDE CONSTRUCTION BARRICADES AND SIGNAGE AS NECESSARY FOR THE PROJECT.
 6. DO NOT INTERRUPT UTILITIES SERVING FACILITIES OCCUPIED BY OWNER OR OTHERS UNLESS PERMITTED. NOTIFY THE OWNER NOT LESS THAN 72 HOURS IN ADVANCE OF ACTIVITIES THAT WILL AFFECT OWNER'S OPERATIONS.
 7. PROTECT EXISTING ADJACENT FINISHES TO REMAIN AGAINST DAMAGE FROM DEMOLITION ACTIVITIES.
 8. REMOVE CONSTRUCTION DEBRIS FROM SITE AND DISPOSE OF IN A LAWFUL MANNER.
 9. CONTRACTOR SHALL COMPLETE EACH WORK PHASE IN ITS ENTIRETY BEFORE PROCEEDING TO NEXT NUMBERED WORK PHASE.
 10. CONTRACTOR SHALL COORDINATE WITH CONSTRUCTION ADMINISTRATOR FOR ITEMS REMOVED BY OWNER WITHIN AREAS OF WORK. OWNER WILL REMOVE AND REPLACE THE FOLLOWING ITEMS: PERSONAL BELONGINGS, DIGITAL DISPLAYS, AND MEDIA INSTALLATIONS.
 11. EXISTING FLOORING WAS FOUND TO CONTAIN ASBESTOS. NEW FLOOR TO ENCAPSULATE WITHOUT DISTURBING THE HAZARDOUS MATERIAL, UNLESS OTHERWISE NOTED. REFER TO APPENDIX A OF THE PROJECT MANUAL FOR REPORT OF FINDINGS. IF SUSPECT MATERIALS ARE ENCOUNTERED OR DISTURBED, STOP WORK AND NOTIFY THE ARCHITECT/OWNER IMMEDIATELY.
 12. EXISTING WALL TILE WAS FOUND TO CONTAIN LEAD-BASED PAINT. MATERIALS SHOULD BE DISPOSED OF PROPERLY. FOLLOW OSHA SAFE WORK PRACTICES DURING DEMOLITION. LEAD-BASED PAINT COMPONENTS SHOULD BE FULLY DISCLOSED TO ANY LANDFILL OR RECYCLING FACILITY DESTINATIONS. REFER TO APPENDIX A OF THE PROJECT MANUAL FOR REPORT OF FINDINGS.
 13. GENERAL CONTRACTOR SHALL USE GROUND PENETRATING RADAR (GPR) OR OTHER APPROVED NON-DESTRUCTIVE METHOD TO DETECT THE LOCATION OF REINFORCING BARS IN FLOOR SLABS BEFORE CORE DRILLING FOR PIPE PENETRATIONS. COORDINATE WITH PLUMBING CONTRACTORS TO ADJUST PENETRATION LOCATIONS AS NEEDED TO AVOID CUTTING REINFORCING BARS. NOTIFY THE ENGINEER PRIOR TO CORE DRILLING IF CUTTING REINFORCING BARS IS UNAVOIDABLE. REFER TO PLUMBING PLANS FOR PENETRATION LOCATIONS.
- MECHANICAL, ELECTRICAL, AND PLUMBING GENERAL NOTES:**
1. COORDINATE WITH EXISTING SYSTEMS WHICH SHALL REMAIN IN OPERATION DURING DEMOLITION CONSTRUCTION PHASES. INSTALL TEMPORARY CAPS AT TERMINATION POINTS OF EXISTING PIPE, DUCT, AND CONDUIT TO REMAIN DURING DEMOLITION PHASES.


- PHASING INDEX:**
- PHASE 1 - FLOORING AND FINISHES
AREAS OF WORK TO BE DONE AFTER
BUSINESS HOURS. COORD. WITH STAFF
- PHASE 2 - FLOORING AND FINISHES
AREAS OF WORK TO BE DONE AFTER
BUSINESS HOURS. COORD. WITH STAFF
- PHASE 3 - FLOORING AND FINISHES
- PHASE 4 - FLOORING AND FINISHES
- PHASE 5 - FLOORING AND FINISHES
- PHASE 6 - RESTROOMS
- PHASE 7 - RESTROOMS
- PHASE 8 - RESTROOMS
- PHASE 9 - RESTROOMS

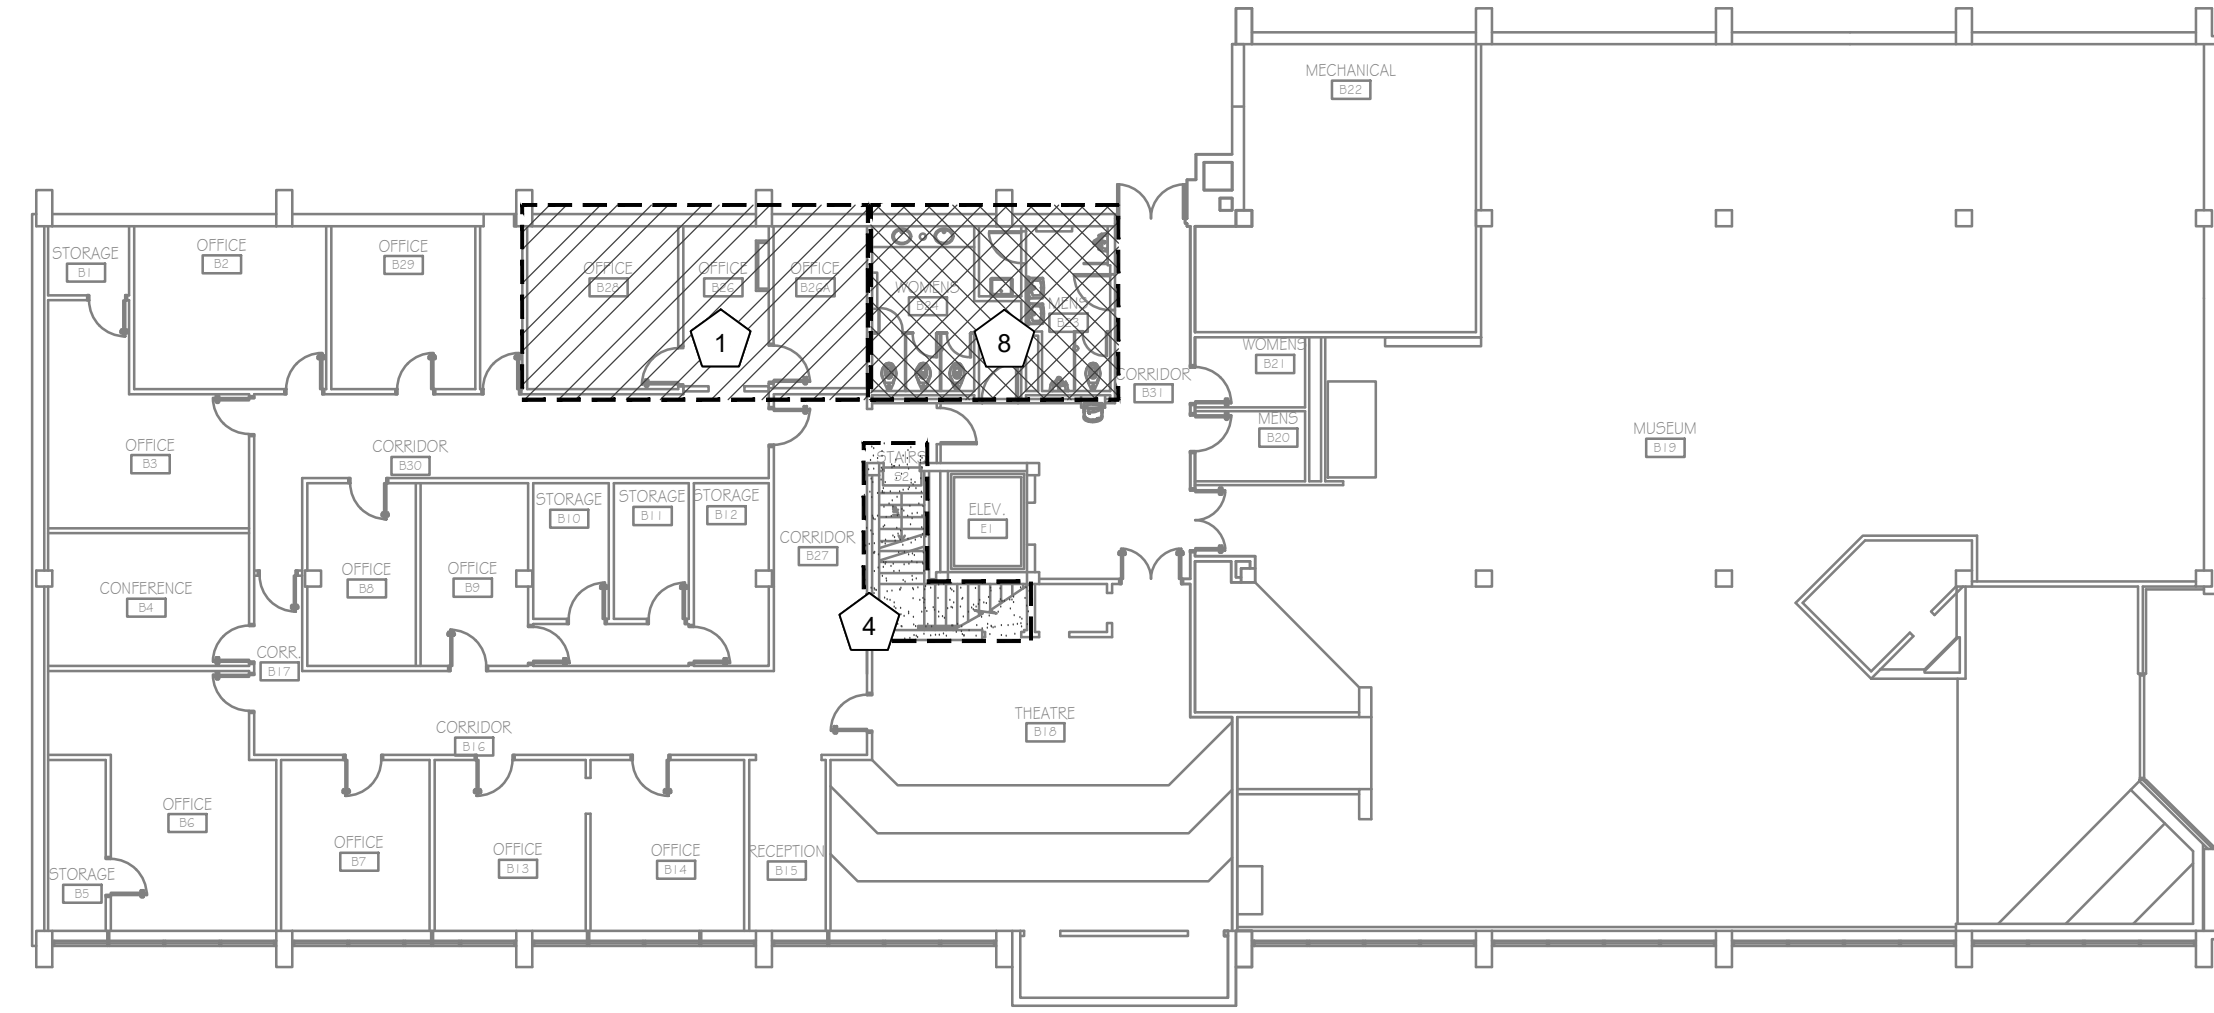


2 OVERALL PHASING PLAN — BASEMENT
SCALE: 1/16" = 1'-0"

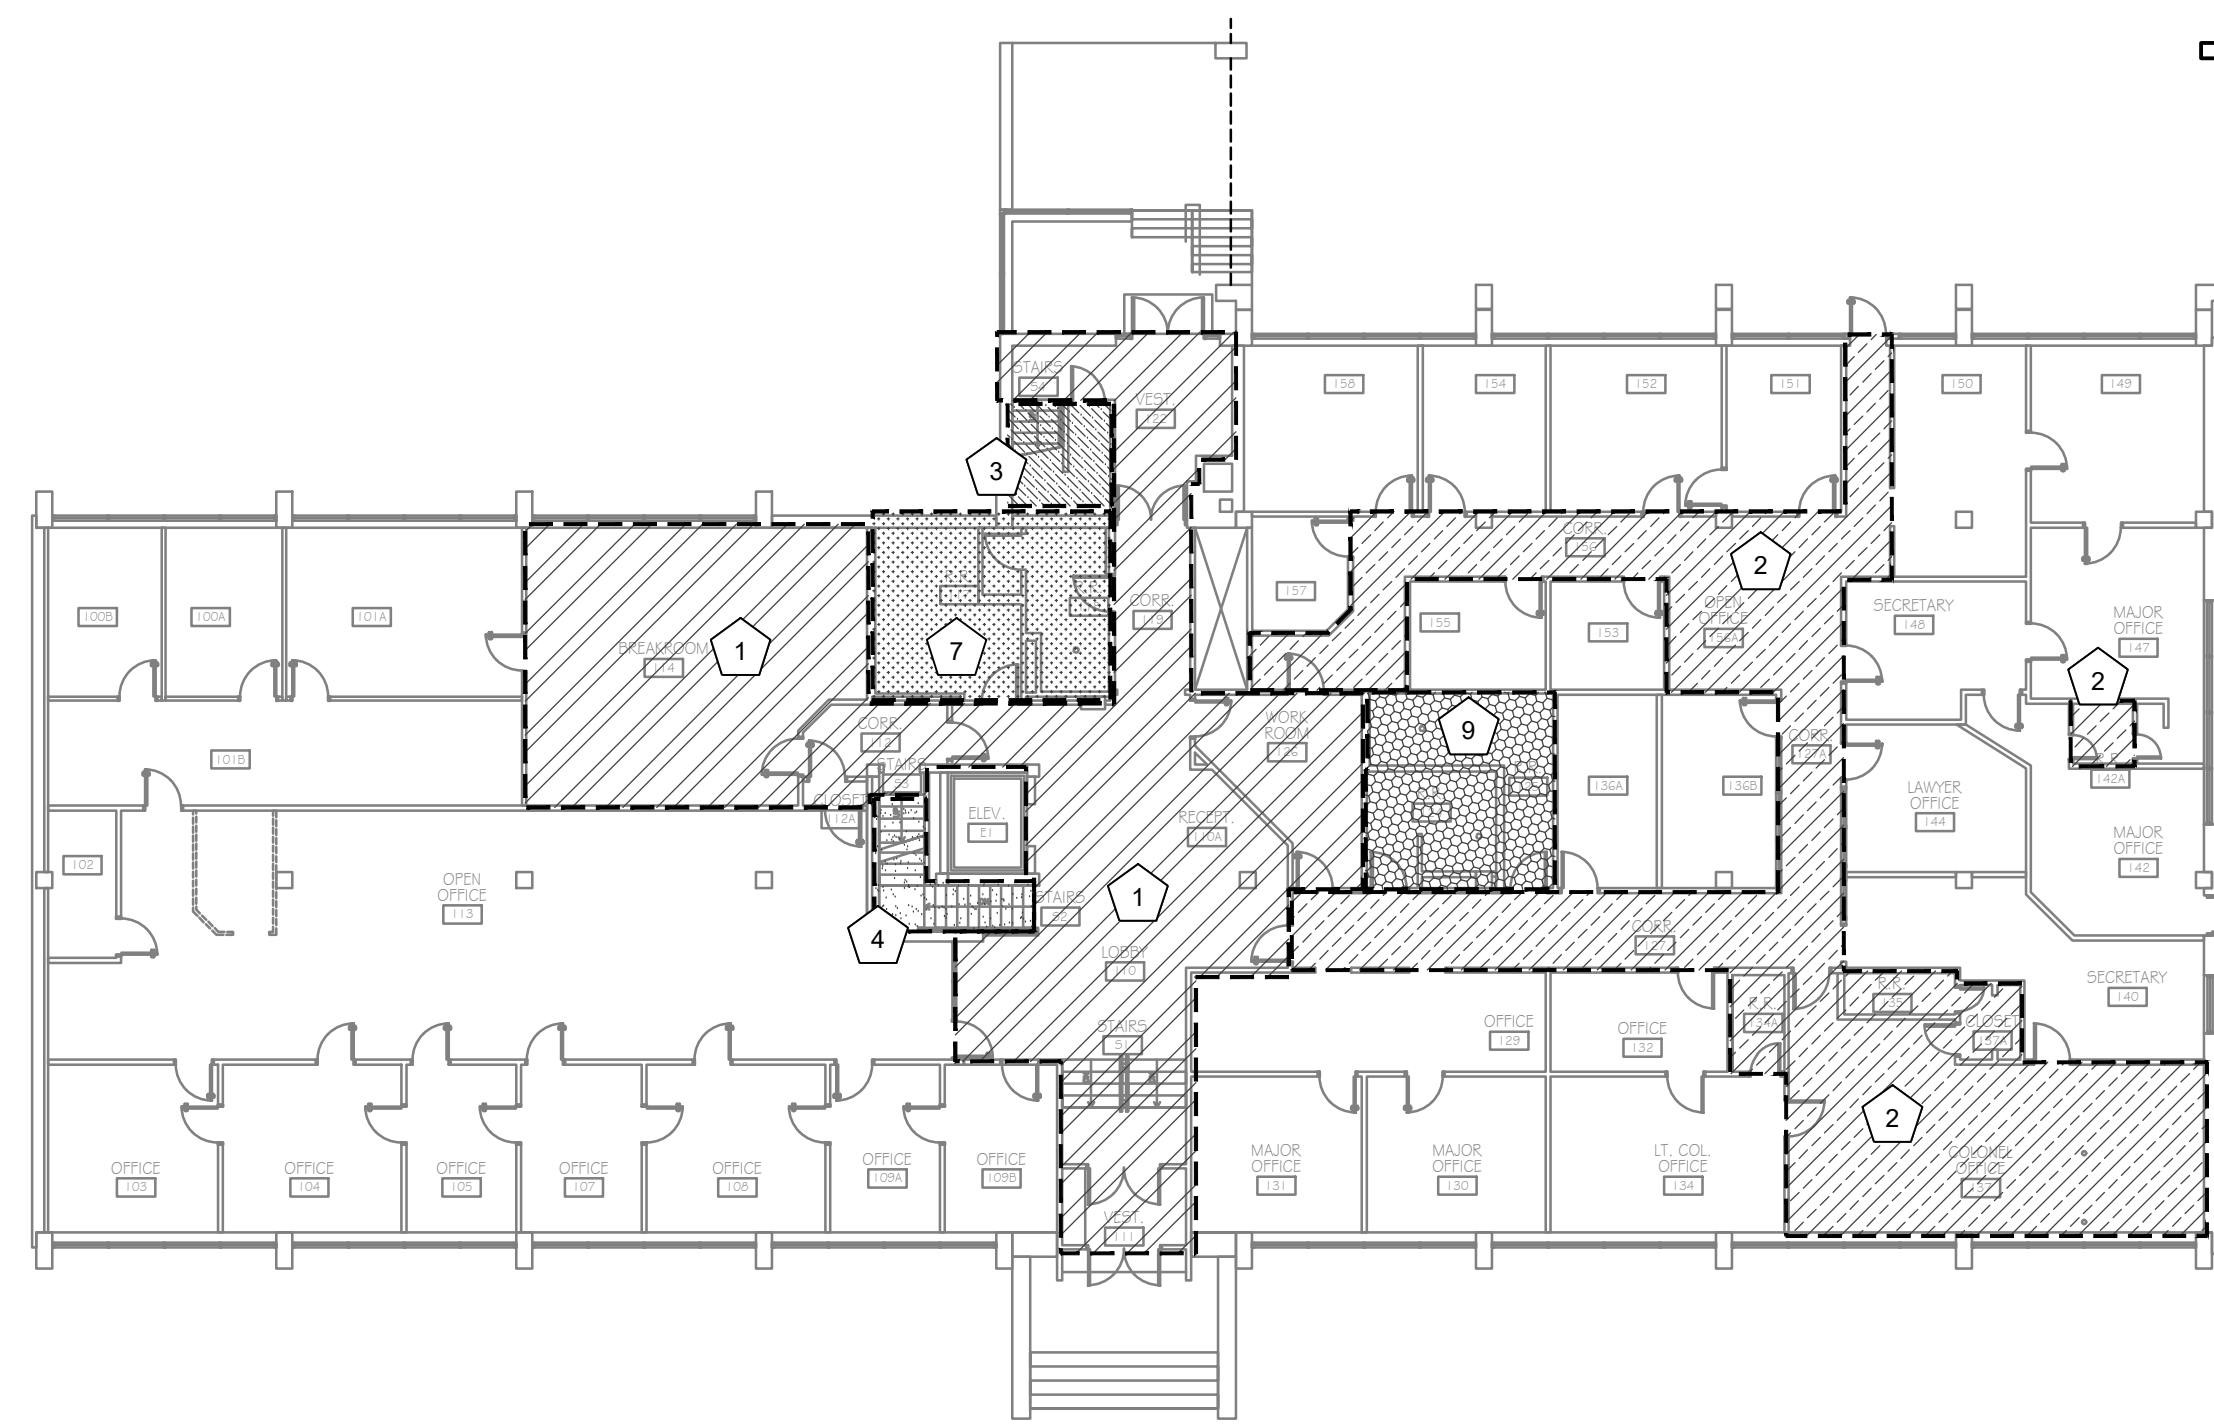

2 OVERALL PHASING PLAN — FIRST FLOOR
SCALE: 1/16" = 1'-0"

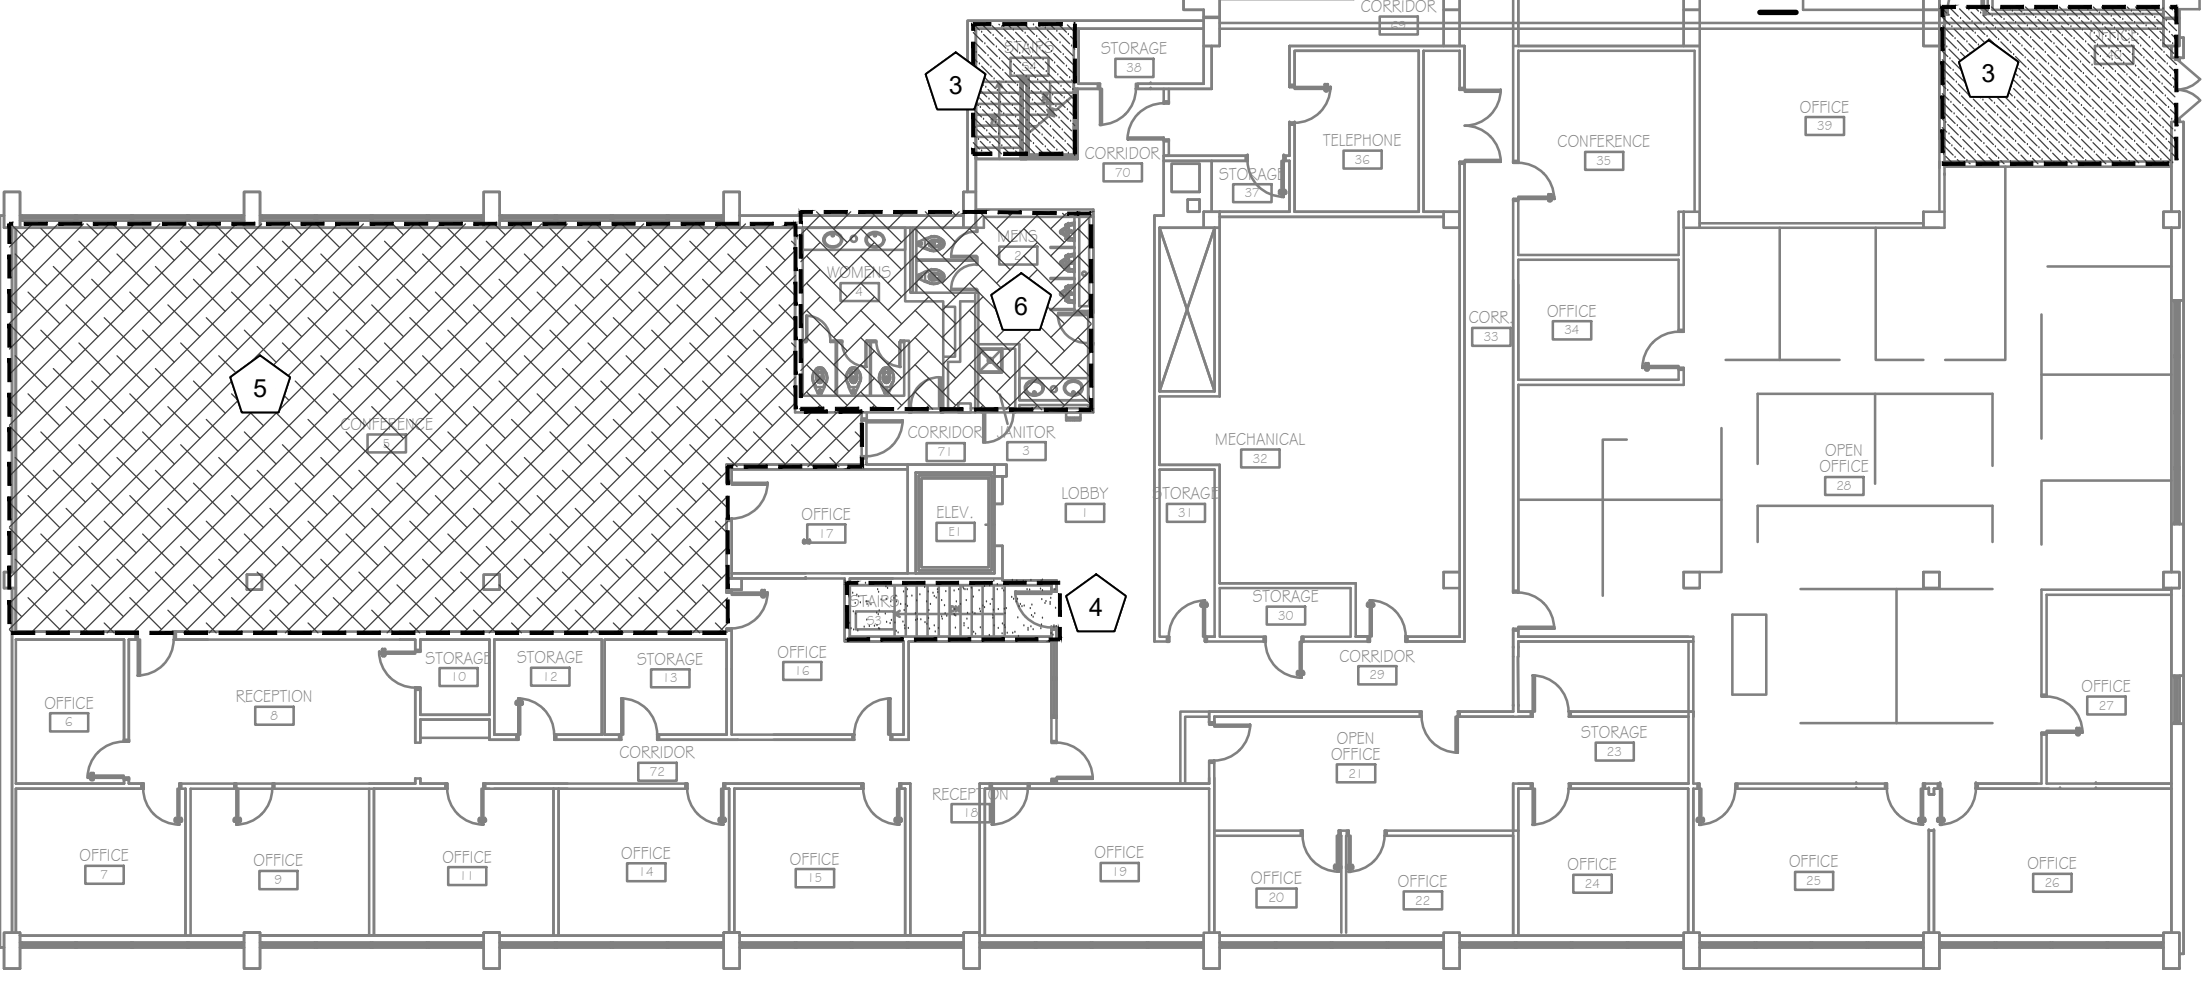

2 OVERALL PHASING PLAN — SECOND FLOOR
SCALE: 1/16" = 1'-0"

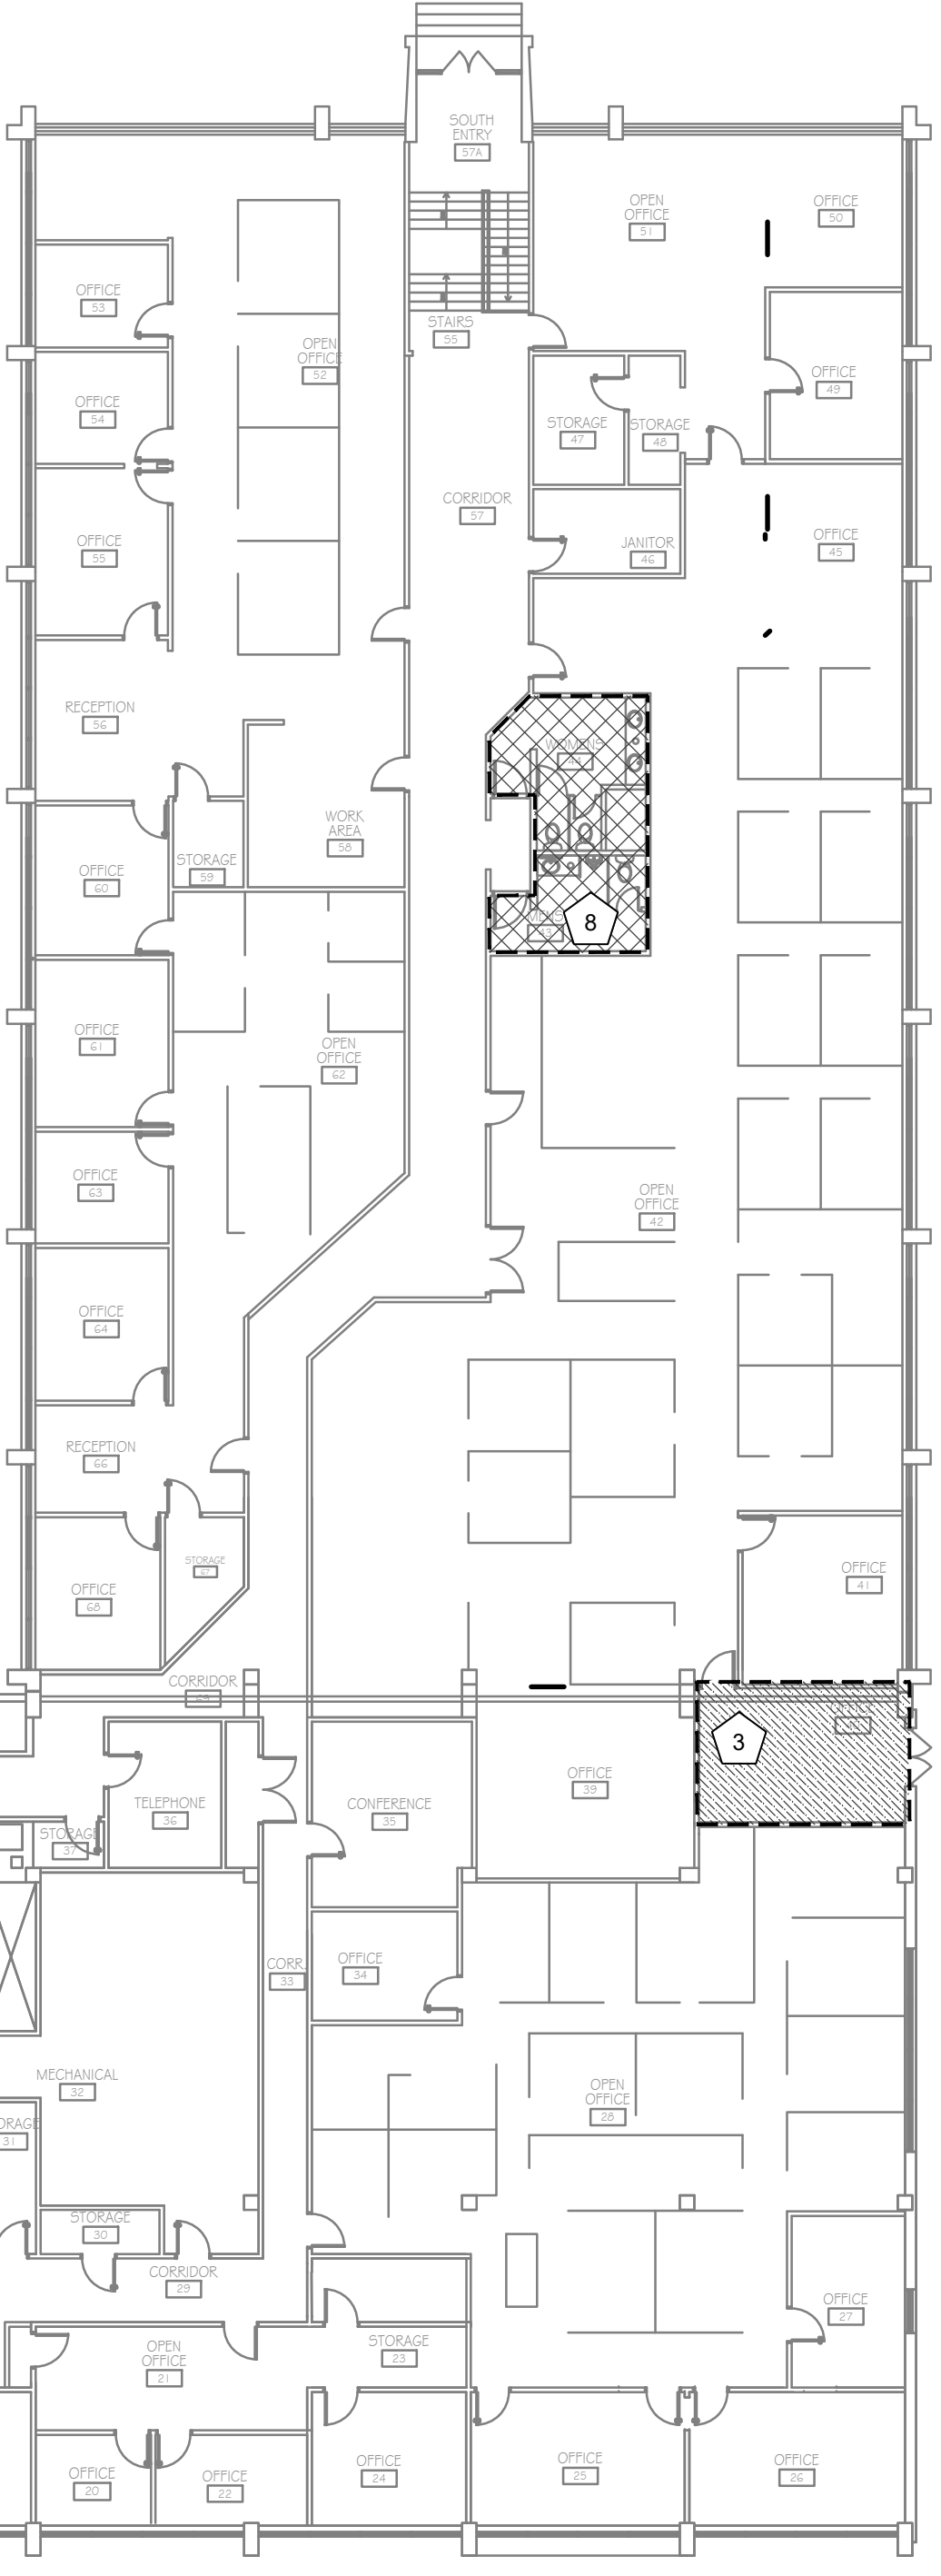

STATE OF MISSOURI
MIKE KEHOE,
GOVERNOR



Brad M. Schaefer - Architect
MO# A-2009027294

BID DOCUMENTS

OFFICE OF ADMINISTRATION
DIVISION OF FACILITIES
MANAGEMENT,
DESIGN AND CONSTRUCTION

DEPARTMENT OF
PUBLIC SAFETY
STATE HIGHWAY PATROL

RENOVATE INTERIOR

GENERAL HEADQUARTERS
1510 EAST ELM STREET
JEFFERSON CITY, MO 65101

PROJECT # R2410-01
SITE # 6001
ASSET # 8136001001

REVISION: _____
DATE: _____
REVISION: _____
DATE: _____
REVISION: _____
DATE: _____
ISSUE DATE: 06/18/2026

CAD DWG FILE: _____
DRAWN BY: RG/CL
CHECKED BY: BMS
DESIGNED BY: CL

SHEET TITLE:
SHEET INDEX
& PHASING PLANS

SHEET NUMBER:

G-002

2 OF 39 SHEETS
06/18/2026

LEGEND:	
	NEW CARPET TILE (CPT)
	NEW CERAMIC TILE (FT)


ALTERNATE NO. 1 - DEMOLITION KEYNOTES:	
A1	REMOVE EXISTING CERAMIC FLOOR TILE AND MORTAR DOWN TO SUBFLOOR BELOW. PREPARE SUBFLOOR TO NEW FLOOR MANUFACTURER'S RECOMMENDATIONS FOR INSTALLATION.
A2	REMOVE EXISTING THRESHOLD/TRANSITION STRIP.

DEMOLITION KEYNOTES:	
1	REMOVE EXISTING BASE TRIM. REPAIR ANY DAMAGED WALLS TO A LEVEL 4 FINISH TO MATCH ADJACENT. ENSURE CLEAN AND MOUNTABLE SURFACE FOR NEW BASE APPLICATION.
2	REMOVE EXISTING CARPET, PAD, AND TACKSTRIPS DOWN TO SUBFLOOR BELOW. PREPARE EXISTING SUBFLOOR TO NEW FLOOR MANUFACTURER'S RECOMMENDATIONS FOR INSTALLATION.
3	REMOVE EXISTING STAIR TREAD AND RISER. EXISTING VINYL FLOOR TILE AT LANDING TO REMAIN.

ALTERNATE NO. 1 - RENOVATION KEYNOTES:	
A1	INSTALL NEW CERAMIC FLOOR TILE.
A2	INSTALL METAL TRANSITION STRIP. NEW FLOOR SHOULD BE SQUARELY CUT AND LEVEL WITH ADJOINING FLOOR FINISH. PROVIDE TRANSITION PROFILE TO ACCOMMODATE CHANGE IN FLOOR HEIGHT.
A3	RAISE FLOOR DRAIN AND SLURRY FLOOR TO DECREASE SLOPE TO DRAIN. ENSURE MINIMUM SLOPE OF 1/4" PER FOOT IS MAINTAINED.

RENOVATION KEYNOTES:	
1	INSTALL NEW CARPET TILE (CPT). EXISTING FLOOR DUCTS TO REMAIN ACCESSIBLE UNLESS INDICATED OTHERWISE.
2	INSTALL NEW VINYL COVE BASE. PATCH AND REPAIR EXISTING WALL DAMAGE TO LEVEL 4 FINISH PRIOR TO NEW BASE INSTALLATION. PAINT TO MATCH ADJACENT FINISH.
3	INSTALL NEW STAIR TREAD WITH INTEGRATED RISER. INSTALL STAIR TREAD ON LANDING TO MATCH STAIR.

GENERAL NOTES:	
1.	HATCHING SHOWN INDICATES AREAS OF NEW FLOORING.
2.	REMOVE AND REINSTALL EXISTING FLOOR MOUNT DOOR STOPS TO EXISTING LOCATIONS WHERE NEW FLOORING IS INSTALLED.
3.	CONTRACTOR SHALL VERIFY DIMENSIONS OF EXISTING SPACE PRIOR TO BID.
4.	CONTRACTOR SHALL REMOVE ALL FURNITURE WITHIN THE AREAS OF WORK. PROTECT FURNITURE FROM DAMAGE. COORDINATE TEMPORARY STORAGE LOCATION WITH OWNER. MOVE FURNITURE BACK TO ORIGINAL LOCATIONS AFTER CONSTRUCTION IS COMPLETE, EXCEPT FURNITURE INDICATED TO BE DISPOSED OF.
5.	CONTRACTOR SHALL REMOVE EXISTING TRANSITIONS AND TRIM AS REQUIRED AND PROTECT EXISTING TRIM TO REMAIN.
6.	CONTRACTOR SHALL TAKE MEASURES TO PROTECT EXISTING WALL FIXTURES AND MATERIAL FROM DAMAGE DURING DEMOLITION AND INSTALLATION.
7.	CONTRACTOR SHALL COORDINATE PATHS THROUGH BUILDING FOR DELIVERY OF CONSTRUCTION MATERIAL AND WORKERS WITH OWNER PRIOR TO COMMENCEMENT OF WORK.
8.	CONTRACTOR SHALL COORDINATE WITH STAFF WHEN REMOVING FURNITURE TO DETERMINE STORAGE LOCATIONS AND TO DETERMINE EXACT LAYOUT FOR ACCURATE REPLACEMENT OF ITEMS.
9.	CONTRACTOR SHALL FIELD VERIFY DIMENSIONS OF EXISTING SPACE PRIOR TO MATERIAL PROCUREMENT AND INSTALLATION.
10.	CONTRACTOR SHALL PROTECT ADJACENT STRUCTURES TO REMAIN IN PLACE THAT COULD POTENTIALLY BE DAMAGED DURING INSTALLATION TO ENSURE INTEGRITY AND FINISH ARE MAINTAINED.
11.	CONTRACTOR SHALL COORDINATE SCHEDULE WITH OWNER PRIOR TO START OF WORK.

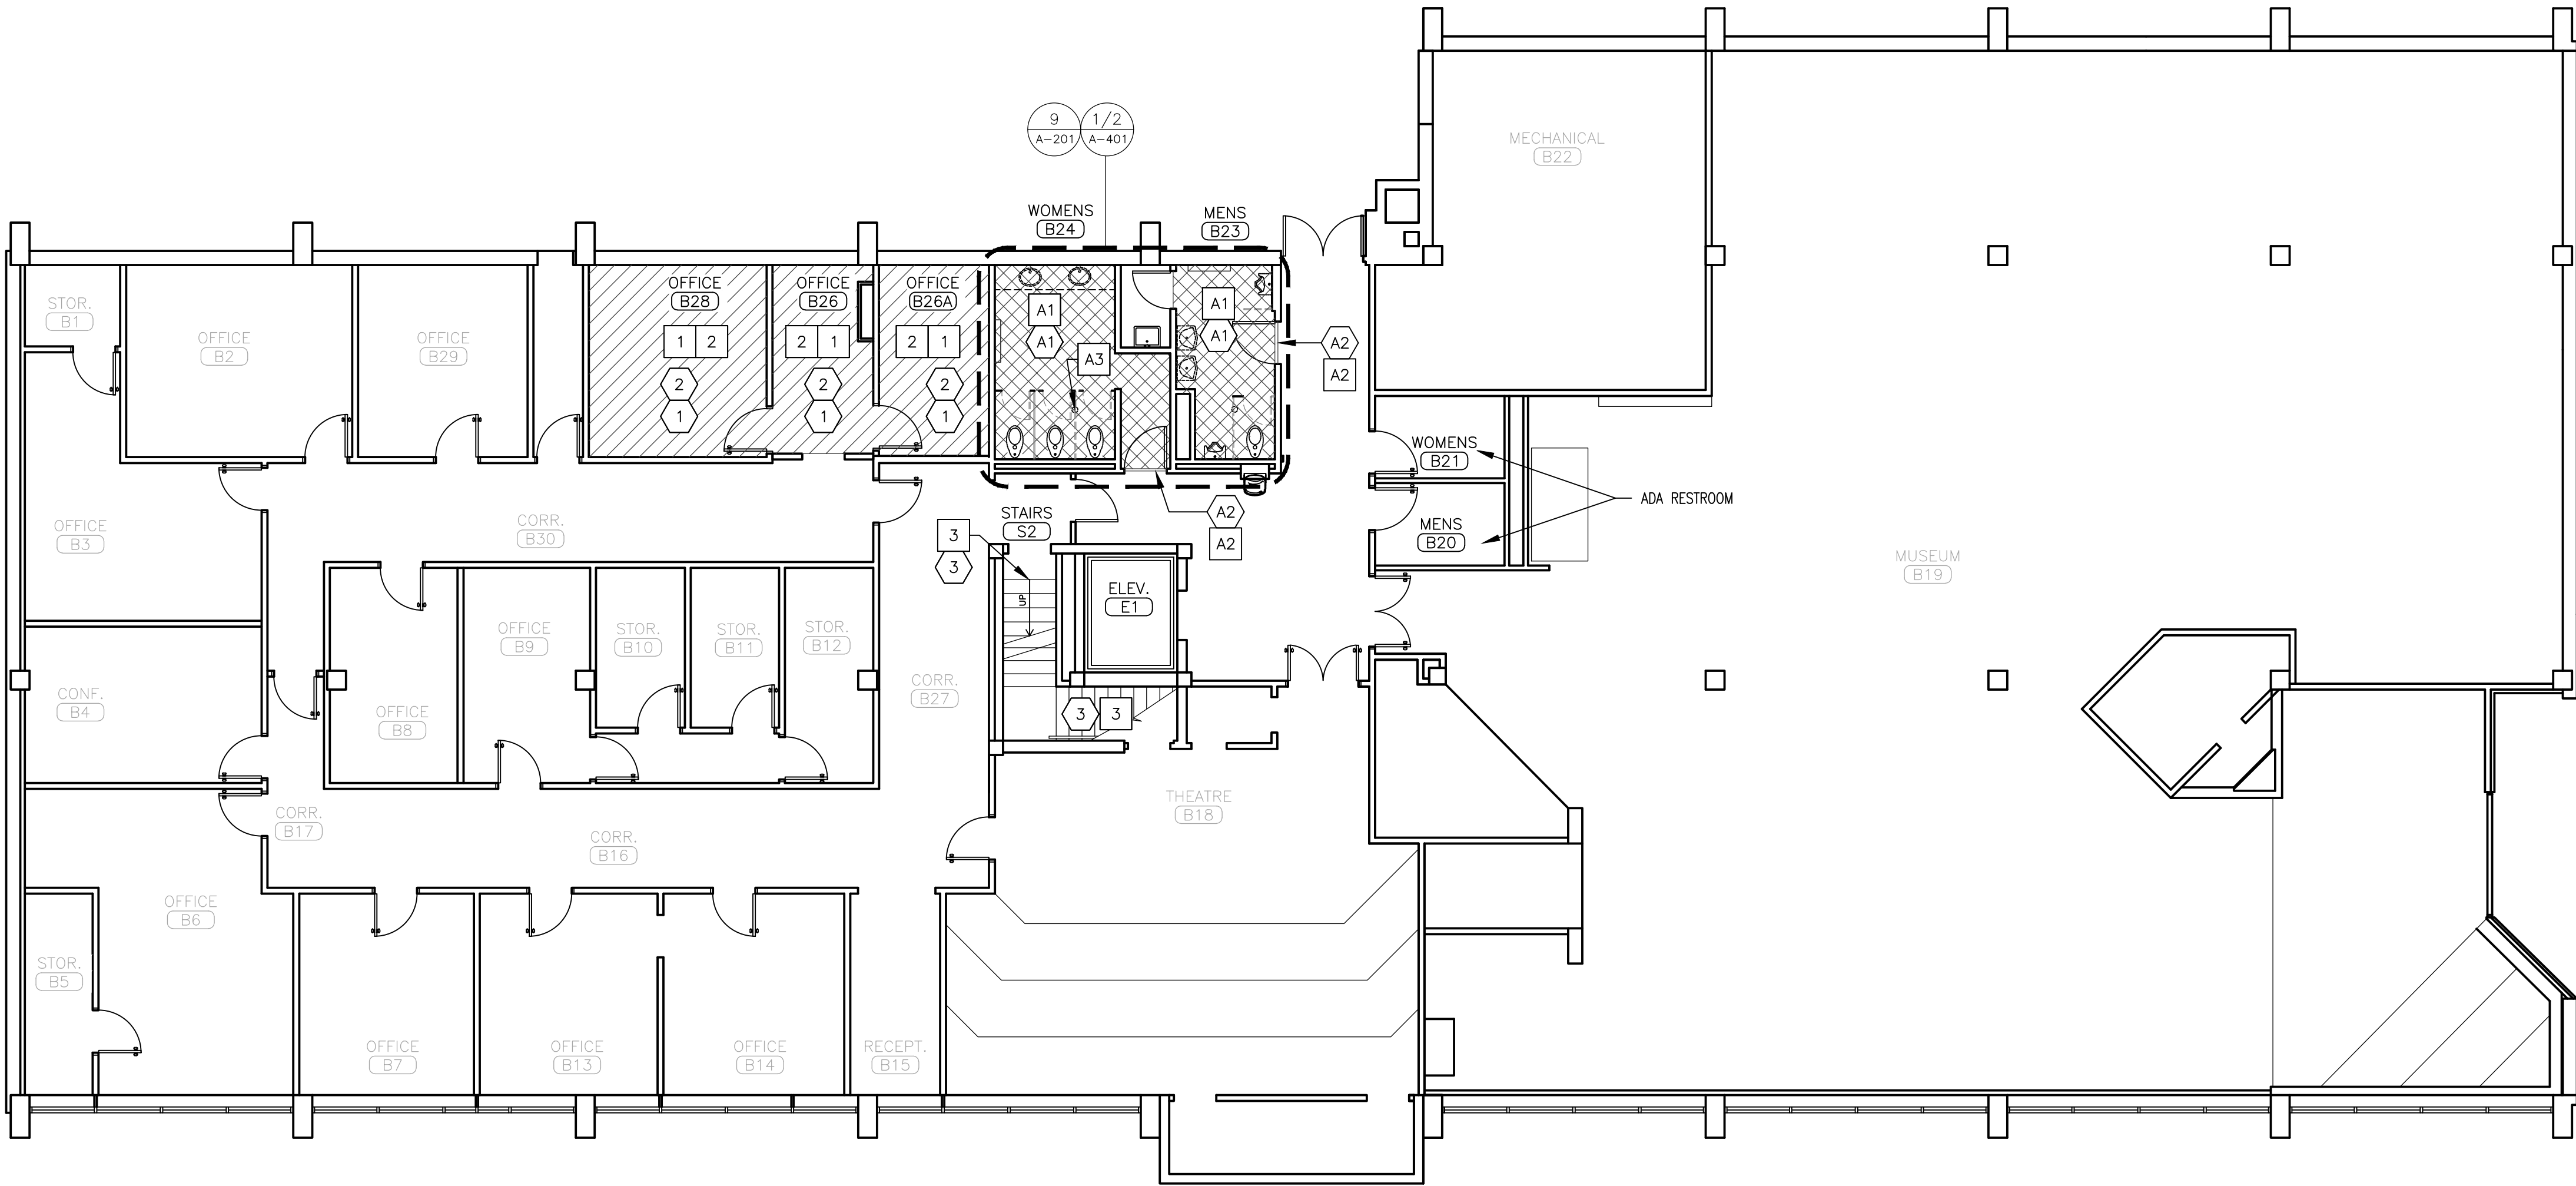

BID
DOCUMENTS

OFFICE OF ADMINISTRATION
DIVISION OF FACILITIES
MANAGEMENT,
DESIGN AND CONSTRUCTION

DEPARTMENT OF
PUBLIC SAFETY
STATE HIGHWAY PATROL

RENOVATE INTERIOR

GENERAL HEADQUARTERS
1510 EAST ELM STREET
JEFFERSON CITY, MO 65101

PROJECT # R2410-01
SITE # 6001
ASSET # 8136001001

REVISION: _____
DATE: _____
REVISION: _____
DATE: _____
REVISION: _____
DATE: _____
ISSUE DATE: 06/18/2026

CAD DWG FILE: _____
DRAWN BY: RG/CL
CHECKED BY: BMS
DESIGNED BY: CL

SHEET TITLE:
GHQ BASEMENT
FLOOR PLAN

SHEET NUMBER:

A-101

3 OF 39 SHEETS
06/18/2026



Brad M. Schaefer - Architect
MO# A-2009027294

BID
DOCUMENTS

OFFICE OF ADMINISTRATION
DIVISION OF FACILITIES
MANAGEMENT,
DESIGN AND CONSTRUCTION

DEPARTMENT OF
PUBLIC SAFETY
STATE HIGHWAY PATROL

RENOVATE INTERIOR

GENERAL HEADQUARTERS
1510 EAST ELM STREET
JEFFERSON CITY, MO 65101

PROJECT # R2410-01
SITE # 6001
ASSET # 8136001001

REVISION: _____
DATE: _____
REVISION: _____
DATE: _____
REVISION: _____
DATE: _____
ISSUE DATE: 06/18/2026

CAD DWG FILE: _____
DRAWN BY: RG/CL
CHECKED BY: BMS
DESIGNED BY: CL

SHEET TITLE:
GHQ FIRST FLOOR
PLAN

SHEET NUMBER:

A-102

4 OF 39 SHEETS
06/18/2026

RENOVATION KEYNOTES:

1. INSTALL NEW CARPET TILE (CPT). EXISTING FLOOR DUCTS TO REMAIN ACCESSIBLE UNLESS INDICATED OTHERWISE.
2. INSTALL NEW LUXURY VINYL TILE (LVT).
3. INSTALL NEW WALK-OFF CARPET TILE (WOC).
4. INSTALL NEW VINYL COVE BASE. PATCH AND REPAIR EXISTING WALL DAMAGE TO LEVEL 4 FINISH PRIOR TO NEW BASE INSTALLATION. PAINT TO MATCH ADJACENT FINISH.
5. INSTALL NEW CERAMIC FLOOR TILE.
6. INSTALL NEW METAL TRANSITION STRIP. NEW FLOOR SHOULD BE SQUARELY CUT AND LEVEL WITH ADJOINING FLOOR FINISH. PROVIDE TRANSITION PROFILE TO ACCOMMODATE CHANGE IN FLOOR HEIGHT.
7. REINSTALL FREESTANDING APPLIANCES.
8. INSTALL NEW STAIR TREAD WITH INTEGRATED RISER.
9. REINSTALL RECEPTION DESK AND ASSOCIATED WOOD TRIM.
10. INSTALL NEW VINYL TRANSITION STRIP. NEW FLOOR SHOULD BE SQUARELY CUT AND LEVEL WITH ADJOINING FLOOR FINISH. PROVIDE TRANSITION PROFILE TO ACCOMMODATE CHANGE IN FLOOR HEIGHT.
11. INSTALL STAIR TREAD ON LANDING TO MATCH STAIR.

DEMOLITION KEYNOTES:



1. REMOVE EXISTING BASE TRIM. REPAIR ANY DAMAGED WALLS TO A LEVEL 4 FINISH TO MATCH ADJACENT. ENSURE CLEAN AND MOUNTABLE SURFACE FOR NEW BASE APPLICATION.
2. PROTECT EXISTING WOOD BASE TRIM TO REMAIN.
3. REMOVE EXISTING THRESHOLD/TRANSITION STRIP.
4. REMOVE EXISTING CARPET, PAD, AND TACKSTRIPS DOWN TO VINYL TILE BELOW. CLEAN AND PREPARE EXISTING VINYL TILE TO NEW FLOOR MANUFACTURER'S RECOMMENDATIONS FOR INSTALLATION.
5. REMOVE EXISTING WALK-OFF CARPET TILES DOWN TO VINYL TILE BELOW. CLEAN AND PREPARE EXISTING VINYL TILE TO NEW FLOOR MANUFACTURER'S RECOMMENDATIONS FOR INSTALLATION. RELINQUISH UNDAMAGED WALK-OFF CARPET TILES TO OWNER.
6. CLEAN EXISTING VINYL TILE TO REMAIN, AND PREPARE SURFACE TO NEW FLOOR MANUFACTURER'S RECOMMENDATIONS FOR INSTALLATION.
7. REMOVE EXISTING CERAMIC FLOOR TILE AND MORTAR DOWN TO SUBFLOOR BELOW. SMOOTH AND PREPARE SUBFLOOR TO NEW FLOOR MANUFACTURER'S RECOMMENDATIONS FOR INSTALLATION.
8. REMOVE FREESTANDING APPLIANCES FROM AREA OF WORK. PROTECT FROM DAMAGE, TO BE REINSTALLED IN SAME LOCATIONS AFTER CONSTRUCTION IS COMPLETE.
9. PROTECT EXISTING CABINETS TO REMAIN.
10. REMOVE EXISTING STAIR NOSING, TREAD, AND RISER. EXISTING VINYL FLOOR TILE AT LANDING TO REMAIN.
11. REMOVE AND SALVAGE EXISTING RECEPTION DESK AND ASSOCIATED WOOD TRIM TO EXTENTS REQUIRED FOR FLOORING REMOVAL. PROTECT FROM DAMAGE, TO BE REINSTALLED IN SAME LOCATION AFTER CONSTRUCTION IS COMPLETE.


GENERAL NOTES:

1. HATCHING SHOWN INDICATES AREAS OF NEW FLOORING.
2. REMOVE AND REINSTALL EXISTING FLOOR MOUNT DOOR STOPS TO EXISTING LOCATIONS WHERE NEW FLOORING IS INSTALLED.
3. CONTRACTOR SHALL VERIFY DIMENSIONS OF EXISTING SPACE PRIOR TO BID.
4. CONTRACTOR SHALL REMOVE ALL FURNITURE WITHIN THE AREAS OF WORK. PROTECT FURNITURE FROM DAMAGE. COORDINATE TEMPORARY STORAGE LOCATION WITH OWNER. MOVE FURNITURE BACK TO ORIGINAL LOCATIONS AFTER CONSTRUCTION IS COMPLETE, EXCEPT FURNITURE INDICATED TO BE DISPOSED OF.
5. CONTRACTOR SHALL REMOVE EXISTING TRANSITIONS AND TRIM AS REQUIRED AND PROTECT EXISTING TRIM TO REMAIN.
6. CONTRACTOR SHALL TAKE MEASURES TO PROTECT EXISTING WALL FIXTURES AND MATERIAL FROM DAMAGE DURING DEMOLITION AND INSTALLATION.
7. CONTRACTOR SHALL COORDINATE PATHS THROUGH BUILDING FOR DELIVERY OF CONSTRUCTION MATERIAL AND WORKERS WITH OWNER PRIOR TO COMMENCEMENT OF WORK.
8. CONTRACTOR SHALL COORDINATE WITH STAFF WHEN REMOVING FURNITURE TO DETERMINE STORAGE LOCATIONS AND TO DETERMINE EXACT LAYOUT FOR ACCURATE REPLACEMENT OF ITEMS.
9. CONTRACTOR SHALL FIELD VERIFY DIMENSIONS OF EXISTING SPACE PRIOR TO MATERIAL PROCUREMENT AND INSTALLATION.
10. CONTRACTOR SHALL PROTECT ADJACENT STRUCTURES TO REMAIN IN PLACE THAT COULD POTENTIALLY BE DAMAGED DURING INSTALLATION TO ENSURE INTEGRITY AND FINISH ARE MAINTAINED.
11. CONTRACTOR SHALL COORDINATE SCHEDULE WITH OWNER PRIOR TO START OF WORK.

LEGEND:

- | | |
|--|-----------------------------|
| | NEW WALK-OFF CARPET (WOC) |
| | NEW CARPET TILE (CPT-1) |
| | NEW CARPET TILE (CPT-2) |
| | NEW LUXURY VINYL TILE (LVT) |
| | NEW CERAMIC TILE (FT) |

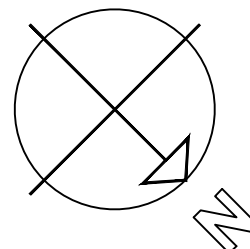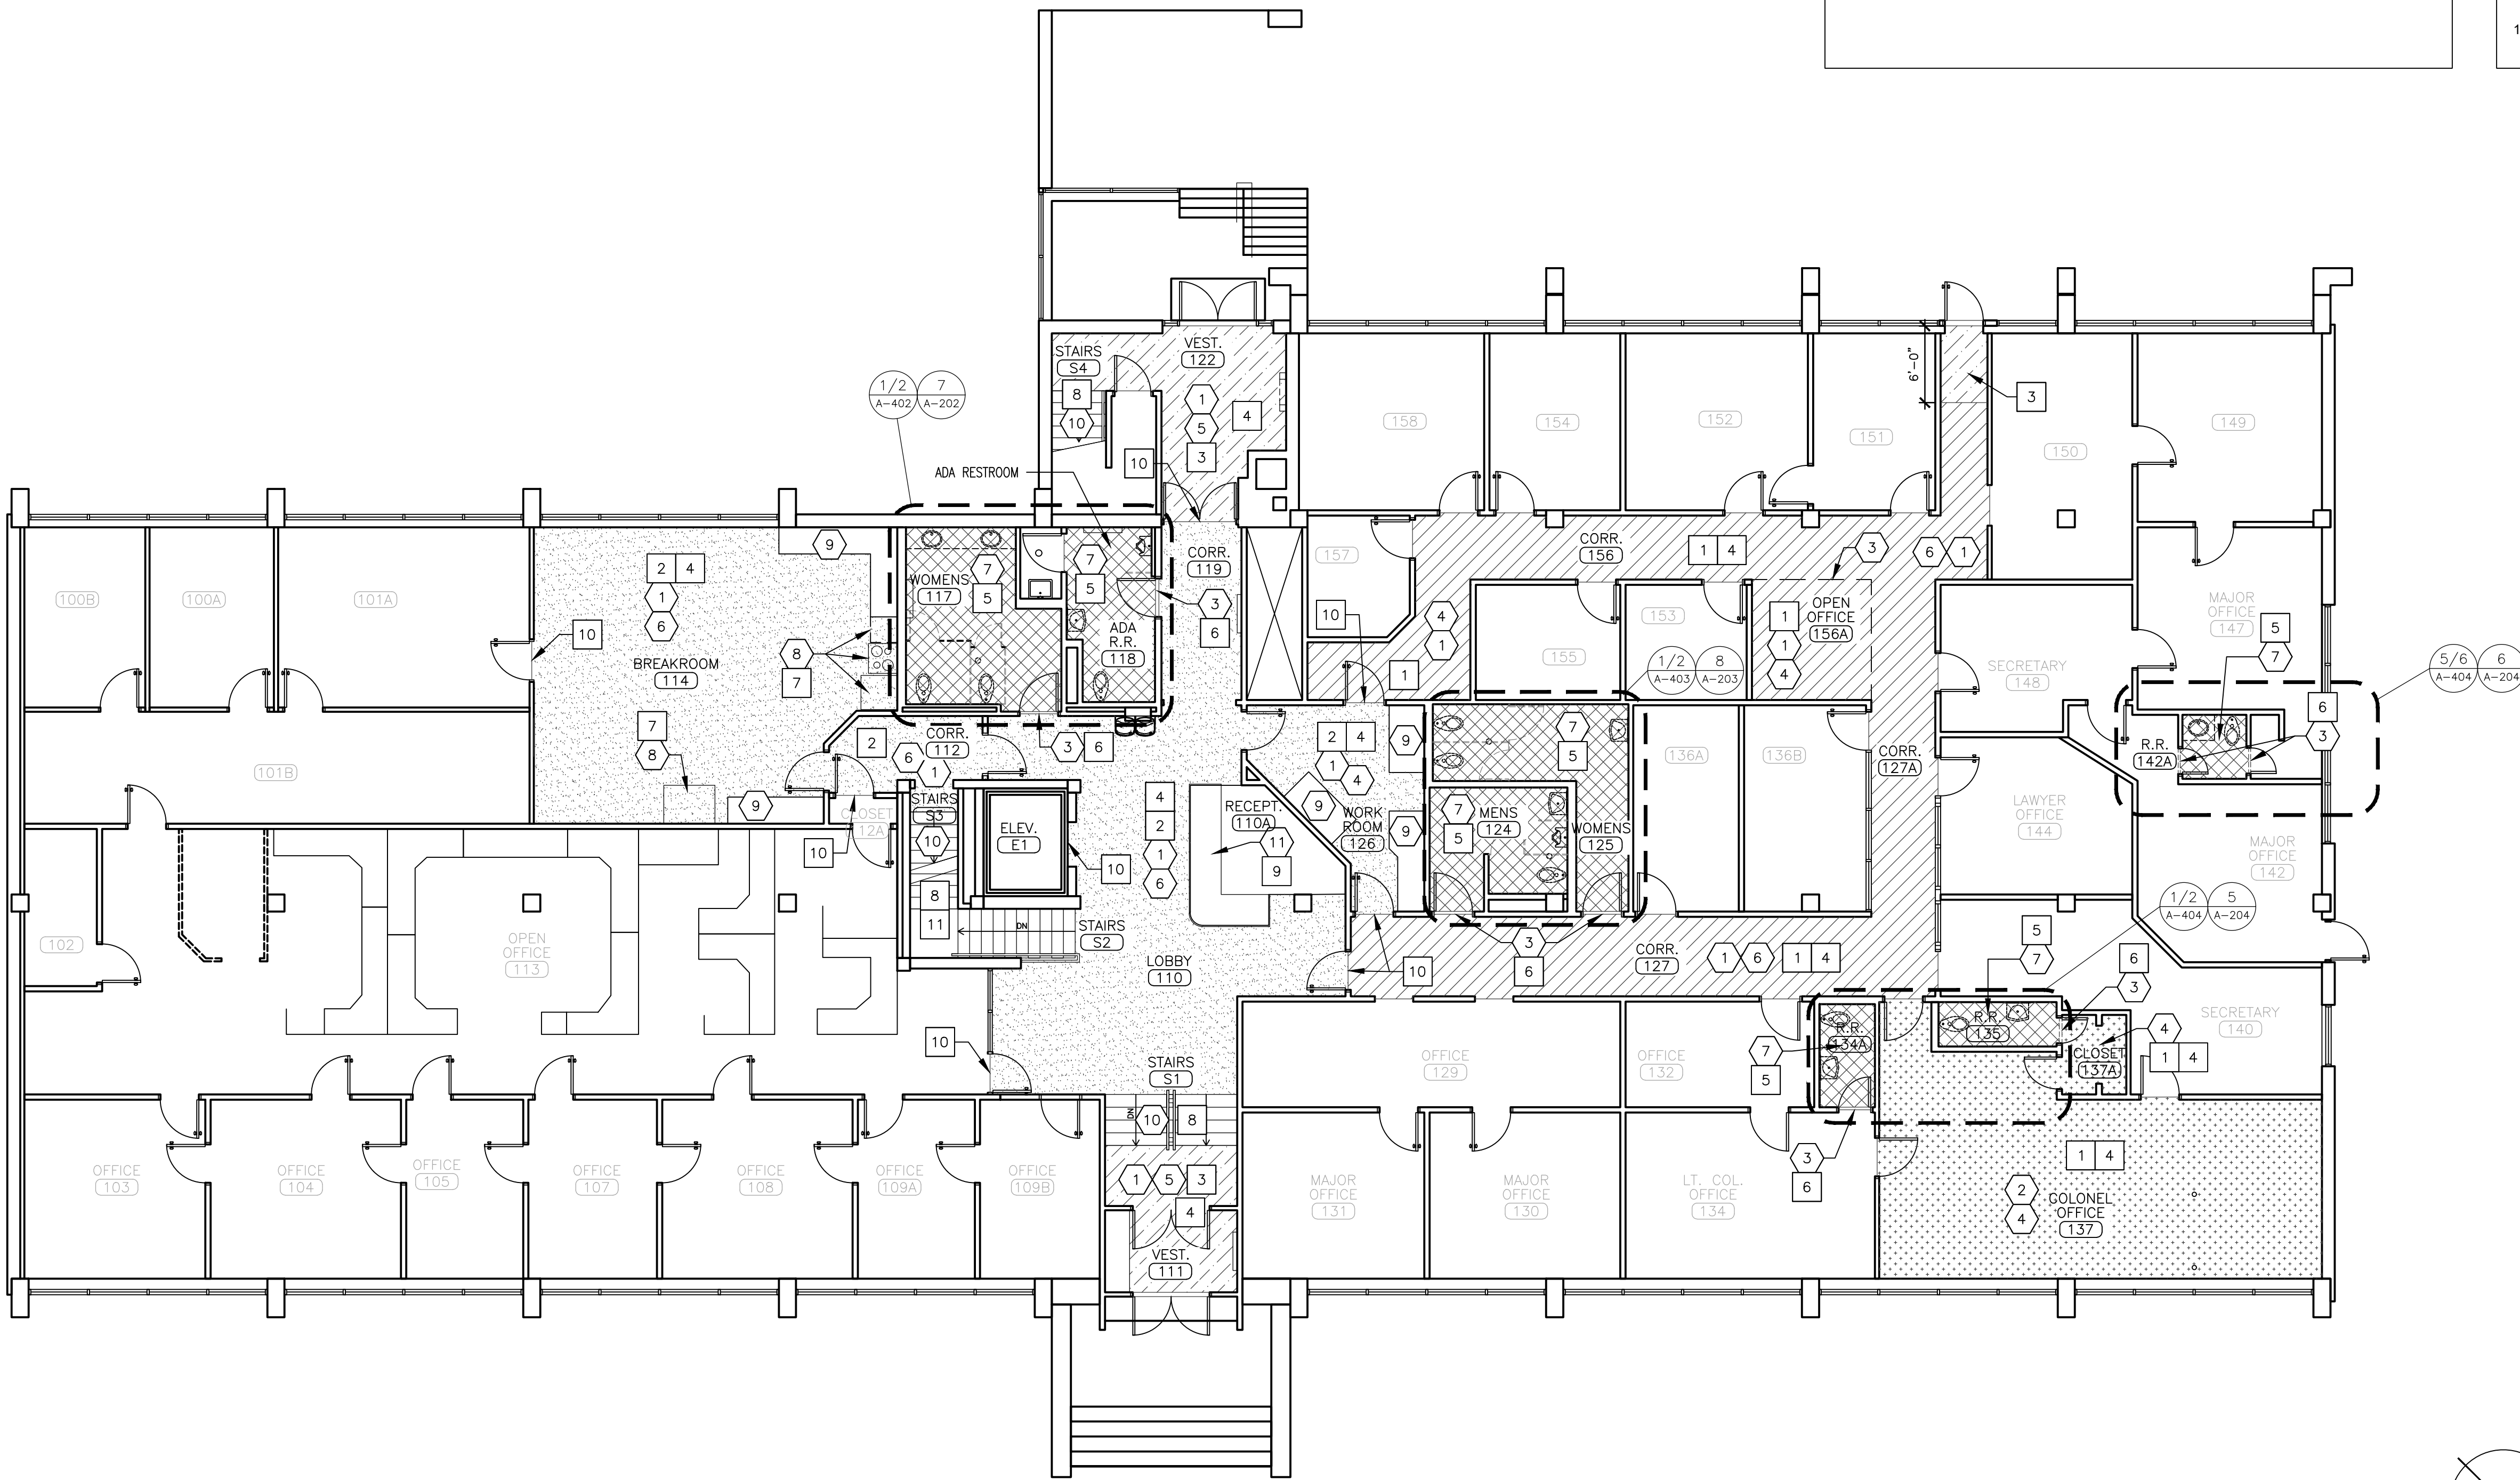

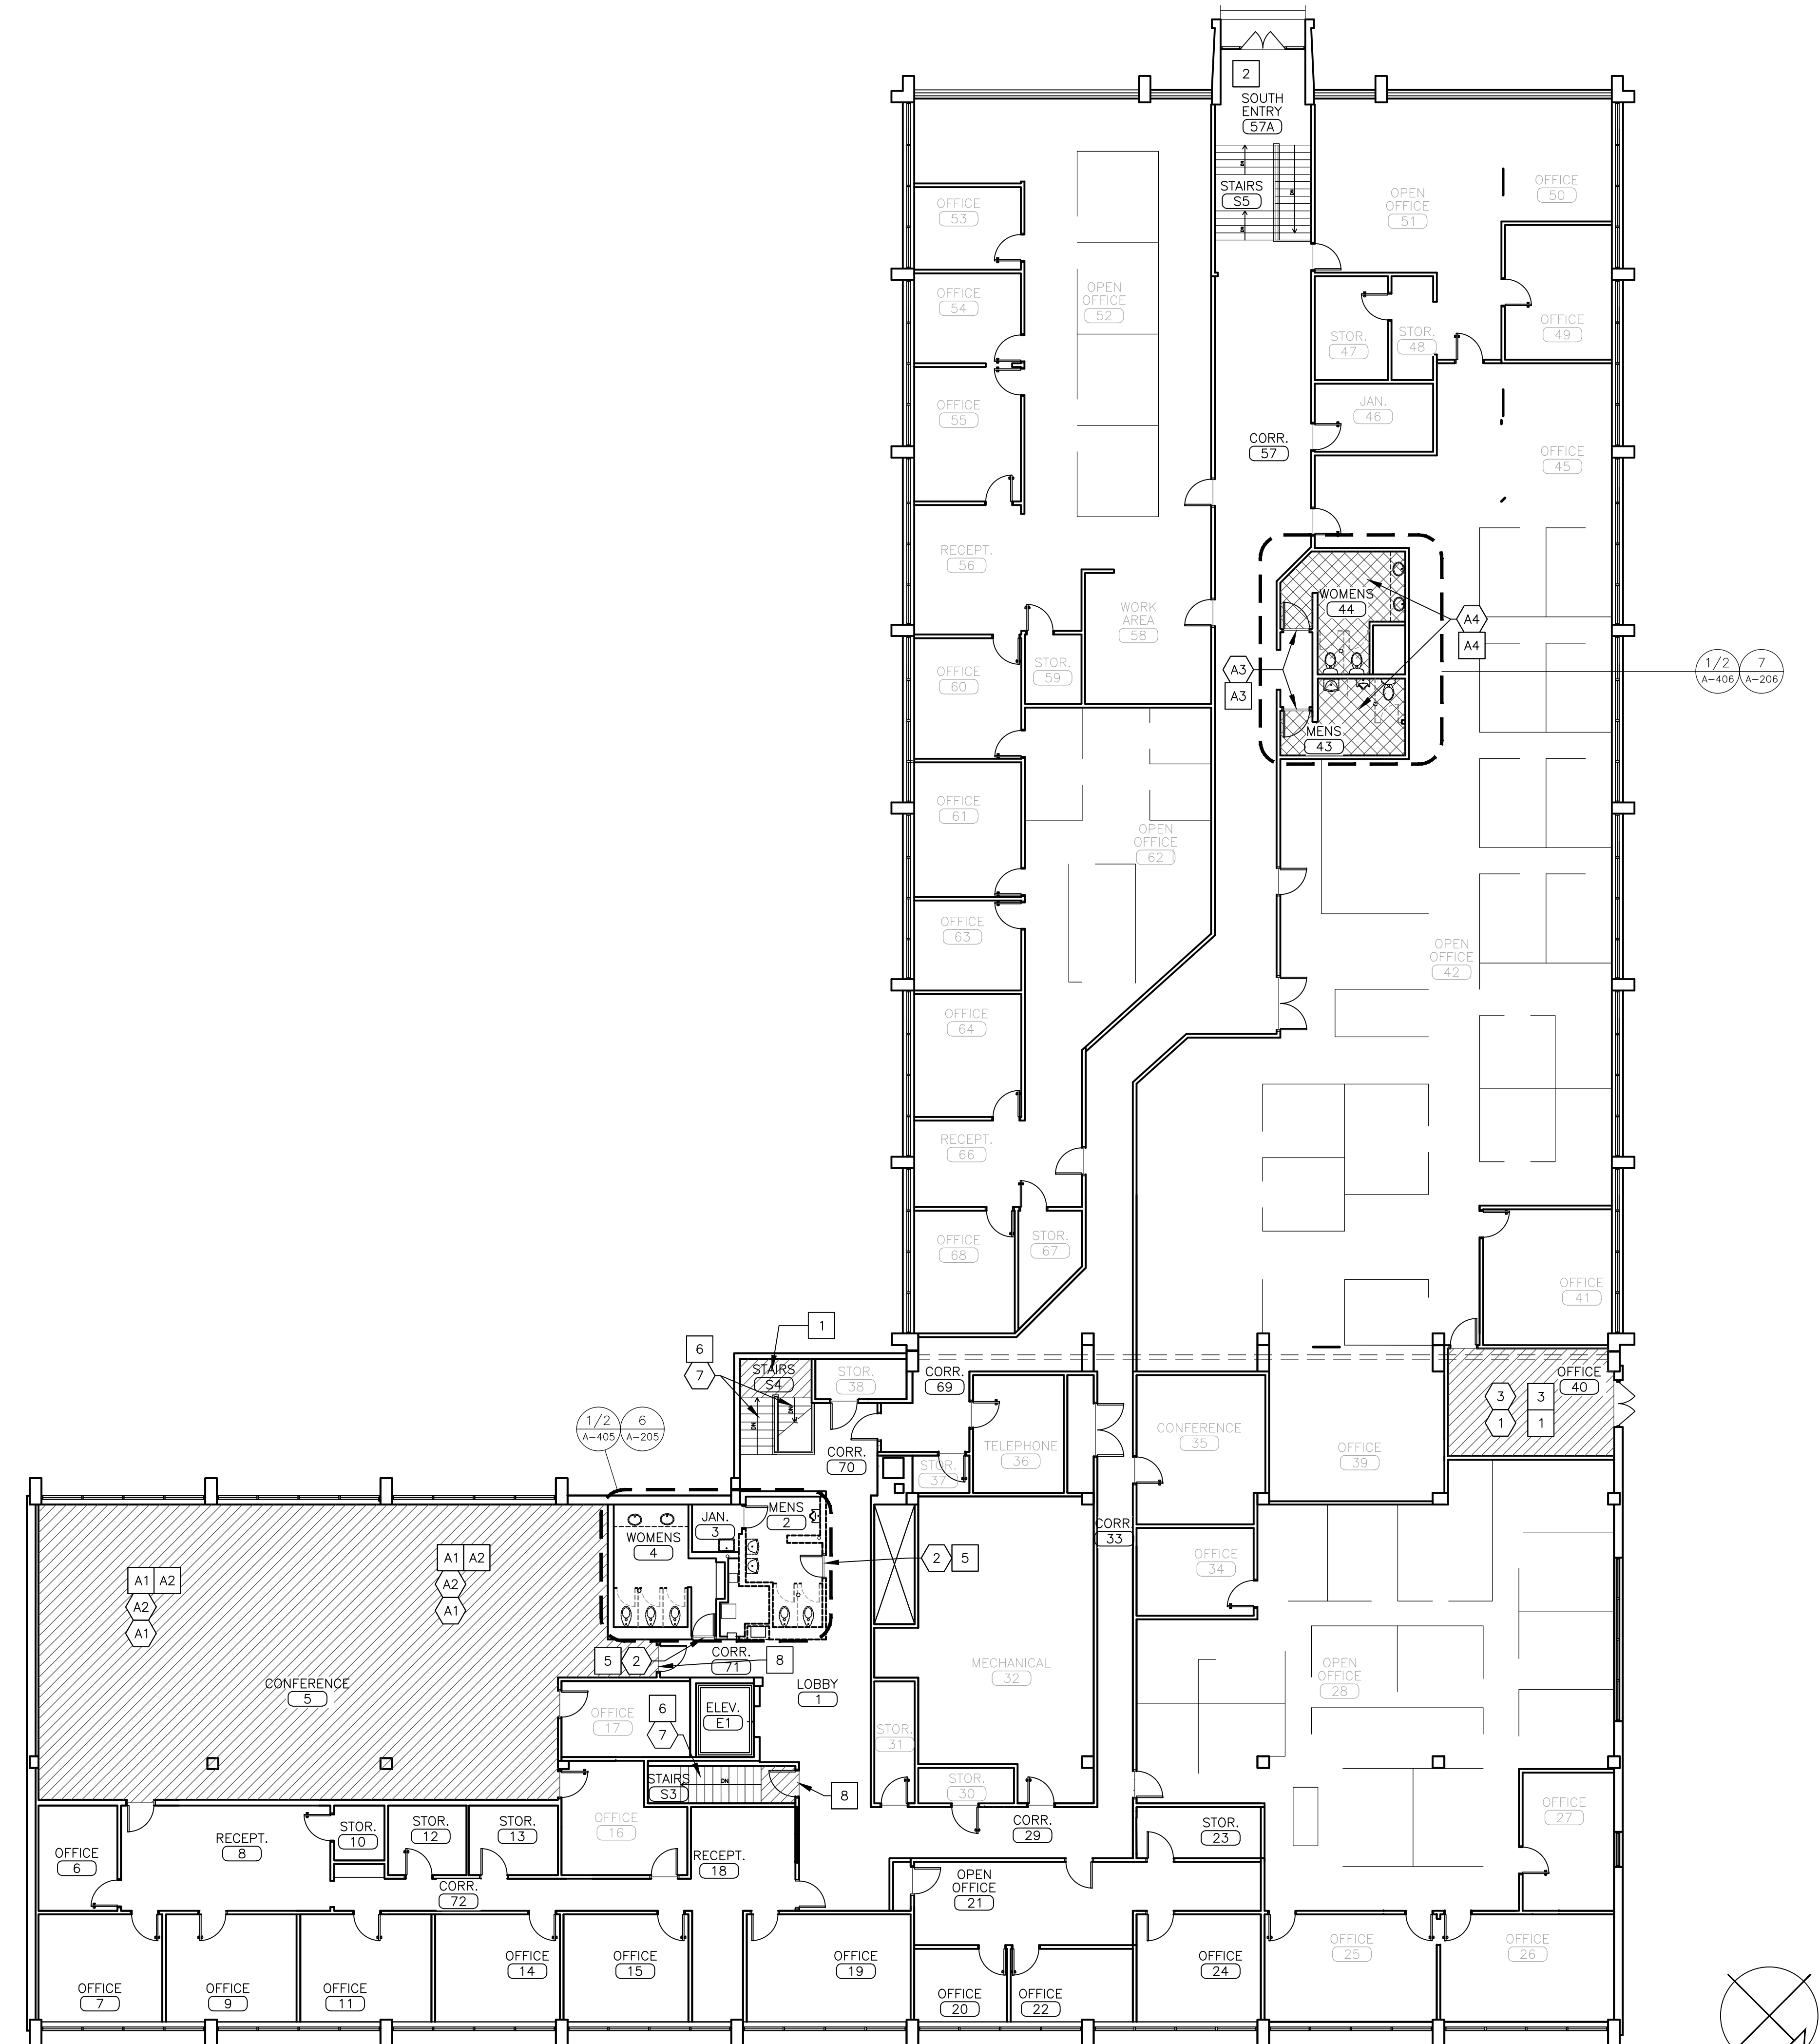

1 GENERAL HEADQUARTERS SECOND FLOOR PLAN
SCALE: 3/32"=1'-0"

LEGEND:	
	NEW WALK OF CARPET (WOC)
	NEW CARPET TILE (CPT)
	NEW LUXURY VINYL TILE (LVT)
	NEW CERAMIC TILE (FT)

- GENERAL NOTES:**
- HATCHING SHOWN INDICATES AREAS OF NEW FLOORING.
 - REMOVE AND REINSTALL EXISTING FLOOR MOUNT DOOR STOPS TO EXISTING LOCATIONS WHERE NEW FLOORING IS INSTALLED.
 - CONTRACTOR SHALL VERIFY DIMENSIONS OF EXISTING SPACE PRIOR TO BID.
 - CONTRACTOR SHALL REMOVE ALL FURNITURE WITHIN THE AREAS OF WORK. PROTECT FURNITURE FROM DAMAGE. COORDINATE TEMPORARY STORAGE LOCATION WITH OWNER. MOVE FURNITURE BACK TO ORIGINAL LOCATIONS AFTER CONSTRUCTION IS COMPLETE, EXCEPT FURNITURE INDICATED TO BE DISPOSED OF.
 - CONTRACTOR SHALL REMOVE EXISTING TRANSITIONS AND TRIM AS REQUIRED AND PROTECT EXISTING TRIM TO REMAIN.
 - CONTRACTOR SHALL TAKE MEASURES TO PROTECT EXISTING WALL FIXTURES AND MATERIAL FROM DAMAGE DURING DEMOLITION AND INSTALLATION.
 - CONTRACTOR SHALL COORDINATE PATHS THROUGH BUILDING FOR DELIVERY OF CONSTRUCTION MATERIAL AND WORKERS WITH OWNER PRIOR TO COMMENCEMENT OF WORK.
 - CONTRACTOR SHALL COORDINATE WITH STAFF WHEN REMOVING FURNITURE TO DETERMINE STORAGE LOCATIONS AND TO DETERMINE EXACT LAYOUT FOR ACCURATE REPLACEMENT OF ITEMS.
 - CONTRACTOR SHALL FIELD VERIFY DIMENSIONS OF EXISTING SPACE PRIOR TO MATERIAL PROCUREMENT AND INSTALLATION.
 - CONTRACTOR SHALL PROTECT ADJACENT STRUCTURES TO REMAIN IN PLACE THAT COULD POTENTIALLY BE DAMAGED DURING INSTALLATION TO ENSURE INTEGRITY AND FINISH ARE MAINTAINED.
 - CONTRACTOR SHALL COORDINATE SCHEDULE WITH OWNER PRIOR TO START OF WORK.

- ALTERNATE NO. 3 - DEMOLITION KEYNOTES:**
- A1 REMOVE EXISTING BASE TRIM. REPAIR ANY DAMAGED WALLS TO A LEVEL 4 FINISH TO MATCH ADJACENT. ENSURE CLEAN AND MOUNTABLE SURFACE FOR NEW BASE APPLICATION.
- A2 REMOVE EXISTING CARPET, PAD, AND TACKSTRIPS DOWN TO VINYL TILE BELOW. CLEAN AND PREPARE EXISTING VINYL TILE TO NEW FLOOR MANUFACTURER'S RECOMMENDATIONS FOR INSTALLATION.
- ALTERNATE NO. 2 - DEMOLITION KEYNOTES:**
- A3 REMOVE EXISTING THRESHOLD/TRANSITION STRIP.
- A4 REMOVE EXISTING CERAMIC FLOOR TILE AND MORTAR DOWN TO SUBFLOOR BELOW. SMOOTH AND PREPARE SUBFLOOR TO NEW FLOOR MANUFACTURER'S RECOMMENDATIONS FOR INSTALLATION.

- DEMOLITION KEYNOTES:**
- 1 REMOVE EXISTING BASE TRIM. REPAIR ANY DAMAGED WALLS TO A LEVEL 4 FINISH TO MATCH ADJACENT. ENSURE CLEAN AND MOUNTABLE SURFACE FOR NEW BASE APPLICATION.
- 2 REMOVE EXISTING THRESHOLD/TRANSITION STRIP.
- 3 REMOVE AND DISPOSE OF EXISTING CARPET, PAD, AND TACKSTRIPS DOWN TO VINYL TILE BELOW. CLEAN AND PREPARE EXISTING VINYL TILE TO NEW FLOOR MANUFACTURER'S RECOMMENDATIONS FOR INSTALLATION.
- 4 REMOVE EXISTING WALK-OFF CARPET TILES DOWN TO VINYL TILE BELOW. CLEAN AND PREPARE EXISTING VINYL TILE TO NEW FLOOR MANUFACTURER'S RECOMMENDATIONS FOR INSTALLATION. RELINQUISH UNDAMAGED WALK-OFF CARPET TILES TO OWNER.
- 5 CLEAN EXISTING VINYL TILE TO REMAIN, AND PREPARE SURFACE TO NEW FLOOR MANUFACTURER'S RECOMMENDATIONS FOR INSTALLATION.
- 6 REMOVE EXISTING CERAMIC FLOOR TILE AND MORTAR DOWN TO SUBFLOOR BELOW. SMOOTH AND PREPARE SUBFLOOR TO NEW FLOOR MANUFACTURER'S RECOMMENDATIONS FOR INSTALLATION.
- 7 REMOVE EXISTING STAIR NOSING, TREAD, AND RISER. EXISTING VINYL FLOOR TILE AT LANDING TO REMAIN.

- ALTERNATE NO. 3 - RENOVATION KEYNOTES:**
- A1 INSTALL NEW CARPET TILE (CPT). EXISTING FLOOR DUCTS TO REMAIN ACCESSIBLE UNLESS INDICATED OTHERWISE.
- A2 INSTALL NEW VINYL COVE BASE. PATCH AND REPAIR EXISTING WALL DAMAGE TO LEVEL 4 FINISH PRIOR TO NEW BASE INSTALLATION. PAINT TO MATCH ADJACENT FINISH.
- ALTERNATE NO. 2 - RENOVATION KEYNOTES:**
- A3 INSTALL NEW METAL TRANSITION STRIP. NEW FLOOR SHOULD BE SQUARELY CUT AND LEVEL WITH ADJOINING FLOOR FINISH. PROVIDE TRANSITION PROFILE TO ACCOMMODATE CHANGE IN FLOOR HEIGHT.
- A4 INSTALL NEW CERAMIC FLOOR TILE.

- RENOVATION KEYNOTES:**
- 1 INSTALL NEW CARPET TILE (CPT). EXISTING FLOOR DUCTS TO REMAIN ACCESSIBLE UNLESS INDICATED OTHERWISE.
- 2 INSTALL NEW WALK-OFF CARPET TILE (WOC).
- 3 INSTALL NEW VINYL COVE BASE. PATCH AND REPAIR EXISTING WALL DAMAGE TO LEVEL 4 FINISH PRIOR TO NEW BASE INSTALLATION. PAINT TO MATCH ADJACENT FINISH.
- 4 INSTALL NEW CERAMIC FLOOR TILE.
- 5 INSTALL NEW METAL TRANSITION STRIP. NEW FLOOR SHOULD BE SQUARELY CUT AND LEVEL WITH ADJOINING FLOOR FINISH. PROVIDE TRANSITION PROFILE TO ACCOMMODATE CHANGE IN FLOOR HEIGHT.
- 6 INSTALL NEW STAIR TREAD WITH INTEGRATED RISER.
- 7 INSTALL NEW CARPET TILE OVER EXISTING WALKERDUCT PLATE.
- 8 INSTALL NEW VINYL TRANSITION STRIP. PROVIDE TRANSITION PROFILE TO ACCOMMODATE CHANGE IN FLOOR HEIGHT.

STATE OF MISSOURI
MIKE KEHOE,
GOVERNOR



Brad M. Schaefer - Architect
MO# A-2009027294

BID DOCUMENTS

OFFICE OF ADMINISTRATION
DIVISION OF FACILITIES
MANAGEMENT,
DESIGN AND CONSTRUCTION

DEPARTMENT OF
PUBLIC SAFETY
STATE HIGHWAY PATROL

RENOVATE INTERIOR

GENERAL HEADQUARTERS
1510 EAST ELM STREET
JEFFERSON CITY, MO 65101

PROJECT # R2410-01
SITE # 6001
ASSET # 8136001001

REVISION: _____
DATE: _____
REVISION: _____
DATE: _____
REVISION: _____
DATE: _____
ISSUE DATE: 06/18/2026


CAD DWG FILE: _____
DRAWN BY: RG/CL
CHECKED BY: BMS
DESIGNED BY: CL

SHEET TITLE:
GHQ SECOND
FLOOR PLAN

SHEET NUMBER:

A-103


5 OF 39 SHEETS
06/18/2026

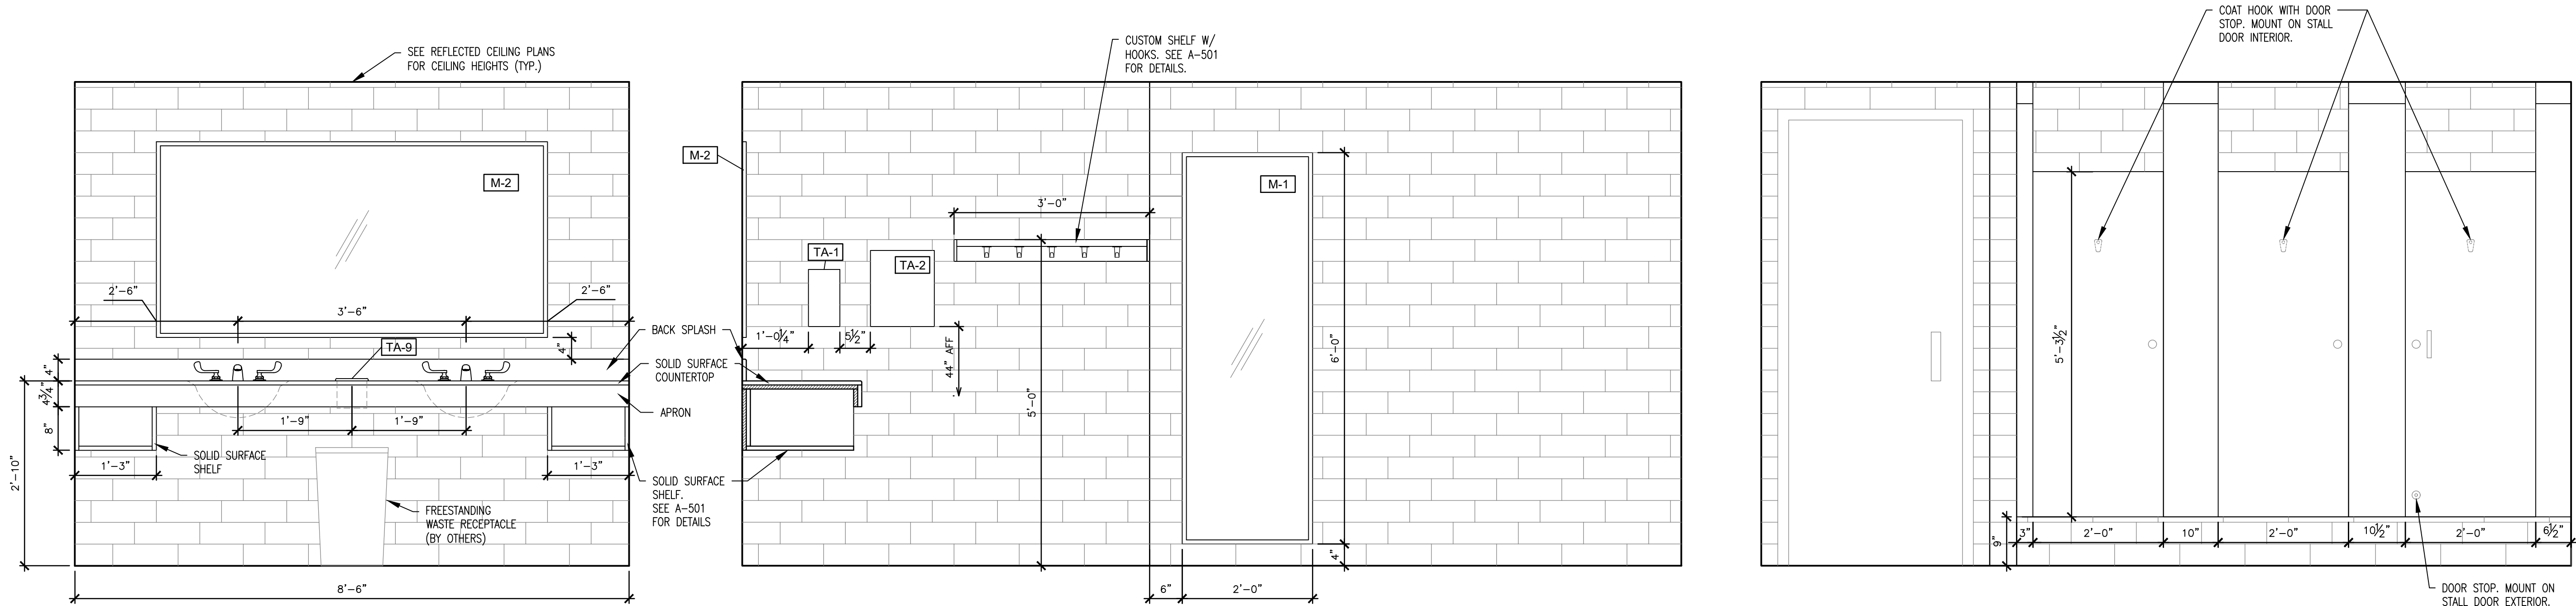


1 TYP. SINK ELEVATION - WOMENS RESTROOMS B24, 117, AND 4
SCALE: 3/4" = 1'-0"

2 TYP. ELEVATION - WOMENS RESTROOMS B24 AND 117
SCALE: 3/4" = 1'-0"


3 TYP. ELEVATION - RESTROOMS B24 AND 4
SCALE: 3/4" = 1'-0"

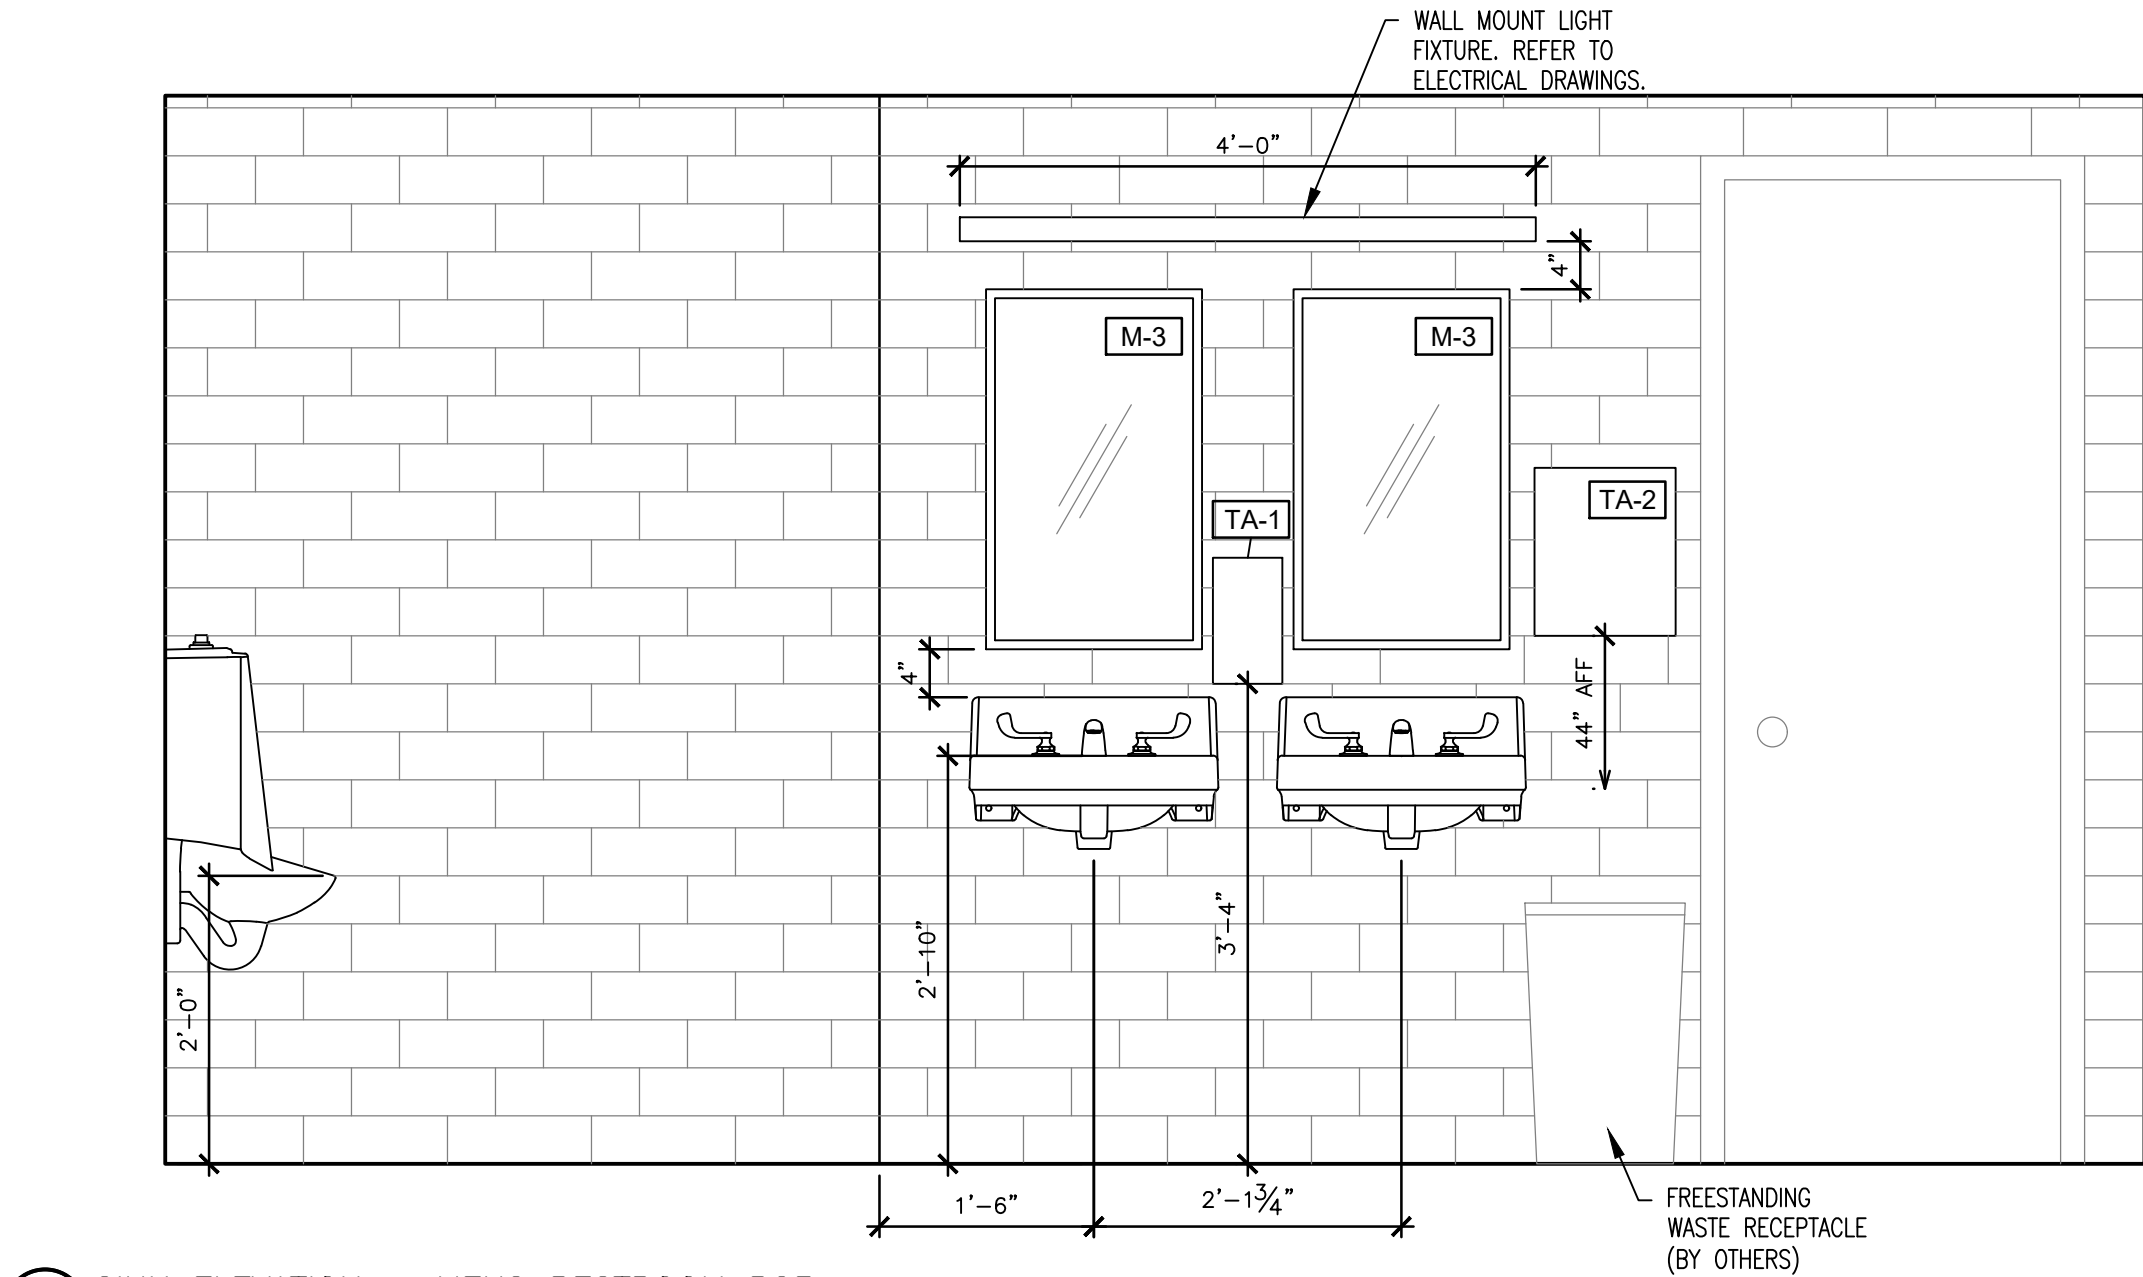


4 SINK ELEVATION - MENS RESTROOM B23
SCALE: 3/4" = 1'-0"

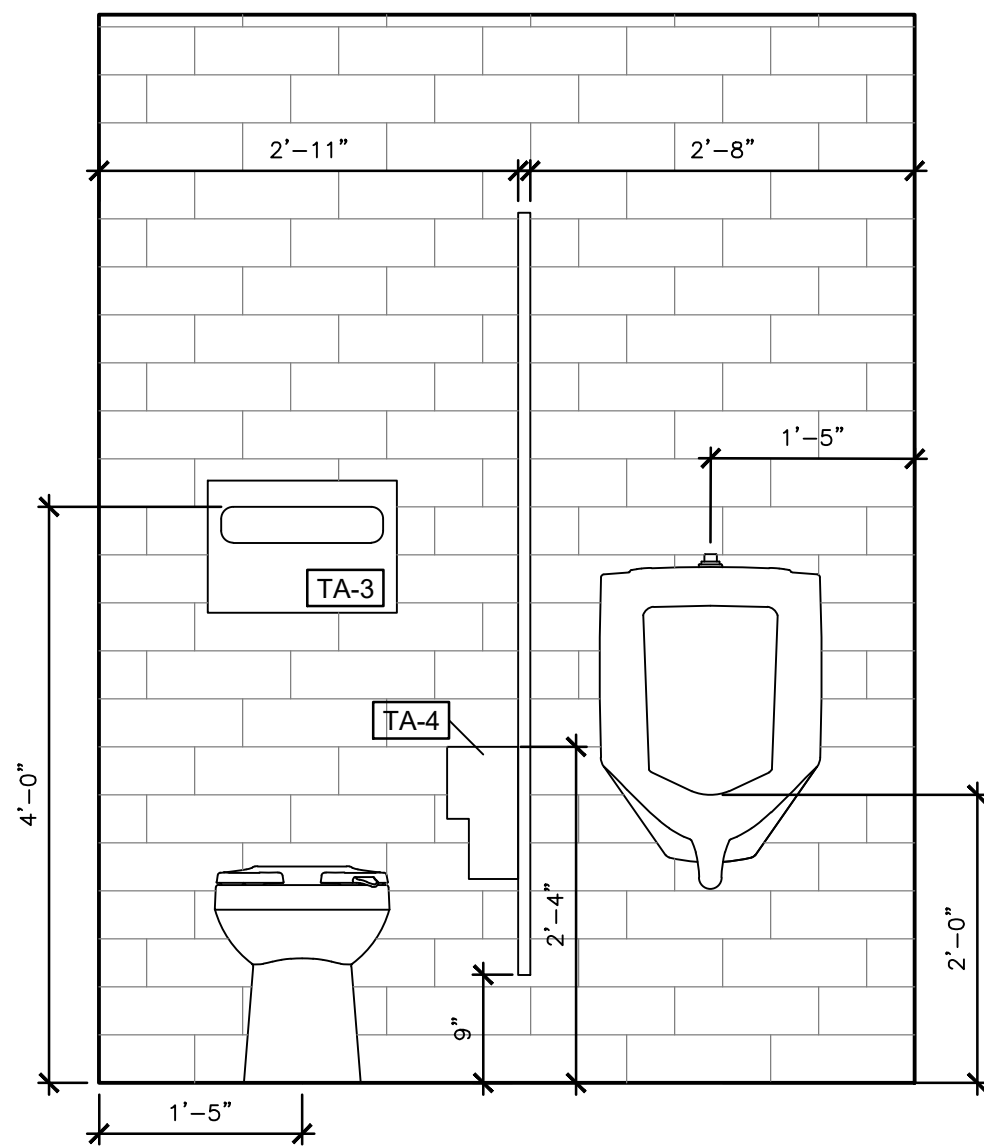


5 ELEVATION - MENS RESTROOM B23
SCALE: 3/4" = 1'-0"

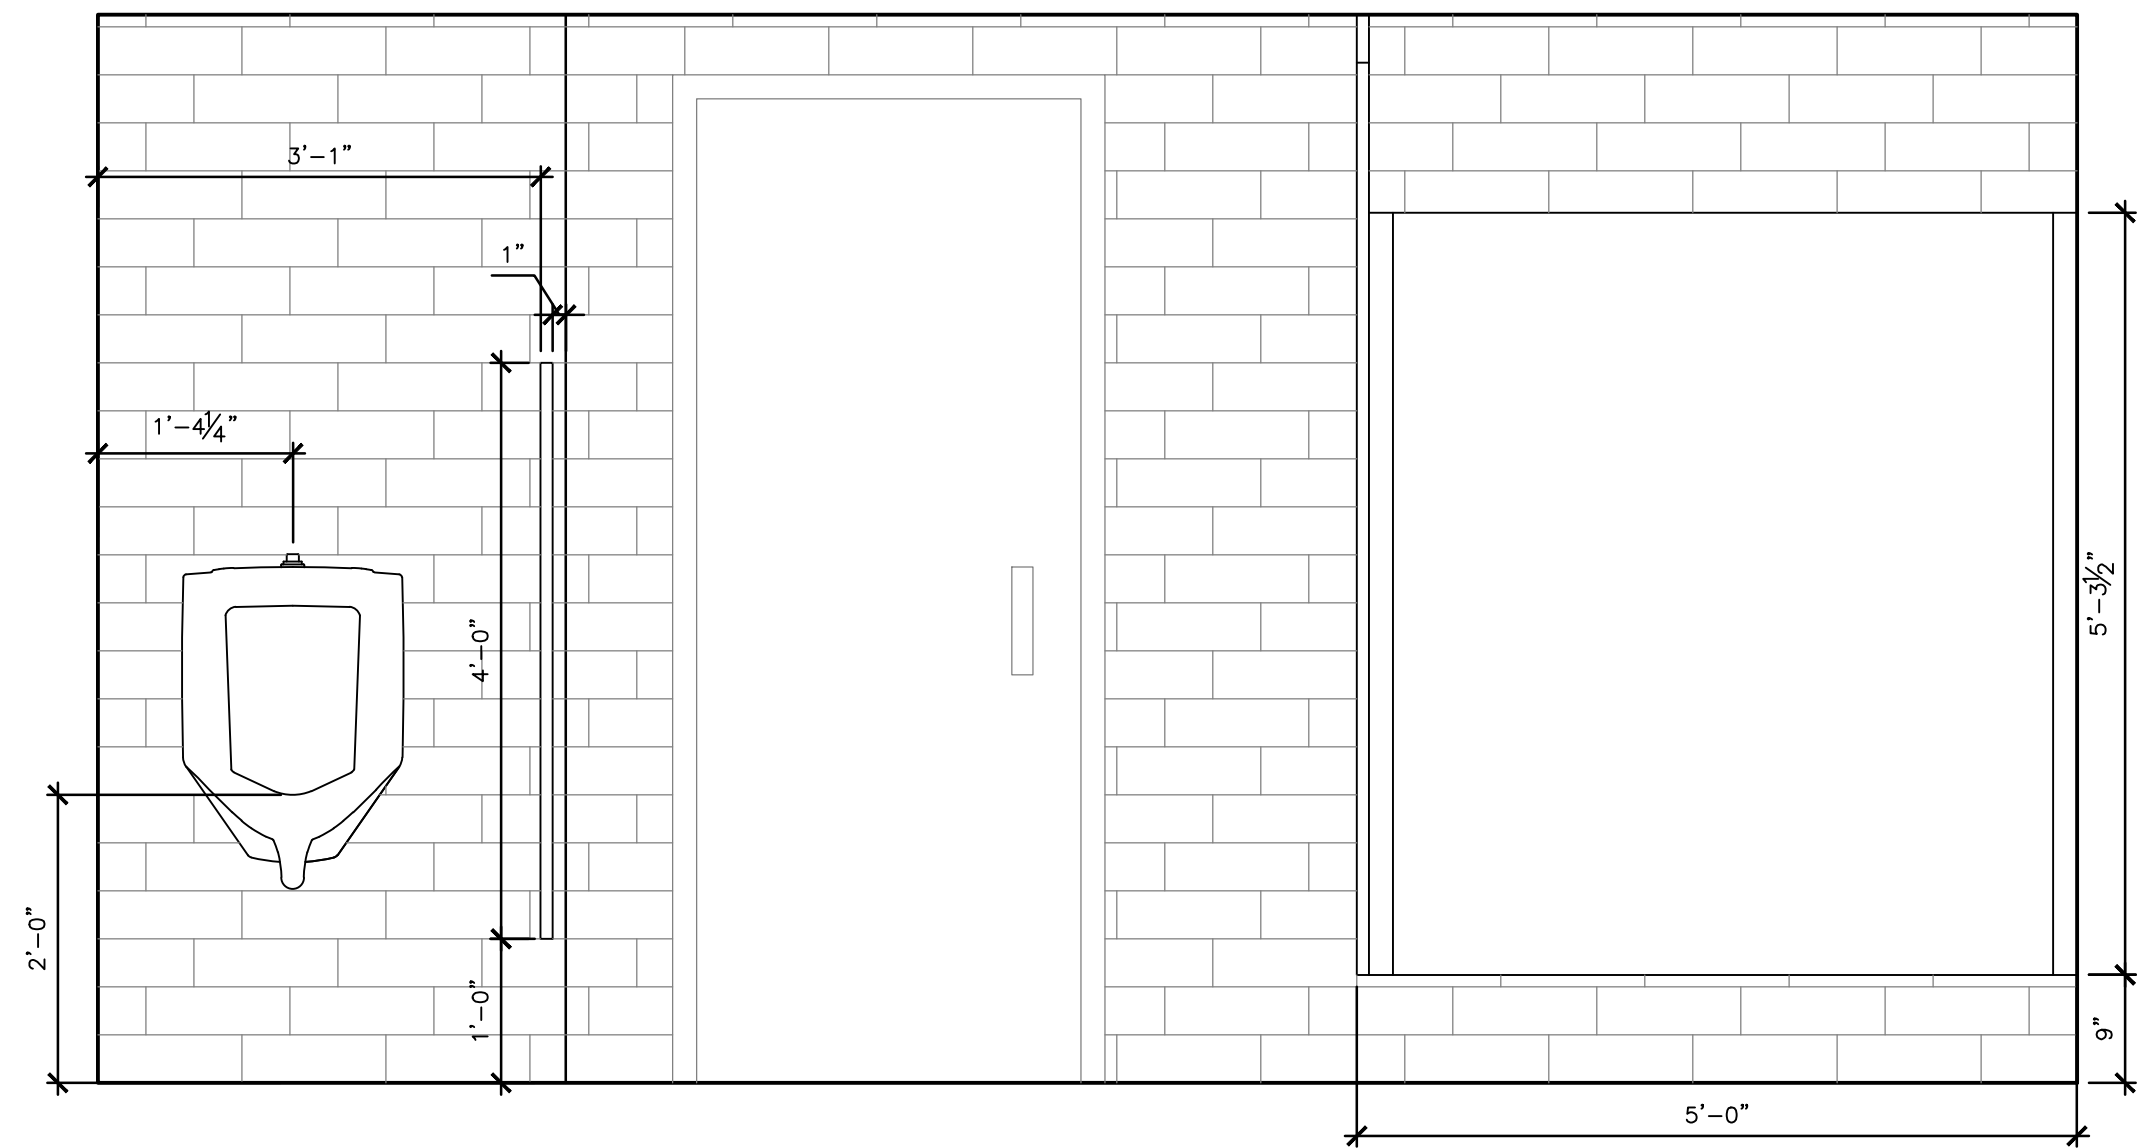

6 ELEVATION - MENS RESTROOM B23
SCALE: 3/4" = 1'-0"

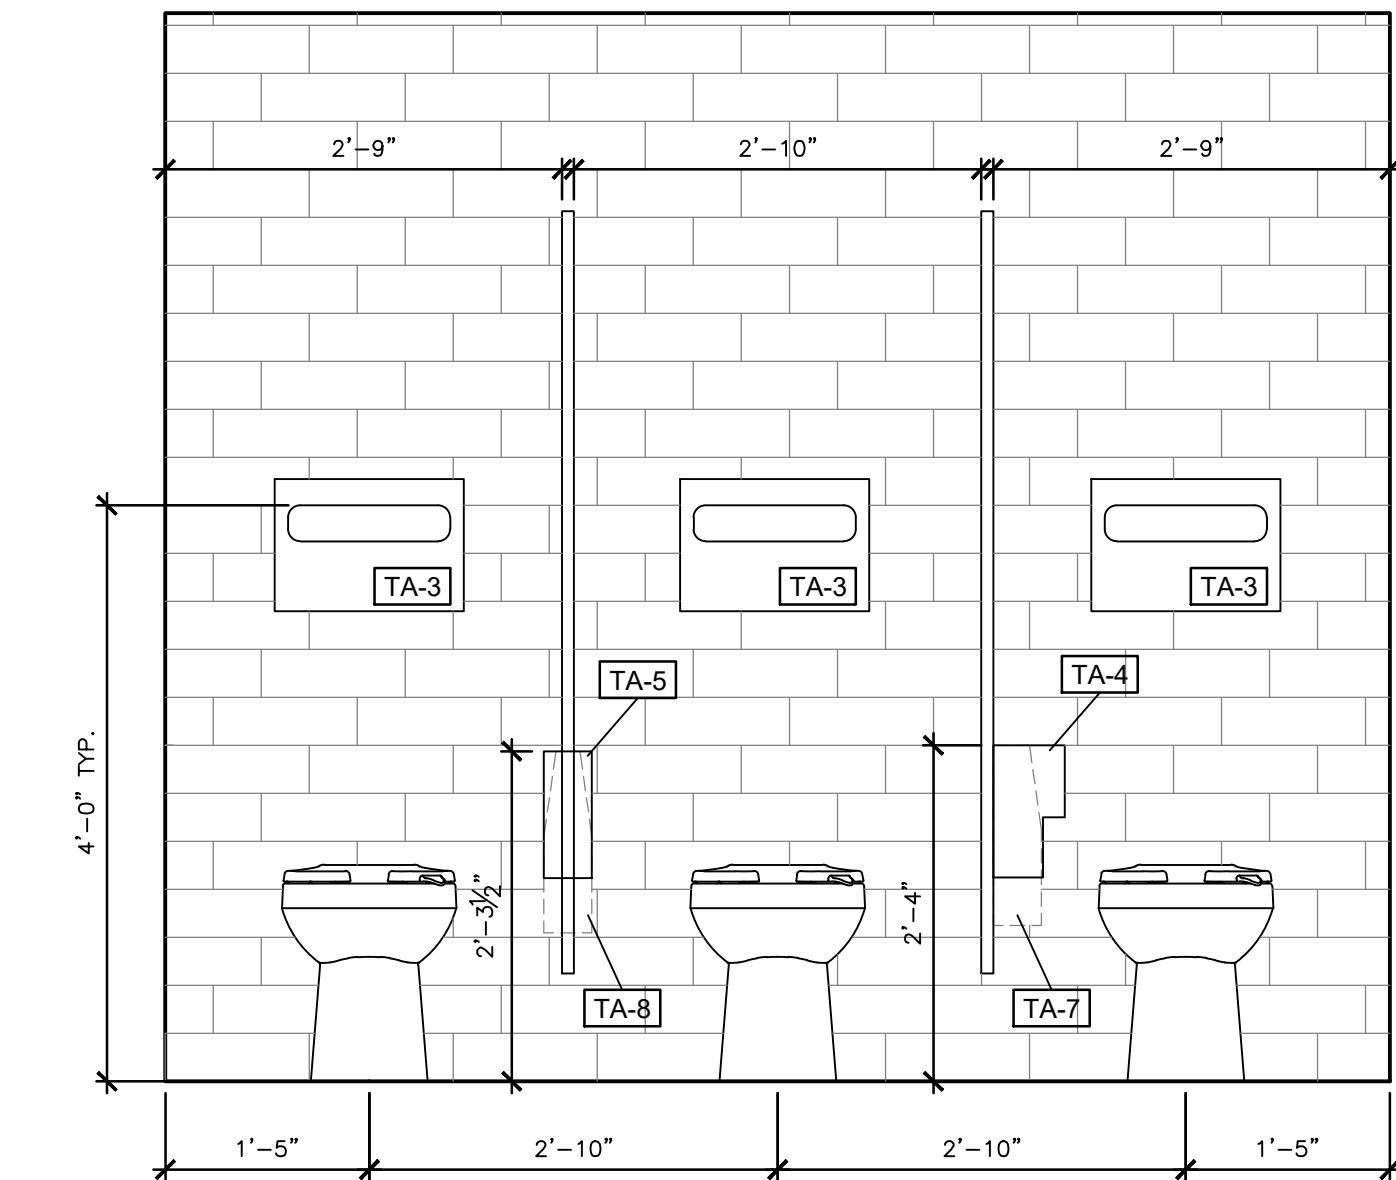


7 TYP. ELEVATION - WOMENS RESTROOMS B24 AND 4
SCALE: 3/4" = 1'-0"

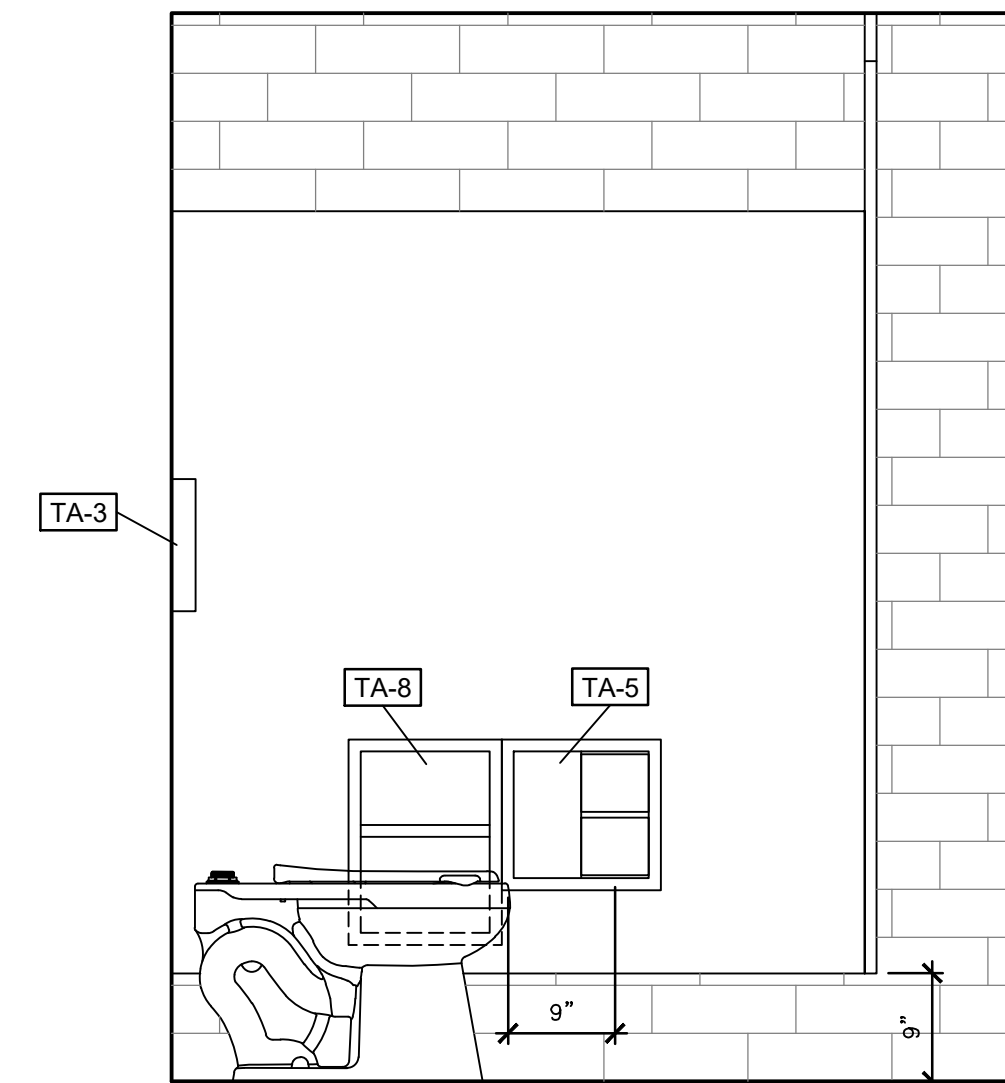

8 TYP. WOMENS TOILET ELEVATION - WITH DUAL SIDED ACCESSORIES
SCALE: 3/4" = 1'-0"

RESTROOM FIXTURE SCHEDULE SHEET REFERENCE	
MARK	PRODUCT
M-1	MIRROR
M-2	MIRROR
M-3	MIRROR
TA-1	SOAP DISPENSER
TA-2	PAPER TOWEL DISPENSER
TA-3	TOILET SEAT COVER DISPENSER
TA-4	TOILET PAPER DISPENSER
TA-5	TOILET PAPER DISPENSER
TA-7	SANITARY NAPKIN DISPOSAL
TA-8	SANITARY NAPKIN DISPOSAL
TA-9	CIRCULAR WASTE CHUTE

*SEE A-601 FOR FULL RESTROOM FIXTURE SCHEDULE.
*ALL FIXTURES TO BE LOCATED AT ADA STANDARD HEIGHTS & SETBACKS UNLESS NOTED OTHERWISE.

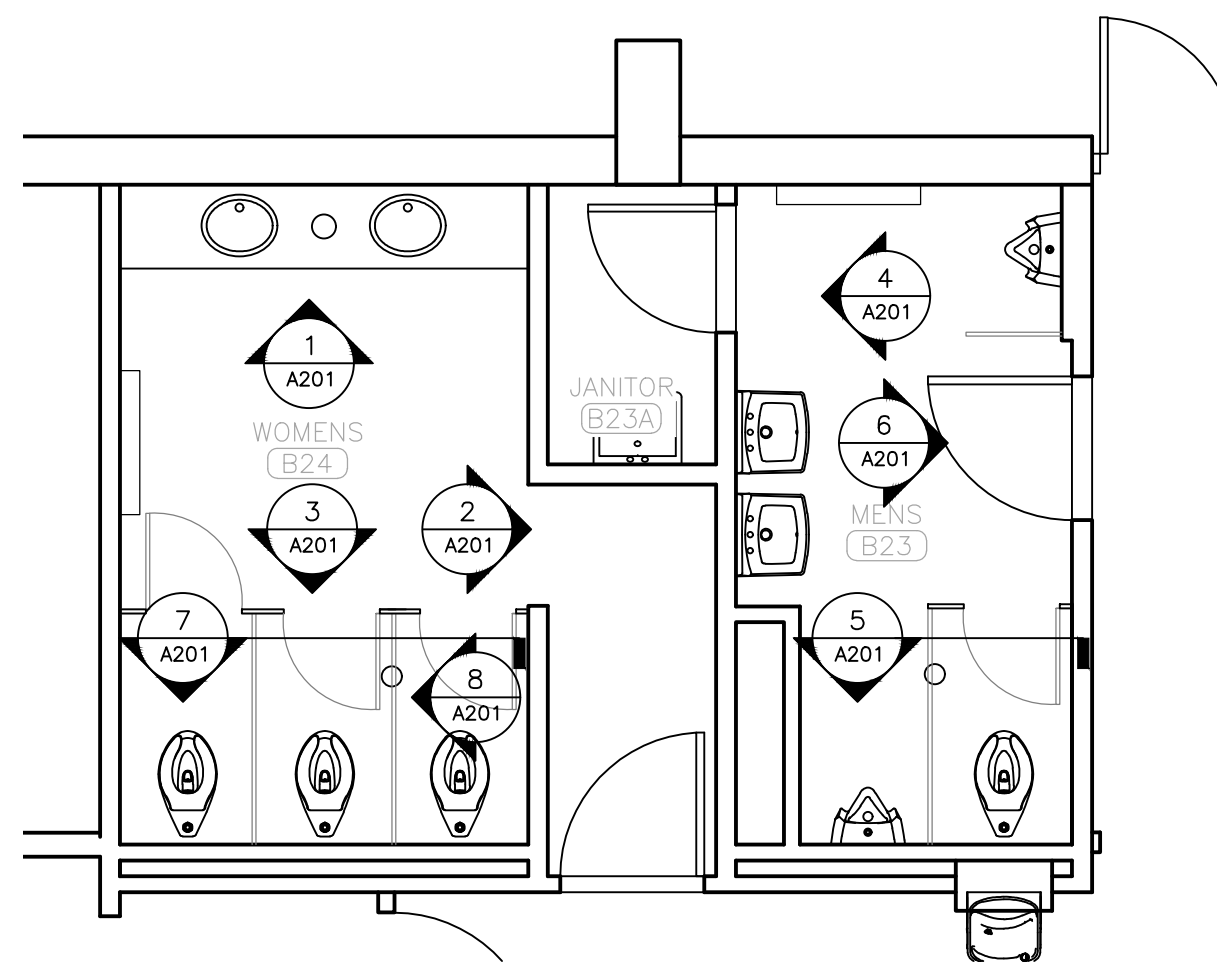

9 KEYPLAN - RESTROOMS B23 & B24 (ALTERNATE NO.1)
SCALE: 1/4" = 1'-0"



Brad M. Schaefer - Architect
MO# A-2009027294

BID DOCUMENTS

OFFICE OF ADMINISTRATION
DIVISION OF FACILITIES
MANAGEMENT,
DESIGN AND CONSTRUCTION

DEPARTMENT OF
PUBLIC SAFETY
STATE HIGHWAY PATROL

RENOVATE INTERIOR

GENERAL HEADQUARTERS
1510 EAST ELM STREET
JEFFERSON CITY, MO 65101

PROJECT # R2410-01
SITE # 6001
ASSET # 8136001001

REVISION: _____
DATE: _____
REVISION: _____
DATE: _____
REVISION: _____
DATE: _____
ISSUE DATE: 06/18/2026

CAD DWG FILE: _____
DRAWN BY: CL
CHECKED BY: BMS
DESIGNED BY: CL

SHEET TITLE:

RESTROOM
ELEVATIONS

SHEET NUMBER:

A-201

6 OF 39 SHEETS
06/18/2026



Brad M. Schaefer - Architect
MO# A-2009027294

BID DOCUMENTS

OFFICE OF ADMINISTRATION
DIVISION OF FACILITIES
MANAGEMENT,
DESIGN AND CONSTRUCTION

DEPARTMENT OF
PUBLIC SAFETY
STATE HIGHWAY PATROL

RENOVATE INTERIOR

GENERAL HEADQUARTERS
1510 EAST ELM STREET
JEFFERSON CITY, MO 65101

PROJECT # R2410-01
SITE # 6001
ASSET # 8136001001

REVISION: _____
DATE: _____
REVISION: _____
DATE: _____
REVISION: _____
DATE: _____
ISSUE DATE: 06/18/2026

CAD DWG FILE: _____
DRAWN BY: CL
CHECKED BY: BMS
DESIGNED BY: CL


SHEET TITLE:

RESTROOM
ELEVATIONS


SHEET NUMBER:

A-202


7 OF 39 SHEETS
06/18/2026

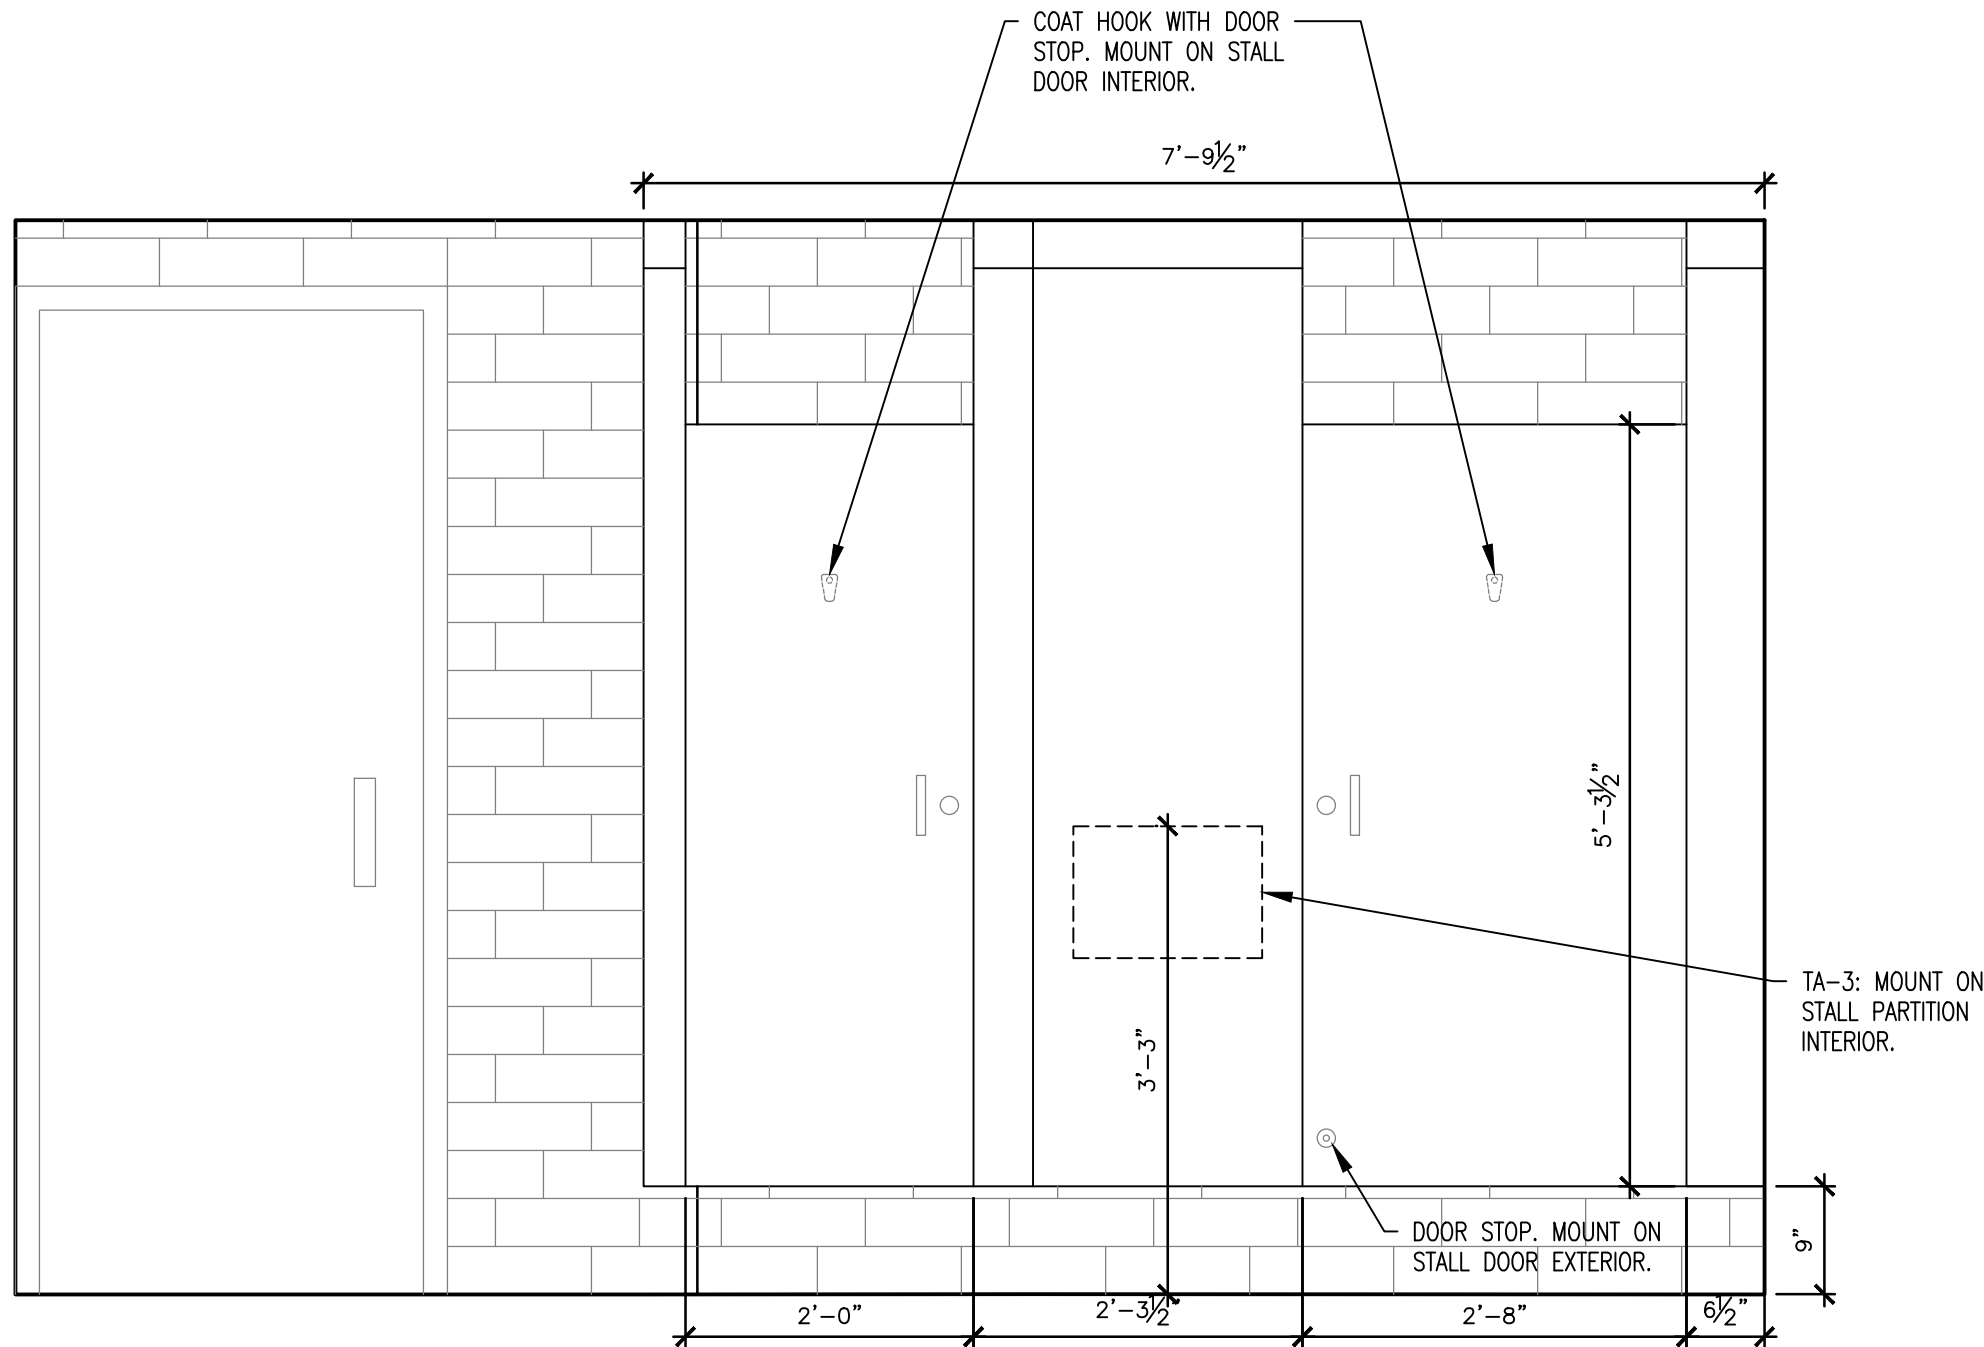


1 ELEVATION - WOMENS RESTROOM 117
SCALE: 3/4" = 1'-0"

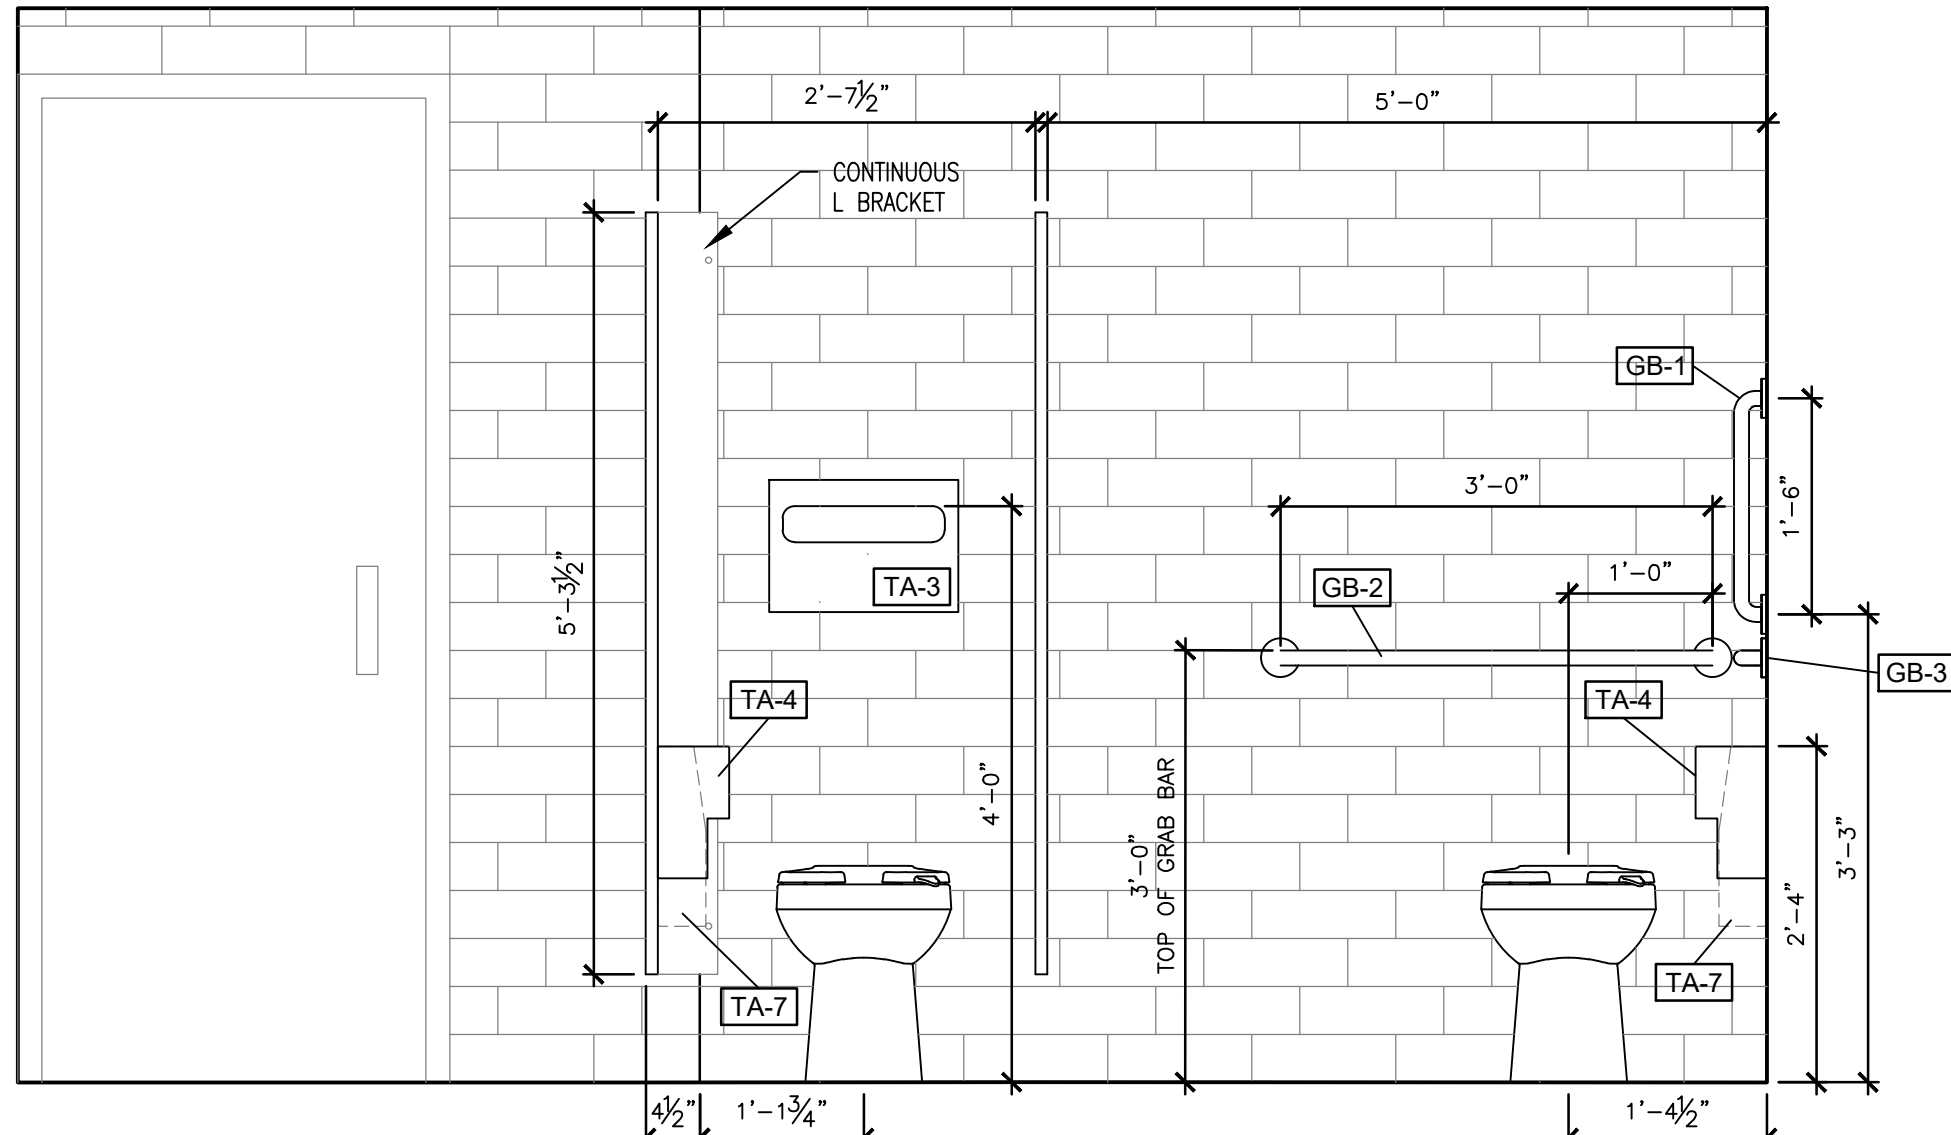


2 ELEVATION - WOMENS RESTROOM 117
SCALE: 3/4" = 1'-0"

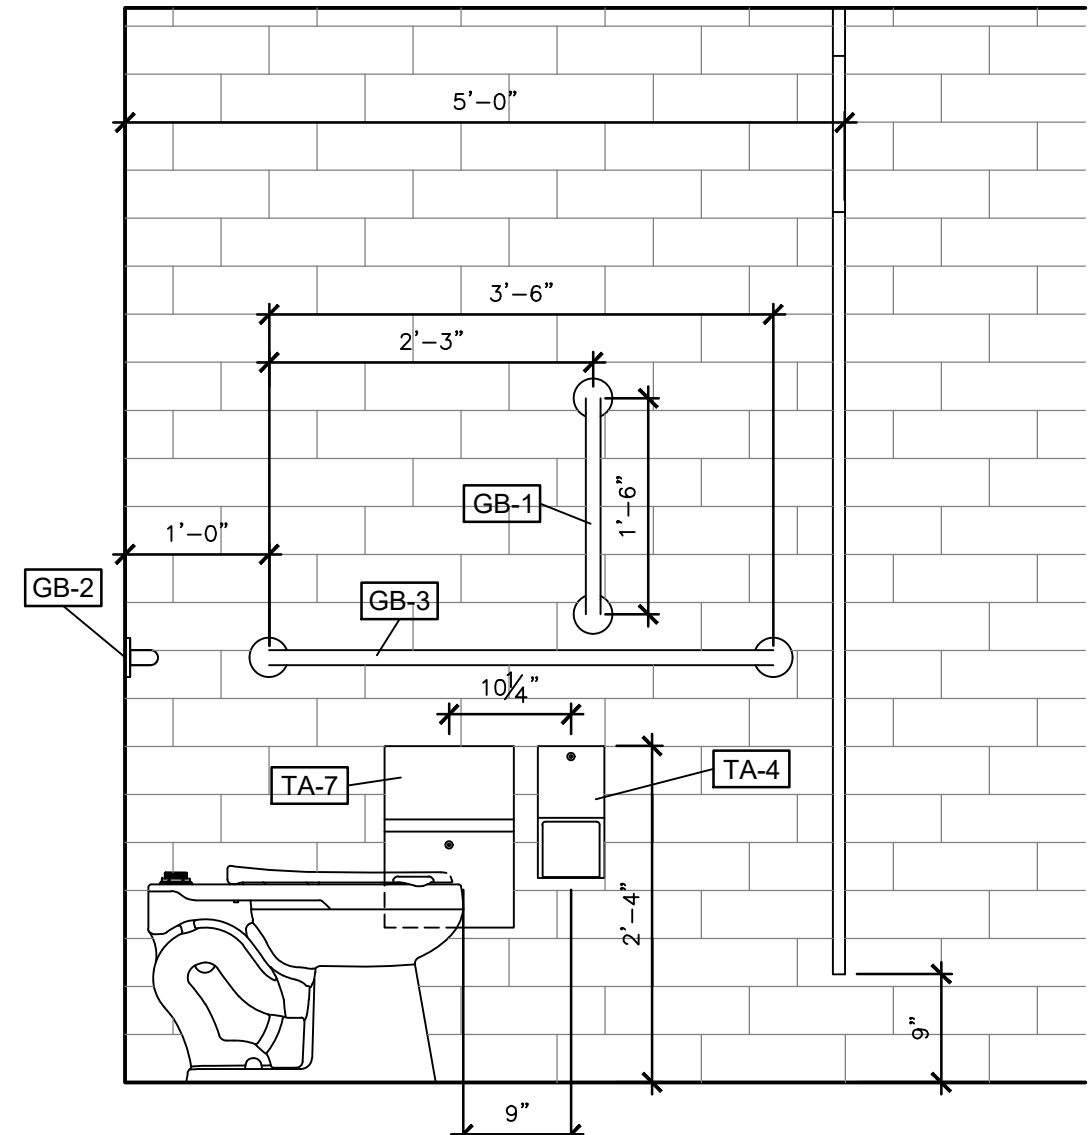


3 ELEVATION - WOMENS RESTROOM 117
SCALE: 3/4" = 1'-0"

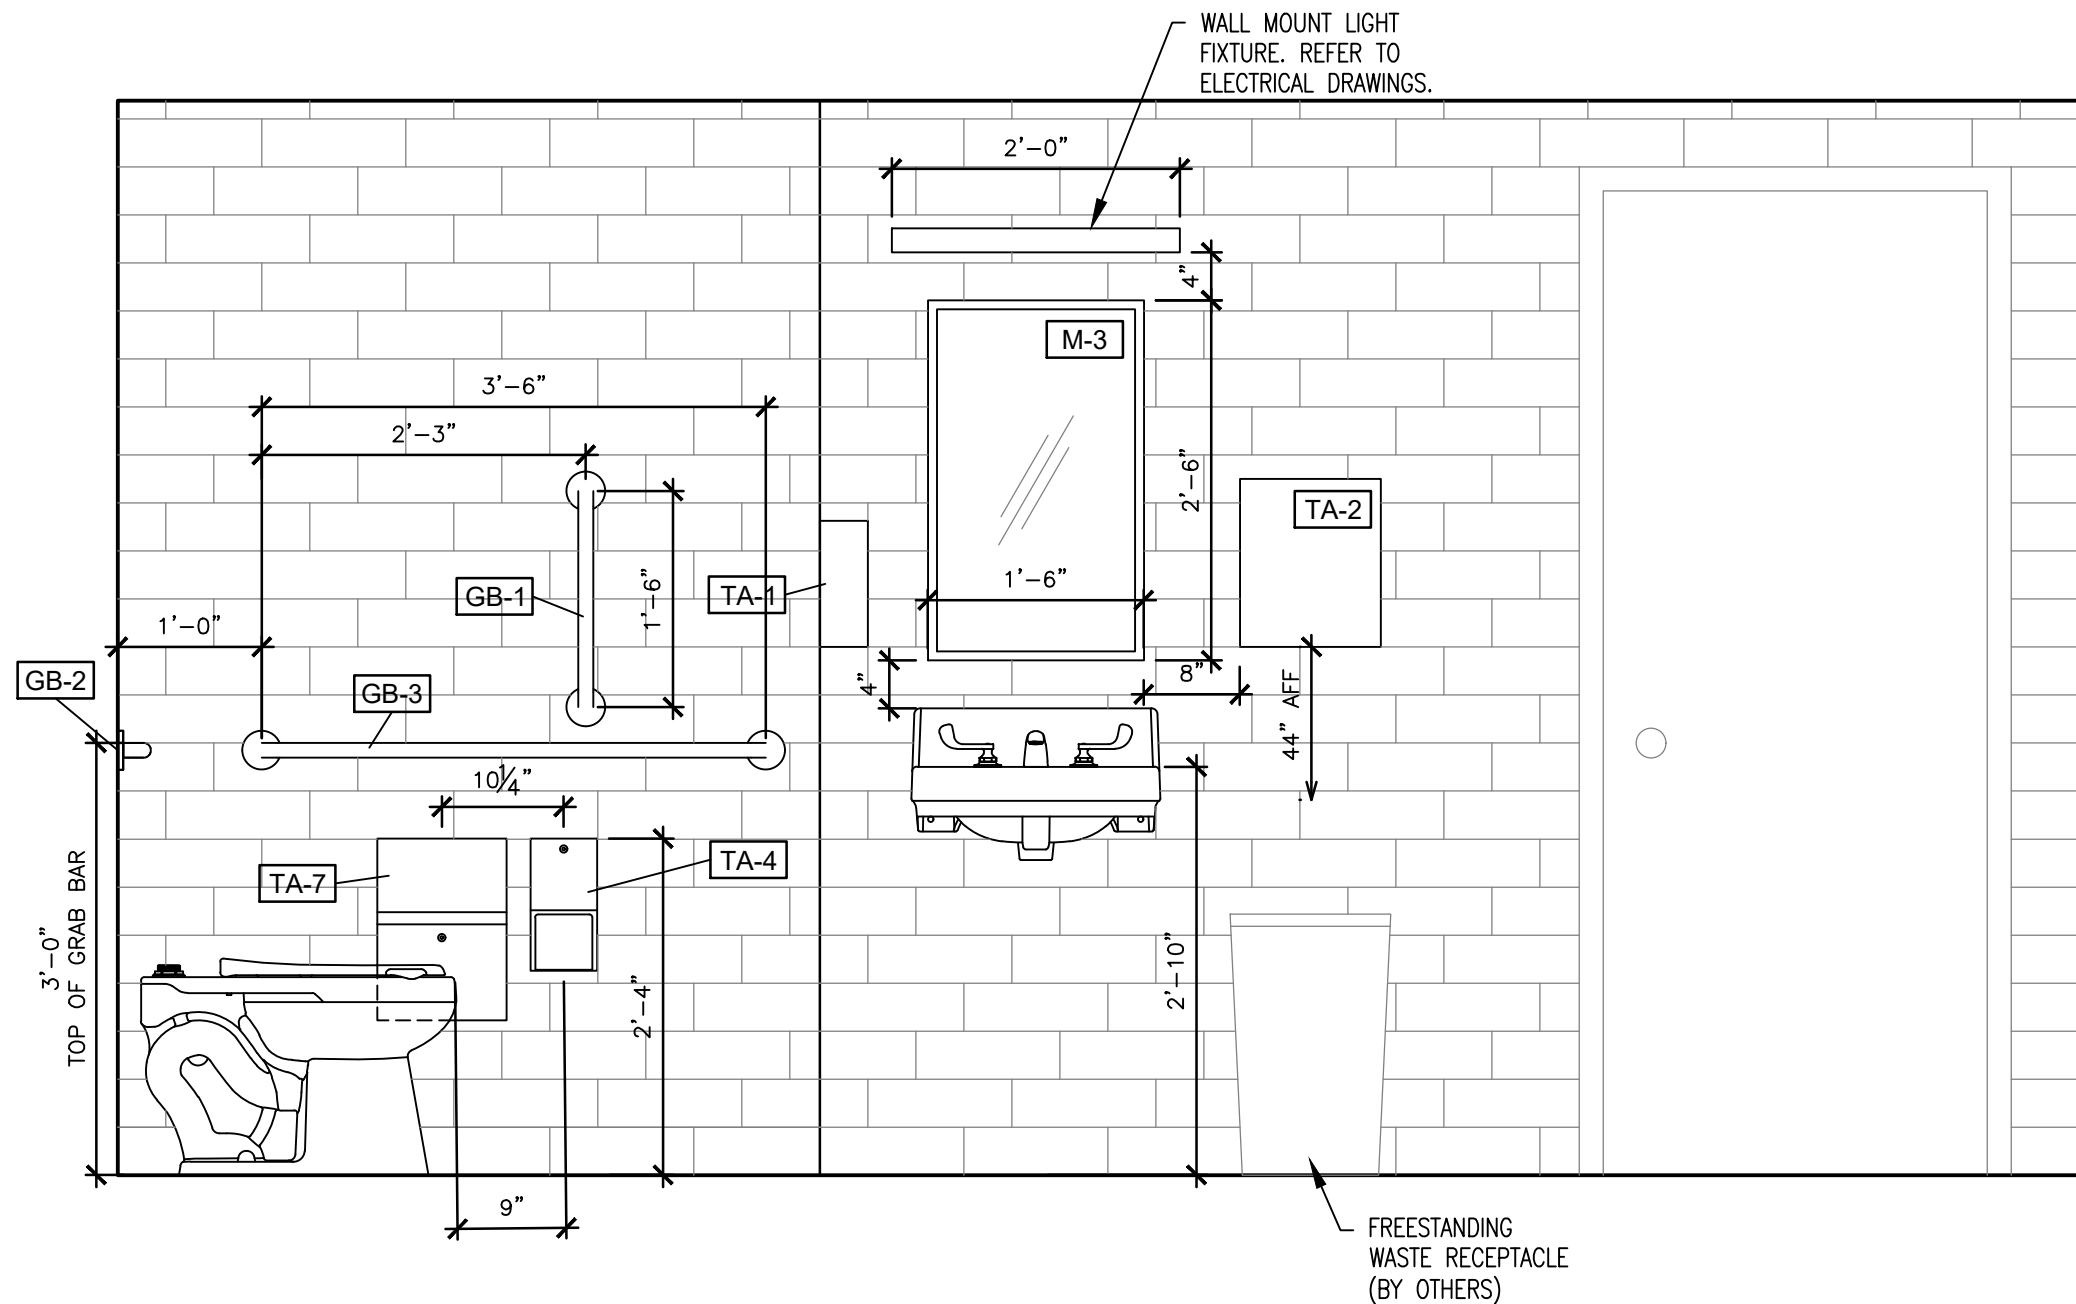

4 ELEVATION - ADA RESTROOM 118
SCALE: 3/4" = 1'-0"

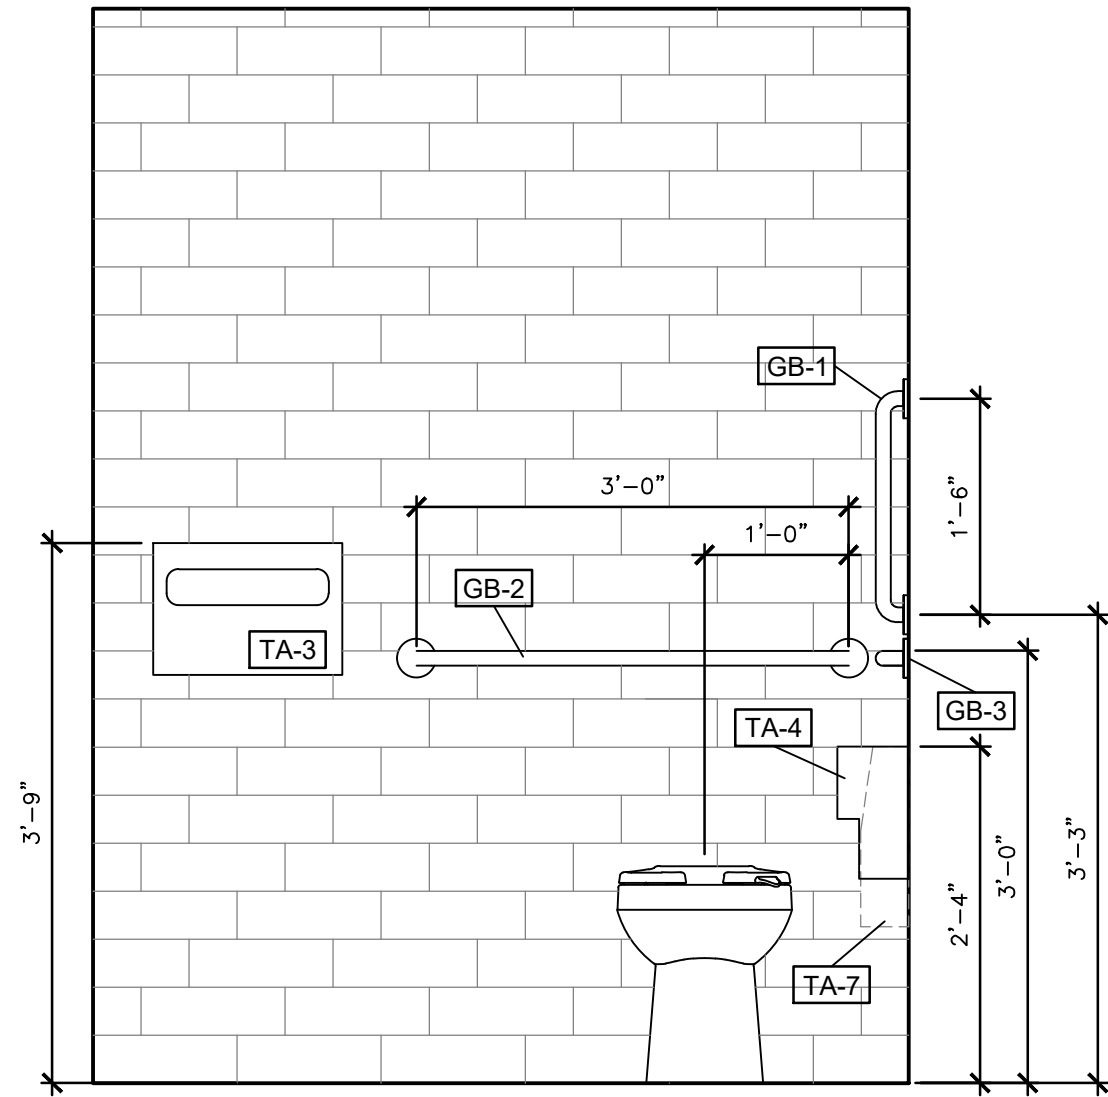


5 ELEVATION - ADA RESTROOM 118
SCALE: 3/4" = 1'-0"

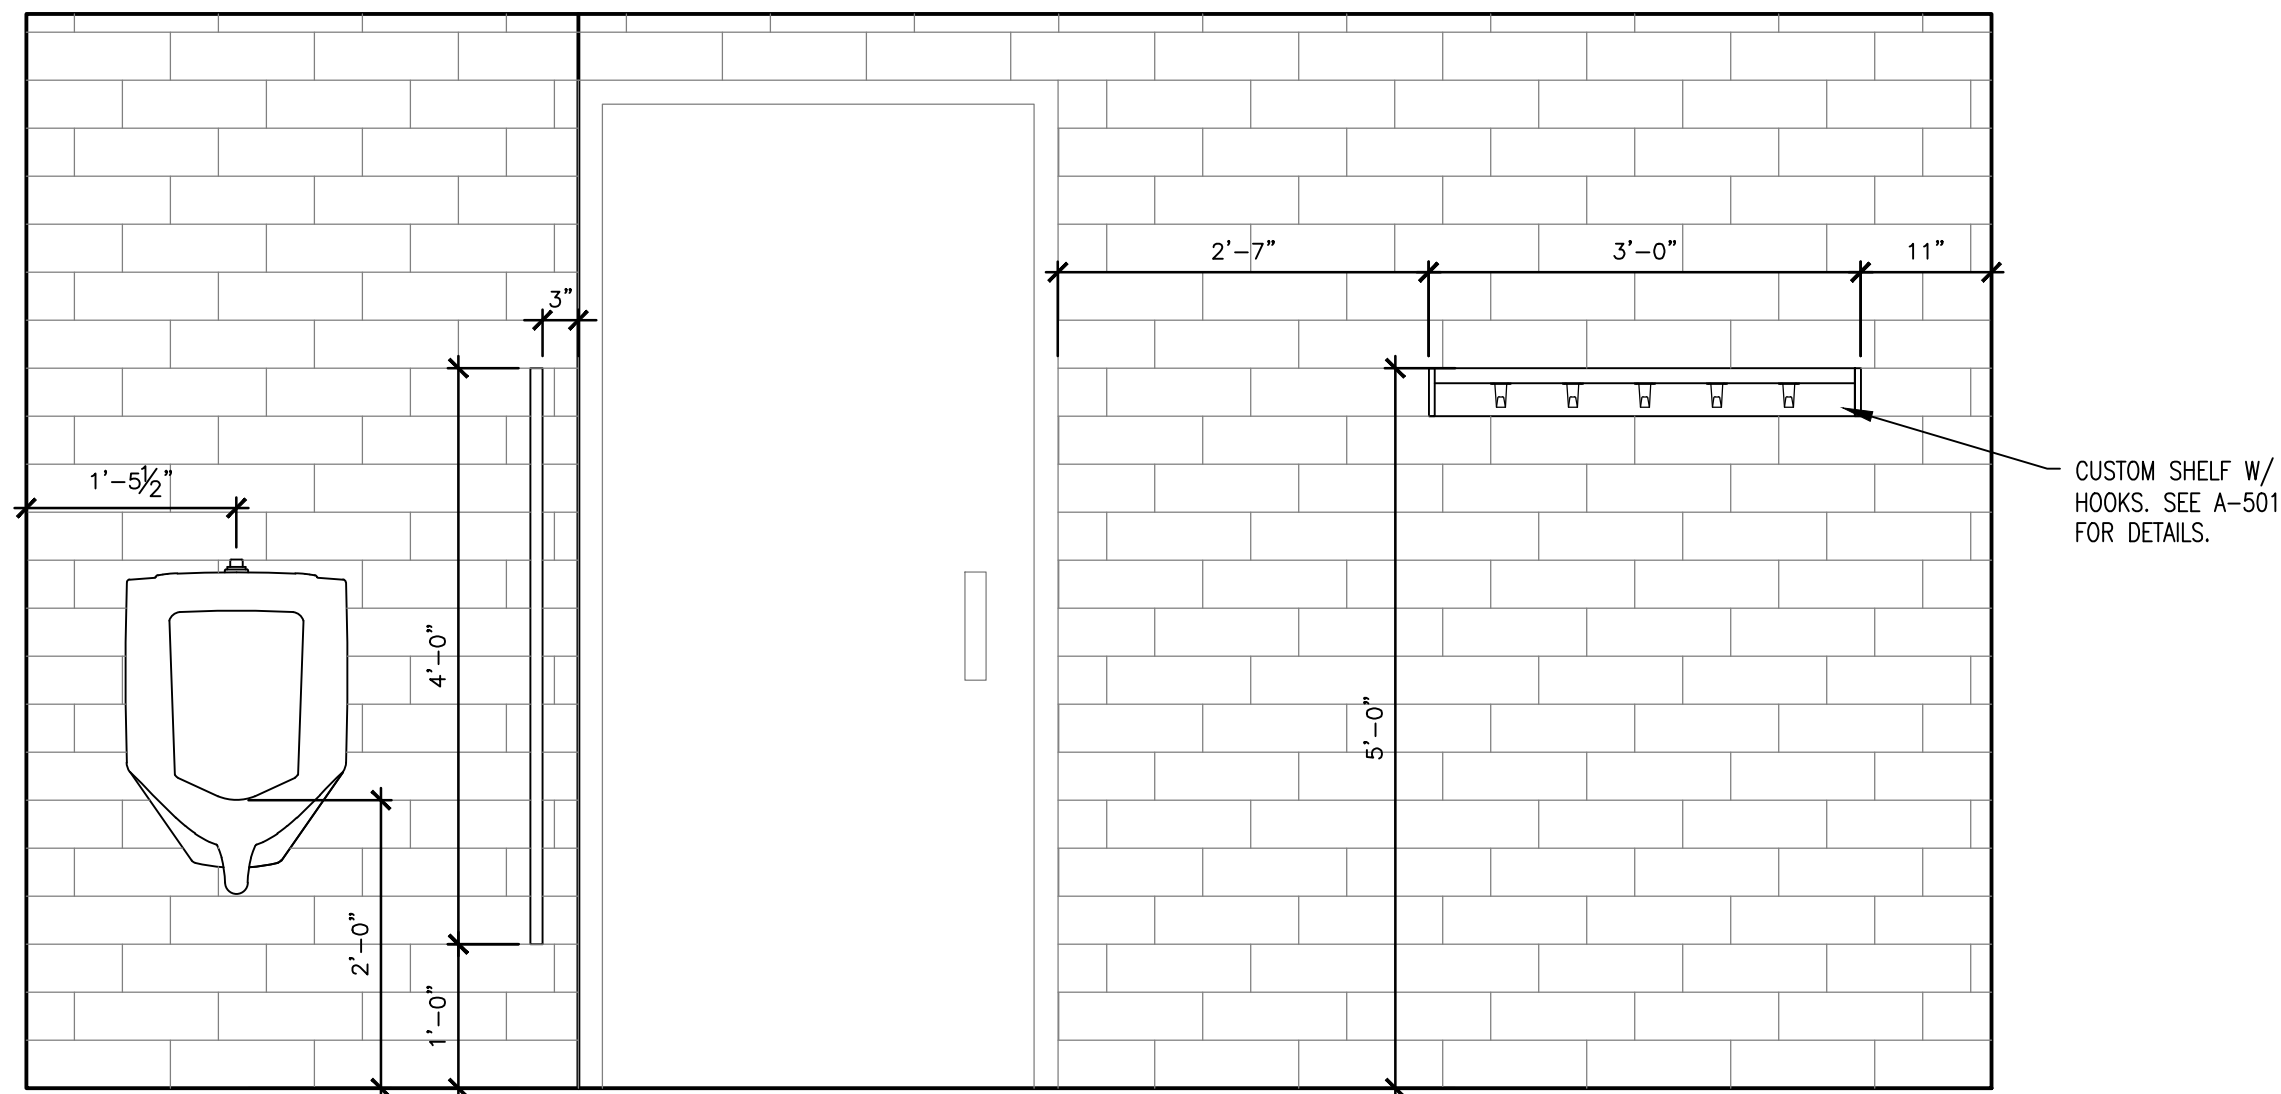

6 ELEVATION - ADA RESTROOM 118
SCALE: 3/4" = 1'-0"

RESTROOM FIXTURE SCHEDULE SHEET REFERENCE	
MARK	PRODUCT
GB-1	GRAB BAR
GB-2	GRAB BAR
GB-3	GRAB BAR
M-3	MIRROR
TA-1	SOAP DISPENSER
TA-2	PAPER TOWEL DISPENSER
TA-3	TOILET SEAT COVER DISPENSER
TA-4	TOILET PAPER DISPENSER
TA-7	SANITARY NAPKIN DISPOSAL

*SEE A-601 FOR FULL RESTROOM FIXTURE SCHEDULE.
*ALL FIXTURES TO BE LOCATED AT ADA STANDARD HEIGHTS & SETBACKS UNLESS NOTED OTHERWISE.

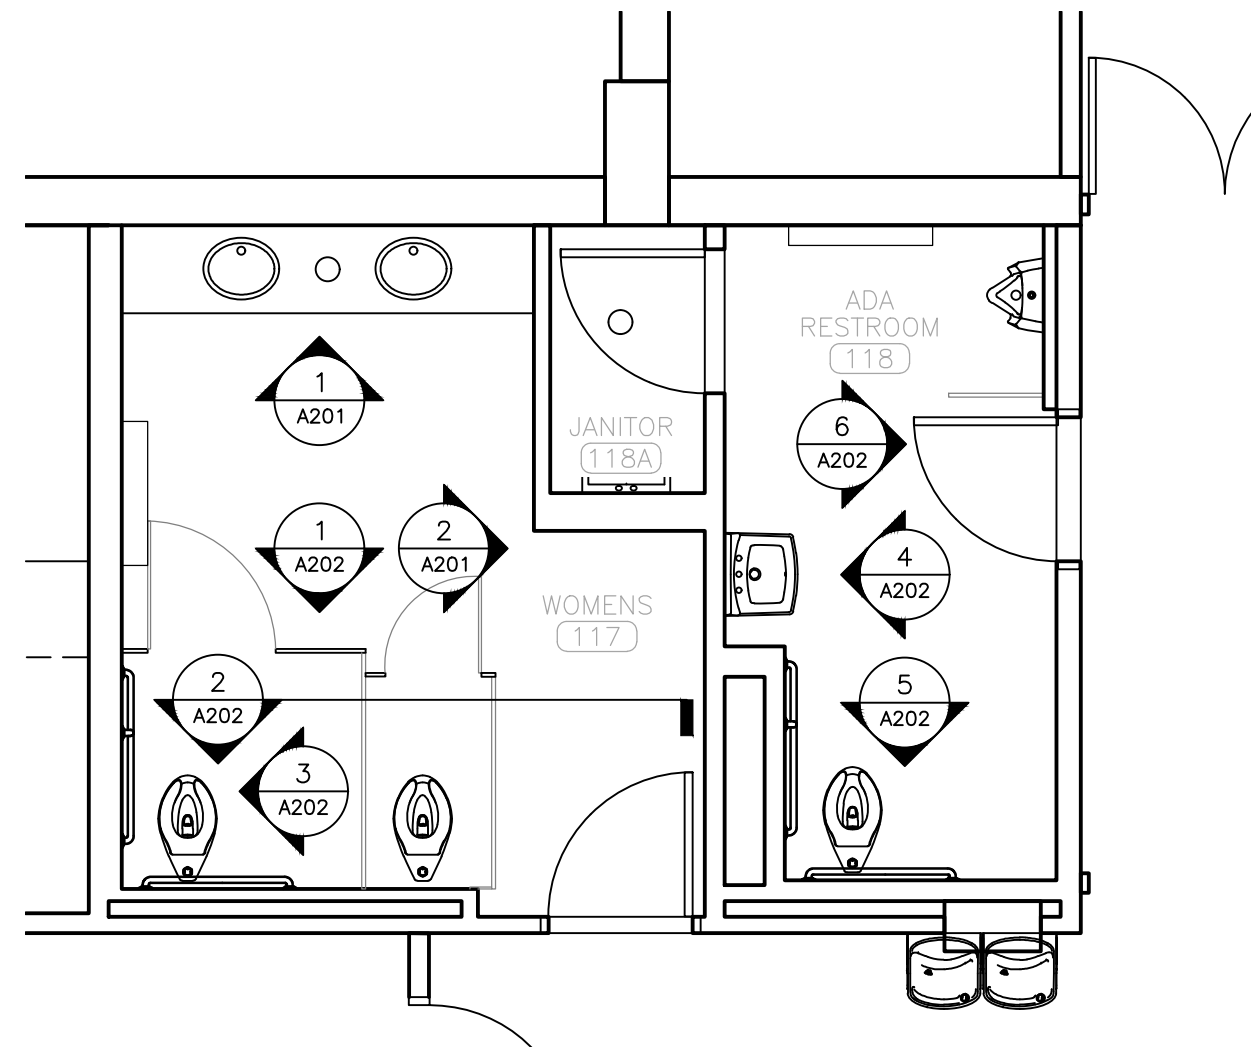

7 KEYPLAN - RESTROOMS 117 & 118
SCALE: 1/4" = 1'-0"



Brad M. Schaefer - Architect
MO# A-2009027294

BID DOCUMENTS

OFFICE OF ADMINISTRATION
DIVISION OF FACILITIES
MANAGEMENT,
DESIGN AND CONSTRUCTION

DEPARTMENT OF
PUBLIC SAFETY
STATE HIGHWAY PATROL

RENOVATE INTERIOR

GENERAL HEADQUARTERS
1510 EAST ELM STREET
JEFFERSON CITY, MO 65101

PROJECT # R2410-01
SITE # 6001
ASSET # 8136001001

REVISION: _____
DATE: _____
REVISION: _____
DATE: _____
REVISION: _____
DATE: _____
ISSUE DATE: 06/18/2026

CAD DWG FILE: _____
DRAWN BY: CL
CHECKED BY: BMS
DESIGNED BY: CL


SHEET TITLE:

RESTROOM
ELEVATIONS


SHEET NUMBER:

A-203


8 OF 39 SHEETS
06/18/2026

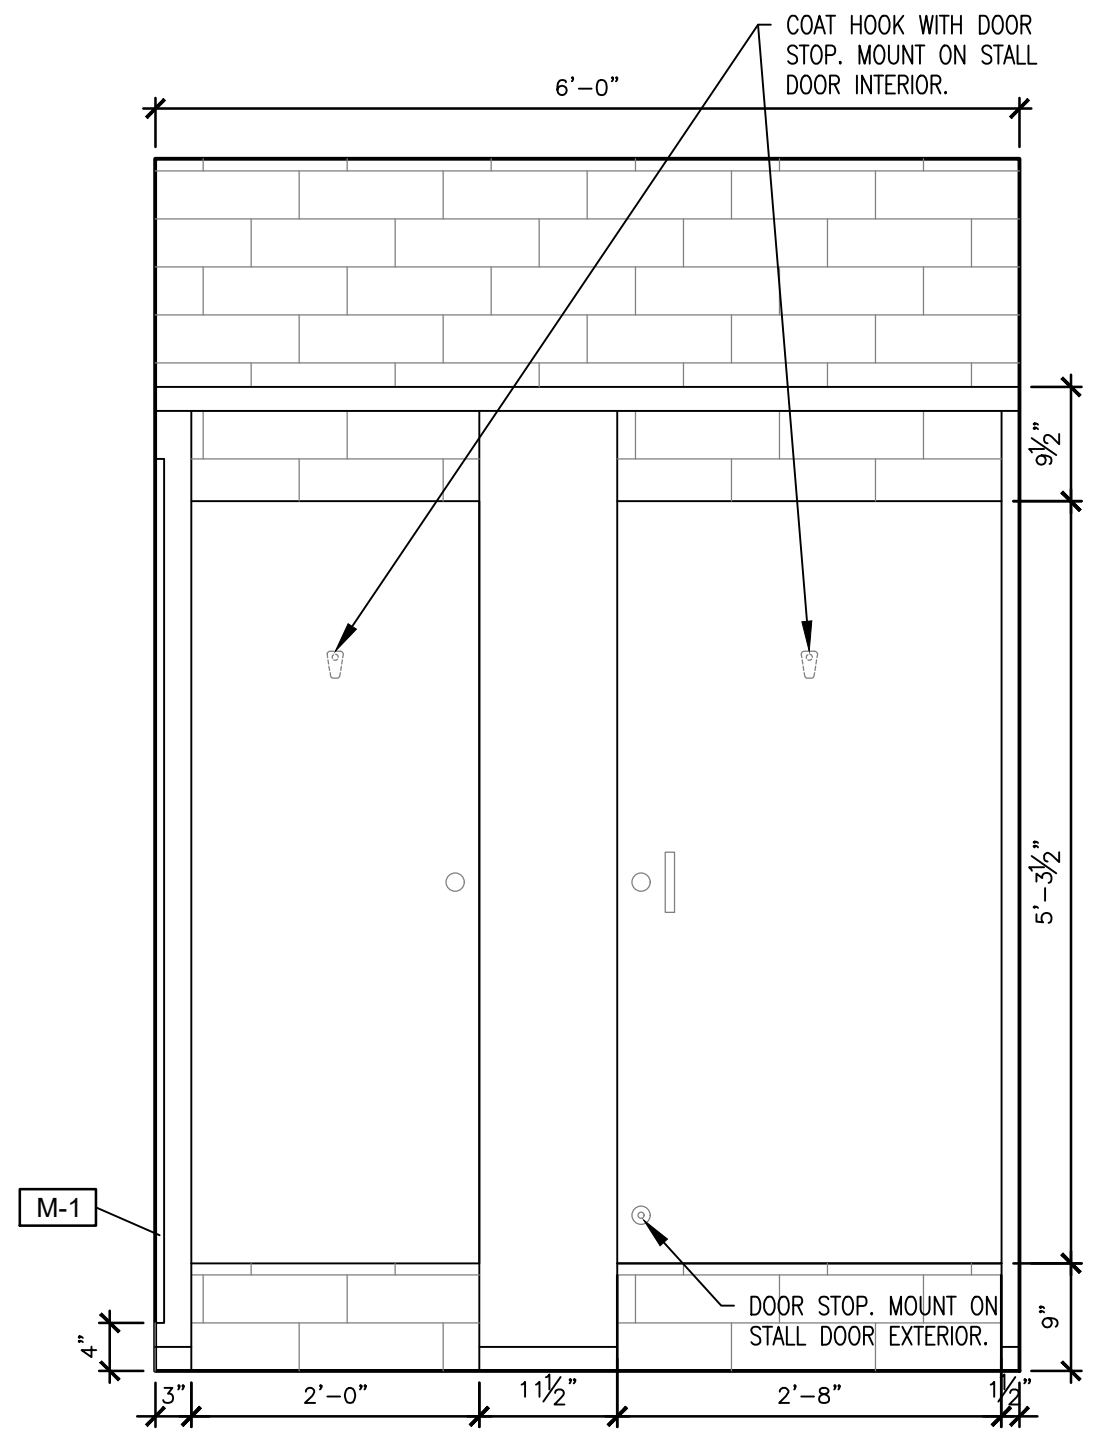


1 ELEVATION — WOMENS RESTROOM 125
SCALE: 3/4" = 1'-0"

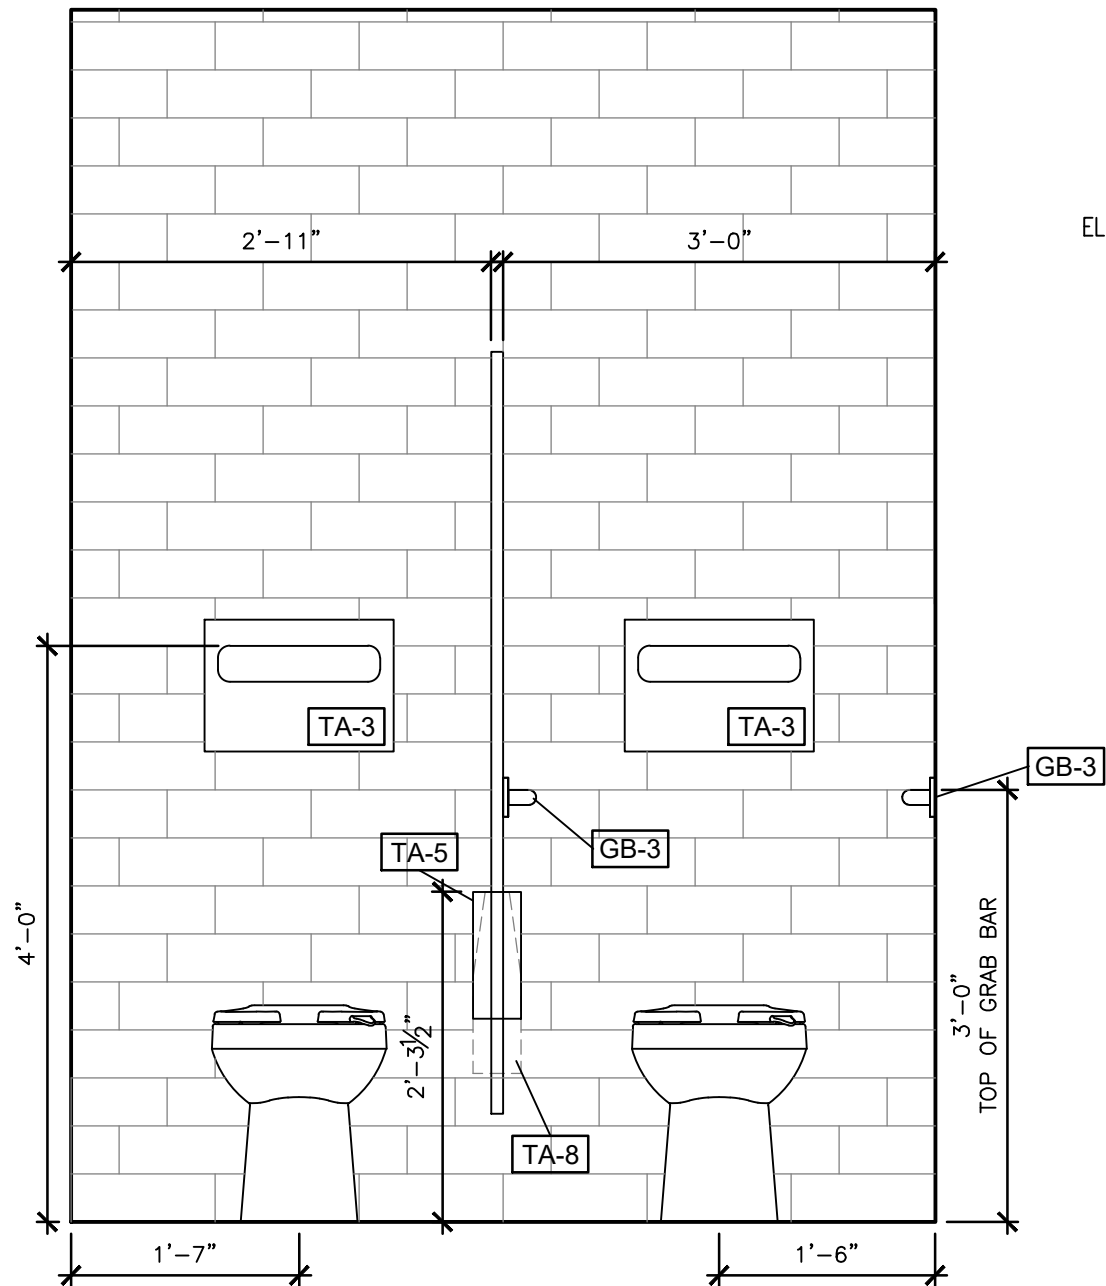


2 ELEVATION — WOMENS RESTROOM 125
SCALE: 3/4" = 1'-0"

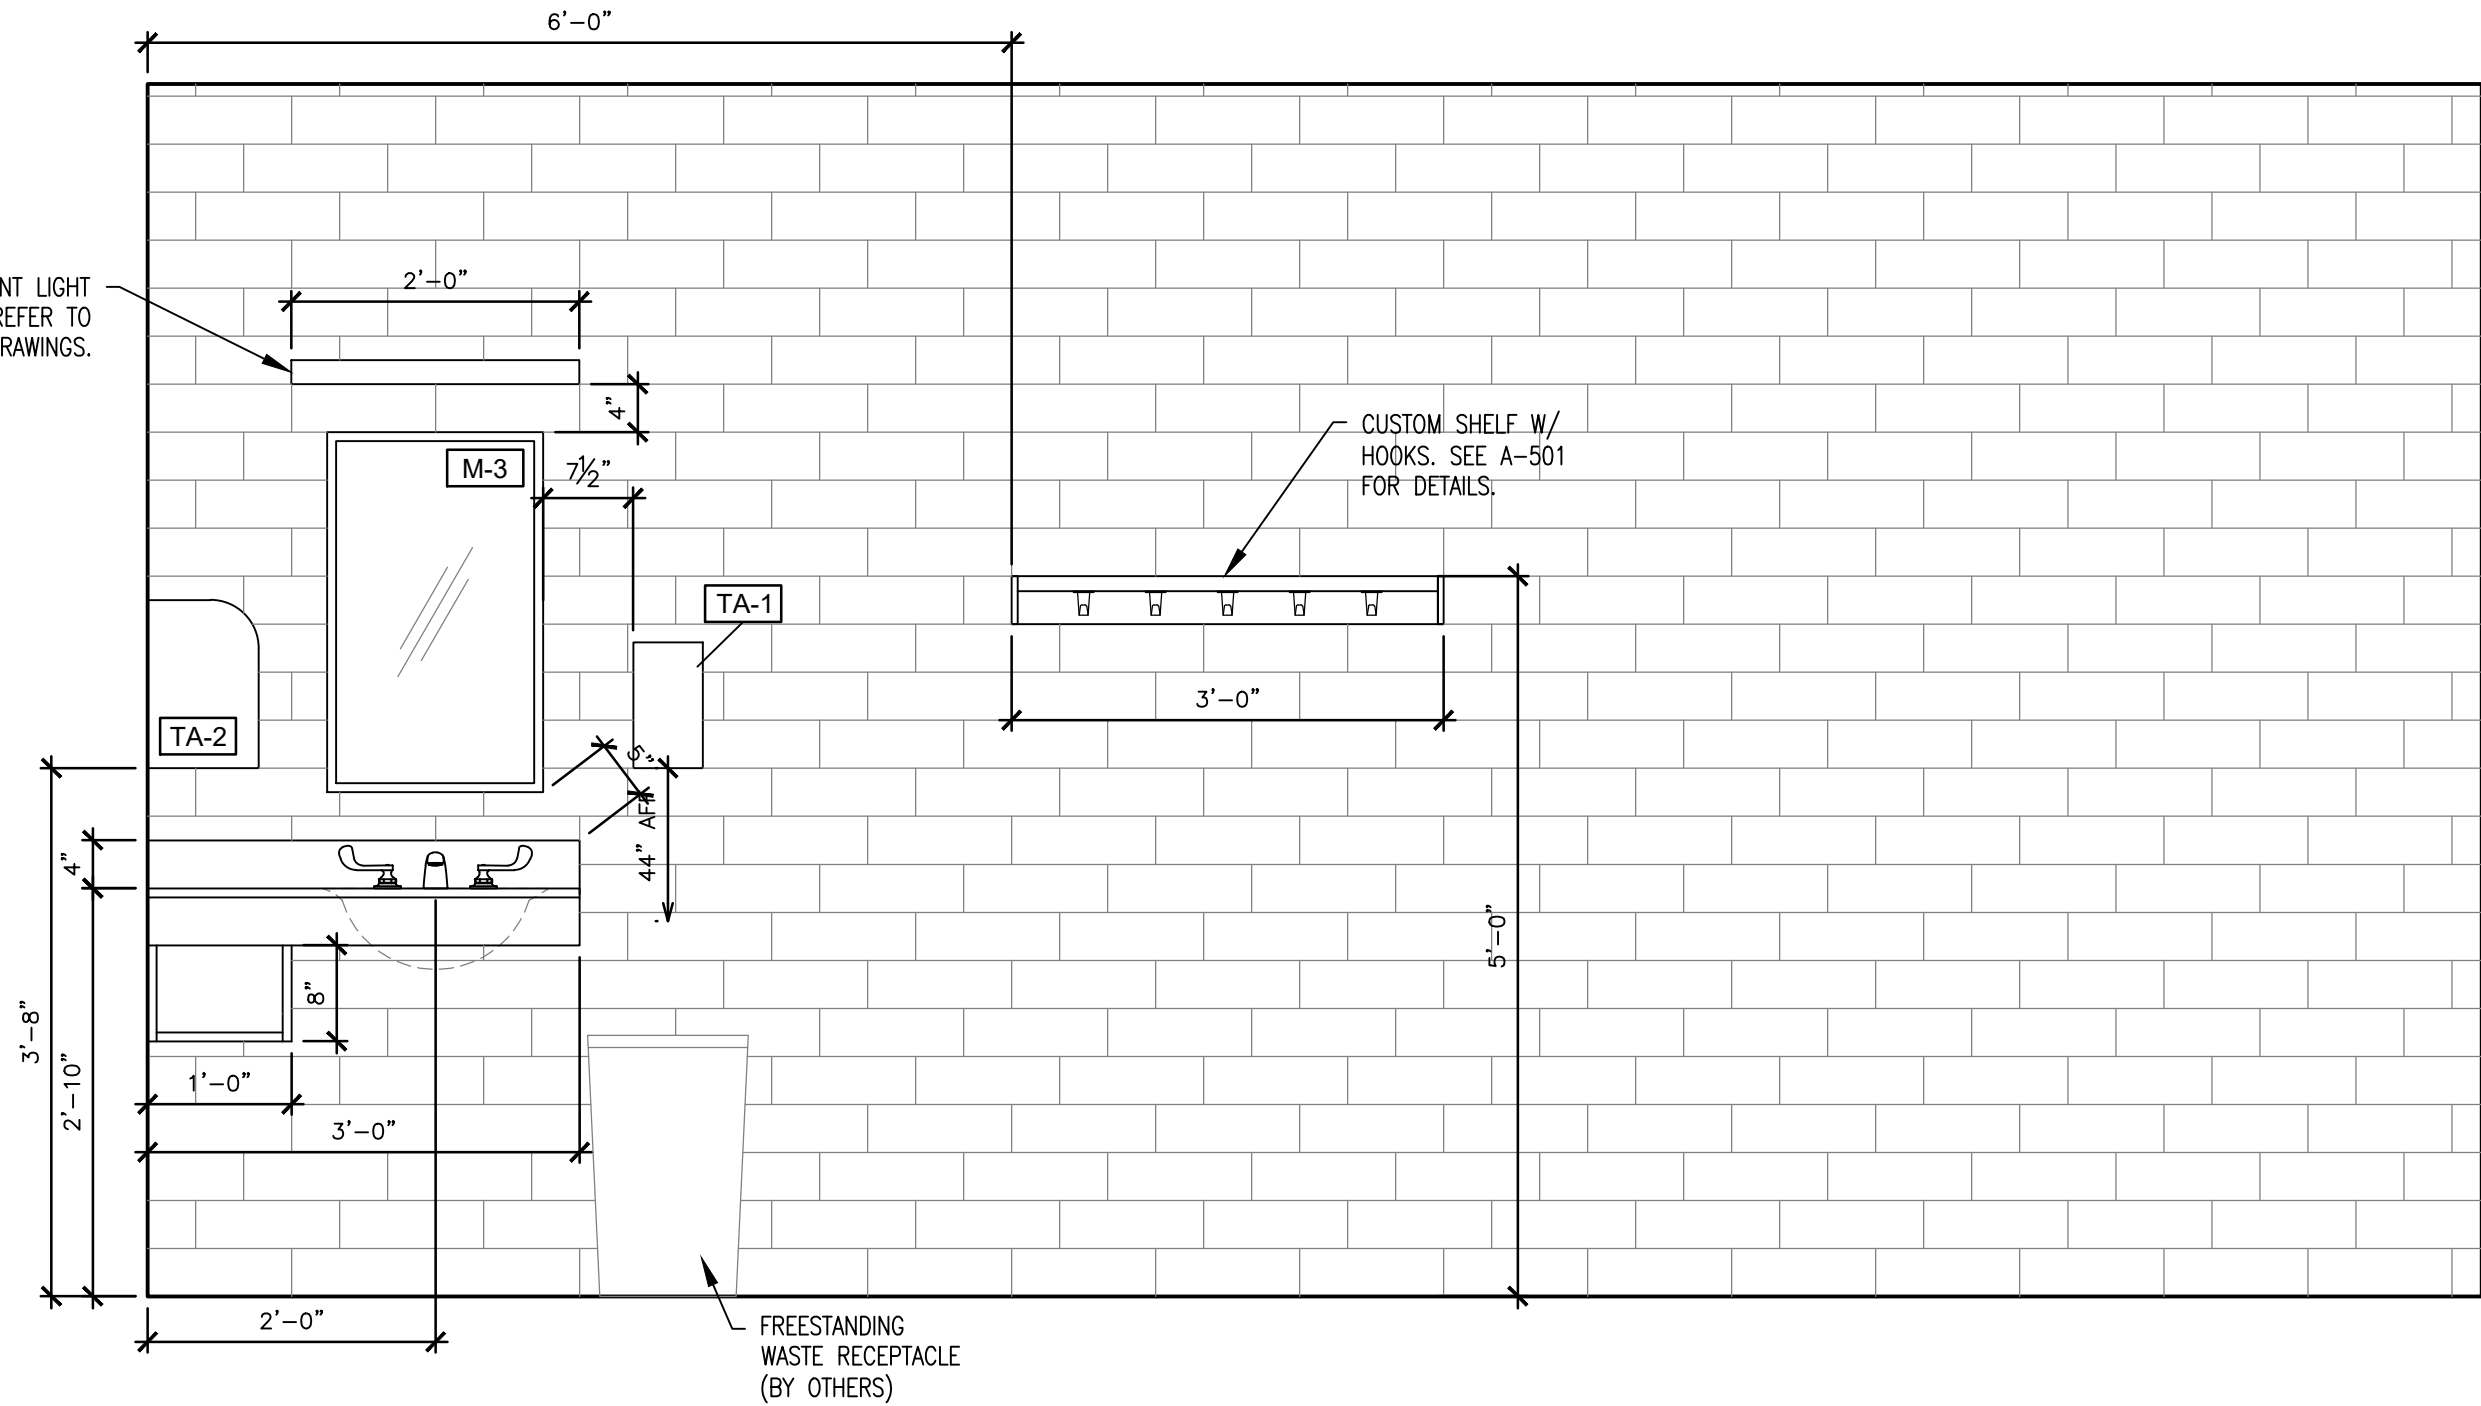


3 ELEVATION — WOMENS RESTROOM 125
SCALE: 3/4" = 1'-0"

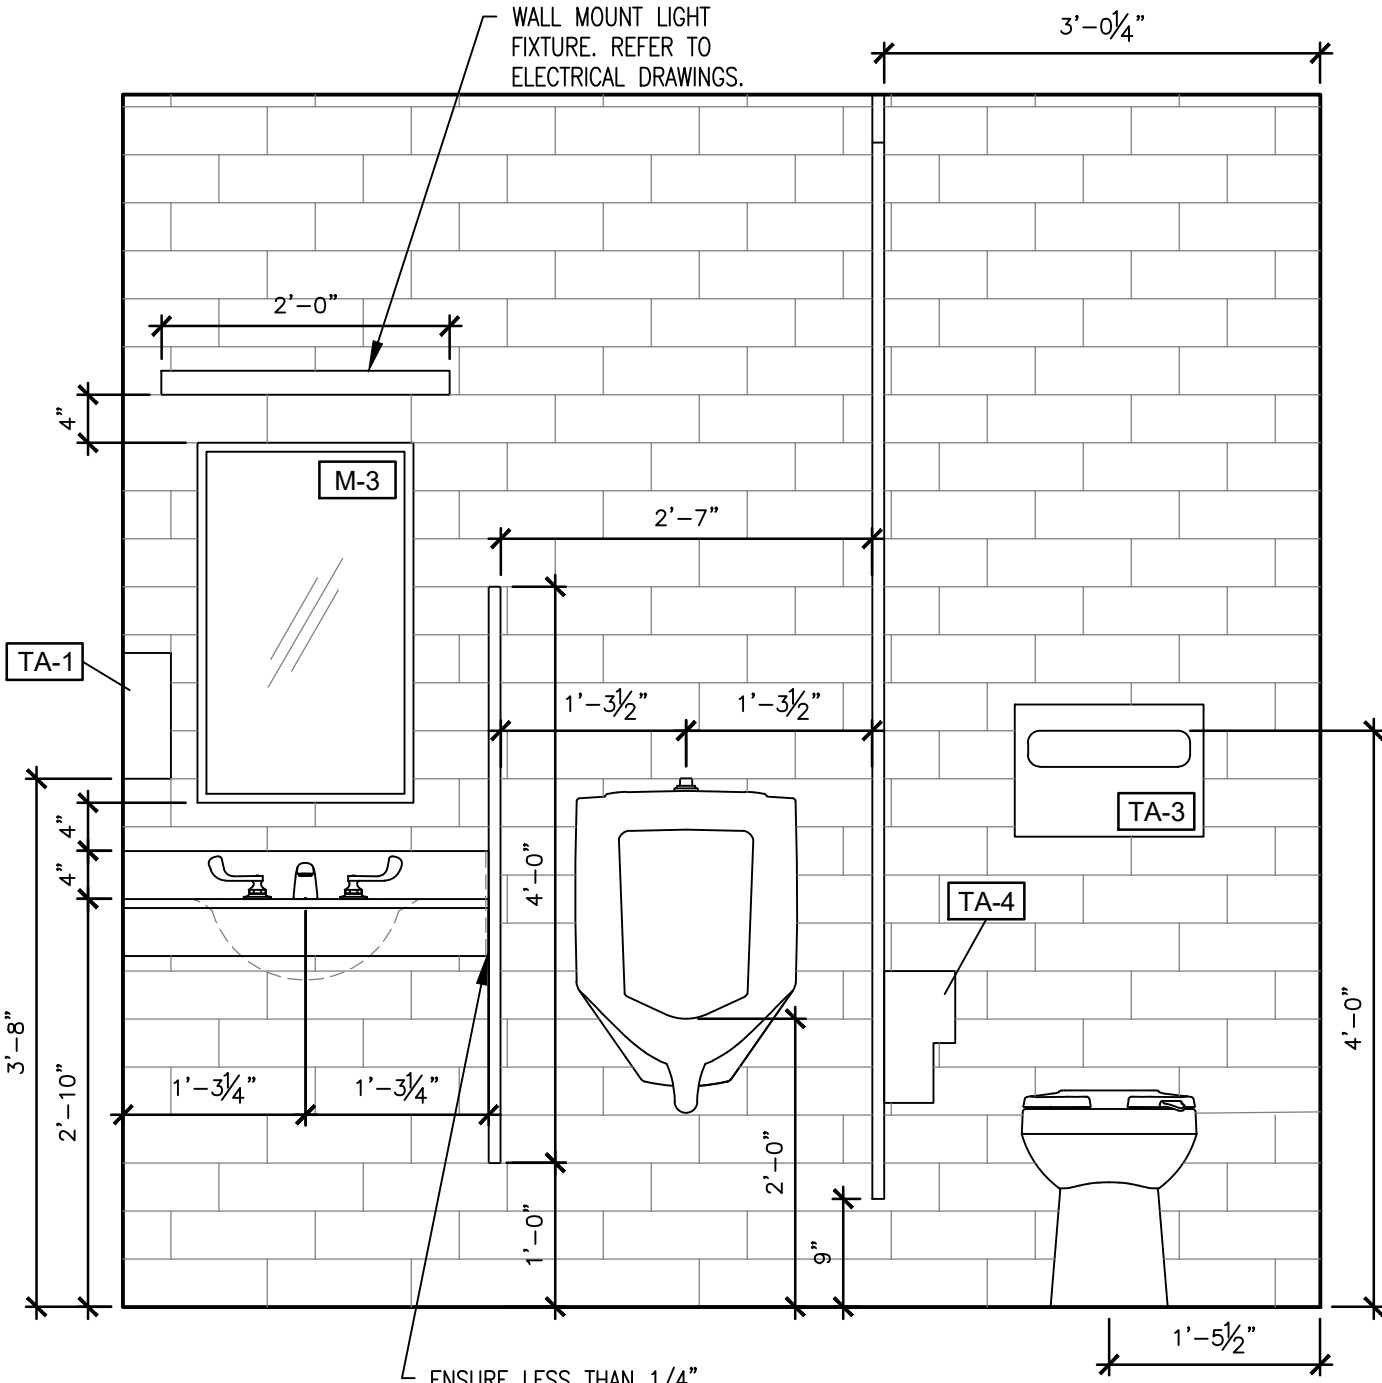


4 ELEVATION — MENS RESTROOM 124
SCALE: 3/4" = 1'-0"

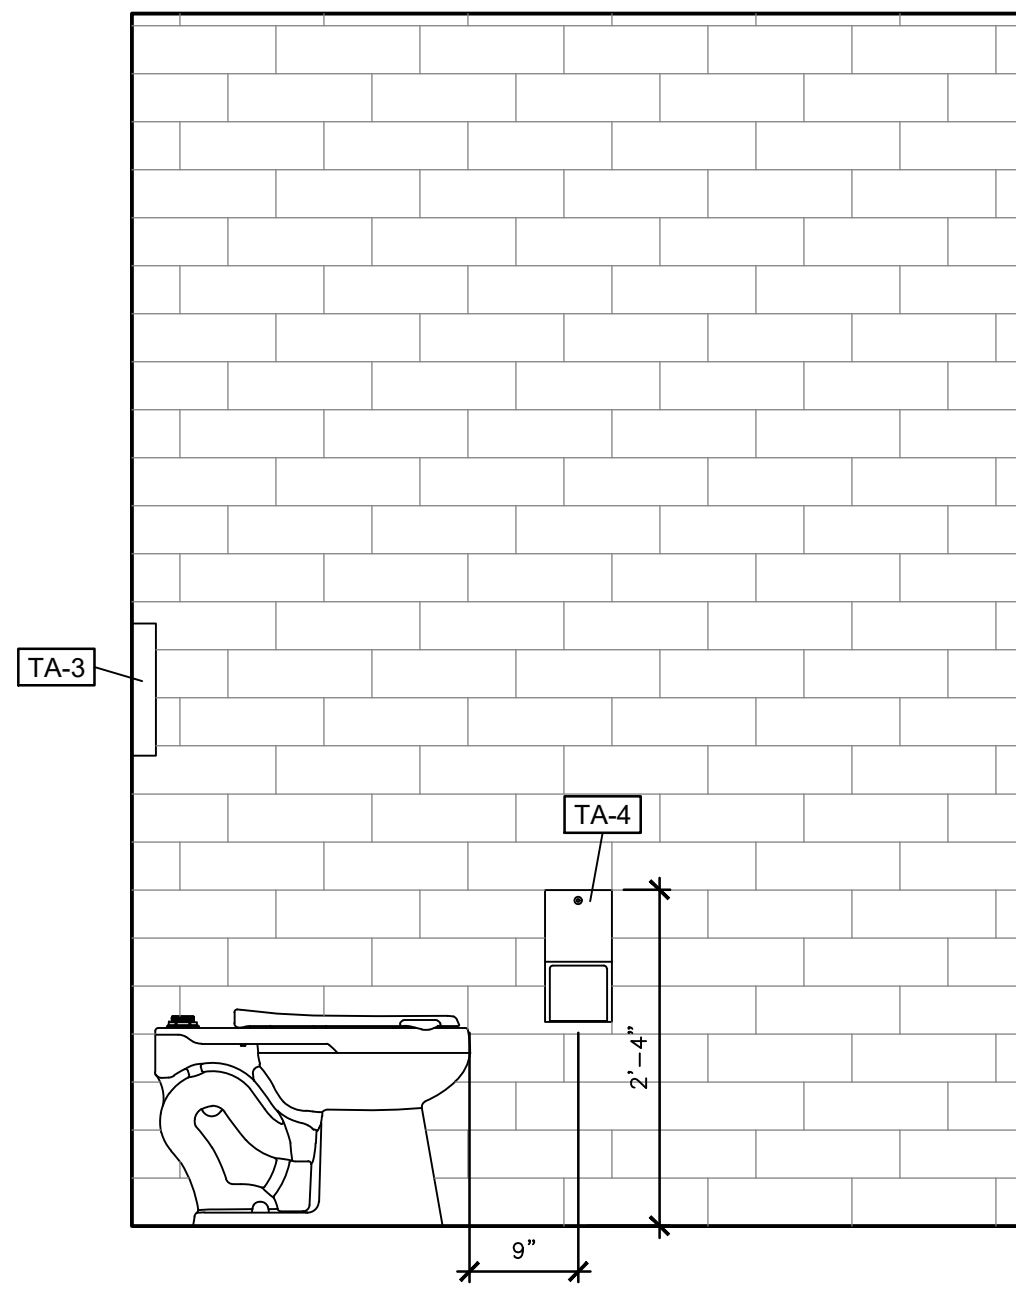

5 ELEVATION — MENS RESTROOM 124
SCALE: 3/4" = 1'-0"

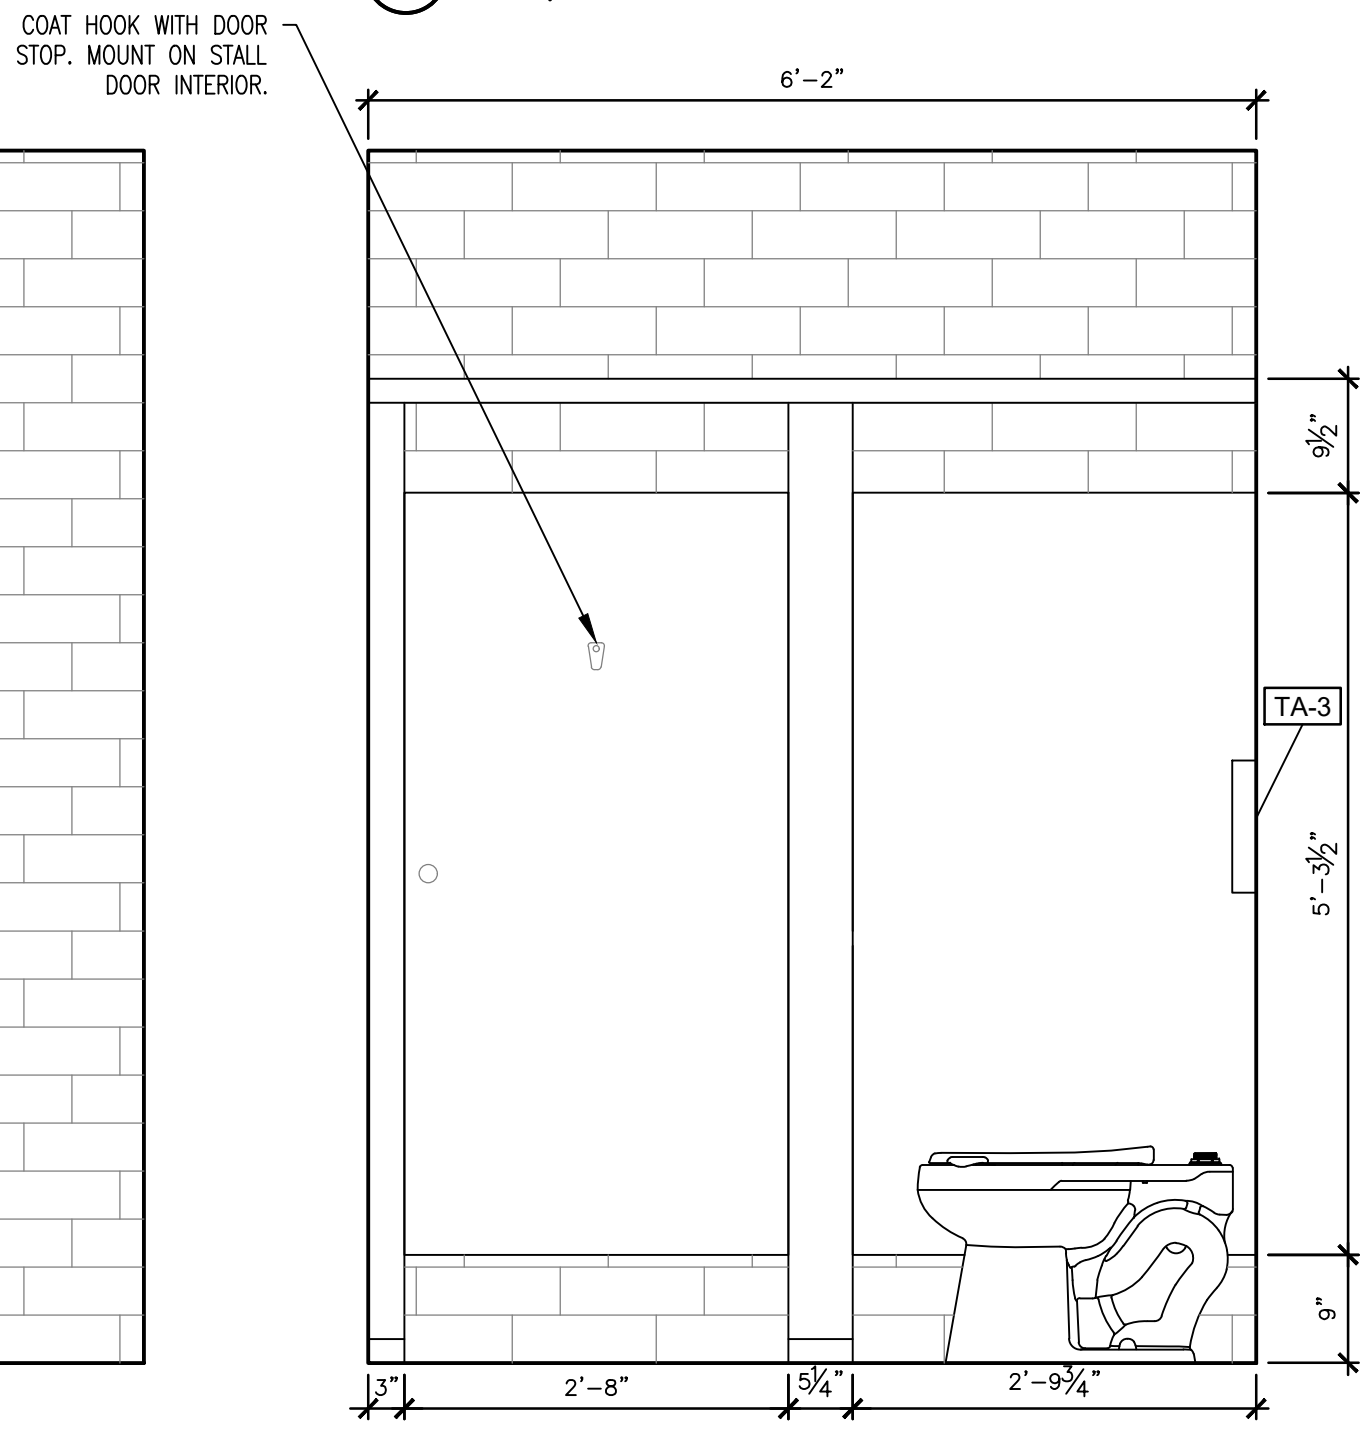

6 ELEVATION — MENS RESTROOM 124
SCALE: 3/4" = 1'-0"

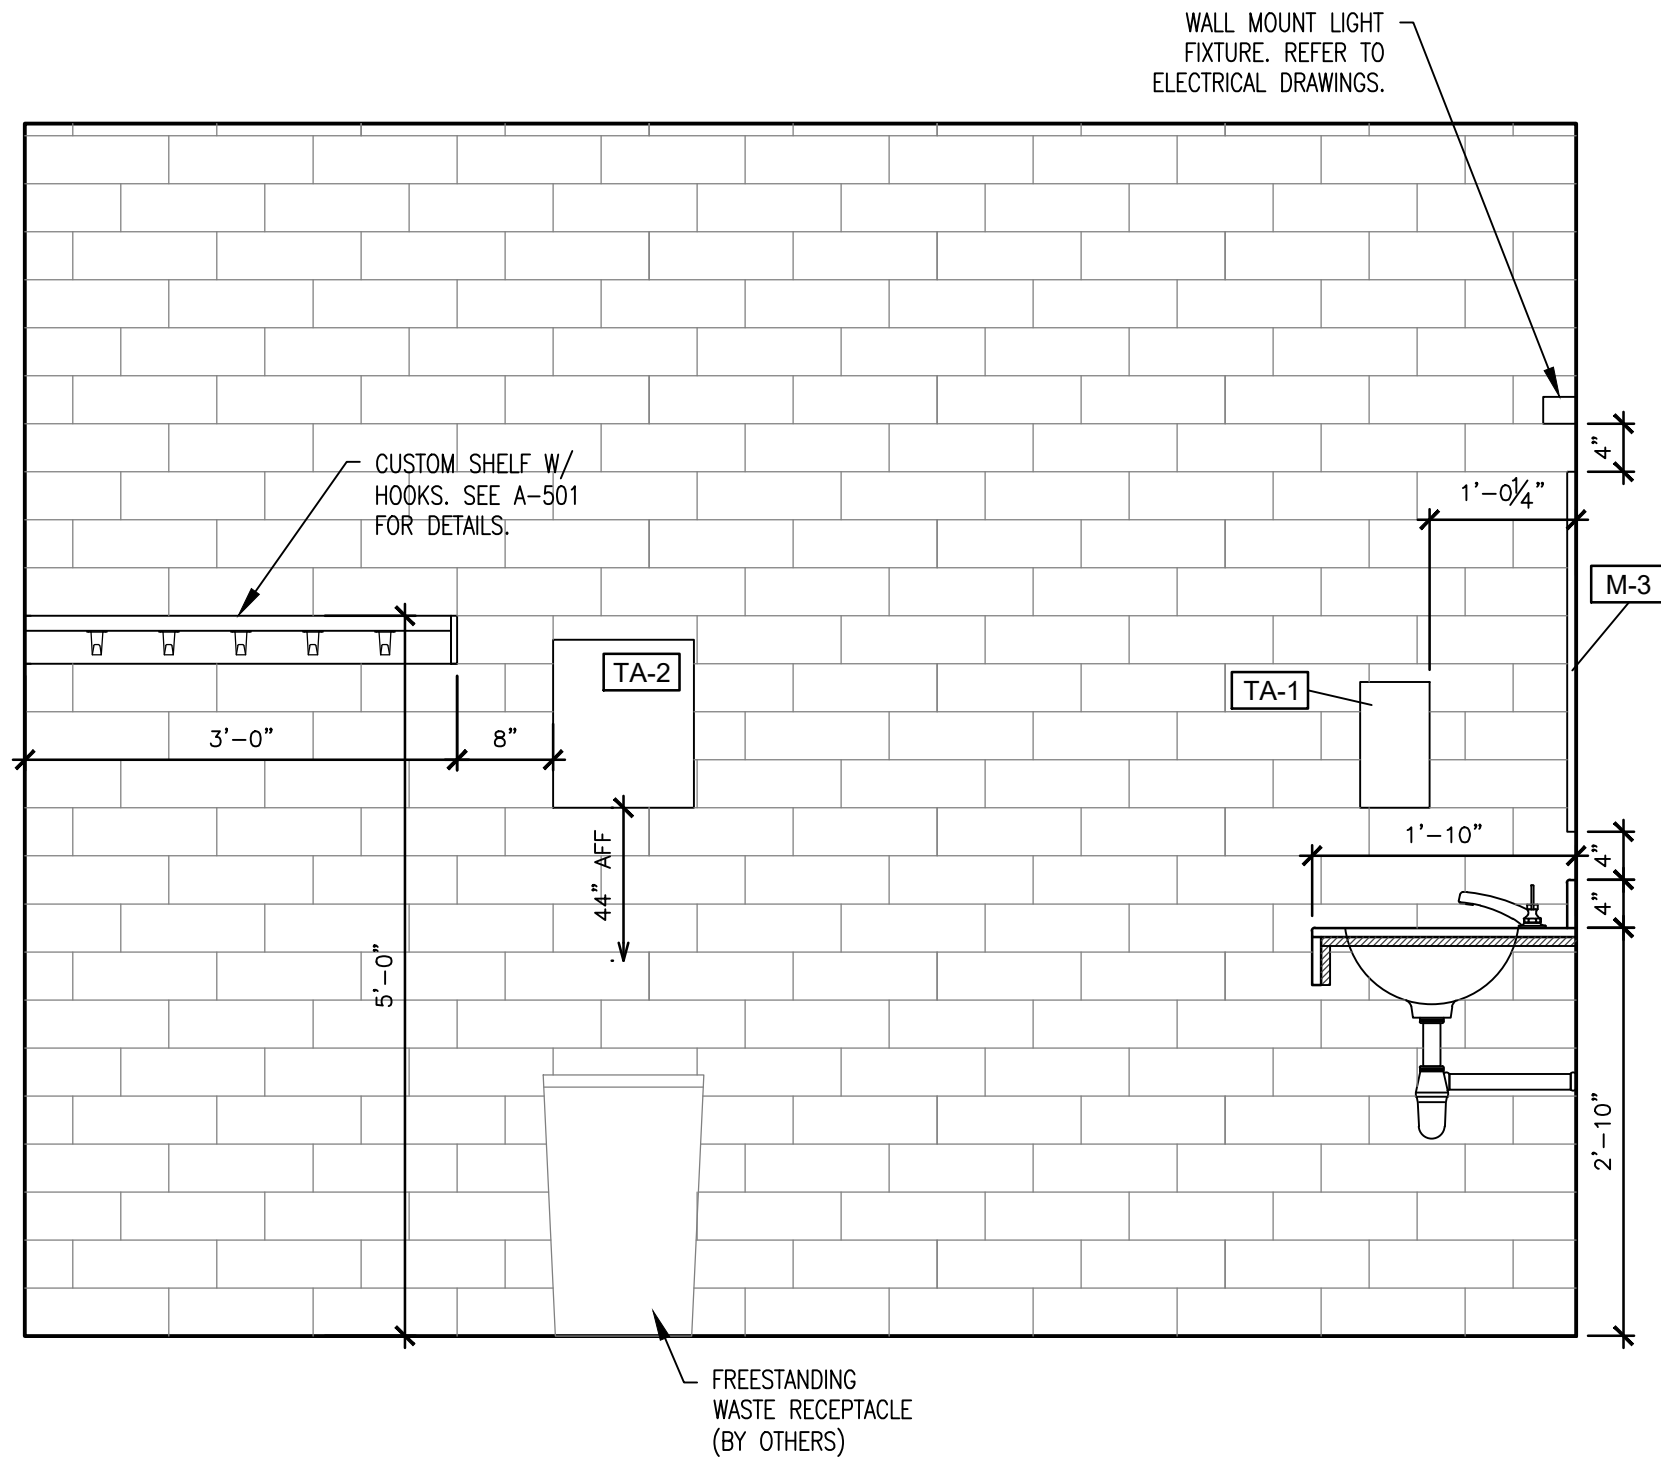


7 ELEVATION — MENS RESTROOM 124
SCALE: 3/4" = 1'-0"






RESTROOM FIXTURE SCHEDULE SHEET REFERENCE

MARK	PRODUCT
GB-3	GRAB BAR
M-1	MIRROR
M-3	MIRROR
TA-1	SOAP DISPENSER
TA-2	PAPER TOWEL DISPENSER
TA-3	TOILET SEAT COVER DISPENSER
TA-4	TOILET PAPER DISPENSER
TA-5	TOILET PAPER DISPENSER
TA-8	SANITARY NAPKIN DISPOSAL


*SEE A-601 FOR FULL RESTROOM FIXTURE SCHEDULE.
*ALL FIXTURES TO BE LOCATED AT ADA STANDARD HEIGHTS &
SETBACKS UNLESS NOTED OTHERWISE.

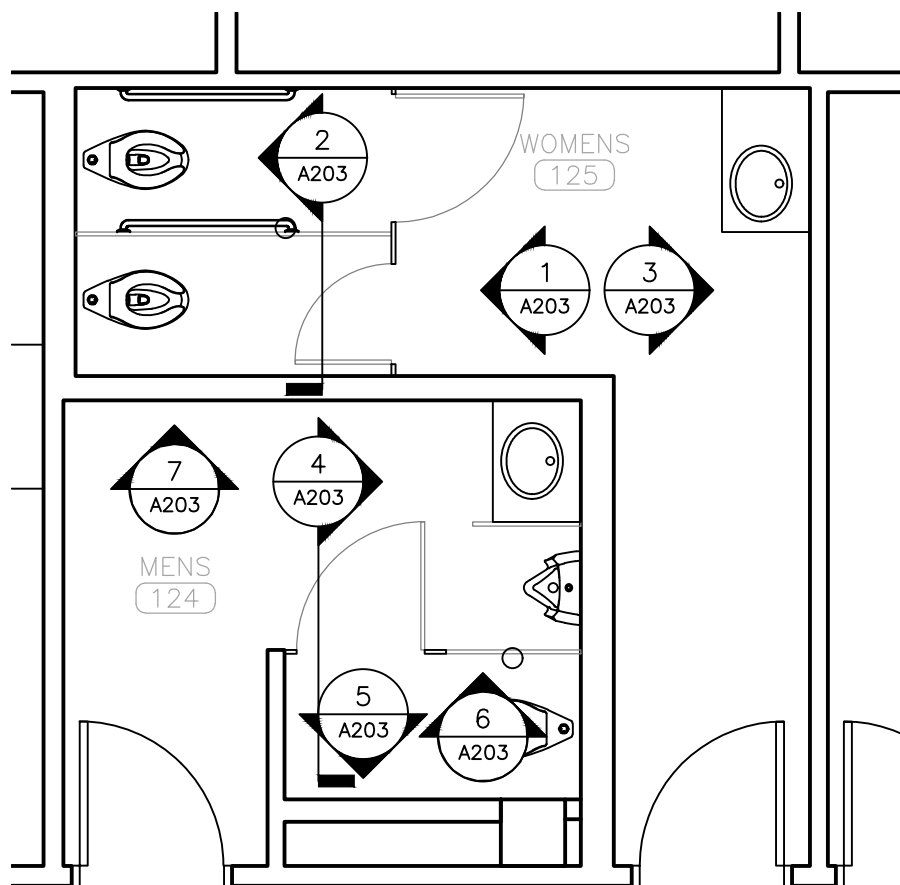

8 KEYPLAN — RESTROOMS 124 & 125
SCALE: 1/4" = 1'-0"

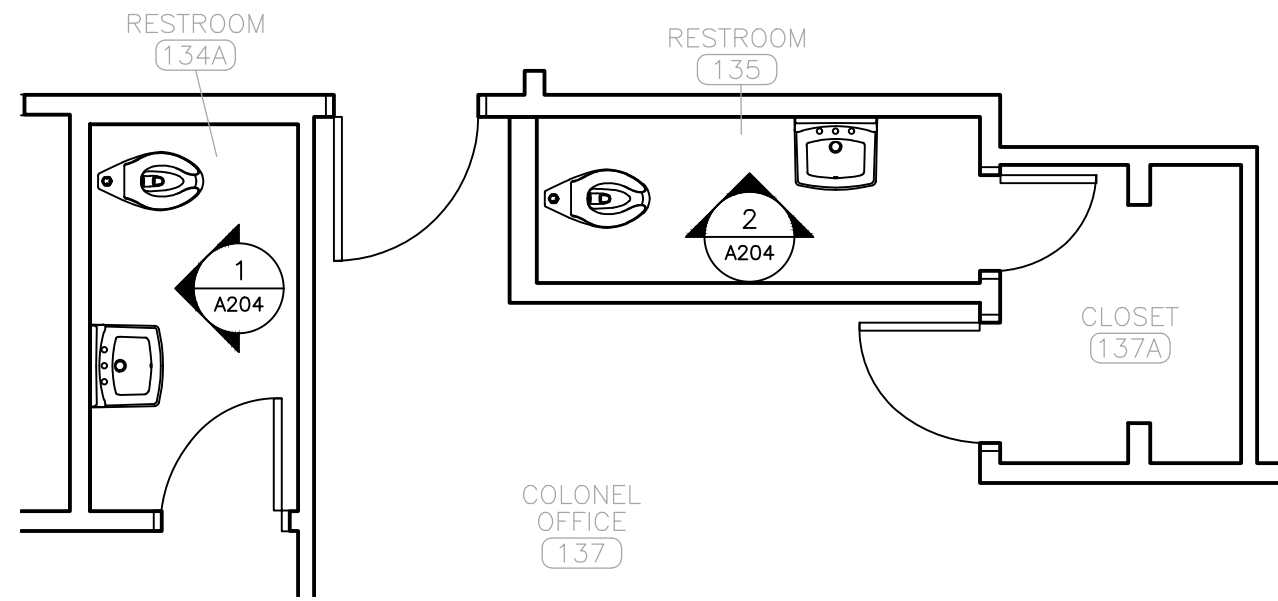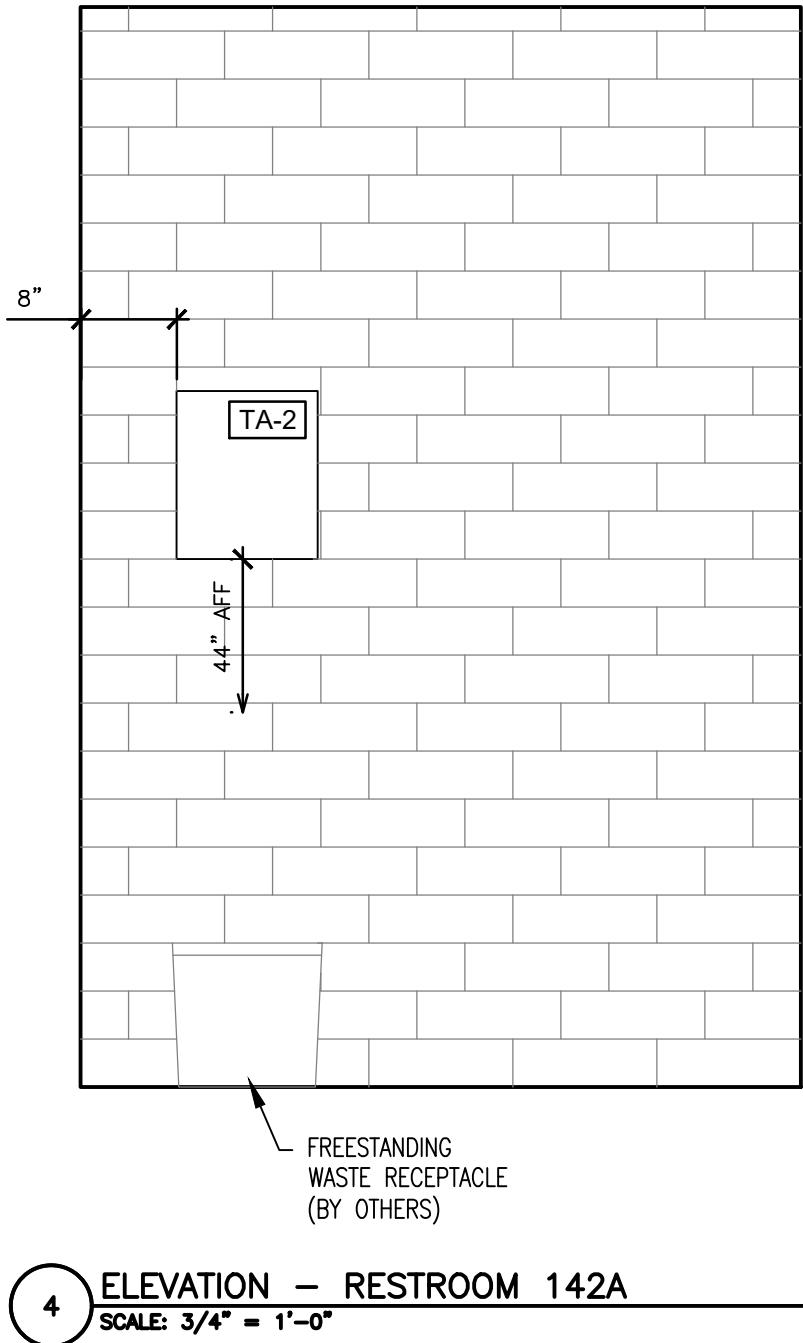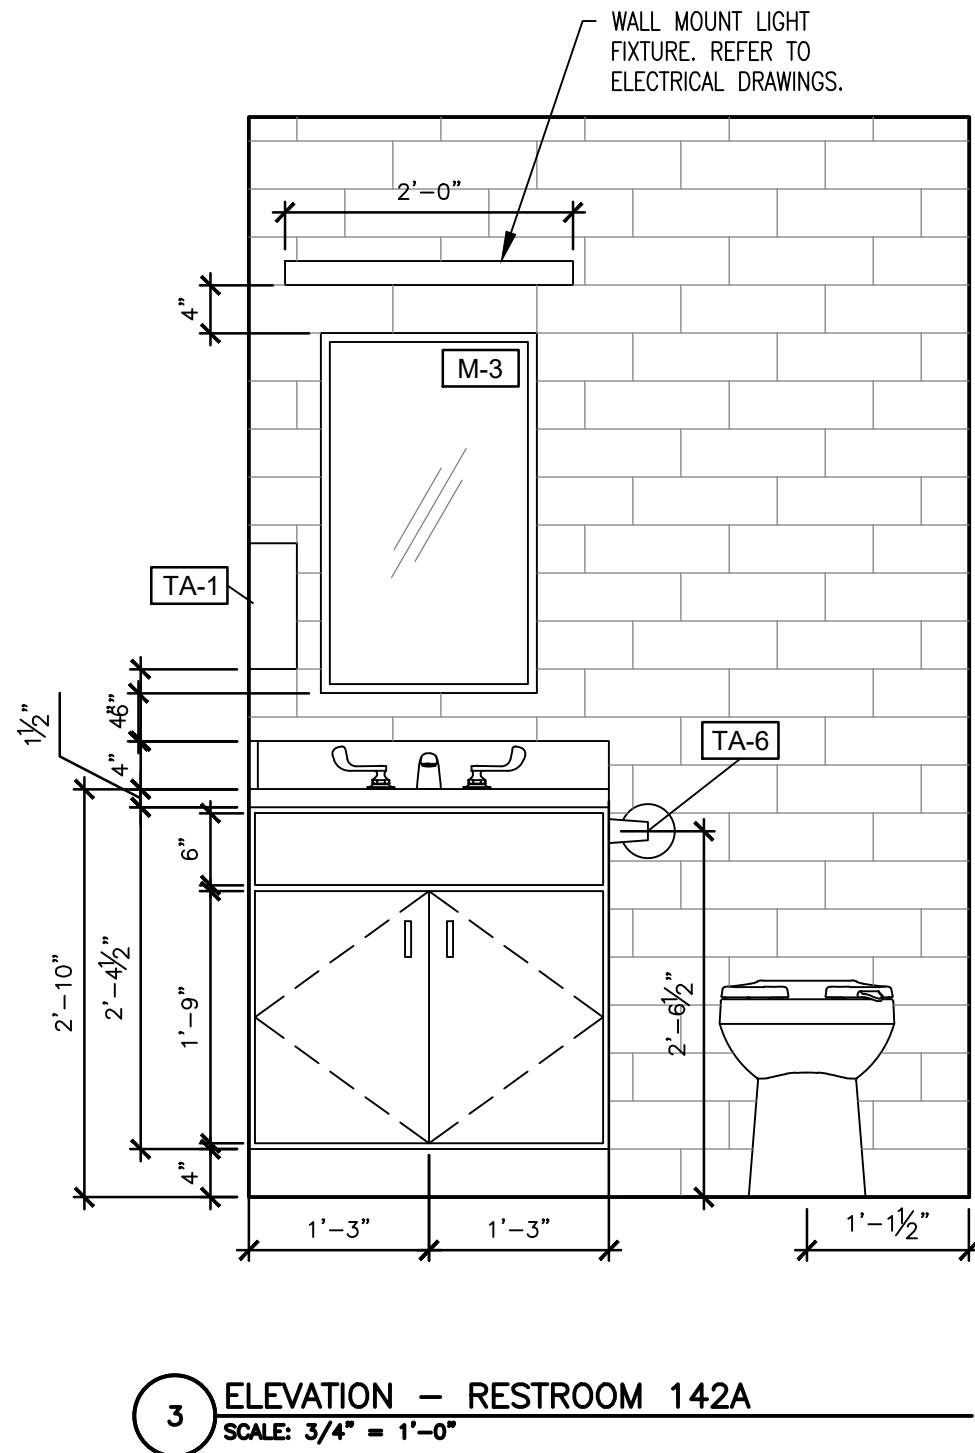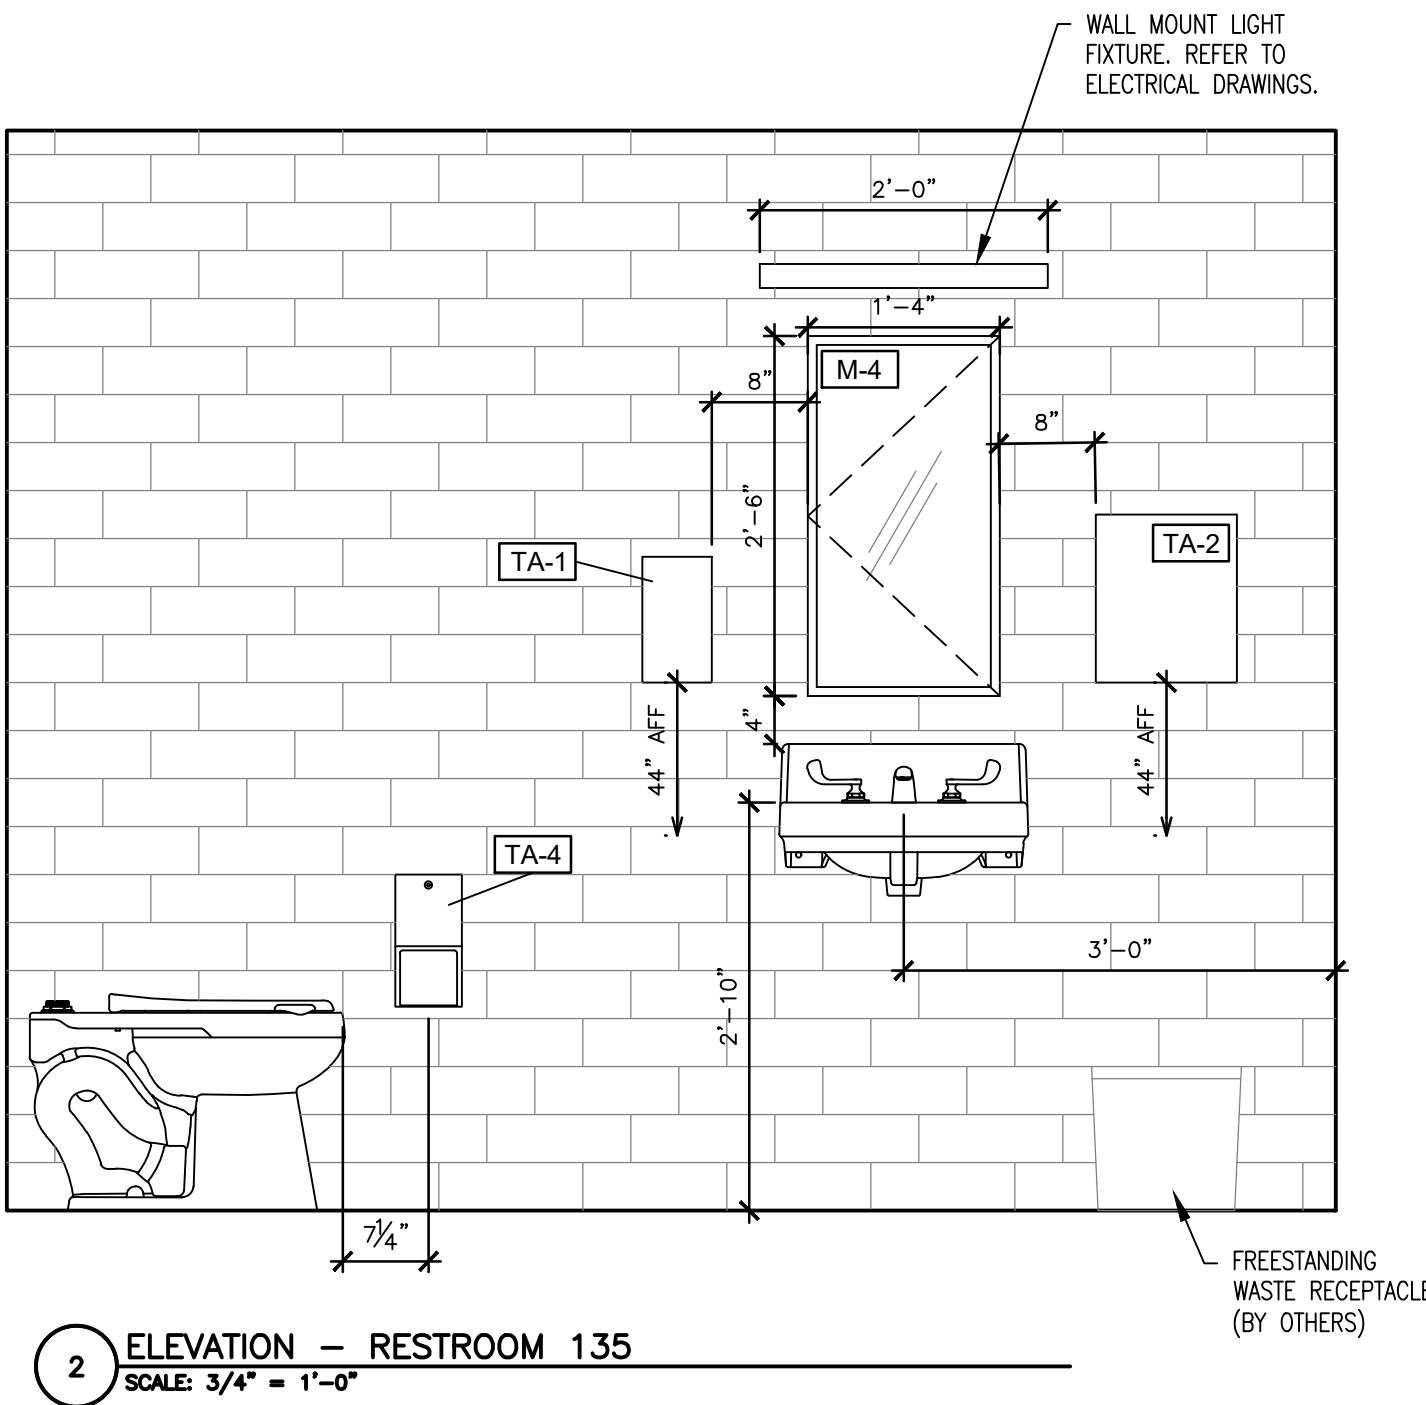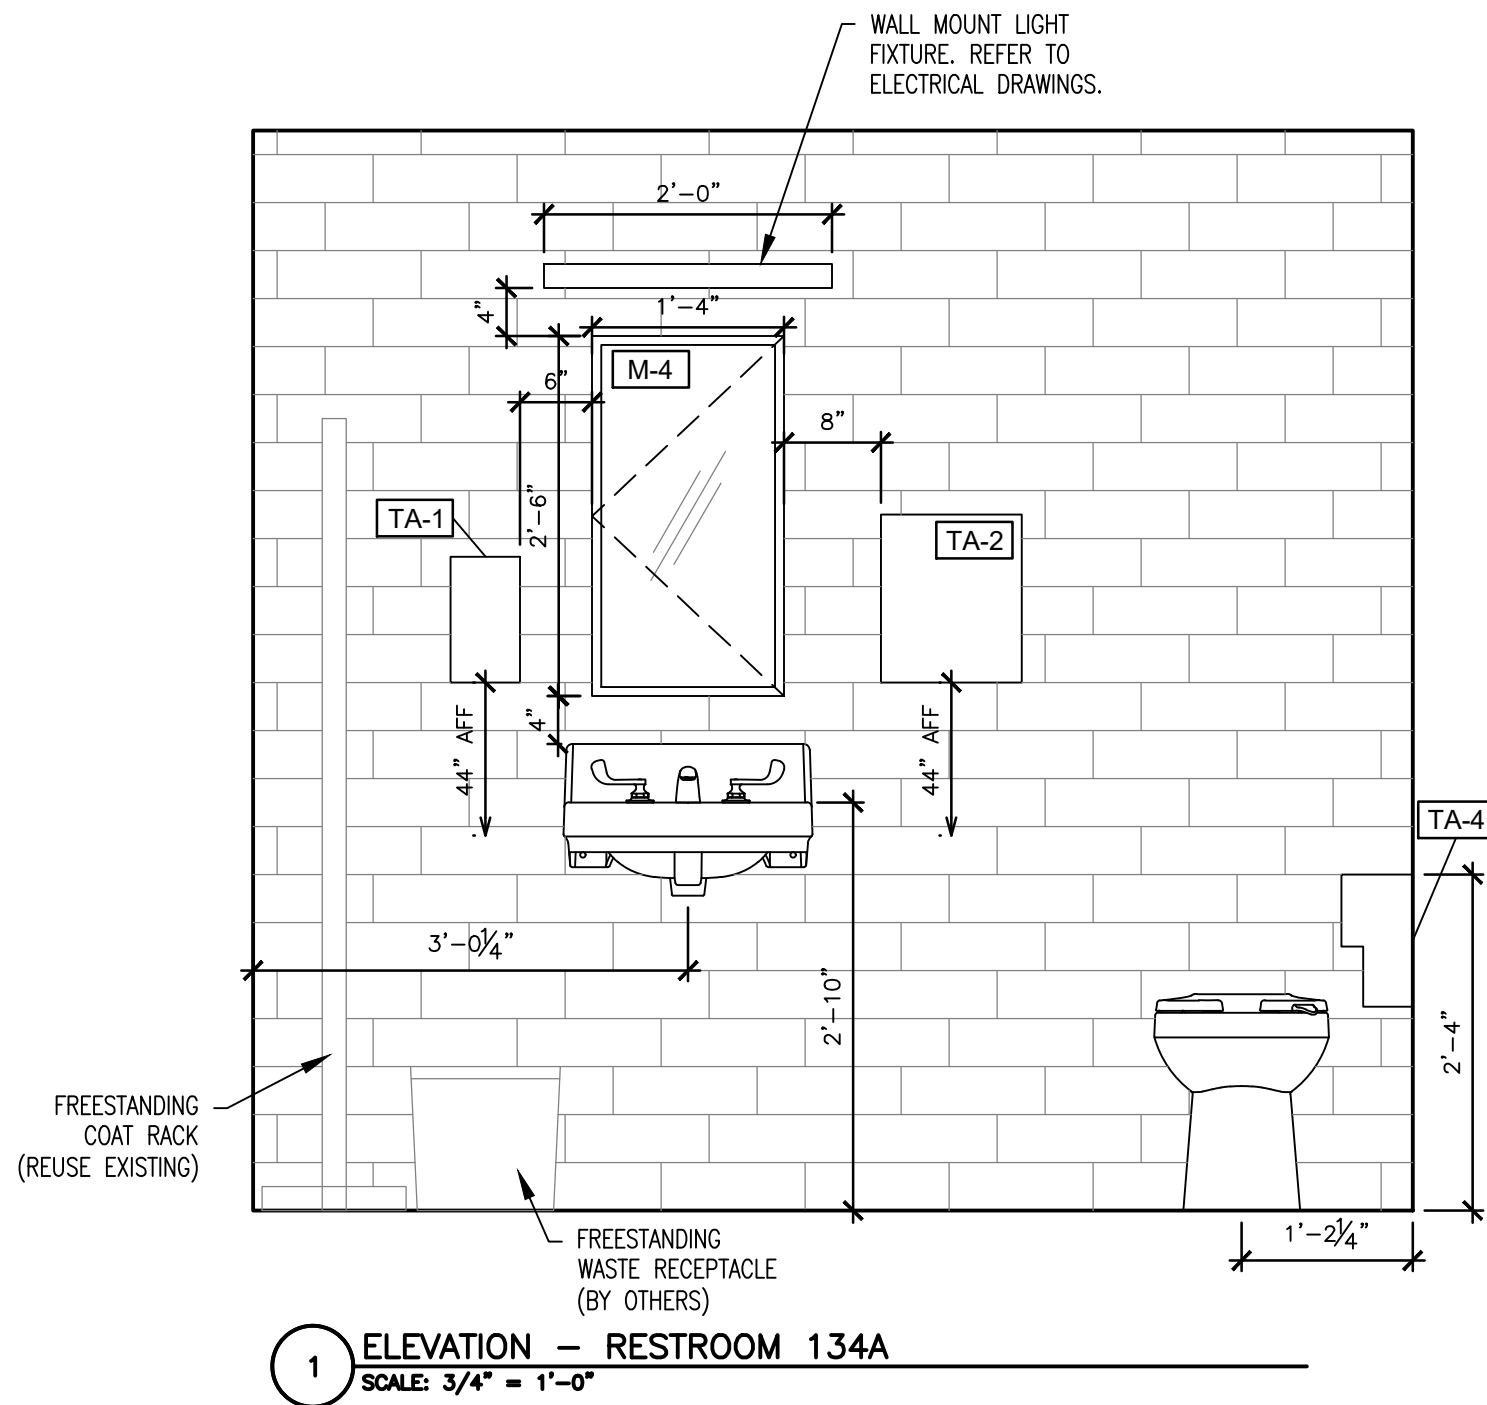

5 KEYPLAN — RESTROOMS 134A & 135
SCALE: 1/4" = 1'-0"

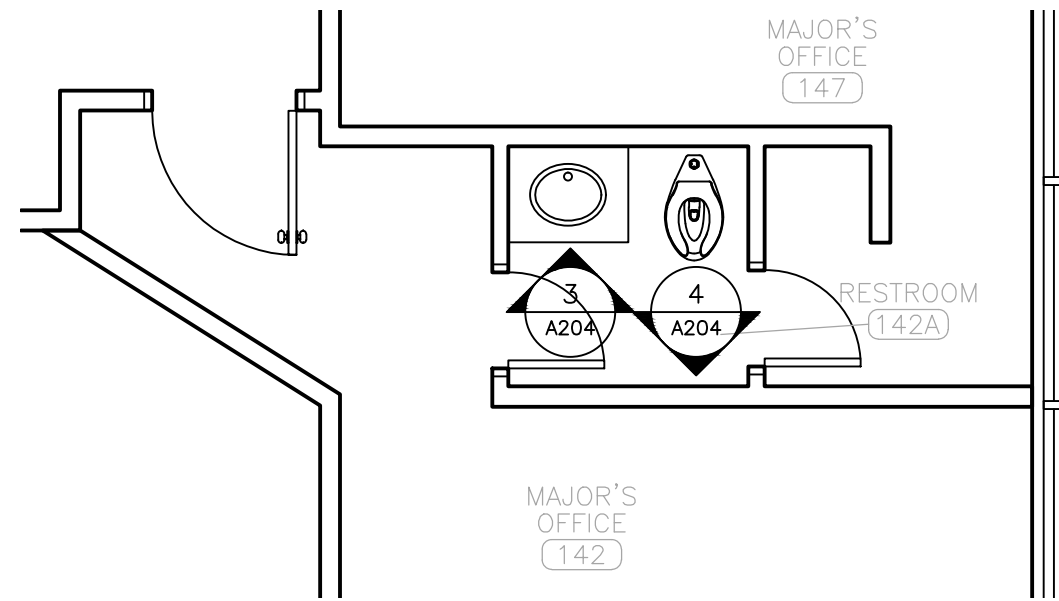

6 KEYPLAN — RESTROOM 142A
SCALE: 1/4" = 1'-0"

RESTROOM FIXTURE SCHEDULE SHEET REFERENCE	
MARK	PRODUCT
M-3	MIRROR
M-4	MIRROR CABINET
TA-1	SOAP DISPENSER
TA-2	PAPER TOWEL DISPENSER
TA-4	TOILET PAPER DISPENSER
TA-6	TOILET PAPER HOLDER

*SEE A-601 FOR FULL RESTROOM FIXTURE SCHEDULE.
*ALL FIXTURES TO BE LOCATED AT ADA STANDARD HEIGHTS &
SETBACKS UNLESS NOTED OTHERWISE.

STATE OF MISSOURI
MIKE KEHOE,
GOVERNOR



Brad M. Schaefer - Architect
MO# A-2009027294

BID DOCUMENTS

OFFICE OF ADMINISTRATION
DIVISION OF FACILITIES
MANAGEMENT,
DESIGN AND CONSTRUCTION

DEPARTMENT OF
PUBLIC SAFETY
STATE HIGHWAY PATROL

RENOVATE INTERIOR

GENERAL HEADQUARTERS
1510 EAST ELM STREET
JEFFERSON CITY, MO 65101

PROJECT # R2410-01
SITE # 6001
ASSET # 8136001001

REVISION: _____
DATE: _____
REVISION: _____
DATE: _____
REVISION: _____
DATE: _____
ISSUE DATE: 06/18/2026

CAD DWG FILE: _____
DRAWN BY: RG/CL
CHECKED BY: BMS
DESIGNED BY: CL

SHEET TITLE:
FIRST FLOOR
RESTROOM
ELEVATIONS

SHEET NUMBER:

A-204

9 OF 39 SHEETS
06/18/2026



Brad M. Schaefer - Architect
MO# A-2009027294

BID DOCUMENTS

OFFICE OF ADMINISTRATION
DIVISION OF FACILITIES
MANAGEMENT,
DESIGN AND CONSTRUCTION

DEPARTMENT OF
PUBLIC SAFETY
STATE HIGHWAY PATROL

RENOVATE INTERIOR

GENERAL HEADQUARTERS
1510 EAST ELM STREET
JEFFERSON CITY, MO 65101

PROJECT # R2410-01
SITE # 6001
ASSET # 8136001001

REVISION: _____
DATE: _____
REVISION: _____
DATE: _____
REVISION: _____
DATE: _____
ISSUE DATE: 06/18/2026


CAD DWG FILE: _____
DRAWN BY: RG/CL
CHECKED BY: BMS
DESIGNED BY: CL

SHEET TITLE:
**SECOND FLOOR
RESTROOM
ELEVATIONS**


SHEET NUMBER:

A-205


10 OF 39 SHEETS
06/18/2026

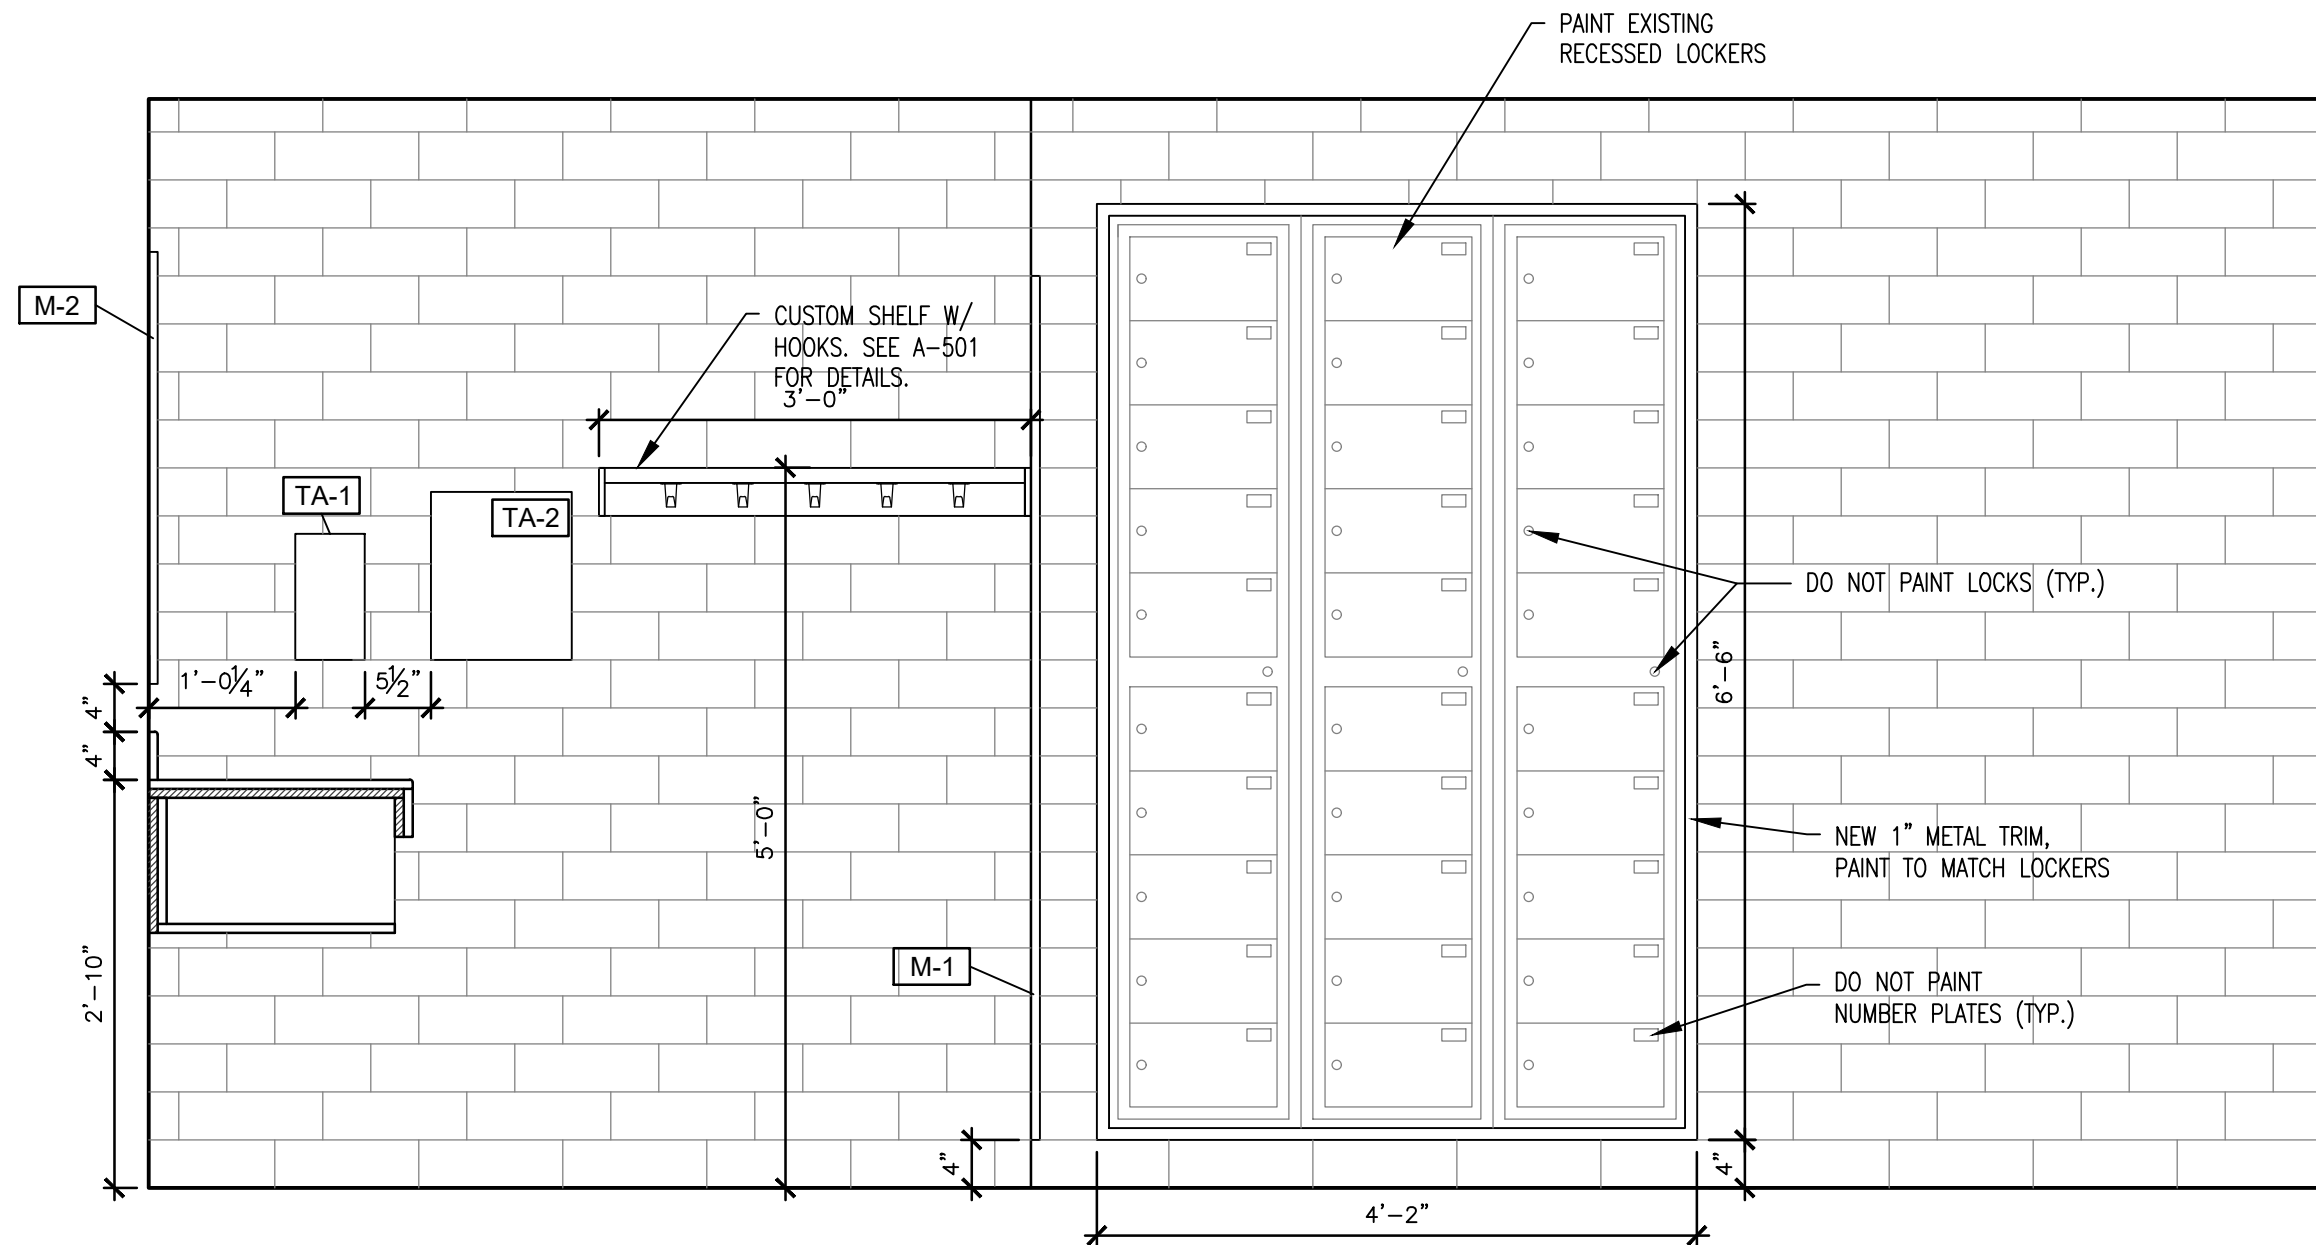


1 ELEVATION — WOMENS RESTROOM 4
SCALE: 3/4" = 1'-0"

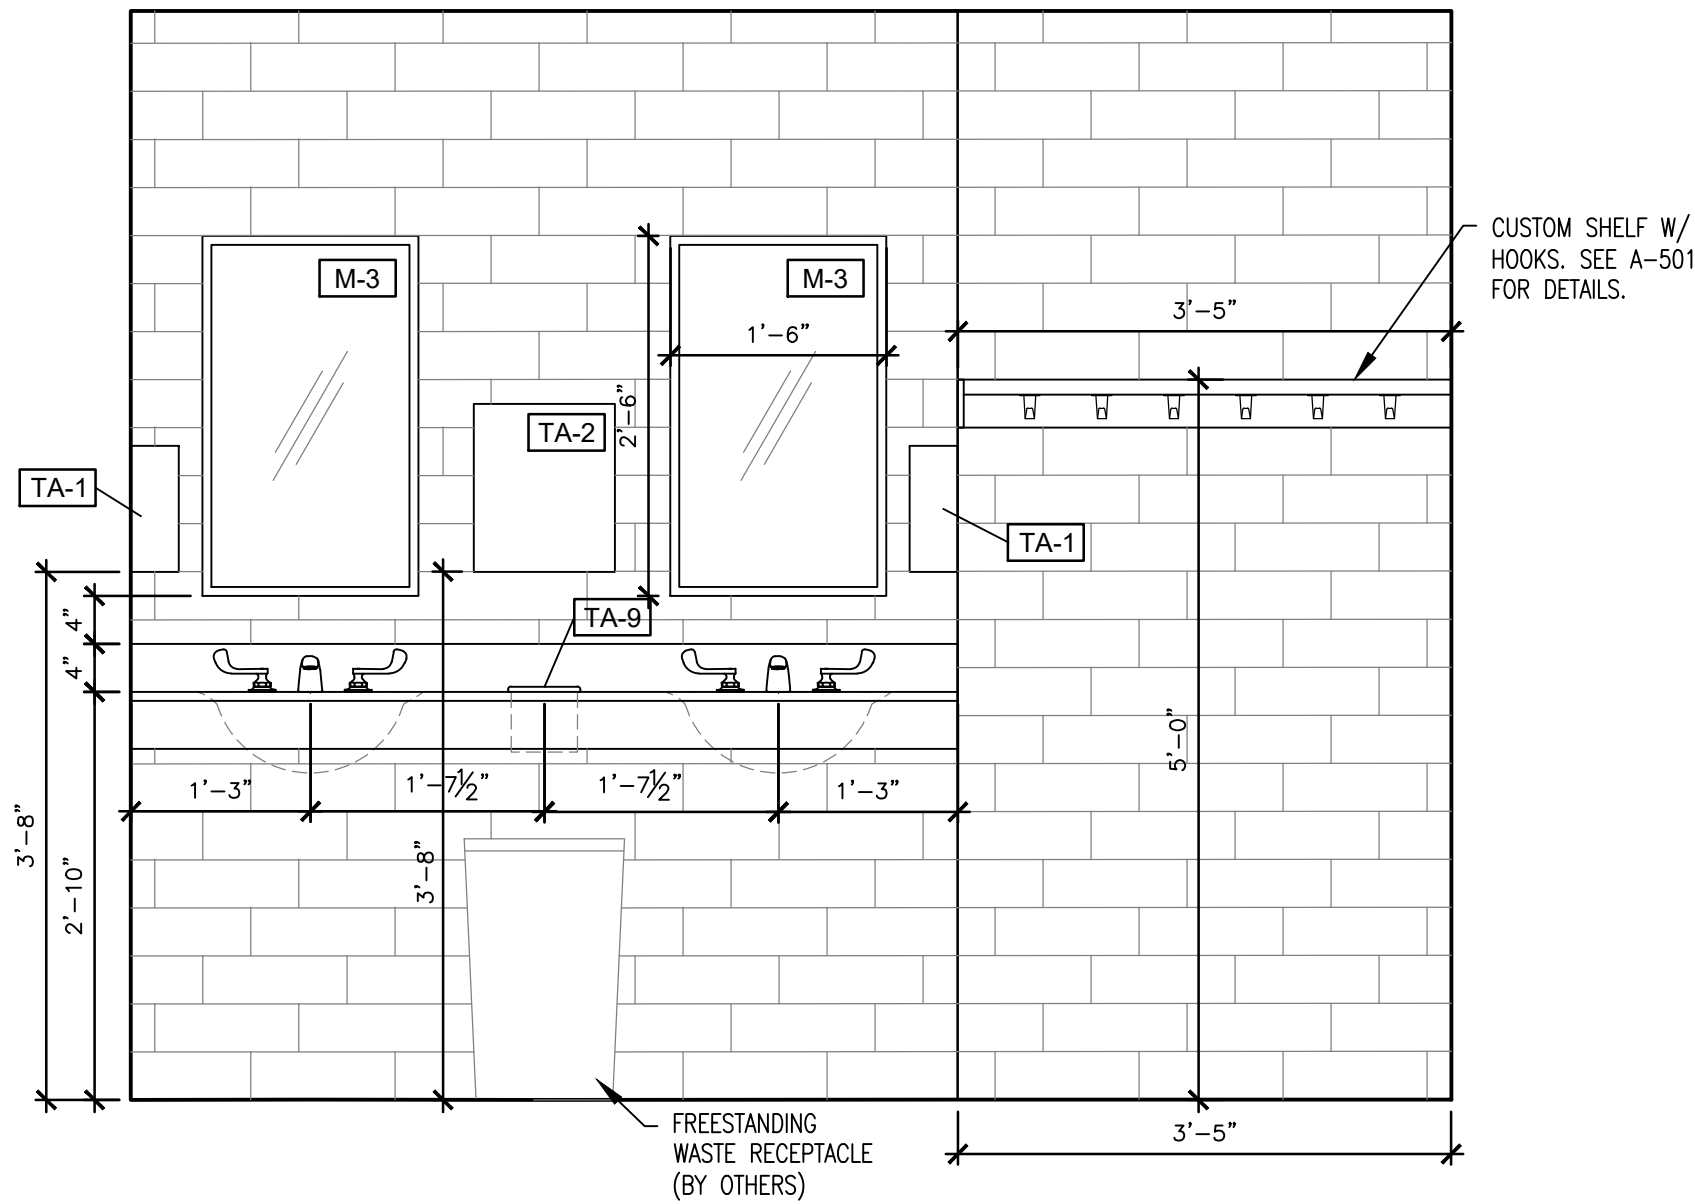


2 ELEVATION — MENS RESTROOM 2
SCALE: 3/4" = 1'-0"

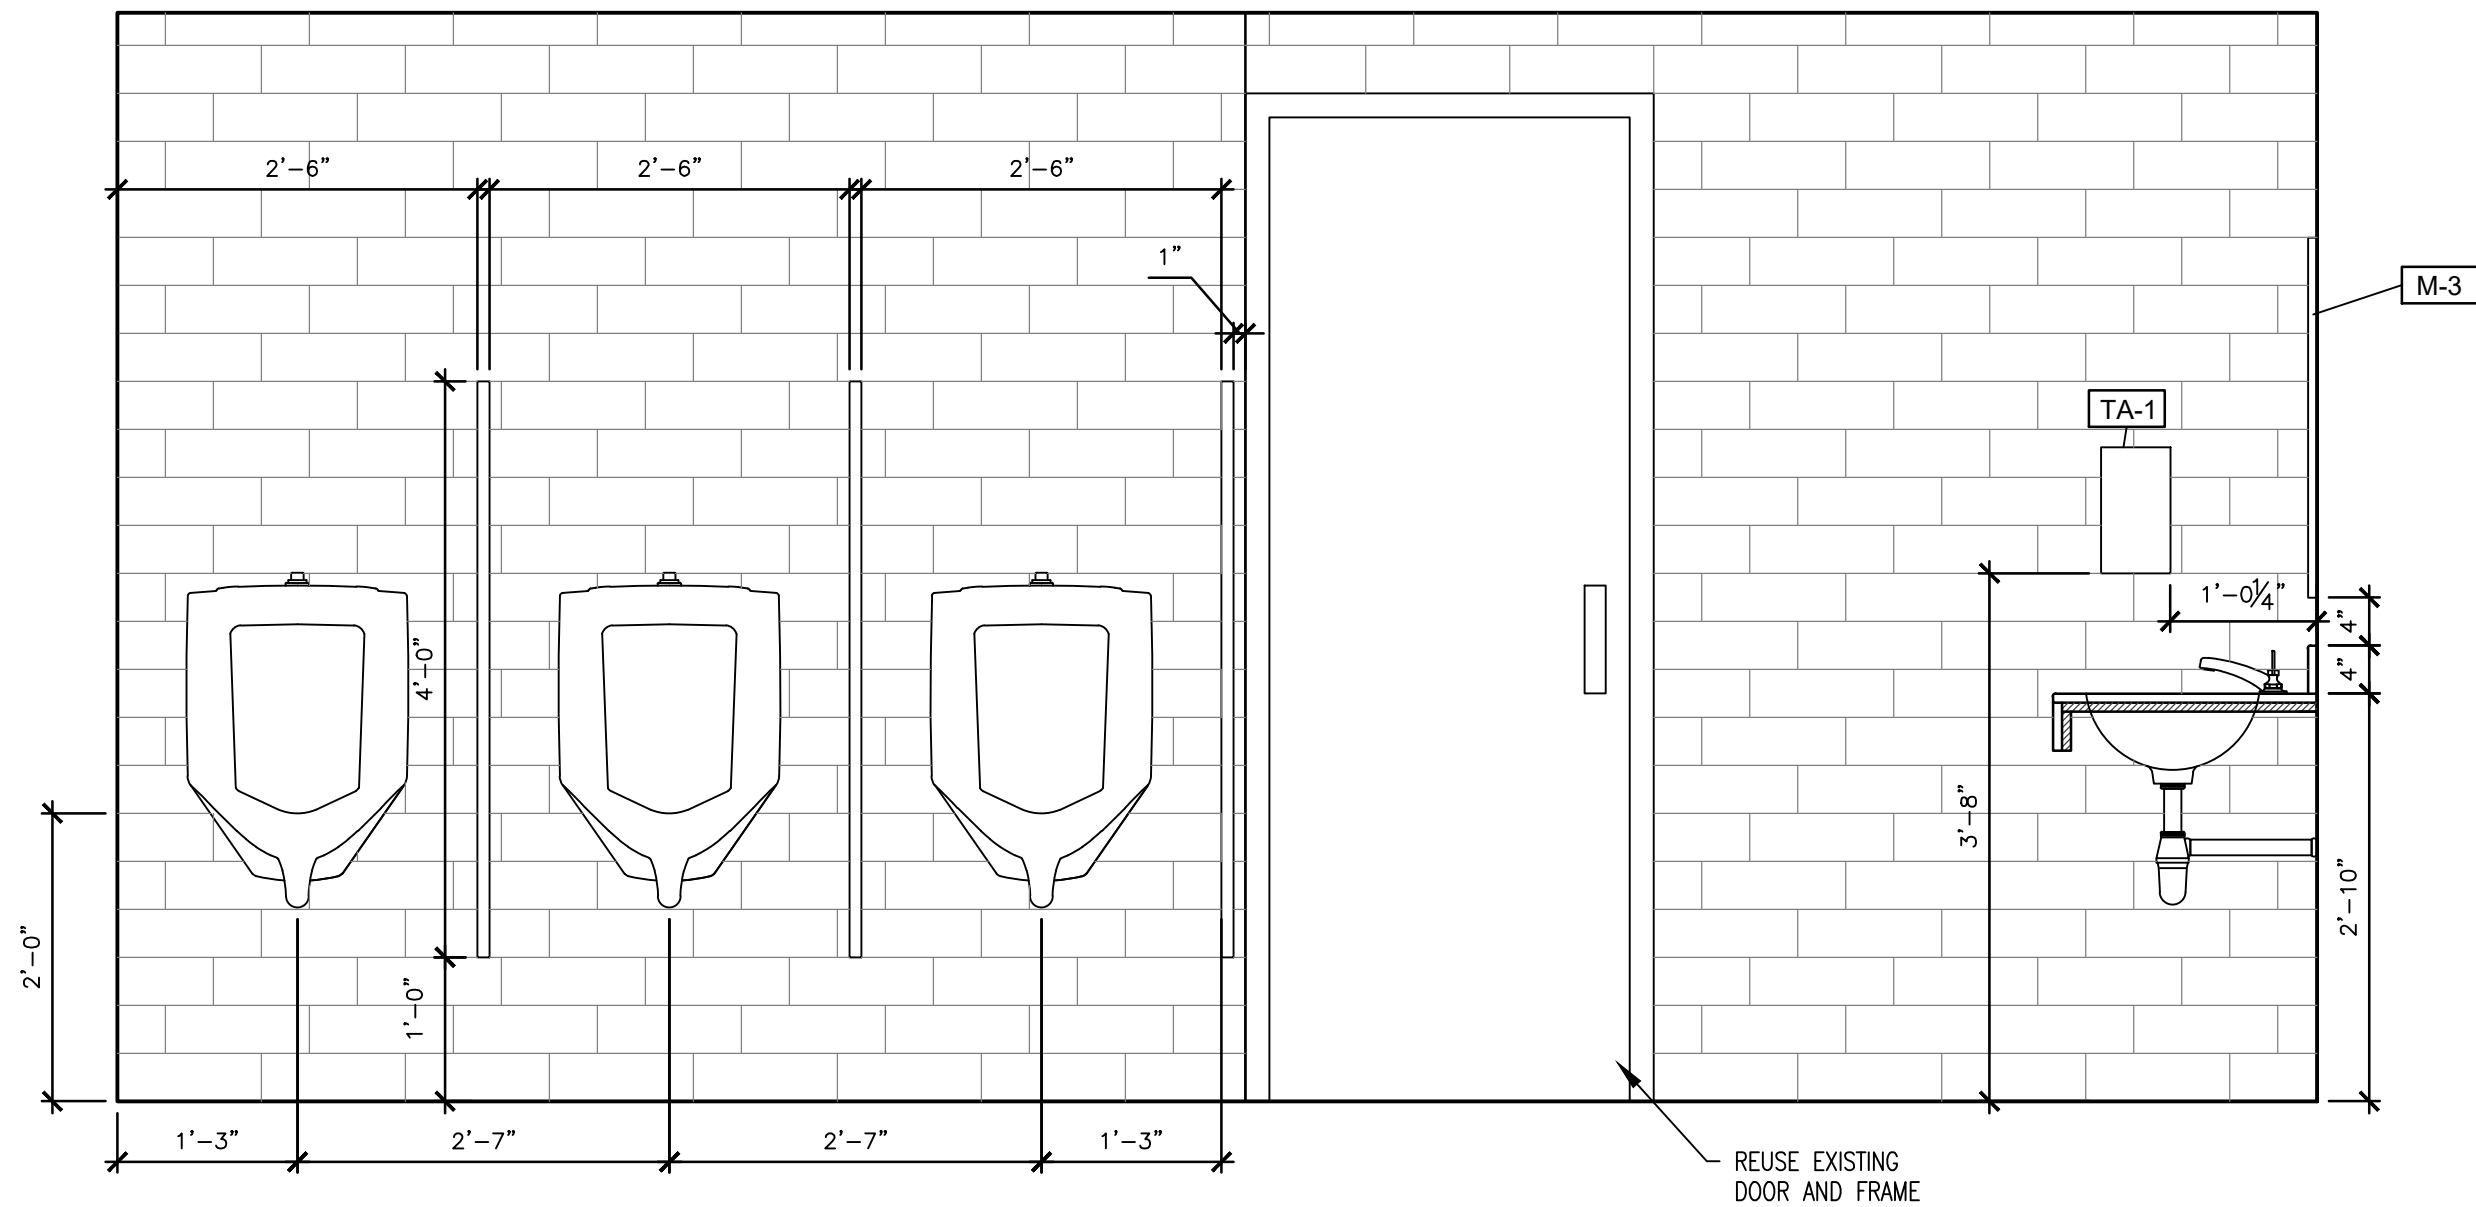

3 ELEVATION — MENS RESTROOM 2
SCALE: 3/4" = 1'-0"

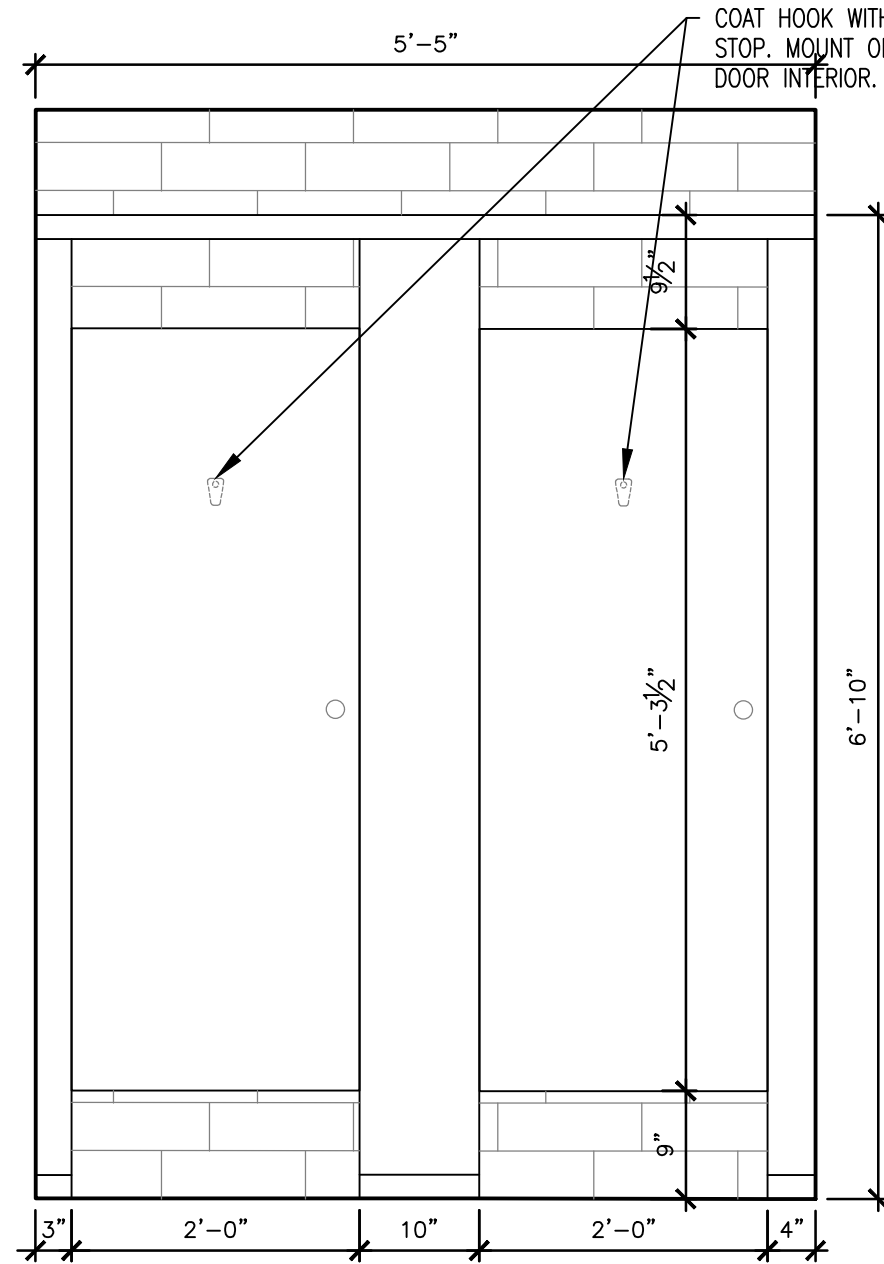

4 TOILET PARTITION ELEVATION — MENS RESTROOM 2
SCALE: 3/4" = 1'-0"

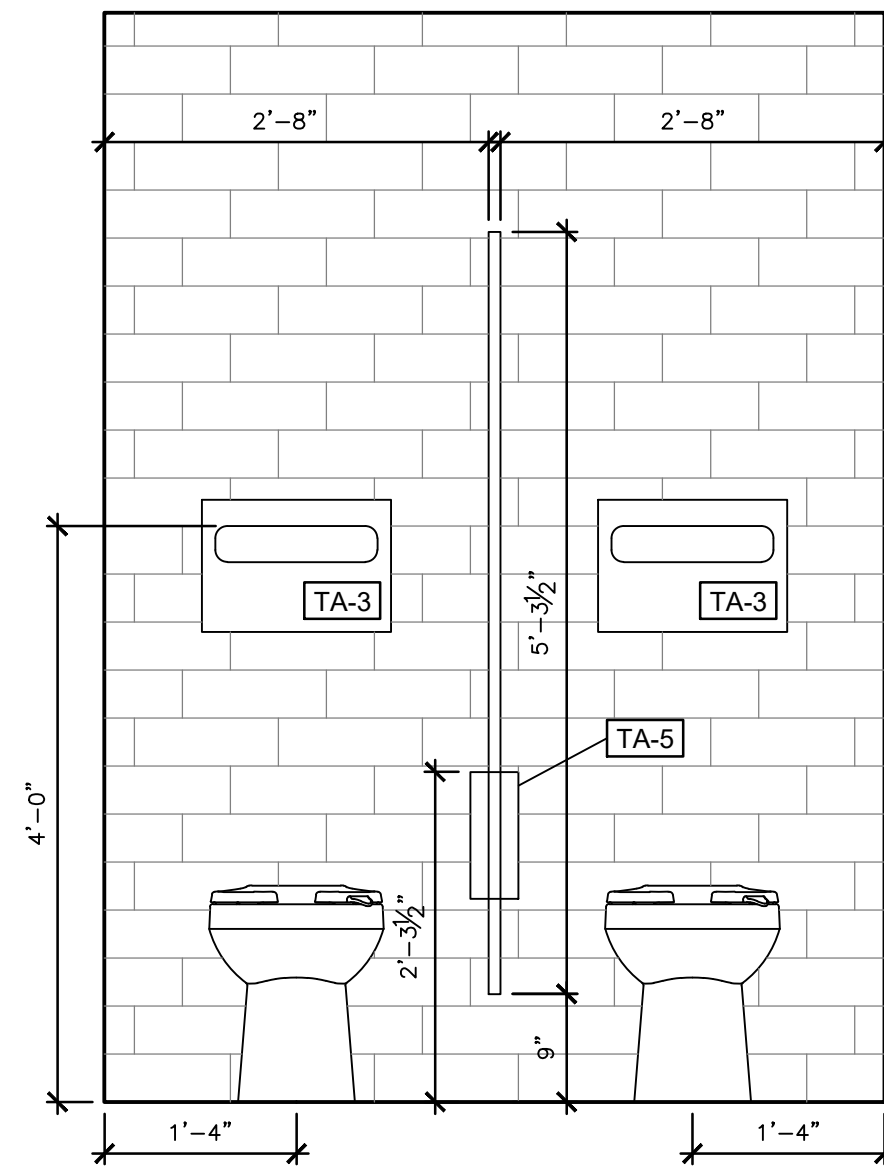


5 ELEVATION — MENS RESTROOM 2
SCALE: 3/4" = 1'-0"

RESTROOM FIXTURE SCHEDULE SHEET REFERENCE

MARK	PRODUCT
M-1	MIRROR
M-2	MIRROR
M-3	MIRROR
TA-1	SOAP DISPENSER
TA-2	PAPER TOWEL DISPENSER
TA-3	TOILET SEAT COVER DISPENSER
TA-5	TOILET PAPER DISPENSER
TA-9	CIRCULAR WASTE CHUTE

*SEE A-601 FOR FULL RESTROOM FIXTURE SCHEDULE.
*ALL FIXTURES TO BE LOCATED AT ADA STANDARD HEIGHTS &
SETBACKS UNLESS NOTED OTHERWISE.

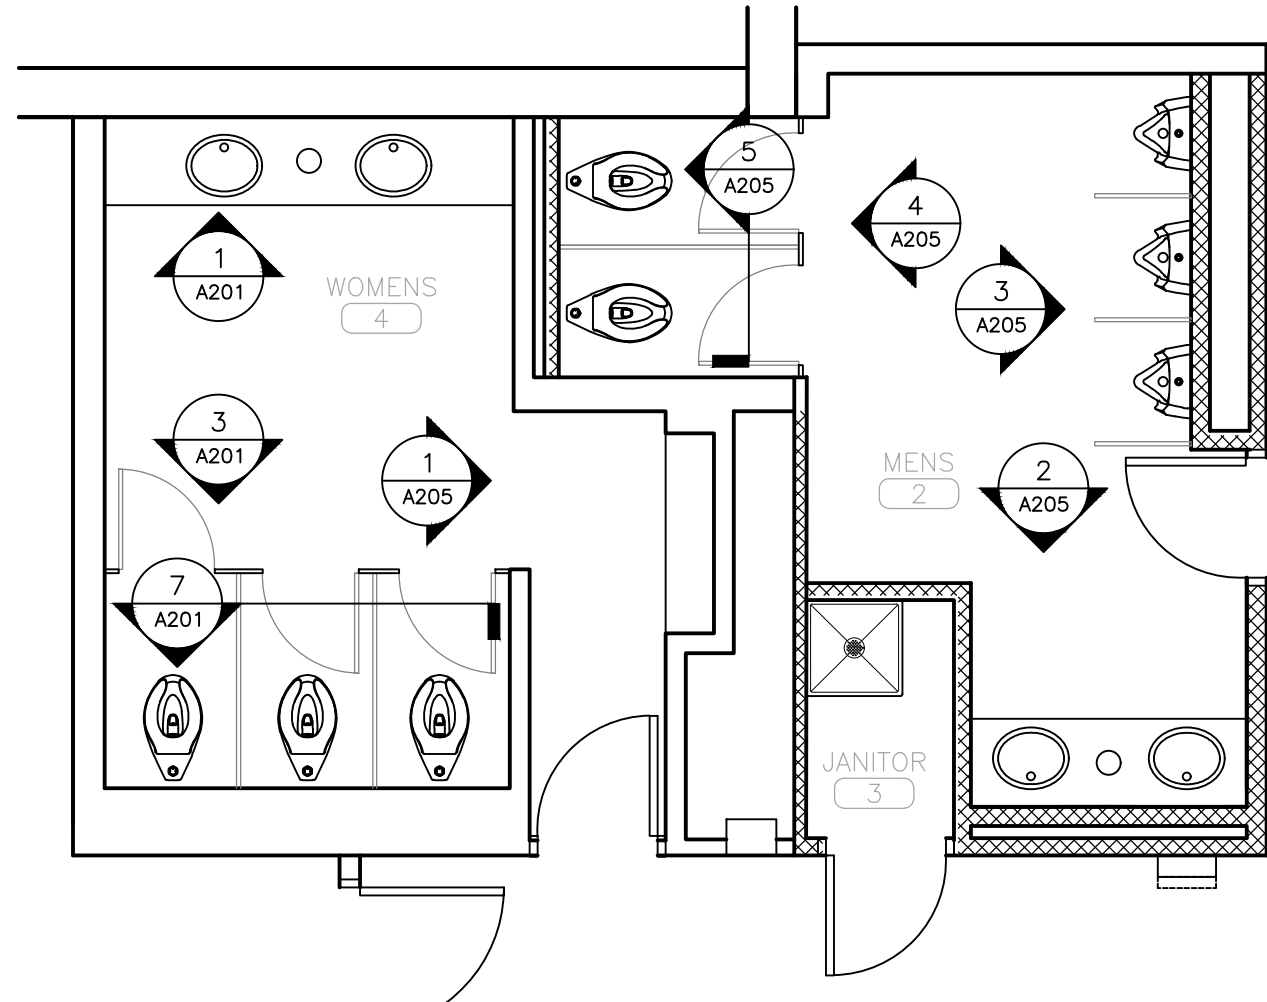

6 KEYPLAN — RESTROOMS 2 & 4
SCALE: 1/4" = 1'-0"

BID DOCUMENTS

**DEPARTMENT OF
PUBLIC SAFETY
STATE HIGHWAY PATROL**

GENERAL HEADQUARTERS
1510 EAST ELM STREET
JEFFERSON CITY, MO 65101

PROJECT #	R2410-01
SITE #	6001
ASSET #	8136001001

REVISION: _____
DATE: _____
REVISION: _____
DATE: _____
REVISION: _____
DATE: _____
ISSUE DATE: 06/18/2026

 
 
 
 
 
 
CAD DWG FILE: _____
 DRAWN BY: RG/CL
 CHECKED BY: BMS
 DESIGNED BY: CL

SHEET TITLE:
SECOND FLOOR
RESTROOM
ELEVATIONS

SHEET NUMBER:



A-206


11 OF 39 SHEETS
06/18/2026




*SEE A-601 FOR FULL RESTROOM
FIXTURE SCHEDULE.

 *ALL FIXTURES TO BE LOCATED AT
ADA STANDARD HEIGHTS & SETBACKS
UNLESS NOTED OTHERWISE.

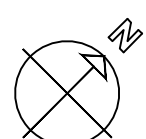

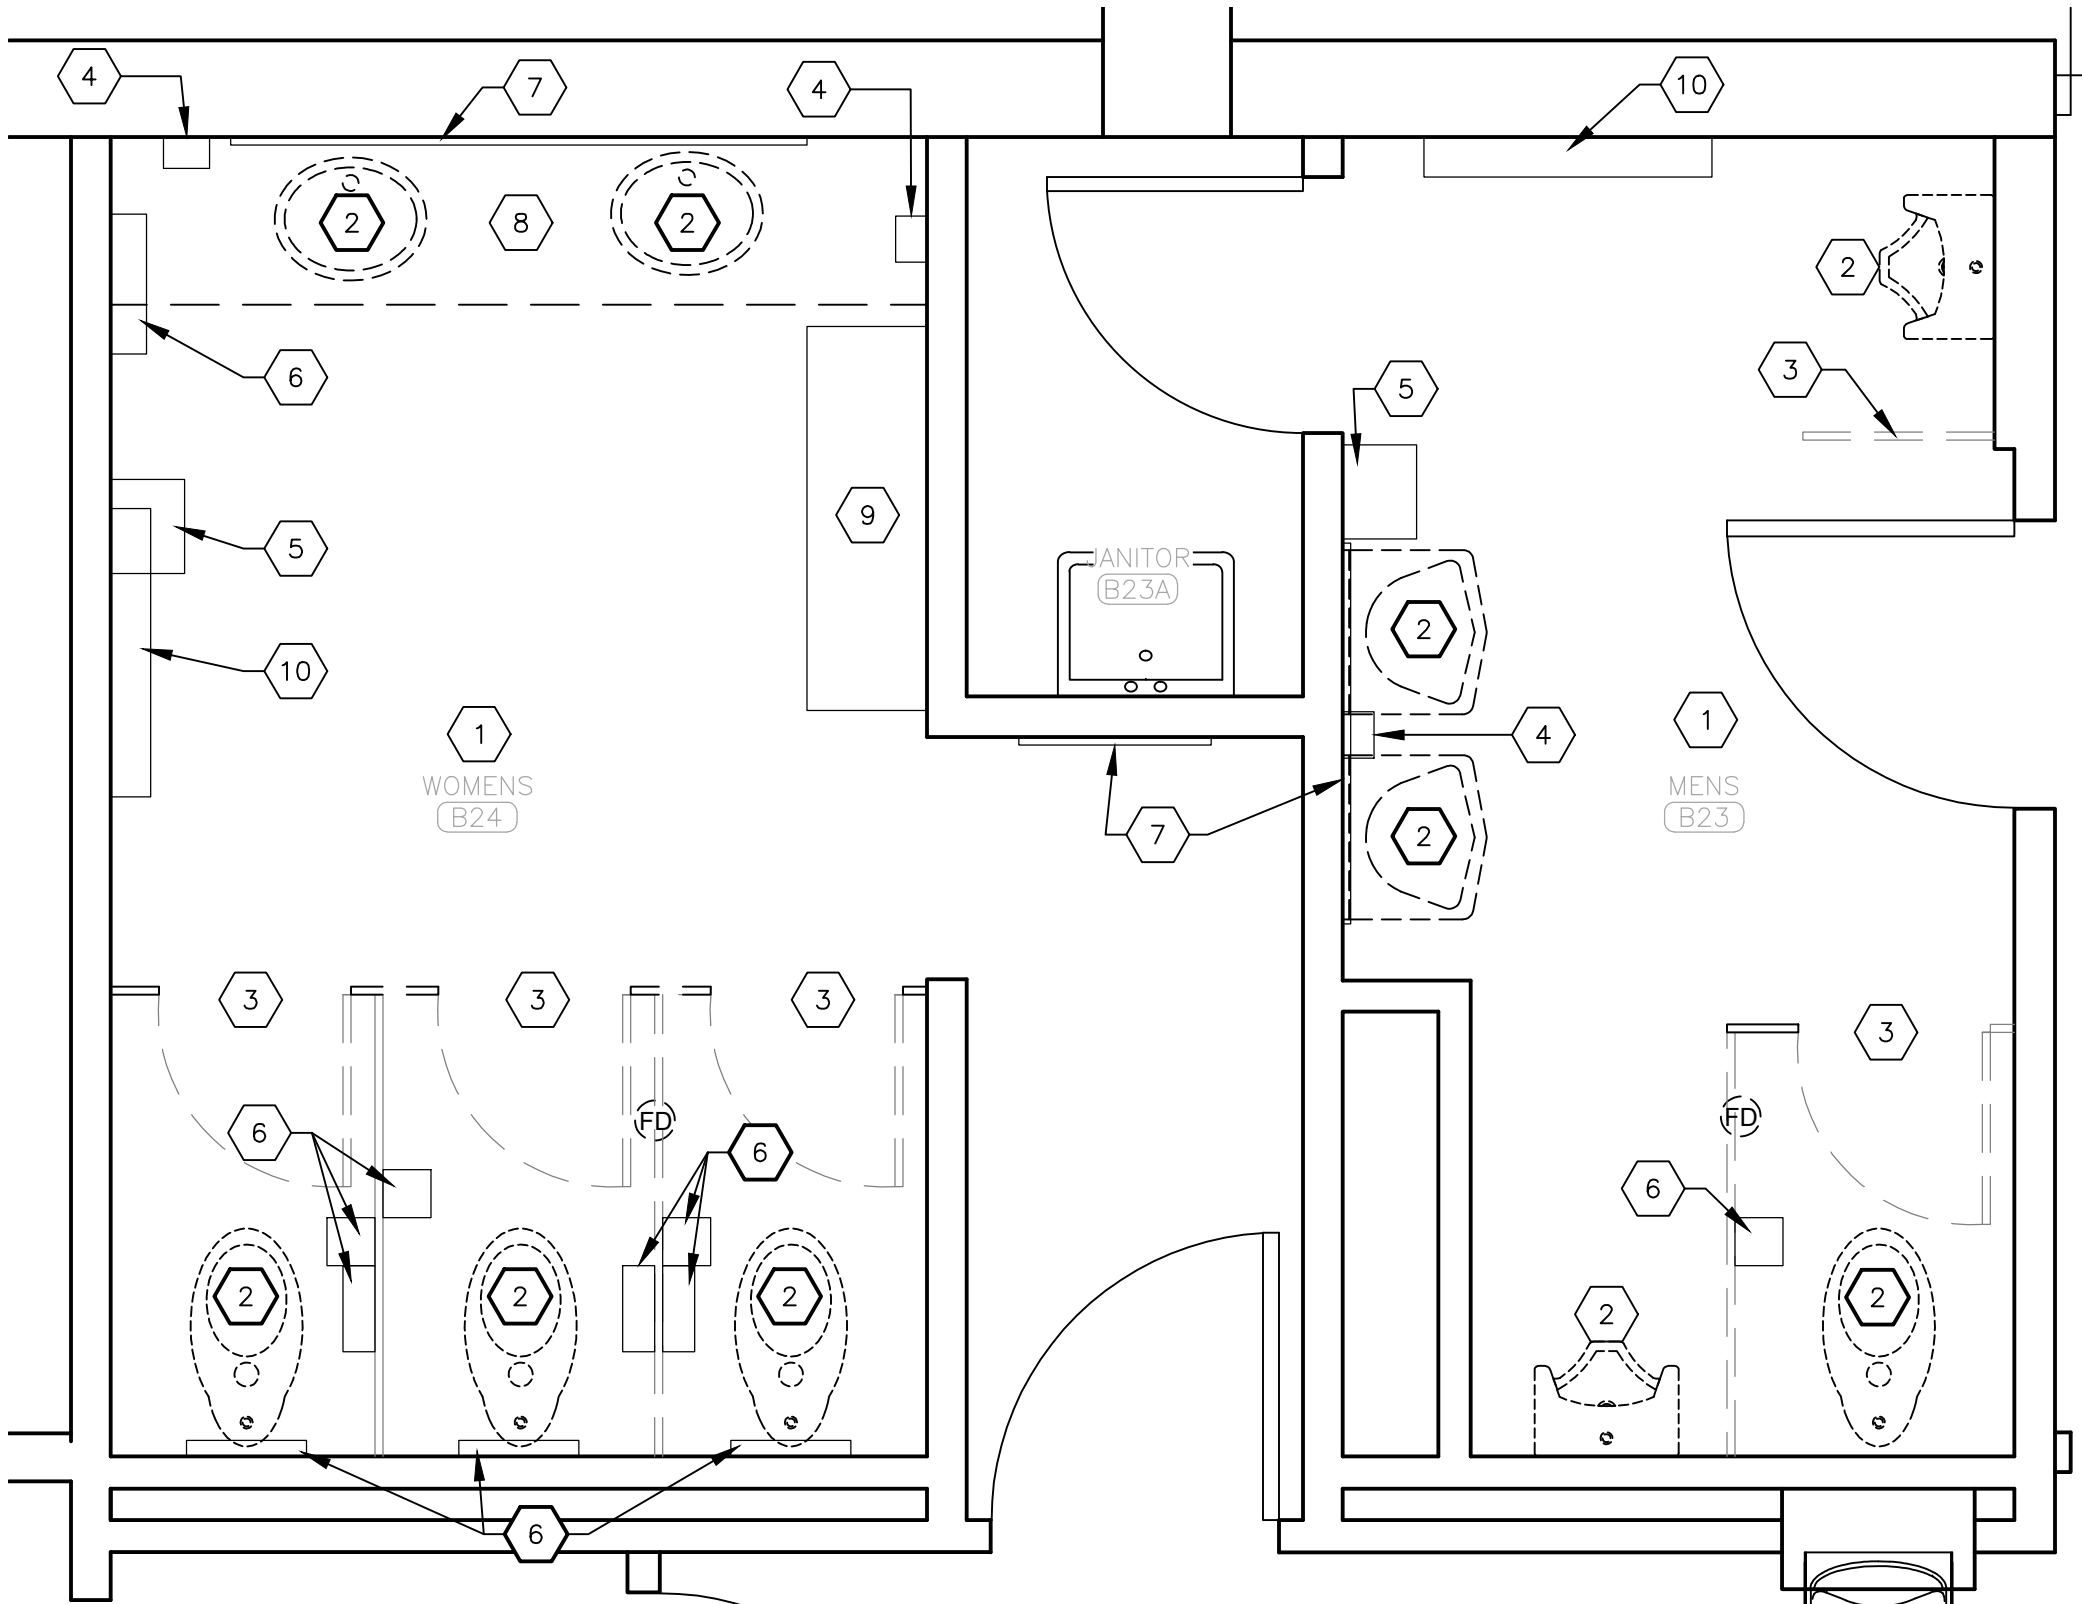

1 ALTERNATE NO. 1 - BASEMENT RESTROOM DEMOLITION PLAN
SCALE: 1/2" = 1'-0"

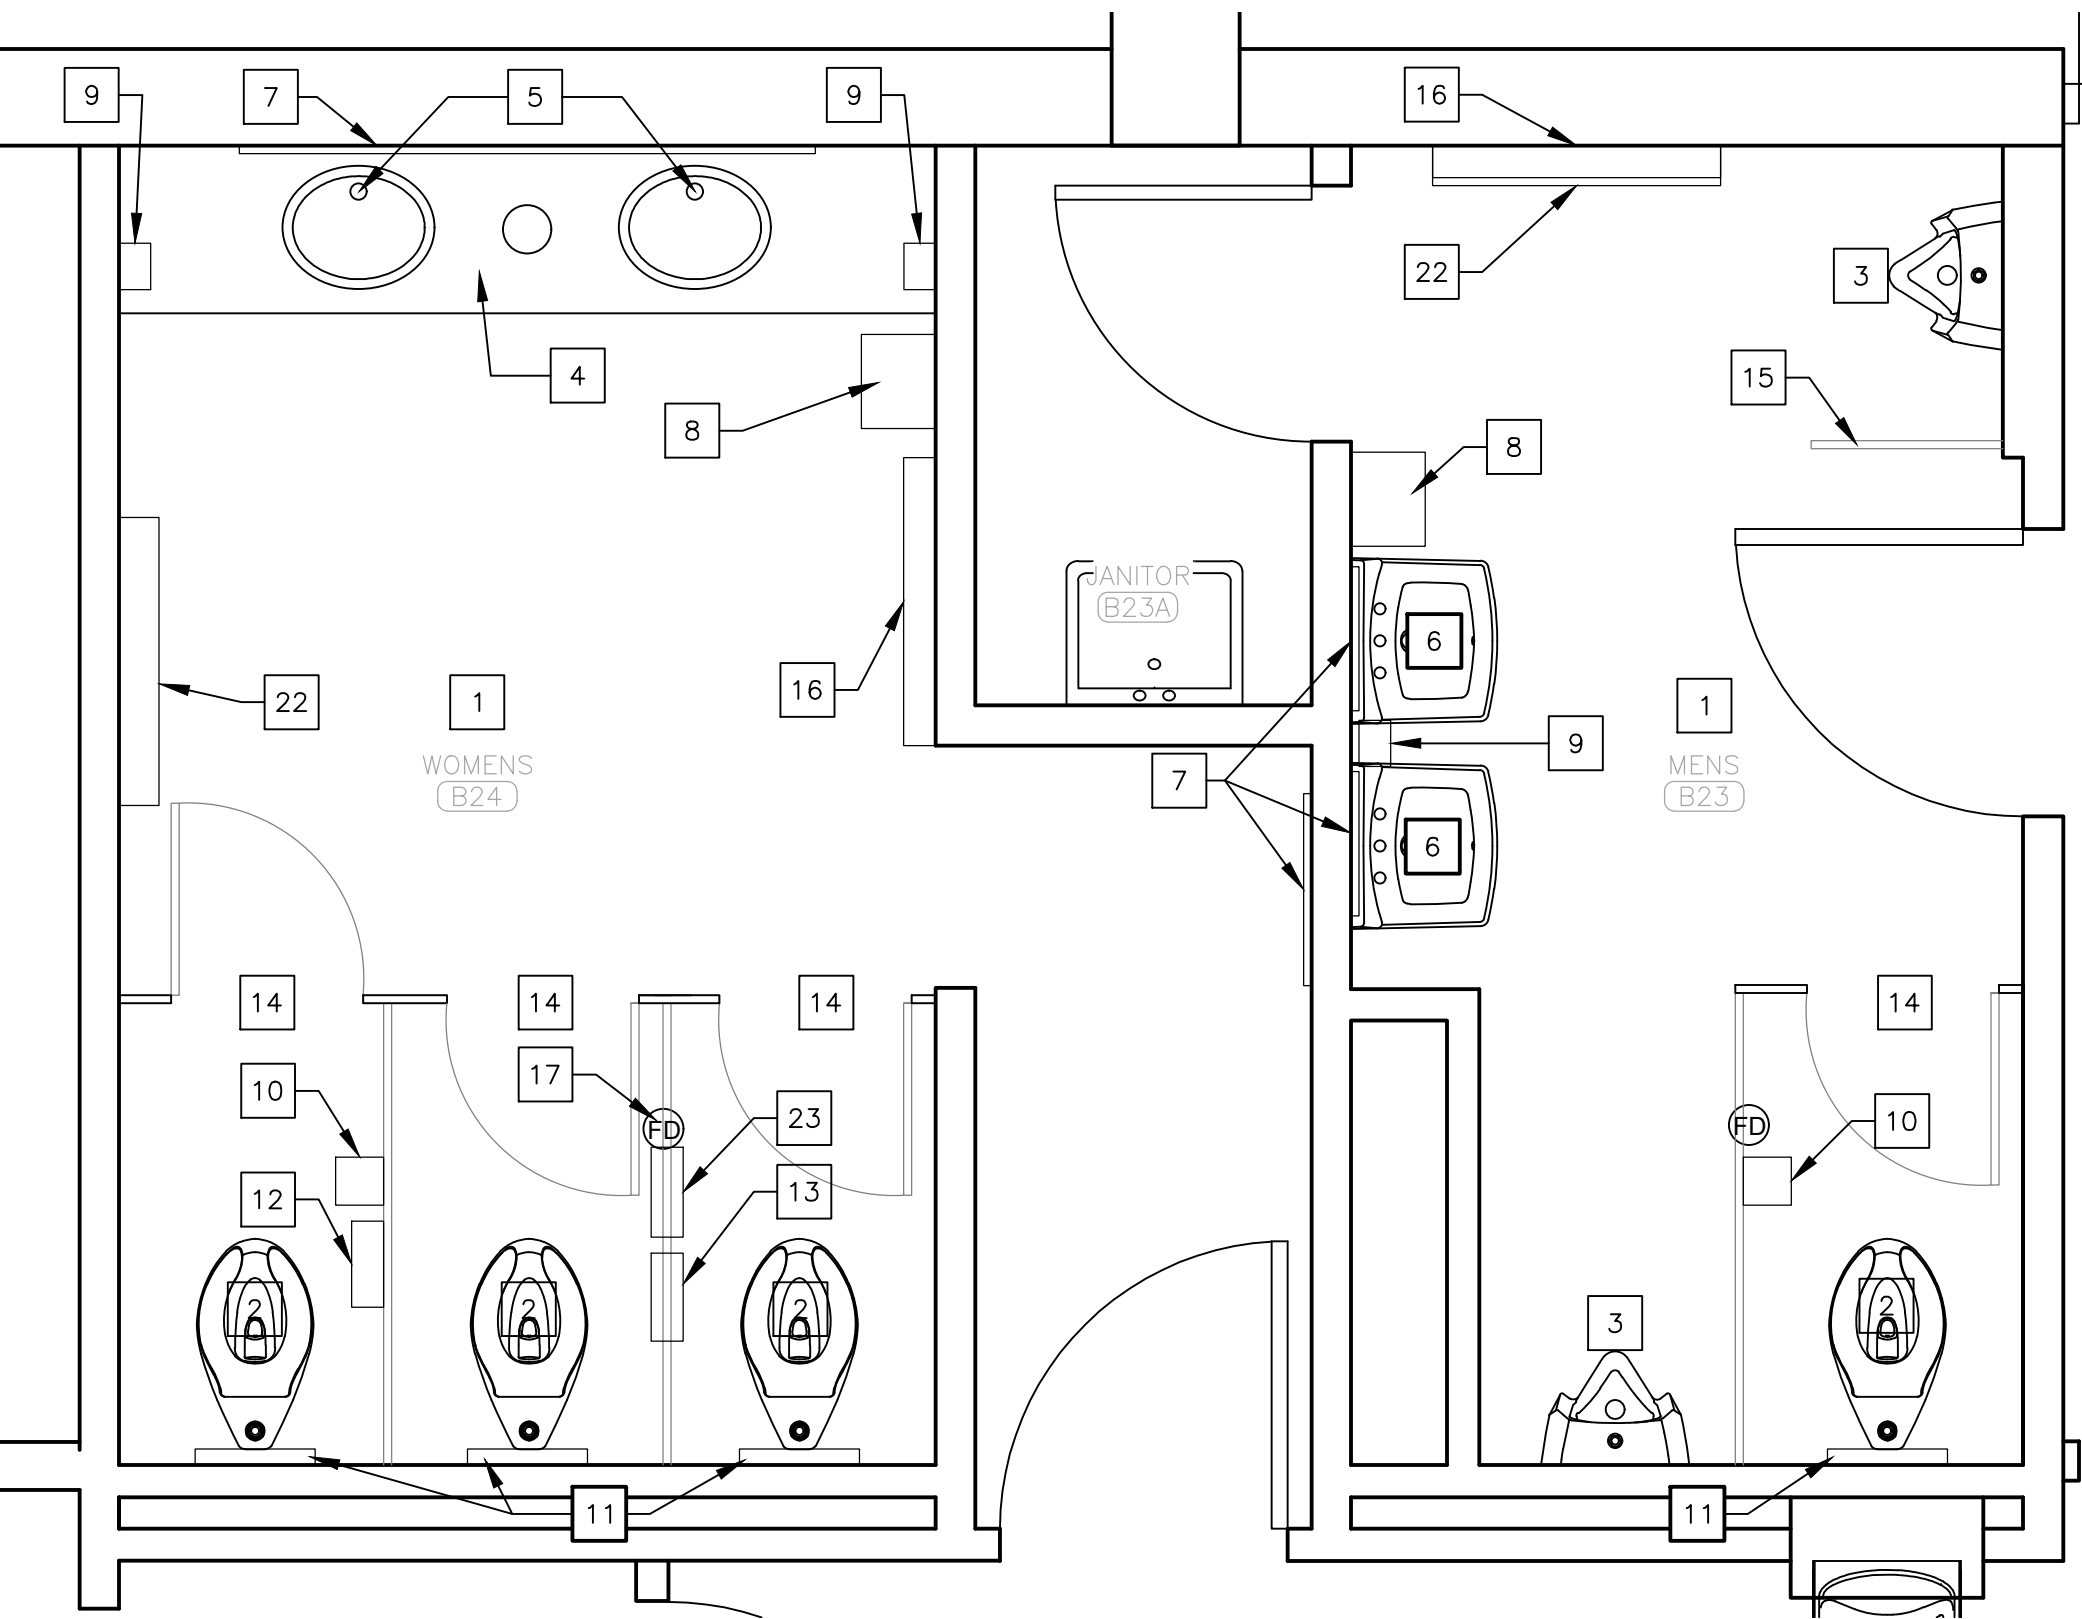

2 ALTERNATE NO. 1 - BASEMENT RESTROOM RENOVATION PLAN
SCALE: 1/2" = 1'-0"

NOTE: REFER TO SHEET A-201 FOR PARTITION ELEVATIONS

ALTERNATE NO. 1 - DEMOLITION KEYNOTES:


- 1 REMOVE EXISTING CERAMIC WALL TILE TO FULL EXTENTS OF THE ROOM, AND REPAIR EXISTING SUBSTRATE FOR NEW WALL TILE APPLICATION.
- 2 REMOVE EXISTING PLUMBING FIXTURES (LAVATORIES, TOILETS, URINALS). PREPARE EXISTING WALLS AND FLOORS FOR NEW FIXTURES. REFER TO PLUMBING DRAWINGS FOR DETAILS.
- 3 REMOVE EXISTING TOILET PARTITIONS AND URINAL SCREENS. PATCH AND REPAIR WALL AND FLOORS. PREPARE FOR NEW PARTITIONS.
- 4 REMOVE EXISTING SOAP DISPENSER AND SALVAGE FOR REUSE.
- 5 REMOVE EXISTING PAPER TOWEL DISPENSER AND SALVAGE FOR REUSE.
- 6 REMOVE EXISTING TOILET ACCESSORIES (TOILET PAPER DISPENSER, TOILET SEAT COVER DISPENSER, SANITARY NAPKIN DISPOSAL, SANITARY NAPKIN DISPENSER).
- 7 REMOVE EXISTING MIRROR.
- 8 REMOVE EXISTING BASE CABINETS AND COUNTERTOP.
- 9 REMOVE EXISTING METAL LOCKERS AND RELINQUISH TO OWNER.
- 10 REFER TO M-101 FOR REMOVAL OF CONVECTOR.
- 11 REMOVE EXISTING CEILING TILES AND SUSPENDED CEILING GRID. RELINQUISH FULL AND UNDAMAGED CEILING TILES TO OWNER.
- 12 REMOVE EXISTING CEILING MOUNTED LIGHT FIXTURES AND AIR DIFFUSERS. REFER TO MECHANICAL AND ELECTRICAL DRAWINGS FOR DETAILS.
- 13 EXISTING SUPPORT STRUCTURE TO REMAIN FOR CEILING HUNG PARTITIONS. PROTECT FROM DAMAGE.

ALTERNATE NO. 1 - RENOVATION KEYNOTES:


- 1 INSTALL NEW CERAMIC WALL TILE, TO FULL EXTENTS OF ROOM.
- 2 INSTALL NEW WATER CLOSET. REFER TO PLUMBING DRAWINGS FOR DETAILS.
- 3 INSTALL NEW URINAL. REFER TO PLUMBING DRAWINGS FOR DETAILS.
- 4 INSTALL NEW SOLID SURFACE COUNTERTOP WITH CIRCULAR WASTE CHUTE CENTERED BETWEEN LAVATORIES. REFER TO A-501 FOR DETAILS.
- 5 INSTALL NEW UNDERMOUNT SINK AND FAUCET. REFER TO PLUMBING DRAWINGS FOR DETAILS.
- 6 INSTALL NEW WALL MOUNT SINK AND FAUCET. REFER TO PLUMBING DRAWINGS FOR DETAILS.
- 7 INSTALL NEW MIRROR.
- 8 REINSTALL PAPER TOWEL DISPENSER.
- 9 REINSTALL SOAP DISPENSER.
- 10 INSTALL NEW TOILET PAPER DISPENSER.
- 11 INSTALL NEW TOILET SEAT COVER DISPENSER.
- 12 INSTALL NEW SURFACE MOUNT SANITARY NAPKIN DISPOSAL.
- 13 INSTALL NEW DUAL ACCESS SANITARY NAPKIN DISPOSAL.
- 14 INSTALL NEW CEILING HUNG TOILET PARTITION. ENSURE ADEQUATE FRAMING ABOVE CEILING TO SUPPORT PARTITIONS.
- 15 INSTALL NEW WALL MOUNT URINAL PARTITION.
- 16 INSTALL CUSTOM SOLID SURFACE SHELF WITH UNDERMOUNT STAINLESS STEEL HOOKS. REFER TO A-501 FOR DETAILS.
- 17 RESLOPE FLOOR TO DRAIN AT 1/4 INCH PER FOOT.
- 18 INSTALL NEW 2'x2' SUSPENDED CEILING GRID AND ACOUSTIC CEILING TILES.
- 19 INSTALL NEW SUSPENDED DRYWALL FRAMING SYSTEM FOR DRYWALL SOFFIT. PROVIDE LEVEL 4 FINISH AND PAINT.
- 20 INSTALL NEW CEILING AIR DIFFUSERS. REFER TO MECHANICAL DRAWINGS FOR DETAILS.
- 21 INSTALL NEW CEILING LIGHT FIXTURES. REFER TO ELECTRICAL DRAWINGS FOR DETAILS.
- 22 REFER TO M-101 FOR INSTALLATION OF CONVECTOR. TILE AROUND EXISTING FLOOR PENETRATIONS.
- 23 INSTALL NEW PARTITION-MOUNTED DUAL-SIDED TOILET PAPER DISPENSER.
- 24 EXISTING STEEL BEAM ABOVE CEILING TO REMAIN. MOUNT NEW PARTITIONS TO BEAM.

LEGEND

- CEILING HEIGHT TAG
- FLOOR DRAIN - DEMO
- FLOOR DRAIN - NEW
- DRYWALL CEILING
- RECESSED CAN LIGHT

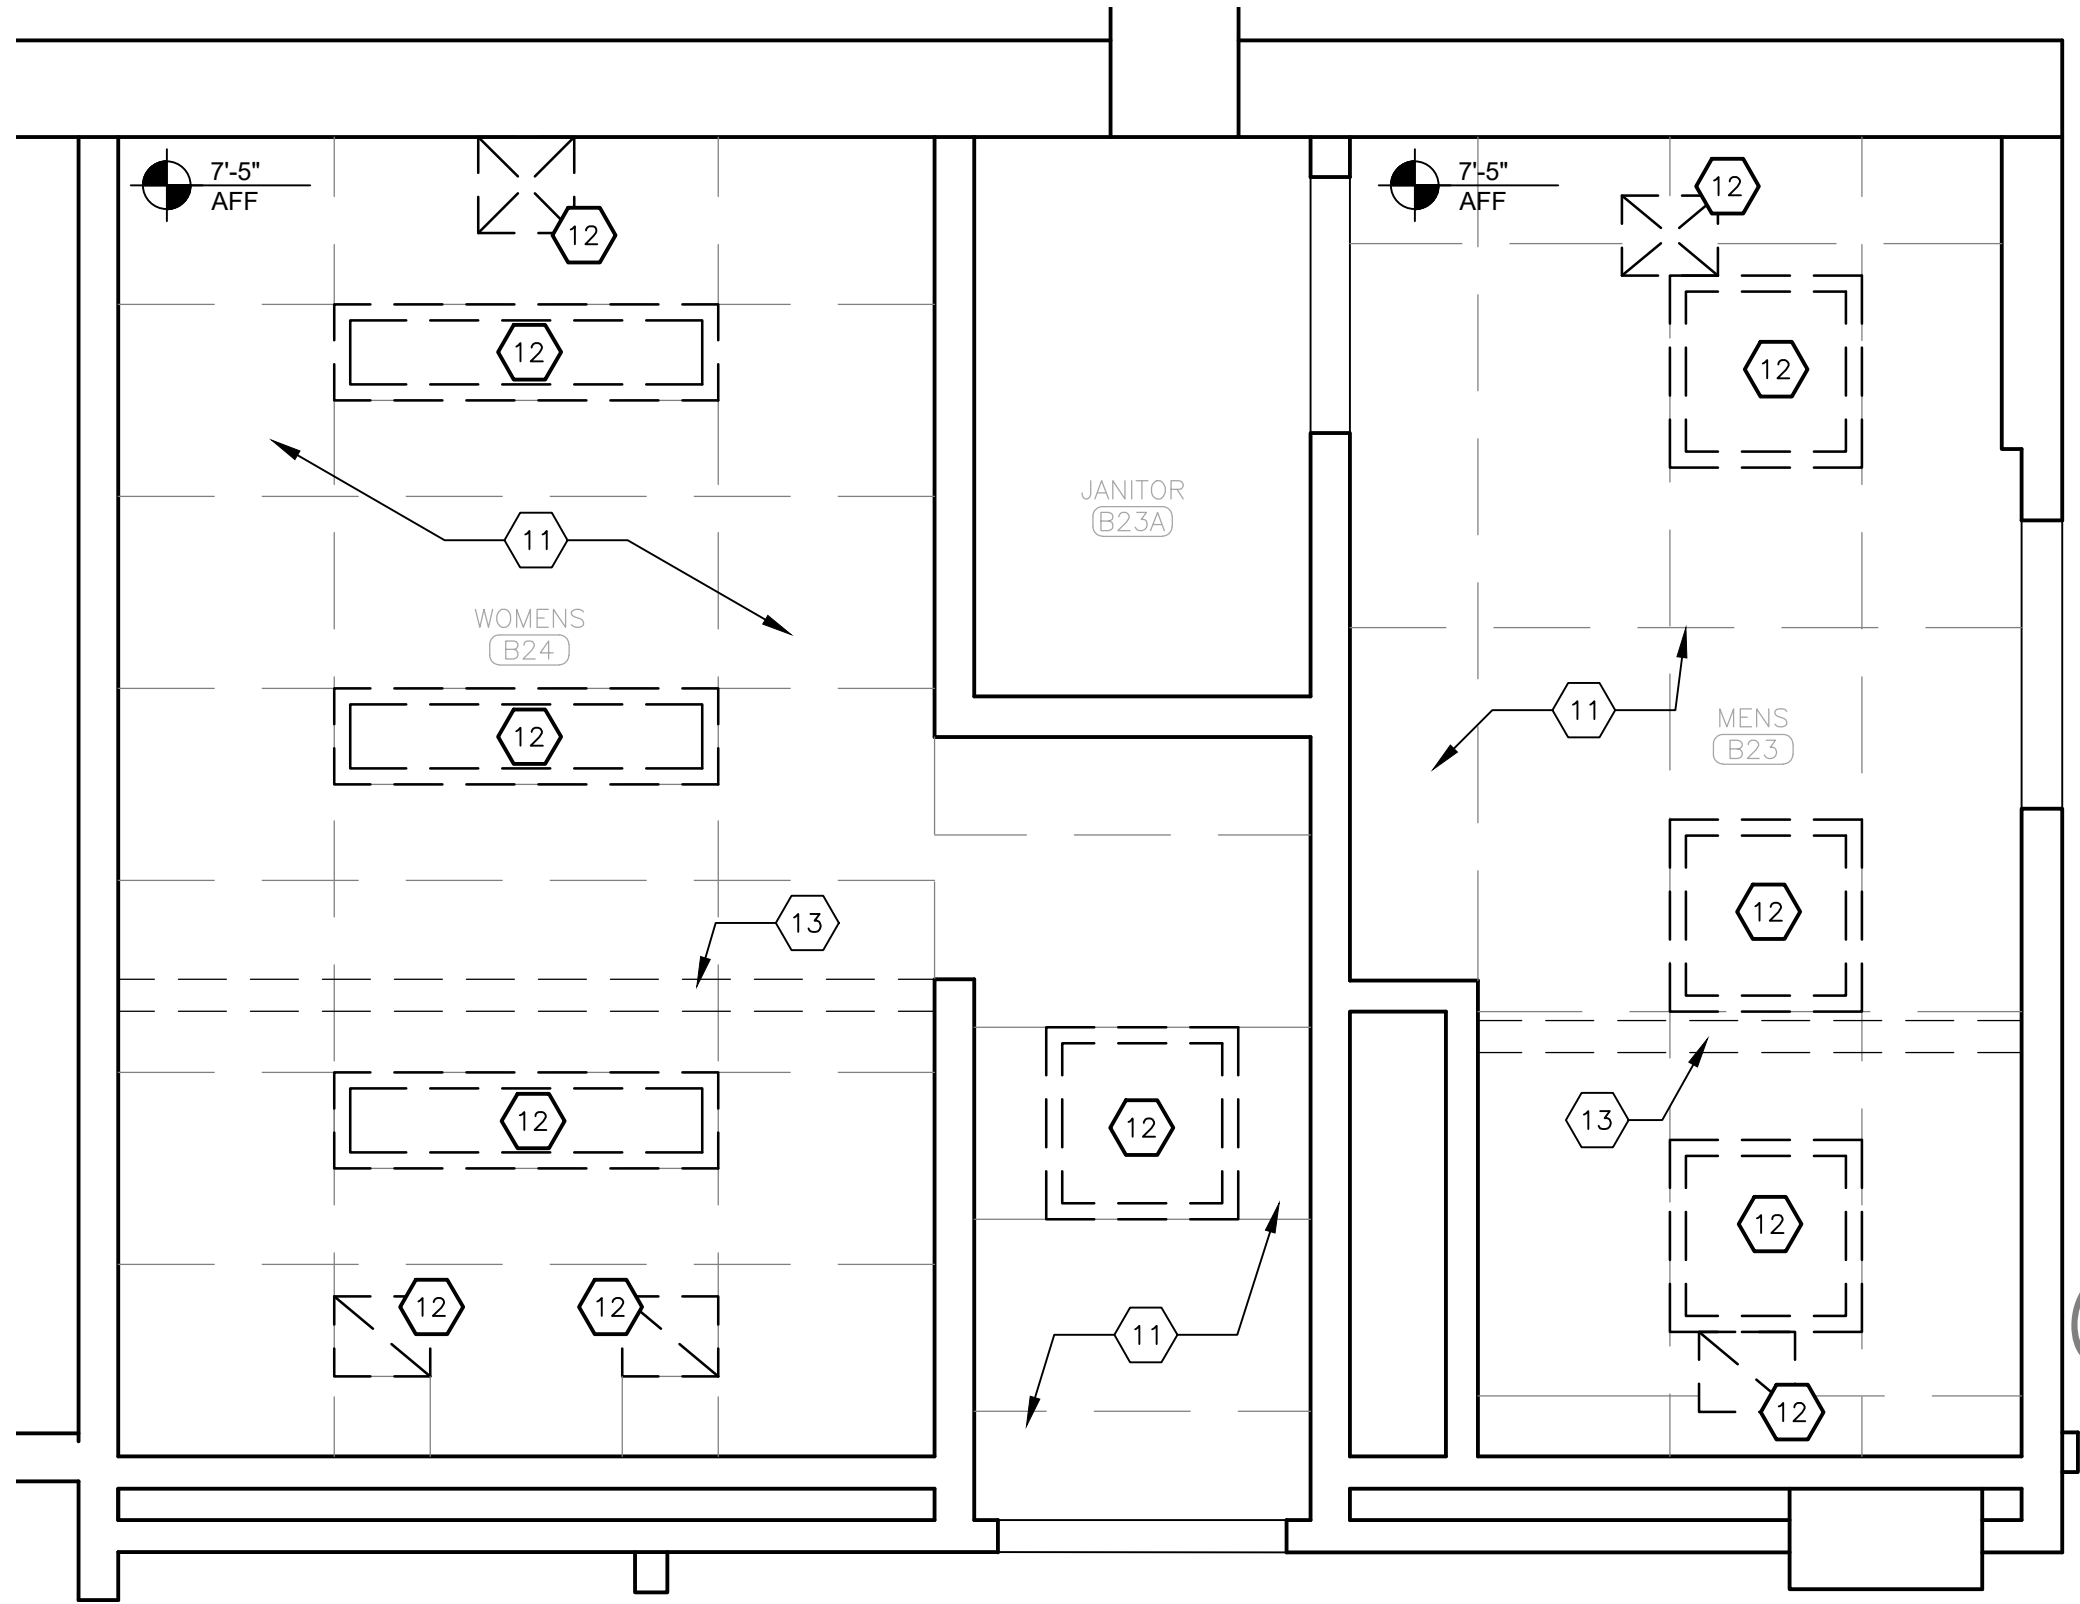

3 ALTERNATE NO. 1 - BASEMENT RESTROOM DEMOLITION REFLECTED CEILING PLAN
SCALE: 1/2" = 1'-0"

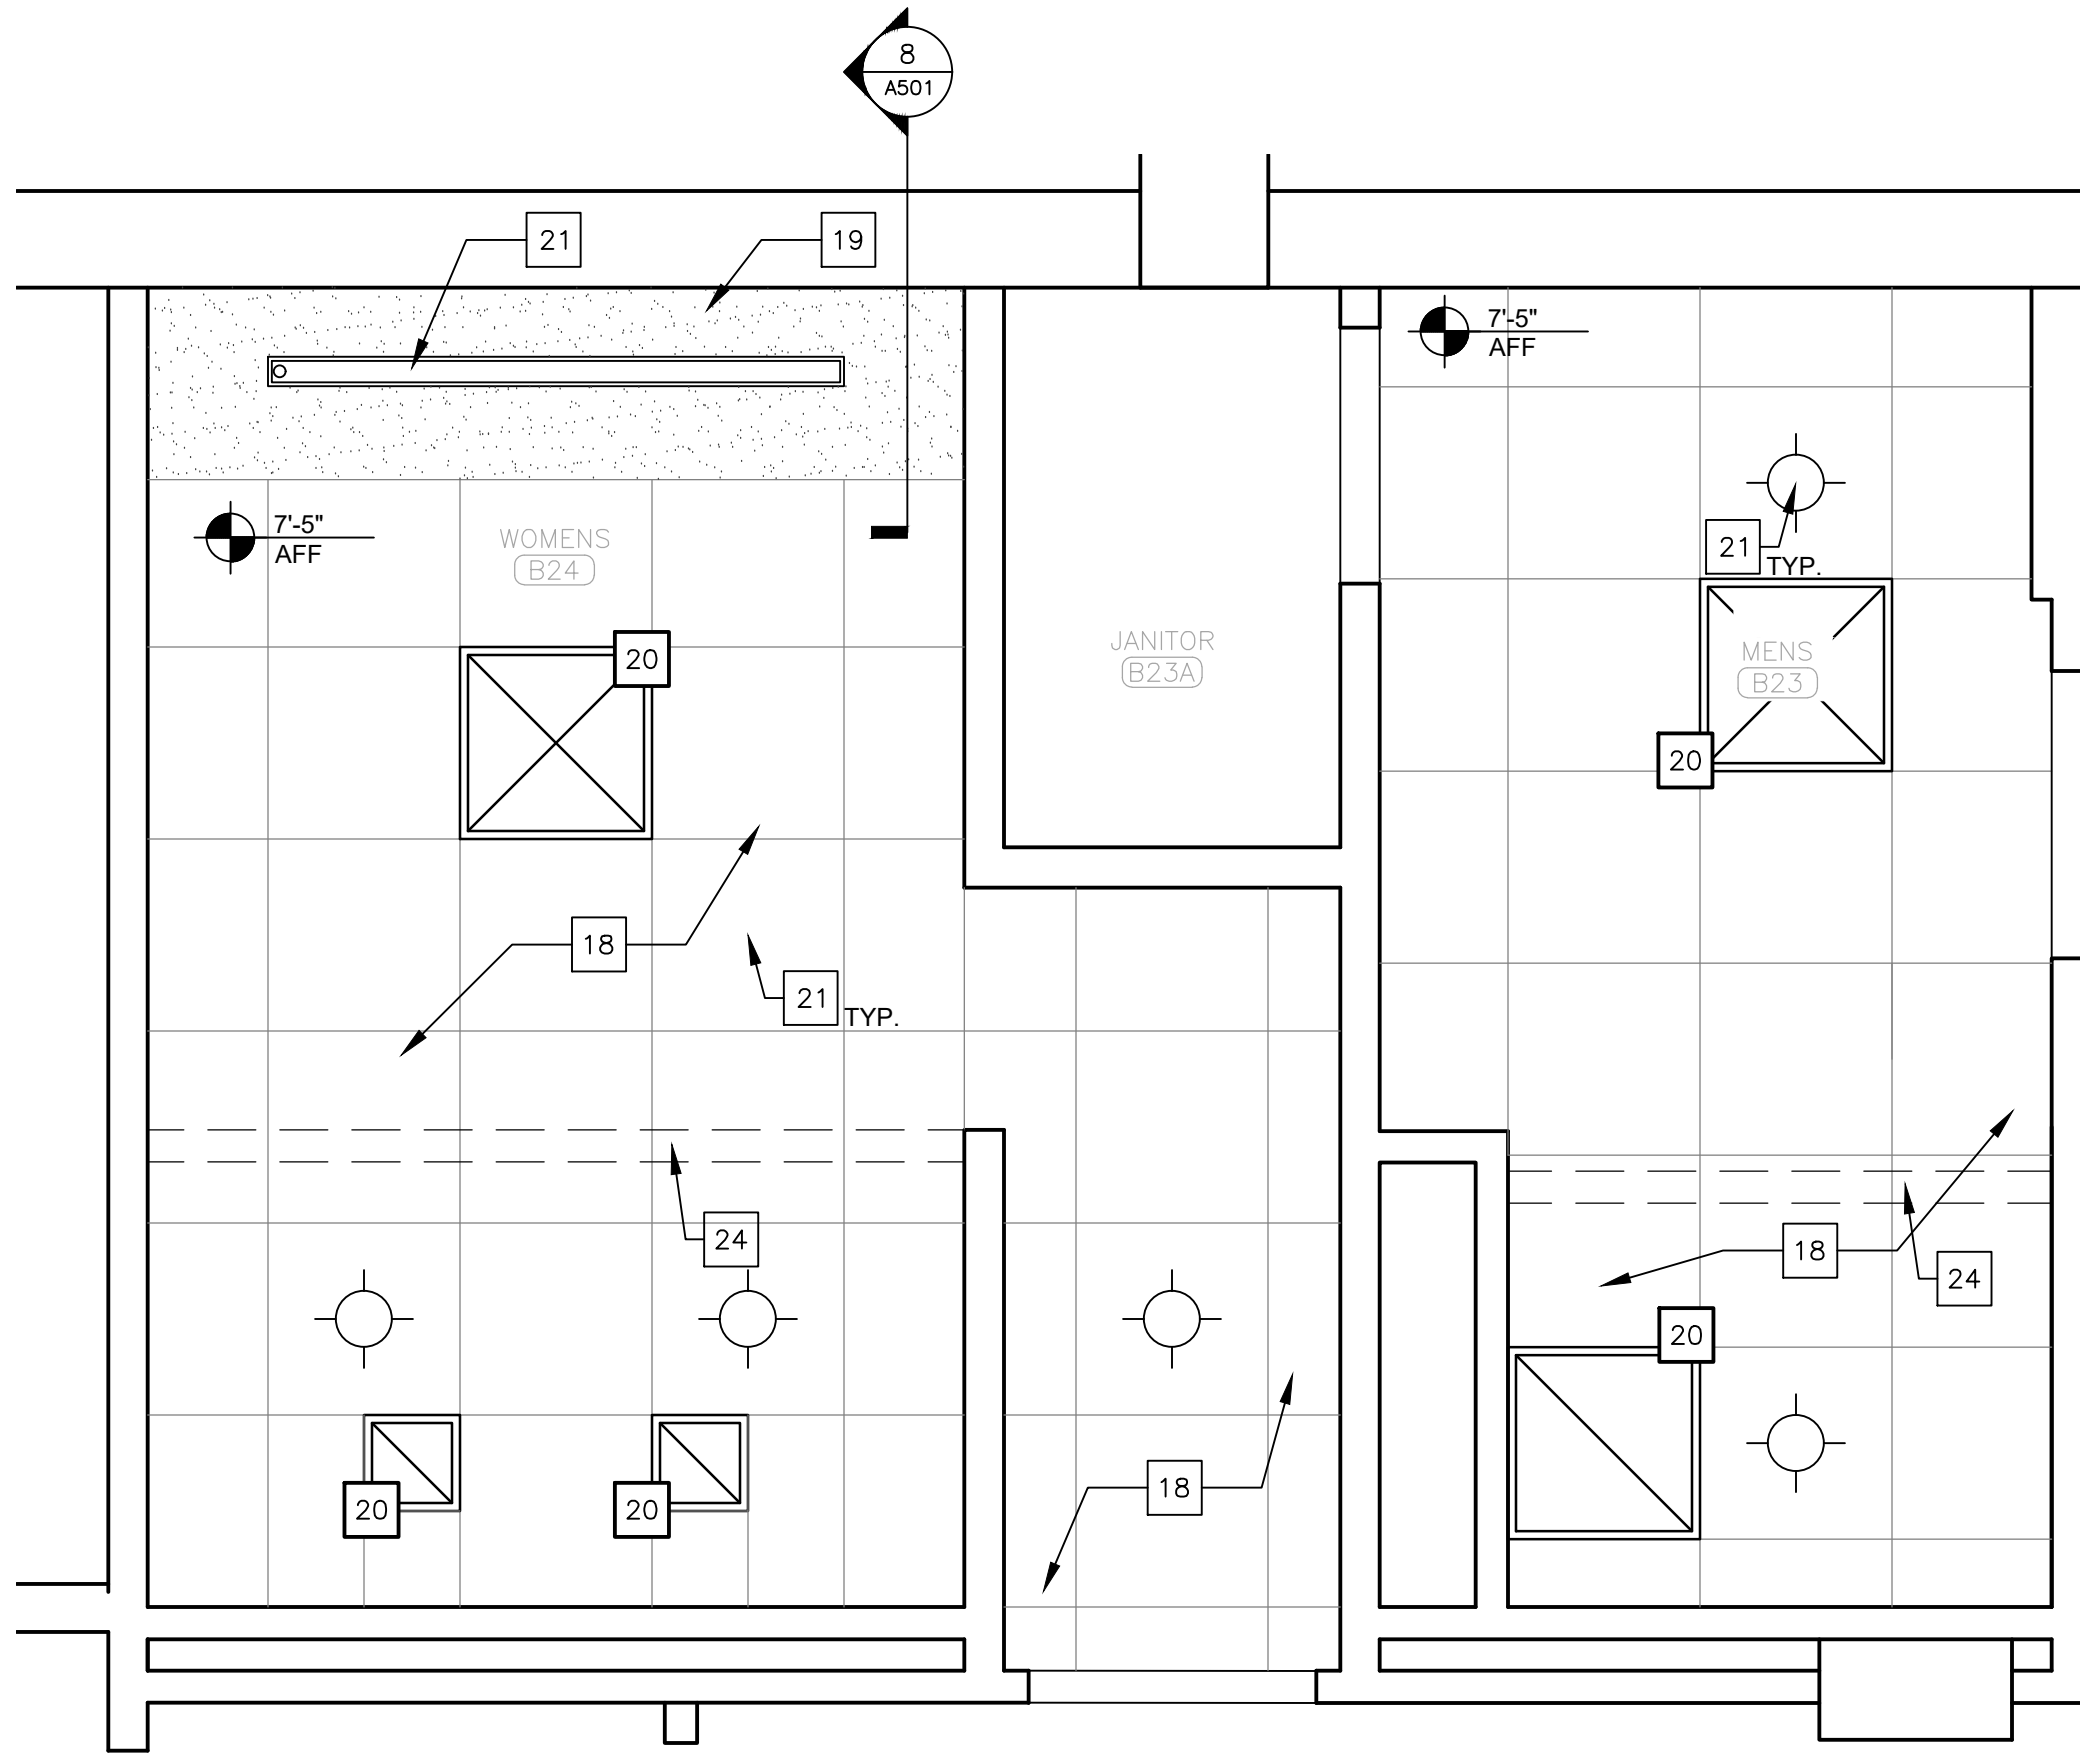

4 ALTERNATE NO. 1 - BASEMENT RESTROOM RENOVATION REFLECTED CEILING PLAN
SCALE: 1/2" = 1'-0"

STATE OF MISSOURI
MIKE KEHOE,
GOVERNOR



Brad M. Schaefer - Architect
MO# A-2009027294

BID DOCUMENTS

OFFICE OF ADMINISTRATION
DIVISION OF FACILITIES
MANAGEMENT,
DESIGN AND CONSTRUCTION

DEPARTMENT OF
PUBLIC SAFETY
STATE HIGHWAY PATROL

RENOVATE INTERIOR

GENERAL HEADQUARTERS
1510 EAST ELM STREET
JEFFERSON CITY, MO 65101

PROJECT # R2410-01
SITE # 6001
ASSET # 8136001001

REVISION: _____
DATE: _____
REVISION: _____
DATE: _____
REVISION: _____
DATE: _____
ISSUE DATE: 06/18/2026

CAD DWG FILE: _____
DRAWN BY: RG/CL
CHECKED BY: BMS
DESIGNED BY: CL


SHEET TITLE:

BASEMENT
RESTROOM
ENLARGED PLANS


SHEET NUMBER:

A-401

12 OF 39 SHEETS
06/18/2026

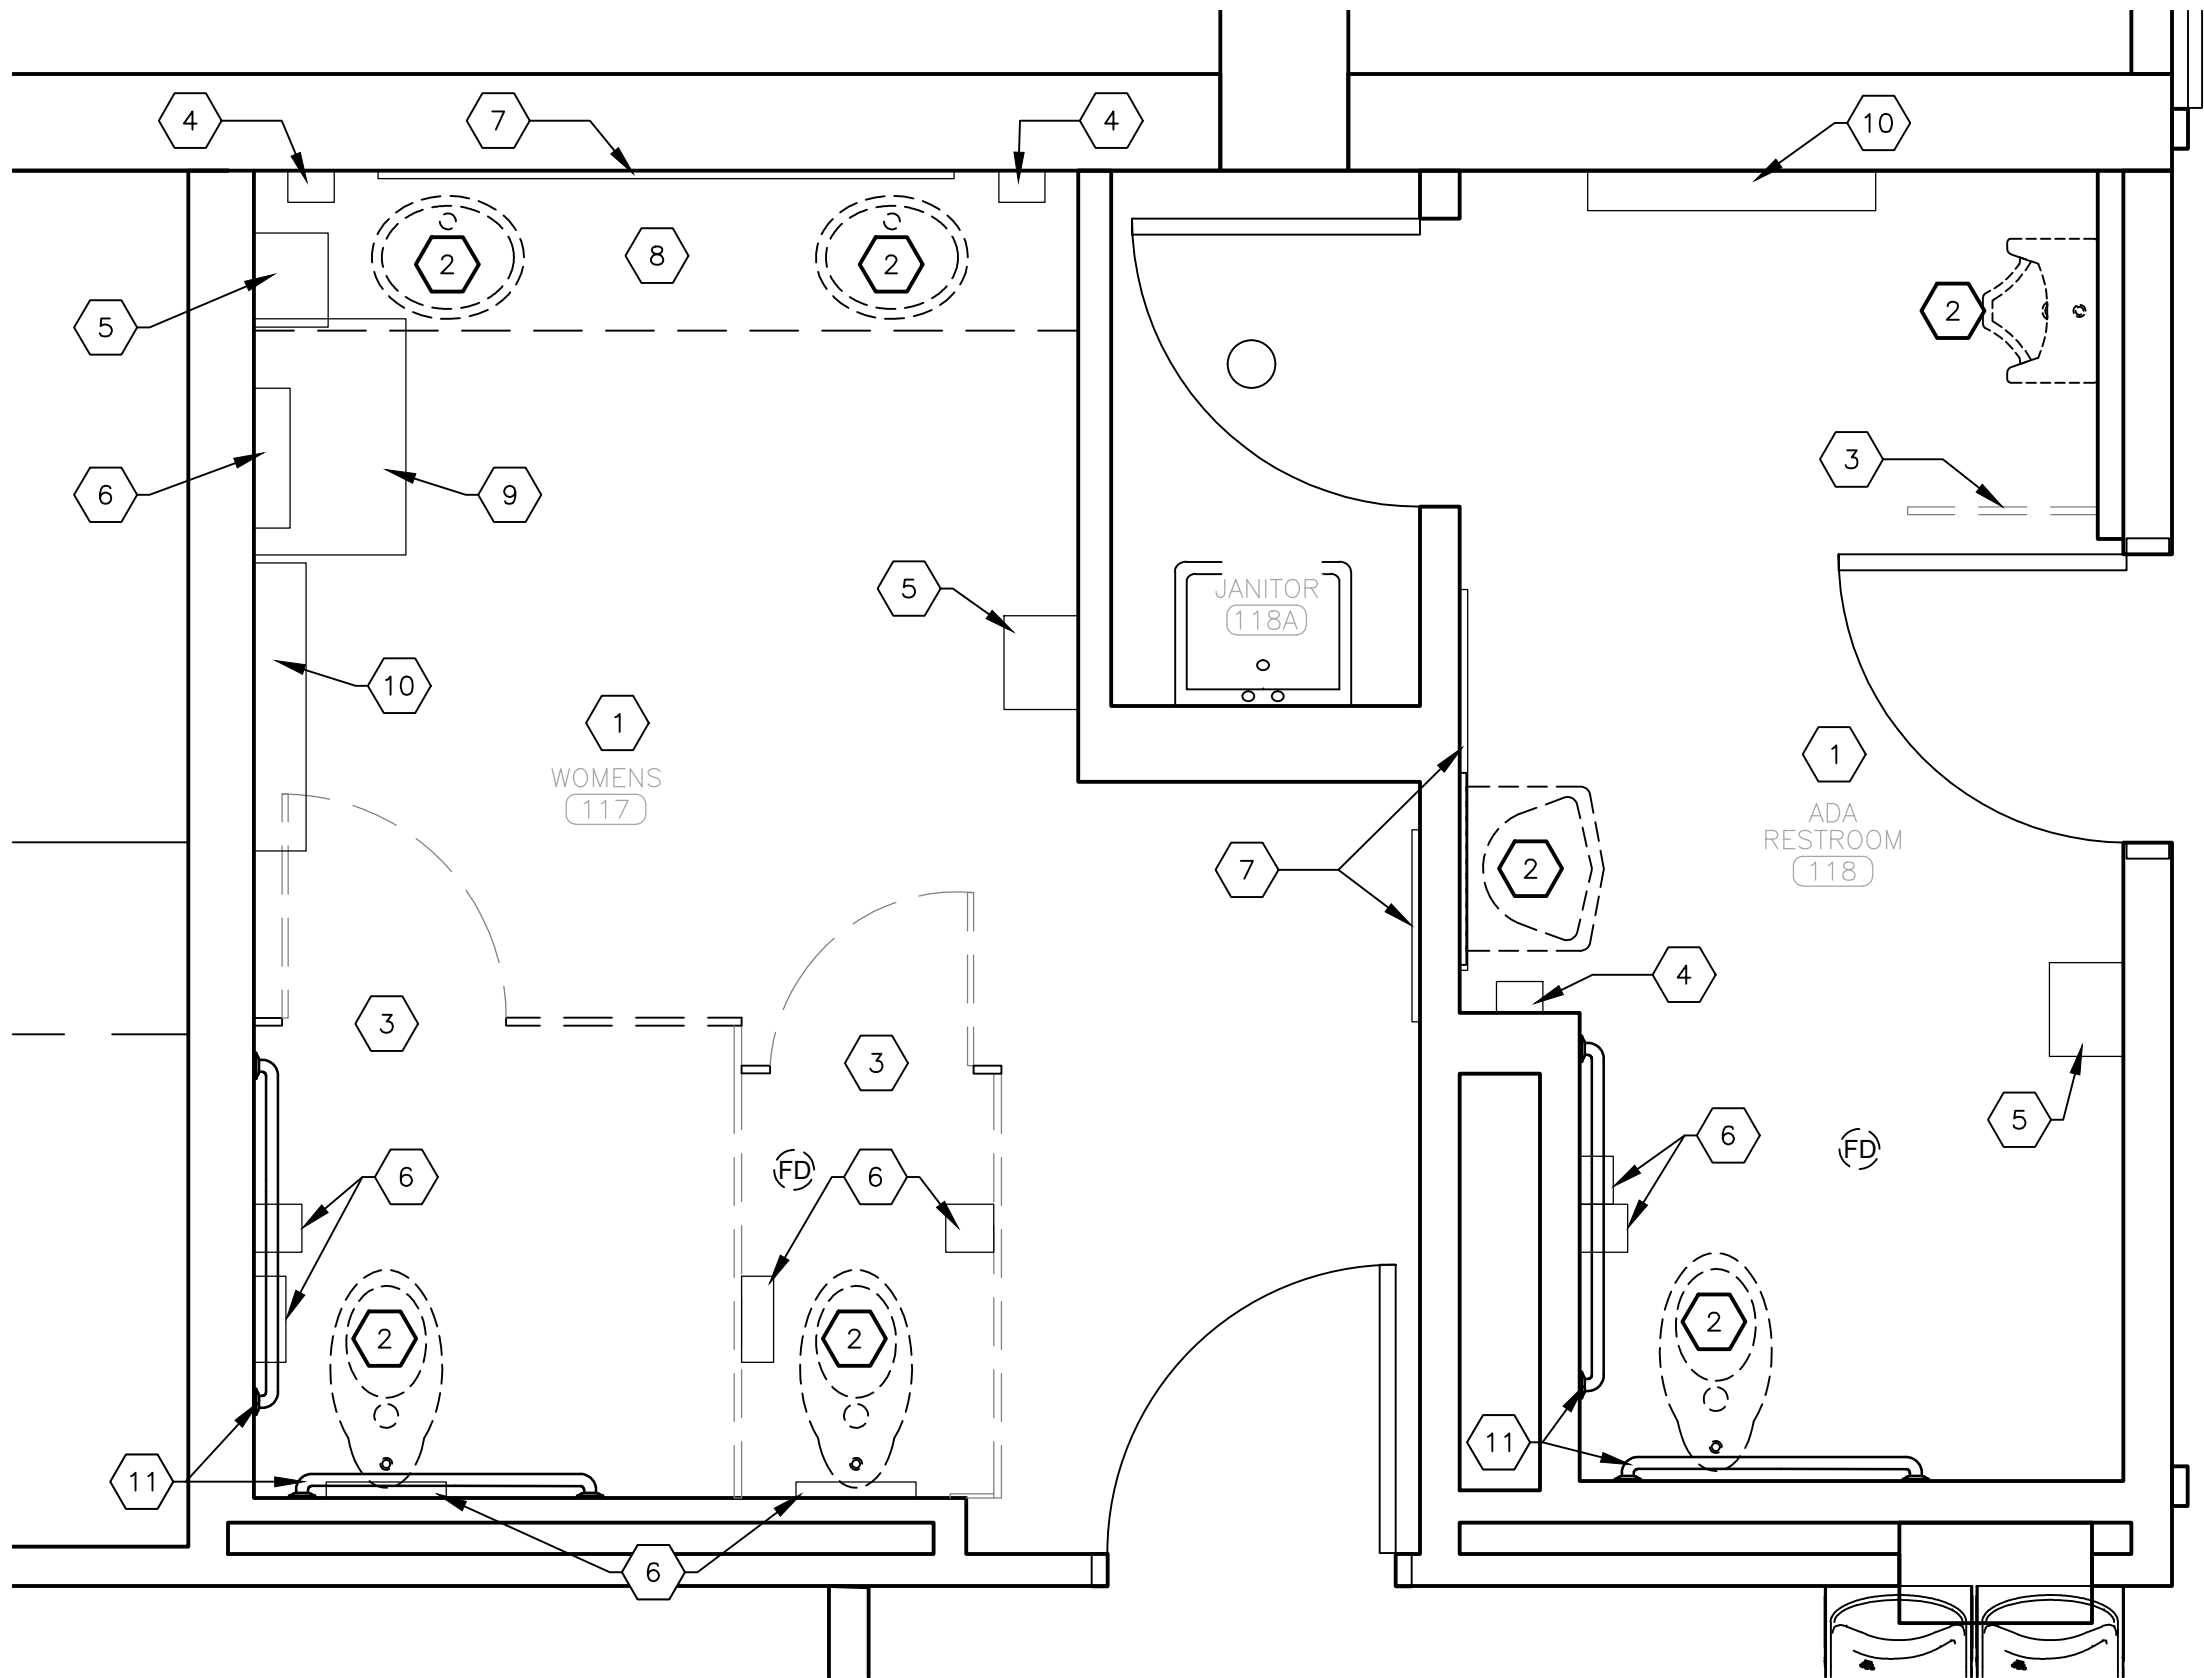

1 FIRST FLOOR RESTROOM DEMOLITION PLAN
SCALE: 1/2" = 1'-0"

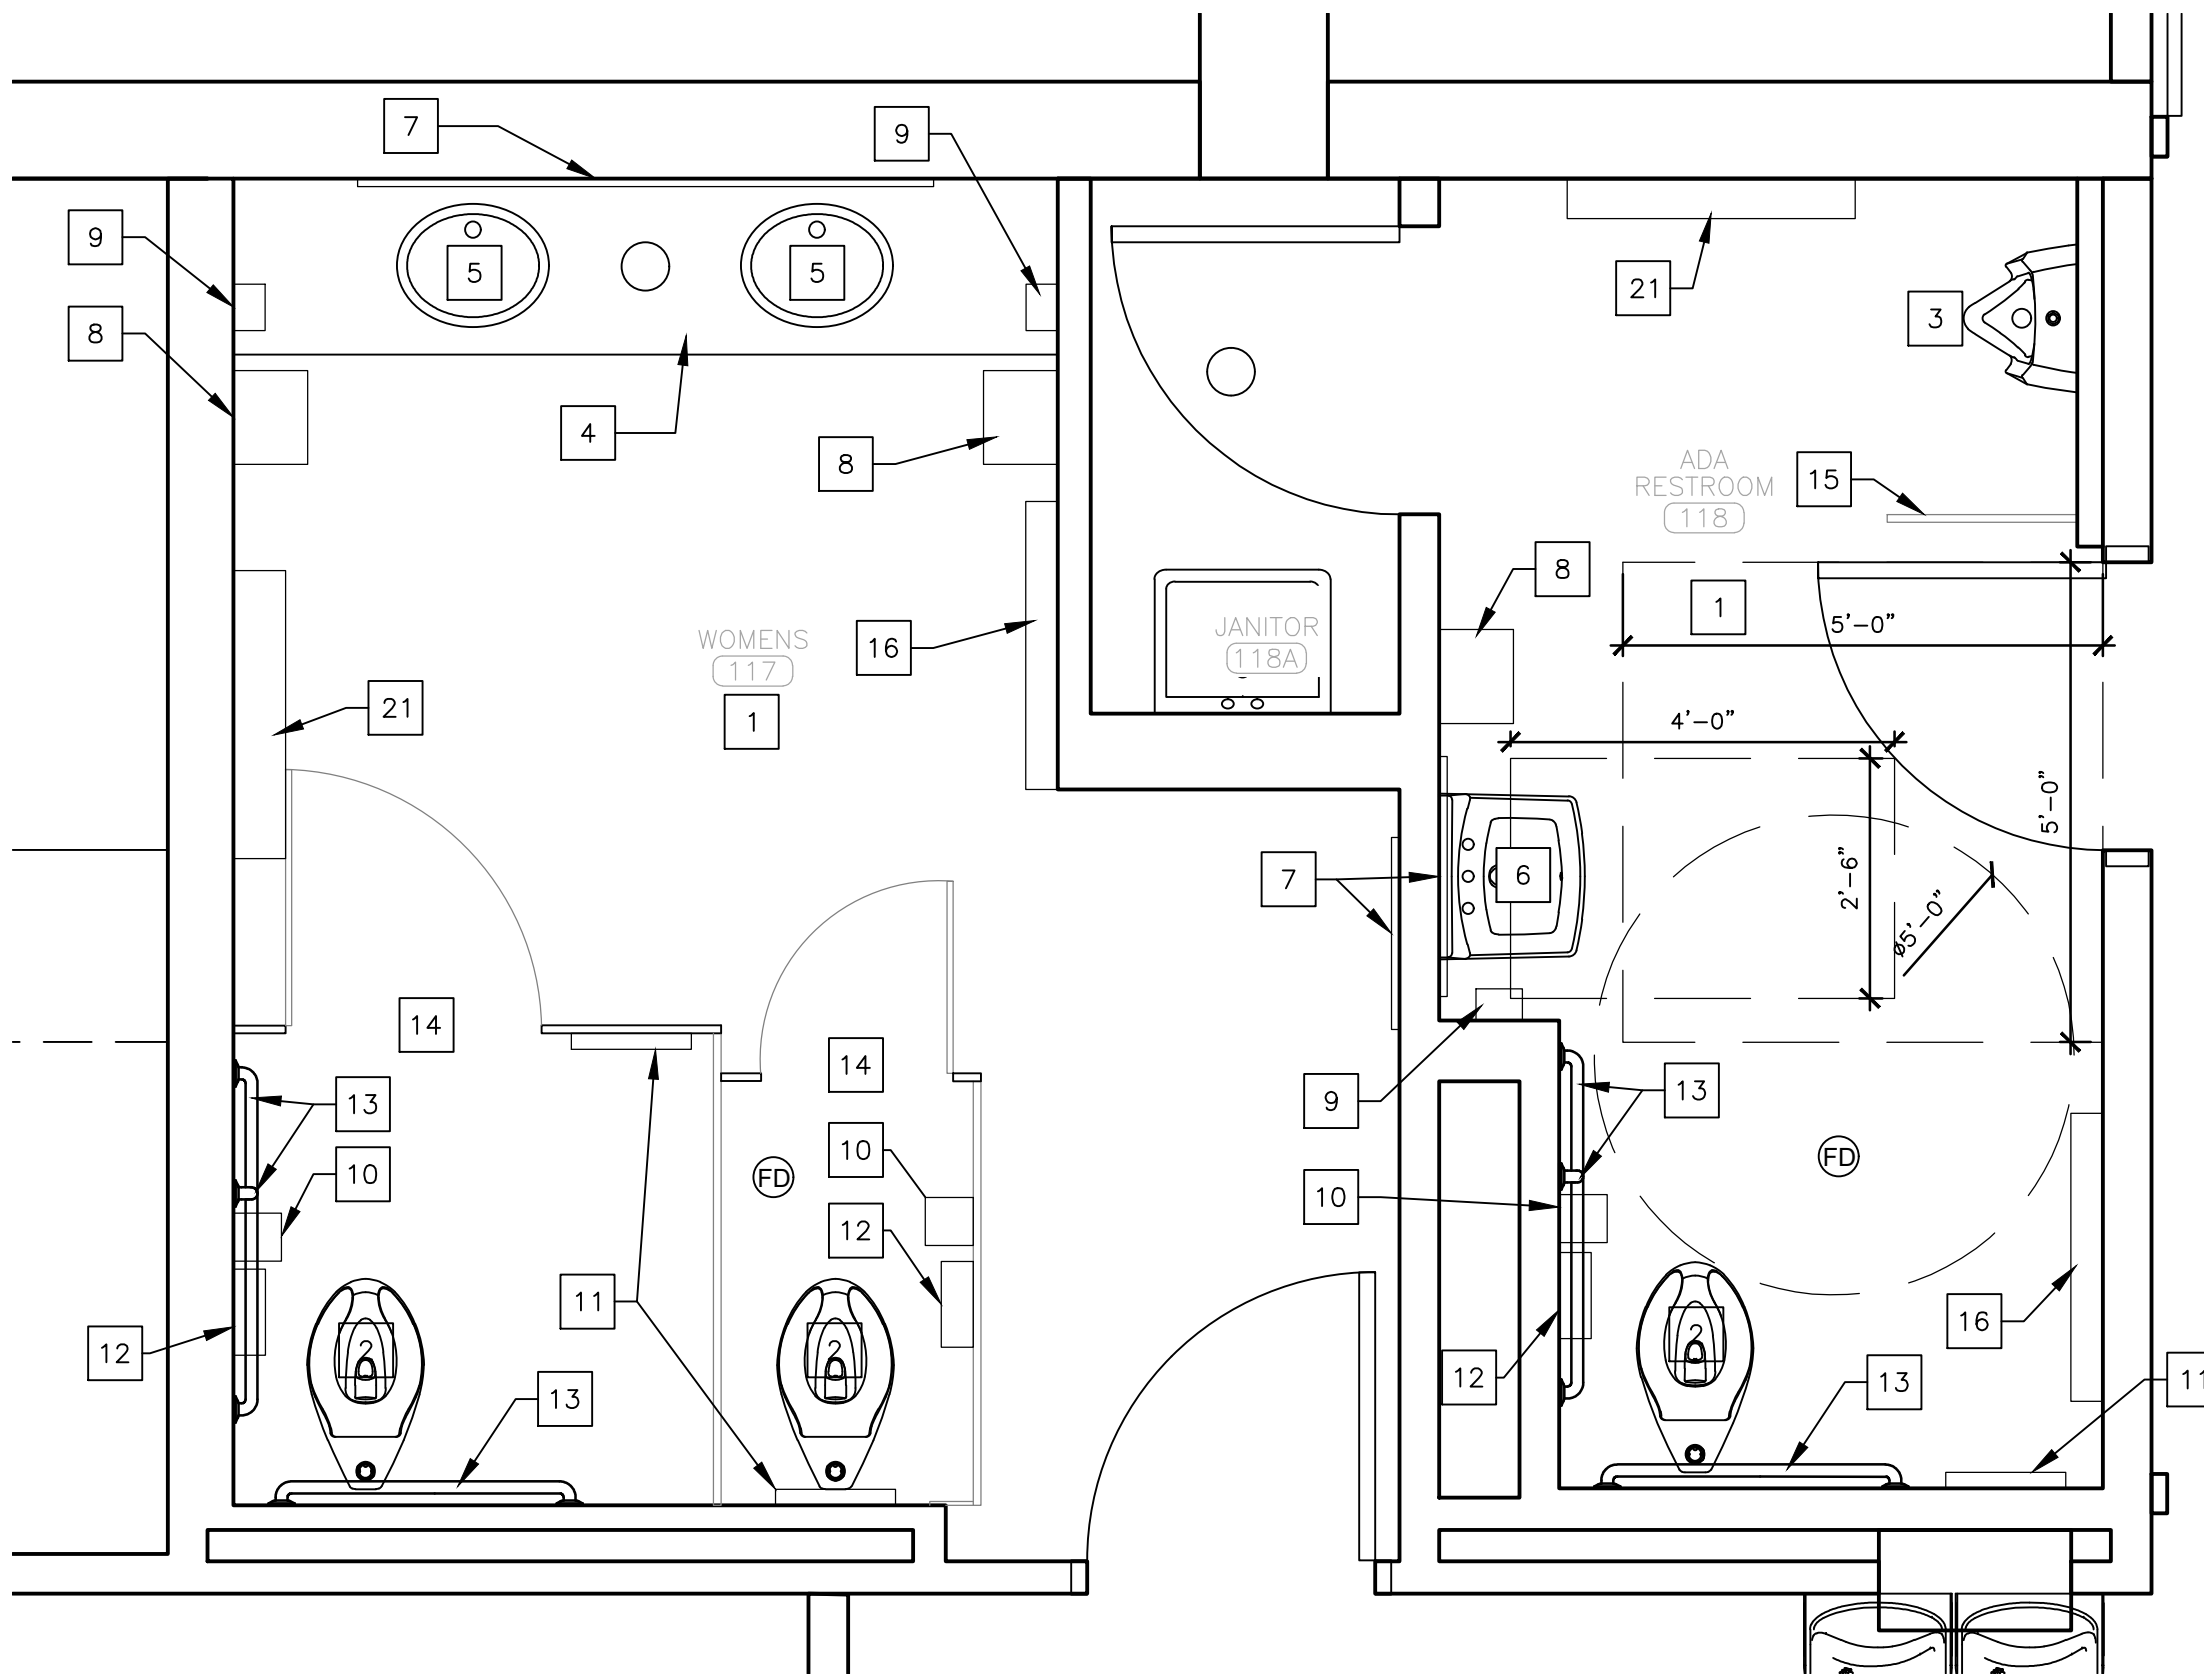


2 FIRST FLOOR RESTROOM RENOVATION PLAN
SCALE: 1/2" = 1'-0"

NOTE: REFER TO SHEET A-202 FOR PARTITION ELEVATIONS


- DEMOLITION KEYNOTES:**
- 1 REMOVE EXISTING CERAMIC WALL TILE TO FULL EXTENTS OF THE ROOM, AND PREPARE EXISTING SUBSTRATE FOR NEW WALL TILE APPLICATION.
 - 2 REMOVE EXISTING PLUMBING FIXTURES (LAVATORIES, TOILETS, URINALS). PREPARE EXISTING WALLS AND FLOORS FOR NEW FIXTURES. REFER TO PLUMBING DRAWINGS FOR DETAILS.
 - 3 REMOVE EXISTING TOILET PARTITIONS AND URINAL SCREENS. PATCH AND REPAIR WALL AND FLOORS. PREPARE FOR NEW PARTITIONS.
 - 4 REMOVE EXISTING SOAP DISPENSER AND SALVAGE FOR REUSE.
 - 5 REMOVE EXISTING PAPER TOWEL DISPENSER AND SALVAGE FOR REUSE.
 - 6 REMOVE EXISTING TOILET ACCESSORIES (TOILET PAPER DISPENSER, TOILET SEAT COVER DISPENSER, SANITARY NAPKIN DISPOSAL, SANITARY NAPKIN DISPENSER).
 - 7 REMOVE EXISTING MIRROR.
 - 8 REMOVE EXISTING BASE CABINETS AND COUNTERTOP.
 - 9 REMOVE EXISTING METAL CABINET.
 - 10 REFER TO M-101 FOR REMOVAL OF CONVECTOR.
 - 11 REMOVE EXISTING GRAB BARS.
 - 12 REMOVE CEILING TILES AND SUSPENDED CEILING GRID. RELINQUISH FULL AND UNDAMAGED CEILING TILES TO OWNER.
 - 13 REMOVE EXISTING CEILING MOUNTED LIGHT FIXTURES AND AIR DIFFUSERS. REFER TO MECHANICAL AND ELECTRICAL DRAWINGS FOR DETAILS.
 - 14 EXISTING SUPPORT STRUCTURE TO REMAIN FOR CEILING HUNG PARTITIONS. PROTECT FROM DAMAGE.

- RENOVATION KEYNOTES:**
- 1 INSTALL NEW CERAMIC WALL TILE, TO FULL EXTENTS OF ROOM.
 - 2 INSTALL NEW WATER CLOSET. REFER TO PLUMBING DRAWINGS FOR DETAILS.
 - 3 INSTALL NEW URINAL. REFER TO PLUMBING DRAWINGS FOR DETAILS.
 - 4 INSTALL NEW SOLID SURFACE COUNTERTOP WITH CIRCULAR WASTE CHUTE CENTERED BETWEEN LAVATORIES. REFER TO A-501 FOR DETAILS.
 - 5 INSTALL NEW UNDERMOUNT SINK AND FAUCET. REFER TO PLUMBING DRAWINGS FOR DETAILS.
 - 6 INSTALL NEW WALL MOUNT SINK AND FAUCET. REFER TO PLUMBING DRAWINGS FOR DETAILS.
 - 7 INSTALL NEW MIRROR.
 - 8 REINSTALL PAPER TOWEL DISPENSER.
 - 9 REINSTALL SOAP DISPENSER.
 - 10 INSTALL NEW TOILET PAPER DISPENSER.
 - 11 INSTALL NEW TOILET SEAT COVER DISPENSER.
 - 12 INSTALL NEW SANITARY NAPKIN DISPOSAL.
 - 13 INSTALL NEW GRAB BARS.
 - 14 INSTALL NEW CEILING HUNG TOILET PARTITION. ENSURE ADEQUATE FRAMING ABOVE CEILING TO SUPPORT PARTITIONS.
 - 15 INSTALL NEW WALL MOUNT URINAL PARTITION.
 - 16 INSTALL CUSTOM SOLID SURFACE SHELF WITH UNDERMOUNT STAINLESS STEEL HOOKS. REFER TO A-501 FOR DETAILS.
 - 17 INSTALL NEW 2'x2' SUSPENDED CEILING GRID AND ACOUSTIC CEILING TILE.
 - 18 INSTALL NEW SUSPENDED DRYWALL FRAMING SYSTEM FOR DRYWALL SOFFIT. PROVIDE LEVEL 4 FINISH AND PAINT.
 - 19 INSTALL NEW CEILING AIR DIFFUSERS. REFER TO MECHANICAL DRAWINGS FOR DETAILS.
 - 20 INSTALL NEW CEILING LIGHT FIXTURES. REFER TO ELECTRICAL DRAWINGS FOR DETAILS.
 - 21 REFER TO M-102 FOR INSTALLATION OF CONVECTOR. TILE AROUND EXISTING FLOOR PENETRATIONS.
 - 22 EXISTING STEEL BEAM ABOVE CEILING TO REMAIN. MOUNT NEW PARTITIONS TO BEAM.

LEGEND	
	CEILING HEIGHT TAG
	FLOOR DRAIN - DEMO
	FLOOR DRAIN - NEW
	DRYWALL CEILING
	RECESSED CAN LIGHT

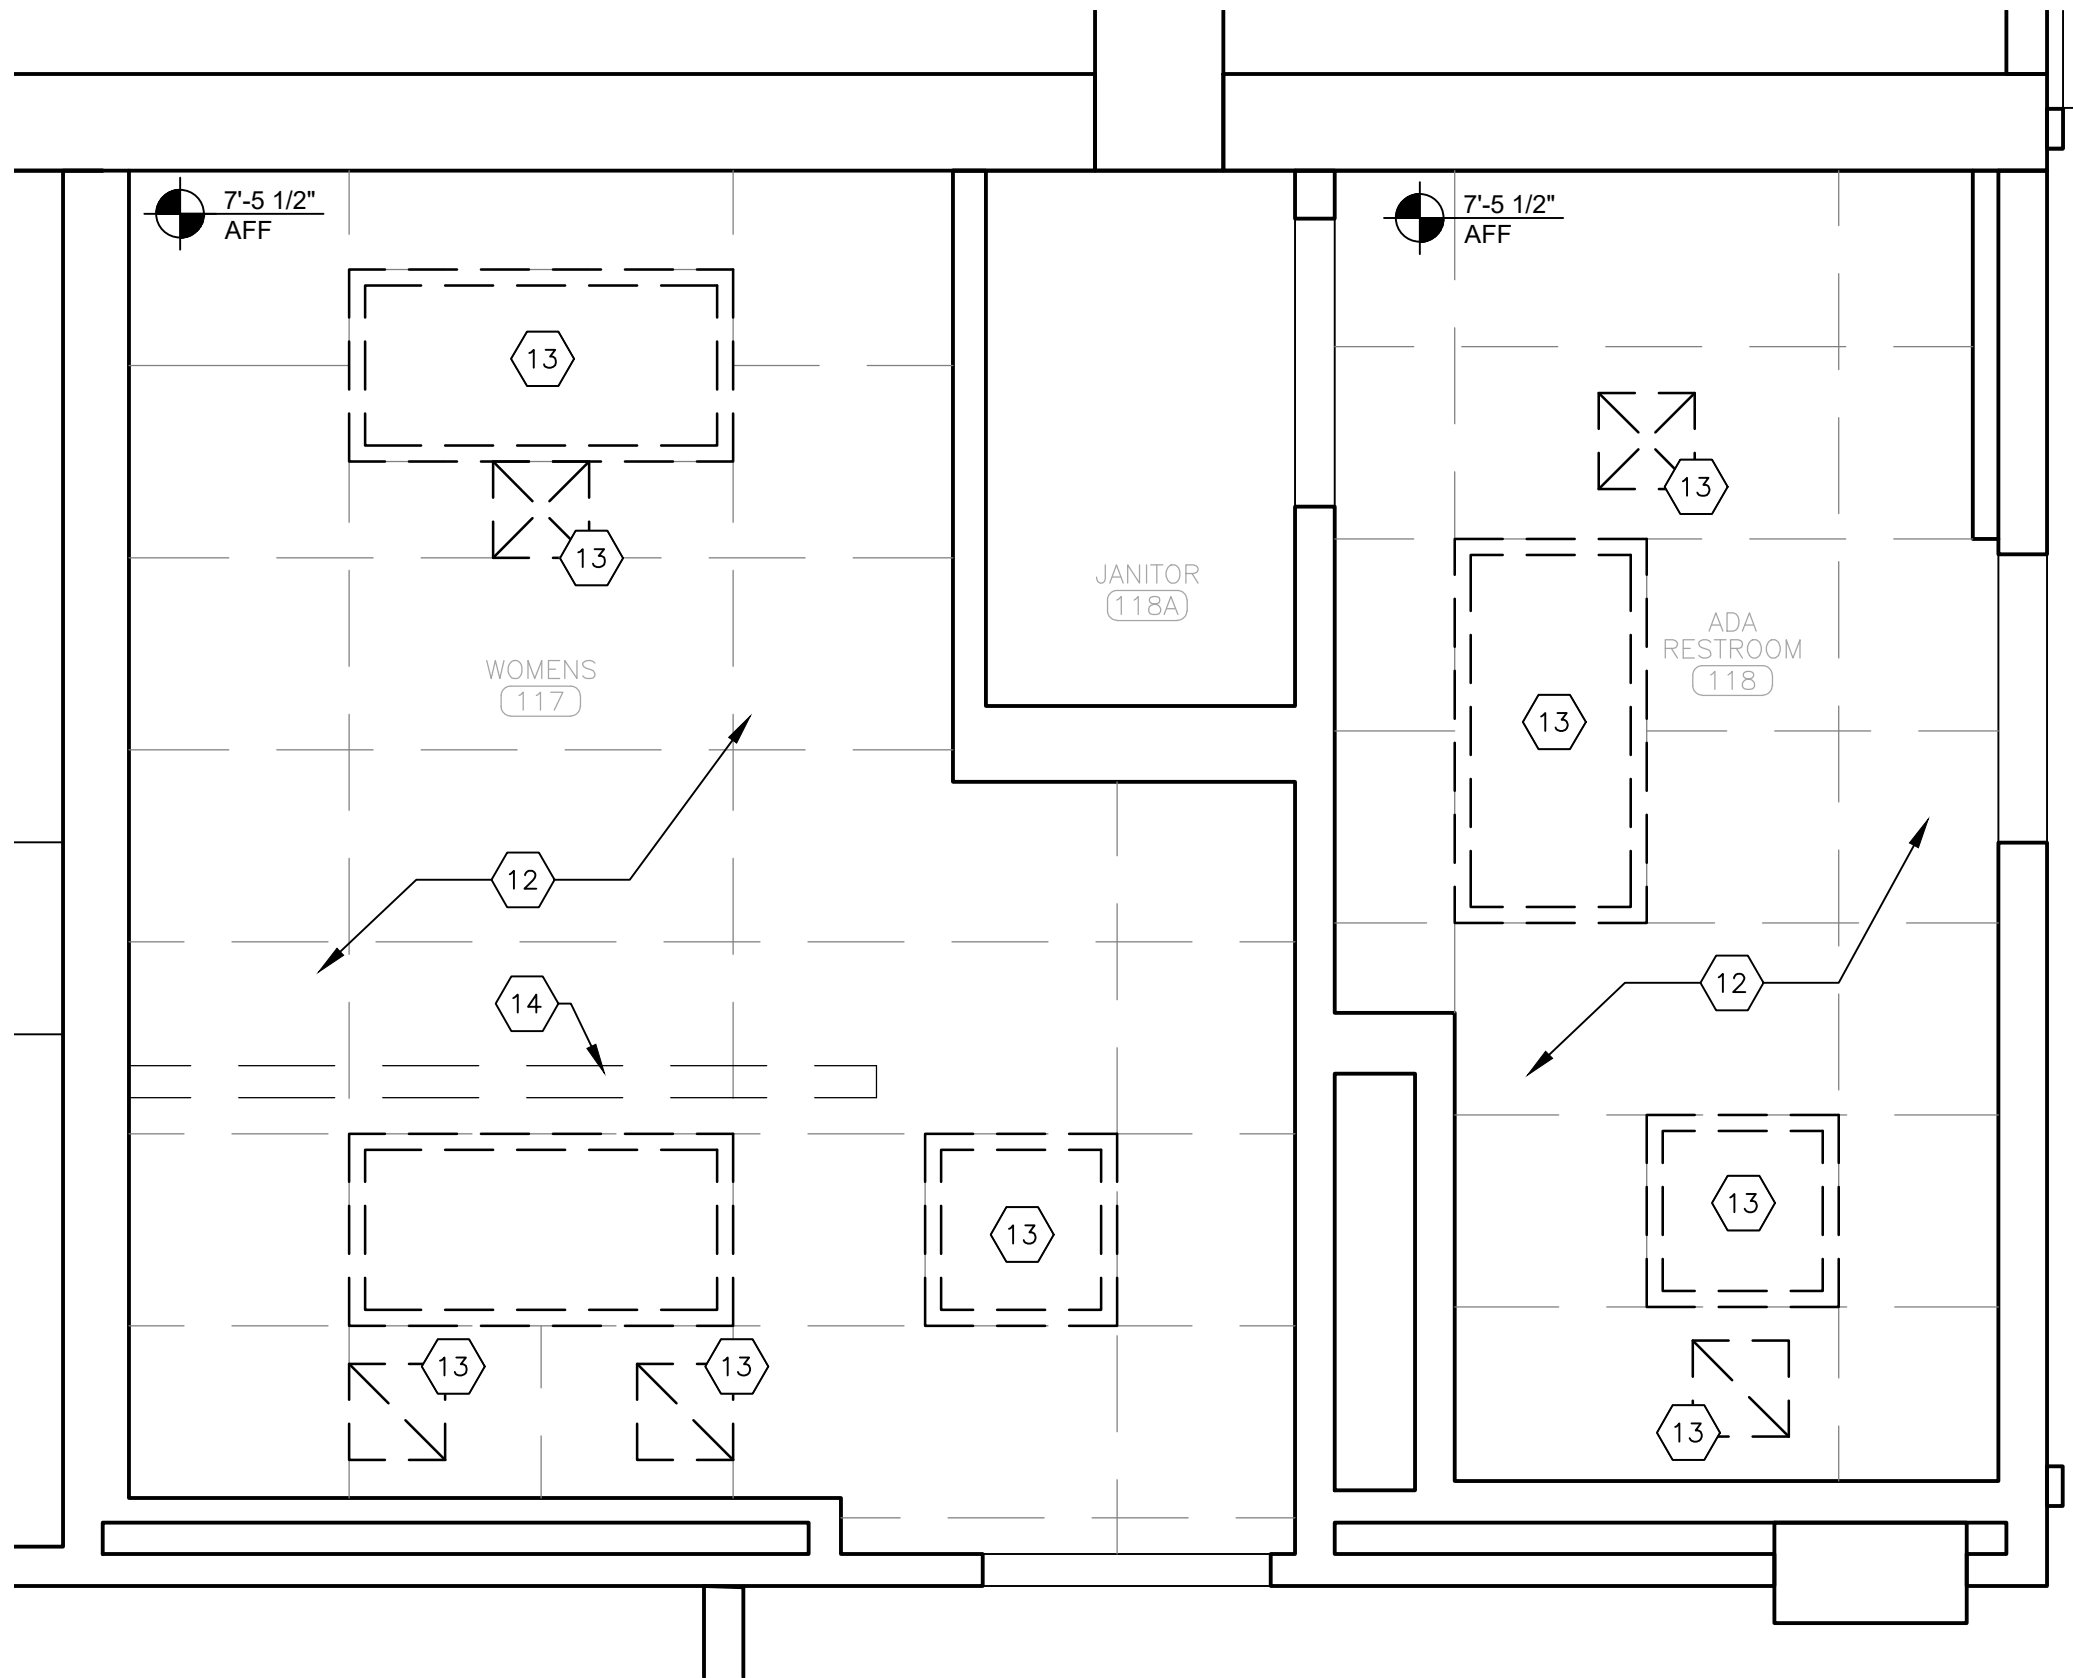


3 FIRST FLOOR RESTROOM DEMOLITION REFLECTED CEILING PLAN
SCALE: 1/2" = 1'-0"

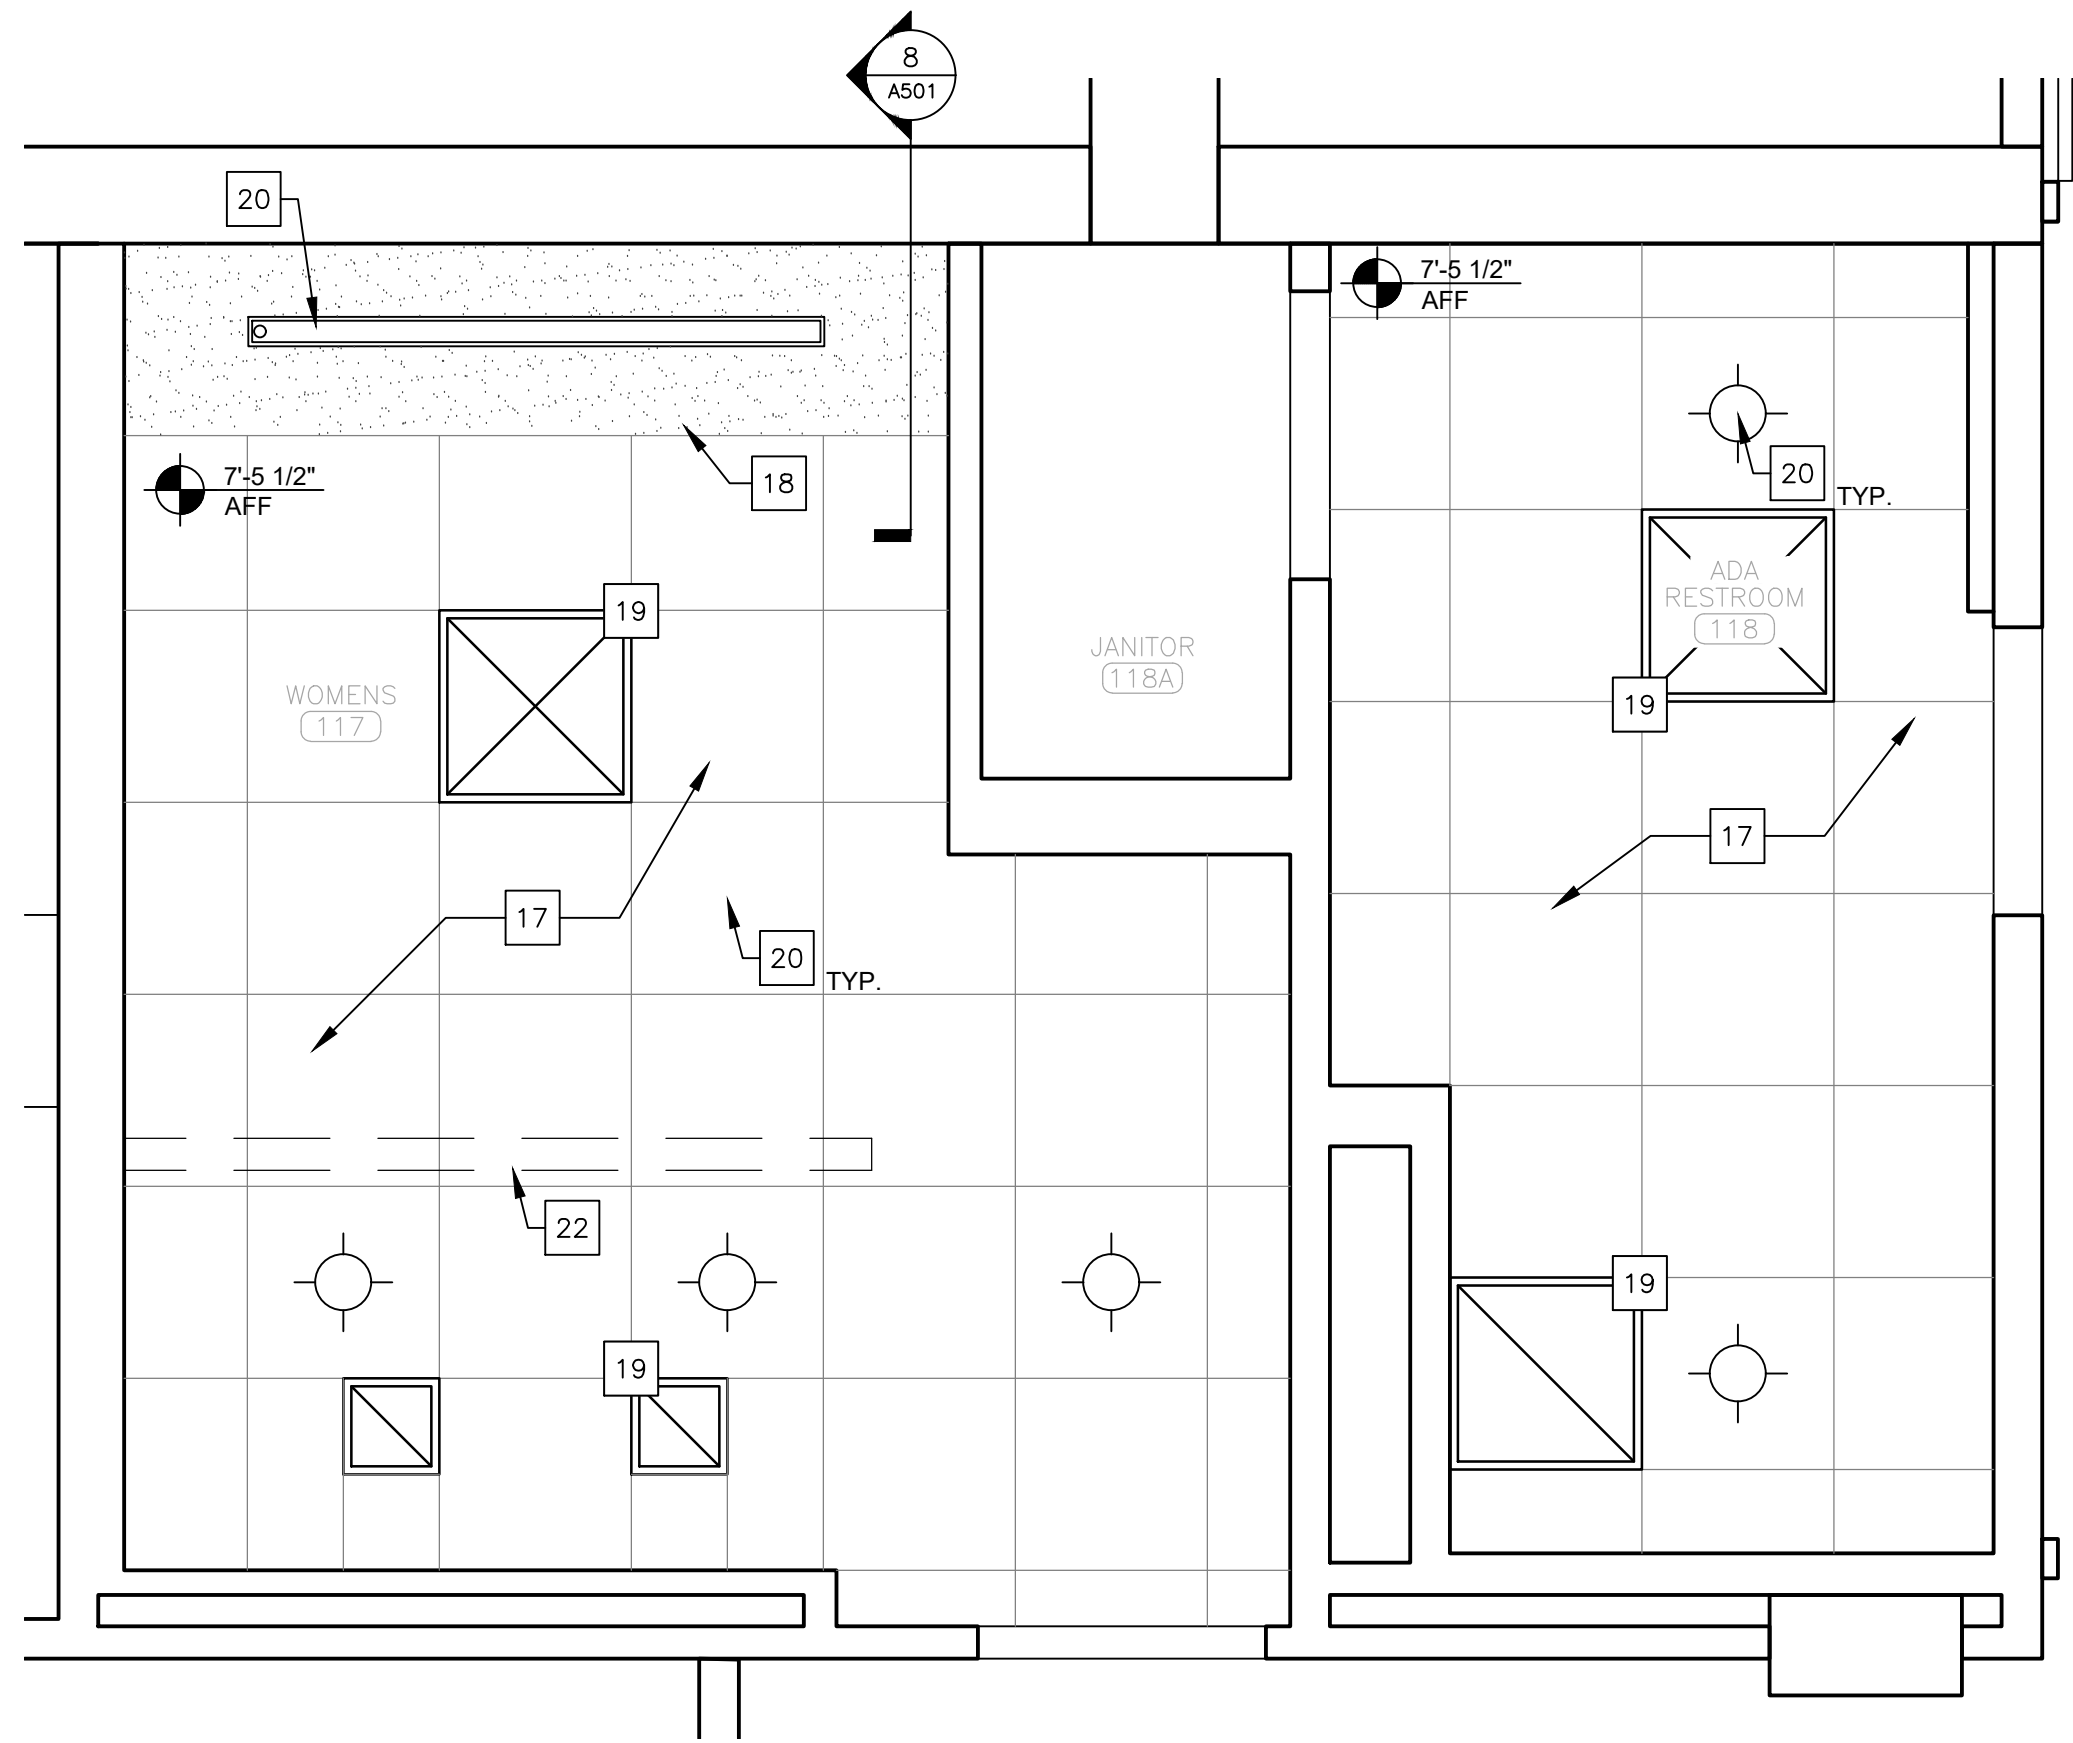

4 FIRST FLOOR RESTROOM RENOVATION REFLECTED CEILING PLAN
SCALE: 1/2" = 1'-0"

STATE OF MISSOURI
MIKE KEHOE,
GOVERNOR

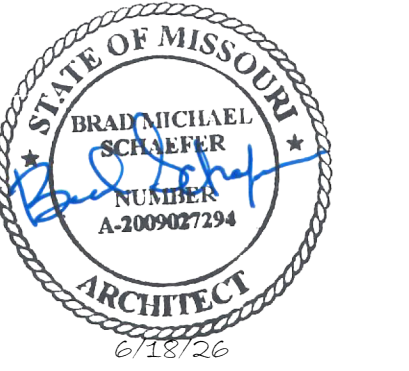

Brad M. Schaefer - Architect
MO# A-2009027294

BID DOCUMENTS

OFFICE OF ADMINISTRATION
DIVISION OF FACILITIES
MANAGEMENT,
DESIGN AND CONSTRUCTION

DEPARTMENT OF
PUBLIC SAFETY
STATE HIGHWAY PATROL

RENOVATE INTERIOR

GENERAL HEADQUARTERS
1510 EAST ELM STREET
JEFFERSON CITY, MO 65101

PROJECT # R2410-01
SITE # 6001
ASSET # 8136001001

REVISION: _____
DATE: _____
REVISION: _____
DATE: _____
REVISION: _____
DATE: _____
ISSUE DATE: 06/18/2026

CAD DWG FILE: _____
DRAWN BY: RG/CL
CHECKED BY: BMS
DESIGNED BY: CL

SHEET TITLE:
FIRST FLOOR
RESTROOM
ENLARGED PLANS

SHEET NUMBER:

A-402

13 OF 39 SHEETS
06/18/2026



Brad M. Schaefer - Architect
MO# A-2009027294

BID DOCUMENTS

OFFICE OF ADMINISTRATION
DIVISION OF FACILITIES
MANAGEMENT,
DESIGN AND CONSTRUCTION

DEPARTMENT OF
PUBLIC SAFETY
STATE HIGHWAY PATROL

RENOVATE INTERIOR

GENERAL HEADQUARTERS
1510 EAST ELM STREET
JEFFERSON CITY, MO 65101

PROJECT # R2410-01
SITE # 6001
ASSET # 8136001001

REVISION: _____
DATE: _____
REVISION: _____
DATE: _____
REVISION: _____
DATE: _____
ISSUE DATE: 06/18/2026


CAD DWG FILE: _____
DRAWN BY: RG/CL
CHECKED BY: BMS
DESIGNED BY: CL

SHEET TITLE:
FIRST FLOOR
RESTROOM
ENLARGED PLANS


SHEET NUMBER:

A-403


14 OF 39 SHEETS
06/18/2026

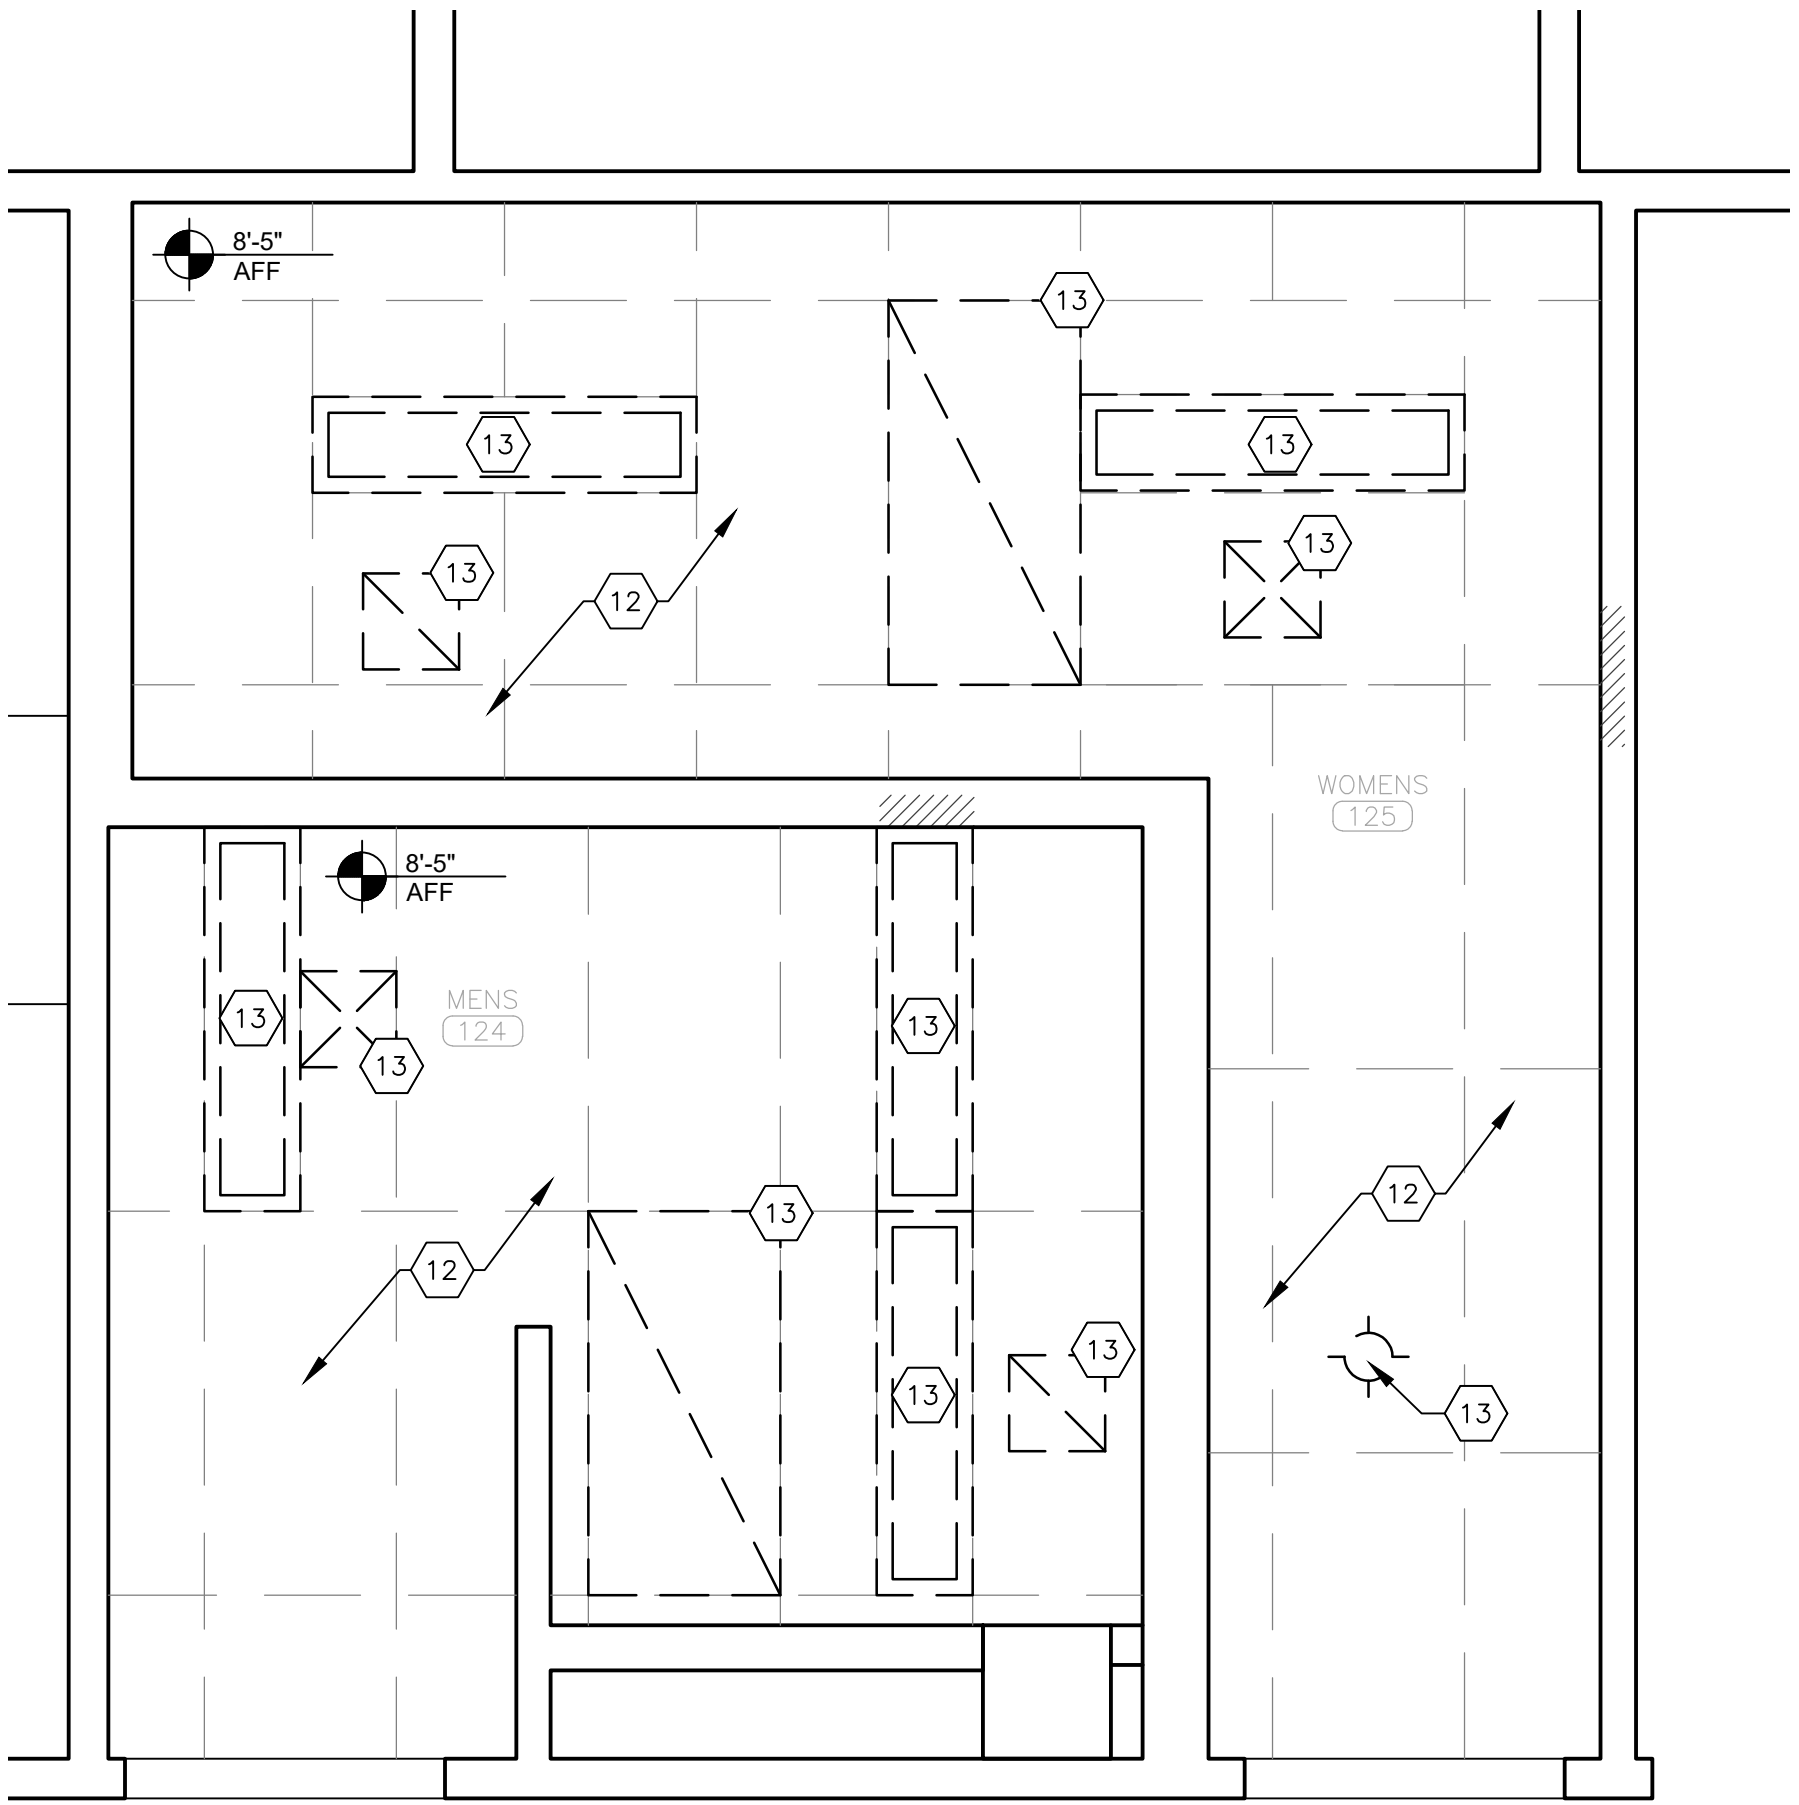


3 FIRST FLOOR RESTROOM DEMOLITION REFLECTED CEILING PLAN
SCALE: 1/2" = 1'-0"

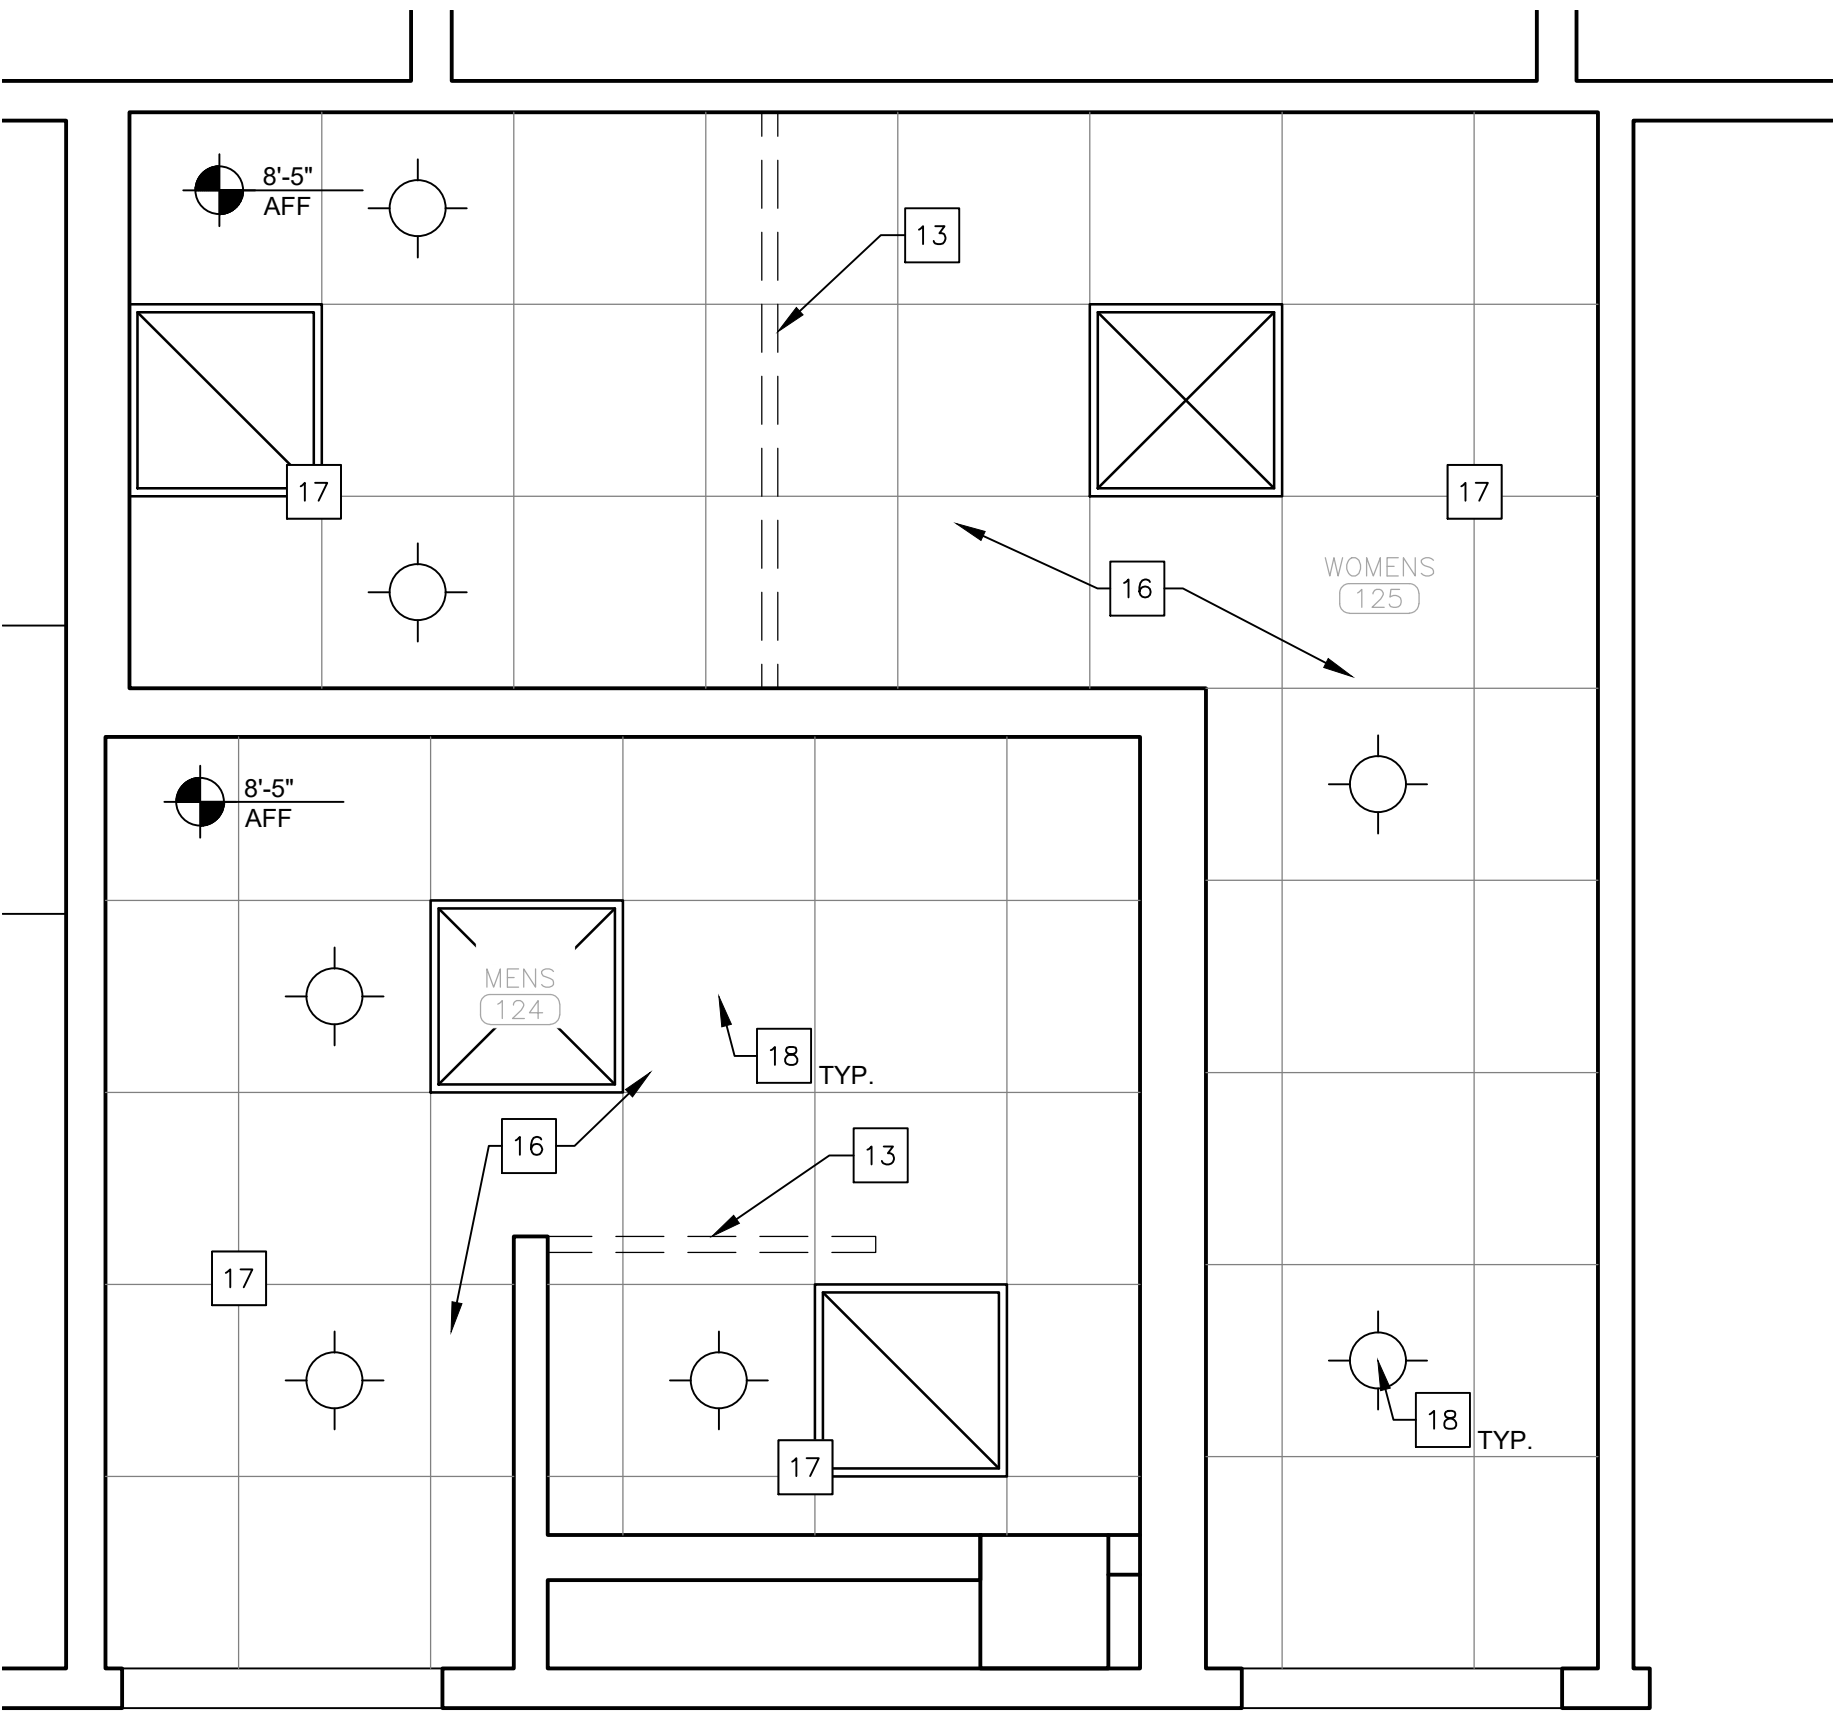

4 FIRST FLOOR RESTROOM RENOVATION REFLECTED CEILING PLAN
SCALE: 1/2" = 1'-0"

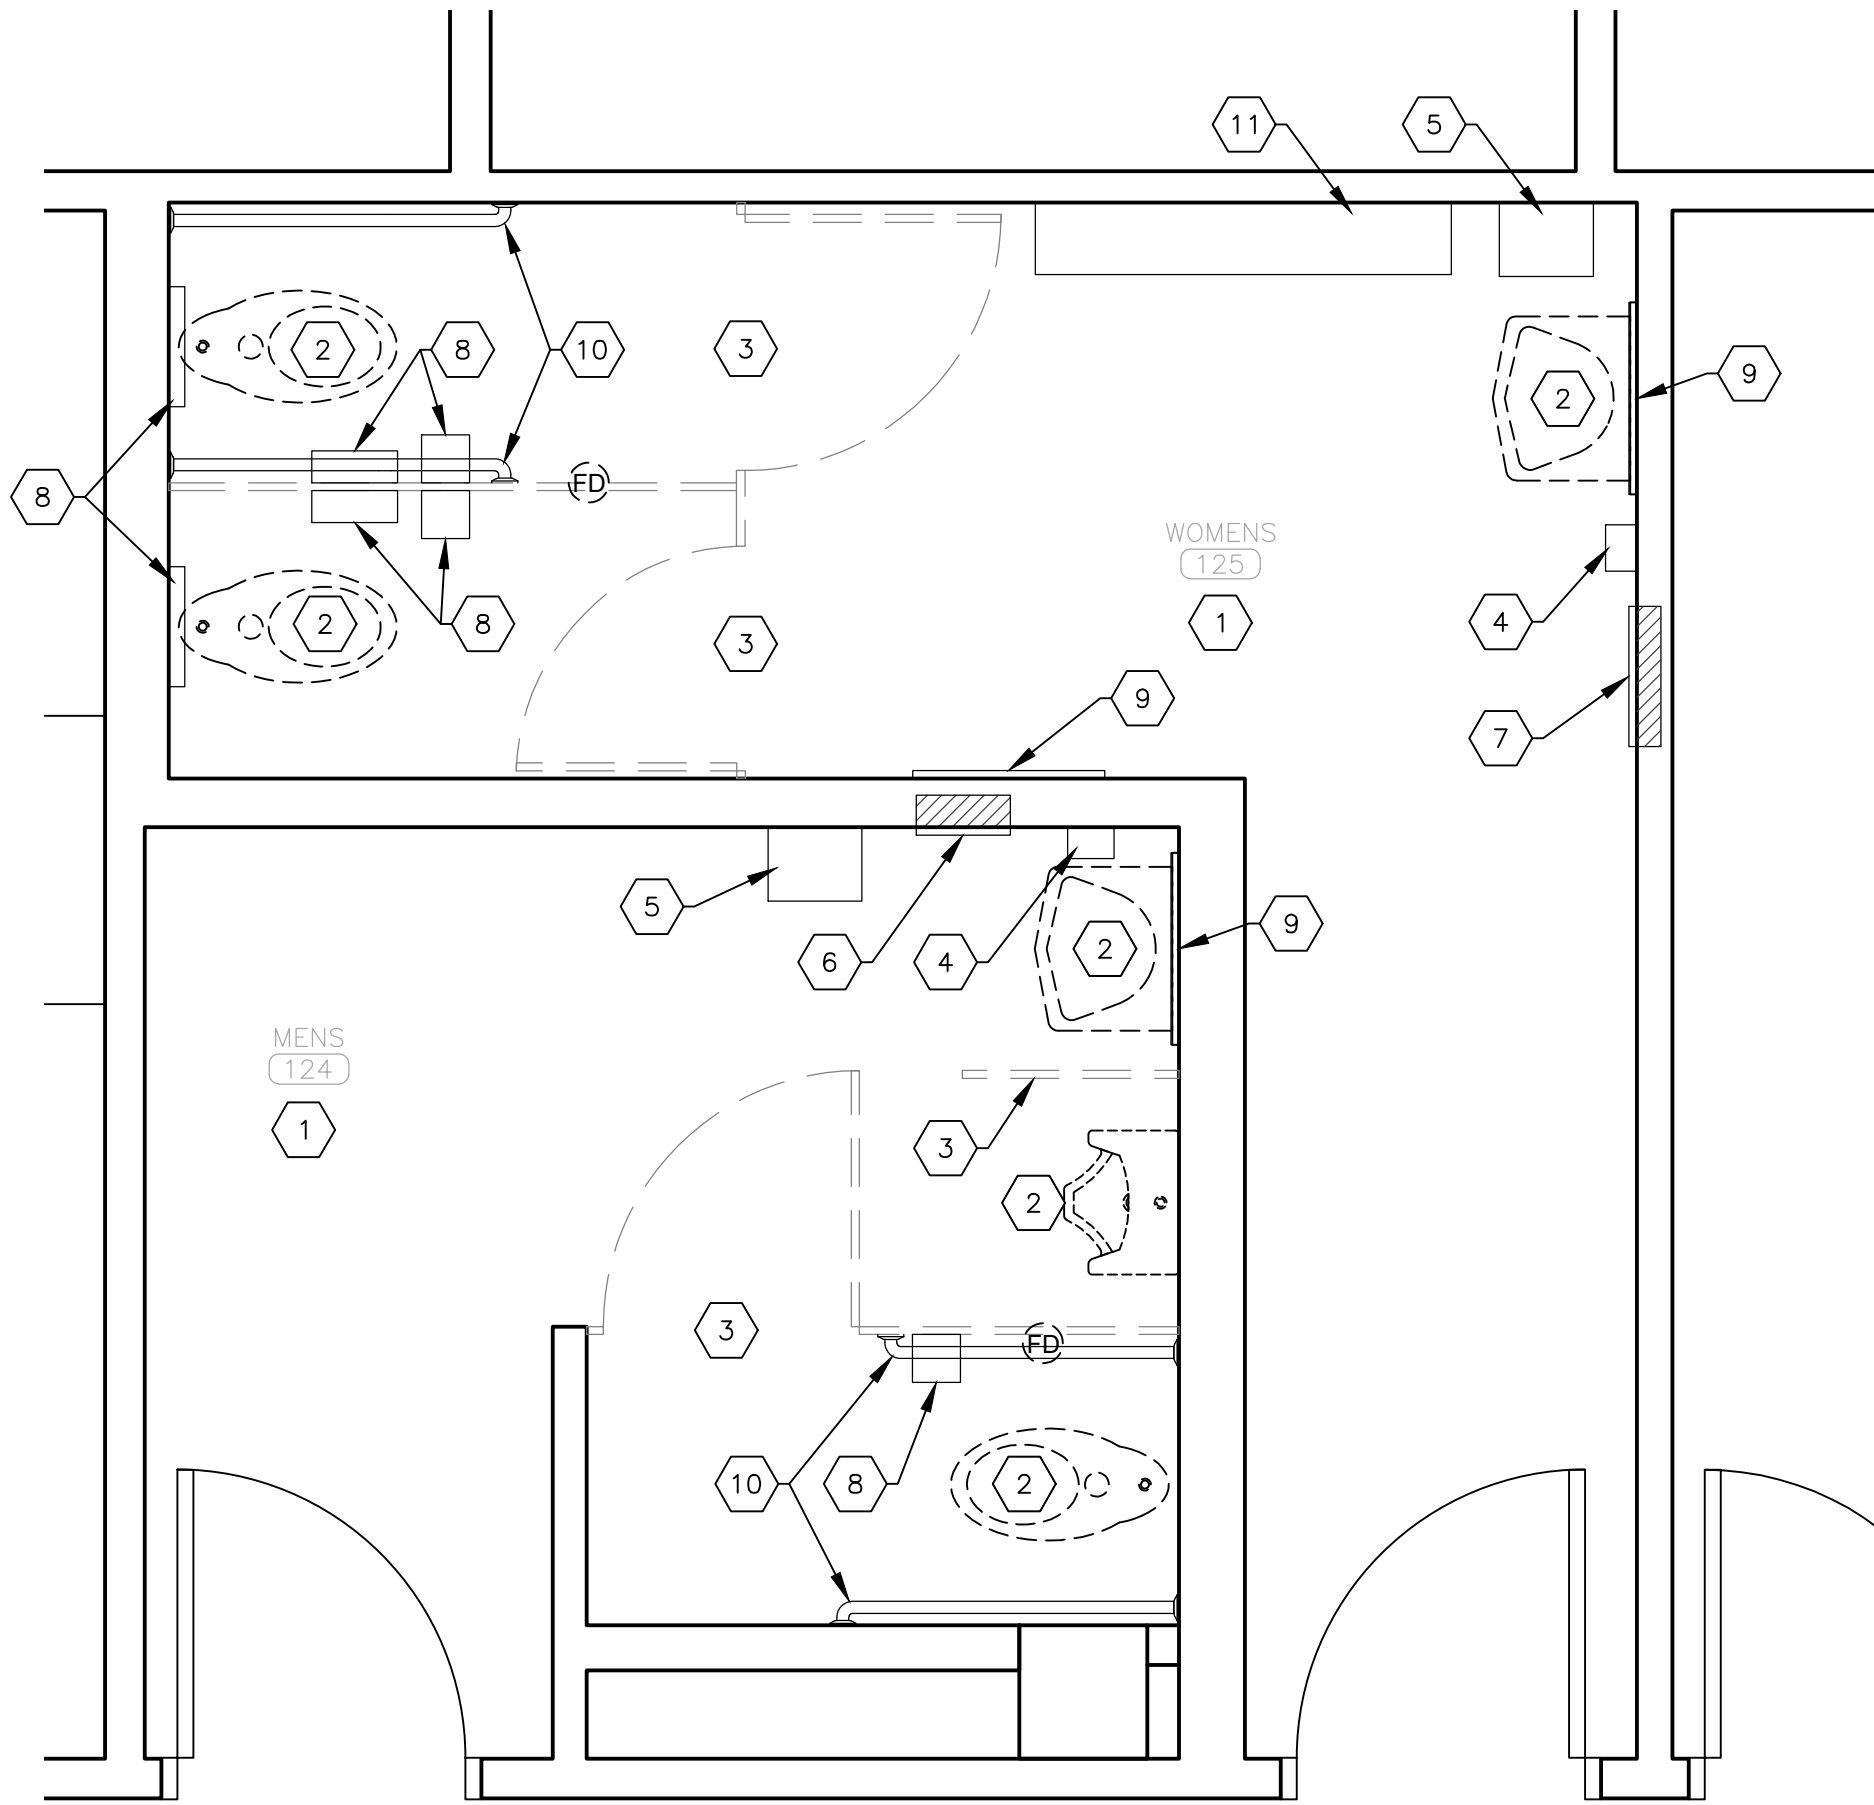

1 FIRST FLOOR RESTROOM DEMOLITION PLAN
SCALE: 1/2" = 1'-0"

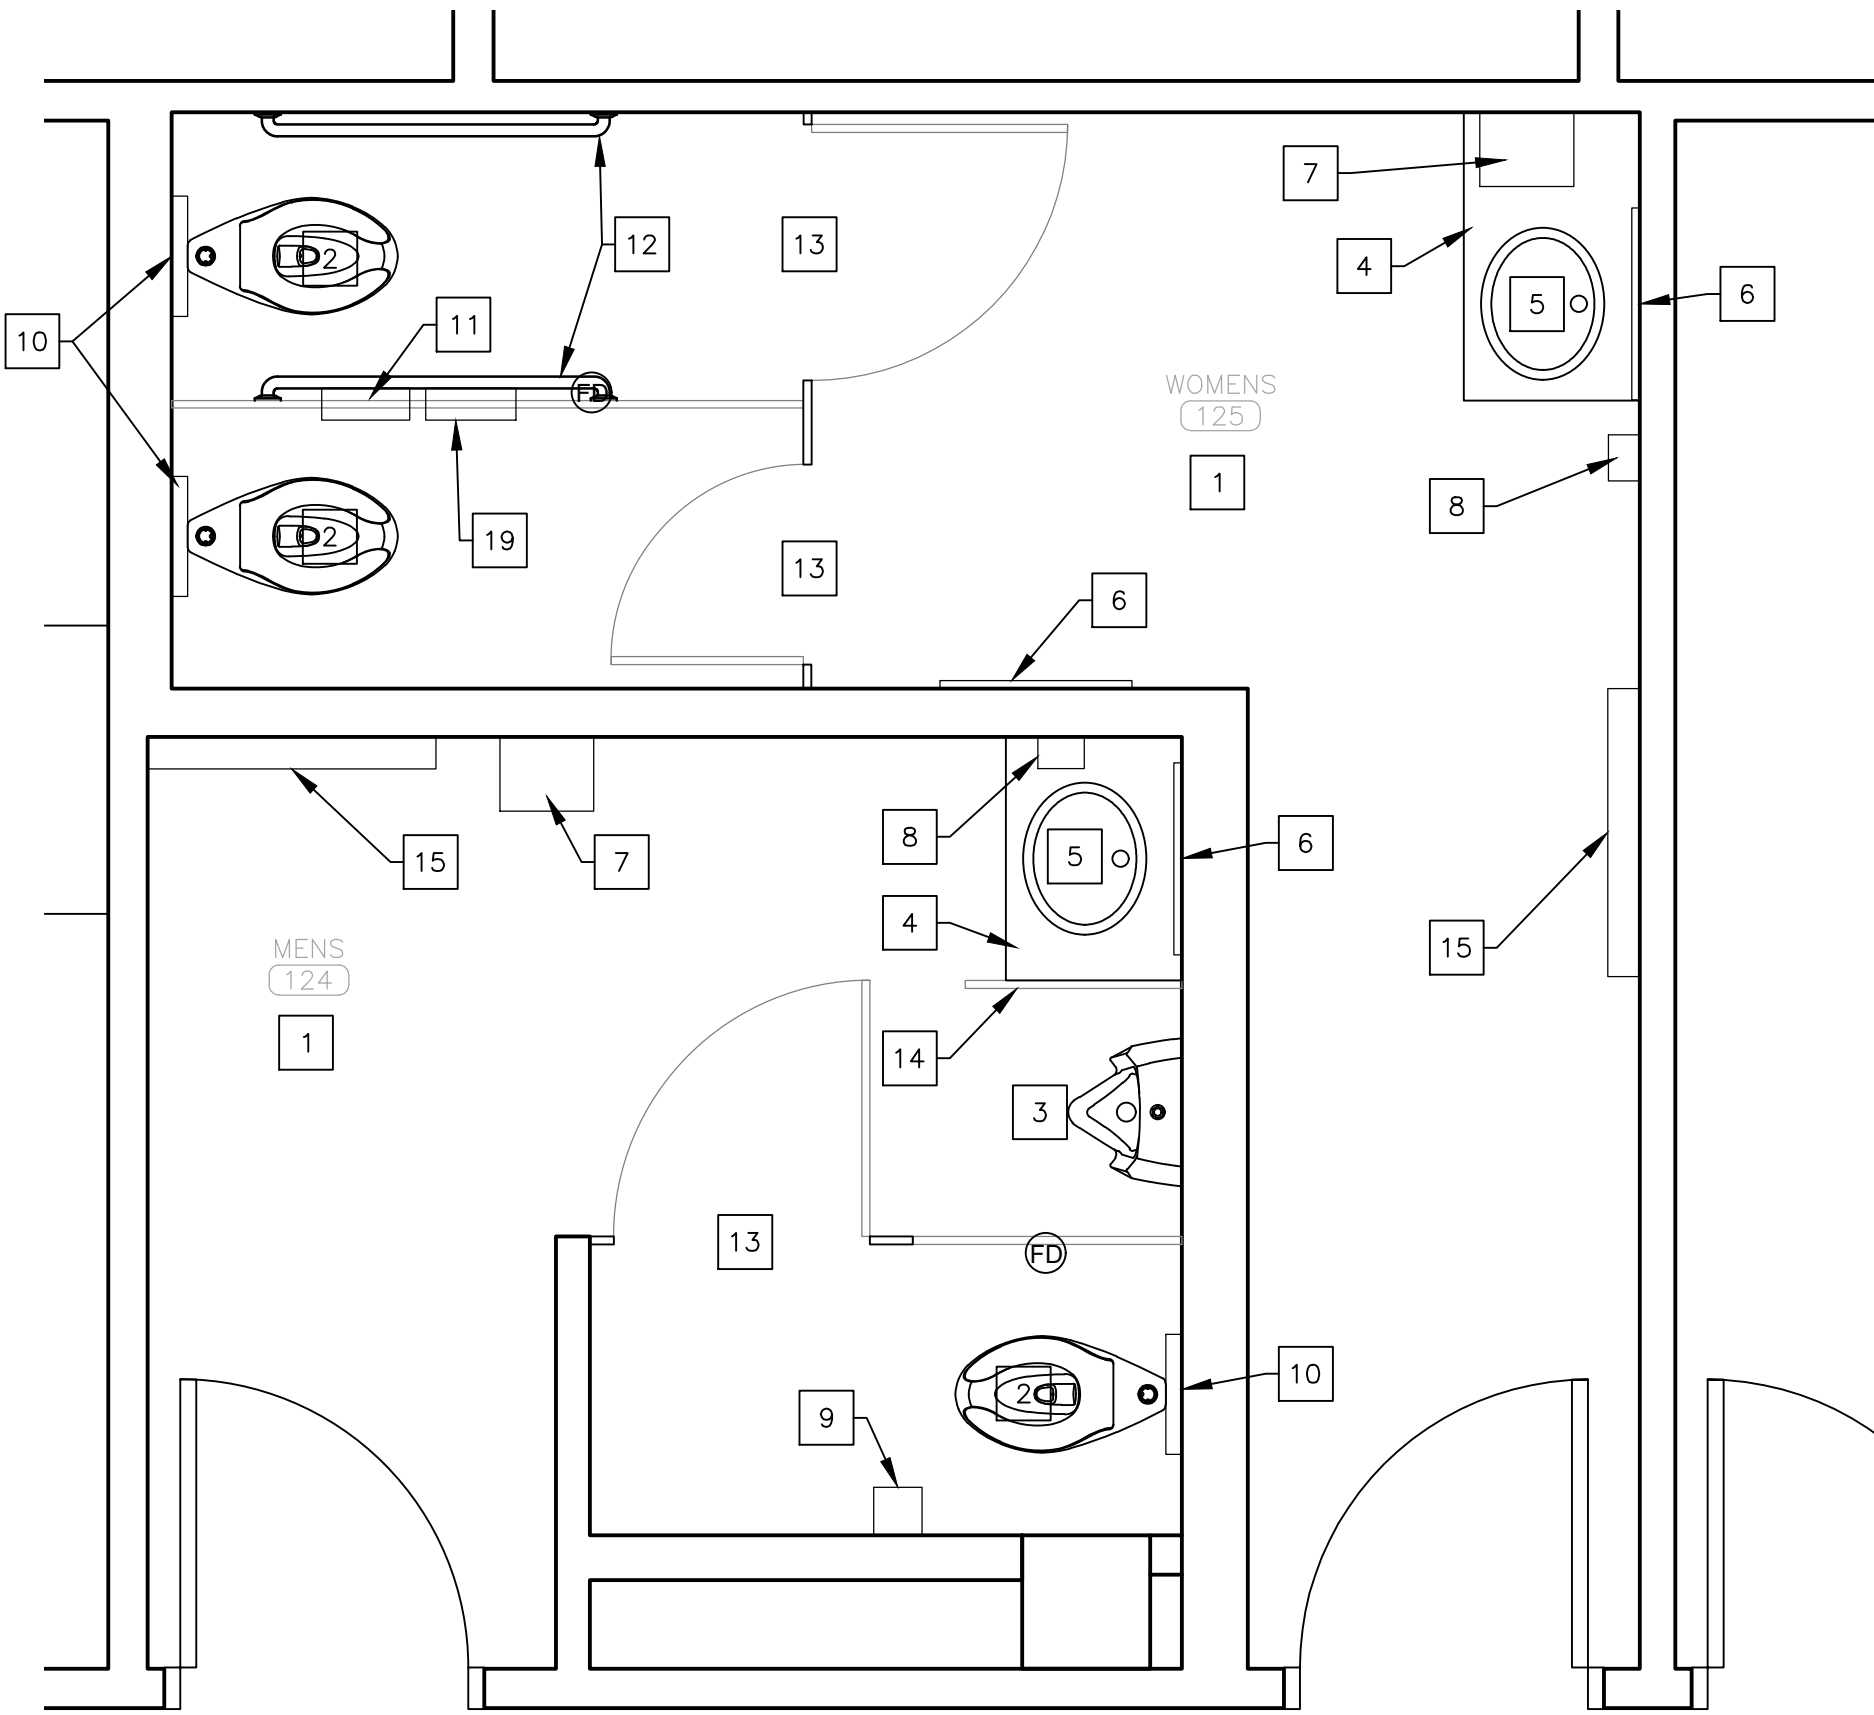


2 FIRST FLOOR RESTROOM RENOVATION PLAN
SCALE: 1/2" = 1'-0"

NOTE: REFER TO SHEET A-203 FOR PARTITION ELEVATIONS


- DEMOLITION KEYNOTES:**
- 1 REMOVE EXISTING CERAMIC WALL TILE TO FULL EXTENTS OF THE ROOM, AND PREPARE EXISTING SUBSTRATE FOR NEW WALL TILE APPLICATION.
 - 2 REMOVE EXISTING PLUMBING FIXTURES (LAVATORIES, TOILETS, URINALS). PREPARE EXISTING WALLS AND FLOORS FOR NEW FIXTURES. REFER TO PLUMBING DRAWINGS FOR DETAILS.
 - 3 REMOVE EXISTING TOILET PARTITIONS AND URINAL SCREENS. PATCH AND REPAIR WALL AND FLOORS. PREPARE FOR NEW PARTITIONS.
 - 4 REMOVE EXISTING SOAP DISPENSER AND SALVAGE FOR REUSE.
 - 5 REMOVE EXISTING PAPER TOWEL DISPENSER AND SALVAGE FOR REUSE.
 - 6 REMOVE EXISTING RECESSED PAPER TOWEL/WASTE RECEPTACLE UNIT. REPAIR HOLE IN WALL AND PREPARE WALL SURFACE FOR NEW WALL TILE.
 - 7 REMOVE EXISTING RECESSED SANITARY NAPKIN DISPENSER. REPAIR HOLE IN WALL AND PREPARE WALL SURFACE FOR NEW WALL TILE.
 - 8 REMOVE EXISTING TOILET ACCESSORIES (TOILET PAPER DISPENSER, TOILET SEAT COVER DISPENSER, SANITARY NAPKIN DISPOSAL).
 - 9 REMOVE EXISTING MIRROR.
 - 10 REMOVE EXISTING GRAB BARS.
 - 11 REMOVE EXISTING WALL MOUNT WOOD CABINET.
 - 12 REMOVE EXISTING CEILING TILES AND SUSPENDED CEILING GRID. RELINQUISH FULL AND UNDAMAGED TILES TO OWNER.
 - 13 REMOVE EXISTING CEILING MOUNTED LIGHT FIXTURES AND AIR DIFFUSERS. REFER TO MECHANICAL AND ELECTRICAL DRAWINGS FOR DETAILS.

- RENOVATION KEYNOTES:**
- 1 INSTALL NEW CERAMIC WALL TILE, TO FULL EXTENTS OF ROOM.
 - 2 INSTALL NEW WATER CLOSET. REFER TO PLUMBING DRAWINGS FOR DETAILS.
 - 3 INSTALL NEW URINAL. REFER TO PLUMBING DRAWINGS FOR DETAILS.
 - 4 INSTALL NEW SOLID SURFACE COUNTERTOP. ENSURE SUPPORT BRACKETS ARE ATTACHED TO EXISTING WALL STUDS. REFER TO A-203 FOR ELEVATIONS.
 - 5 INSTALL NEW UNDERMOUNT SINK AND FAUCET. REFER TO PLUMBING DRAWINGS FOR DETAILS.
 - 6 INSTALL NEW MIRROR.
 - 7 REINSTALL PAPER TOWEL DISPENSER.
 - 8 REINSTALL SOAP DISPENSER.
 - 9 INSTALL NEW SURFACE MOUNT TOILET PAPER DISPENSER.
 - 10 INSTALL NEW TOILET SEAT COVER DISPENSER.
 - 11 INSTALL NEW DUAL ACCESS SANITARY NAPKIN WASTE DISPOSAL.
 - 12 INSTALL NEW GRAB BARS.
 - 13 FLOOR MOUNTED PARTITIONS
 - 14 INSTALL NEW WALL MOUNT URINAL PARTITION.
 - 15 INSTALL CUSTOM SOLID SURFACE SHELF WITH UNDERMOUNT STAINLESS STEEL HOOKS. REFER TO A-501 FOR DETAILS.
 - 16 INSTALL NEW 2'x2' SUSPENDED CEILING GRID AND ACOUSTIC CEILING TILE.
 - 17 INSTALL NEW CEILING AIR DIFFUSERS. REFER TO MECHANICAL DRAWINGS FOR DETAILS.
 - 18 INSTALL NEW CEILING LIGHT FIXTURES. REFER TO ELECTRICAL DRAWINGS FOR DETAILS.
 - 19 INSTALL NEW PARTITION-MOUNTED DUAL-SIDED TOILET PAPER DISPENSER.

LEGEND	
	CEILING HEIGHT TAG
	FLOOR DRAIN - DEMO
	FLOOR DRAIN - NEW
	WALL REPAIR
	RECESSED CAN LIGHT

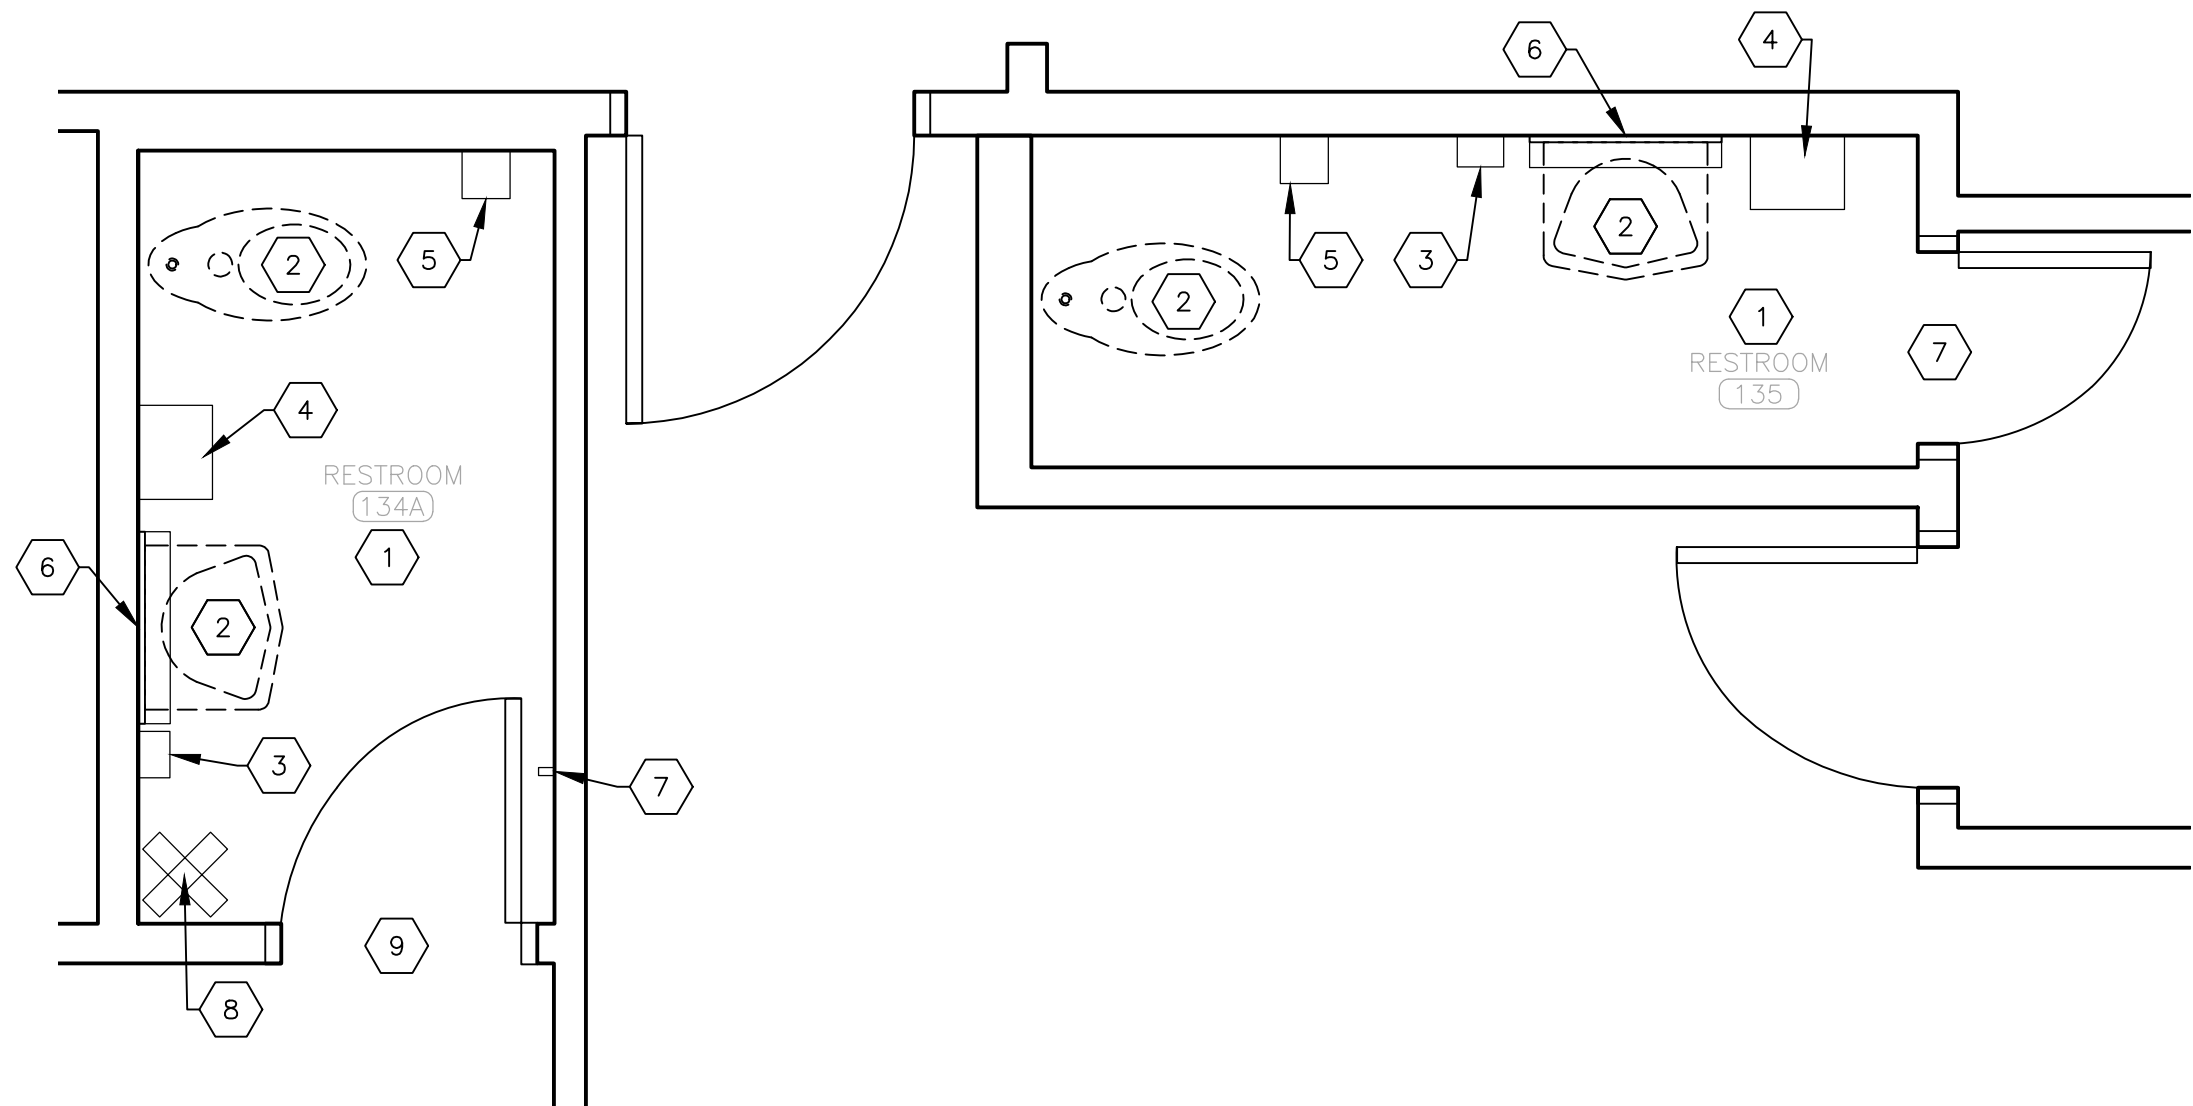


1 FIRST FLOOR RESTROOM DEMOLITION PLAN
SCALE: 1/2" = 1'-0"

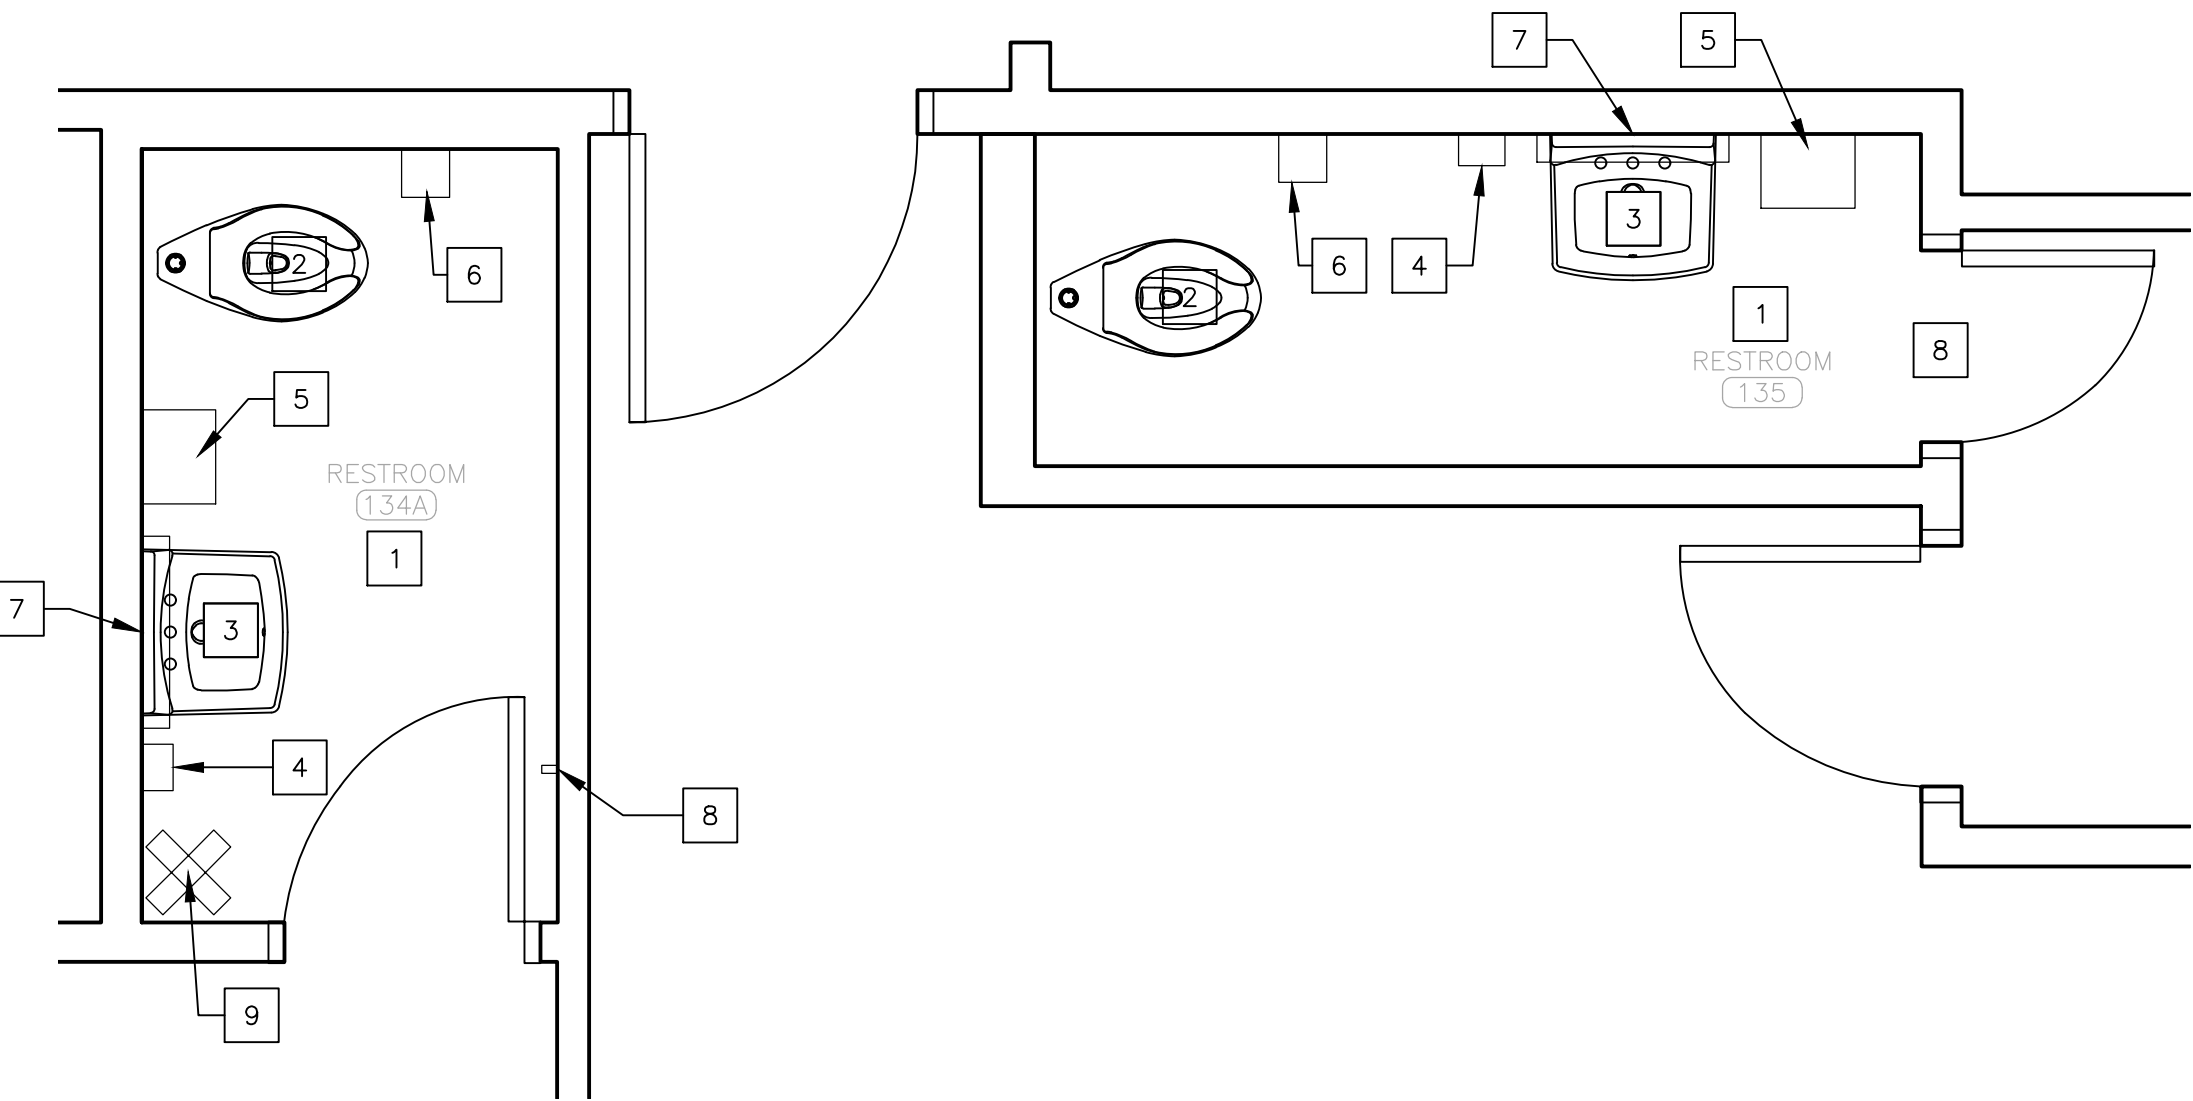


2 FIRST FLOOR RESTROOM RENOVATION PLAN
SCALE: 1/2" = 1'-0"

NOTE: REFER TO SHEET A-204 FOR PARTITION ELEVATIONS

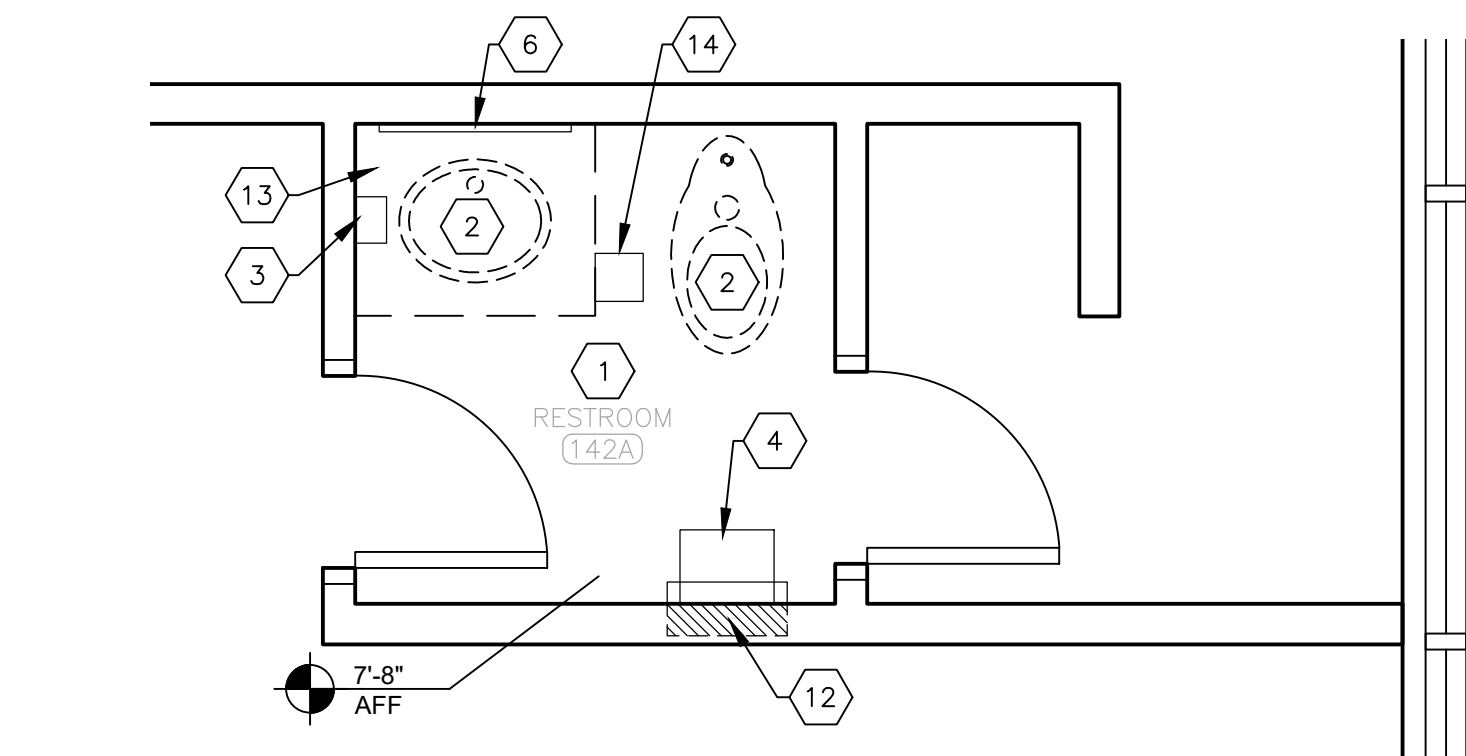


5 FIRST FLOOR RESTROOM DEMOLITION PLAN
SCALE: 1/2" = 1'-0"

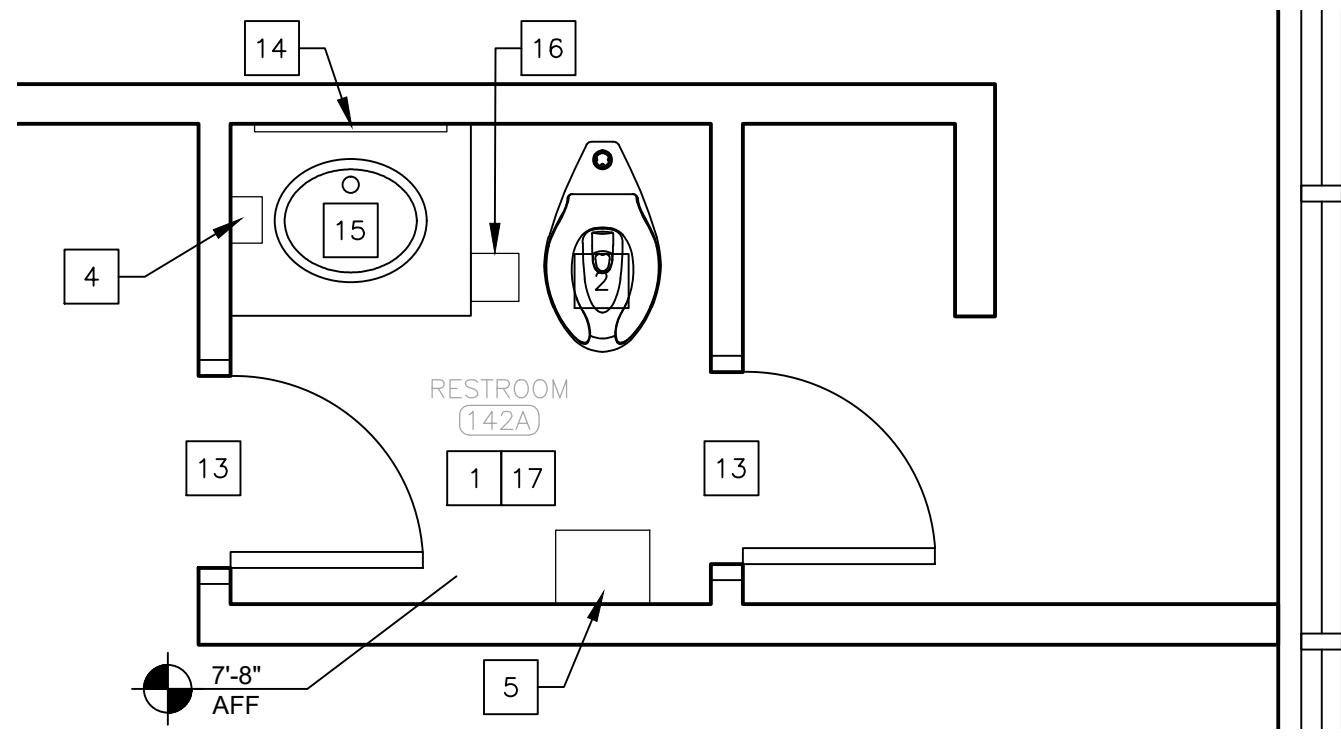


6 FIRST FLOOR RESTROOM RENOVATION PLAN
SCALE: 1/2" = 1'-0"

- DEMOLITION KEYNOTES:**
- 1 REMOVE EXISTING CERAMIC WALL TILE TO FULL EXTENTS OF THE ROOM, AND PREPARE EXISTING SUBSTRATE FOR NEW WALL TILE APPLICATION.
 - 2 REMOVE EXISTING PLUMBING FIXTURES (LAVATORIES, TOILETS); PREPARE EXISTING WALLS AND FLOORS FOR NEW FIXTURES. REFER TO PLUMBING DRAWINGS FOR DETAILS.
 - 3 REMOVE EXISTING SOAP DISPENSER AND SALVAGE FOR REUSE.
 - 4 REMOVE EXISTING PAPER TOWEL DISPENSER AND SALVAGE FOR REUSE.
 - 5 REMOVE EXISTING TOILET PAPER DISPENSER.
 - 6 REMOVE EXISTING MIRROR.
 - 7 REMOVE EXISTING COAT HOOK (WALL MOUNTED AND DOOR MOUNTED).
 - 8 REMOVE FREESTANDING COAT RACK AND SALVAGE FOR REUSE. PROTECT FROM DAMAGE.
 - 9 PROTECT EXISTING MIRROR ON DOOR TO REMAIN.
 - 10 REMOVE CEILING TILES AND SUSPENDED CEILING GRID. RELINQUISH FULL AND UNDAMAGED TILES TO OWNER.
 - 11 REMOVE EXISTING CEILING MOUNTED LIGHT FIXTURES AND AIR DIFFUSERS. REFER TO MECHANICAL AND ELECTRICAL DRAWINGS FOR DETAILS.
 - 12 REMOVE EXISTING RECESSED PAPER TOWEL/WASTE RECEPTACLE UNIT. REPAIR HOLE IN WALL AND PREPARE WALL SURFACE FOR NEW WALL TILE.
 - 13 REMOVE EXISTING CABINET AND COUNTERTOP.
 - 14 REMOVE EXISTING TOILET PAPER HOLDER AND SALVAGE FOR REUSE.

- RENOVATION KEYNOTES:**
- 1 INSTALL NEW CERAMIC WALL TILE, TO FULL EXTENTS OF ROOM. APPLY WALL TILE FULL HEIGHT OF THE WALLS UP TO THE EXISTING CEILING.
 - 2 INSTALL. NEW WATER CLOSET. REFER TO PLUMBING DRAWINGS FOR DETAILS.
 - 3 INSTALL NEW WALL MOUNT SINK AND FAUCET. REFER TO PLUMBING DRAWINGS FOR DETAILS.
 - 4 REINSTALL SOAP DISPENSER.
 - 5 REINSTALL PAPER TOWEL DISPENSER.
 - 6 INSTALL NEW TOILET PAPER DISPENSER.
 - 7 INSTALL NEW MIRROR CABINET.
 - 8 INSTALL NEW COAT HOOK TO SAME LOCATION AS REMOVED COAT HOOKS.
 - 9 REINSTALL FREESTANDING COAT RACK TO SAME LOCATION.
 - 10 INSTALL NEW 2'x2' SUSPENDED CEILING GRID AND ACOUSTIC CEILING TILE.
 - 11 INSTALL NEW CEILING AIR DIFFUSERS. REFER TO MECHANICAL DRAWINGS FOR DETAILS.
 - 12 INSTALL NEW CEILING LIGHT FIXTURES. REFER TO ELECTRICAL DRAWINGS FOR DETAILS.
 - 13 INSTALL NEW COAT HOOK TO EXISTING DOOR WITHIN THE RESTROOM, AT 60" AFF.
 - 14 INSTALL NEW MIRROR.
 - 15 INSTALL NEW BASE CABINET AND COUNTERTOP WITH UNDERMOUNT SINK AND FAUCET. REFER TO PLUMBING DRAWINGS FOR DETAILS.
 - 16 REINSTALL SALVAGED TOILET PAPER HOLDER ONTO SIDE OF NEW BASE CABINET.
 - 17 APPLY PRIMER AND PAINT TO CEILING, TO FULL EXTENTS OF THE ROOM.

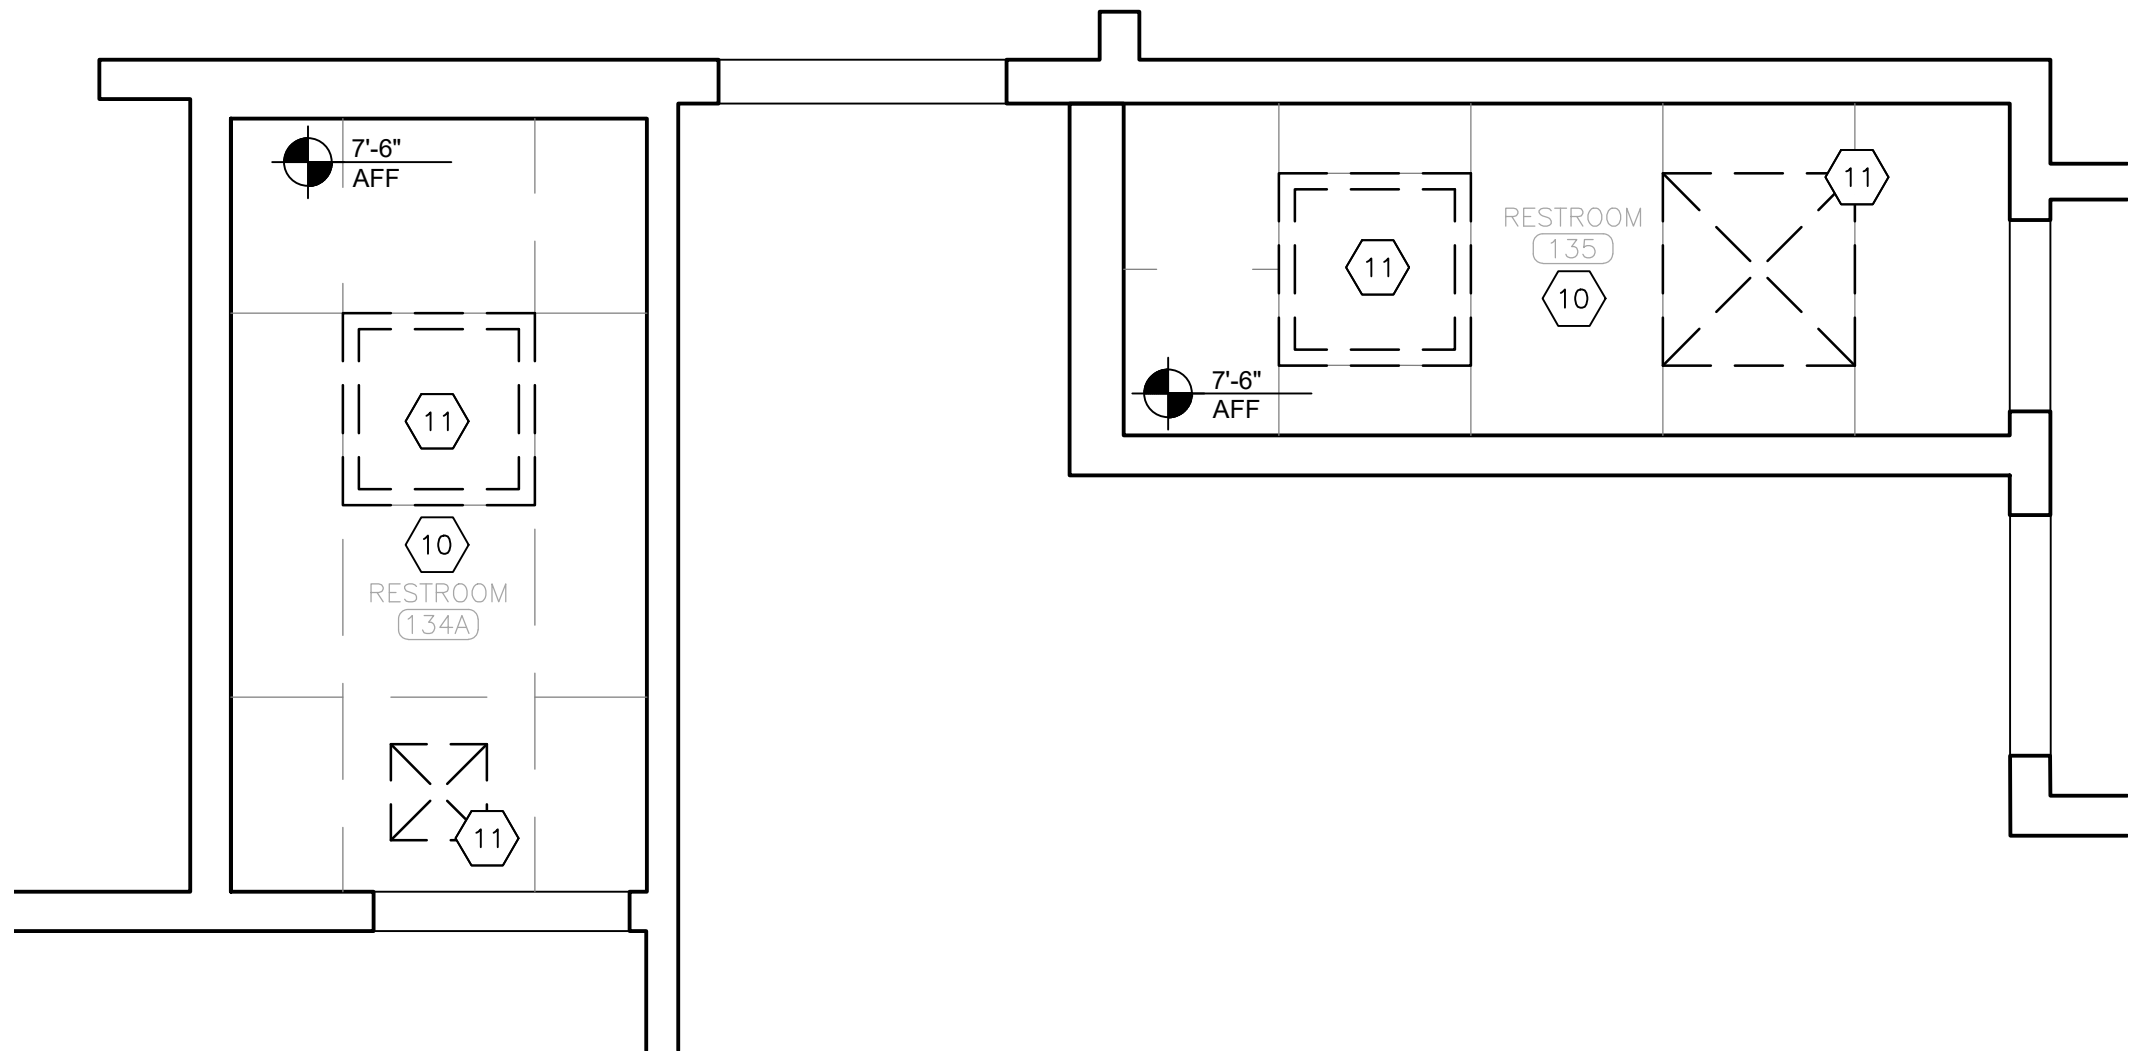

3 FIRST FLOOR RESTROOM DEMOLITION REFLECTED CEILING PLAN
SCALE: 1/2" = 1'-0"

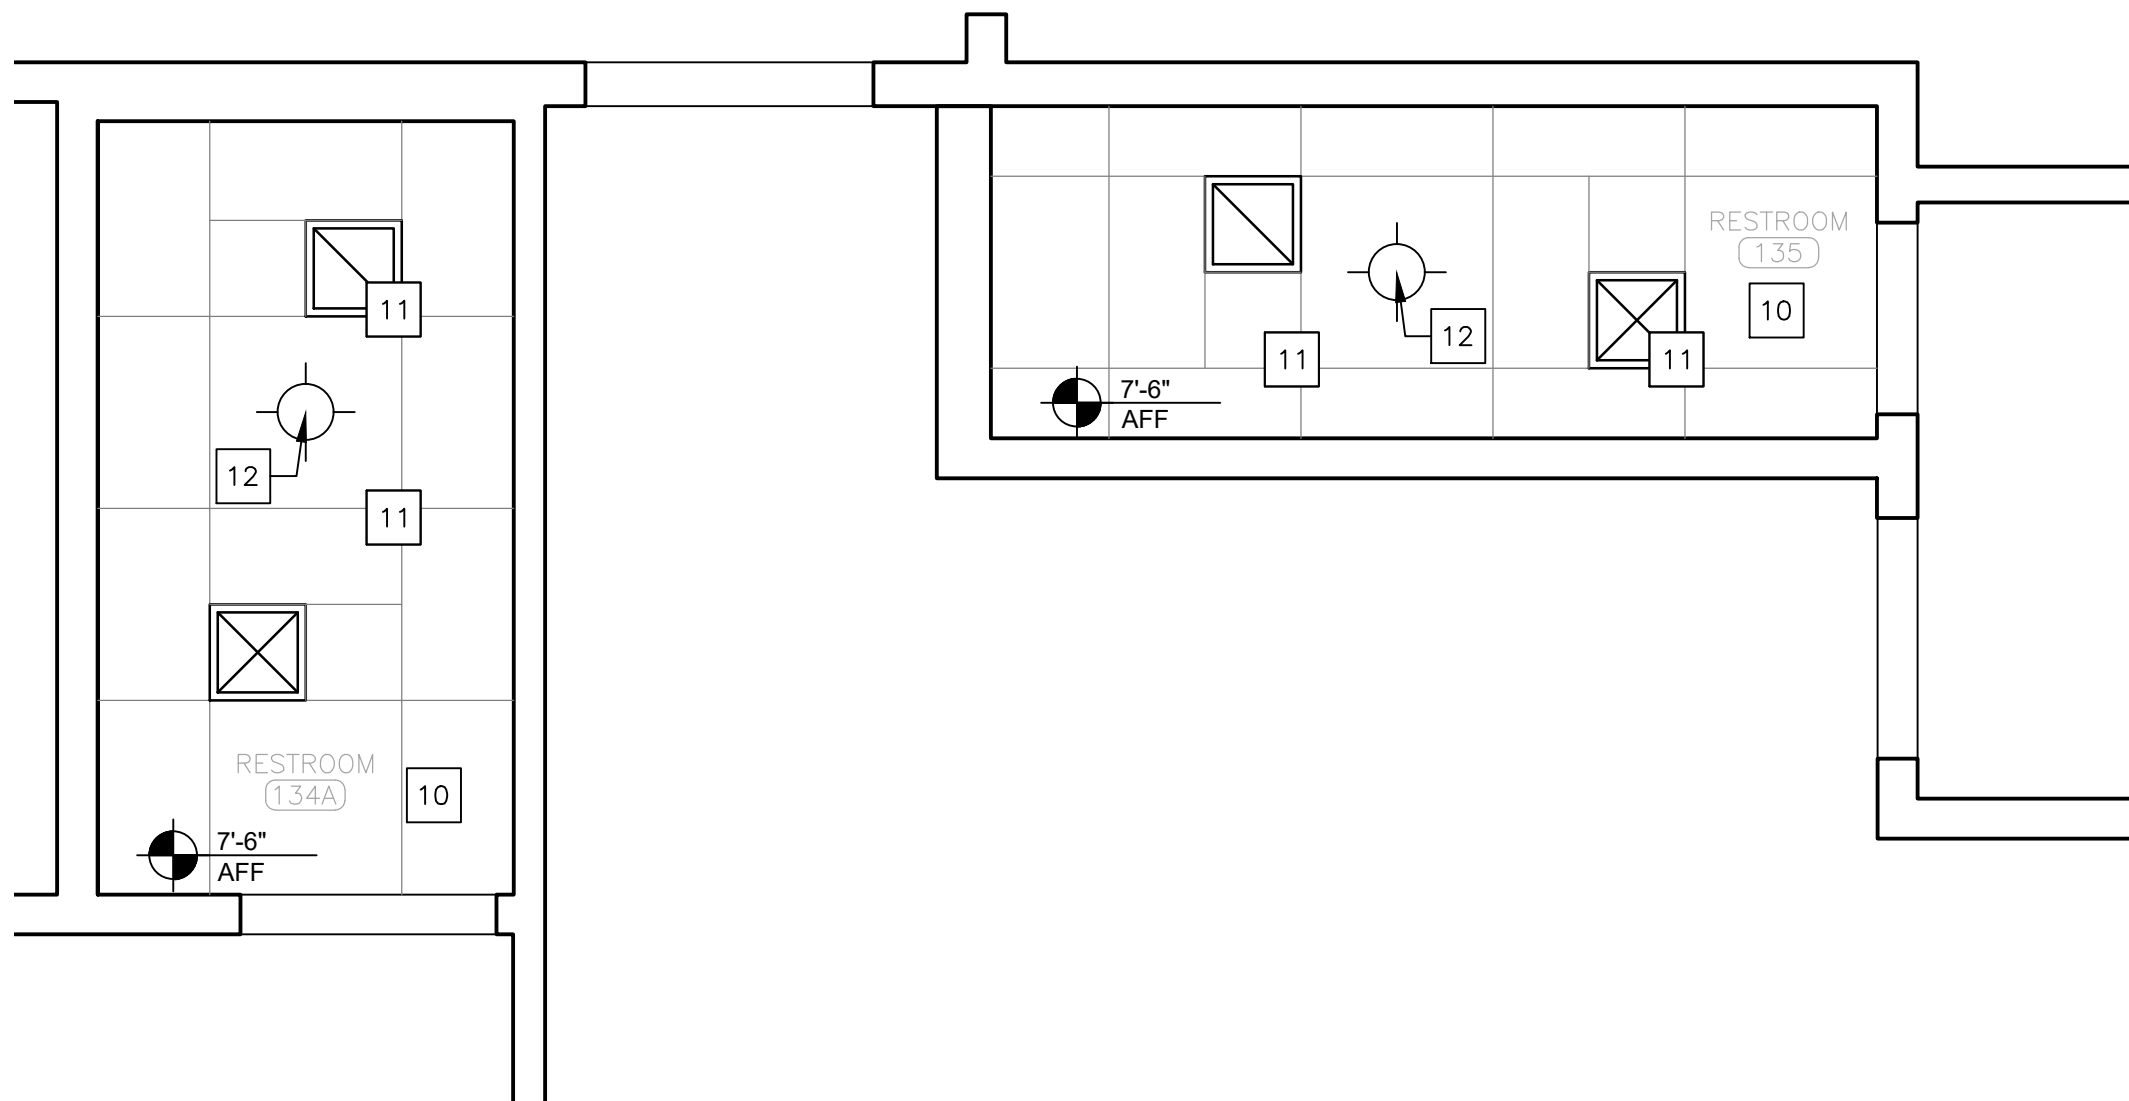

4 FIRST FLOOR RESTROOM RENOVATION REFLECTED CEILING PLAN
SCALE: 1/2" = 1'-0"

STATE OF MISSOURI
MIKE KEHOE,
GOVERNOR



Brad M. Schaefer - Architect
MO# A-2009027294

BID DOCUMENTS

OFFICE OF ADMINISTRATION
DIVISION OF FACILITIES
MANAGEMENT,
DESIGN AND CONSTRUCTION

DEPARTMENT OF
PUBLIC SAFETY
STATE HIGHWAY PATROL

RENOVATE INTERIOR

GENERAL HEADQUARTERS
1510 EAST ELM STREET
JEFFERSON CITY, MO 65101

PROJECT # R2410-01
SITE # 6001
ASSET # 8136001001

REVISION: _____
DATE: _____
REVISION: _____
DATE: _____
REVISION: _____
DATE: _____
ISSUE DATE: 06/18/2026


CAD DWG FILE: _____
DRAWN BY: RG/CL
CHECKED BY: BMS
DESIGNED BY: CL

SHEET TITLE:
FIRST FLOOR
RESTROOM
ENLARGED PLANS


SHEET NUMBER:

A-404

15 OF 39 SHEETS
06/18/2026

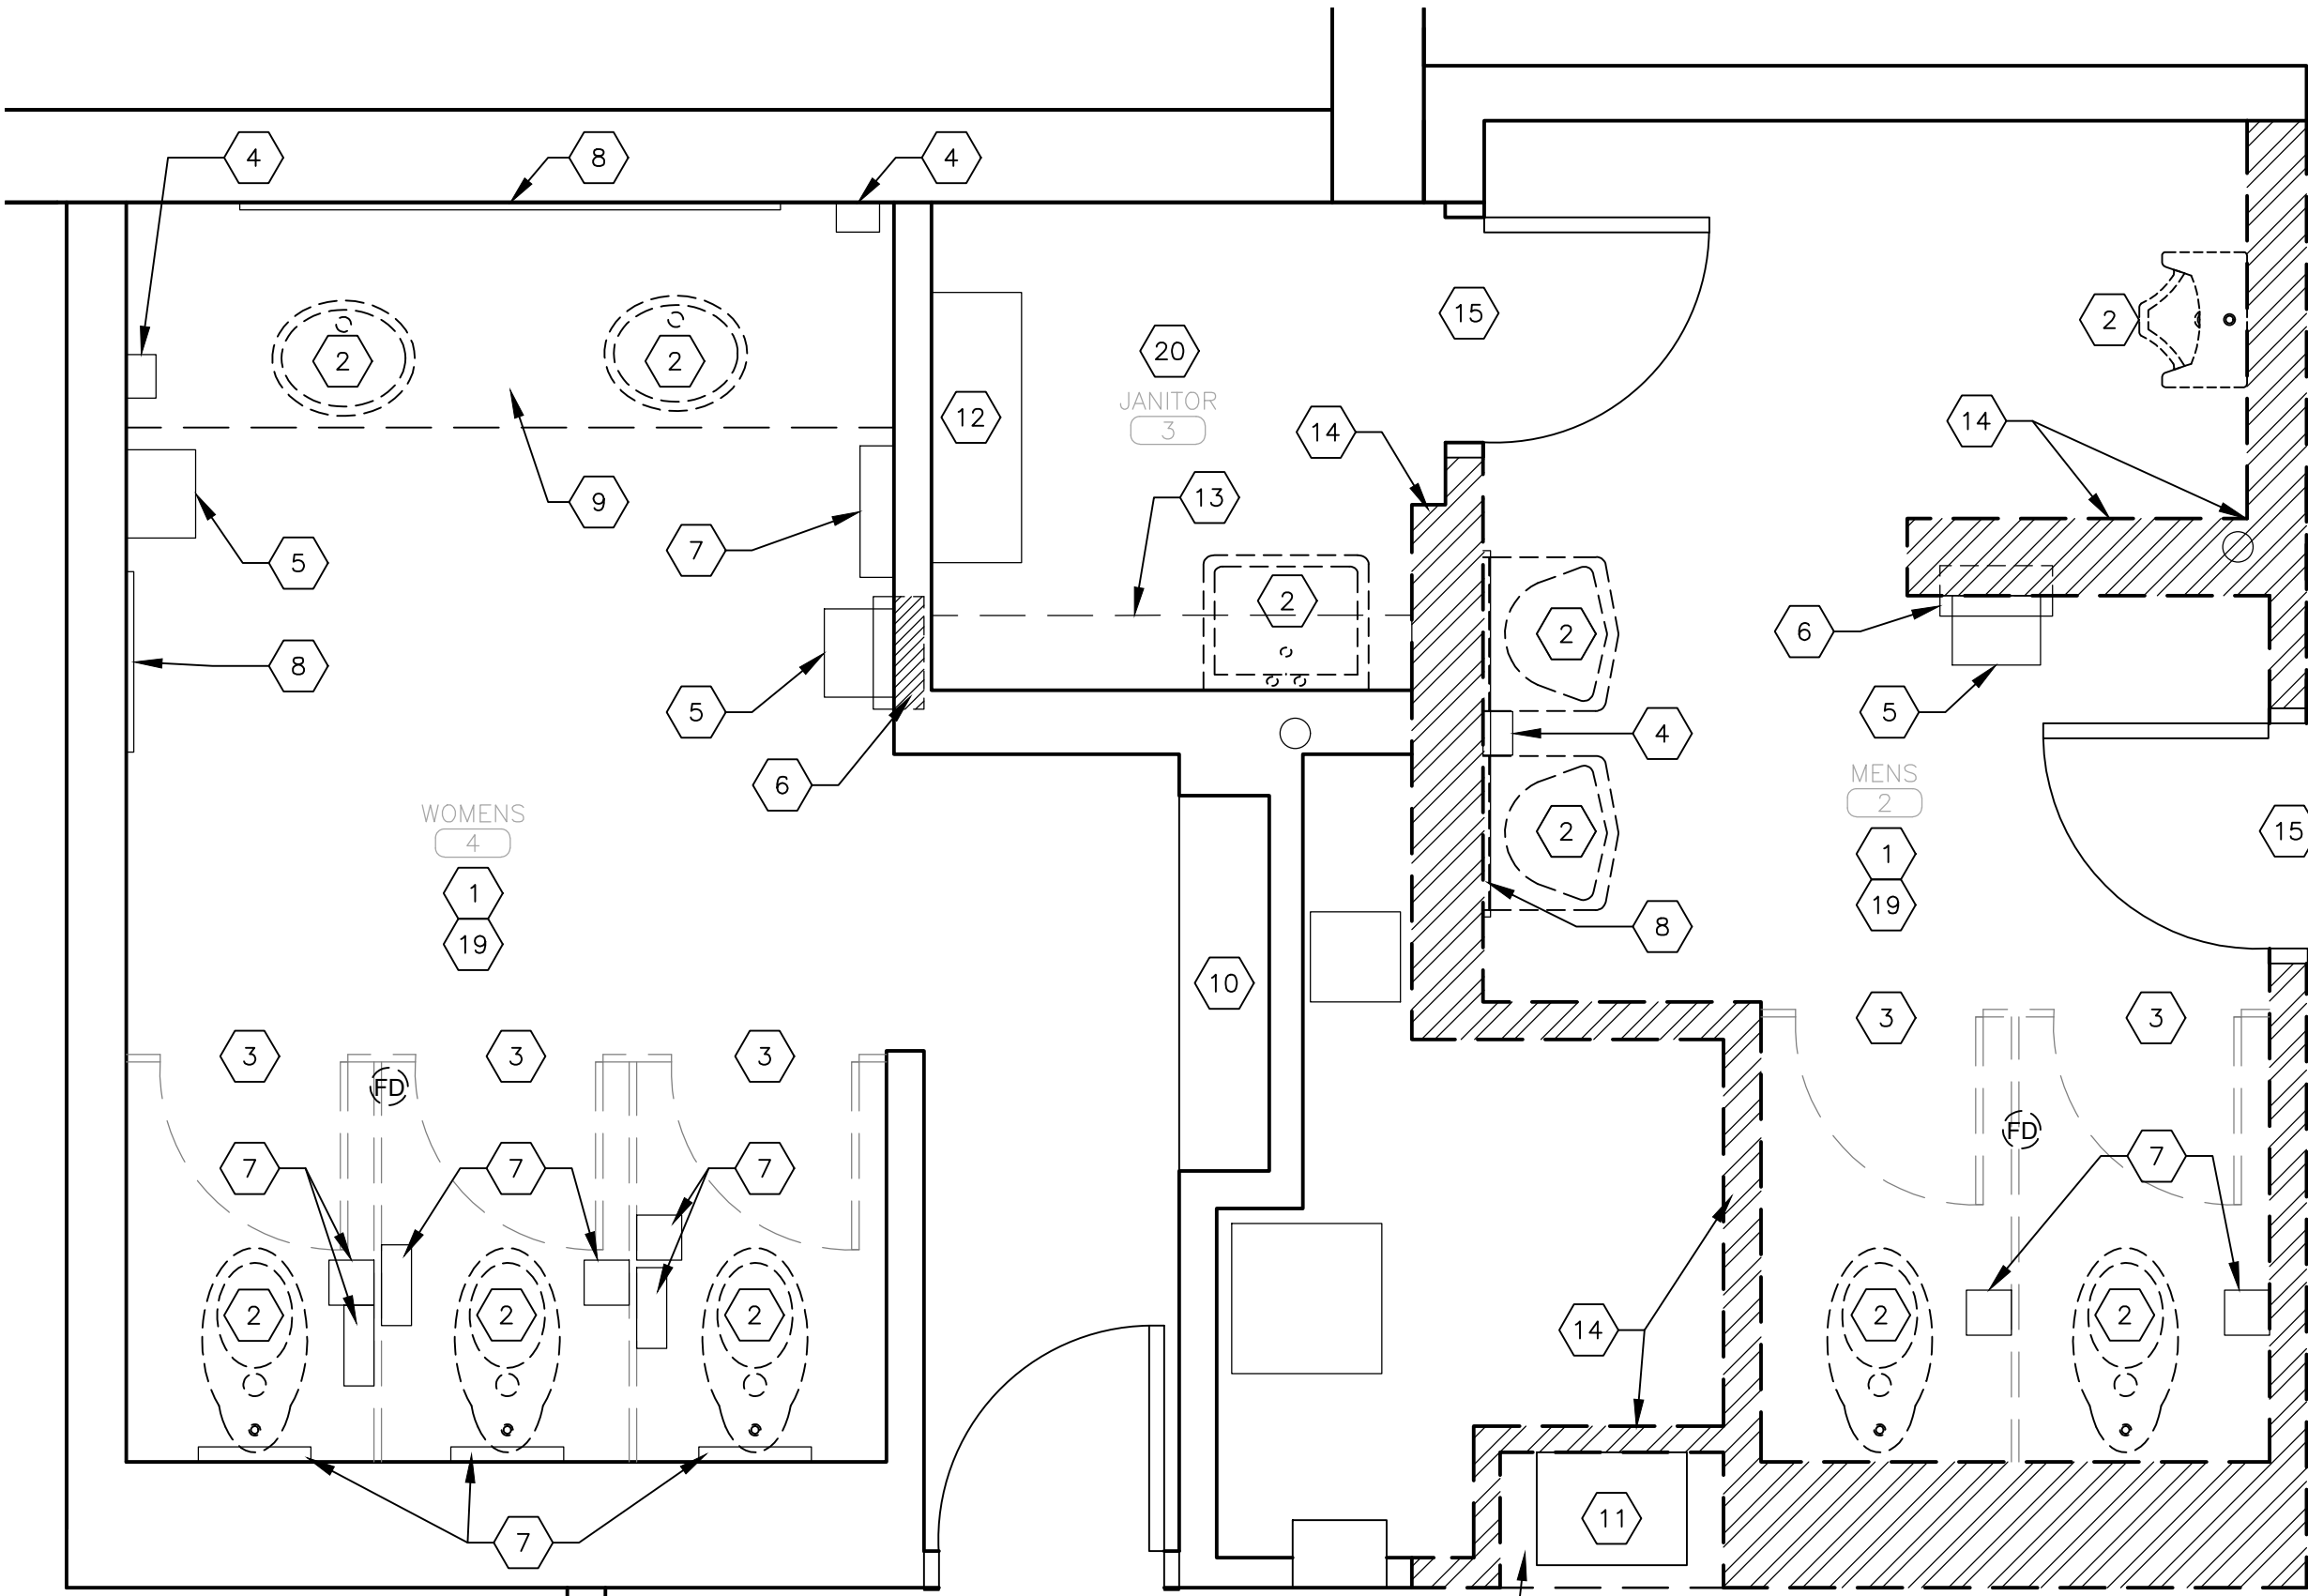

1 SECOND FLOOR RESTROOM DEMOLITION PLAN
SCALE: 1/2" = 1'-0"

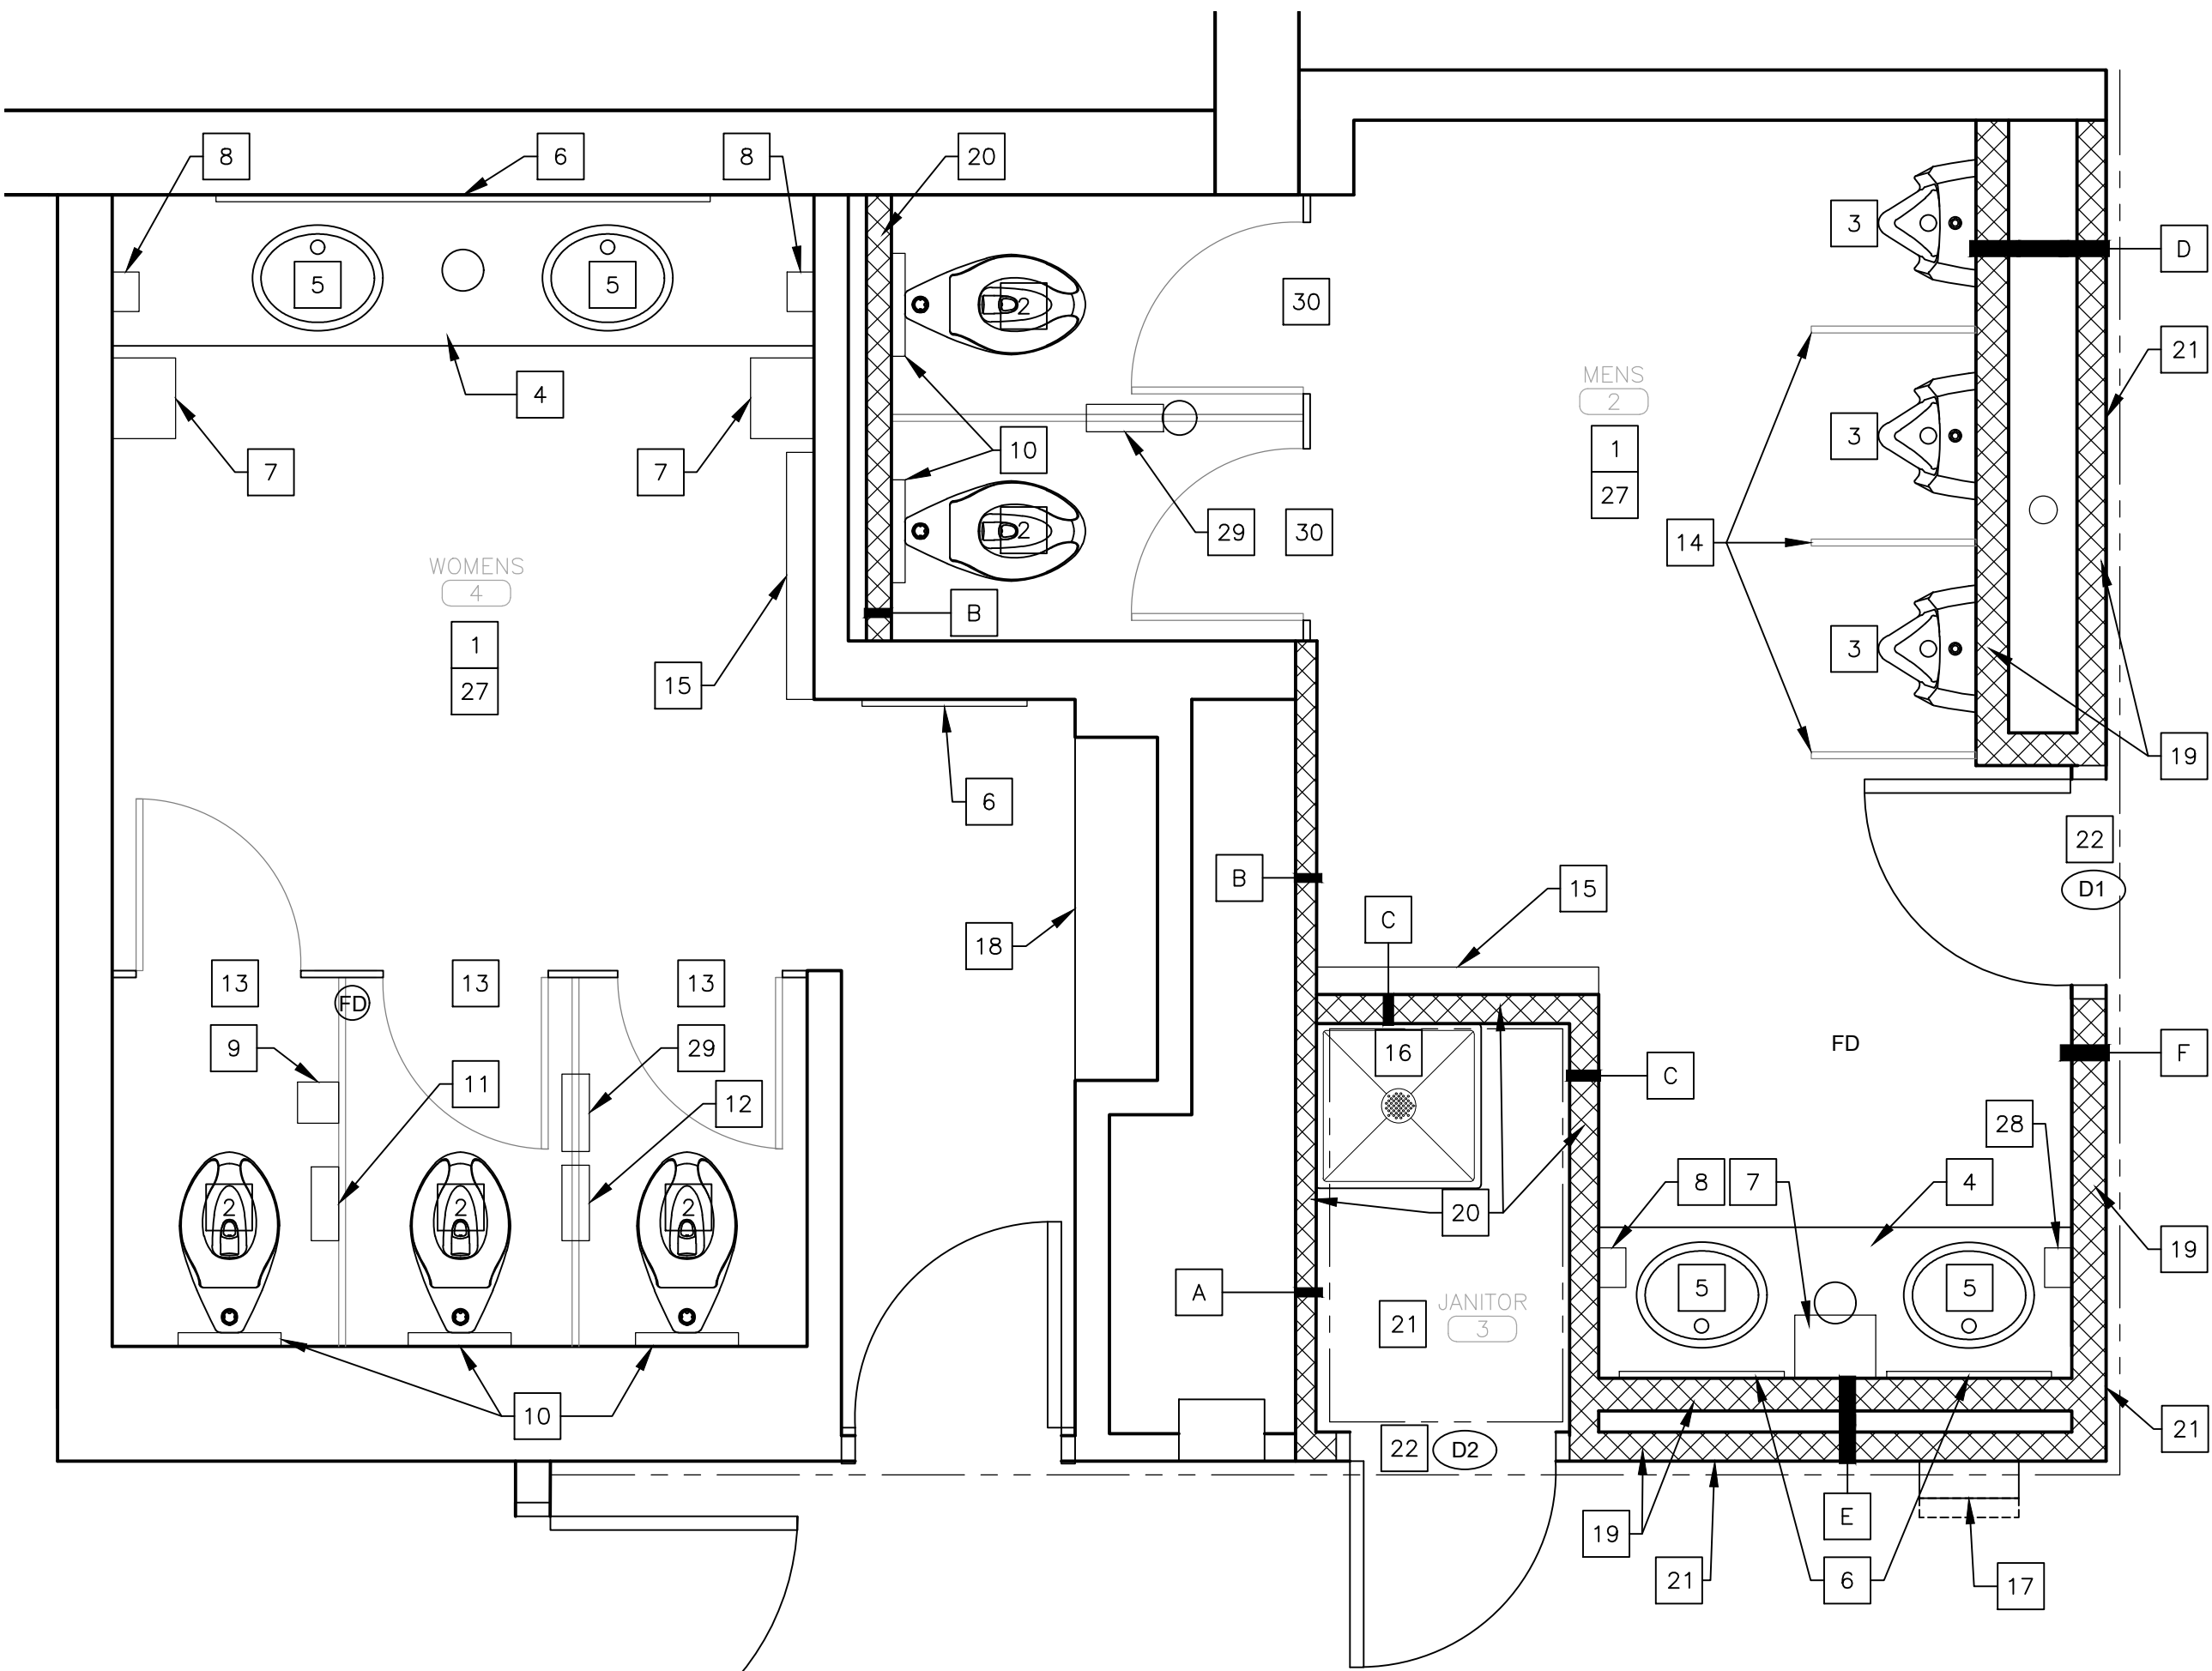

2 SECOND FLOOR RESTROOM RENOVATION PLAN
SCALE: 1/2" = 1'-0"


NOTE: REFER TO SHEET A-205 FOR PARTITION ELEVATIONS

DEMOLITION KEYNOTES:


- REMOVE EXISTING CERAMIC WALL TILE TO FULL EXTENTS OF THE ROOM, AND PREPARE EXISTING SUBSTRATE FOR NEW WALL TILE APPLICATION.
- REMOVE EXISTING PLUMBING FIXTURES (LAVATORIES, TOILETS, URINALS). PREPARE EXISTING WALLS AND FLOORS FOR NEW FIXTURES. REFER TO PLUMBING DRAWINGS FOR DETAILS.
- REMOVE EXISTING TOILET PARTITIONS. PATCH AND REPAIR WALL AND FLOORS. PREPARE FOR NEW PARTITIONS.
- REMOVE EXISTING SOAP DISPENSER AND SALVAGE FOR REUSE.
- REMOVE EXISTING WALL MOUNTED PAPER TOWEL DISPENSER AND SALVAGE FOR REUSE.
- REMOVE EXISTING RECESSED PAPER TOWEL/WASTE RECEPTACLE UNIT. REPAIR HOLE IN WALL AND PREPARE WALL SURFACE FOR NEW WALL TILE.
- REMOVE EXISTING TOILET ACCESSORIES (TOILET PAPER DISPENSER, TOILET SEAT COVER DISPENSER, SANITARY NAPKIN DISPOSAL, SANITARY NAPKIN DISPENSER).
- REMOVE EXISTING MIRROR.
- REMOVE EXISTING COUNTERTOP.
- PROTECT EXISTING RECESSED LOCKERS TO REMAIN.
- REMOVE EXISTING DRINKING FOUNTAIN. REFER TO PLUMBING DRAWINGS FOR DETAILS.
- REMOVE EXISTING FREESTANDING SHELF AND RELINQUISH TO OWNER.
- REMOVE EXISTING WALL MOUNTED SHELVING AND REPAIR WALL SURFACE.
- REMOVE EXISTING WALL TO EXTENTS SHOWN BY HATCH. COORDINATE WITH PLUMBING DRAWINGS AND PATCH ABANDONED PENETRATIONS IN FLOOR SLAB.
- REMOVE EXISTING DOOR, FRAME, AND THRESHOLD/ TRANSITION STRIP. SALVAGE EXISTING SIGNAGE FOR REUSE.
- REMOVE EXISTING CEILING TILES AND SUSPENDED CEILING GRID. RELINQUISH FULL AND UNDAMAGED TILES TO OWNER.
- REMOVE CEILING MOUNTED LIGHT FIXTURES AND AIR DIFFUSERS. REFER TO MECHANICAL AND ELECTRICAL DRAWINGS FOR DETAILS.
- EXISTING SUPPORT STRUCTURE TO REMAIN FOR CEILING HUNG PARTITIONS. PROTECT FROM DAMAGE.
- REMOVE AND DISPOSE OF EXISTING FLOOR TILE DOWN TO SUBFLOOR BELOW, TO FULL EXTENTS OF THE ROOM. SMOOTH AND PREPARE SUBFLOOR TO NEW FLOOR MANUFACTURER'S RECOMMENDATIONS FOR INSTALLATION.
- REMOVE EXISTING FLOOR TILE DOWN TO SUBFLOOR BELOW. SMOOTH AND PREPARE SUBFLOOR TO NEW FLOOR MANUFACTURER'S RECOMMENDATION FOR INSTALLATION. COORDINATE WITH ASBESTOS REMEDIATION FOR REMOVAL OF FLOORING.
- REMOVE EXISTING TOILET PARTITION SUPPORT ABOVE CEILING.

RENOVATION KEYNOTES:

- INSTALL NEW CERAMIC WALL TILE, TO FULL EXTENTS OF ROOM.
- INSTALL NEW WATER CLOSET. REFER TO PLUMBING DRAWINGS FOR DETAILS.
- INSTALL NEW URINAL. REFER TO PLUMBING DRAWINGS FOR DETAILS.
- INSTALL NEW SOLID SURFACE COUNTERTOP WITH CIRCULAR WASTE CHUTE CENTERED BETWEEN LAVATORIES. REFER TO A-501 FOR DETAILS.
- INSTALL NEW UNDERMOUNT SINK AND FAUCET. REFER TO PLUMBING DRAWINGS FOR DETAILS.
- INSTALL NEW MIRROR.
- REINSTALL WALL MOUNTED PAPER TOWEL DISPENSER.
- REINSTALL SOAP DISPENSER.
- INSTALL NEW SURFACE MOUNT TOILET PAPER DISPENSER.
- INSTALL NEW SURFACE MOUNT SANITARY NAPKIN DISPOSAL.
- INSTALL NEW DUAL ACCESS SANITARY NAPKIN DISPOSAL.
- INSTALL NEW CEILING HUNG TOILET PARTITION. ENSURE ADEQUATE FRAMING AT EXISTING SUPPORT STRUCTURE, AND PROVIDE SUPPORT CHANNEL WITH UNISTRUT WHERE NEW SUPPORT IS NEEDED.
- INSTALL NEW WALL MOUNT URINAL PARTITION.
- INSTALL CUSTOM SOLID SURFACE SHELF WITH UNDERMOUNT STAINLESS STEEL HOOKS. REFER TO A-501 FOR DETAILS.
- INSTALL NEW MOP SINK. REFER TO PLUMBING DRAWINGS FOR DETAILS.
- INSTALL NEW DRINKING FOUNTAIN. REFER TO PLUMBING DRAWINGS FOR DETAILS.
- REMOVE EDGE TRIM AROUND RECESSED LOCKERS AND INSTALL NEW METAL TRIM. APPLY PRIMER AND PAINT TO EXPOSED SURFACES OF EXISTING RECESSED LOCKERS, EXCEPT NUMBER PLATES AND LOCKS. PAINT NEW TRIM TO MATCH.
- INSTALL NEW 3-5/8" METAL STUD WALL WITH 5/8" GYPSUM BOARD. DO NOT APPLY FINISH MATERIAL TO INSIDE OF PLUMBING CHASE.
- INSTALL NEW 2-1/2" METAL STUD WALL WITH 5/8" GYPSUM BOARD. DO NOT APPLY FINISH MATERIAL TO INSIDE OF PLUMBING CHASE.
- PAINT NEW EXPOSED GYPSUM BOARD WALLS FROM FLOOR TO CEILING, AND INSTALL NEW VINYL COVE BASE. PROVIDE LEVEL 4 FINISH. PAINT WALLS TO EXTENTS INDICATED BY DASHED LINE.
- INSTALL NEW DOOR, FRAME AND HARDWARE TO LOCATION SHOWN, AND REINSTALL SALVAGED SIGNAGE. INSTALL NEW METAL TRANSITION STRIP AT CERAMIC TILE TO CARPET, AND INSTALL NEW VINYL TRANSITION STRIP AT CONCRETE TO CARPET. PROVIDE TRANSITION PROFILES TO ACCOMMODATE CHANGE IN FLOOR HEIGHT.
- INSTALL NEW 2'x2' SUSPENDED CEILING GRID AND ACOUSTIC CEILING TILE.
- INSTALL NEW SUSPENDED DRYWALL FRAMING SYSTEM FOR DRYWALL SOFFIT. PROVIDE LEVEL 4 FINISH AND PAINT.
- INSTALL NEW CEILING AIR DIFFUSERS. REFER TO MECHANICAL DRAWINGS FOR DETAILS.
- INSTALL NEW CEILING LIGHT FIXTURES. REFER TO ELECTRICAL DRAWINGS FOR DETAILS.
- INSTALL NEW CERAMIC FLOOR TILE, TO FULL EXTENTS OF THE ROOM. SMOOTH AND PREPARE SUBFLOOR AS RECOMMENDED BY MANUFACTURER.
- INSTALL OWNER FURNISHED SOAP DISPENSER.
- INSTALL NEW PARTITION-MOUNTED DUAL-SIDED TOILET PAPER DISPENSER.
- WALL/FLOOR MOUNTED TOILET PARTITION

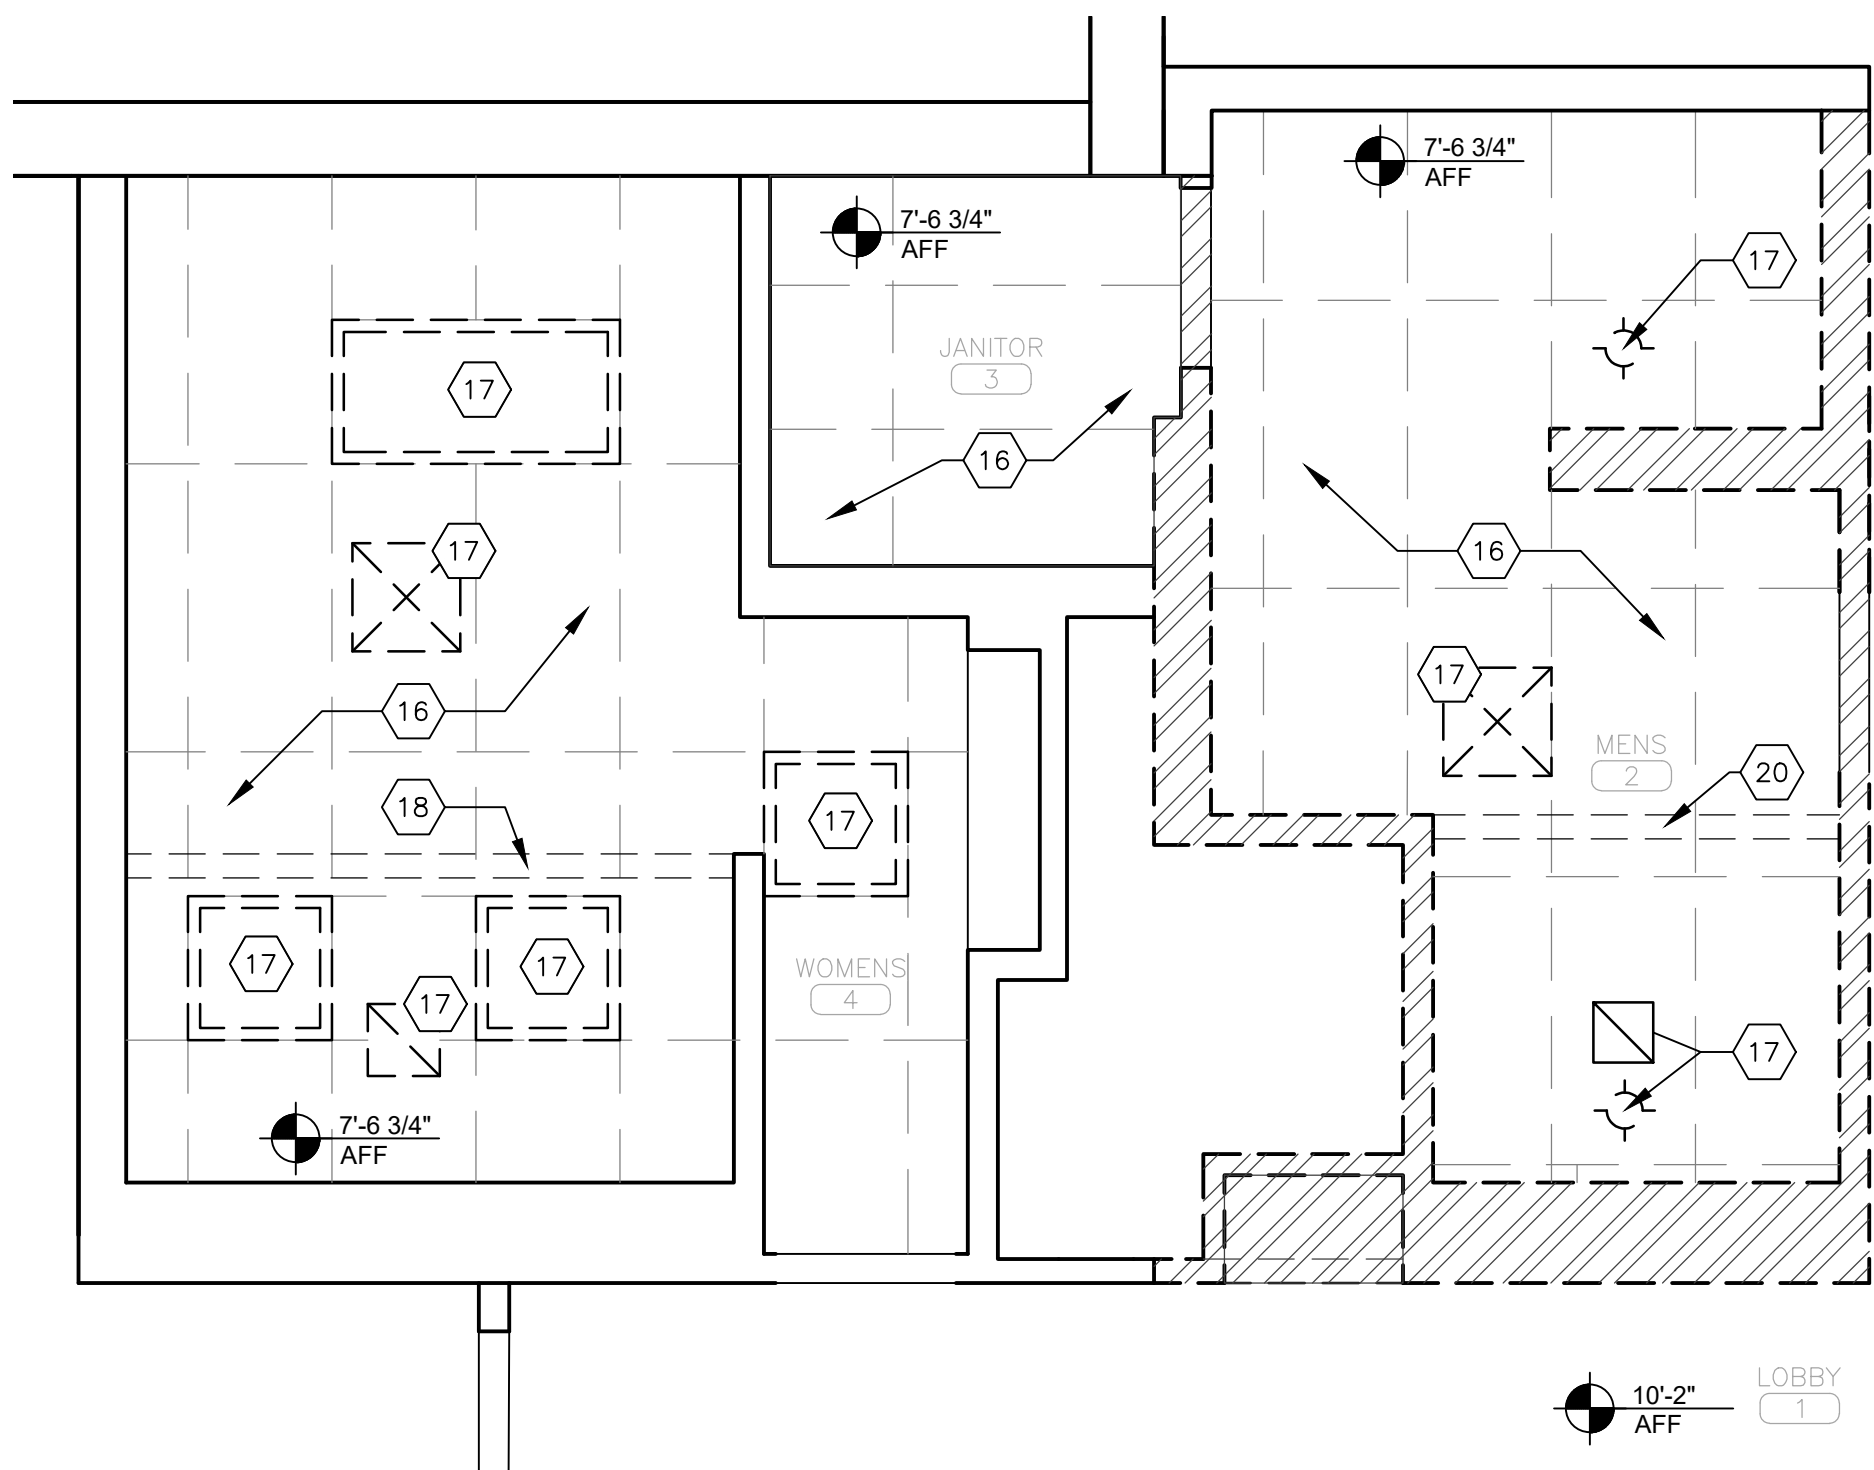

3 SECOND FLOOR RESTROOM DEMOLITION REFLECTED CEILING PLAN
SCALE: 3/8" = 1'-0"

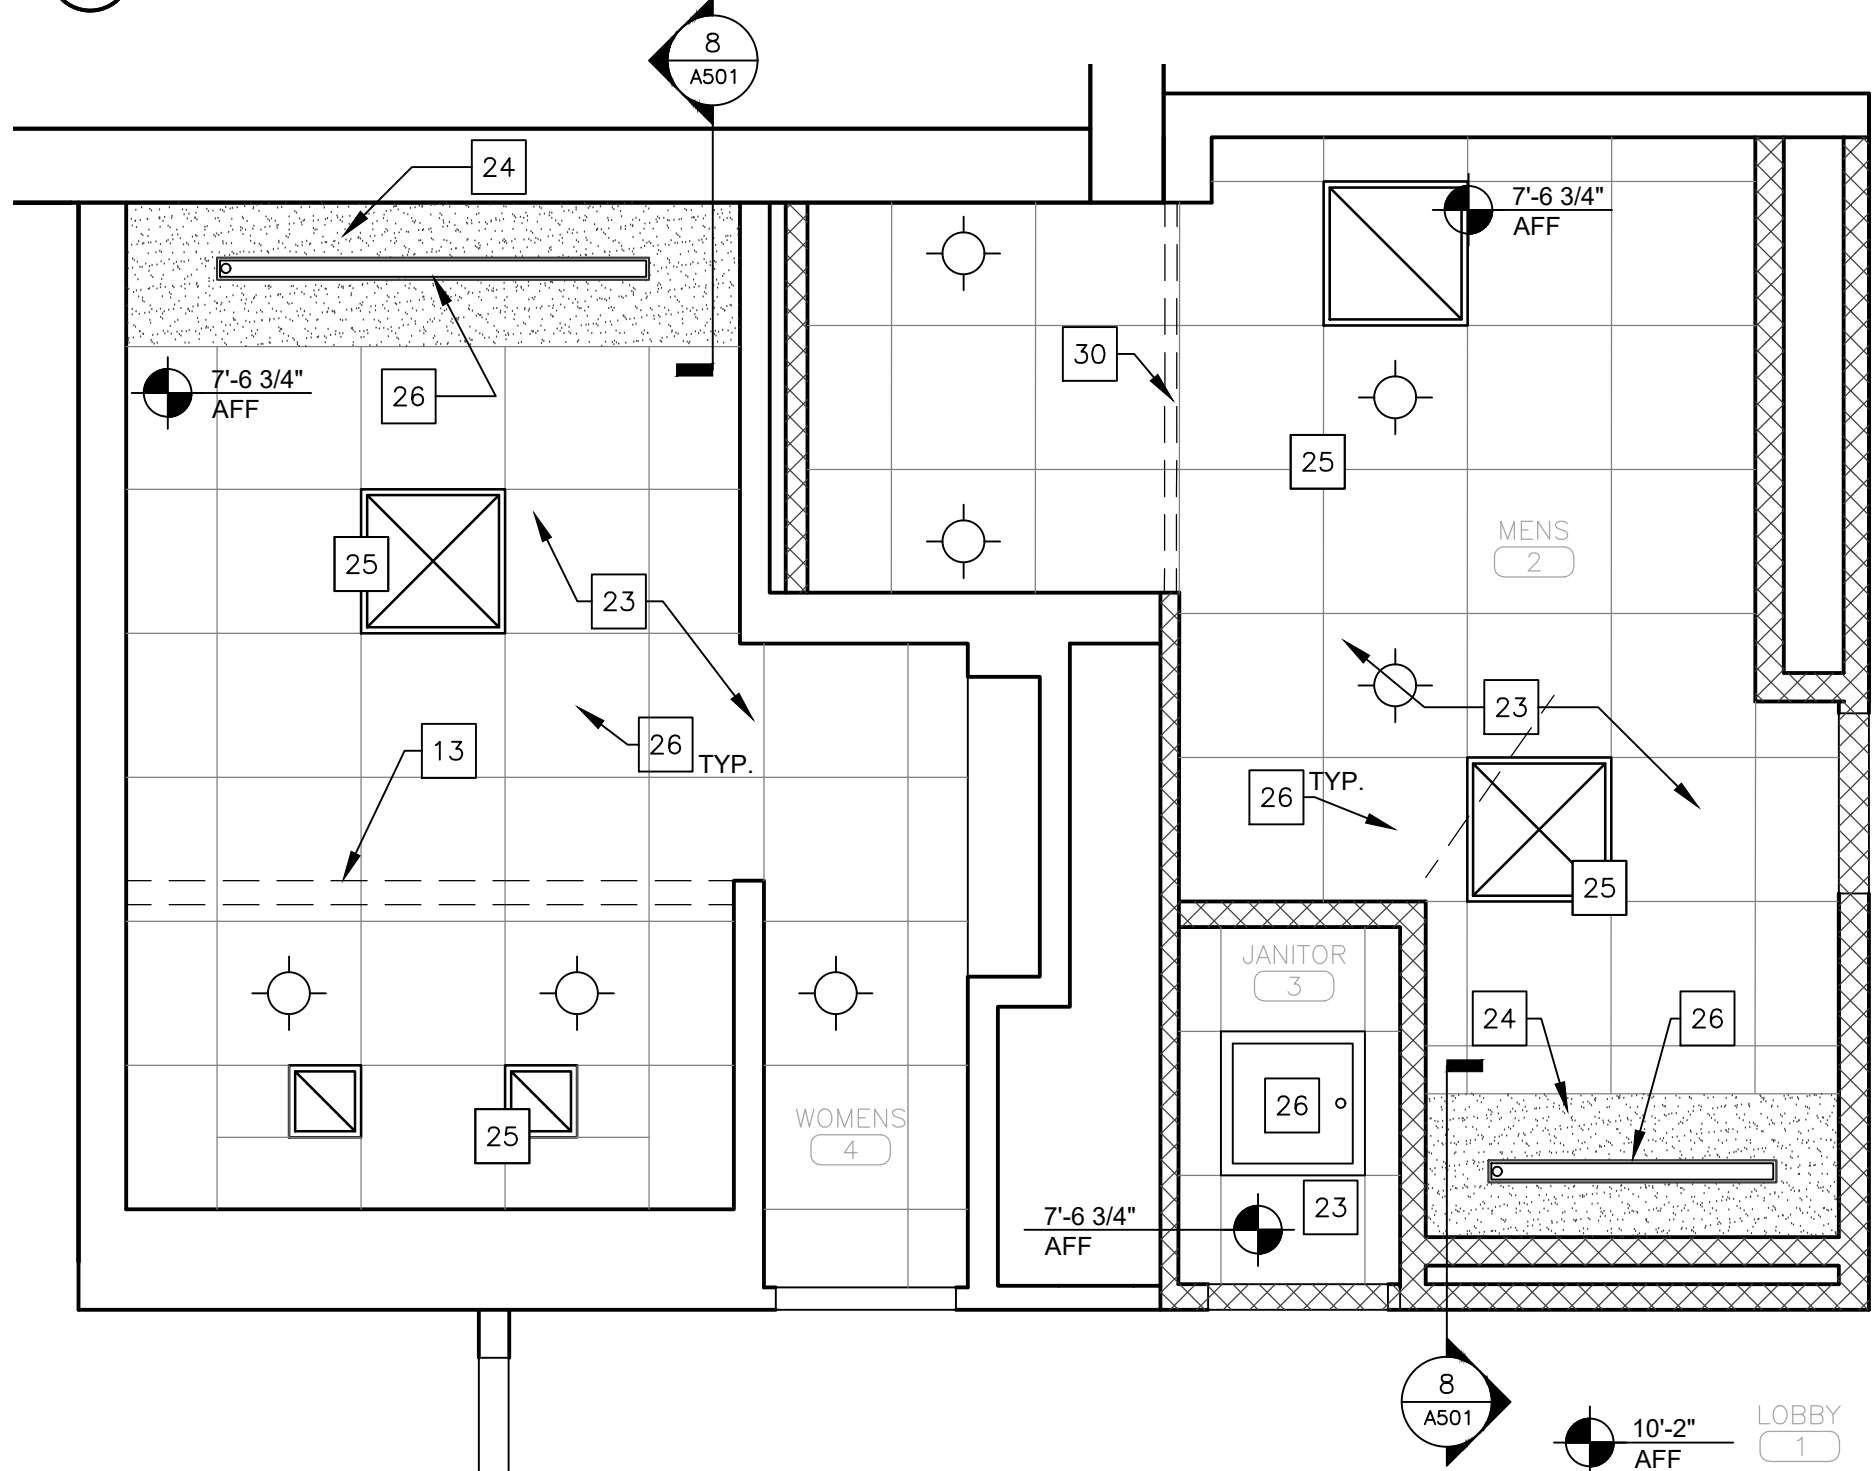

4 SECOND FLOOR RESTROOM RENOVATION REFLECTED CEILING PLAN
SCALE: 3/8" = 1'-0"

LEGEND			
	CEILING HEIGHT TAG		WALL REPAIR
	DOOR TAG		DRYWALL CEILING
	WALL TAG		WALL DEMO
	FLOOR DRAIN - DEMO		NEW WALL
	FLOOR DRAIN - NEW		NEW PAINT
	RECESSED CAN LIGHT		

STATE OF MISSOURI
MIKE KEHOE,
GOVERNOR



Brad M. Schaefer - Architect
MO# A-2009027294

BID DOCUMENTS

OFFICE OF ADMINISTRATION
DIVISION OF FACILITIES
MANAGEMENT,
DESIGN AND CONSTRUCTION

DEPARTMENT OF
PUBLIC SAFETY
STATE HIGHWAY PATROL

RENOVATE INTERIOR

GENERAL HEADQUARTERS
1510 EAST ELM STREET
JEFFERSON CITY, MO 65101

PROJECT # R2410-01
SITE # 6001
ASSET # 8136001001

REVISION: _____
DATE: _____
REVISION: _____
DATE: _____
REVISION: _____
DATE: _____
ISSUE DATE: 06/18/2026

CAD DWG FILE: _____
DRAWN BY: RG/CL
CHECKED BY: BMS
DESIGNED BY: CL

SHEET TITLE:
SECOND FLOOR
RESTROOM
ENLARGED PLANS

SHEET NUMBER:

A-405

16 OF 39 SHEETS
06/18/2026



Brad M. Schaefer - Architect
MO# A-2009027294

BID DOCUMENTS

OFFICE OF ADMINISTRATION
DIVISION OF FACILITIES
MANAGEMENT,
DESIGN AND CONSTRUCTION

DEPARTMENT OF
PUBLIC SAFETY
STATE HIGHWAY PATROL

RENOVATE INTERIOR

GENERAL HEADQUARTERS
1510 EAST ELM STREET
JEFFERSON CITY, MO 65101

PROJECT # R2410-01
SITE # 6001
ASSET # 8136001001

REVISION: _____
DATE: _____
REVISION: _____
DATE: _____
REVISION: _____
DATE: _____
ISSUE DATE: 06/18/2026


CAD DWG FILE: _____
DRAWN BY: RG/CL
CHECKED BY: BMS
DESIGNED BY: CL

SHEET TITLE:
**SECOND FLOOR
RESTROOM
ENLARGED PLANS**


SHEET NUMBER:

A-406

17 OF 39 SHEETS
06/18/2026

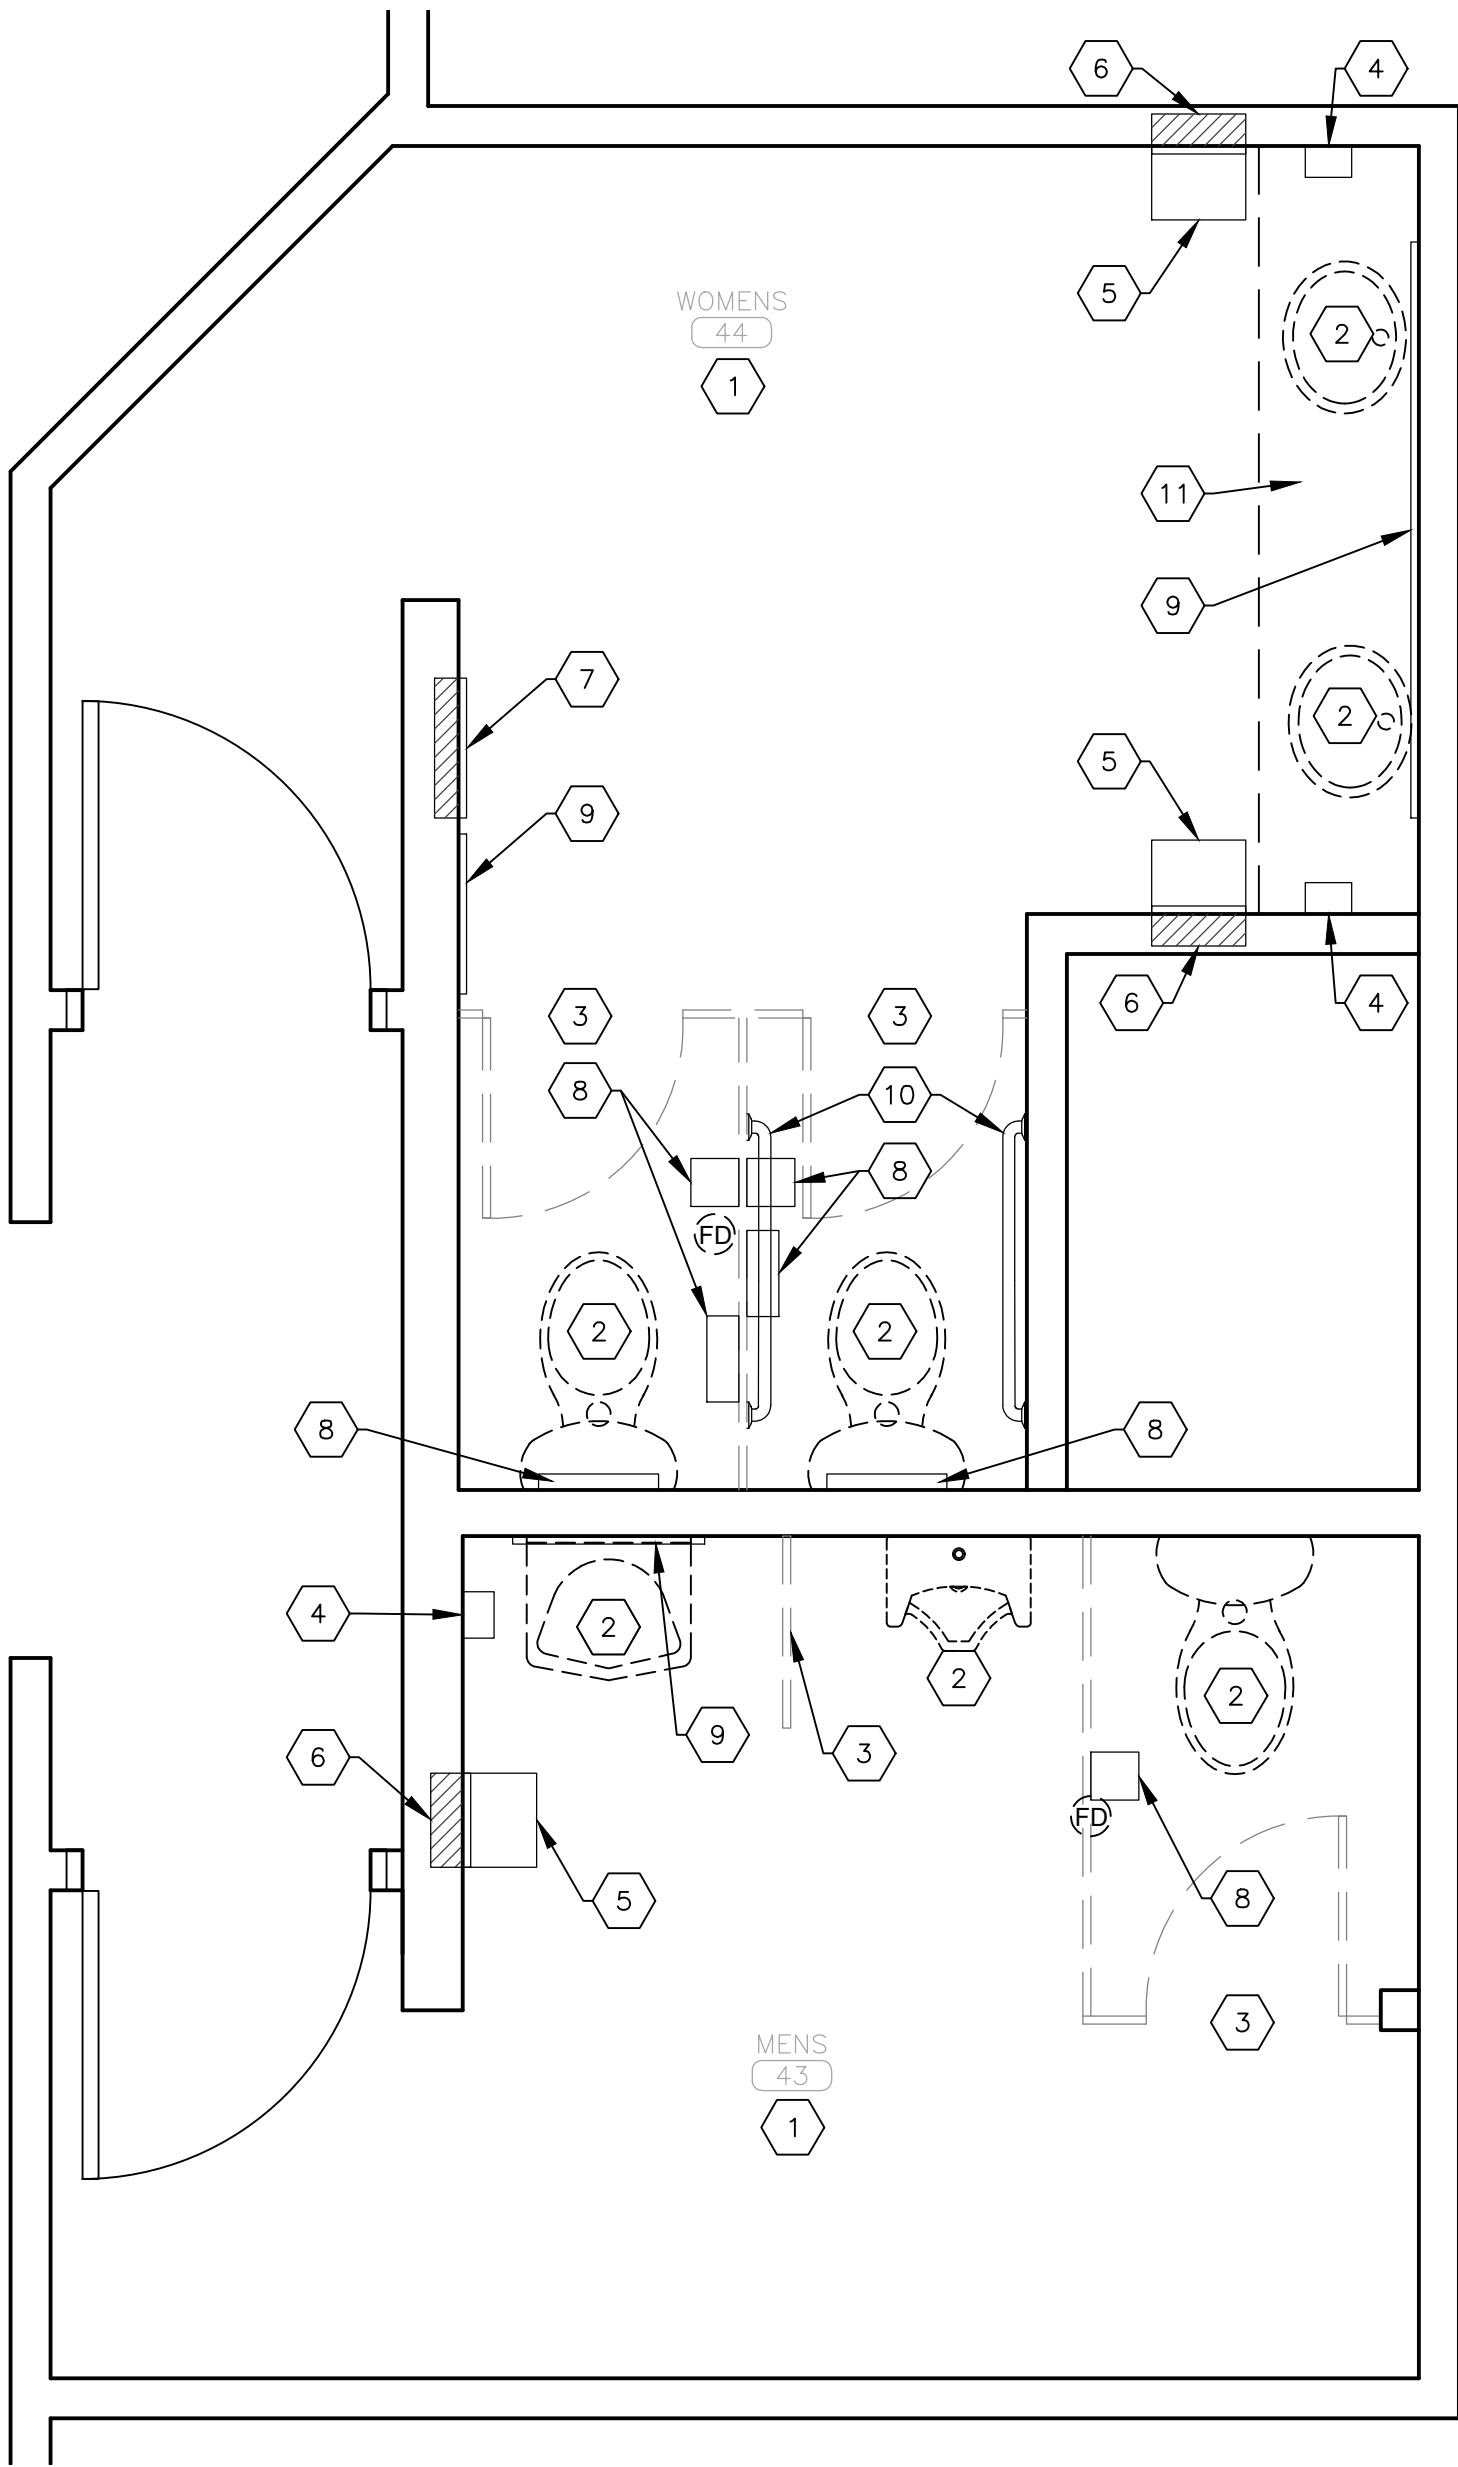

1 **ALTERNATE NO. 2 - SECOND FLOOR RESTROOM DEMOLITION PLAN**
SCALE: 1/2" = 1'-0"

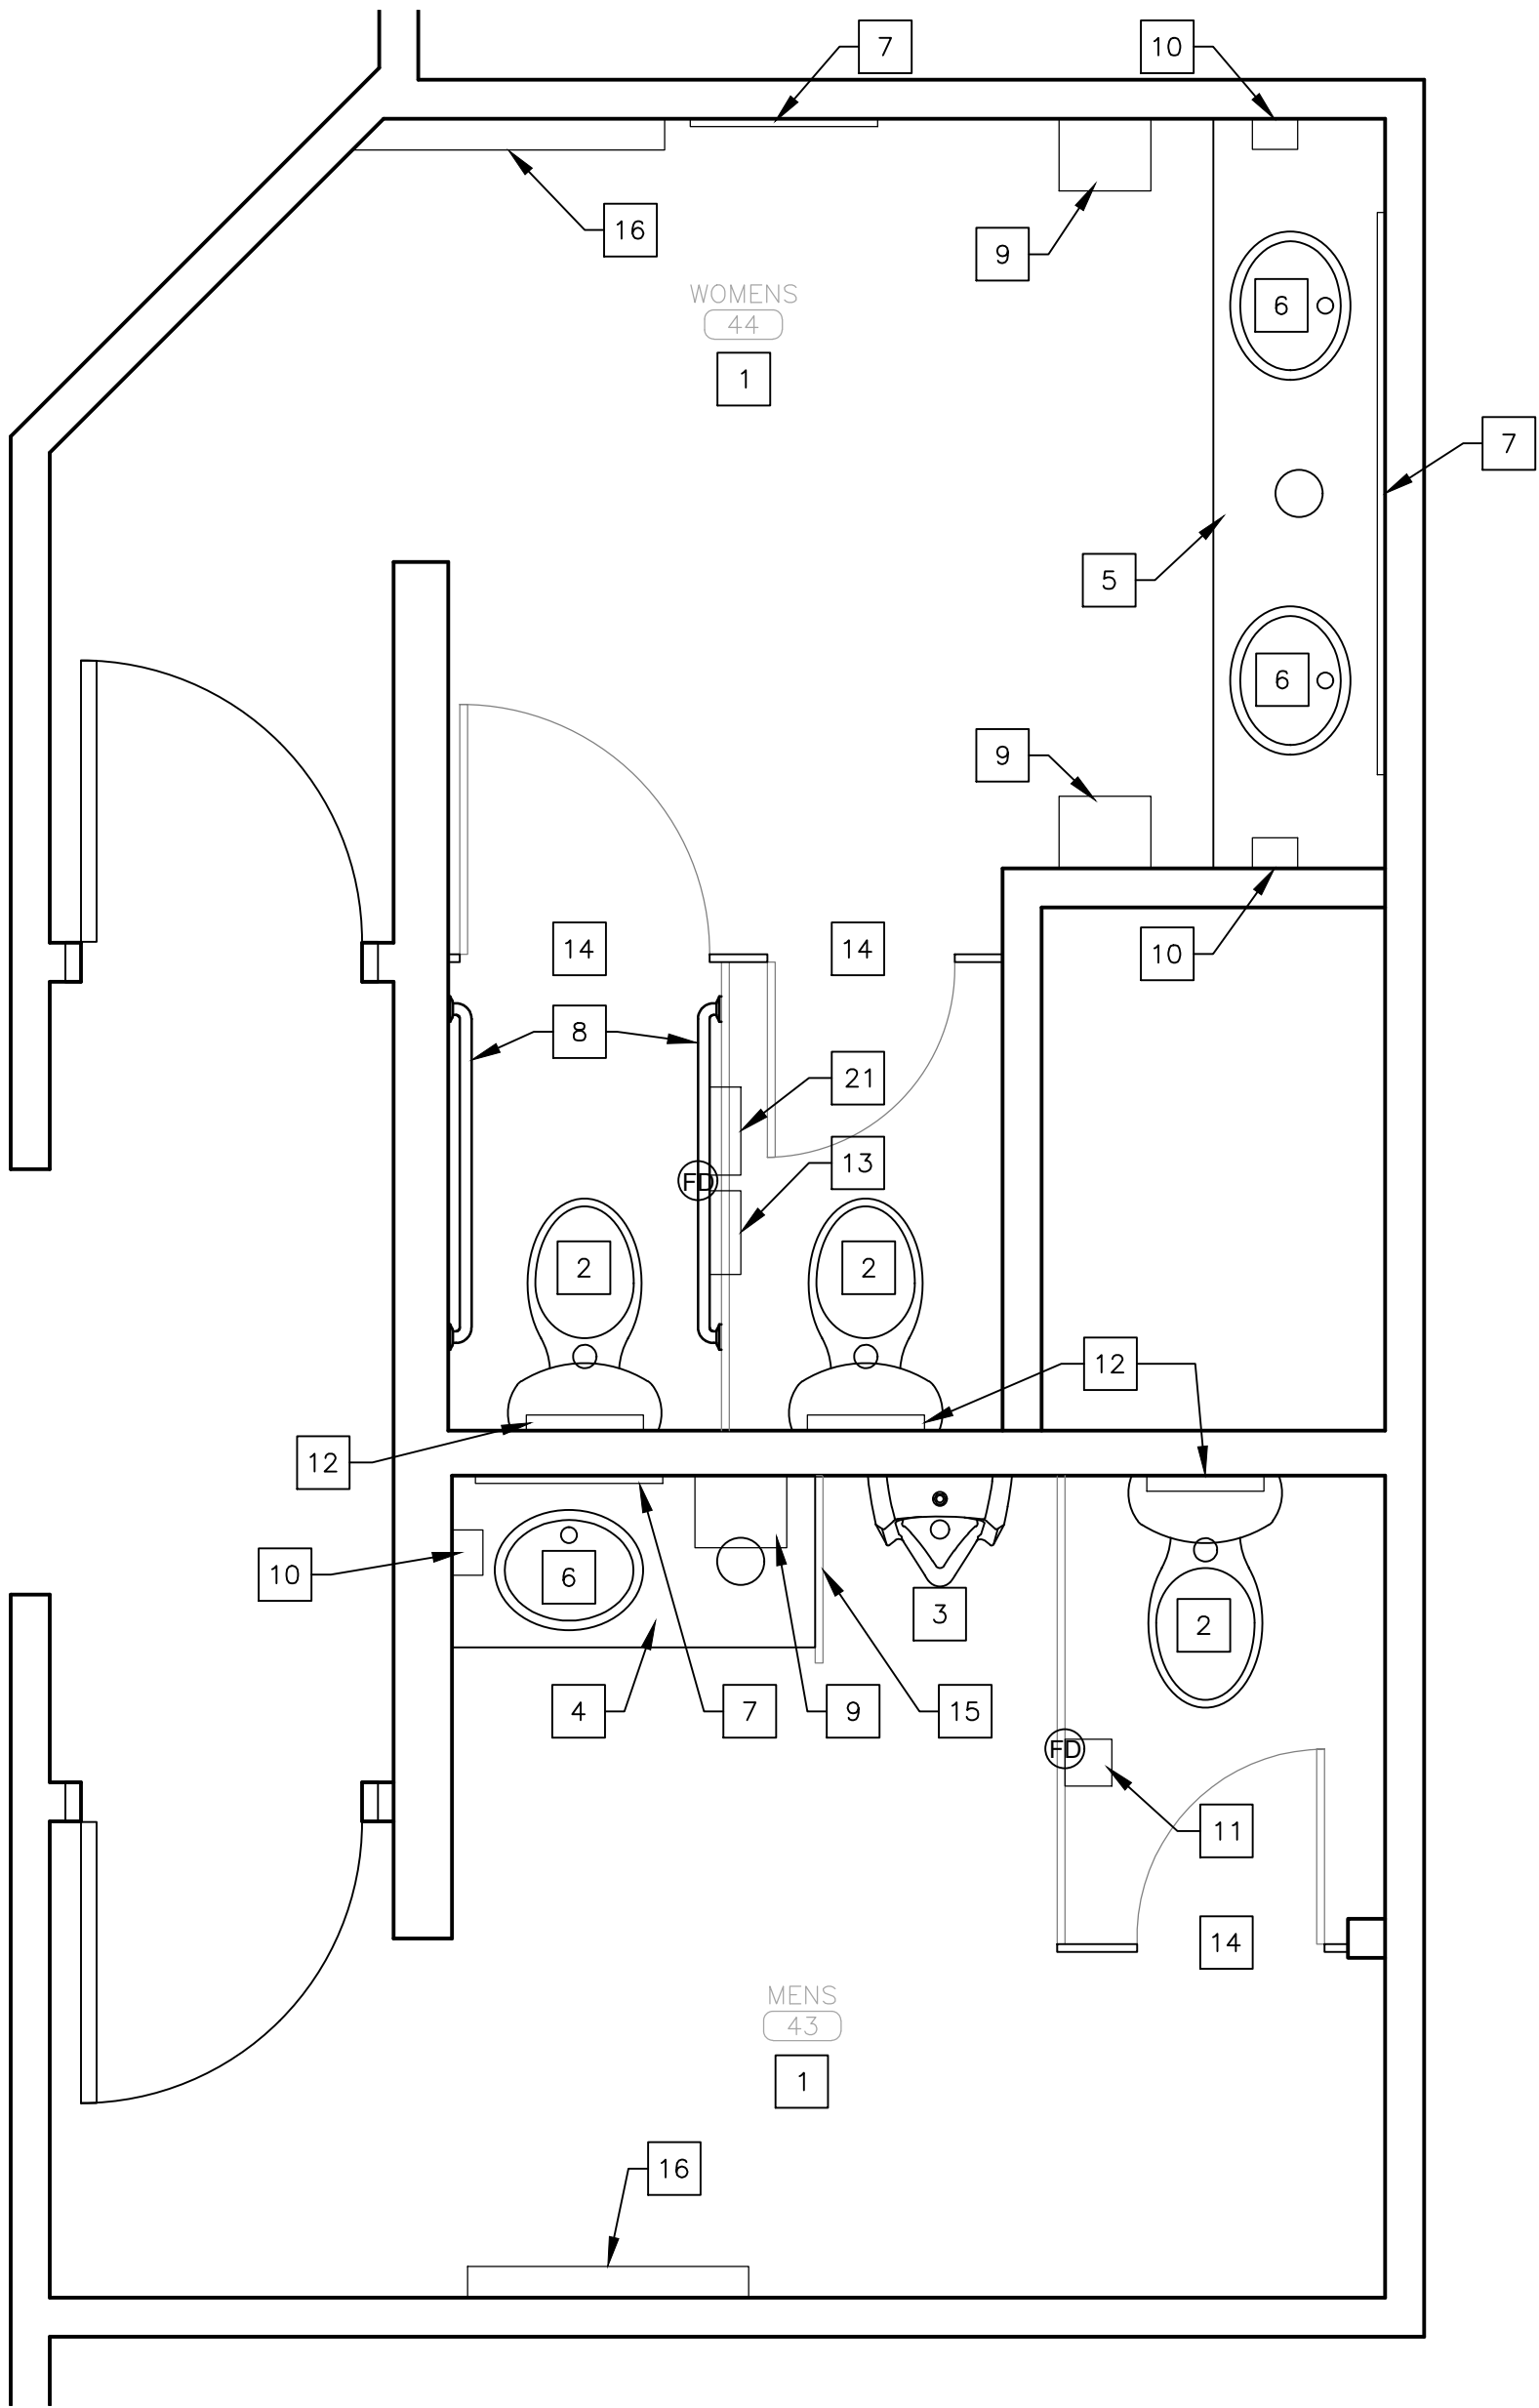

2 **ALTERNATE NO. 2 - SECOND FLOOR RESTROOM RENOVATION PLAN**
SCALE: 1/2" = 1'-0"
NOTE: REFER TO SHEET A-206 FOR PARTITION ELEVATIONS

ALTERNATE NO. 2 - DEMOLITION KEYNOTES:


- 1 REMOVE EXISTING CERAMIC WALL TILE TO FULL EXTENTS OF THE ROOM, AND PREPARE EXISTING SUBSTRATE FOR NEW WALL TILE APPLICATION.
- 2 REMOVE EXISTING PLUMBING FIXTURES (LAVATORIES, TOILETS, URINALS). PREPARE EXISTING WALLS AND FLOORS FOR NEW FIXTURES. REFER TO PLUMBING DRAWINGS FOR DETAILS.
- 3 REMOVE EXISTING TOILET PARTITIONS AND URINAL SCREENS. PATCH AND REPAIR WALL AND FLOORS. PREPARE FOR NEW PARTITIONS.
- 4 REMOVE EXISTING SOAP DISPENSER AND SALVAGE FOR REUSE.
- 5 REMOVE EXISTING WALL MOUNTED PAPER TOWEL DISPENSER AND SALVAGE FOR REUSE.
- 6 REMOVE EXISTING RECESSED PAPER TOWEL/WASTE RECEPTACLE UNIT. REPAIR HOLE IN WALL AND PREPARE WALL SURFACE FOR NEW WALL TILE.
- 7 REMOVE EXISTING RECESSED SANITARY NAPKIN DISPENSER. REPAIR HOLE IN WALL AND PREPARE WALL SURFACE FOR NEW WALL TILE.
- 8 REMOVE EXISTING TOILET ACCESSORIES (TOILET PAPER DISPENSER, TOILET SEAT COVER DISPENSER, SANITARY NAPKIN DISPOSAL).
- 9 REMOVE EXISTING MIRROR.
- 10 REMOVE EXISTING GRAB BARS.
- 11 REMOVE EXISTING COUNTERTOP.
- 12 REMOVE EXISTING CEILING TILES AND SUSPENDED CEILING GRID. RELINQUISH FULL AND UNDAMAGED CEILING TILES TO OWNER.
- 13 REMOVE CEILING MOUNTED LIGHT FIXTURES AND AIR DIFFUSERS. REFER TO MECHANICAL AND ELECTRICAL DRAWINGS FOR DETAILS.

ALTERNATE NO. 2 - RENOVATION KEYNOTES:


- | | | | |
|----|---|----|---|
| 1 | 1. INSTALL NEW CERAMIC WALL TILE, TO FULL EXTENTS OF ROOM. | 14 | 14. FLOOR/WALL MOUNTED TOILET PARTITION. |
| 2 | 2. INSTALL NEW WATER CLOSET. REFER TO PLUMBING DRAWINGS FOR DETAILS. | 15 | 15. INSTALL NEW WALL MOUNT URINAL PARTITION. |
| 3 | 3. INSTALL NEW URINAL. REFER TO PLUMBING DRAWINGS FOR DETAILS. | 16 | 16. INSTALL CUSTOM SOLID SURFACE SHELF WITH UNDERMOUNT STAINLESS STEEL HOOKS. REFER TO A-501 FOR DETAILS. |
| 4 | 4. INSTALL NEW SOLID SURFACE COUNTERTOP WITH CIRCULAR WASTE CHUTE. ENSURE SUPPORT BRACKETS ARE ATTACHED TO EXISTING WALL STUDS. REFER TO A-501 FOR DETAILS. | 17 | 17. INSTALL NEW 2'x2' SUSPENDED CEILING GRID AND ACOUSTIC CEILING TILE. |
| 5 | 5. INSTALL NEW SOLID SURFACE COUNTERTOP WITH CIRCULAR WASTE CHUTE. CENTERED BETWEEN LAVATORIES. REFER TO A-XXX FOR ELEVATIONS. | 18 | 18. INSTALL NEW SUSPENDED DRYWALL FRAMING SYSTEM FOR DRYWALL SOFFIT. PROVIDE LEVEL 4 FINISH AND PAINT. |
| 6 | 6. INSTALL NEW UNDERMOUNT SINK AND FAUCET. REFER TO PLUMBING DRAWINGS FOR DETAILS. | 19 | 19. INSTALL NEW CEILING AIR DIFFUSERS. REFER TO MECHANICAL DRAWINGS FOR DETAILS. |
| 7 | 7. INSTALL NEW MIRROR. | 20 | 20. INSTALL NEW CEILING LIGHT FIXTURES. REFER TO ELECTRICAL DRAWINGS FOR DETAILS. |
| 8 | 8. INSTALL NEW GRAB BARS. | 21 | 21. INSTALL NEW PARTITION-MOUNTED DUAL-SIDED TOILET PAPER DISPENSER. |
| 9 | 9. REINSTALL WALL MOUNTED PAPER TOWEL DISPENSER. | | |
| 10 | 10. REINSTALL SOAP DISPENSER. | | |
| 11 | 11. INSTALL NEW SURFACE MOUNT TOILET PAPER DISPENSER. | | |
| 12 | 12. INSTALL NEW TOILET SEAT COVER DISPENSER. | | |
| 13 | 13. INSTALL NEW DUAL ACCESS SANITARY NAPKIN DISPOSAL. | | |

LEGEND


- | | |
|--|--------------------|
| | CEILING HEIGHT TAG |
| | FLOOR DRAIN - DEMO |
| | FLOOR DRAIN - NEW |
| | WALL REPAIR |
| | DRYWALL CEILING |
| | RECESSED CAN LIGHT |

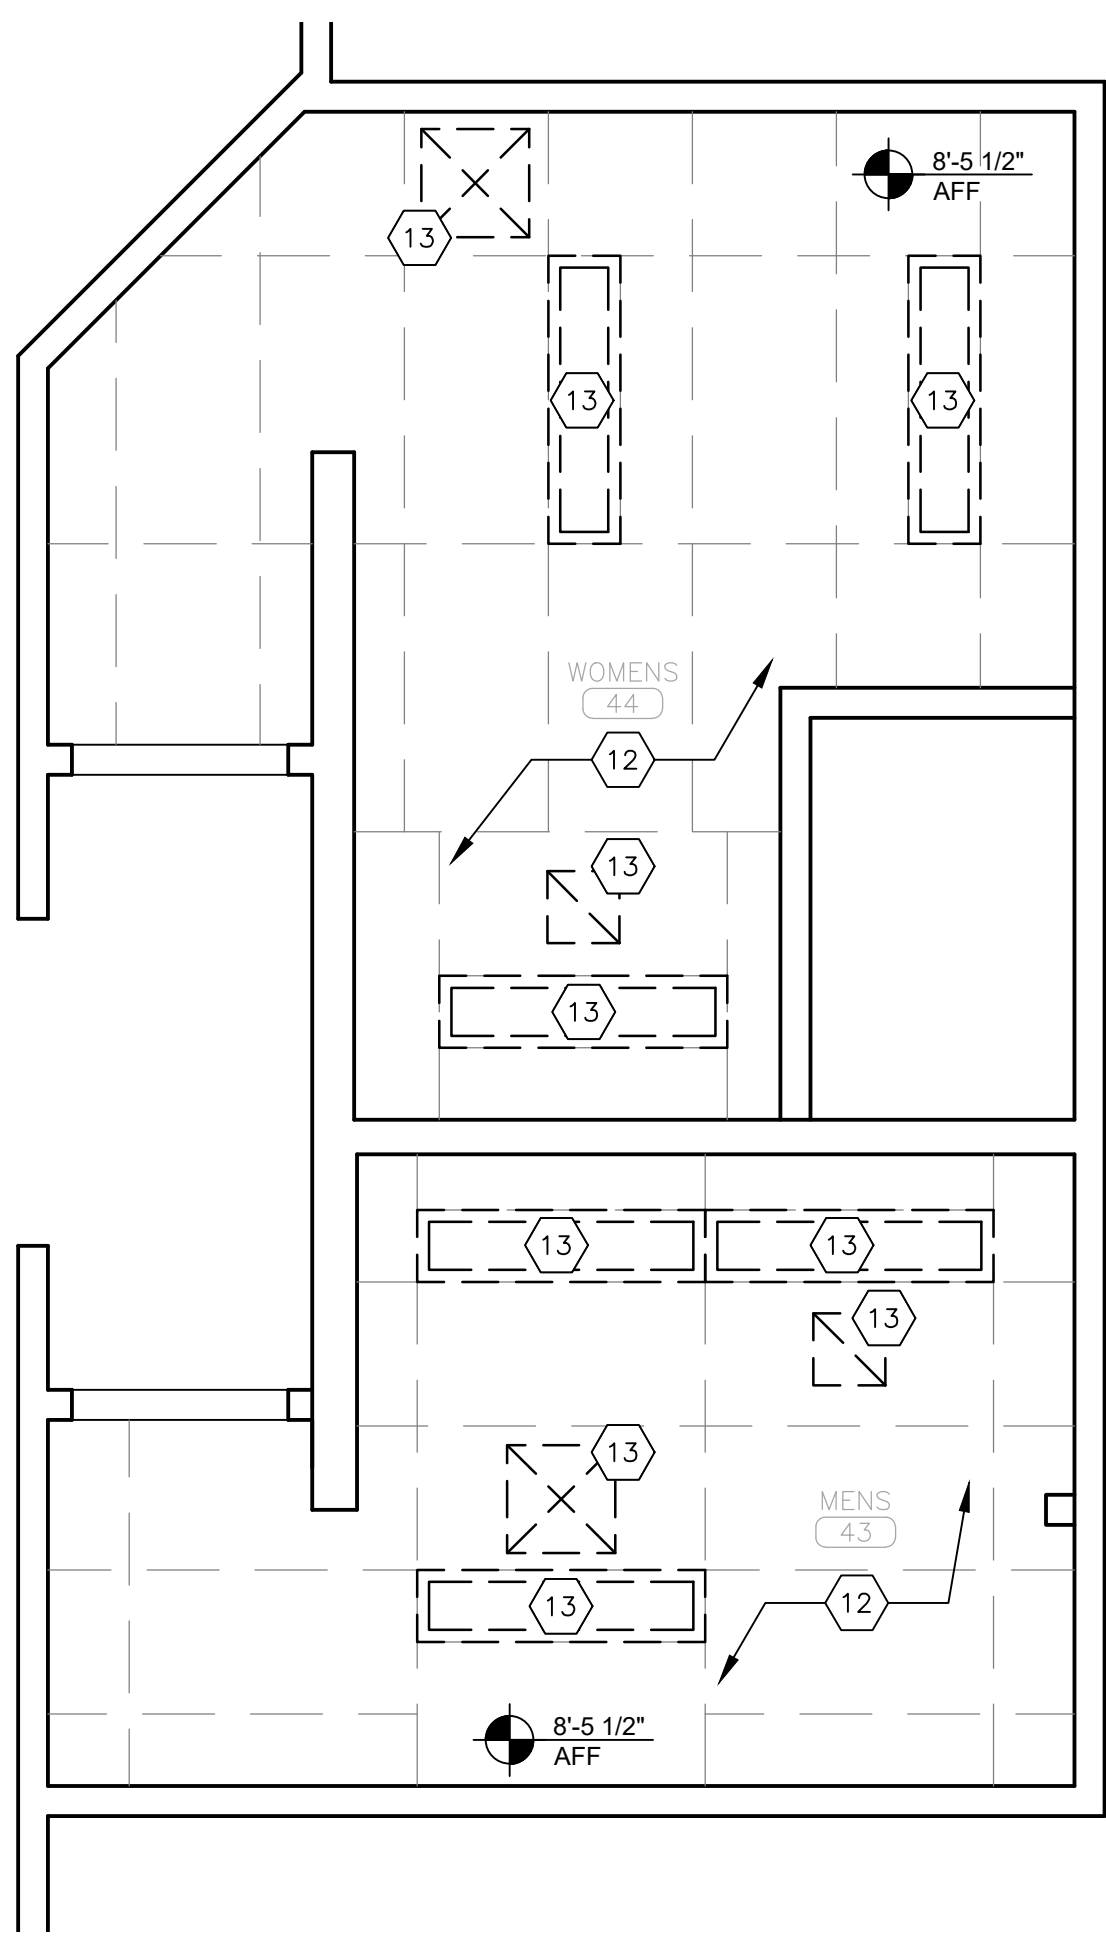


3 **ALTERNATE NO. 2 - SECOND FLOOR RESTROOM RENOVATION RCP**
SCALE: 3/8" = 1'-0"

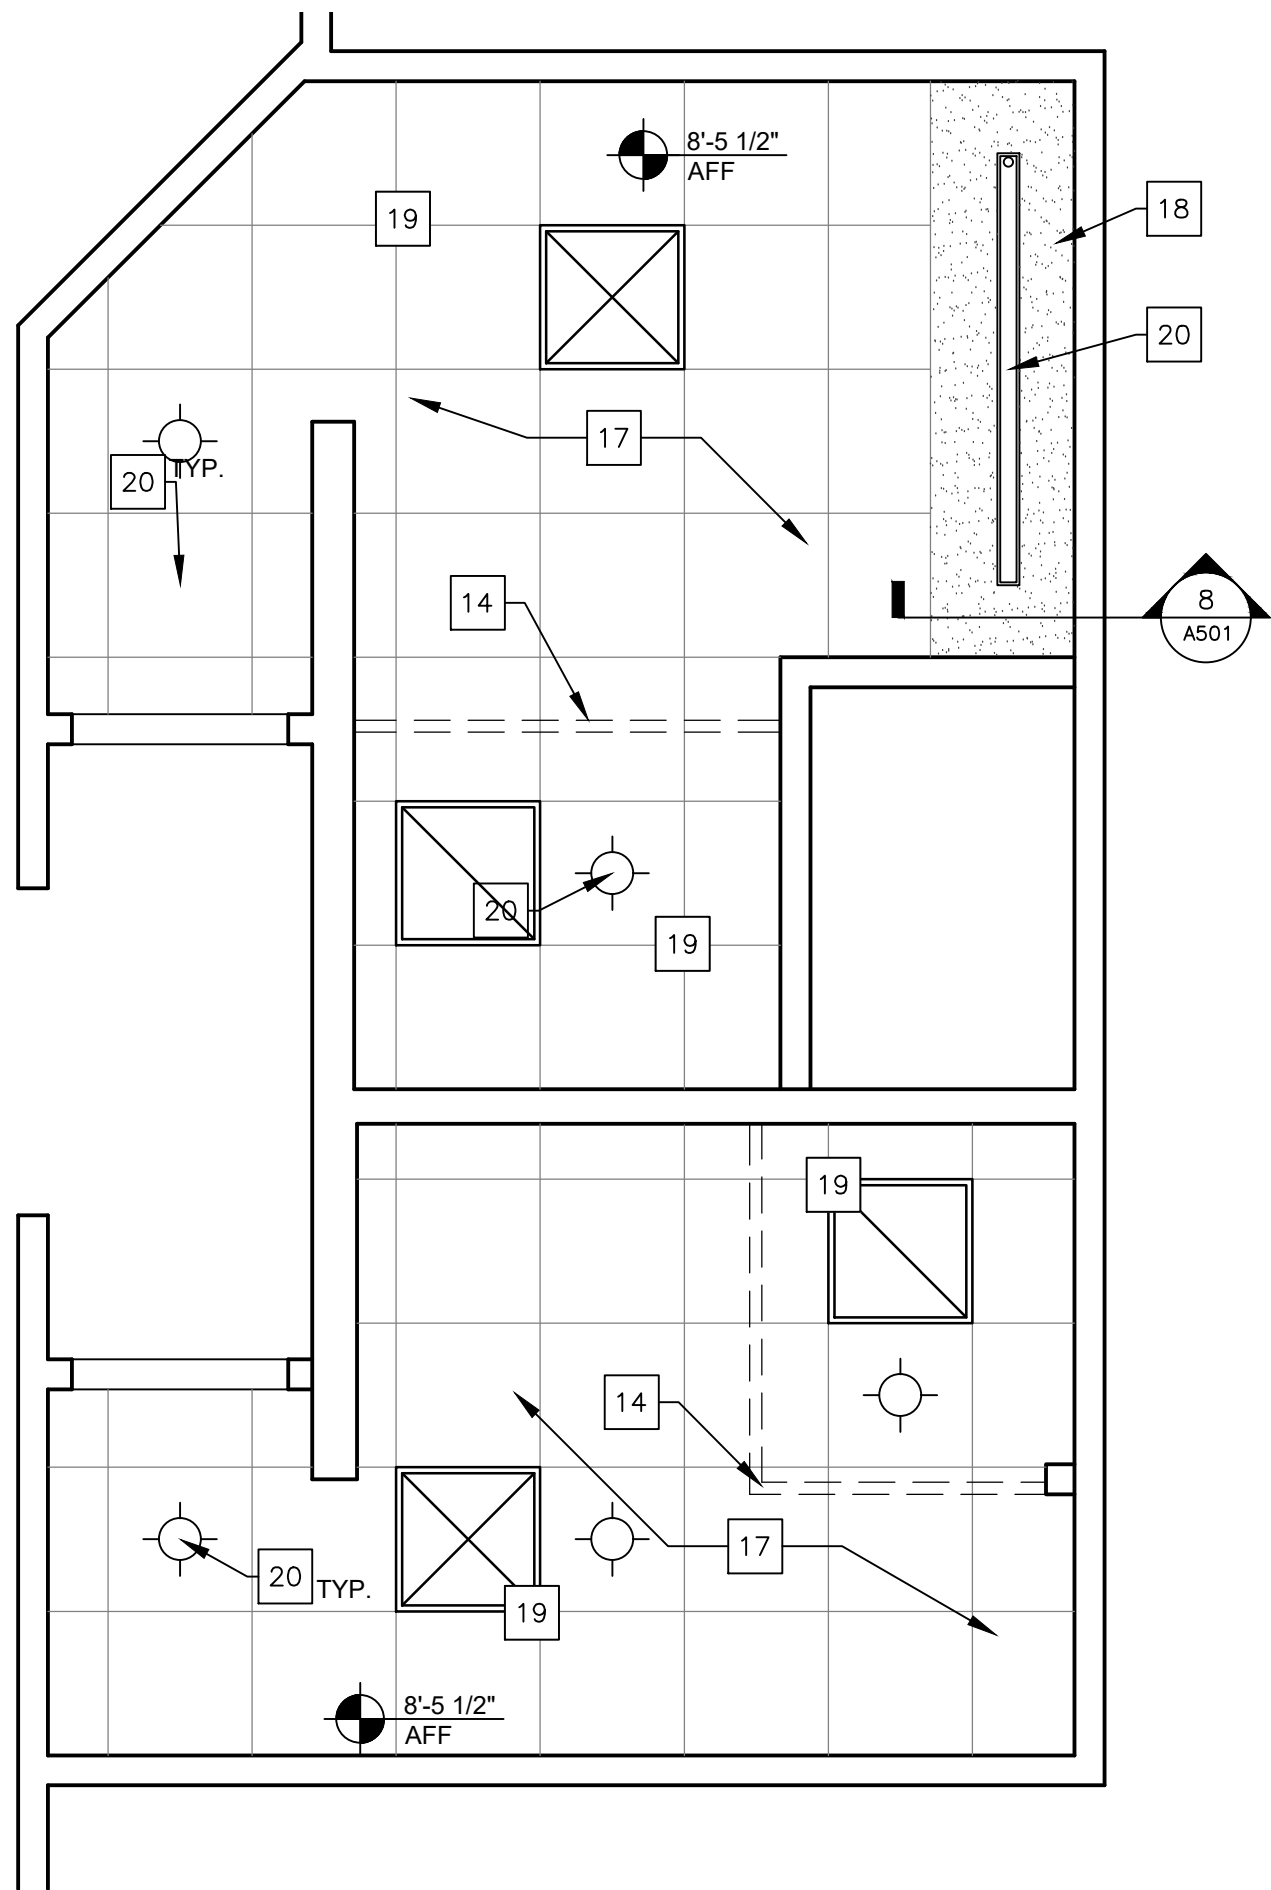


4 **ALTERNATE NO. 2 - SECOND FLOOR RESTROOM RENOVATION RCP**
SCALE: 3/8" = 1'-0"

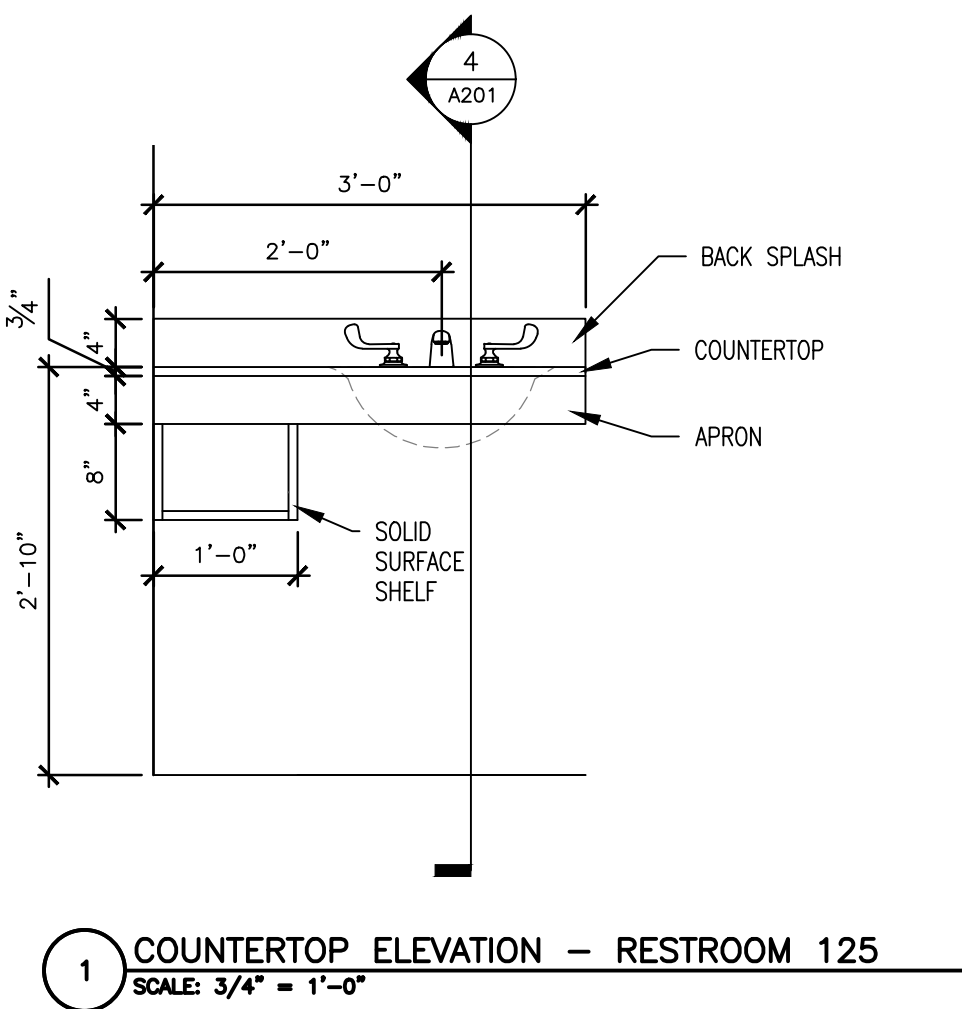


1 COUNTERTOP ELEVATION — RESTROOM 125
SCALE: 3/4" = 1'-0"

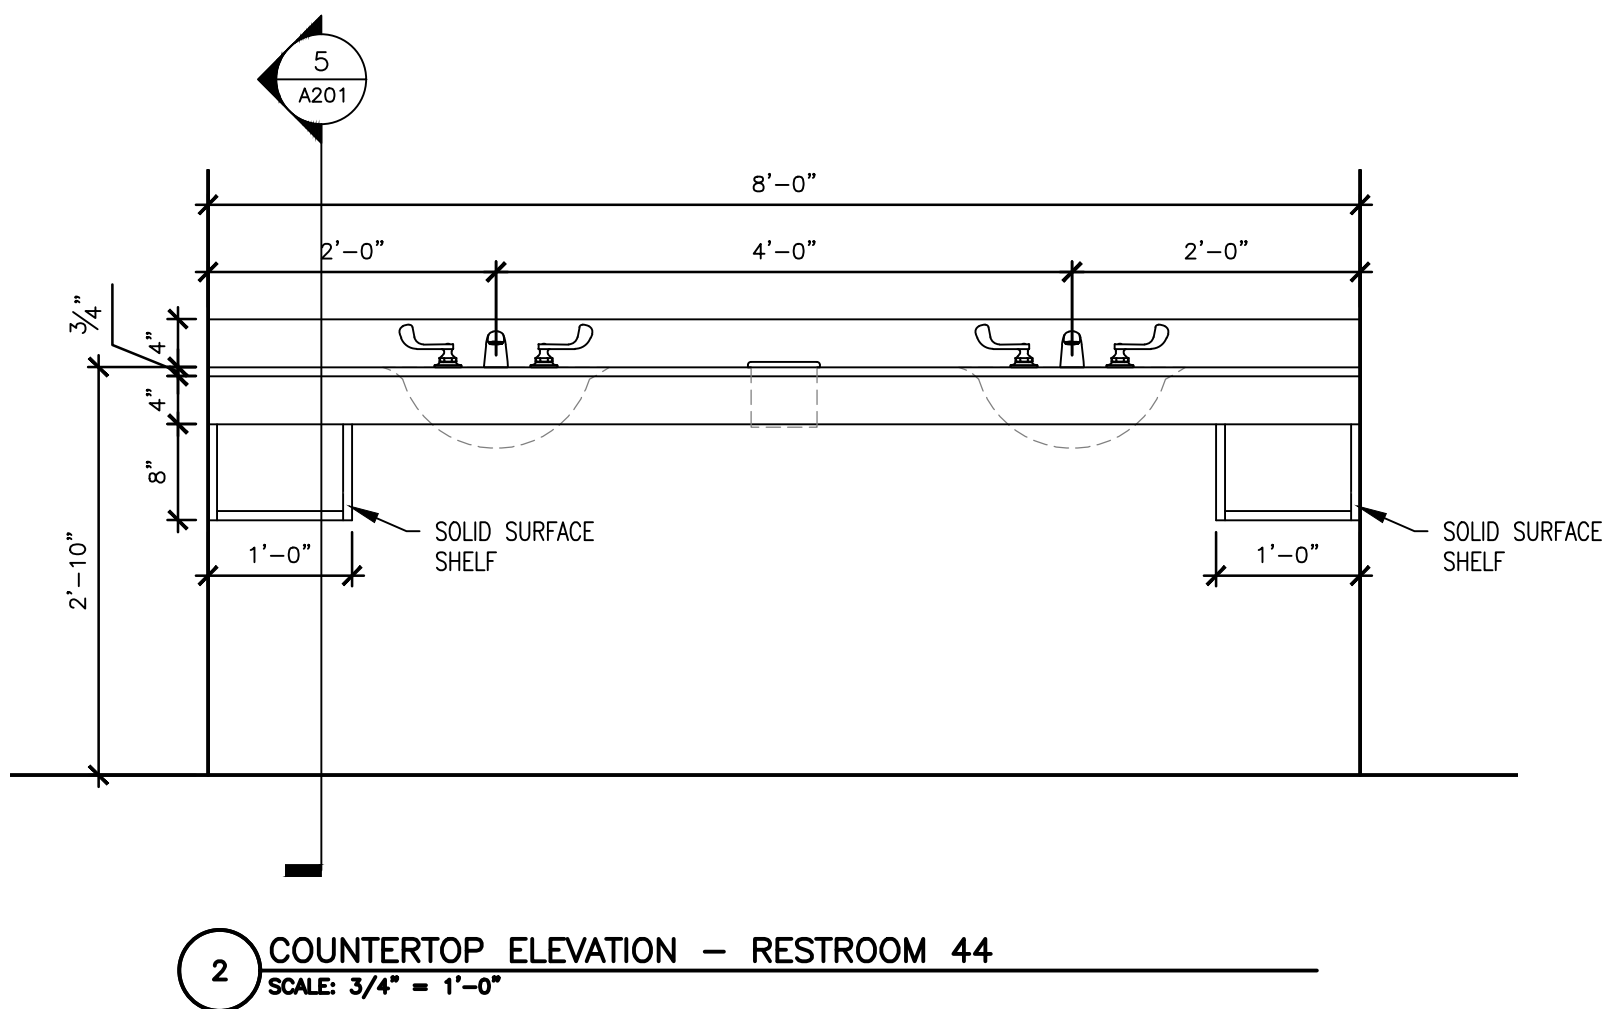


2 COUNTERTOP ELEVATION — RESTROOM 44
SCALE: 3/4" = 1'-0"

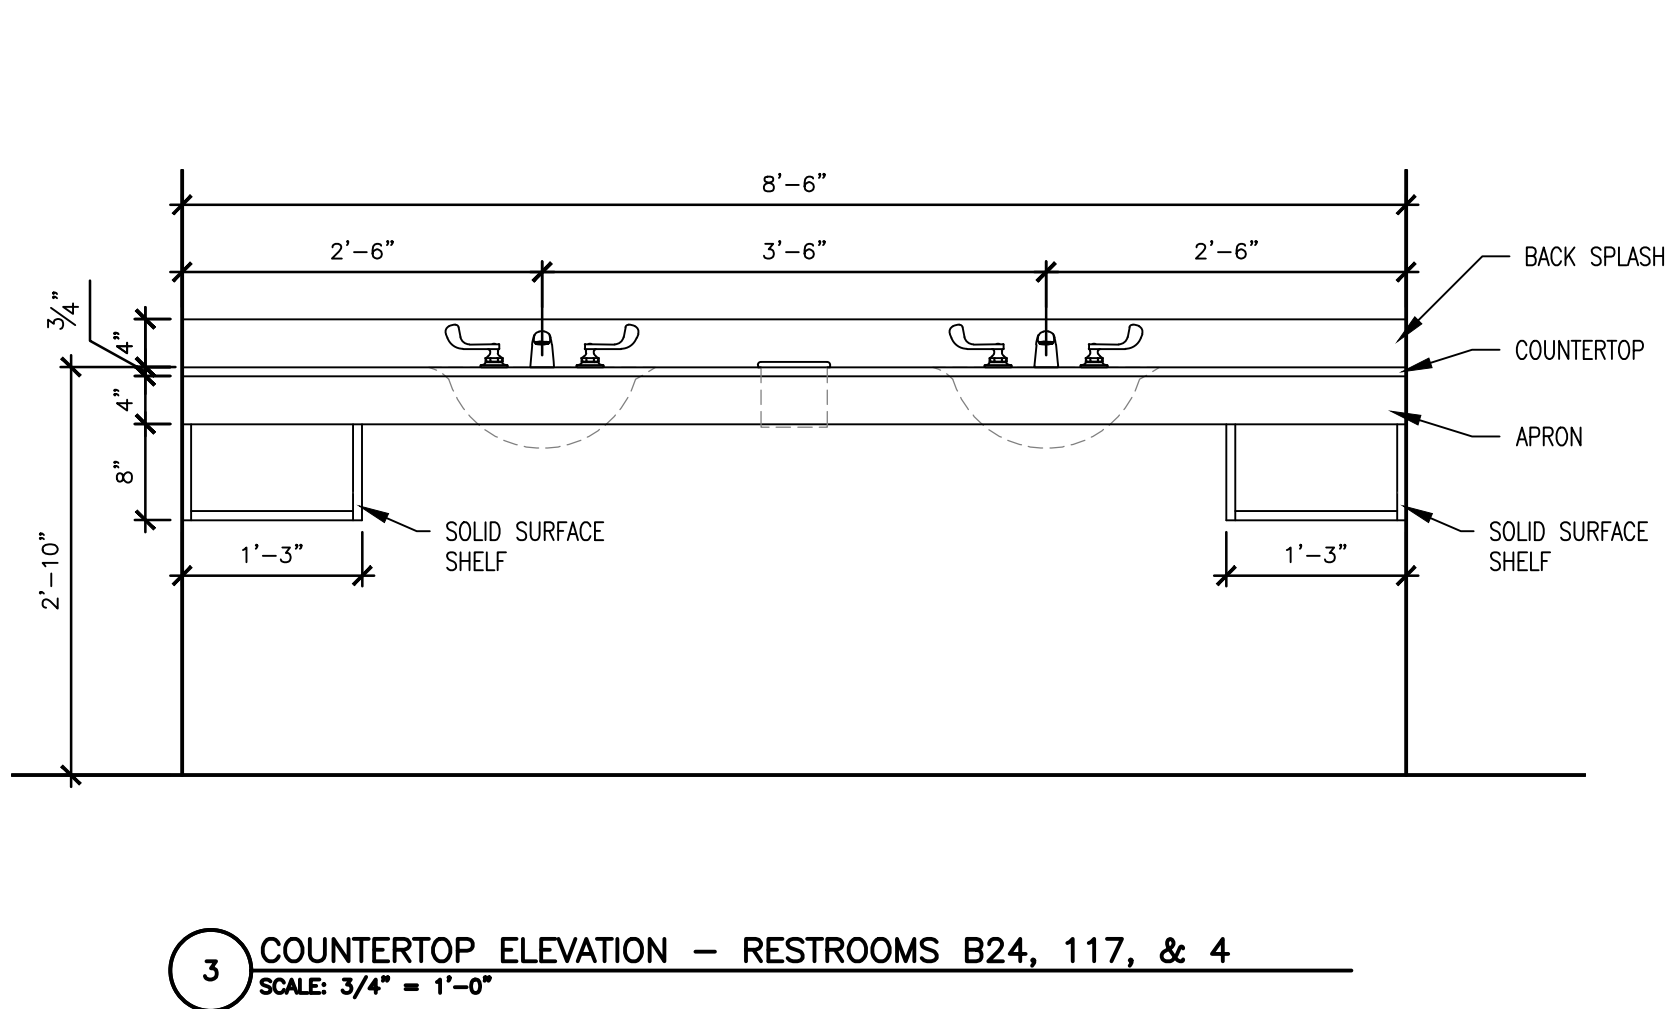


3 COUNTERTOP ELEVATION — RESTROOMS B24, 117, & 4
SCALE: 3/4" = 1'-0"

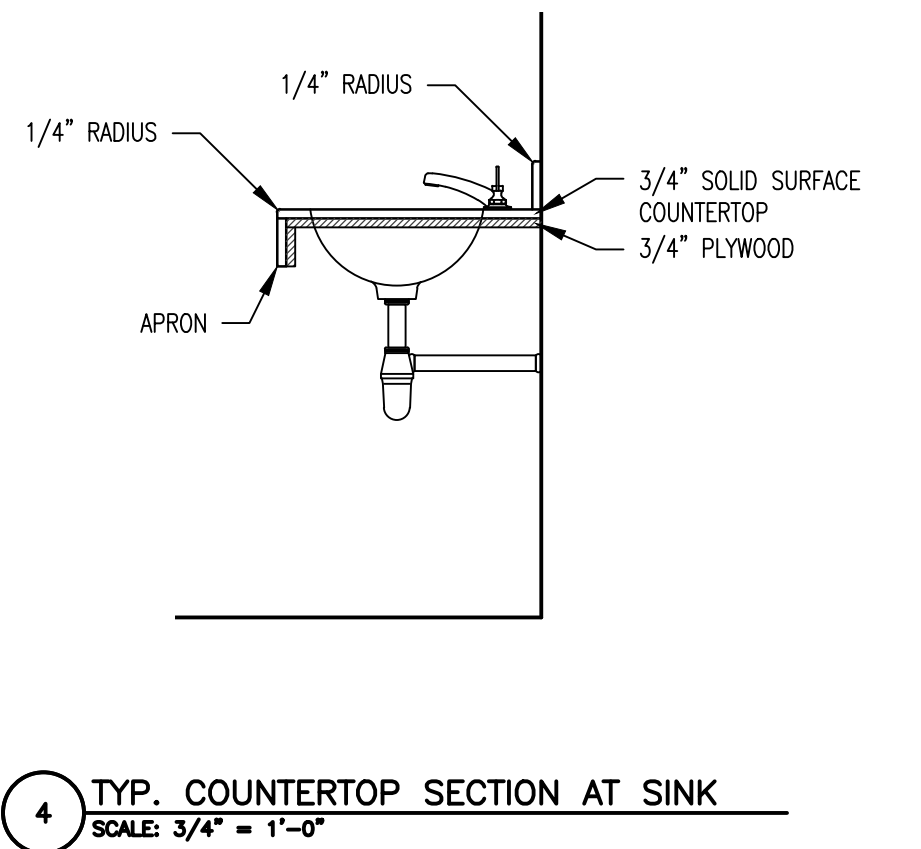


4 TYP. COUNTERTOP SECTION AT SINK
SCALE: 3/4" = 1'-0"

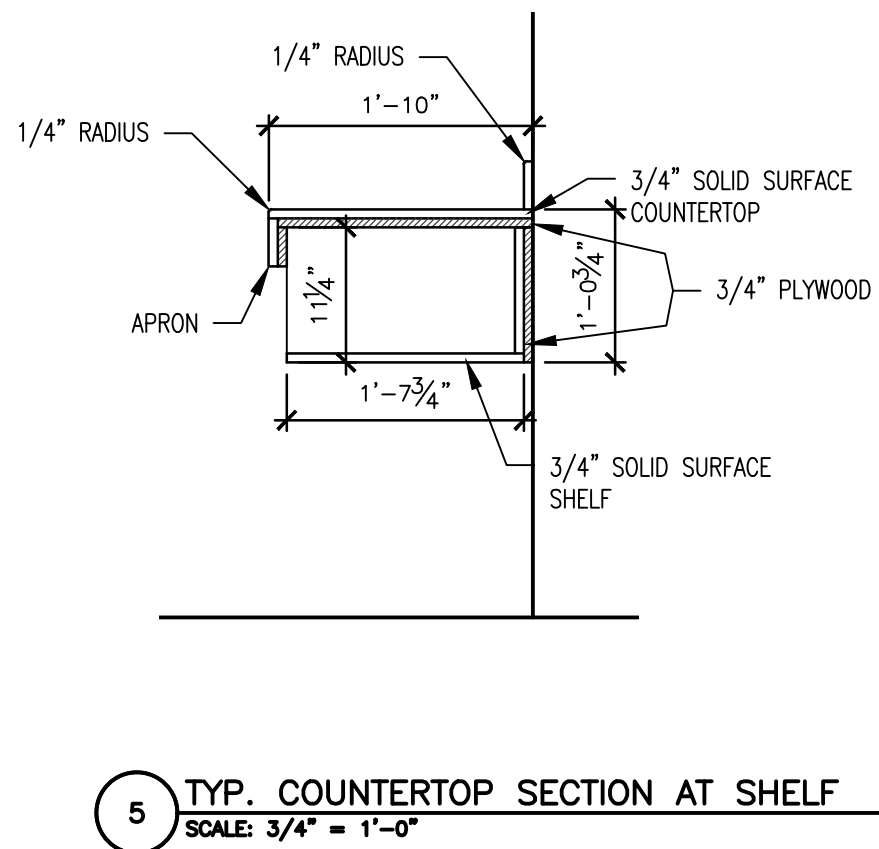


5 TYP. COUNTERTOP SECTION AT SHELF
SCALE: 3/4" = 1'-0"

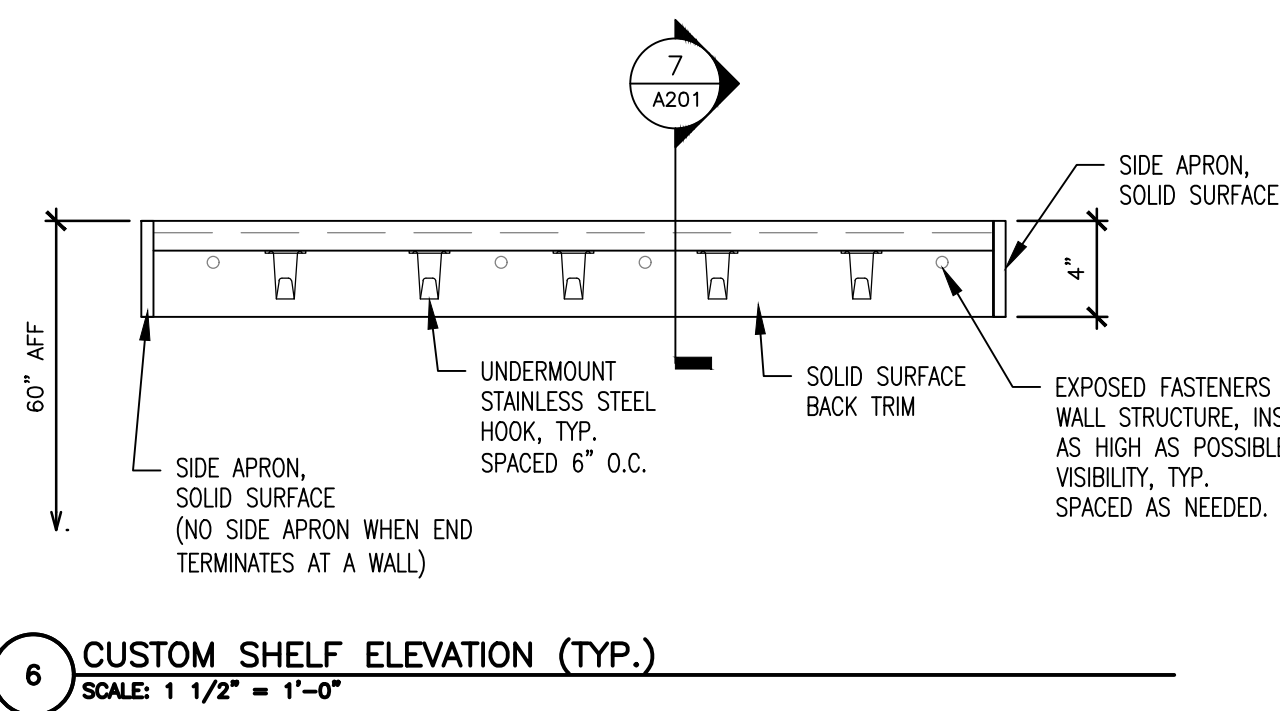


6 CUSTOM SHELF ELEVATION (TYP.)
SCALE: 1 1/2" = 1'-0"

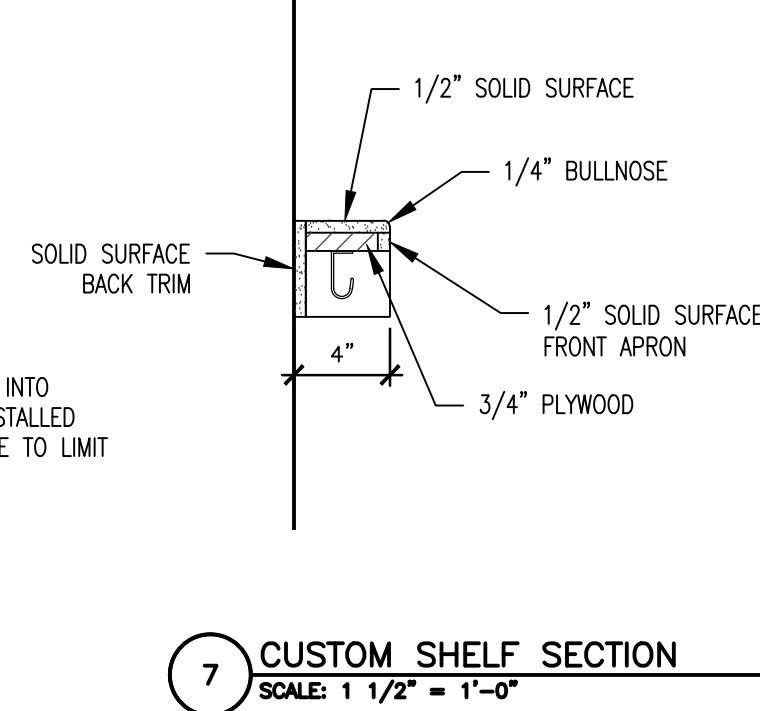


7 CUSTOM SHELF SECTION
SCALE: 1 1/2" = 1'-0"

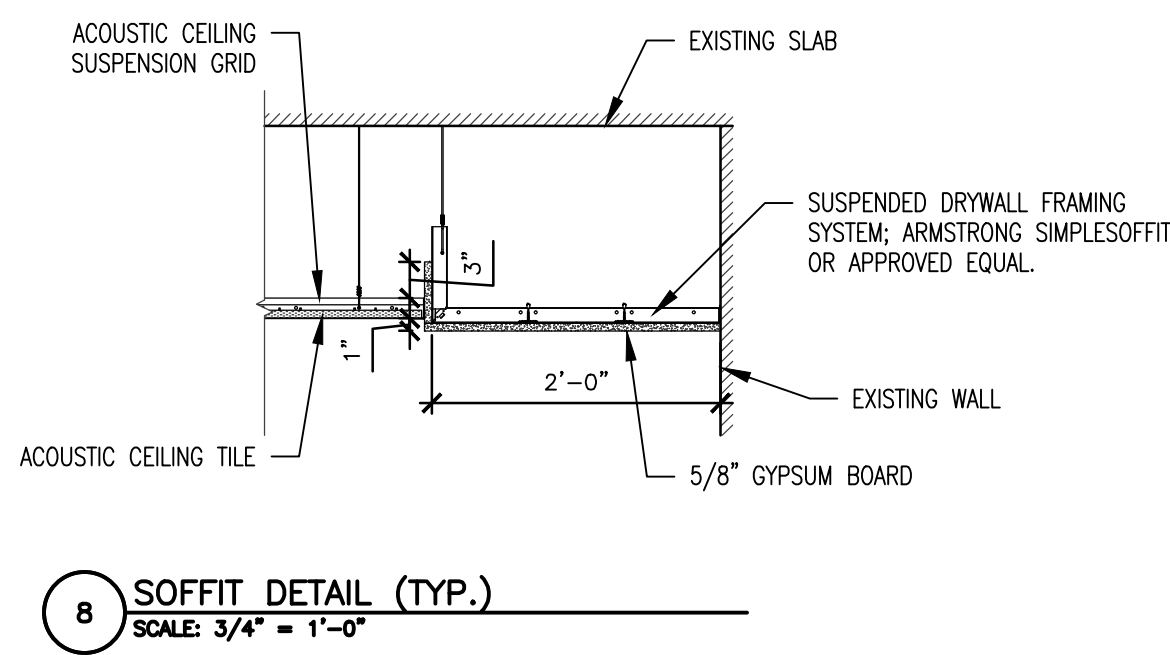


8 SOFFIT DETAIL (TYP.)
SCALE: 3/4" = 1'-0"

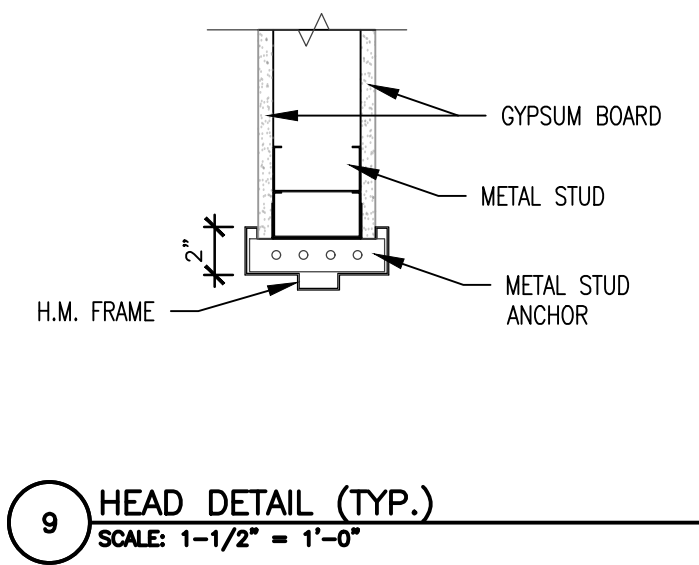

9 HEAD DETAIL (TYP.)
SCALE: 1-1/2" = 1'-0"

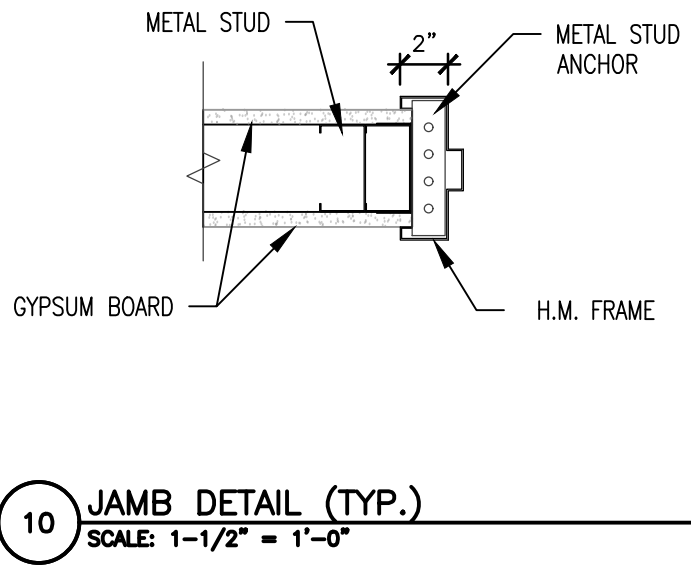

10 JAMB DETAIL (TYP.)
SCALE: 1-1/2" = 1'-0"

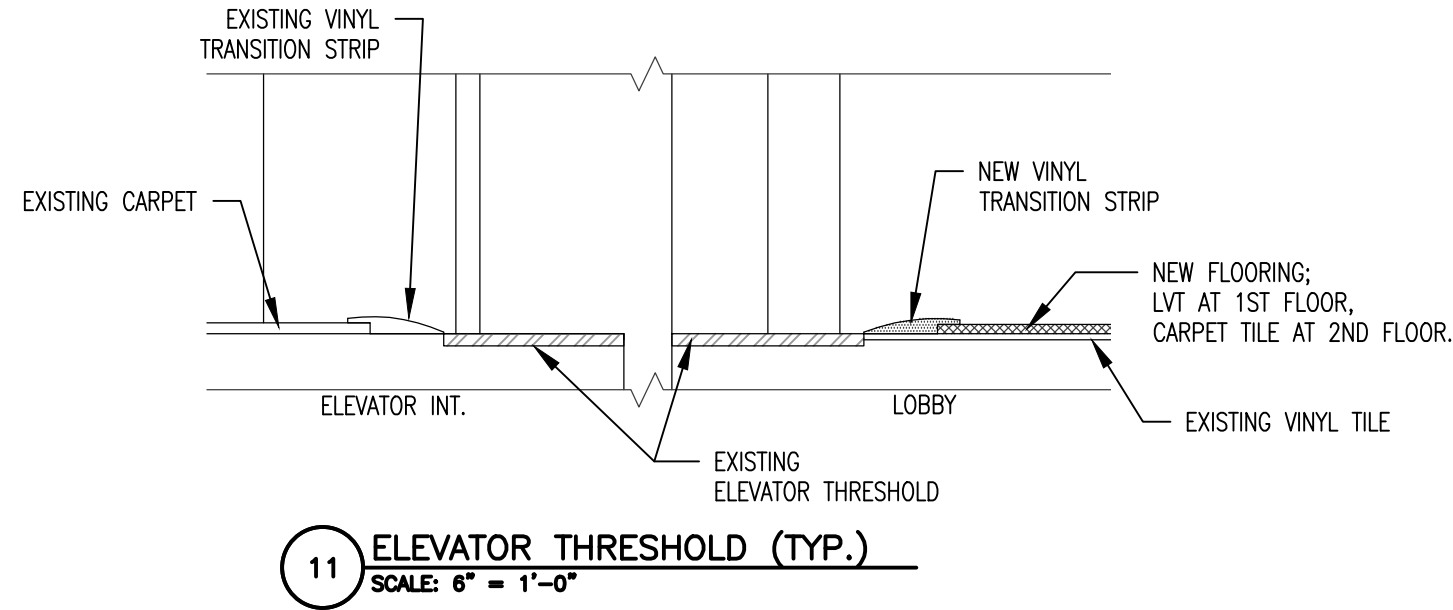

11 ELEVATOR THRESHOLD (TYP.)
SCALE: 6" = 1'-0"

STATE OF MISSOURI
MIKE KEHOE,
GOVERNOR



Brad M. Schaefer - Architect
MO# A-2009027294

BID DOCUMENTS

OFFICE OF ADMINISTRATION
DIVISION OF FACILITIES
MANAGEMENT,
DESIGN AND CONSTRUCTION

DEPARTMENT OF
PUBLIC SAFETY
STATE HIGHWAY PATROL

RENOVATE INTERIOR

GENERAL HEADQUARTERS
1510 EAST ELM STREET
JEFFERSON CITY, MO 65101

PROJECT # R2410-01
SITE # 6001
ASSET # 8136001001

REVISION: _____
DATE: _____
REVISION: _____
DATE: _____
REVISION: _____
DATE: _____
ISSUE DATE: 06/18/2026

CAD DWG FILE: _____
DRAWN BY: CL
CHECKED BY: BMS
DESIGNED BY: CL


SHEET TITLE:

DETAILS

SHEET NUMBER:

A-501


18 OF 39 SHEETS
06/18/2026

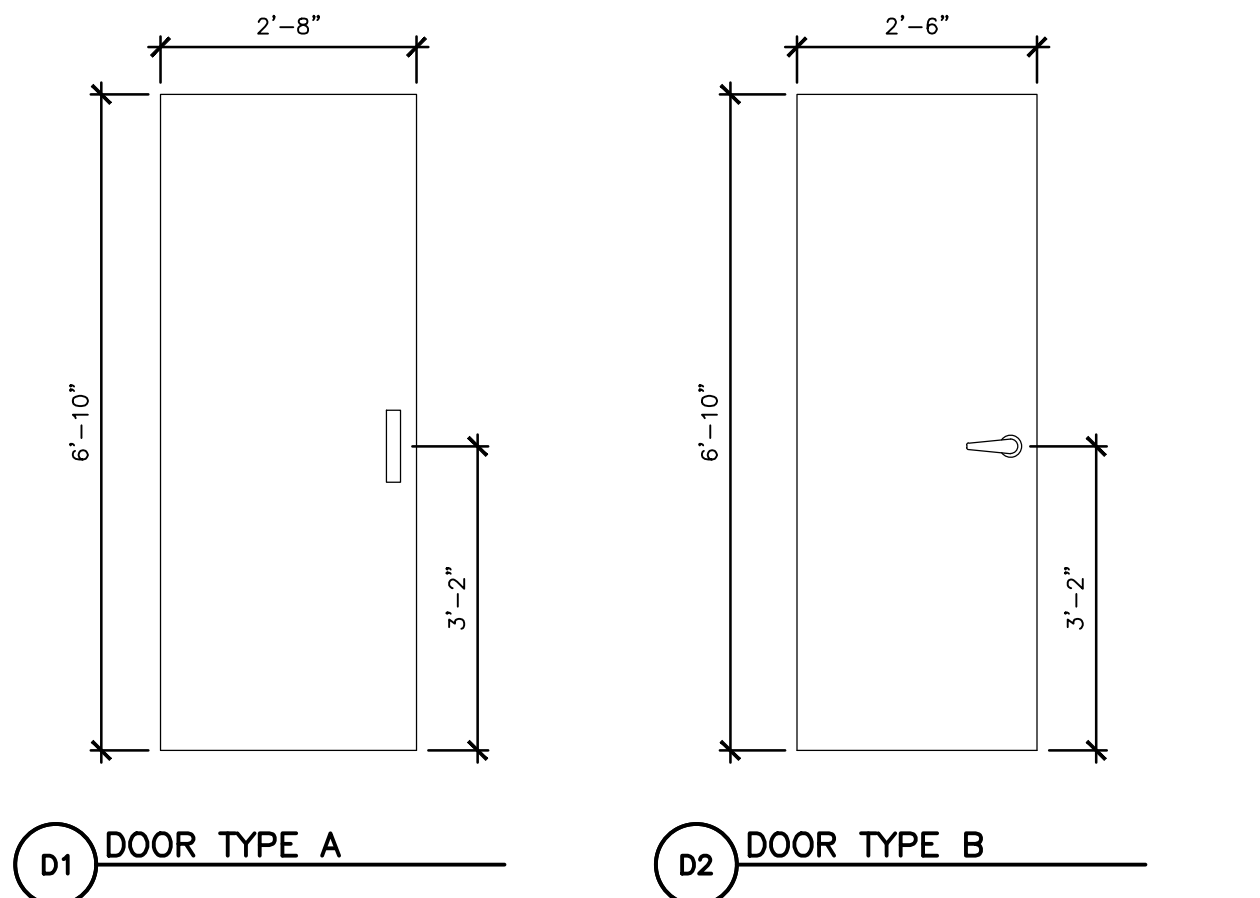

1 DOOR TYPE SCHEDULE
SCALE: 1/2" = 1'-0"


DOOR & FRAME SCHEDULE										
MARK	LOCATION	DOOR					FRAME			NOTES
		SIZE	MATL	GLAZING	TYPE	FINISH	MATL	TYPE	FINISH	
D1	MENS RESTROOM	6'-10" X 2'-8"	WOOD	N/A	A	MATCH EXIST.	H.M.	A	MATCH EXIST.	1
D2	JAN. CLOSET	6'-10" X 2'-6"	WOOD	N/A	B	MATCH EXIST.	H.M.	B	MATCH EXIST.	2

DOOR HARDWARE LEGEND	
HARDWARE SET 1: SINGLE DOOR. LOCATION: RESTROOM 3 HINGES 1 PULL HANDLE 1 PUSH PLATE 1 DOOR CLOSER 1 KICK PLATE (PUSH SIDE)	
HARDWARE SET 2: SINGLE DOOR W/ STORAGE. LOCATION: JANITOR CLOSET 3 HINGES 1 CYLINDRICAL LEVER HANDLE, STOREROOM FUNCTION, LHR, 7-PIN CORE 1 DOOR CLOSER 1 KICK PLATE (INTERIOR SIDE)	
NOTE: COORDINATE WITH OWNER FOR KEYING. MOUNT OPERABLE PARTS BETWEEN 34" MINIMUM AND 48" MAXIMUM HEIGHT, FOR ADA COMPLIANCE.	

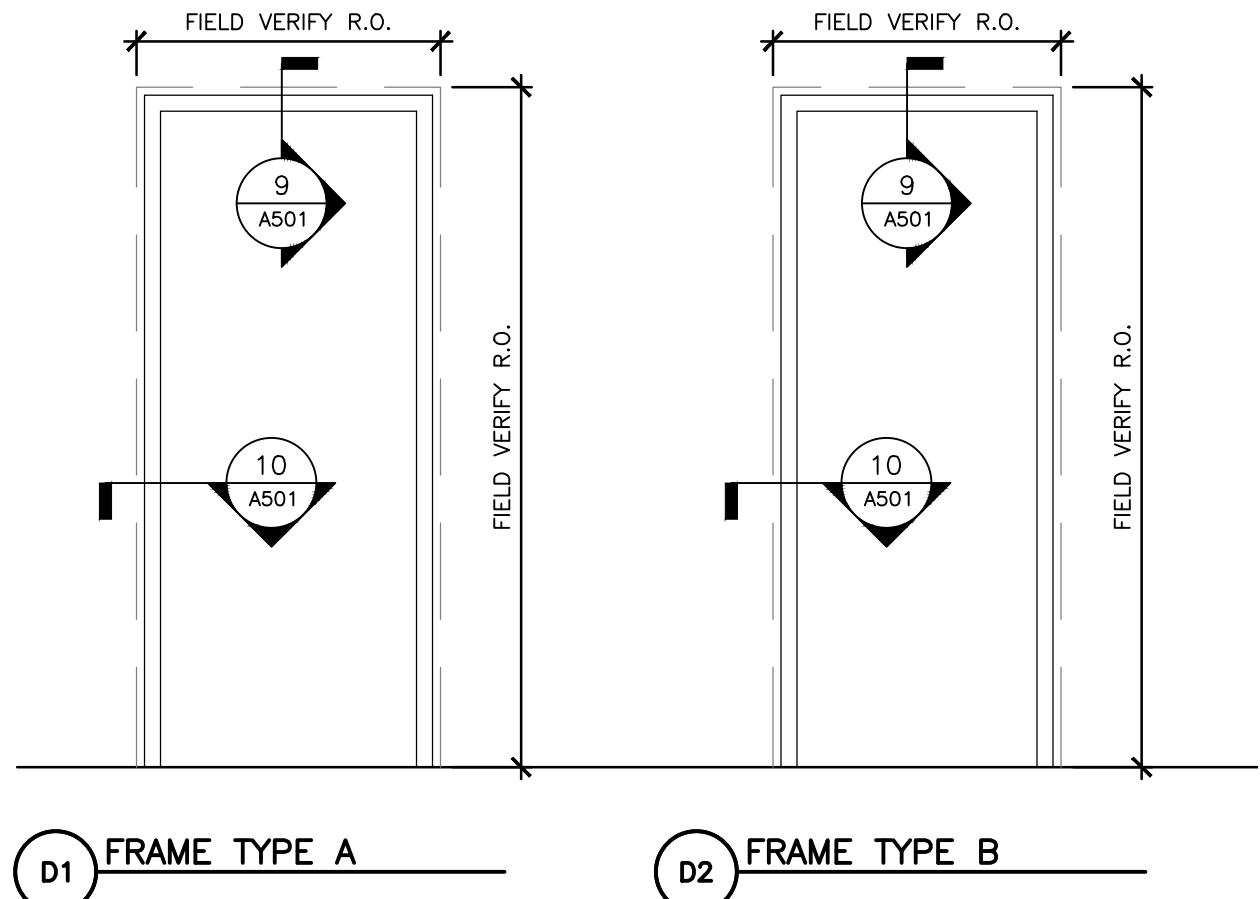

2 FRAME TYPE SCHEDULE
SCALE: 1/2" = 1'-0"

MARK	DESCRIPTION	BASIS-OF-DESIGN		REMARKS
		MANUFACTURER	MODEL	
TA-1	SOAP DISPENSER; SURFACE MOUNTED	—	—	REUSE EXISTING
TA-2	PAPER TOWEL DISPENSER; SURFACE MOUNTED	—	—	REUSE EXISTING
TA-3	TOILET SEAT COVER DISPENSER; SURFACE MOUNTED; MULTI-ROLL	BOBRICK	B-4221	
TA-4	TOILET PAPER DISPENSER; SURFACE MOUNTED	BOBRICK	B-2888	
TA-5	TOILET PAPER DISPENSER; PARTITION MOUNTED; DUAL-SIDED; MULTI-ROLL	BOBRICK	B-386	
TA-6	TOILET PAPER HOLDER; SURFACE MOUNTED	—	—	REUSE EXISTING
TA-7	SANITARY NAPKIN DISPOSAL; SURFACE MOUNTED	BOBRICK	B-254	
TA-8	SANITARY NAPKIN DISPOSAL; PARTITION MOUNTED; DUAL-ACCESS	BOBRICK	B-354	
TA-9	CIRCULAR WASTE CHUTE FOR MOUNTING IN COUNTERTOPS	BOBRICK	B-529	
GB-1	GRAB BAR; 18" LENGTH	BOBRICK	B-5806x18	
GB-2	GRAB BAR; 36" LENGTH	BOBRICK	B-5806x36	
GB-3	GRAB BAR; 42" LENGTH	BOBRICK	B-5806x42	
M-1	MIRROR WITH FRAME; 24" x 72"	BOBRICK	B-290 2472	
M-2	MIRROR WITH FRAME; 72" x 36"	BOBRICK	B-290 SERIES	SPECIAL-ORDER SIZE
M-3	MIRROR WITH FRAME; 18" x 30"	BOBRICK	B-290 1830	
M-4	MIRROR CABINET; SURFACE MOUNTED, 16" x 30", 3-1/2" DEEP	BASCO	WM326-W	

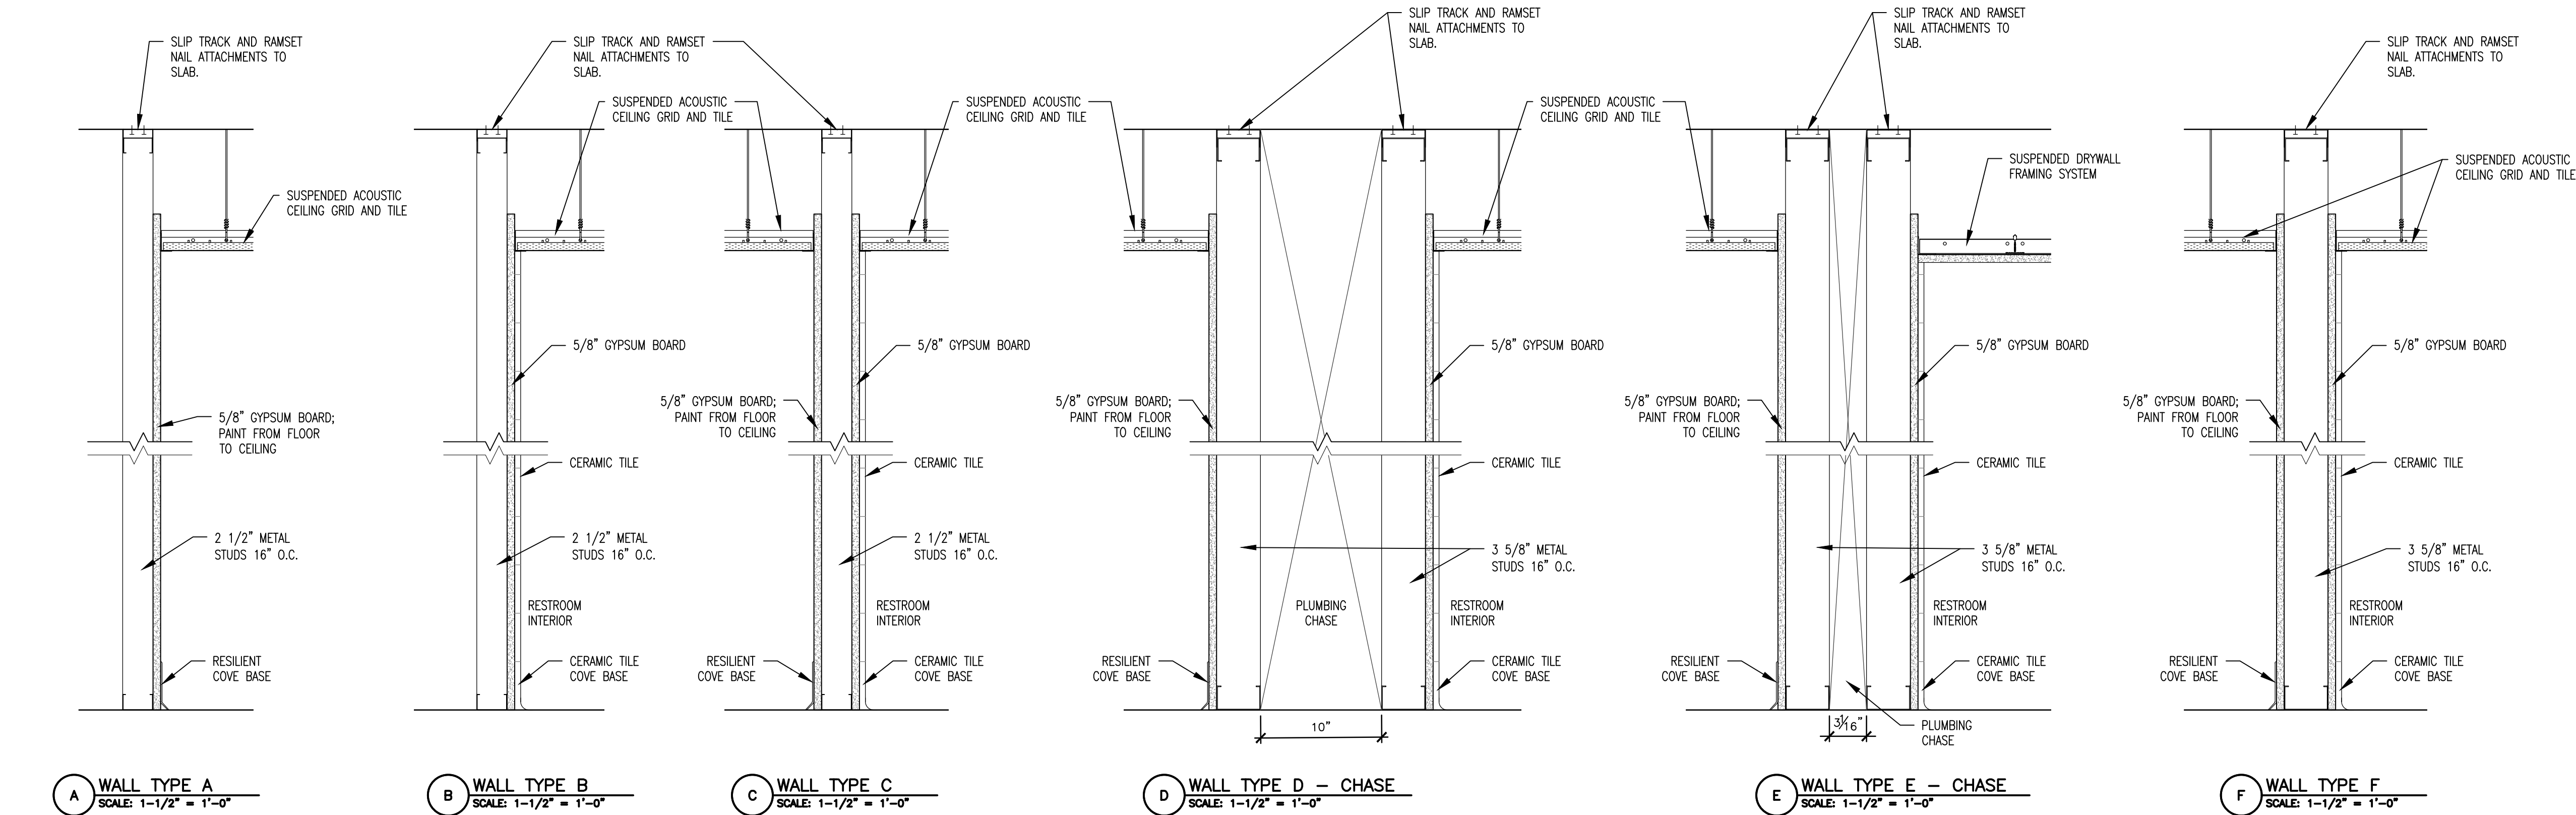

3 WALL TYPE SCHEDULE
SCALE: 1-1/2" = 1'-0"

STATE OF MISSOURI
MIKE KEHOE,
GOVERNOR



Brad M. Schaefer - Architect
MO# A-2009027294

BID DOCUMENTS

OFFICE OF ADMINISTRATION
DIVISION OF FACILITIES
MANAGEMENT,
DESIGN AND CONSTRUCTION

DEPARTMENT OF
PUBLIC SAFETY
STATE HIGHWAY PATROL

RENOVATE INTERIOR

GENERAL HEADQUARTERS
1510 EAST ELM STREET
JEFFERSON CITY, MO 65101

PROJECT # R2410-01
SITE # 6001
ASSET # 8136001001

REVISION: _____
DATE: _____
REVISION: _____
DATE: _____
REVISION: _____
DATE: _____
ISSUE DATE: 06/18/2026

CAD DWG FILE: _____
DRAWN BY: CL
CHECKED BY: BMS
DESIGNED BY: CL


SHEET TITLE:

SCHEDULES


SHEET NUMBER:

A-601

19 OF 39 SHEETS
06/18/2026

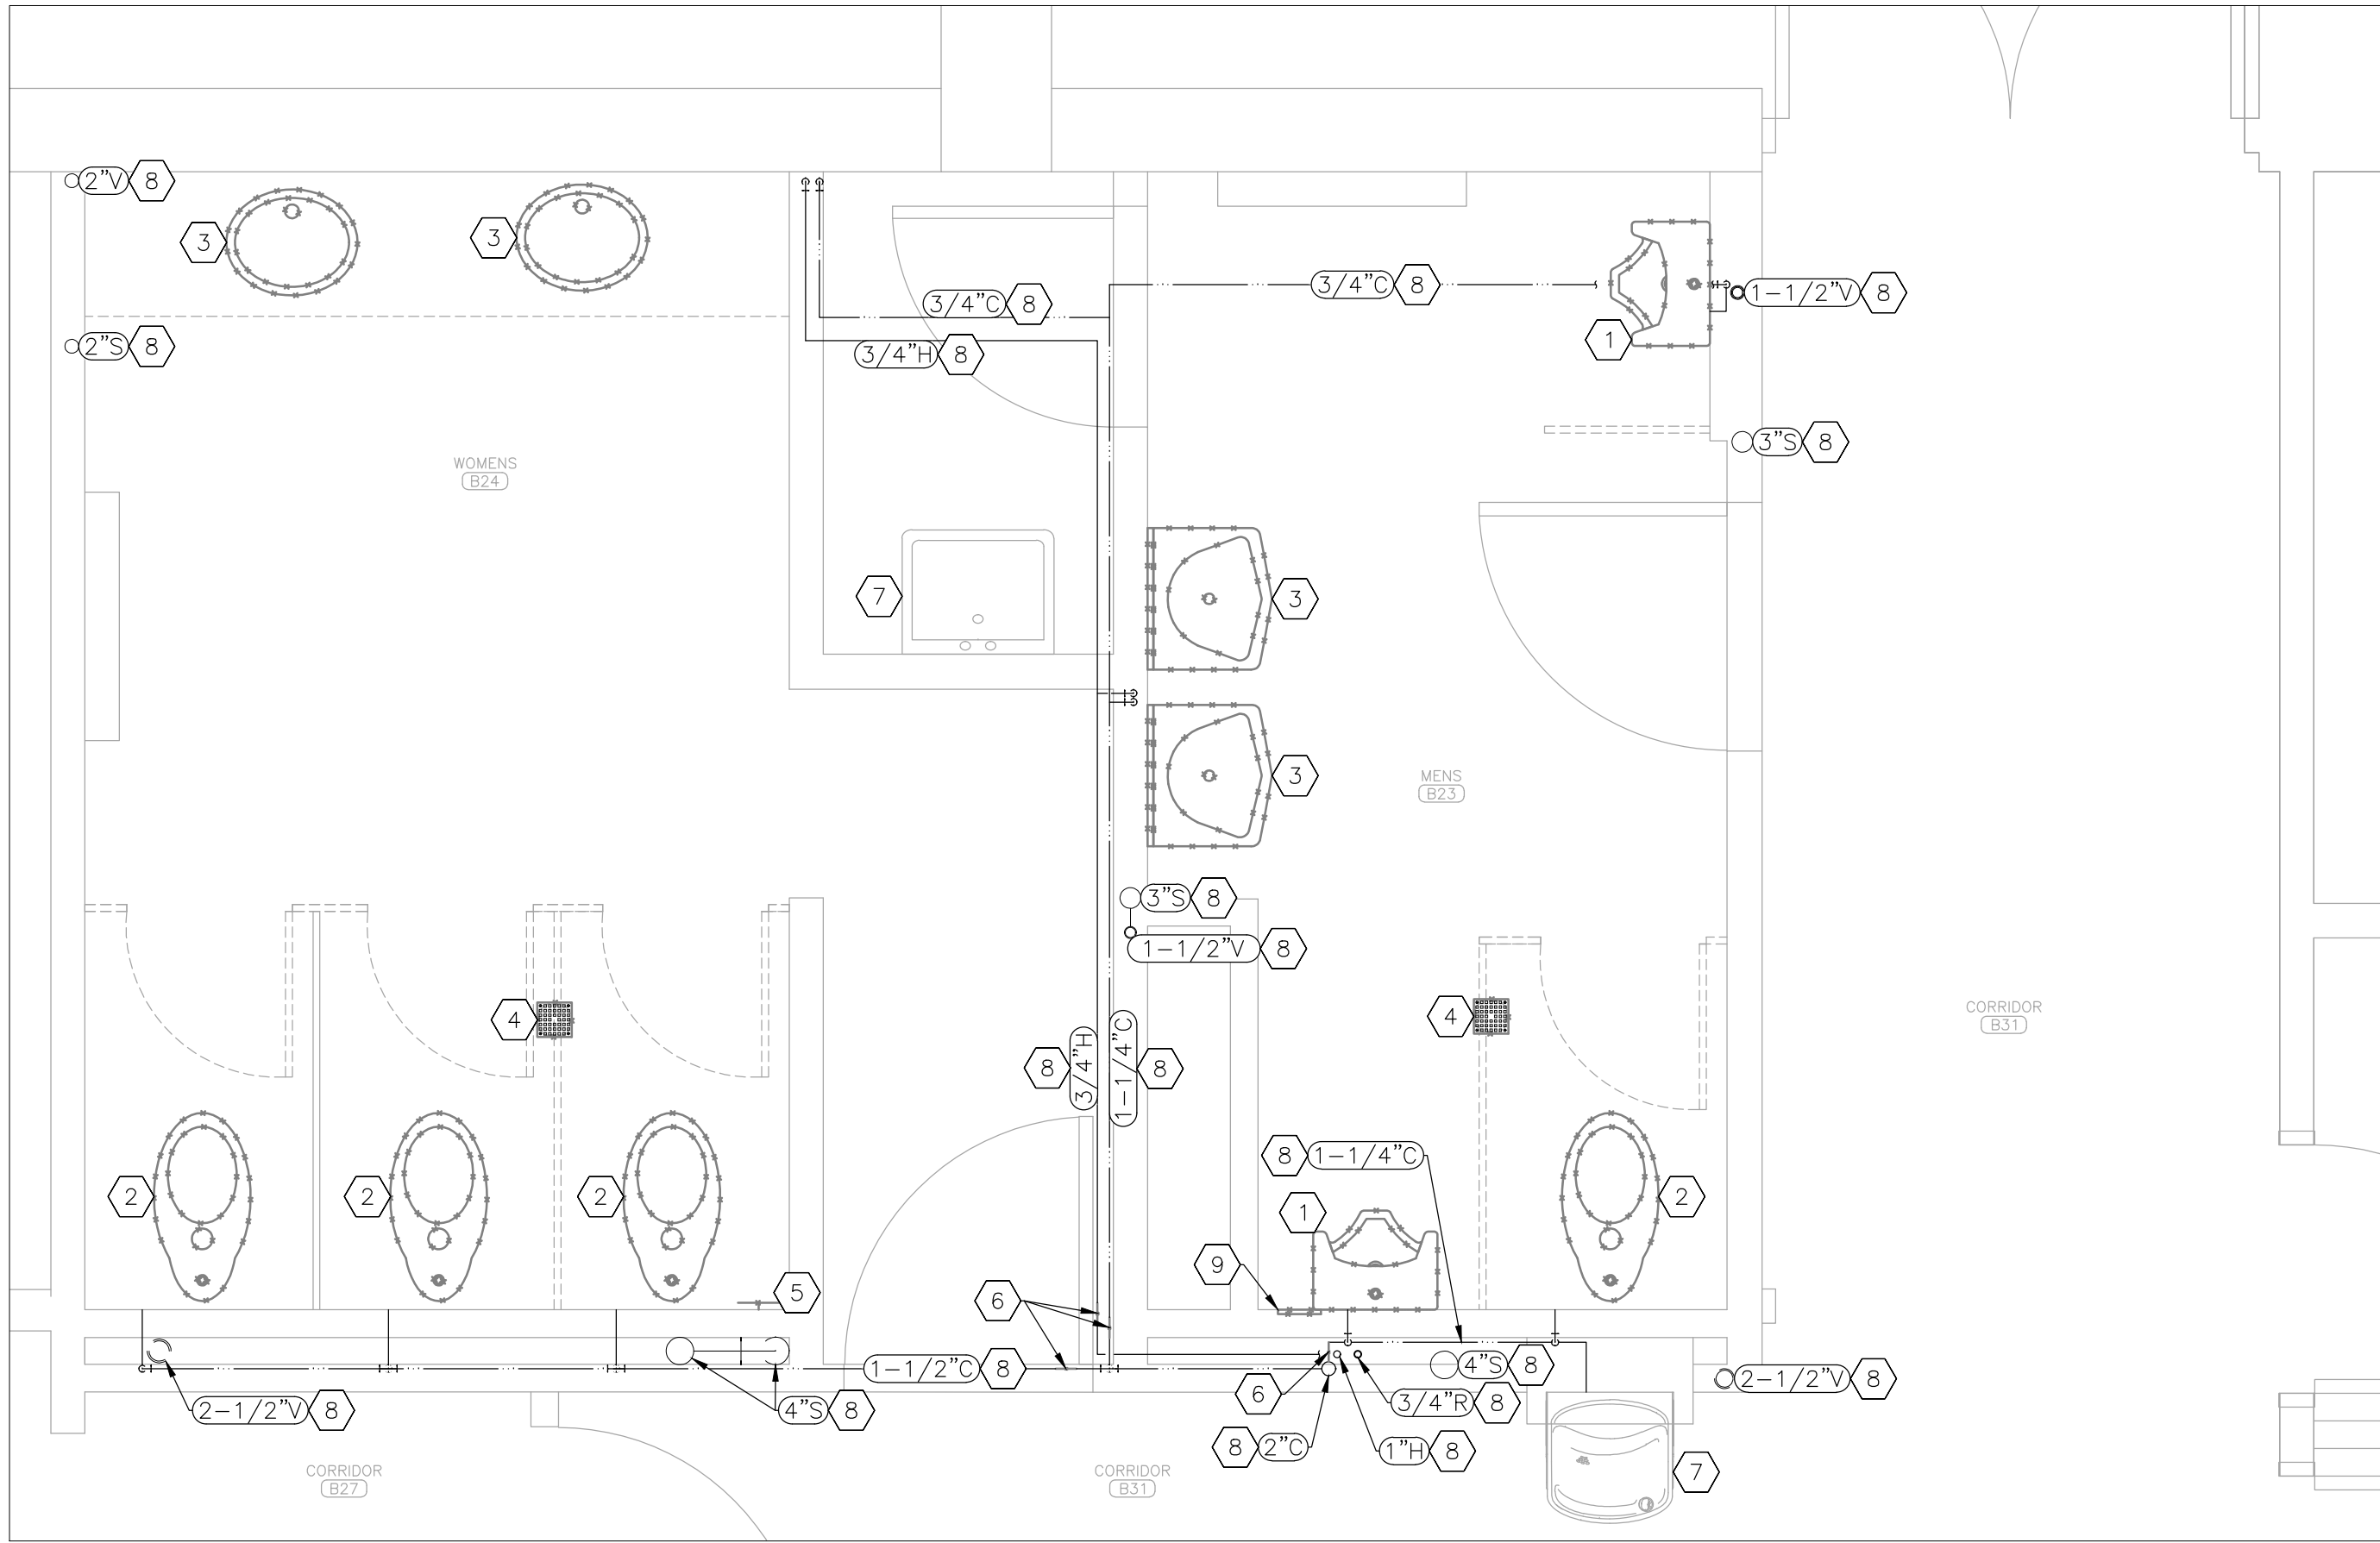

1 ALTERNATE NO. 1 – PLUMBING DEMOLITION PLAN – BASEMENT
SCALE: 1/2" = 1'-0"

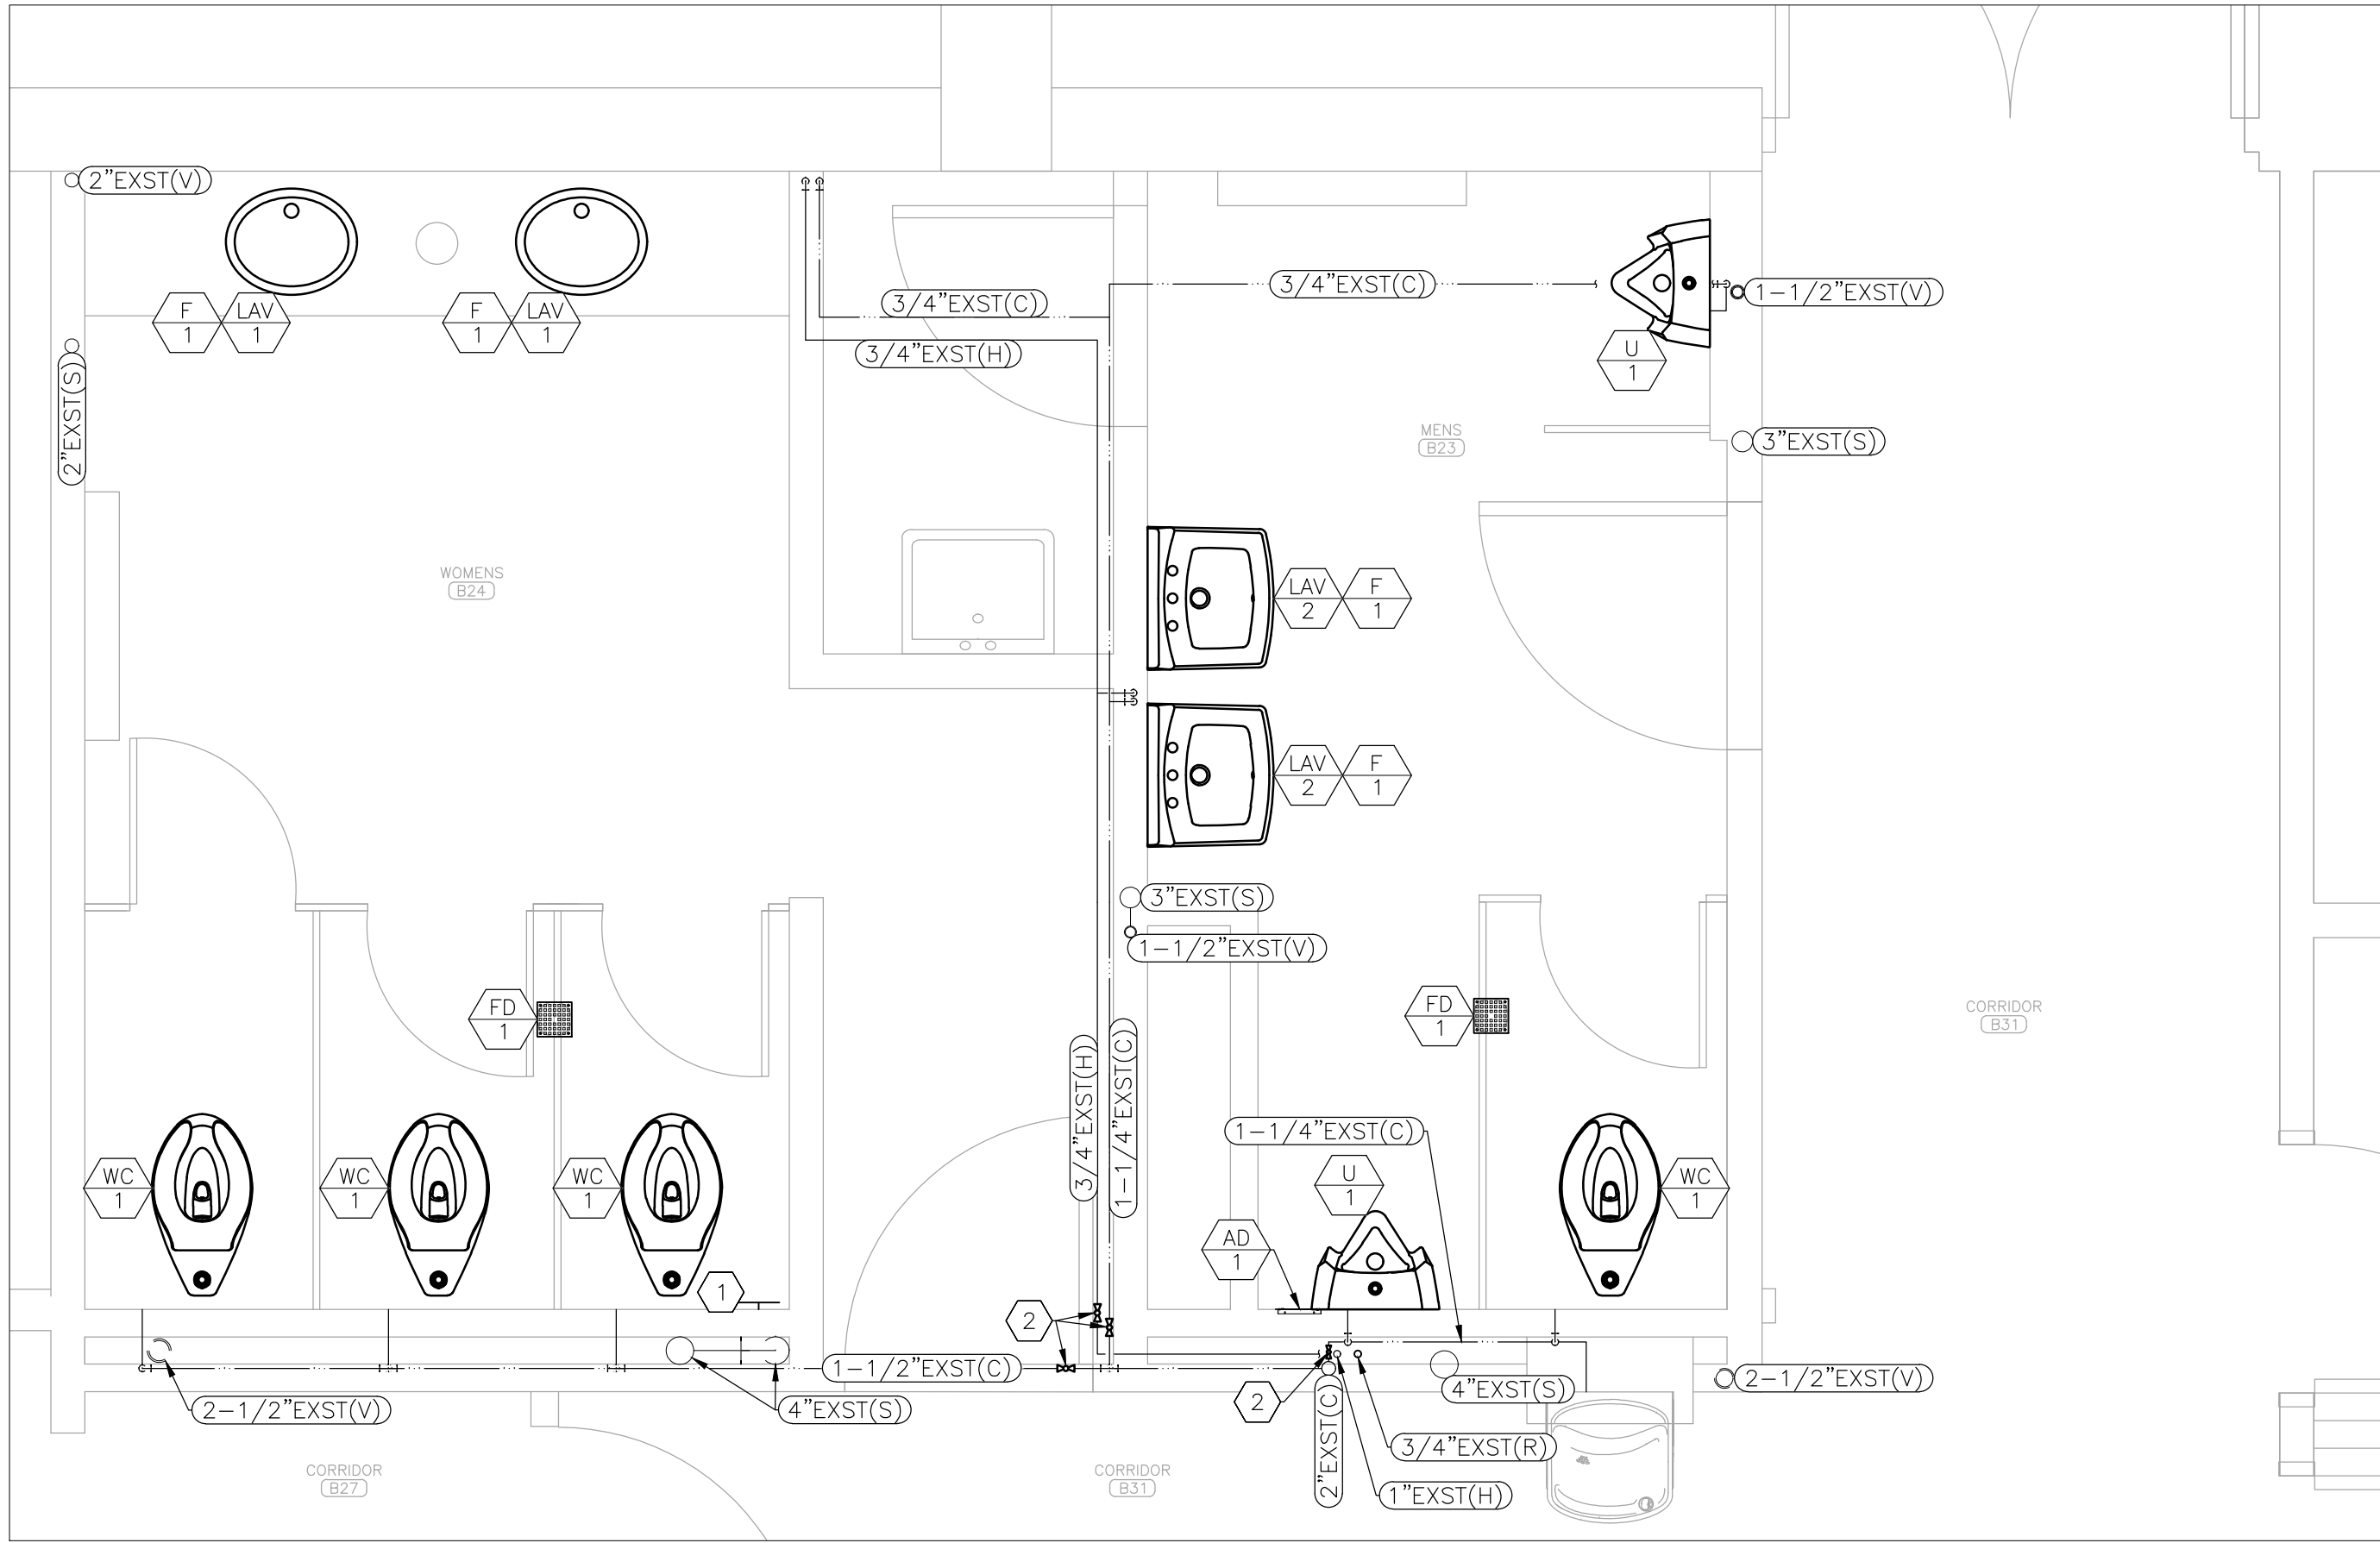

2 ALTERNATE NO. 1 – PLUMBING RENOVATION PLAN – BASEMENT
SCALE: 1/2" = 1'-0"

GENERAL DEMOLITION NOTES

- REFER TO SHEET G-002 FOR GENERAL CONSTRUCTION NOTES.
- PRIOR TO CORE DRILLING FOR ANY FLOOR PENETRATION, COORDINATE WITH GENERAL CONTRACTOR TO SCAN SLAB FOR REINFORCING BARS. REFER TO SHEET G-002 FOR ADDITIONAL INFORMATION.
- REFER TO APPENDIX B OF THE PROJECT MANUAL FOR ASBESTOS INSPECTION RESULTS FOR PLUMBING PIPE FITTINGS. PRIOR TO DEMOLITION ACTIVITIES, CONTRACTOR SHALL LABEL PLUMBING PIPE FITTINGS IDENTIFIED AS CONTAINING ASBESTOS.
- CONTRACTOR IS RESPONSIBLE FOR REPAIRING ANY DAMAGE TO ANY SURFACE IN THE AREA OF CONSTRUCTION THAT IS A RESULT OF CONSTRUCTION ACTIVITY. SURFACE SHALL BE REPAIRED AND FINISHED TO MATCH EXISTING CONDITIONS.

GENERAL RENOVATION NOTES

- FABRICATION, INSTALLATION, AND TESTING OF ALL PLUMBING SYSTEMS SHALL BE IN ACCORDANCE WITH ALL MANUFACTURER INSTALLATION GUIDELINES. REFER TO SHEET G-002 FOR APPLICABLE CODES.
- CONTRACTOR SHALL FIELD VERIFY FOR ANY UNFORESEEN CONFLICTS PRIOR TO FABRICATING PIPE. CONTRACTOR SHALL COORDINATE WITH OTHER DISCIPLINES TO ENSURE ADEQUATE SPACE IS AVAILABLE.
- ALL SINKS AND LAVATORIES SHALL BE PROVIDED WATER HAMMER ARRESTERS ON BOTH HOT AND COLD WATER SUPPLY PIPES. NEW DRINKING FOUNTAIN SHALL BE PROVIDED WITH A WATER HAMMER ARRESTER ON THE COLD WATER SUPPLY. REFER TO DETAIL 1 OF SHEET P-601.

ALTERNATE NO. 1

DEMOLITION NOTES – DETAIL 1

INDICATES KEYED NOTES

- DEMOLISH URINAL AND ASSOCIATED FLUSHOMETER. WATER SUPPLY AND SANITARY DRAIN LOCATIONS TO REMAIN.
- DEMOLISH WATER CLOSET AND ASSOCIATED FLUSHOMETER. WATER SUPPLY AND SANITARY DRAIN LOCATIONS TO REMAIN.
- DEMOLISH LAVATORY, FAUCET, RISERS, AND SUPPLY STOPS. HOT AND COLD WATER SUPPLY AND SANITARY DRAIN LOCATIONS TO REMAIN.
- DEMOLISH FLOOR DRAIN STRAINER. ASSOCIATED SANITARY DRAIN BODY AND PIPE TO REMAIN.
- DEMOLISH WALL CLEANOUT COVER. ASSOCIATED SANITARY CLEANOUT AND DRAIN PIPE TO REMAIN.
- DEMOLISH SECTION OF WATER SUPPLY PIPE FOR ISOLATION VALVE INSTALLATION. WORK SHALL BE PERFORMED OUTSIDE OF NORMAL BUSINESS HOURS.
- EXISTING DRINKING FOUNTAIN/SINK TO REMAIN.
- EXISTING PIPE, RISER, OR STACK TO REMAIN.
- COORDINATE WITH GENERAL CONTRACTOR TO CREATE PENETRATION FOR NEW ACCESS DOOR. PENETRATION TO BE SIZED AS NEEDED TO INSTALL BALL VALVE, BUT NO LESS THAN AS NEEDED FOR ACCESS DOOR INSTALLATION.


RENOVATION NOTES – DETAIL 2

INDICATES KEYED NOTES

- PROVIDE NEW STAINLESS STEEL WALL CLEANOUT COVER.
- PROVIDE AND INSTALL LEAD-FREE, QUARTER-TURN, FULL PORT BALL VALVES ON COLD WATER AND HOT WATER PIPES IN ACCESSIBLE LOCATION. WORK SHALL BE PERFORMED OUTSIDE OF NORMAL BUSINESS HOURS.

PLUMBING LEGEND

AA #	DEVICE SCHEDULE TAG
1-1/2"C	PIPE SIZE-TYPE: COLD,HOT,SANITARY,VENT
EXST	EXISTING
BV	BALL VALVE
—	PLUMBING FIXTURE – NEW
---	PLUMBING FIXTURE – EXISTING
---	DOMESTIC COLD WATER (C) – EXISTING
---	DOMESTIC HOT WATER (H) – EXISTING
---	HOT WATER RECIRCULATION (R) – EXISTING
---	ABOVE GRADE SANITARY SEWER (S) – EXST
---	VENT (V) – EXISTING
---	EXISTING MATERIALS TO BE REMOVED

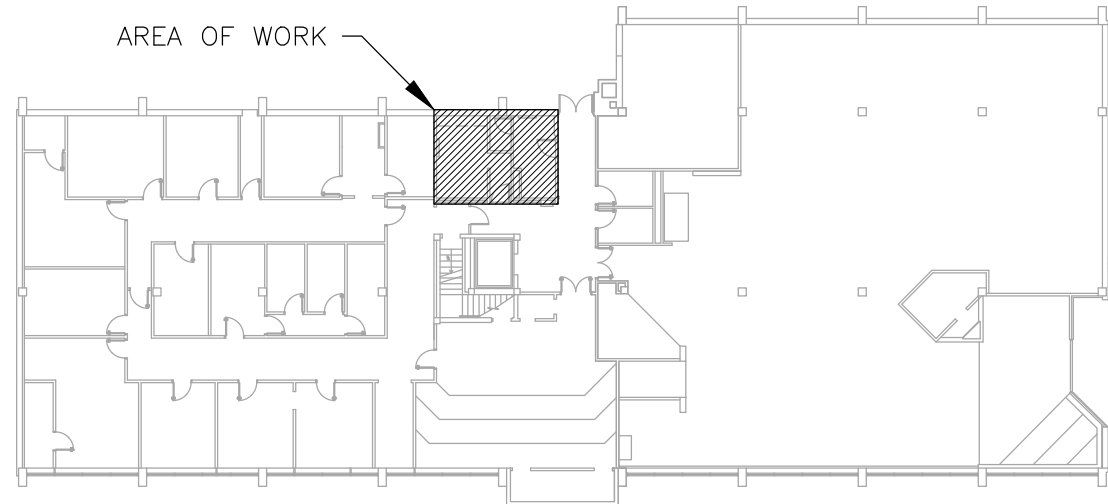

3 AREA MAP – BASEMENT

STATE OF MISSOURI
MIKE KEHOE,
GOVERNOR



Tracie L. Siebeneck - Engineer
MO# PE-2013019114

BID DOCUMENTS

OFFICE OF ADMINISTRATION
DIVISION OF FACILITIES
MANAGEMENT,
DESIGN AND CONSTRUCTION

DEPARTMENT OF
PUBLIC SAFETY
STATE HIGHWAY PATROL

RENOVATE INTERIOR

GENERAL HEADQUARTERS
1510 EAST ELM STREET
JEFFERSON CITY, MO 65101

PROJECT # R2410-01
SITE # 6001
ASSET # 8136001001

REVISION: _____
DATE: _____
REVISION: _____
DATE: _____
REVISION: _____
DATE: _____
ISSUE DATE: 06/18/2026

CAD DWG FILE: P_R2410-01
DRAWN BY: TS/AH
CHECKED BY: TS
DESIGNED BY: TS/AH


SHEET TITLE:

PLUMBING PLAN
BASEMENT


SHEET NUMBER:

P-101


20 OF 39 SHEETS
06/18/2026

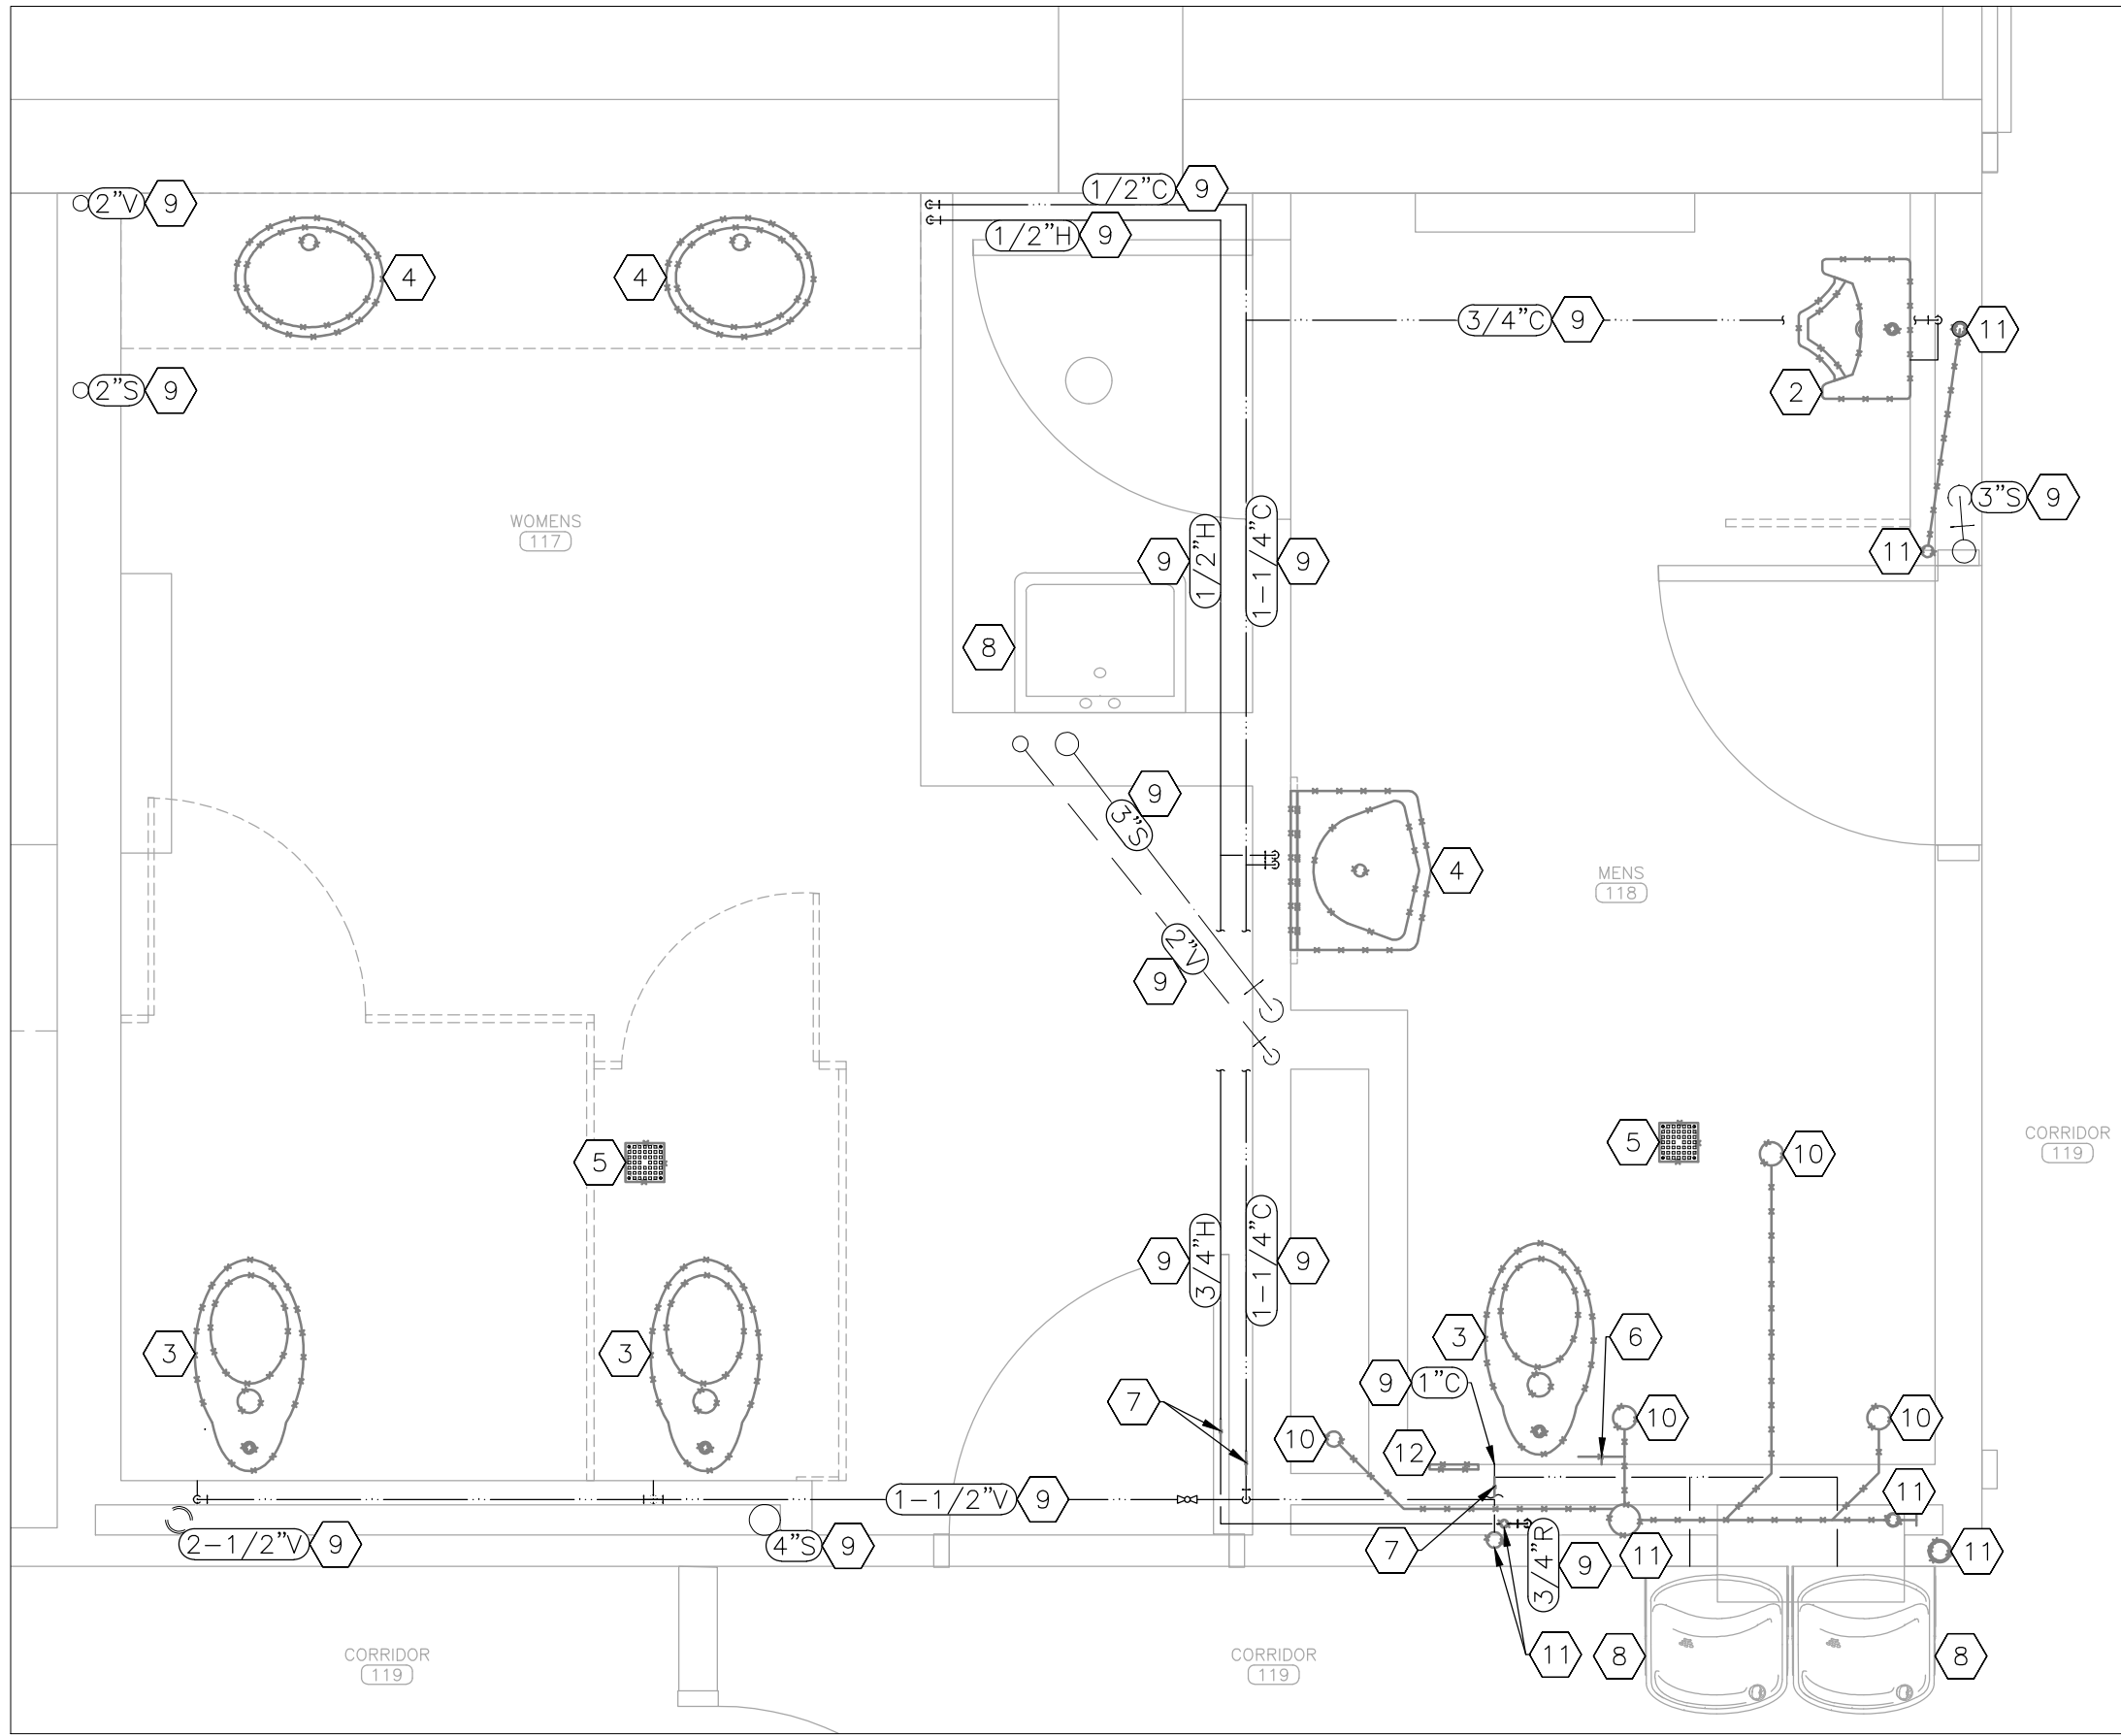


1 PLUMBING DEMOLITION PLAN – PARTIAL FIRST FLOOR
SCALE: 1/2" = 1'-0"

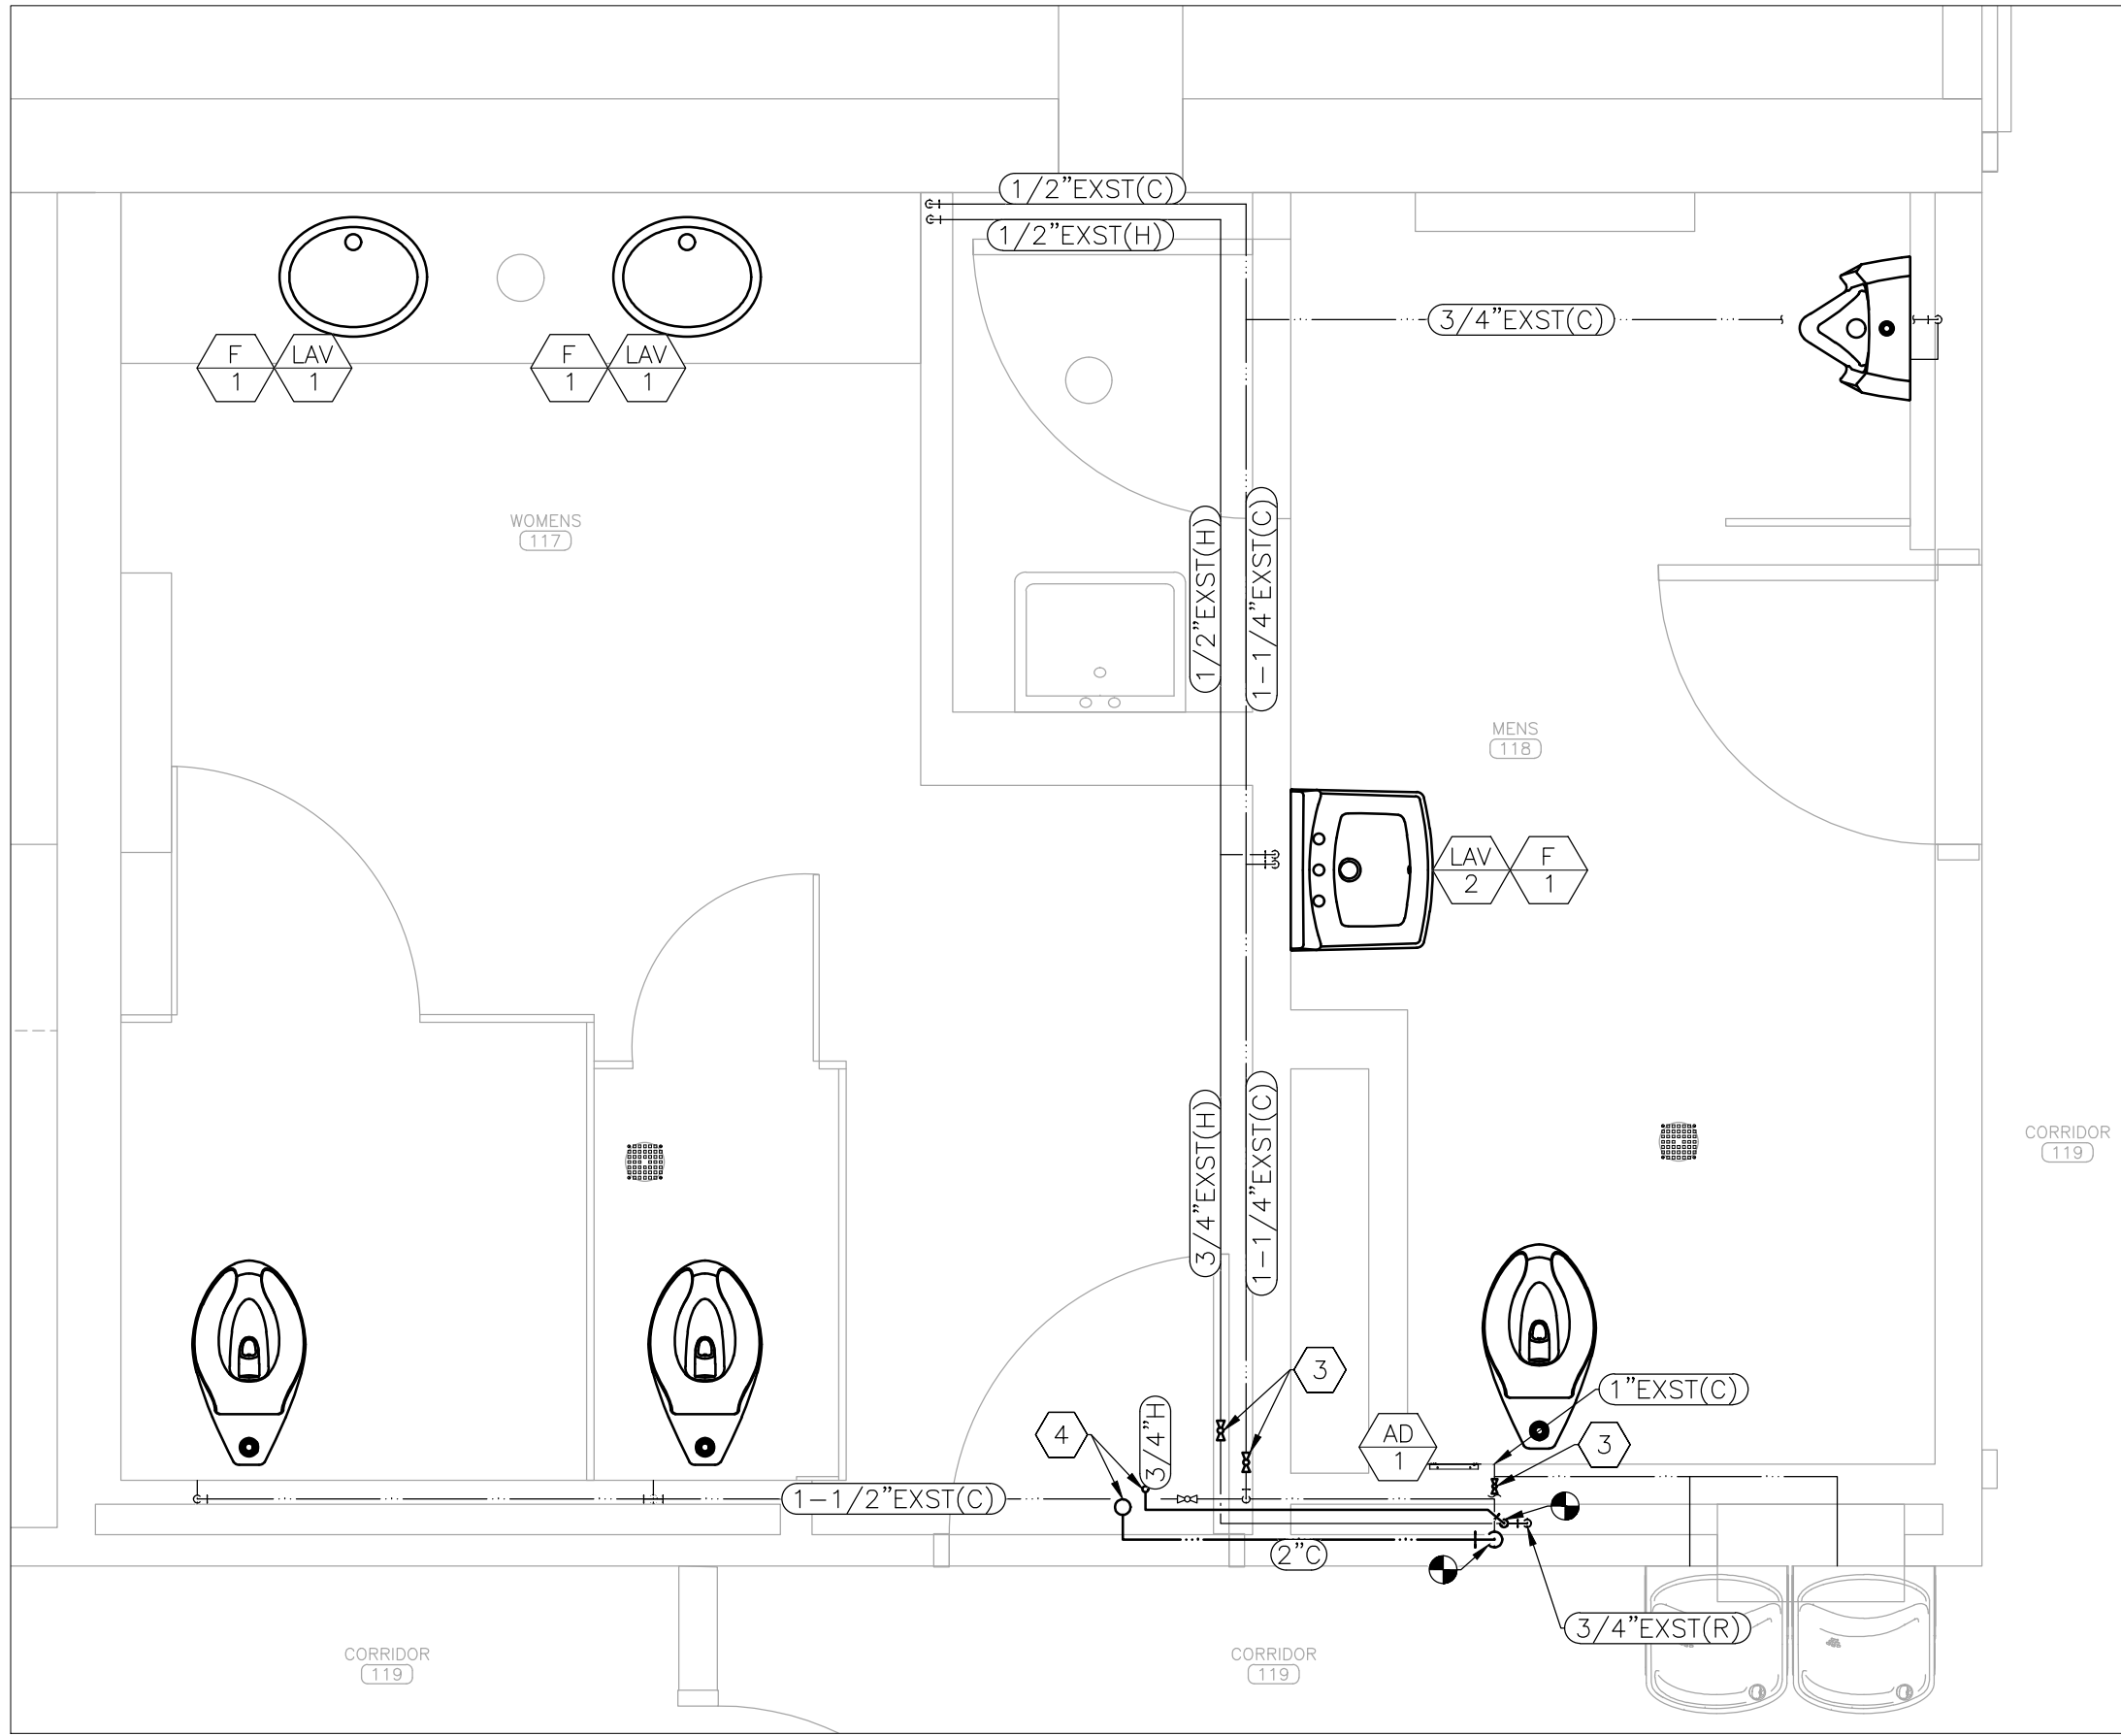

2 DOMESTIC WATER SUPPLY RENOVATION PLAN – PARTIAL FIRST FLOOR
SCALE: 1/2" = 1'-0"

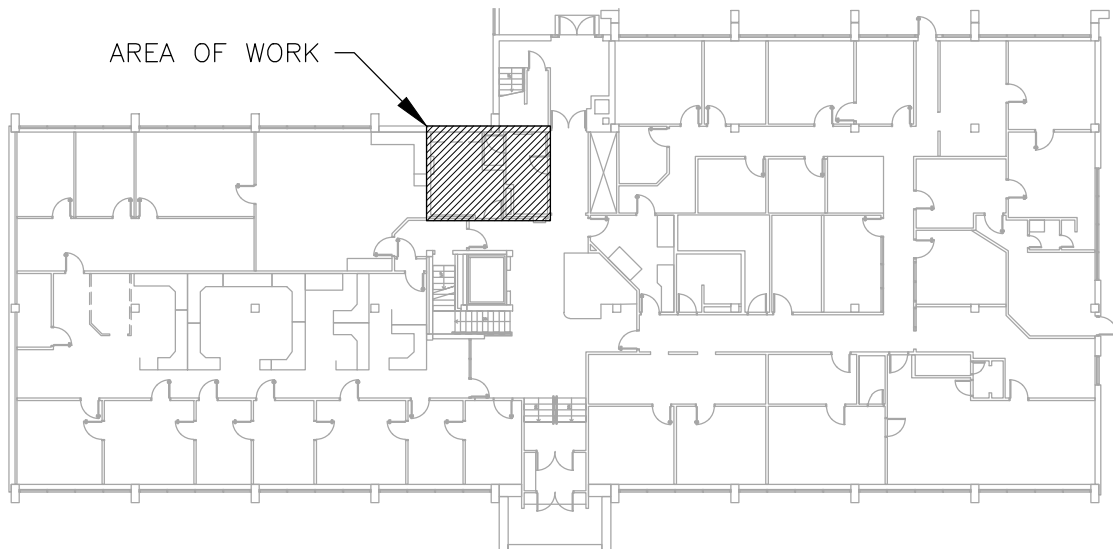

4 AREA MAP – FIRST FLOOR

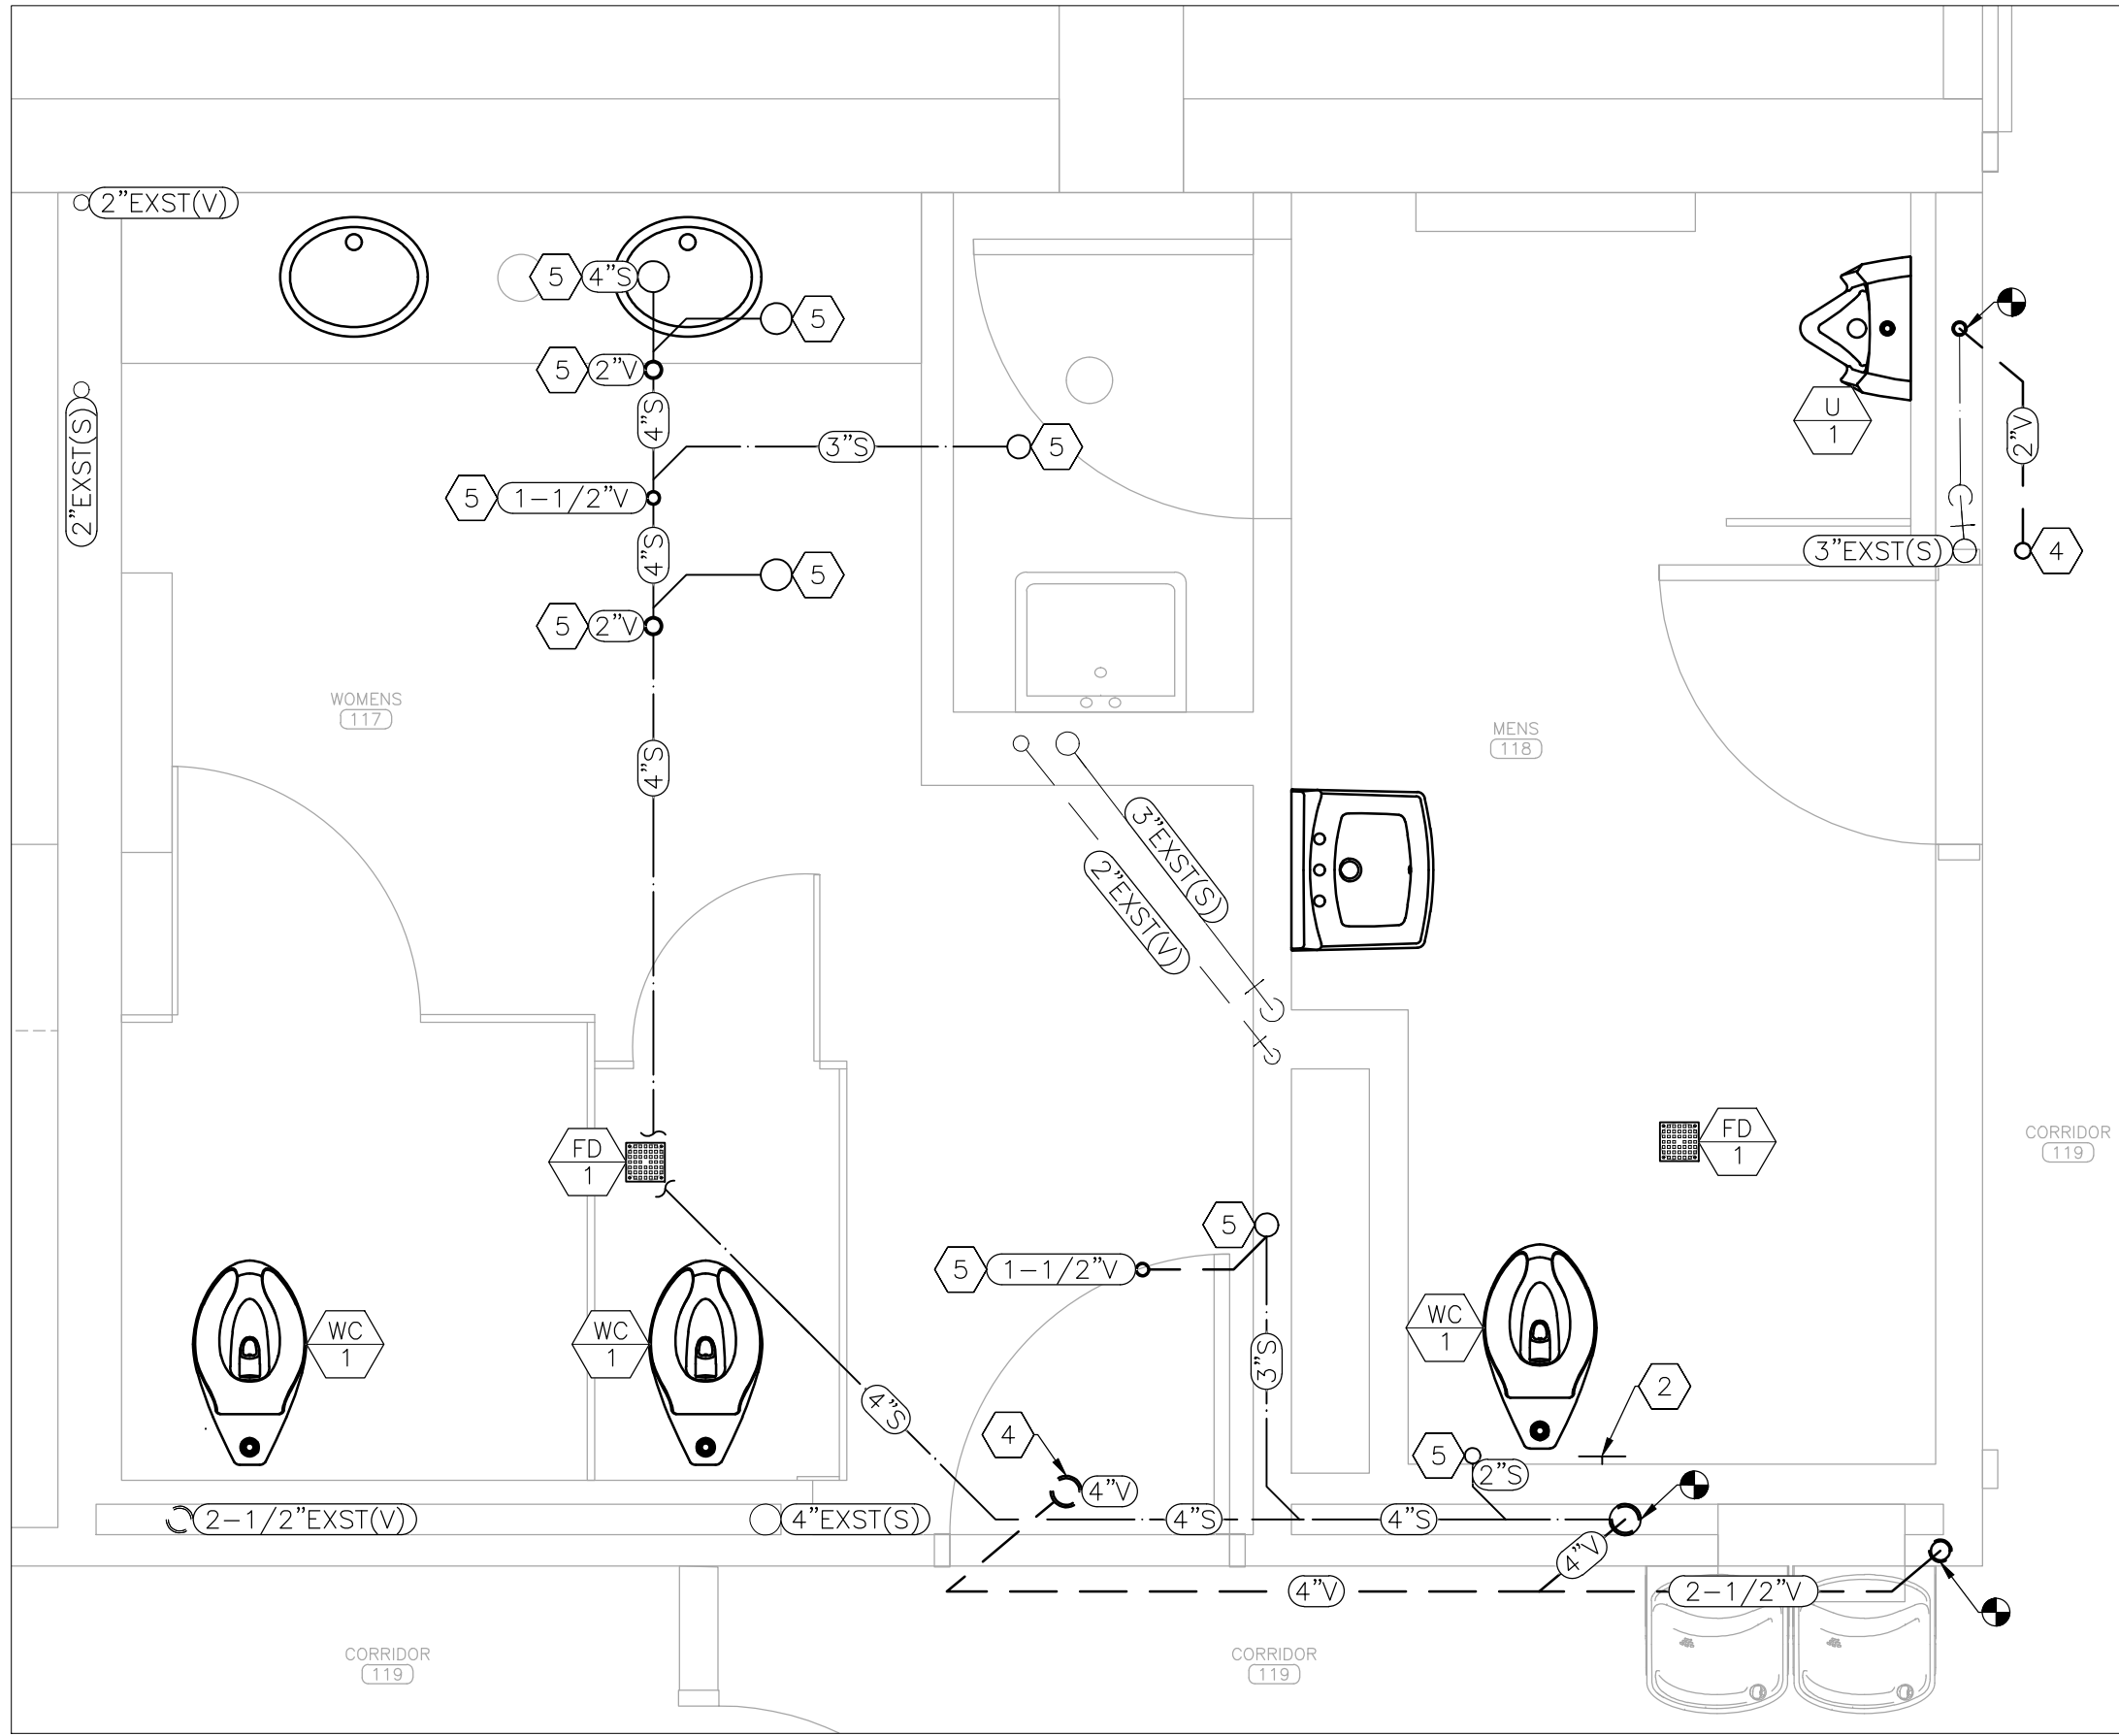

3 SANITARY SEWER RENOVATION PLAN – PARTIAL FIRST FLOOR
SCALE: 1/2" = 1'-0"

PLUMBING LEGEND	
	CONNECT TO EXISTING EQUIPMENT
	DEVICE SCHEDULE TAG
	PIPE SIZE–TYPE: COLD,HOT,SANITARY,VENT
	EXISTING
	BALL VALVE
	PLUMBING FIXTURE – NEW
	PLUMBING FIXTURE – EXISTING
	DOMESTIC COLD WATER (C) – NEW
	DOMESTIC COLD WATER (C) – EXISTING
	DOMESTIC HOT WATER (H) – NEW
	DOMESTIC HOT WATER (H) – EXISTING
	HOT WATER RECIRCULATION (R) – EXISTING
	ABOVE GRADE SANITARY SEWER (S) – NEW
	ABOVE GRADE SANITARY SEWER (S) – EXST
	VENT (V) – NEW
	VENT (V) – EXISTING
	EXISTING MATERIALS TO BE REMOVED

DEMOLITION NOTES – DETAIL 1

INDICATES KEYED NOTES

- 1 REFER TO SHEET P-101 FOR GENERAL DEMOLITION NOTES.
- 2 DEMOLISH URINAL AND ASSOCIATED FLUSHOMETER. WATER SUPPLY AND SANITARY DRAIN LOCATIONS TO REMAIN.
- 3 DEMOLISH WATER CLOSET AND ASSOCIATED FLUSHOMETER. WATER SUPPLY AND SANITARY DRAIN LOCATIONS TO REMAIN.
- 4 DEMOLISH LAVATORY, FAUCET, RISERS, AND SUPPLY STOPS. HOT AND COLD WATER SUPPLY AND SANITARY DRAIN LOCATIONS TO REMAIN.
- 5 DEMOLISH FLOOR DRAIN STRAINER. ASSOCIATED SANITARY DRAIN BODY AND PIPE TO REMAIN.
- 6 DEMOLISH WALL CLEANOUT COVER. ASSOCIATED SANITARY CLEANOUT AND DRAIN PIPE TO REMAIN.
- 7 DEMOLISH SECTION OF WATER SUPPLY PIPE FOR ISOLATION VALVE INSTALLATION. WORK SHALL BE PERFORMED OUTSIDE OF NORMAL BUSINESS HOURS.
- 8 EXISTING DRINKING FOUNTAIN/SINK TO REMAIN.
- 9 EXISTING PIPE, RISER, OR STACK TO REMAIN.
- 10 DEMOLISH SANITARY DRAIN AND VENT PIPE SERVING FIXTURE LOCATED ABOVE THE 2ND FLOOR SLAB. COORDINATE WITH GENERAL CONTRACTOR TO REPAIR FLOOR.
- 11 DEMOLISH HOT WATER/COLD WATER RISER OR SANITARY DRAIN/VENT STACK AS NEEDED TO COMPLETE THE WORK. COORDINATE WITH GENERAL CONTRACTOR TO REPAIR ANY UNUSED FLOOR PENETRATIONS.
- 12 COORDINATE WITH GENERAL CONTRACTOR TO CREATE PENETRATION FOR NEW ACCESS DOOR. PENETRATION TO BE SIZED AS NEEDED TO INSTALL BALL VALVE, BUT NO LESS THAN AS NEEDED FOR ACCESS DOOR INSTALLATION.

RENOVATION NOTES – DETAILS 2 & 3

INDICATES KEYED NOTES

- 1 REFER TO SHEET P-101 FOR GENERAL RENOVATION NOTES.
- 2 PROVIDE NEW STAINLESS STEEL WALL CLEANOUT COVER.
- 3 PROVIDE AND INSTALL LEAD-FREE, QUARTER-TURN, FULL PORT BALL VALVES ON COLD WATER AND HOT WATER PIPES IN ACCESSIBLE LOCATION. WORK SHALL BE PERFORMED OUTSIDE OF NORMAL BUSINESS HOURS.
- 4 ROUTE HOT WATER, COLD WATER, SANITARY DRAIN, OR VENT RISER/STACK TO NEW FLOOR PENETRATION. COORDINATE WITH GENERAL CONTRACTOR FOR FINAL LOCATION.
- 5 ROUTE SANITARY DRAIN AND VENT PIPE SERVING FIXTURE LOCATED ABOVE THE 2ND FLOOR SLAB AS SHOWN. COORDINATE WITH GENERAL CONTRACTOR TO CREATE PENETRATIONS IN SLAB.

STATE OF MISSOURI
MIKE KEHOE,
GOVERNOR



Tracie L. Siebeneck - Engineer
MO# PE-2013019114

BID DOCUMENTS

OFFICE OF ADMINISTRATION
DIVISION OF FACILITIES
MANAGEMENT,
DESIGN AND CONSTRUCTION

DEPARTMENT OF
PUBLIC SAFETY
STATE HIGHWAY PATROL

RENOVATE INTERIOR

GENERAL HEADQUARTERS
1510 EAST ELM STREET
JEFFERSON CITY, MO 65101

PROJECT # R2410-01
SITE # 6001
ASSET # 8136001001

REVISION: _____
DATE: _____
REVISION: _____
DATE: _____
REVISION: _____
DATE: _____
ISSUE DATE: 06/18/2026

CAD DWG FILE: P_R2410-01
DRAWN BY: TS/AH
CHECKED BY: TS
DESIGNED BY: TS/AH

SHEET TITLE:
PARTIAL
PLUMBING PLAN
FIRST FLOOR

SHEET NUMBER:

P-102

21 OF 39 SHEETS
06/18/2026



Tracie L. Siebeneck - Engineer
MO# PE-2013019114

BID
DOCUMENTS

OFFICE OF ADMINISTRATION
DIVISION OF FACILITIES
MANAGEMENT,
DESIGN AND CONSTRUCTION

DEPARTMENT OF
PUBLIC SAFETY
STATE HIGHWAY PATROL

RENOVATE INTERIOR

GENERAL HEADQUARTERS
1510 EAST ELM STREET
JEFFERSON CITY, MO 65101

PROJECT # R2410-01
SITE # 6001
ASSET # 8136001001

REVISION: _____
DATE: _____
REVISION: _____
DATE: _____
REVISION: _____
DATE: _____
ISSUE DATE: 06/18/2026

CAD DWG FILE: P_R2410-01
DRAWN BY: TS/AH
CHECKED BY: TS
DESIGNED BY: TS/AH

SHEET TITLE:

PARTIAL
PLUMBING PLAN
SECOND FLOOR

SHEET NUMBER:

P-103

22 OF 39 SHEETS
06/18/2026

DEMOLITION NOTES – DETAIL 1


INDICATES KEYED NOTES

- 1 REFER TO SHEET P-101 FOR GENERAL DEMOLITION NOTES.
- 2 DEMOLISH WATER CLOSET AND ASSOCIATED FLUSHOMETER. WATER SUPPLY AND SANITARY DRAIN LOCATIONS TO REMAIN.
- 3 DEMOLISH LAVATORY, FAUCET, RISERS, AND SUPPLY STOPS. HOT AND COLD WATER SUPPLY AND SANITARY DRAIN LOCATIONS TO REMAIN.
- 4 DEMOLISH FLOOR DRAIN STRAINER. ASSOCIATED SANITARY DRAIN BODY AND PIPE TO REMAIN.
- 5 DEMOLISH URINAL AND ASSOCIATED FLUSHOMETER. DEMOLISH WATER SUPPLY, SANITARY DRAIN, AND VENT PIPE AS SHOWN.
- 6 DEMOLISH WATER CLOSET AND ASSOCIATED FLUSHOMETER. DEMOLISH WATER SUPPLY PIPE AS SHOWN. REFER TO SHEET P-102 FOR SANITARY DRAIN PIPE DEMOLITION.
- 7 DEMOLISH SINK/LAVATORY, FAUCET, RISERS, AND SUPPLY STOPS. DEMOLISH ASSOCIATED HOT AND COLD WATER SUPPLY, SANITARY DRAIN, AND VENT PIPE AS SHOWN.
- 8 DEMOLISH DRINKING FOUNTAIN. DEMOLISH WATER SUPPLY AND VENT PIPE AS SHOWN. REFER TO SHEET P-102 FOR SANITARY DRAIN PIPE DEMOLITION.
- 9 DEMOLISH VENT STACK AS NEEDED TO COMPLETE THE WORK. ROOF PENETRATION TO REMAIN.
- 10 EXISTING PIPE, RISER, OR STACK TO REMAIN.
- 11 DEMOLISH FLOOR DRAIN. REFER TO SHEET P-102 FOR SANITARY DRAIN PIPE DEMOLITION.
- 12 DEMOLISH ACCESS DOOR.

RENOVATION NOTES – DETAILS 2 & 3


INDICATES KEYED NOTES

- 1 REFER TO SHEET P-101 FOR GENERAL RENOVATION NOTES.
- 2 PROVIDE AND INSTALL WALL CLEANOUT WITH STAINLESS STEEL COVER PLATE. SIZE TO MATCH ASSOCIATED SANITARY DRAIN PIPE. ENSURE CLEANOUT IS INSTALLED IN ACCESSIBLE LOCATION.
- 3 PROVIDE AND INSTALL LEAD-FREE, QUARTER-TURN, FULL PORT BALL VALVES ON COLD WATER AND HOT WATER PIPES IN ACCESSIBLE LOCATION. WORK SHALL BE PERFORMED OUTSIDE OF NORMAL BUSINESS HOURS.
- 4 ROUTE VENT RISER FROM BELOW SLAB TO EXISTING VENT STACK.

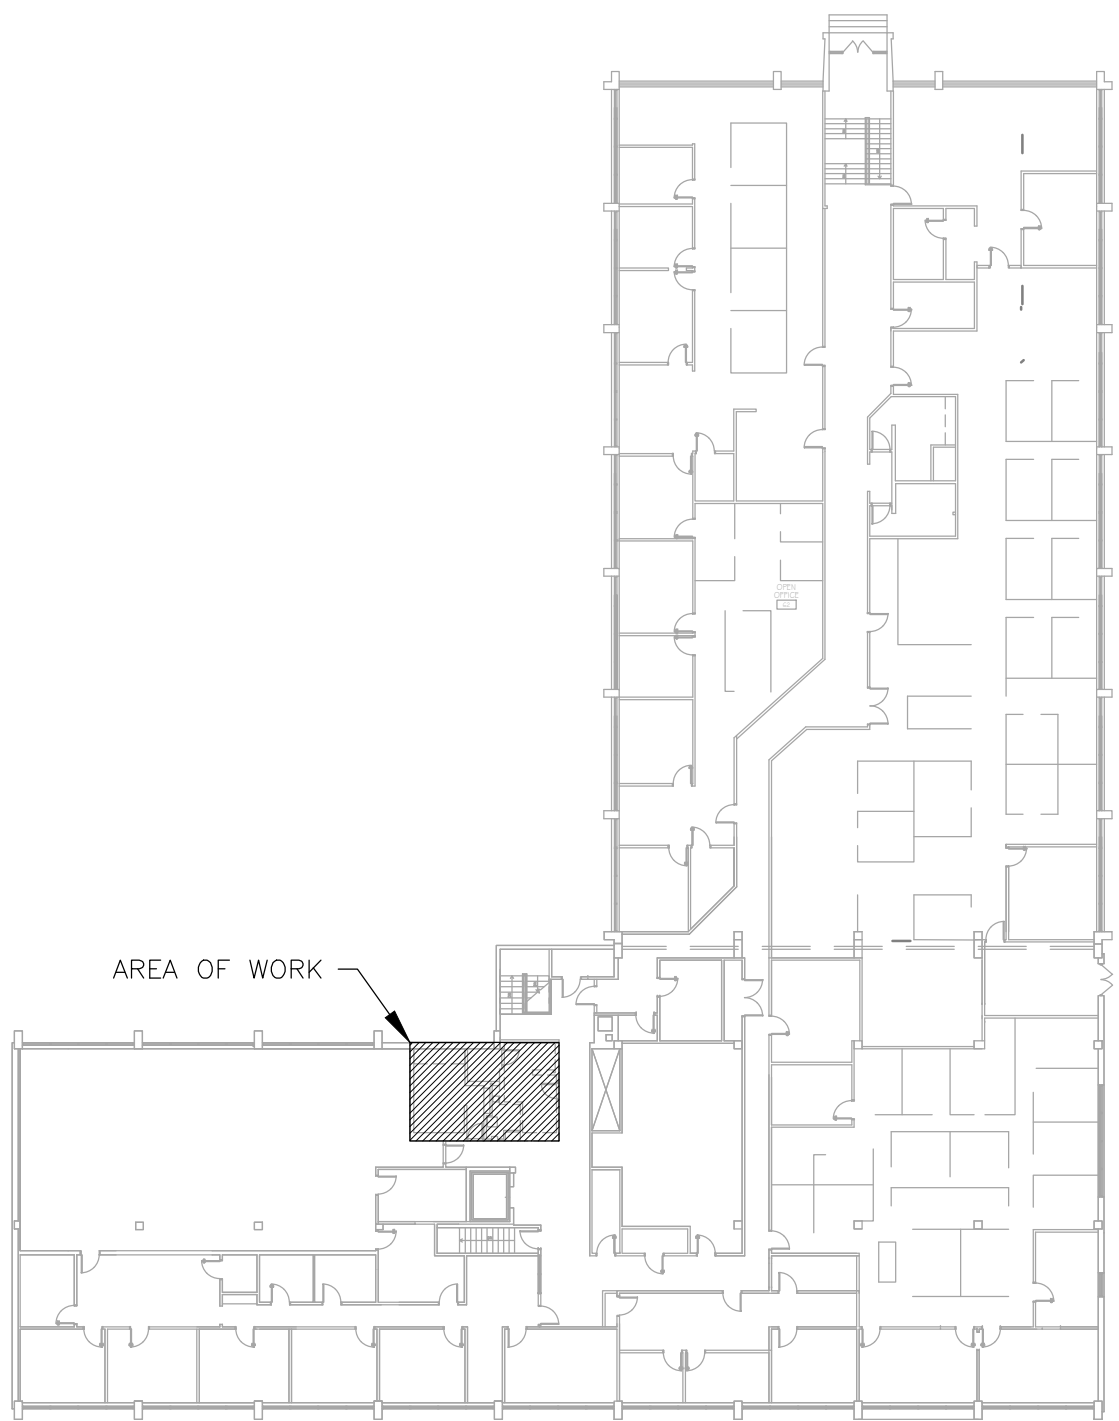


PLUMBING LEGEND


	CONNECT TO EXISTING EQUIPMENT		PLUMBING FIXTURE – NEW
	DEVICE SCHEDULE TAG		DOMESTIC COLD WATER (C) – NEW
	DETAIL REFERENCE, NUMBER/SHEET		DOMESTIC COLD WATER (C) – EXISTING
	PIPE SIZE-TYPE: COLD,HOT,SANITARY,VENT		DOMESTIC HOT WATER (H) – NEW
	EXISTING		ABOVE GRADE SANITARY SEWER (S) – NEW
	BALL VALVE		VENT PIPE (V) – NEW
			VENT PIPE (V) – EXISTING
			EXISTING MATERIALS TO BE REMOVED

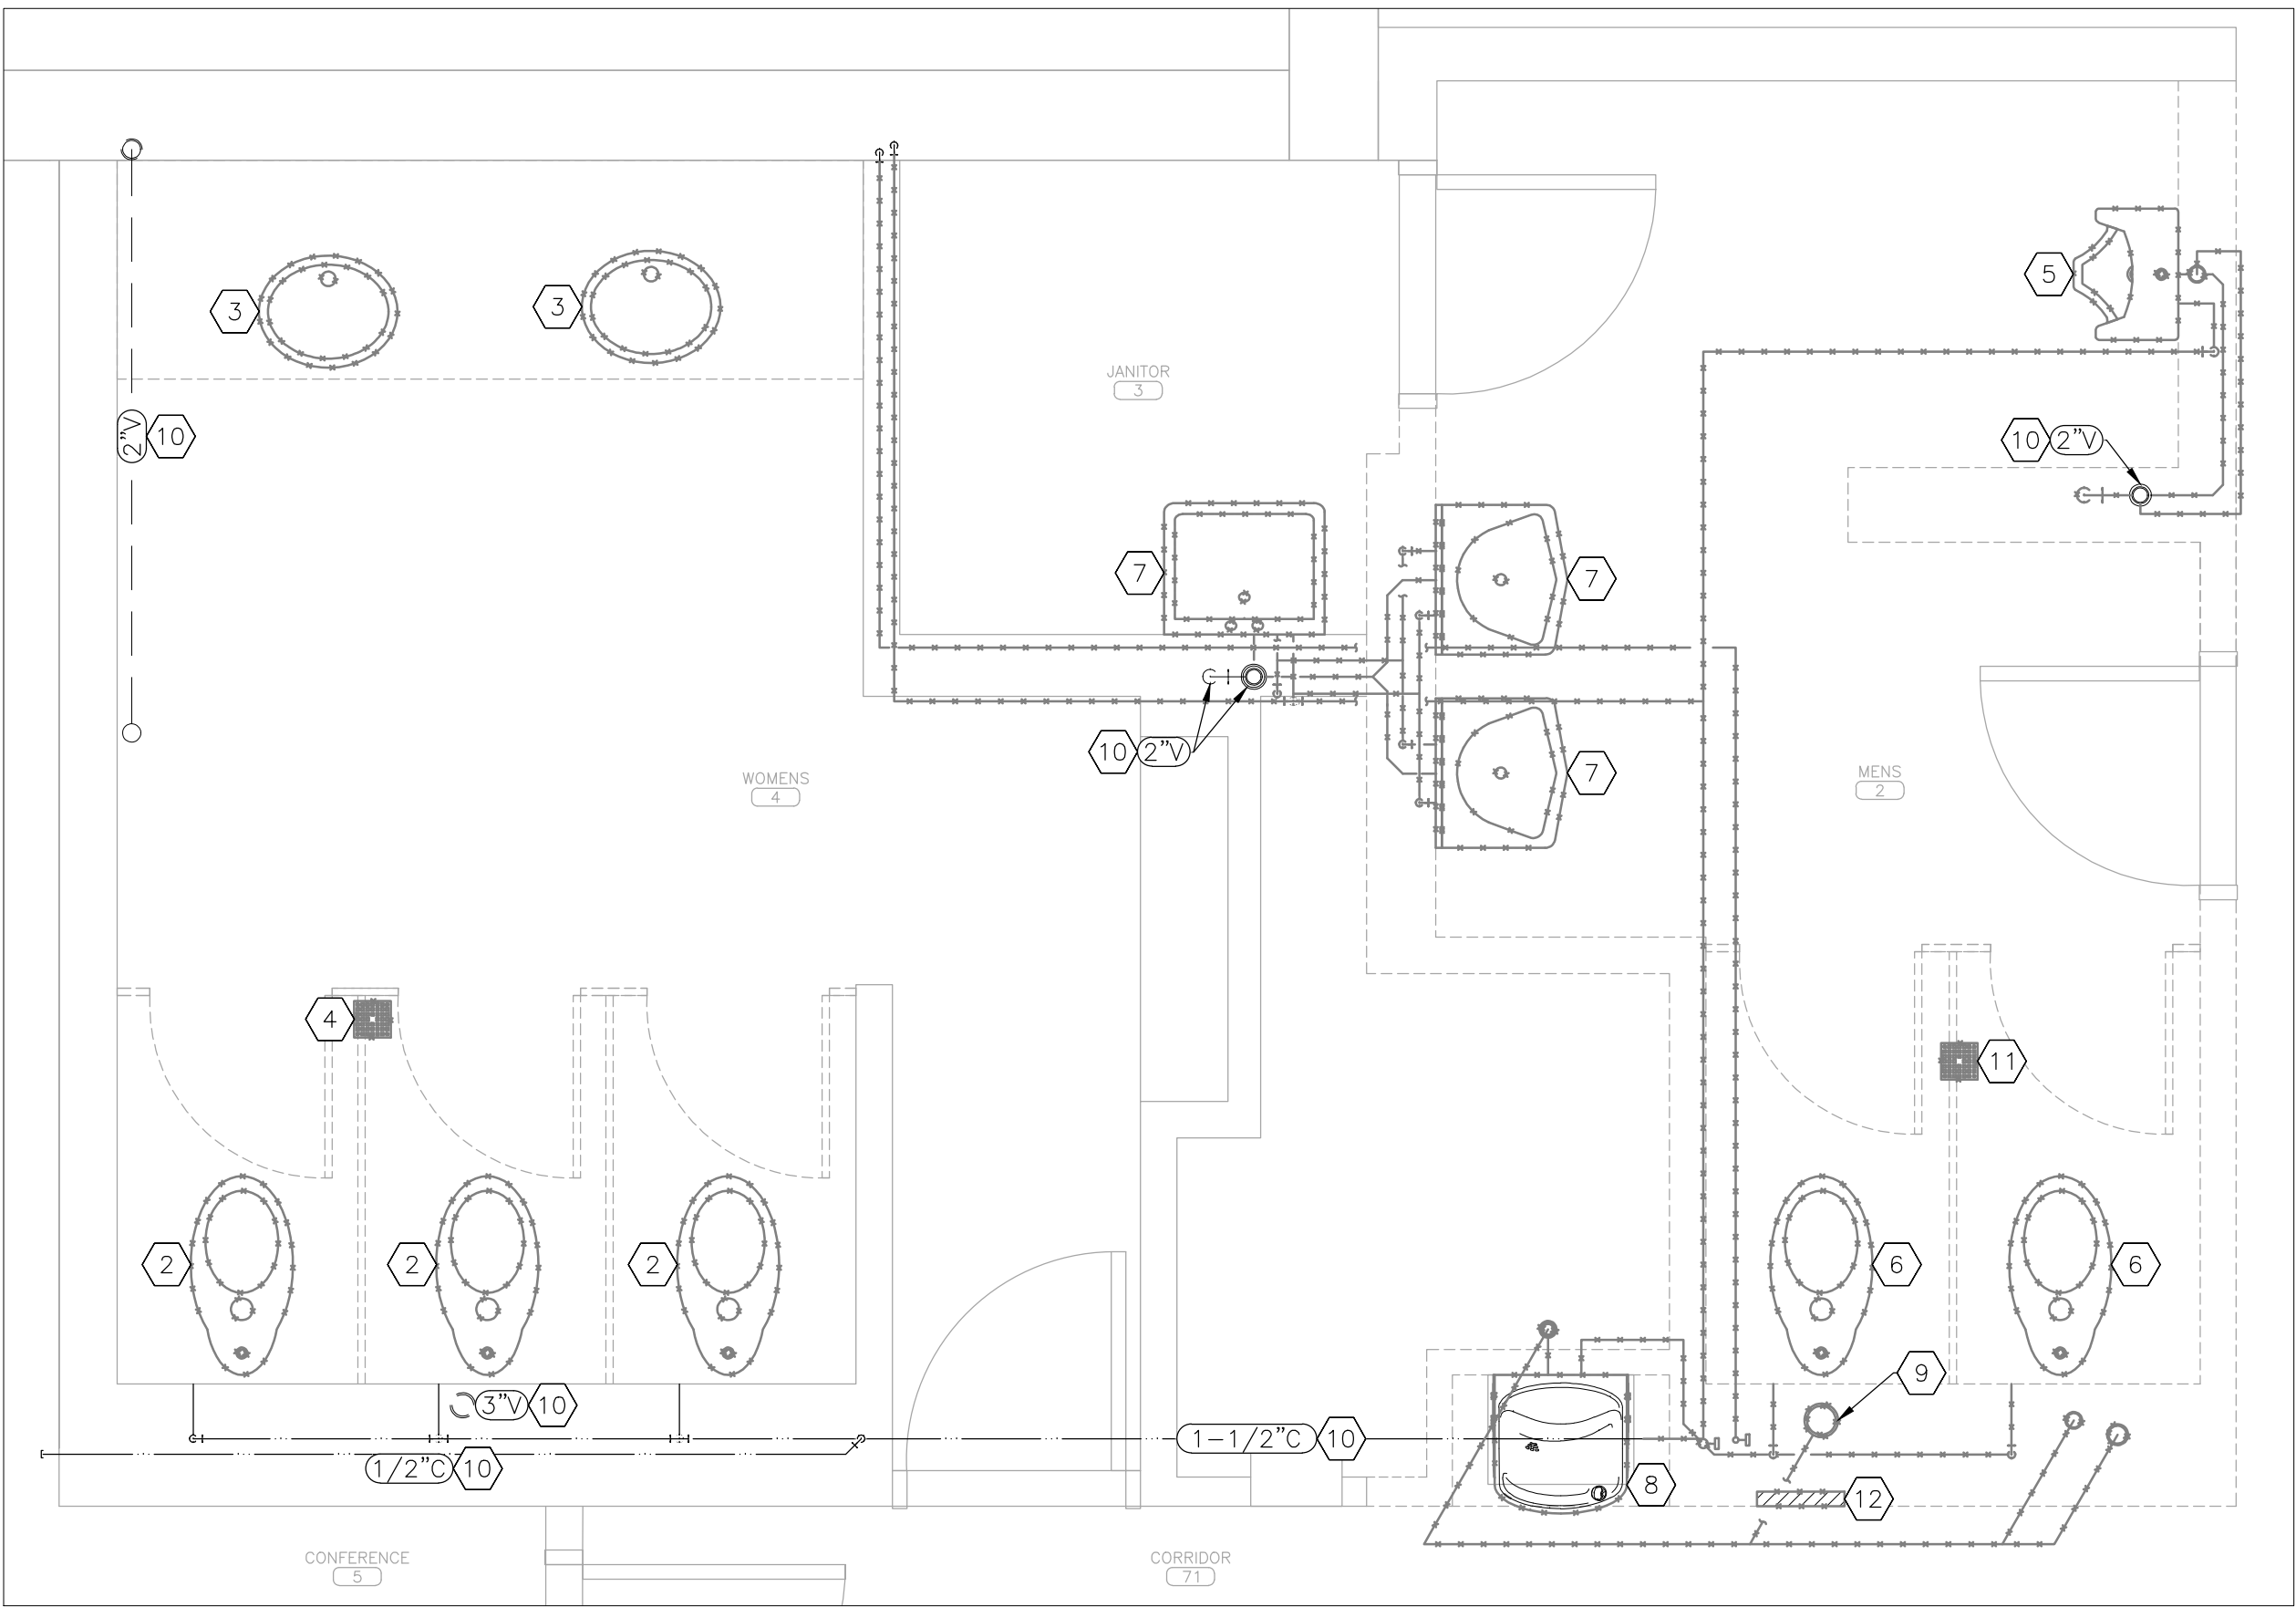


1 PLUMBING DEMOLITION PLAN – PARTIAL SECOND FLOOR
SCALE: 1/2" = 1'-0"

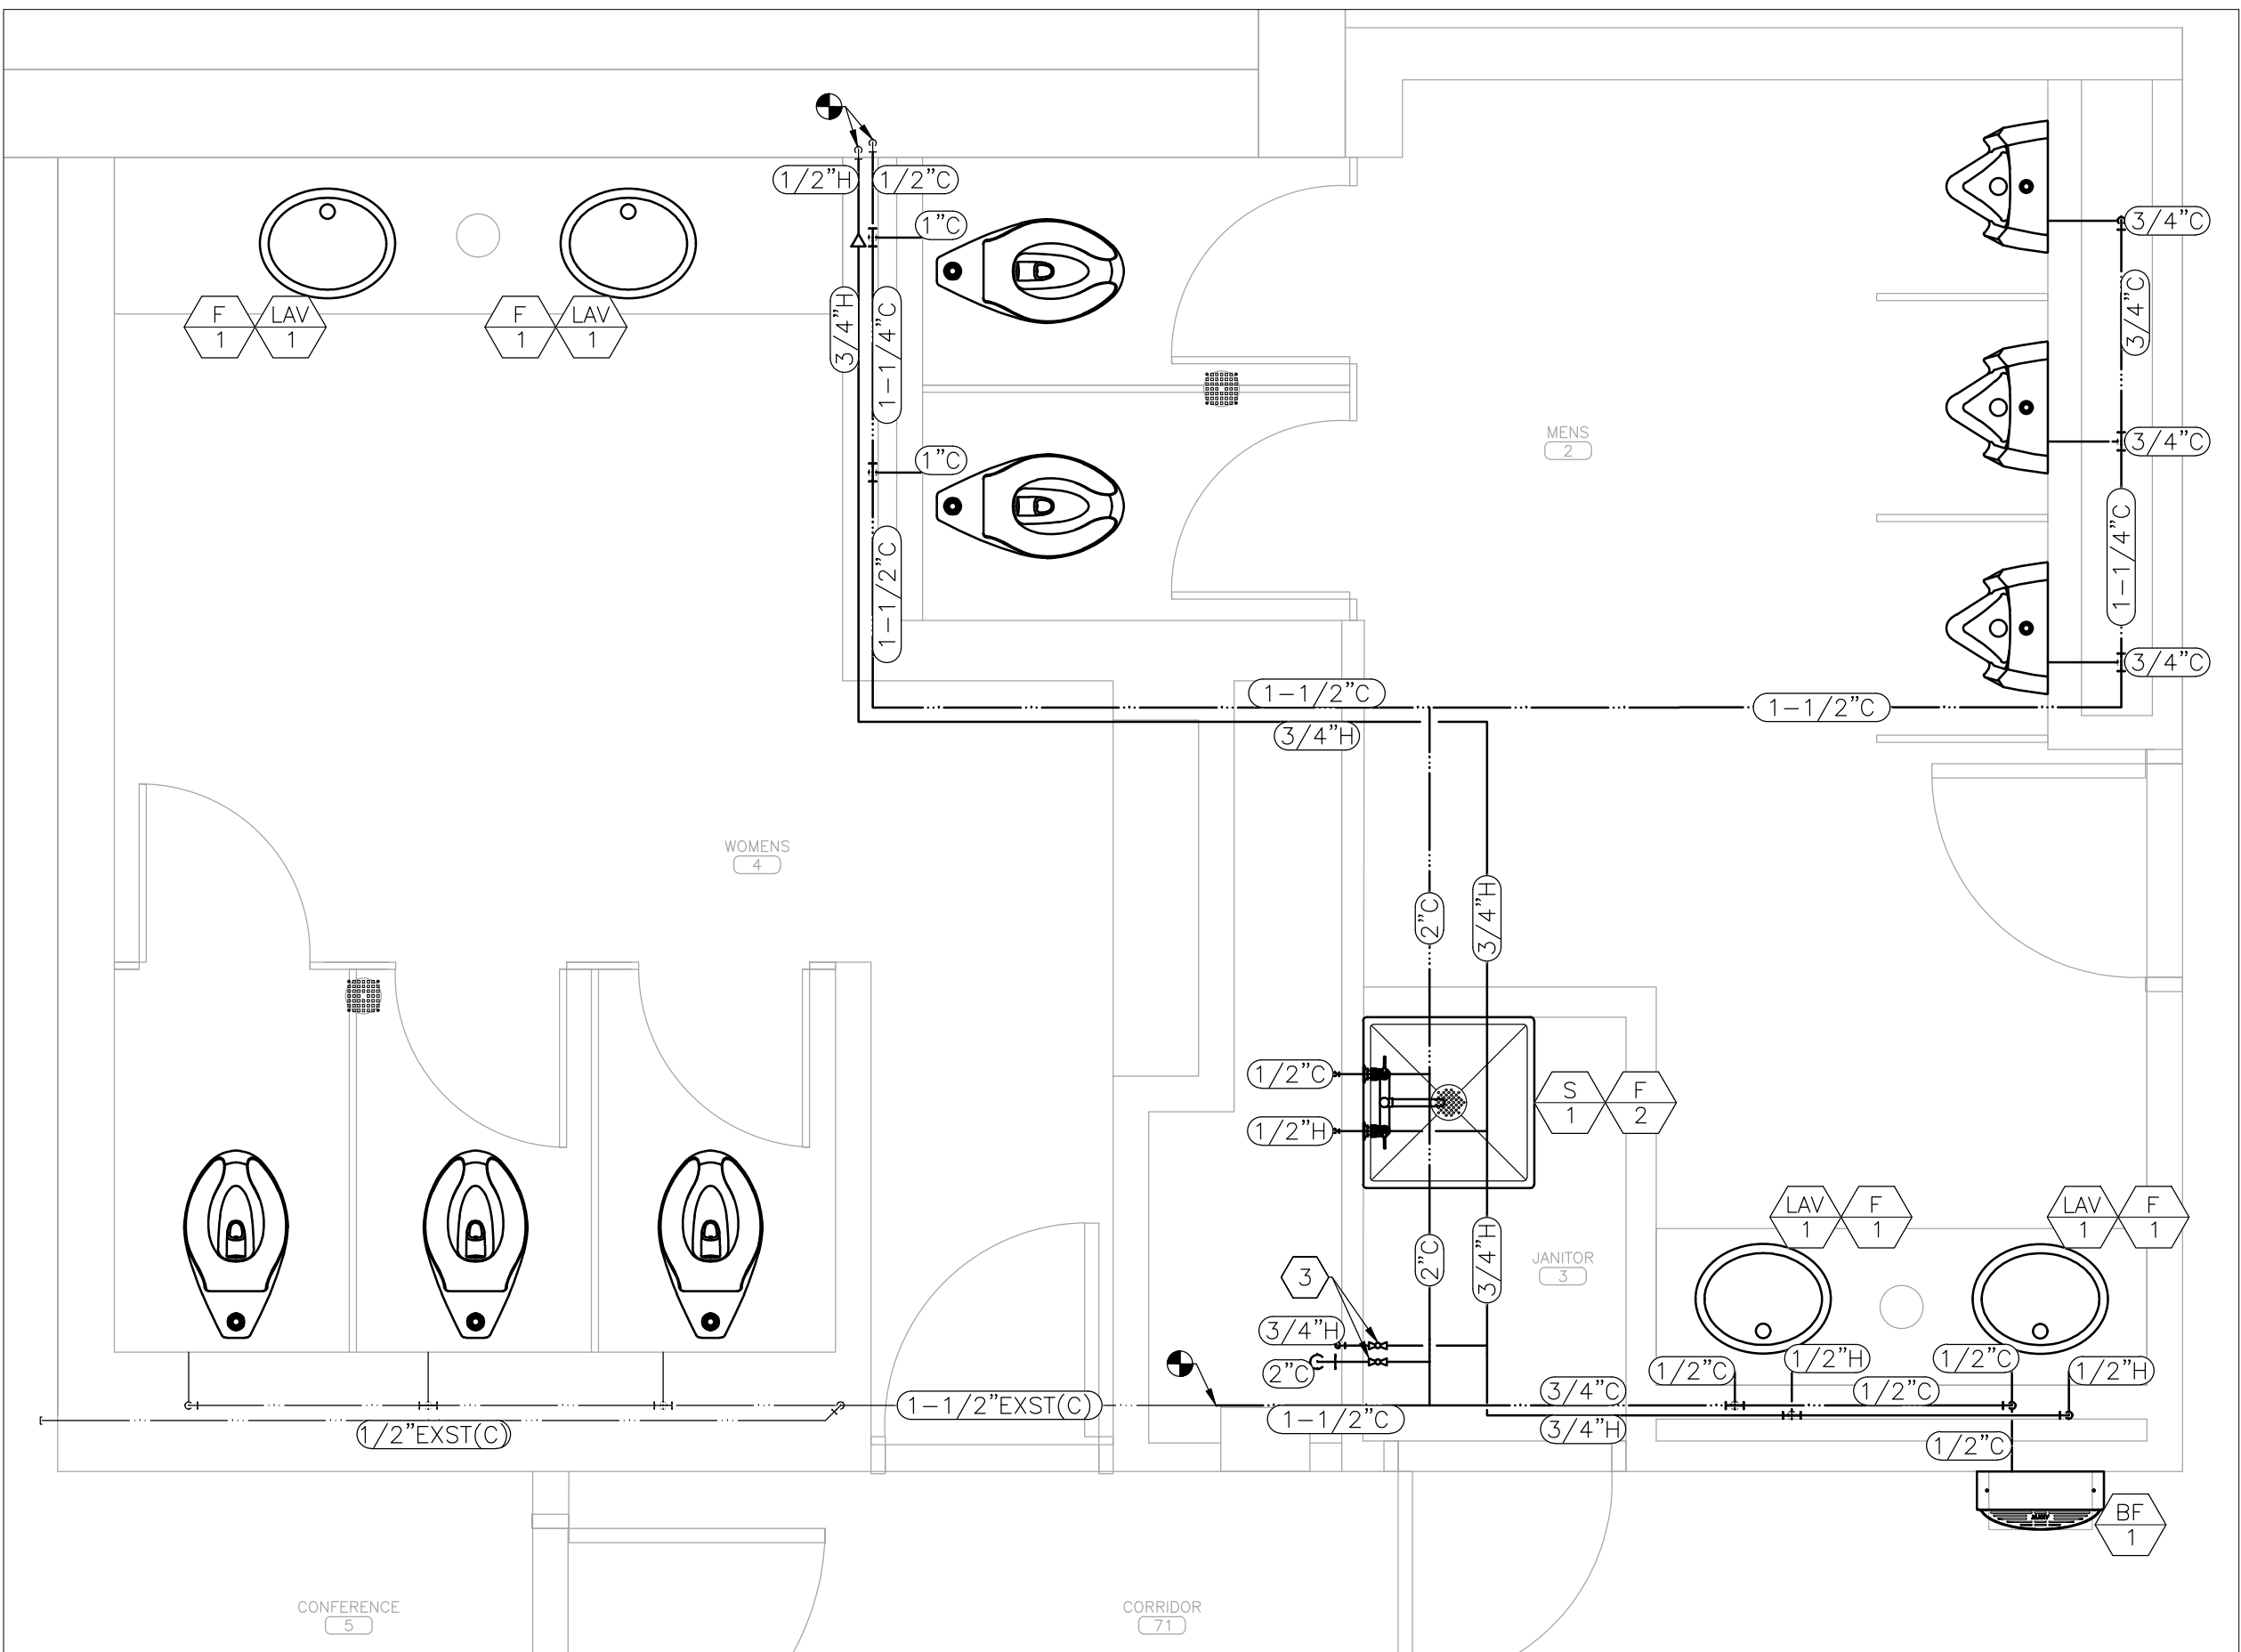


2 DOMESTIC WATER SUPPLY RENOVATION PLAN – PARTIAL SECOND FLOOR
SCALE: 1/2" = 1'-0"

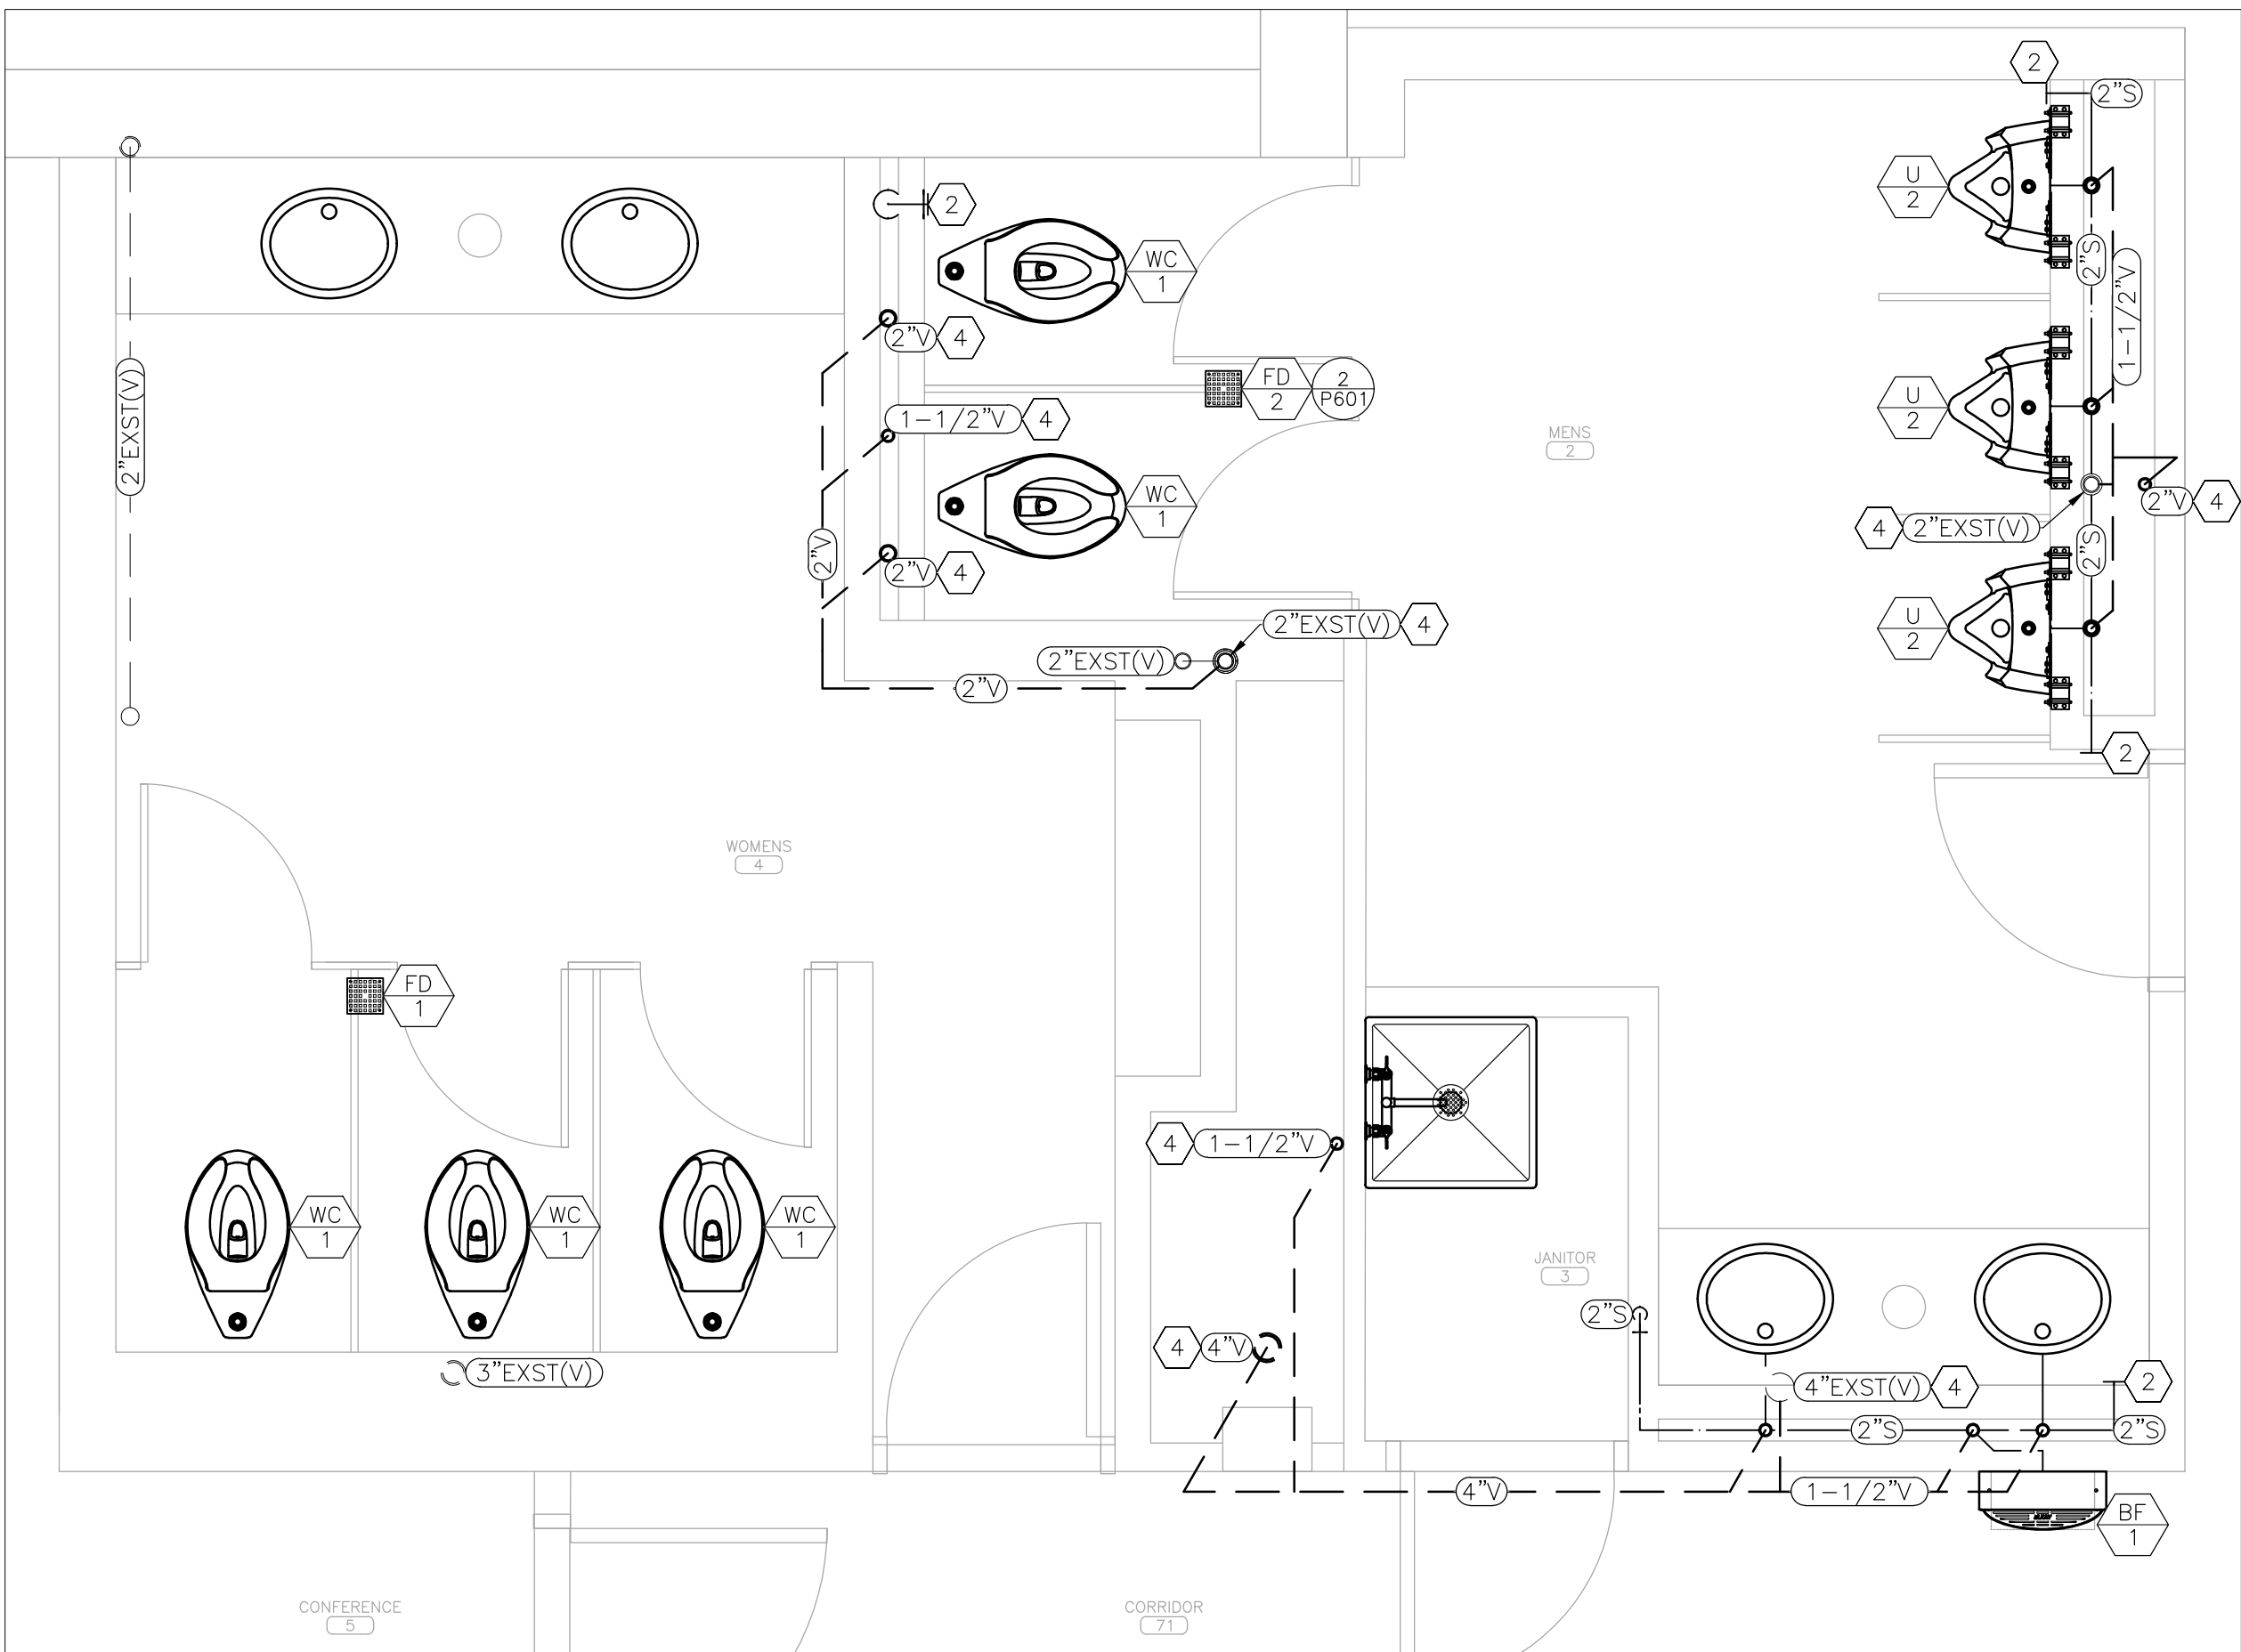


3 SANITARY SEWER RENOVATION PLAN – PARTIAL SECOND FLOOR
SCALE: 1/2" = 1'-0"

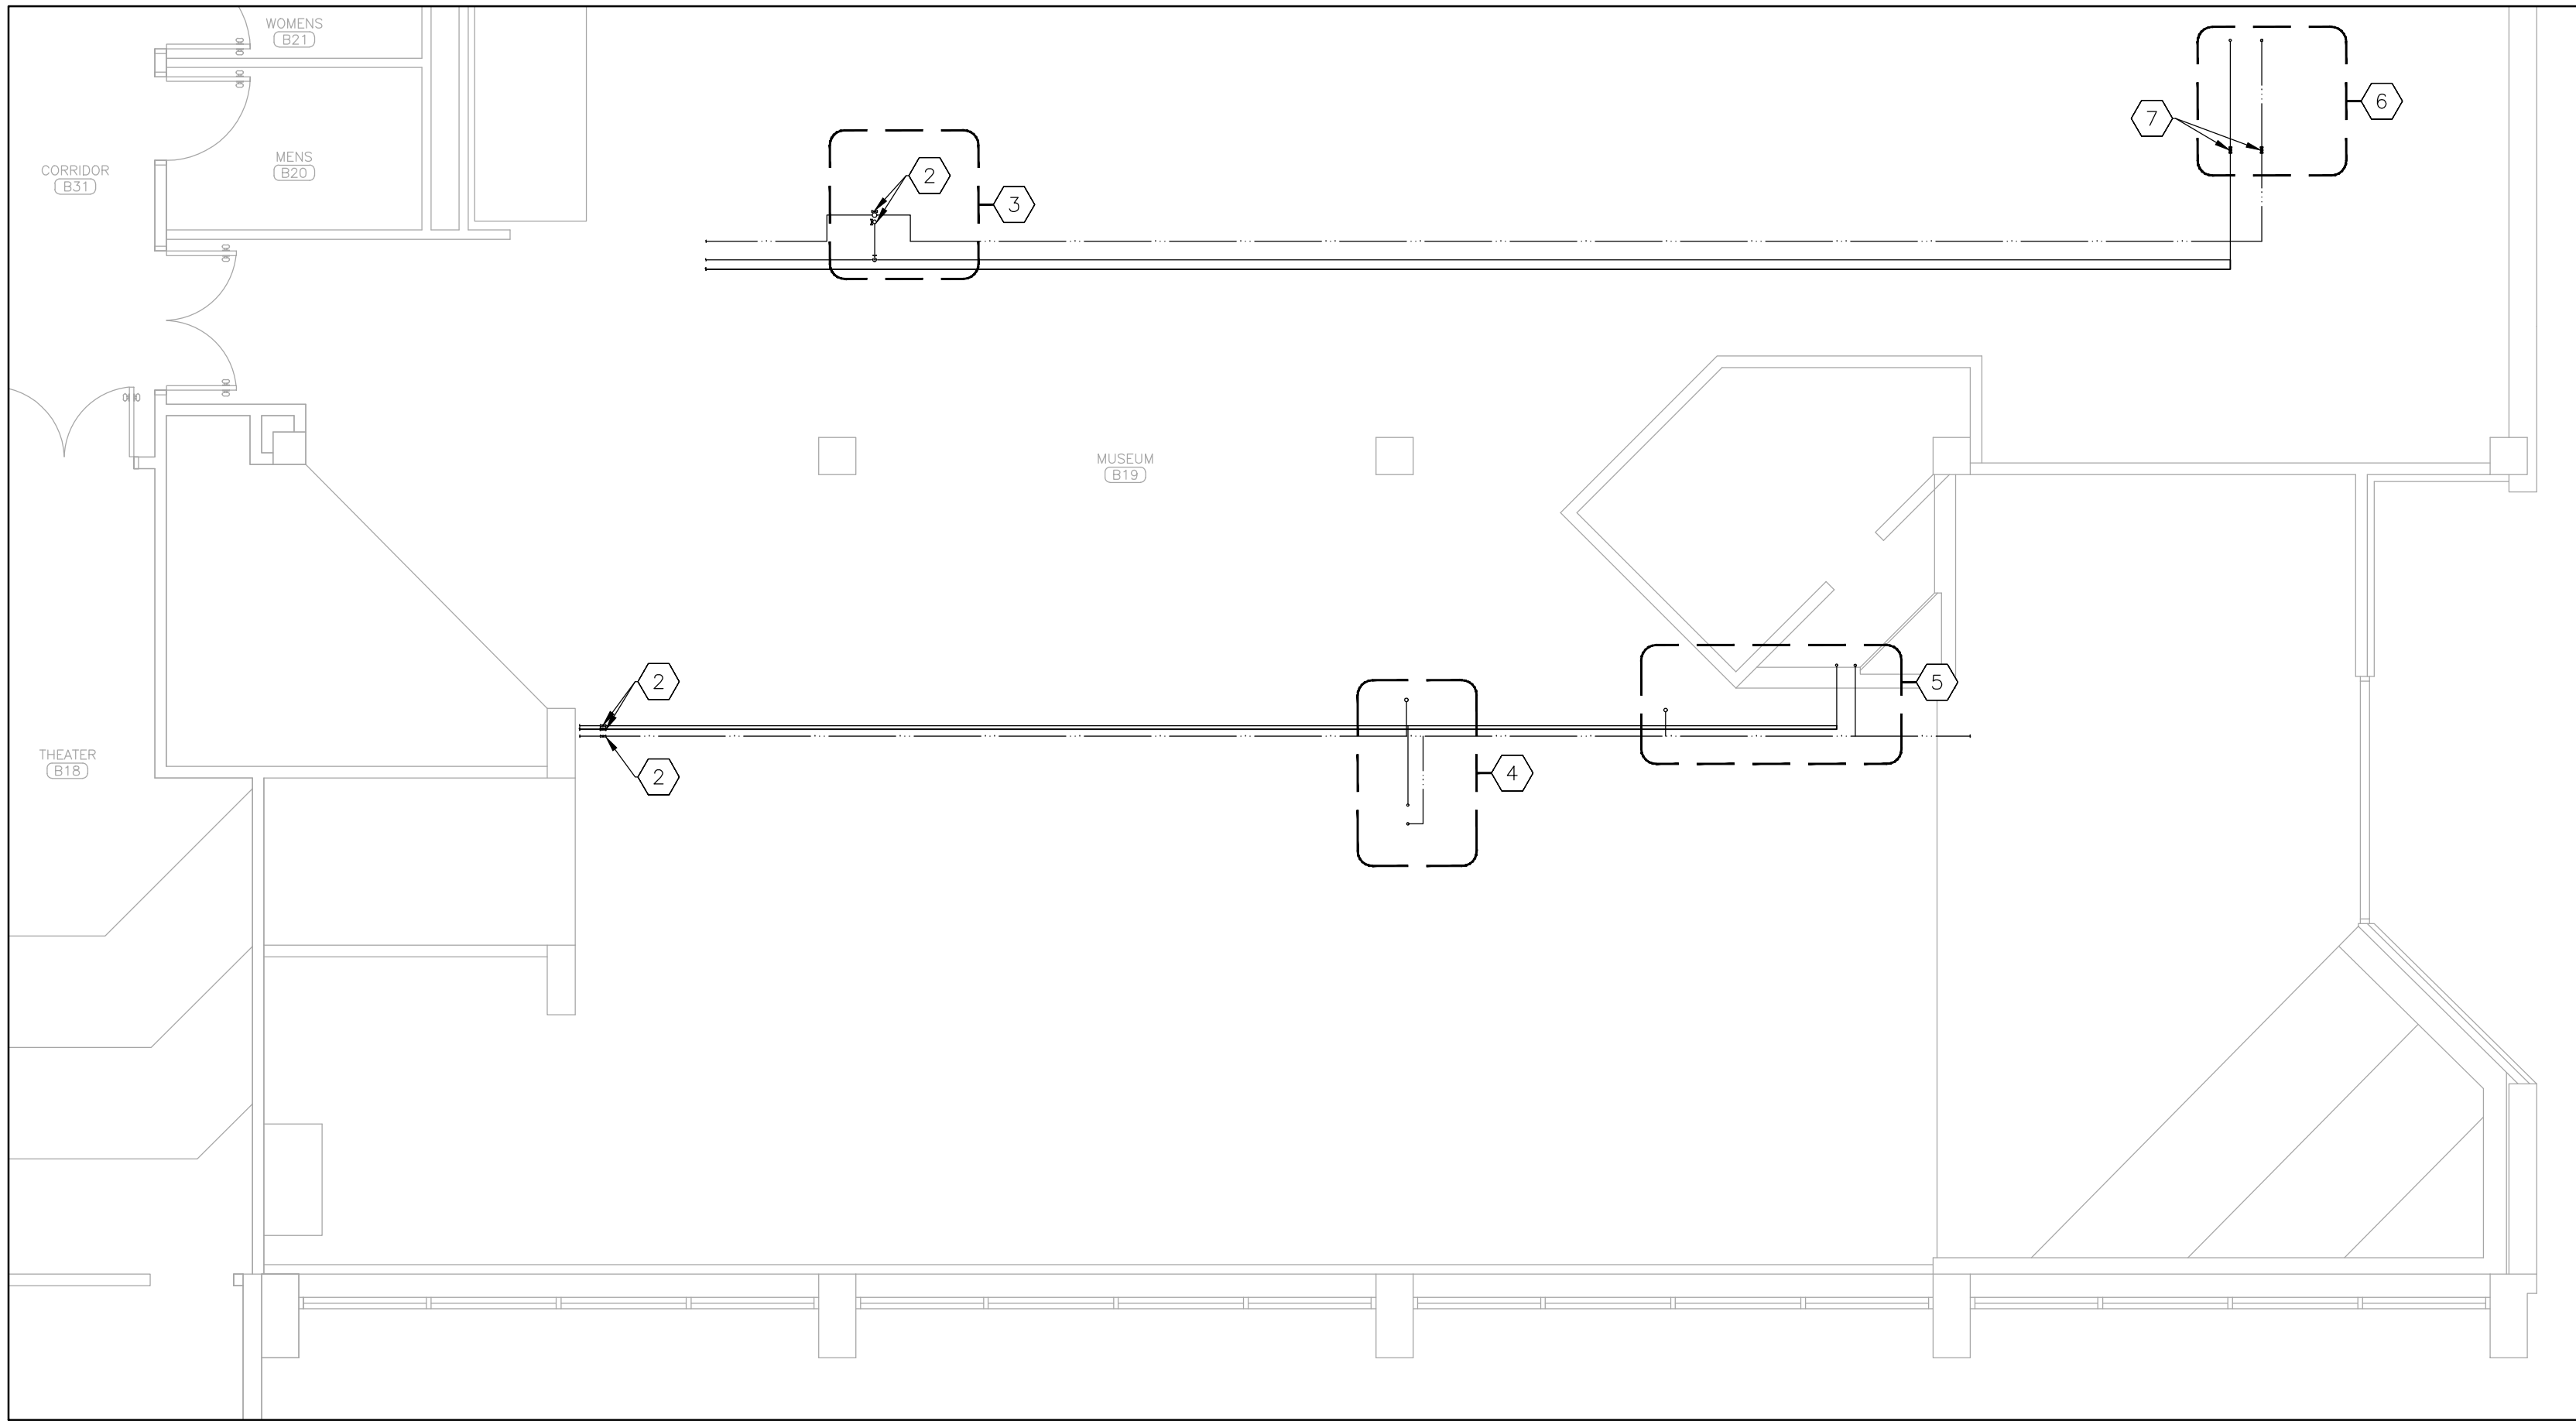

1 PLUMBING PLAN -- BASEMENT ISOLATION VALVES
SCALE: 3/16" = 1'-0"

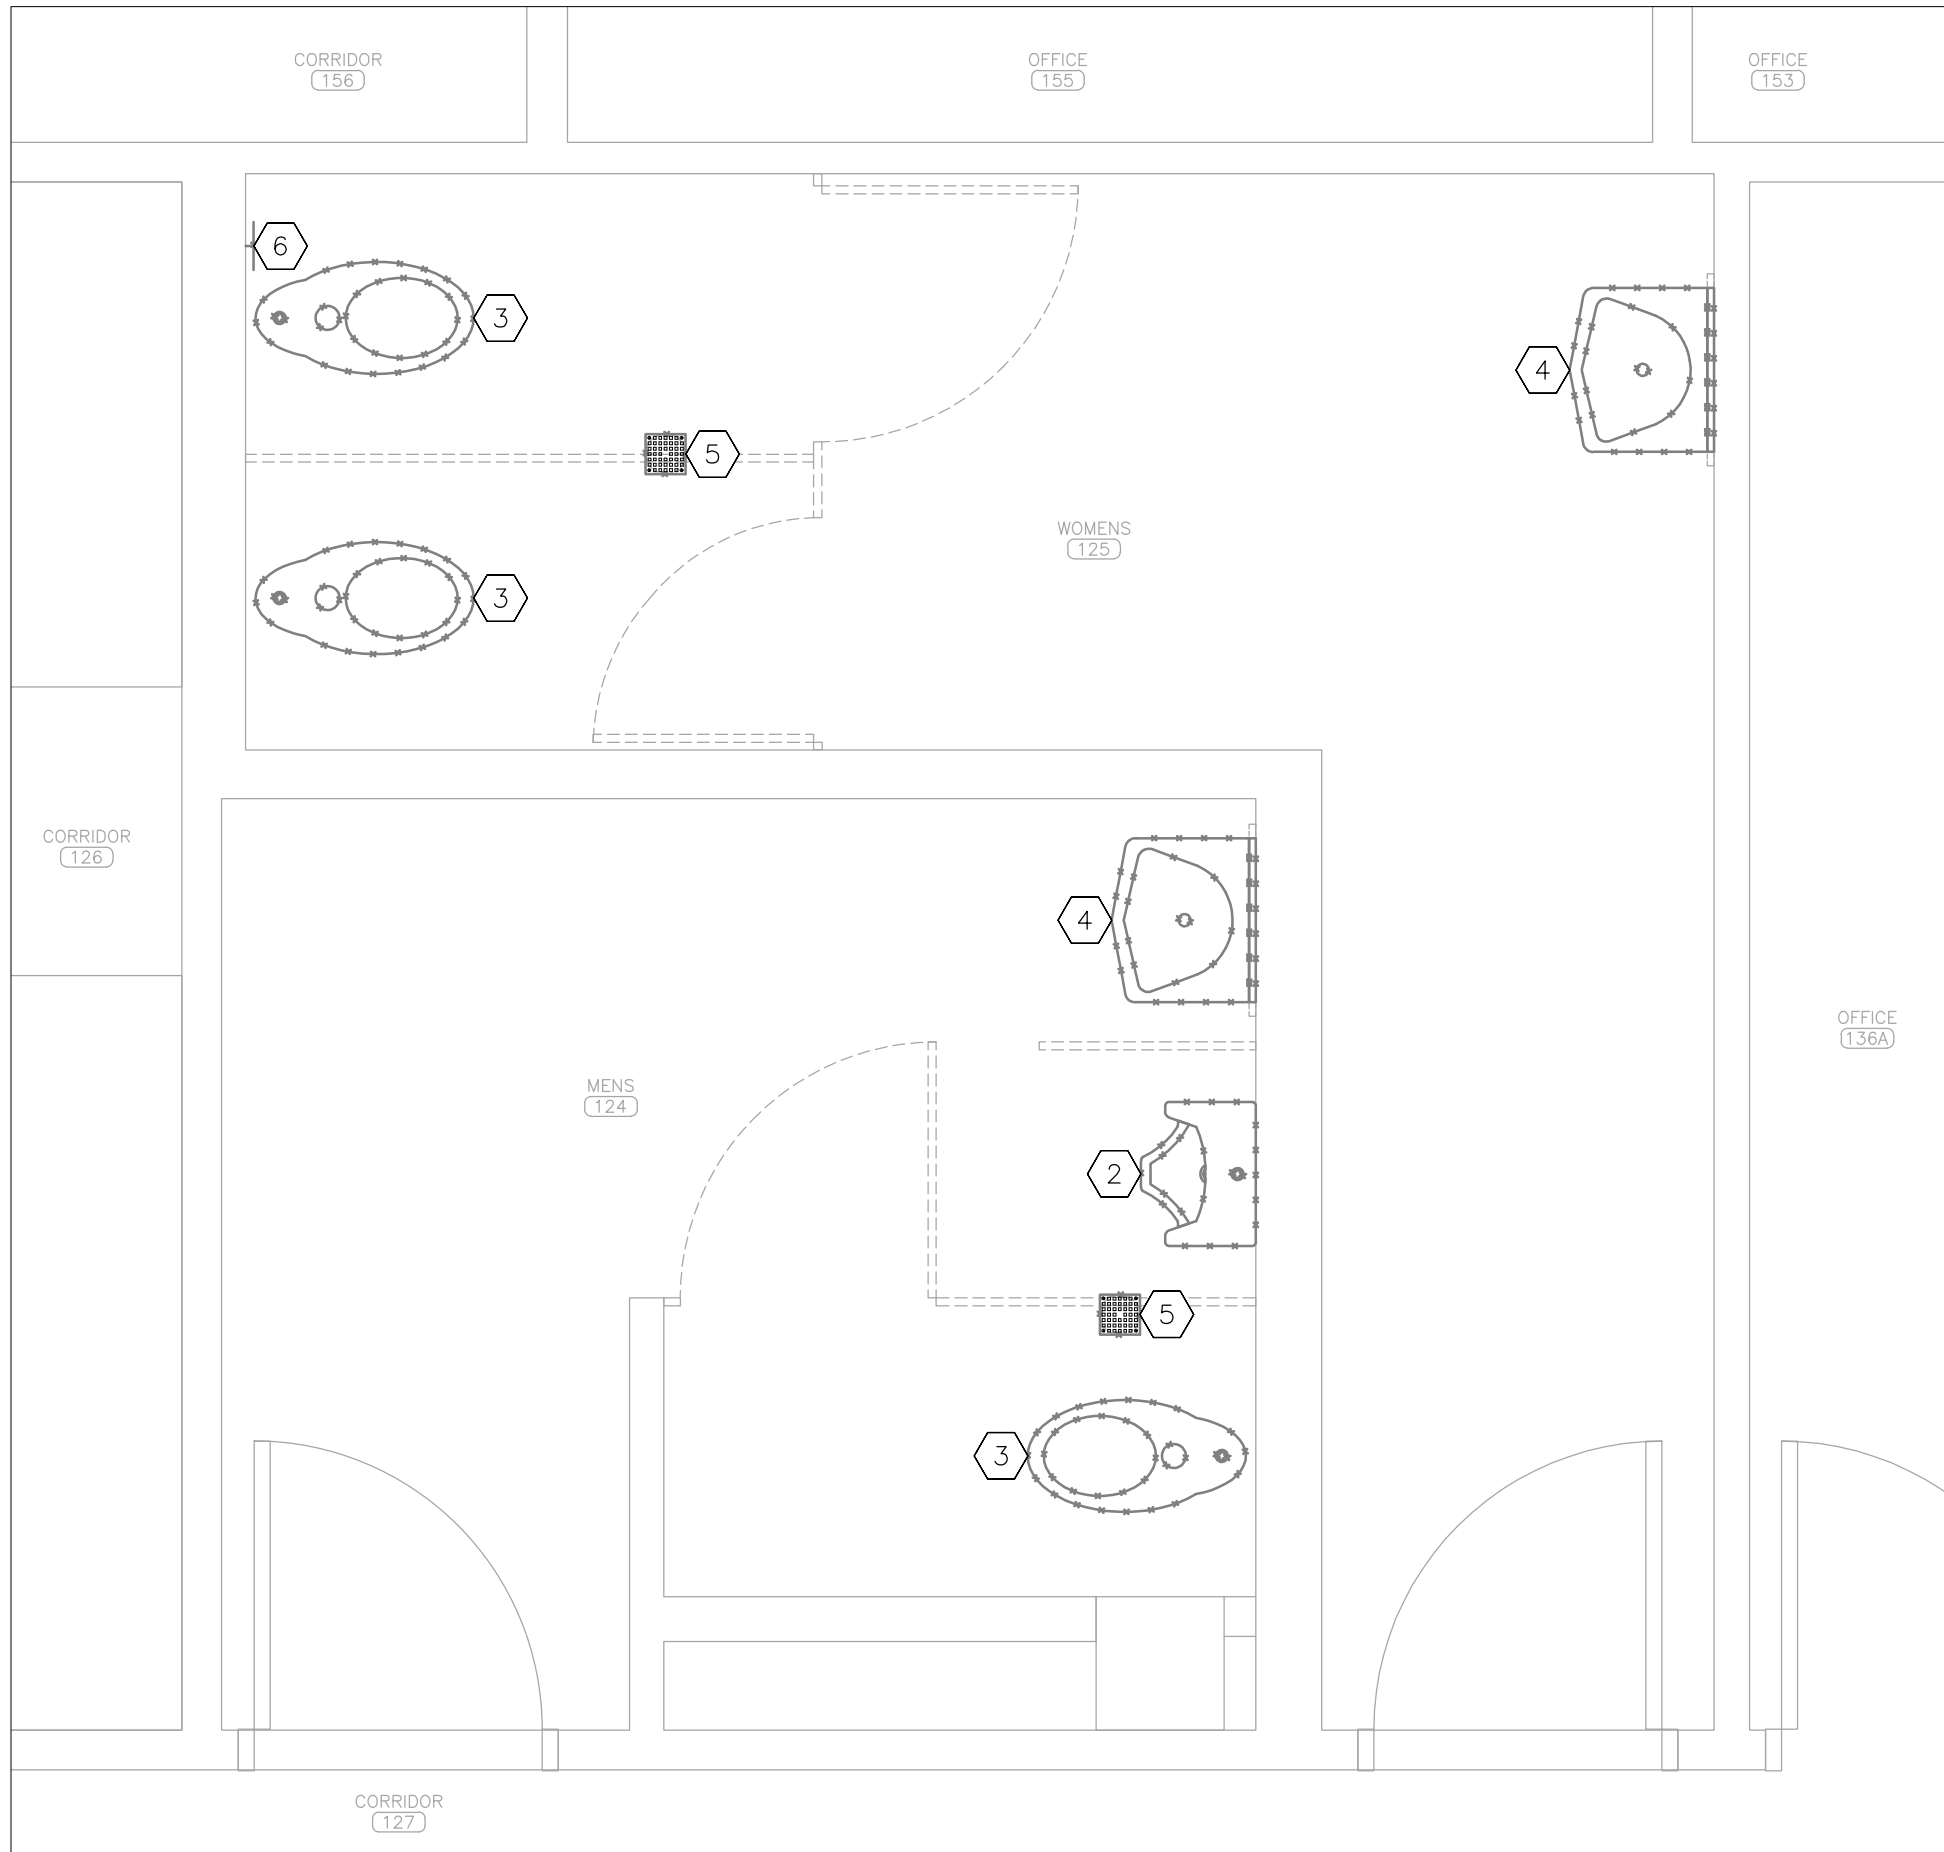

2 PLUMBING DEMOLITION PLAN -- PARTIAL FIRST FLOOR
SCALE: 1/2" = 1'-0"

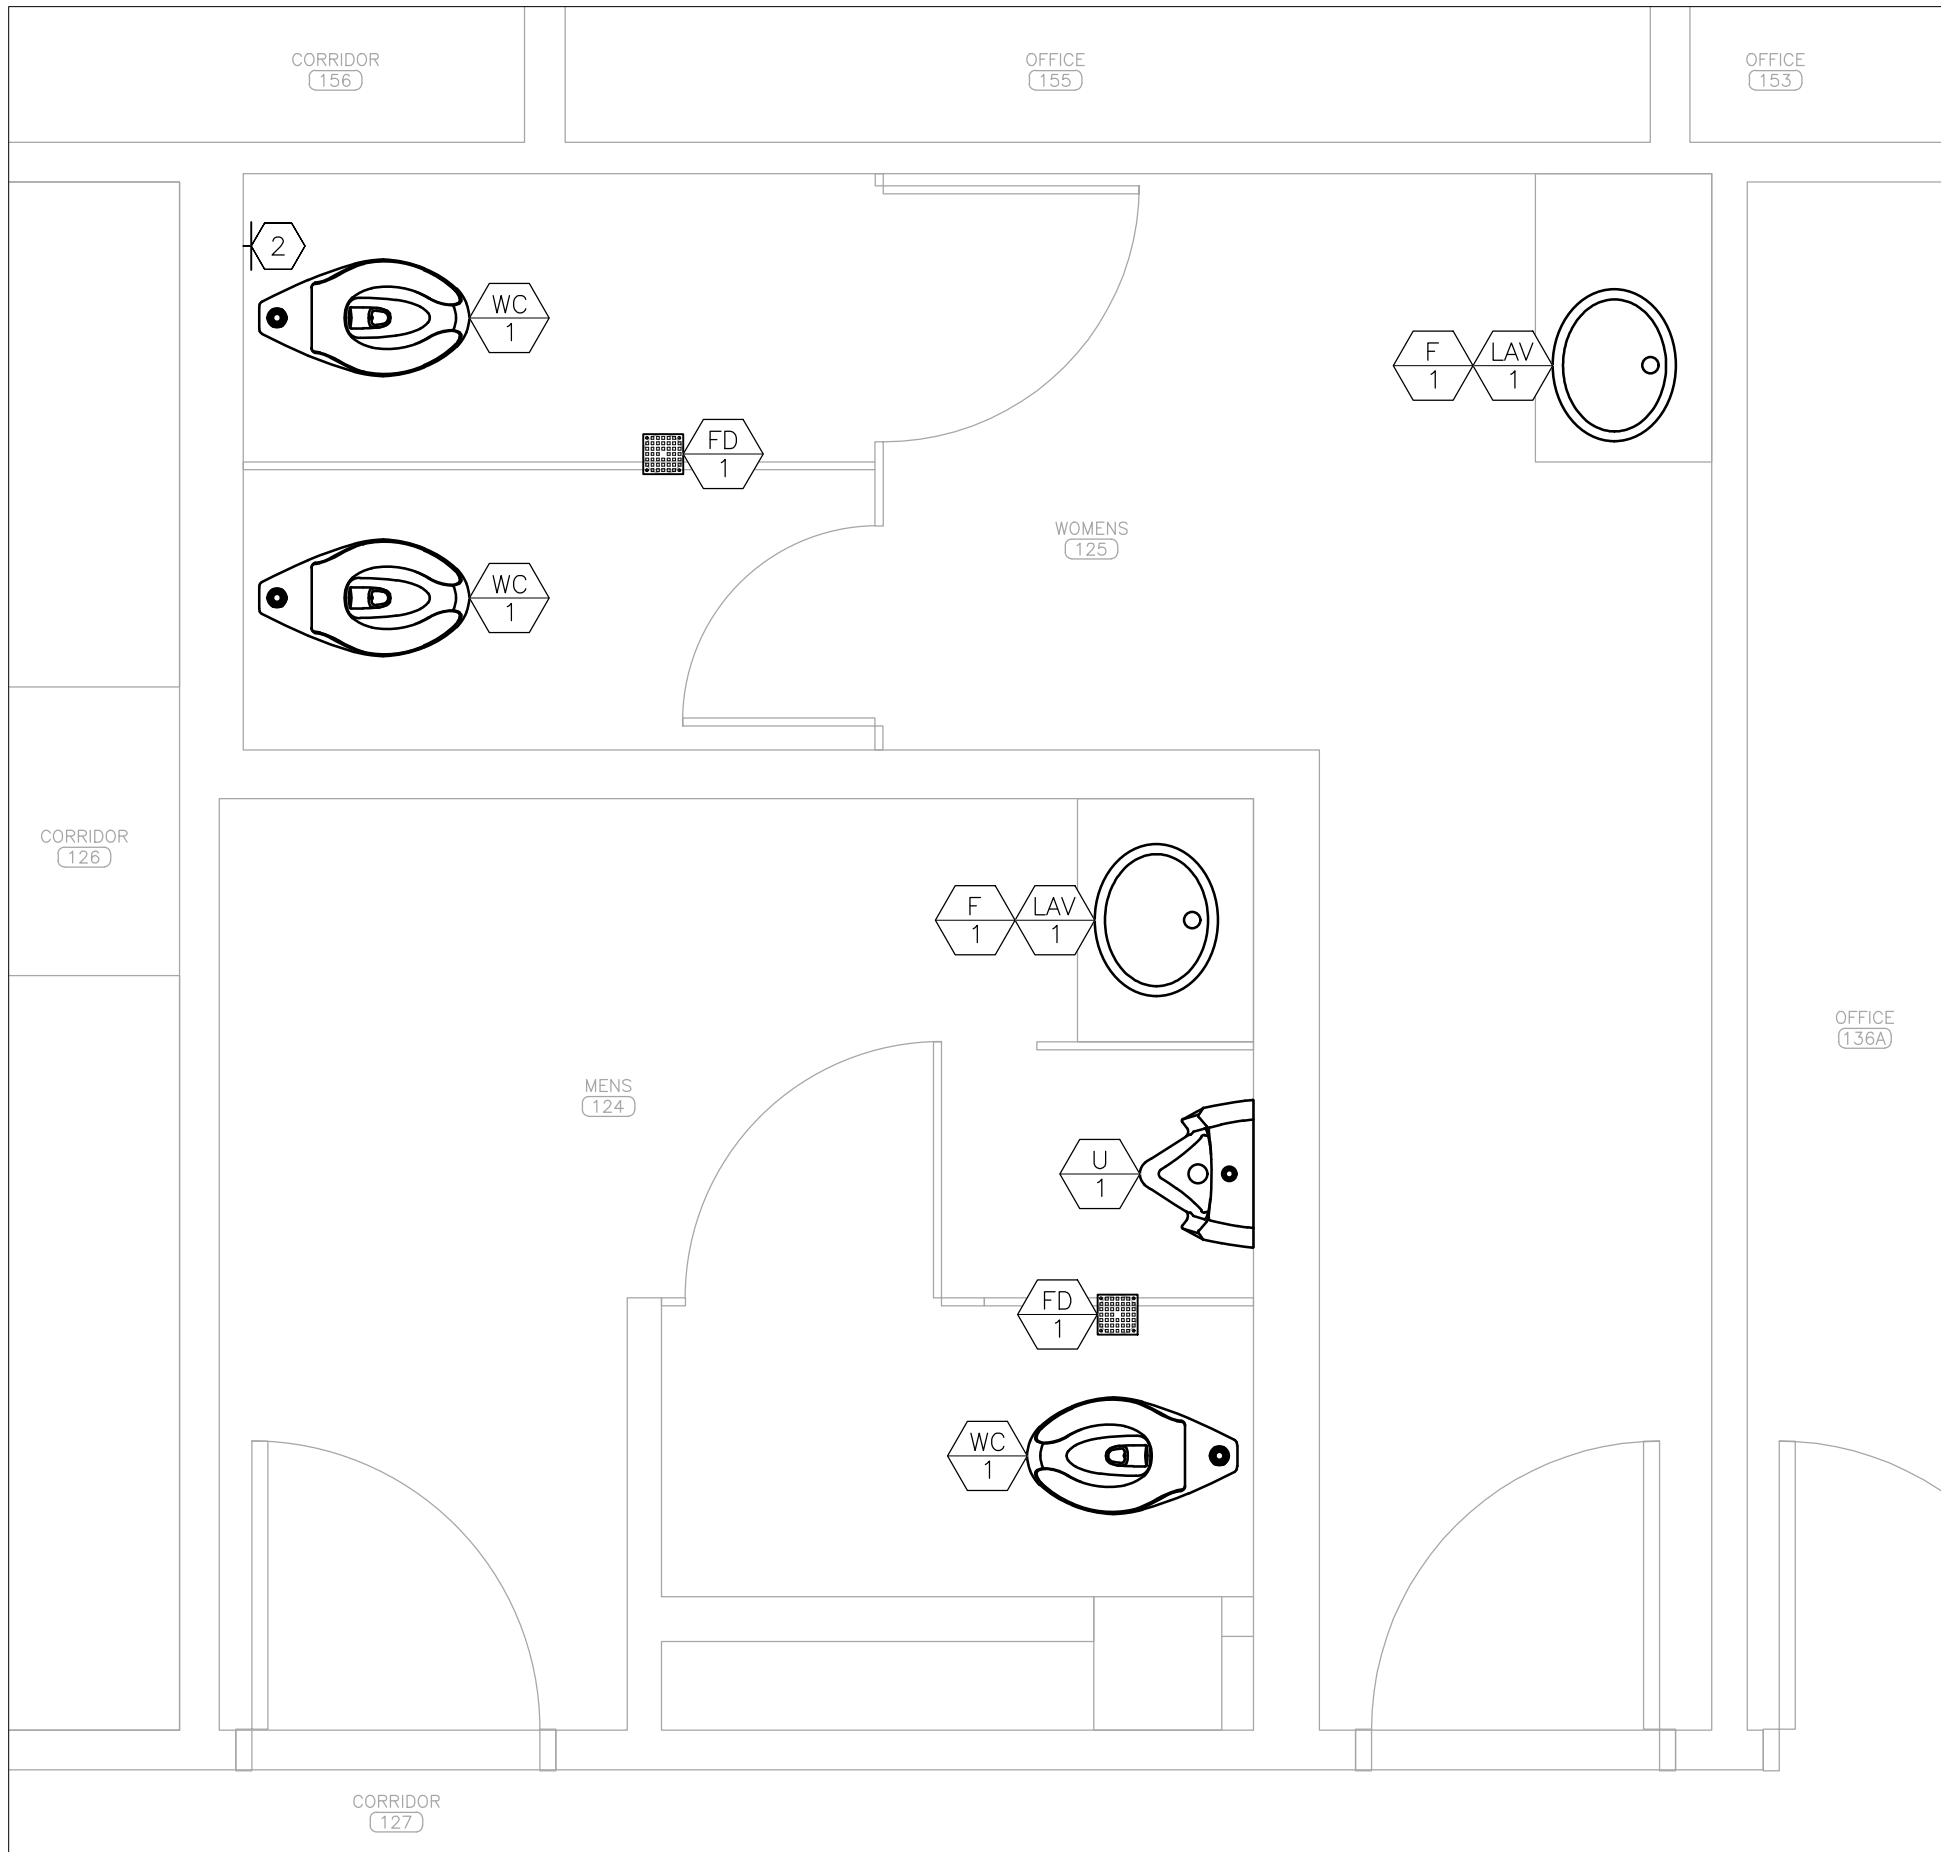

3 PLUMBING RENOVATION PLAN -- PARTIAL FIRST FLOOR
SCALE: 1/2" = 1'-0"

KEYNOTES -- DETAIL 1

INDICATES KEYED NOTES

- 1 REFER TO SHEET P-101 FOR GENERAL NOTES.
- 2 EXISTING COLD AND HOT WATER SUPPLY ISOLATION VALVES.
- 3 COLD AND HOT WATER SUPPLY PIPES SERVING FIRST FLOOR RESTROOMS 124 AND 125. REFER TO DETAILS 2 AND 3 THIS SHEET.
- 4 COLD AND HOT WATER SUPPLY PIPES SERVING FIRST FLOOR RESTROOM 134A. REFER TO DETAILS 1 AND 3 ON SHEET P-105.
- 5 COLD AND HOT WATER SUPPLY PIPES SERVING FIRST FLOOR RESTROOM 136A. REFER TO DETAILS 1 AND 3 ON SHEET P-105.
- 6 COLD AND HOT WATER SUPPLY PIPES SERVING FIRST FLOOR RESTROOM 142A. REFER TO DETAILS 2 AND 4 ON SHEET P-105.
- 7 DEMOLISH SECTION OF WATER SUPPLY PIPE FOR BALL VALVE INSTALLATION. PROVIDE AND INSTALL LEAD-FREE, QUARTER-TURN, FULL PORT BALL VALVES ON COLD WATER AND HOT WATER PIPES IN ACCESSIBLE LOCATION. WORK SHALL BE PERFORMED OUTSIDE OF NORMAL BUSINESS HOURS.

DEMOLITION NOTES -- DETAIL 2

INDICATES KEYED NOTES

- 1 REFER TO SHEET P-101 FOR GENERAL DEMOLITION NOTES.
- 2 DEMOLISH URINAL AND ASSOCIATED FLUSHOMETER. WATER SUPPLY AND SANITARY DRAIN LOCATIONS TO REMAIN.
- 3 DEMOLISH WATER CLOSET AND ASSOCIATED FLUSHOMETER. WATER SUPPLY AND SANITARY DRAIN LOCATIONS TO REMAIN.
- 4 DEMOLISH LAVATORY, FAUCET, RISERS, AND SUPPLY STOPS. HOT AND COLD WATER SUPPLY AND SANITARY DRAIN LOCATIONS TO REMAIN.
- 5 DEMOLISH FLOOR DRAIN STRAINER. ASSOCIATED SANITARY DRAIN BODY AND PIPE TO REMAIN.
- 6 DEMOLISH WALL CLEANOUT COVER. ASSOCIATED SANITARY CLEANOUT AND DRAIN PIPE TO REMAIN.


RENOVATION NOTES -- DETAIL 3

INDICATES KEYED NOTES


- 1 REFER TO SHEET P-101 FOR GENERAL RENOVATION NOTES.
- 2 PROVIDE NEW STAINLESS STEEL WALL CLEANOUT COVER.

PLUMBING LEGEND

AA #	DEVICE SCHEDULE TAG
	BALL VALVE
	BALL VALVE LOCATED IN RISER
	PLUMBING FIXTURE -- NEW
	DOMESTIC COLD WATER (C) -- NEW
	DOMESTIC COLD WATER (C) -- EXISTING
	DOMESTIC HOT WATER (H) -- NEW
	DOMESTIC HOT WATER (H) -- EXISTING
	HOT WATER RECIRCULATION (R) -- EXISTING
	EXISTING MATERIALS TO BE REMOVED

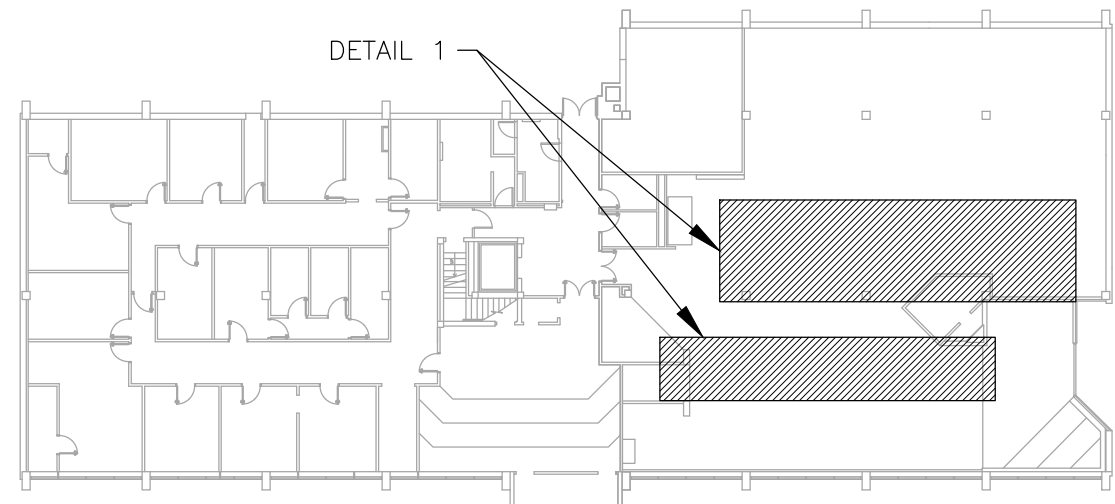

4 AREA MAP -- BASEMENT

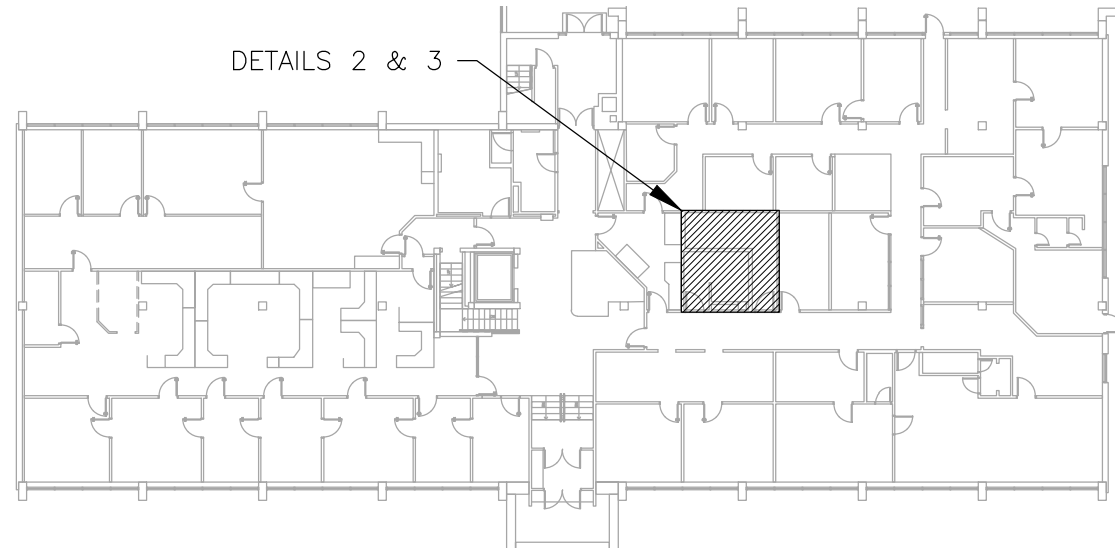

5 AREA MAP -- FIRST FLOOR

STATE OF MISSOURI
MIKE KEHOE,
GOVERNOR



Tracie L. Siebeneck - Engineer
MO# PE-2013019114

BID DOCUMENTS

OFFICE OF ADMINISTRATION
DIVISION OF FACILITIES
MANAGEMENT,
DESIGN AND CONSTRUCTION

DEPARTMENT OF
PUBLIC SAFETY
STATE HIGHWAY PATROL

RENOVATE INTERIOR

GENERAL HEADQUARTERS
1510 EAST ELM STREET
JEFFERSON CITY, MO 65101

PROJECT # R2410-01
SITE # 6001
ASSET # 8136001001

REVISION: _____
DATE: _____
REVISION: _____
DATE: _____
REVISION: _____
DATE: _____
ISSUE DATE: 06/18/2026

CAD DWG FILE: P_R2410-01
DRAWN BY: TS/AH
CHECKED BY: TS
DESIGNED BY: TS/AH

SHEET TITLE:

PARTIAL
PLUMBING PLAN
FIRST FLOOR

SHEET NUMBER:

P-104

23 OF 39 SHEETS
06/18/2026



Tracie L. Siebeneck - Engineer
MO# PE-2013019114

BID
DOCUMENTS

OFFICE OF ADMINISTRATION
DIVISION OF FACILITIES
MANAGEMENT,
DESIGN AND CONSTRUCTION

DEPARTMENT OF
PUBLIC SAFETY
STATE HIGHWAY PATROL

RENOVATE INTERIOR

GENERAL HEADQUARTERS
1510 EAST ELM STREET
JEFFERSON CITY, MO 65101

PROJECT # R2410-01
SITE # 6001
ASSET # 8136001001

REVISION: _____
DATE: _____
REVISION: _____
DATE: _____
REVISION: _____
DATE: _____
ISSUE DATE: 06/18/2026

CAD DWG FILE: P_R2410-01
DRAWN BY: TS/AH
CHECKED BY: TS
DESIGNED BY: TS/AH

SHEET TITLE:

PARTIAL
PLUMBING PLAN
FIRST FLOOR

SHEET NUMBER:

P-105

24 OF 39 SHEETS
06/18/2026



DEMOLITION NOTES – DETAILS 1 & 2 # INDICATES KEYED NOTES

- 1 REFER TO SHEET P-101 FOR GENERAL DEMOLITION NOTES.
- 2 DEMOLISH WATER CLOSET AND ASSOCIATED FLUSHOMETER, WATER SUPPLY AND SANITARY DRAIN LOCATIONS TO REMAIN.
- 3 DEMOLISH LAVATORY, FAUCET, RISERS, AND SUPPLY STOPS. HOT AND COLD WATER SUPPLY AND SANITARY DRAIN LOCATIONS TO REMAIN.


RENOVATION NOTES – DETAILS 3 & 4 # INDICATES KEYED NOTES

- 1 REFER TO SHEET P-101 FOR GENERAL RENOVATION NOTES.


PLUMBING LEGEND	
	DEVICE SCHEDULE TAG
	PLUMBING FIXTURE – NEW
	EXISTING MATERIALS TO BE REMOVED

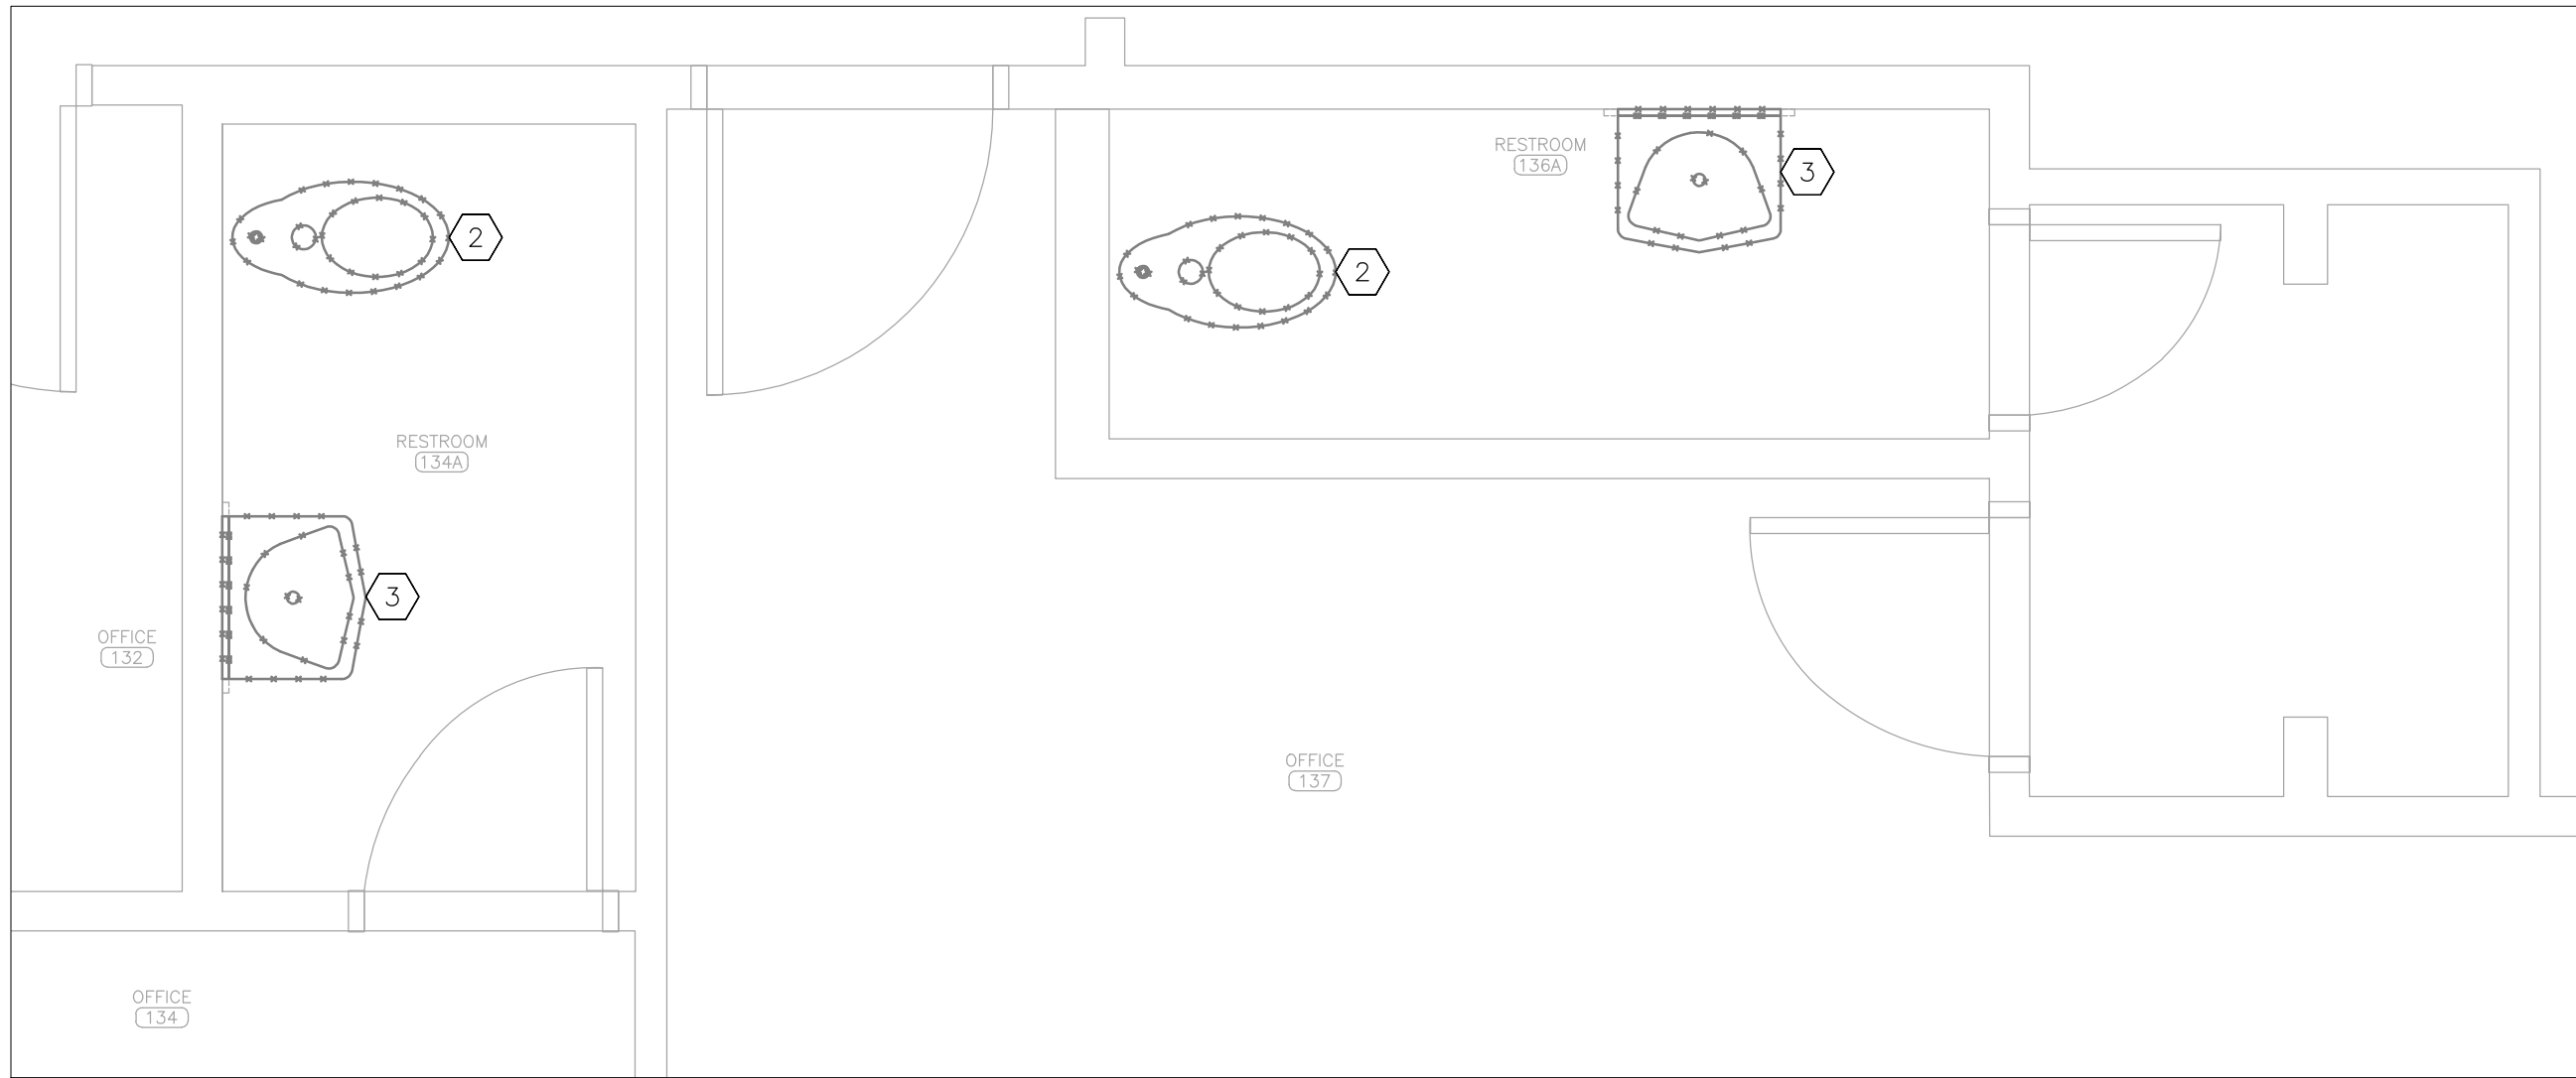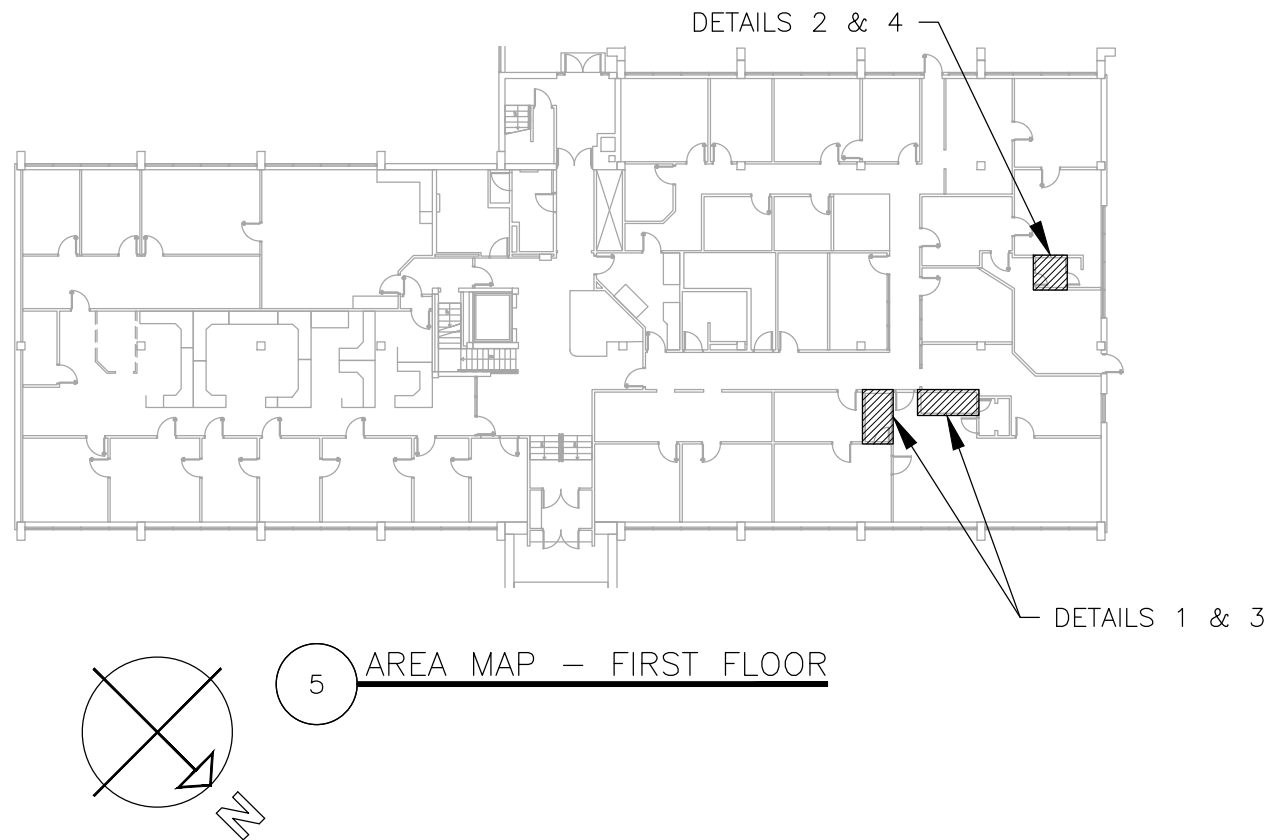


1 PLUMBING DEMOLITION PLAN – PARTIAL FIRST FLOOR
SCALE: 1/2" = 1'-0"

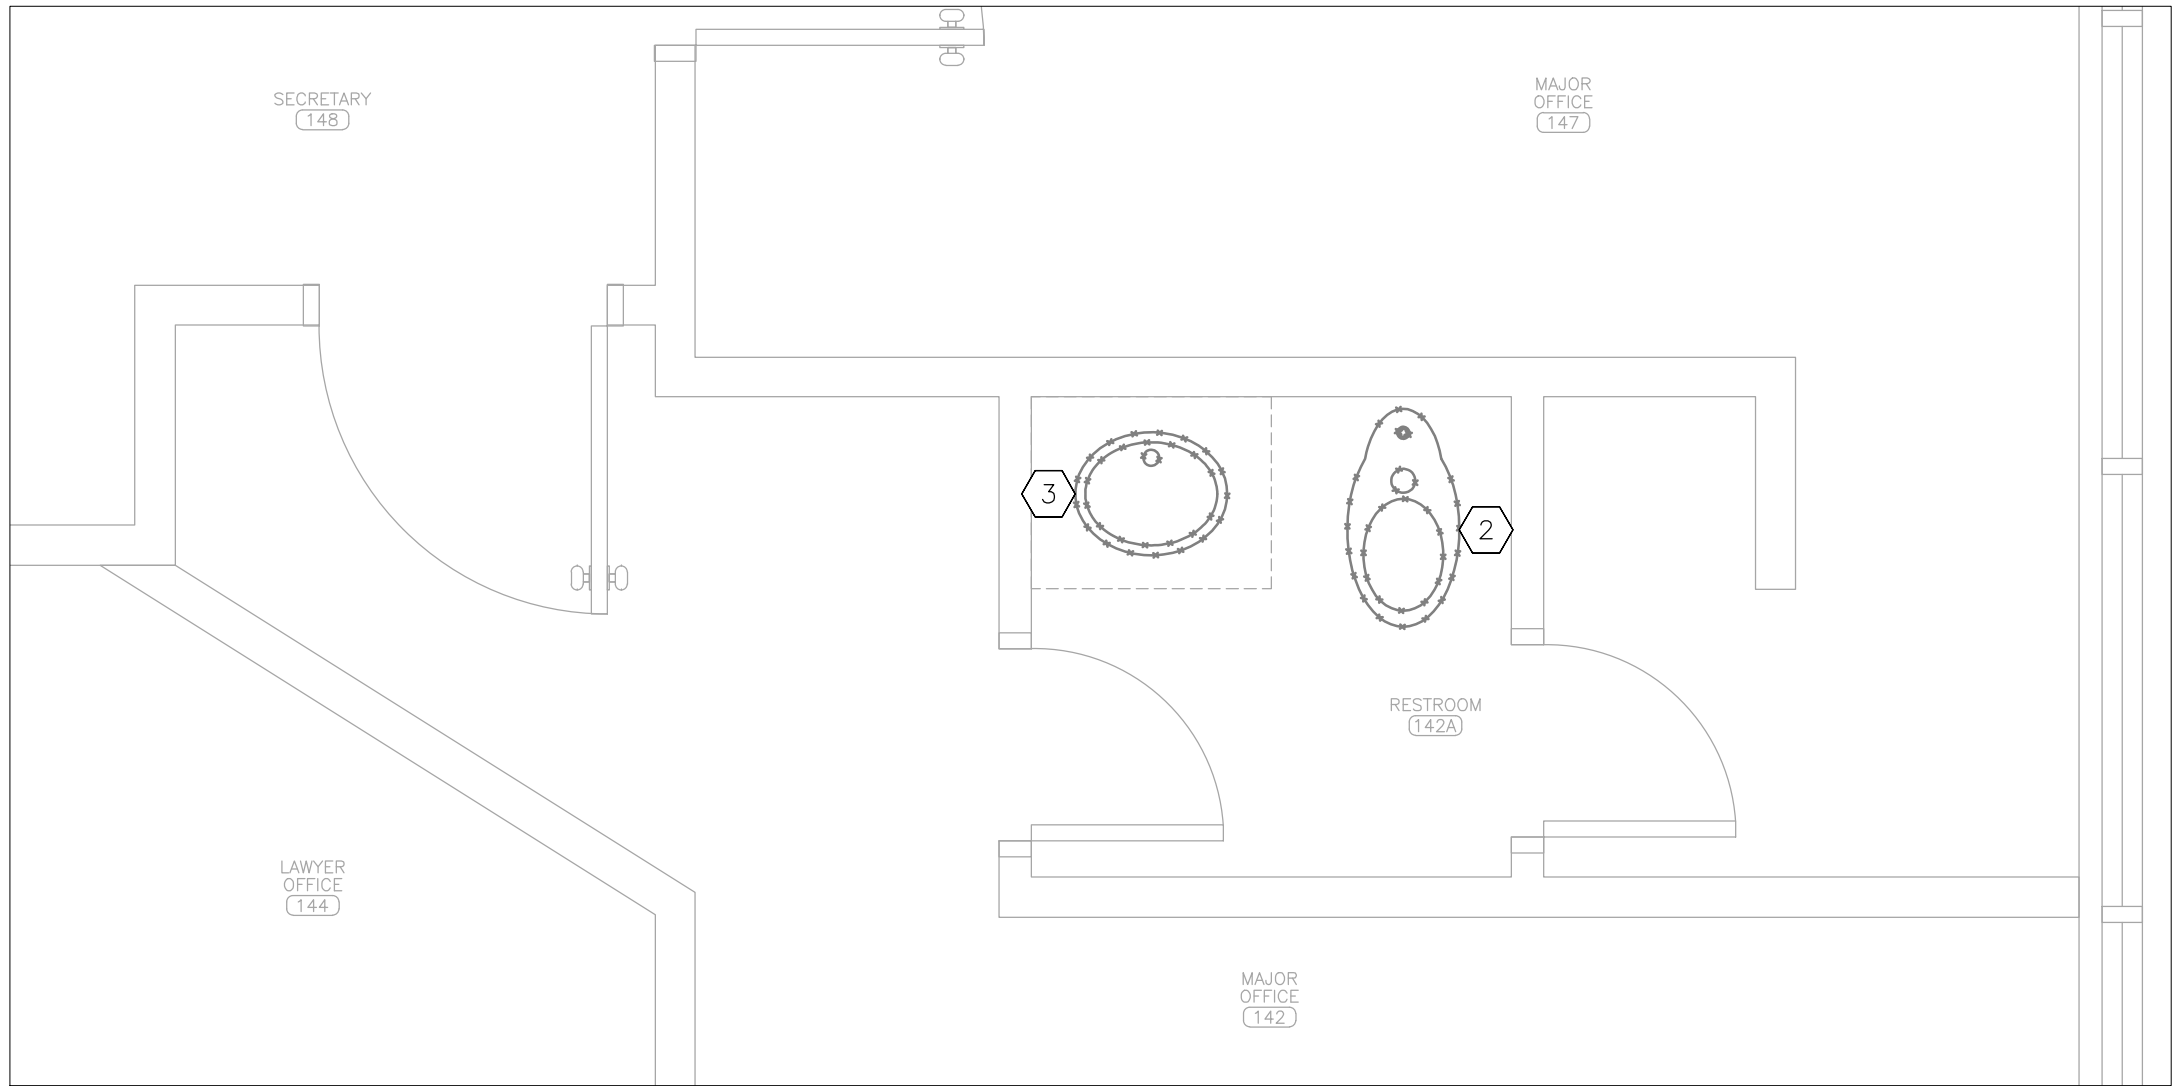

2 PLUMBING DEMOLITION PLAN – PARTIAL FIRST FLOOR
SCALE: 1/2" = 1'-0"

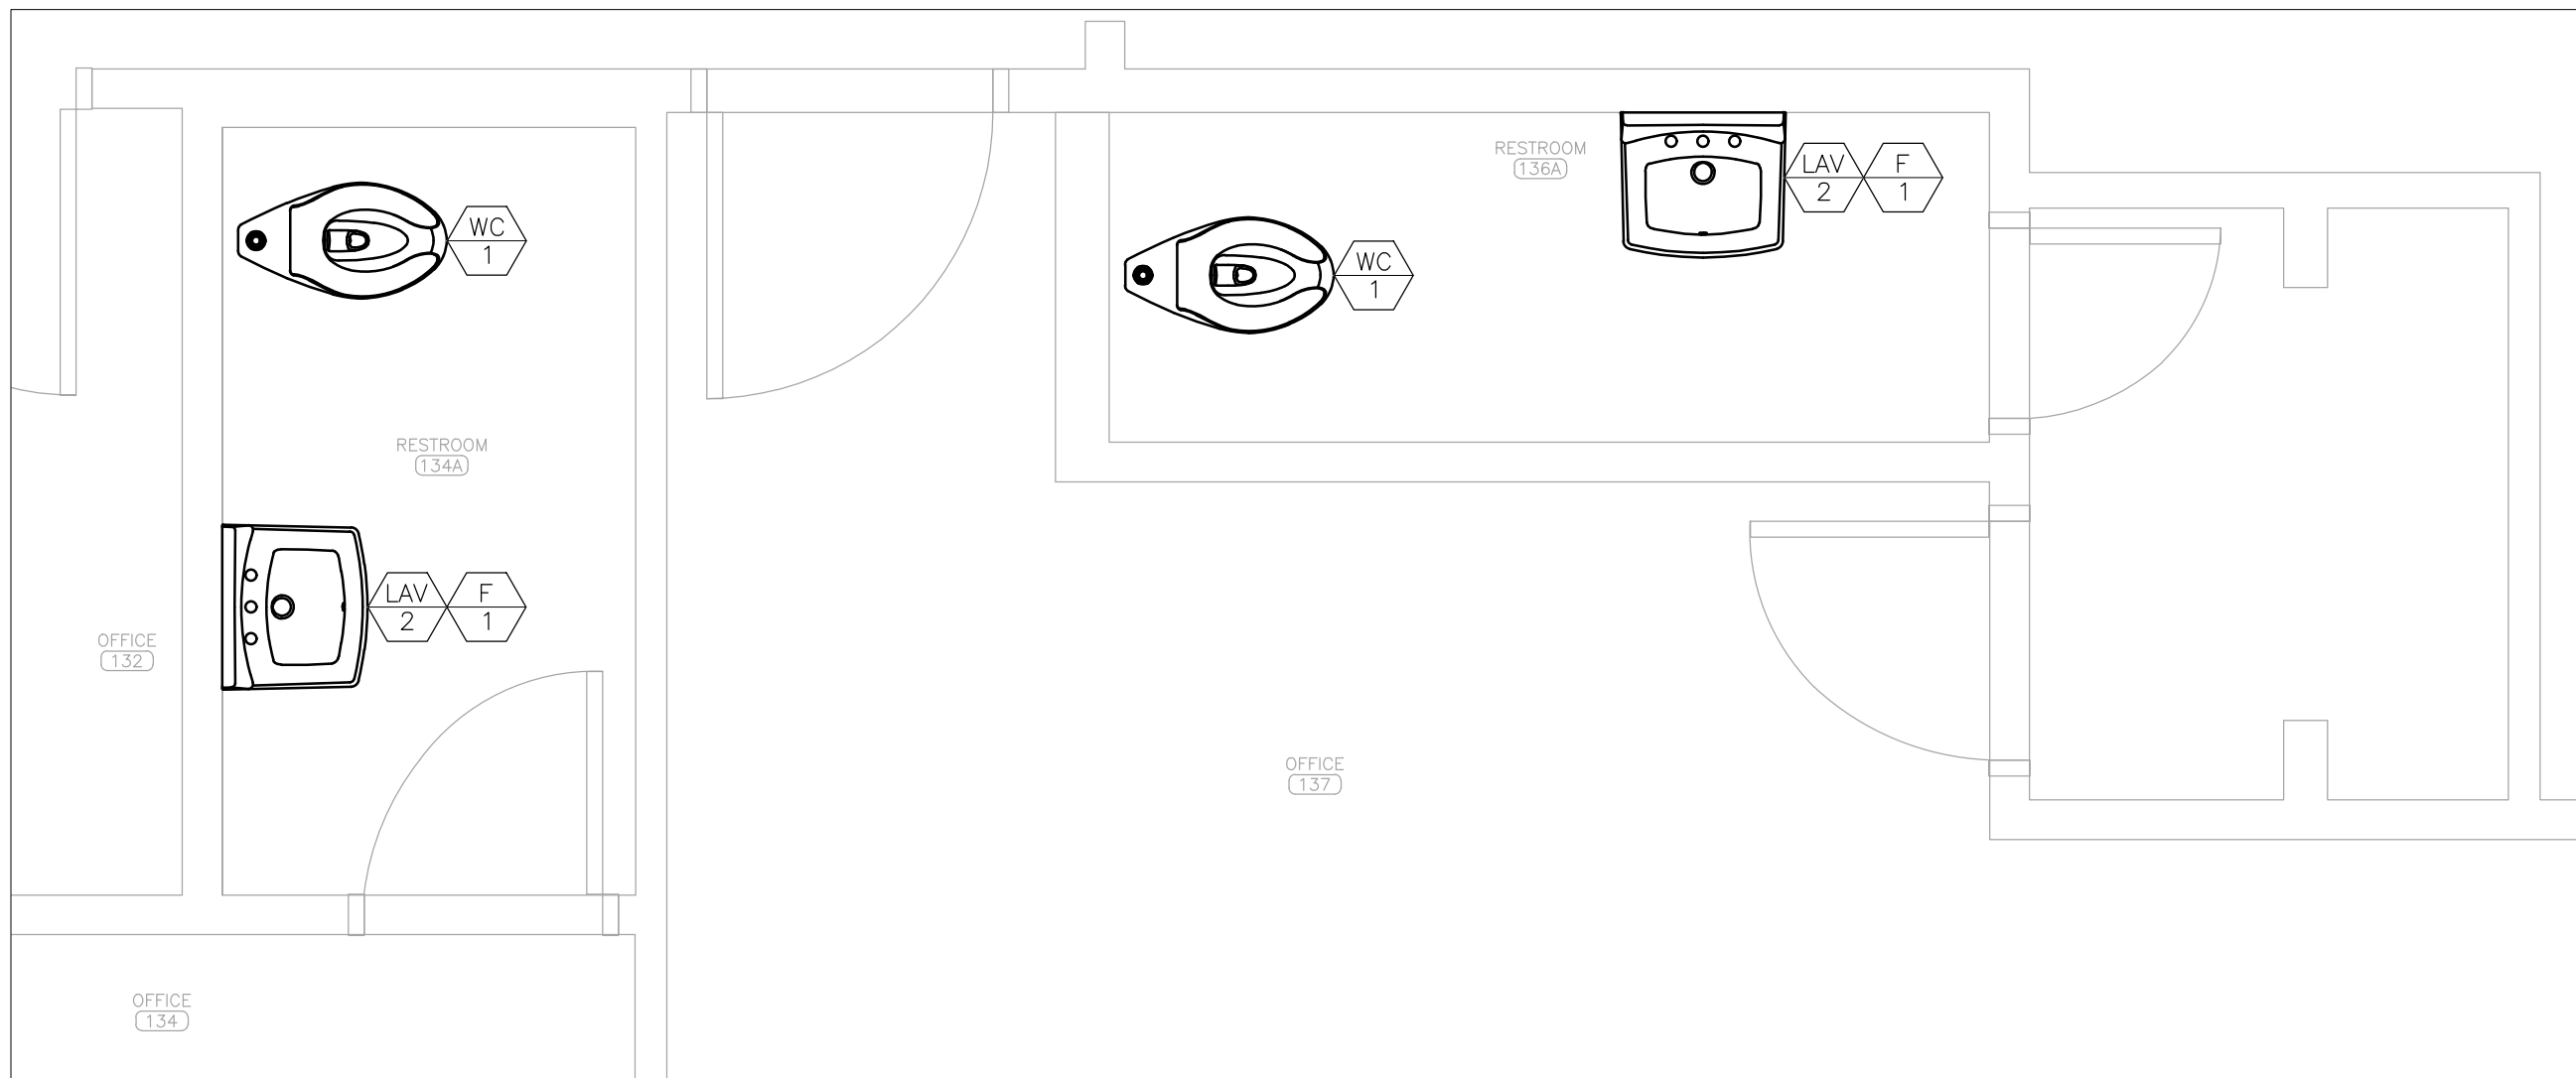

3 PLUMBING RENOVATION PLAN – PARTIAL FIRST FLOOR
SCALE: 1/2" = 1'-0"

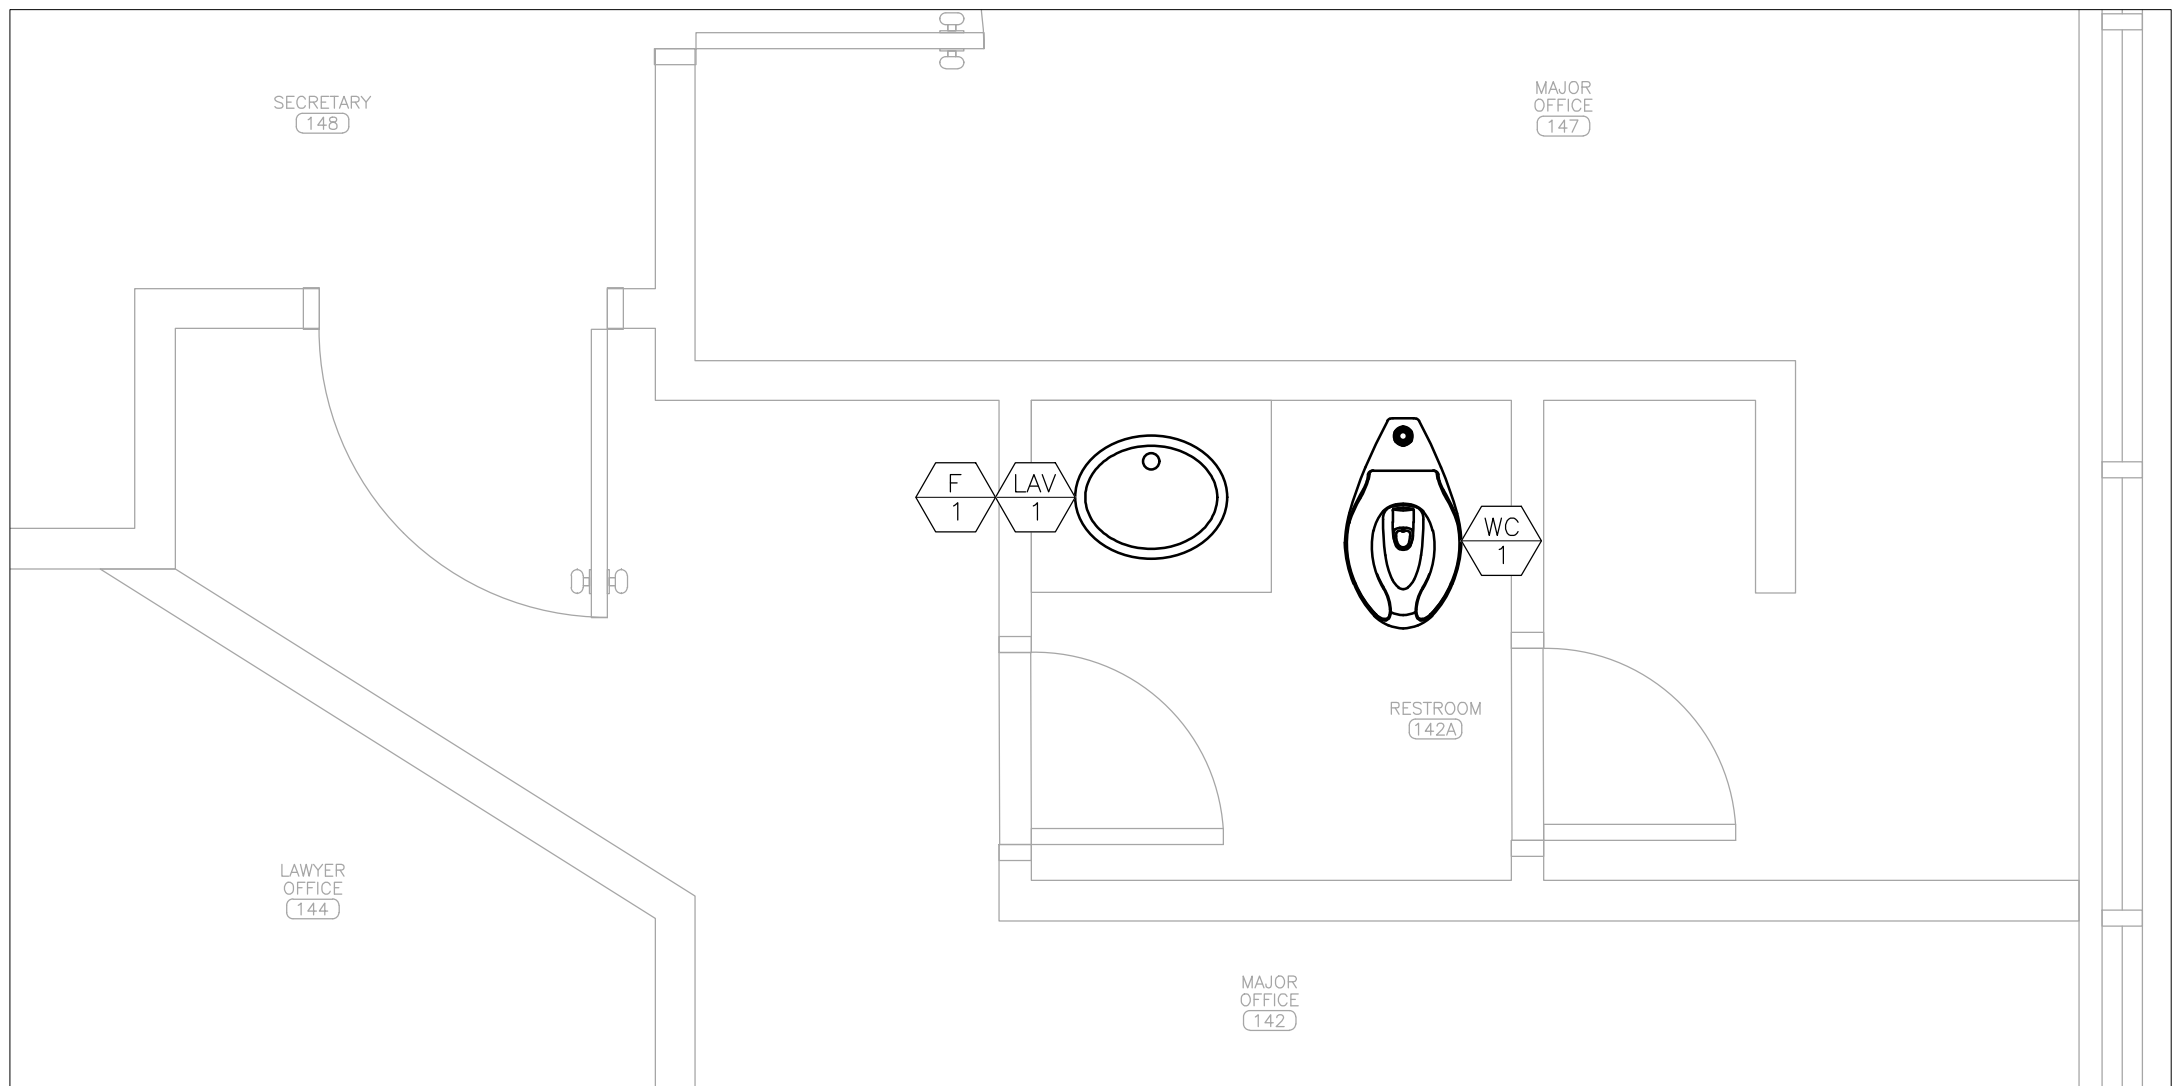

4 PLUMBING RENOVATION PLAN – PARTIAL FIRST FLOOR
SCALE: 1/2" = 1'-0"

DEMOLITION NOTES – DETAIL 1


INDICATES KEYED NOTES

- 1
- REFER TO SHEET P-101 FOR GENERAL DEMOLITION NOTES.
- 2
- DEMOLISH URINAL AND ASSOCIATED FLUSHOMETER. WATER SUPPLY AND SANITARY DRAIN LOCATIONS TO REMAIN.
- 3
- DEMOLISH TANK TYPE WATER CLOSET, FLEXIBLE HOSE, AND SUPPLY STOP. WATER SUPPLY AND SANITARY DRAIN LOCATIONS TO REMAIN.
- 4
- DEMOLISH LAVATORY, FAUCET, RISERS, AND SUPPLY STOPS. HOT AND COLD WATER SUPPLY AND SANITARY DRAIN LOCATIONS TO REMAIN.
- 5
- DEMOLISH FLOOR DRAIN STRAINER. ASSOCIATED SANITARY DRAIN BODY AND PIPE TO REMAIN.
- 6
- DEMOLISH WALL CLEANOUT COVER. ASSOCIATED SANITARY DRAIN CLEANOUT AND PIPE TO REMAIN.
- 7
- DEMOLISH SECTION OF WATER SUPPLY PIPE FOR ISOLATION VALVE INSTALLATION. WORK SHALL BE PERFORMED OUTSIDE OF NORMAL BUSINESS HOURS.


RENOVATION NOTES – DETAIL 2

INDICATES KEYED NOTES

- 1
- REFER TO SHEET P-101 FOR GENERAL RENOVATION NOTES.
- 2
- PROVIDE NEW STAINLESS STEEL WALL CLEANOUT COVER.
- 3
- PROVIDE AND INSTALL LEAD-FREE, QUARTER-TURN, FULL PORT BALL VALVES ON COLD WATER AND HOT WATER PIPES IN ACCESSIBLE LOCATION. WORK SHALL BE PERFORMED OUTSIDE OF NORMAL BUSINESS HOURS.

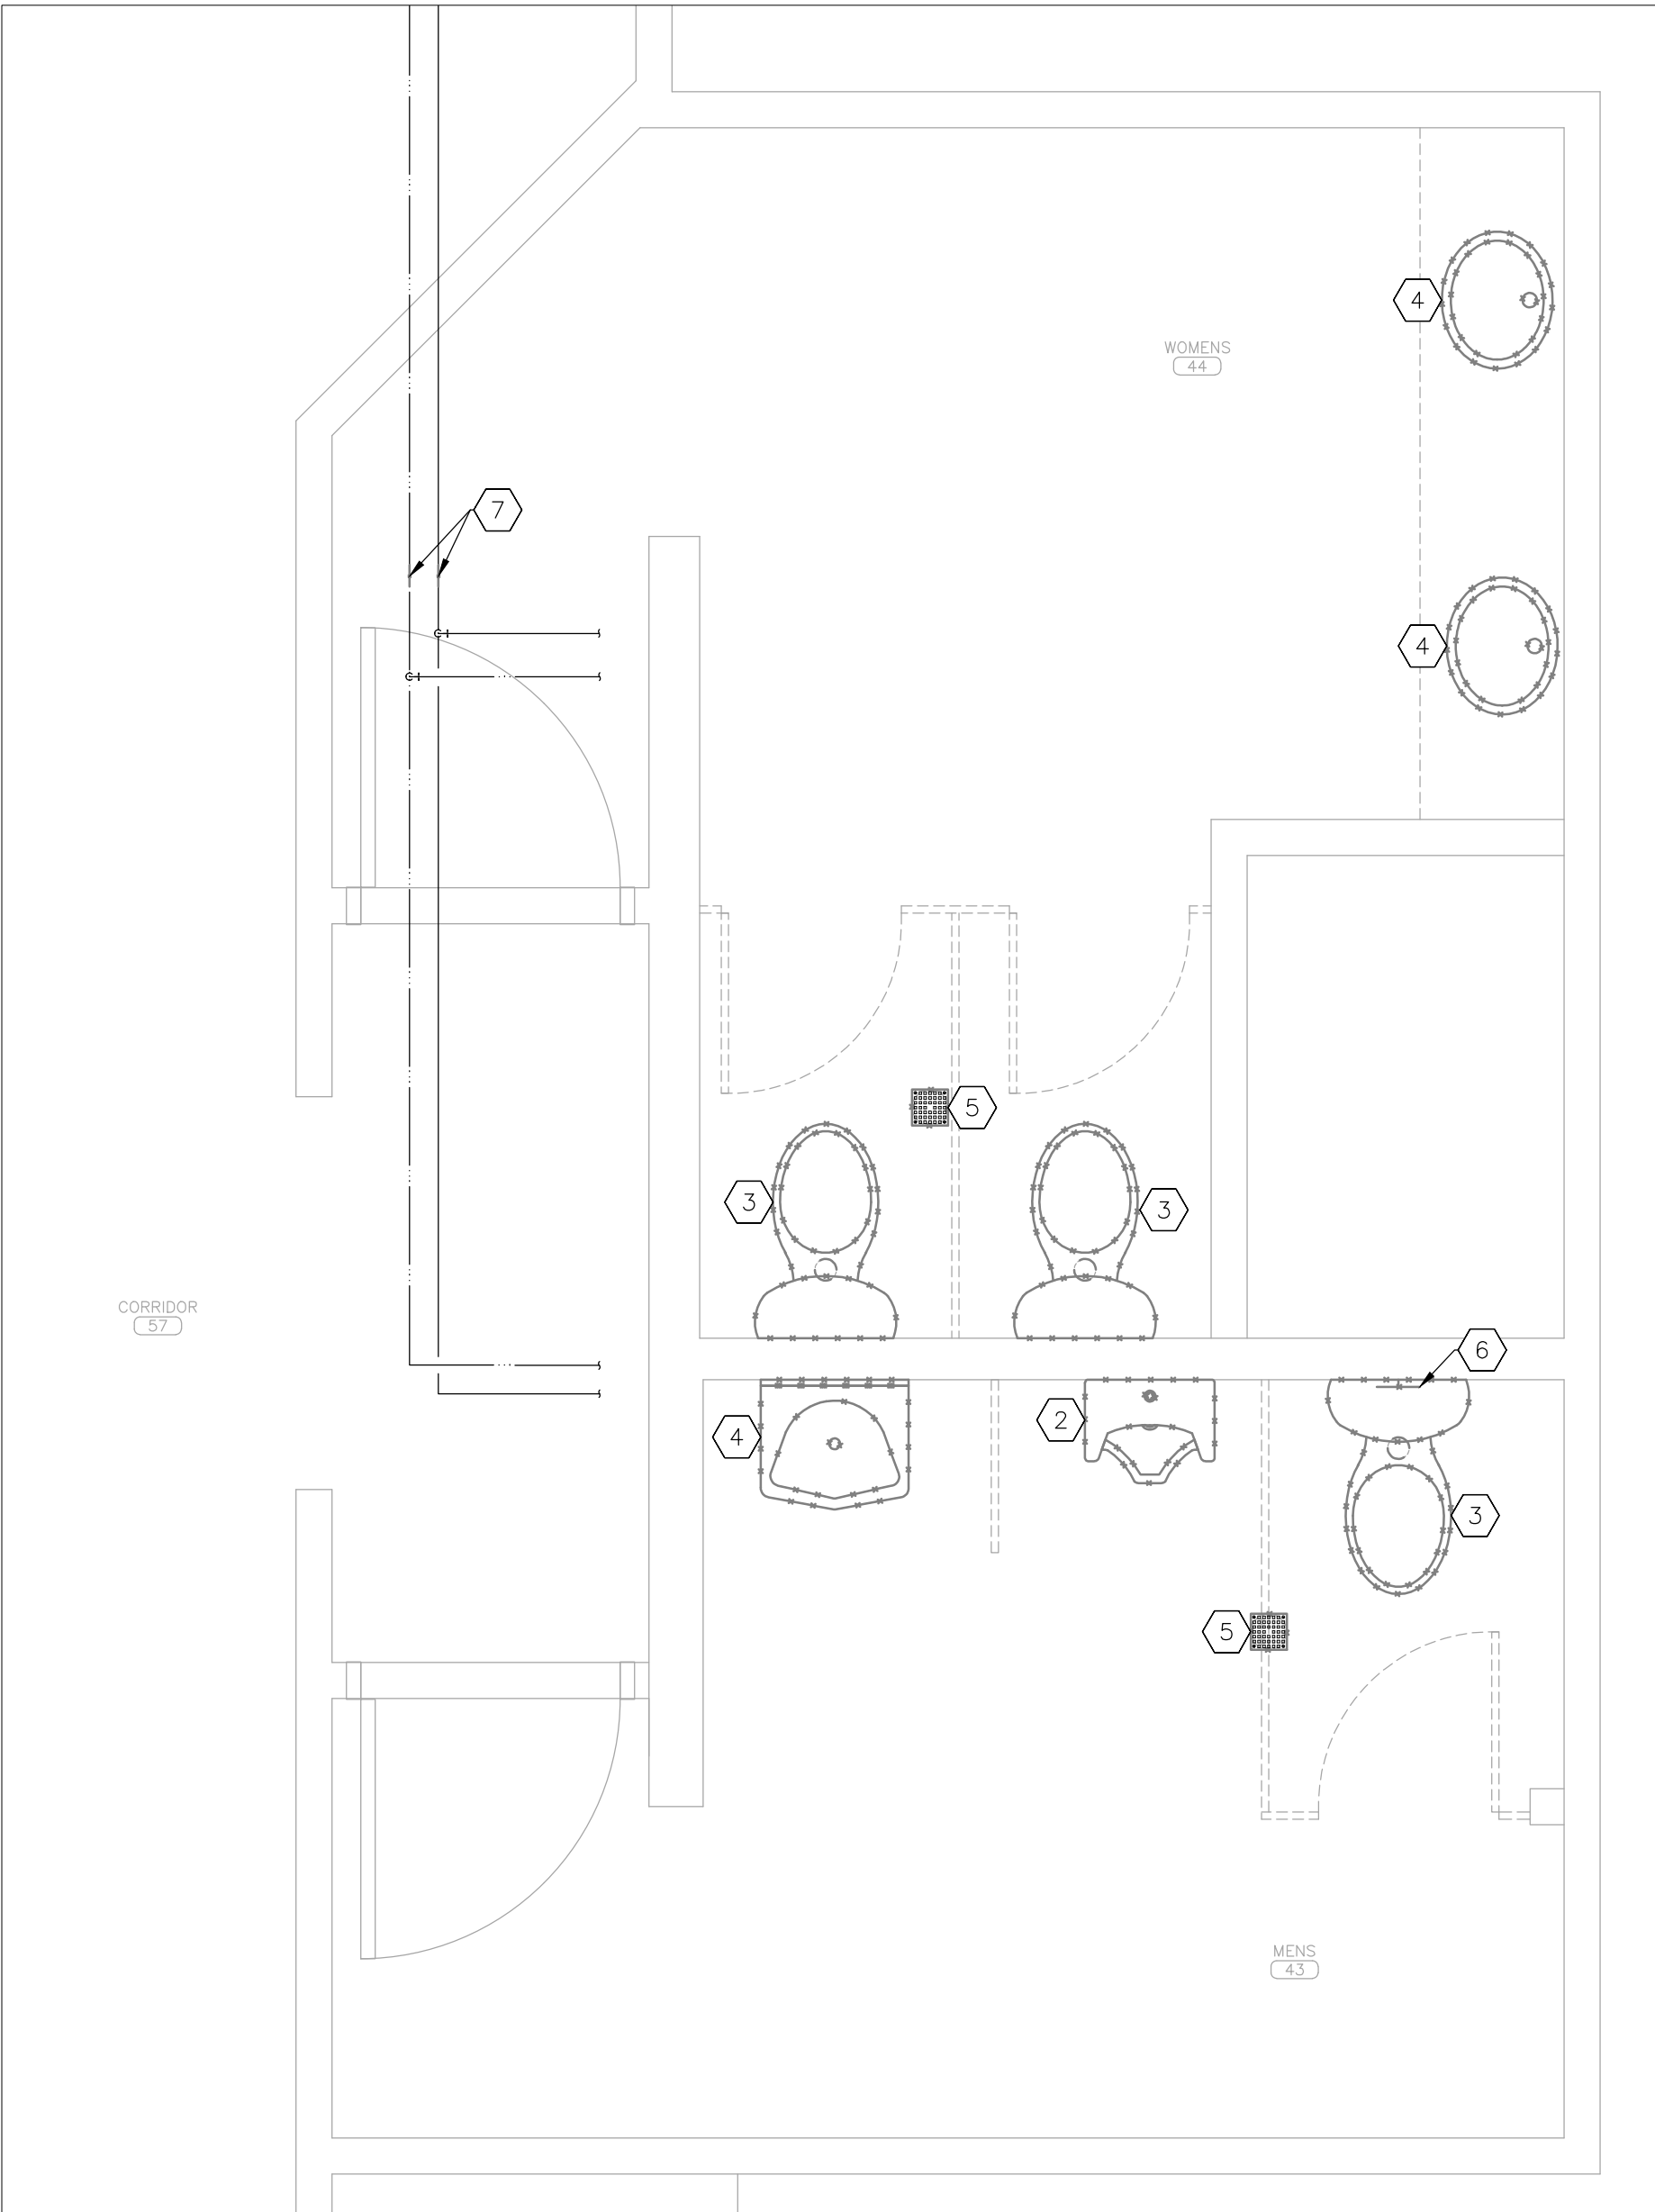


1 ALTERNATE NO. 2 – PLUMBING DEMOLITION PLAN – PARTIAL SECOND FLOOR
SCALE: 1/2" = 1'-0"

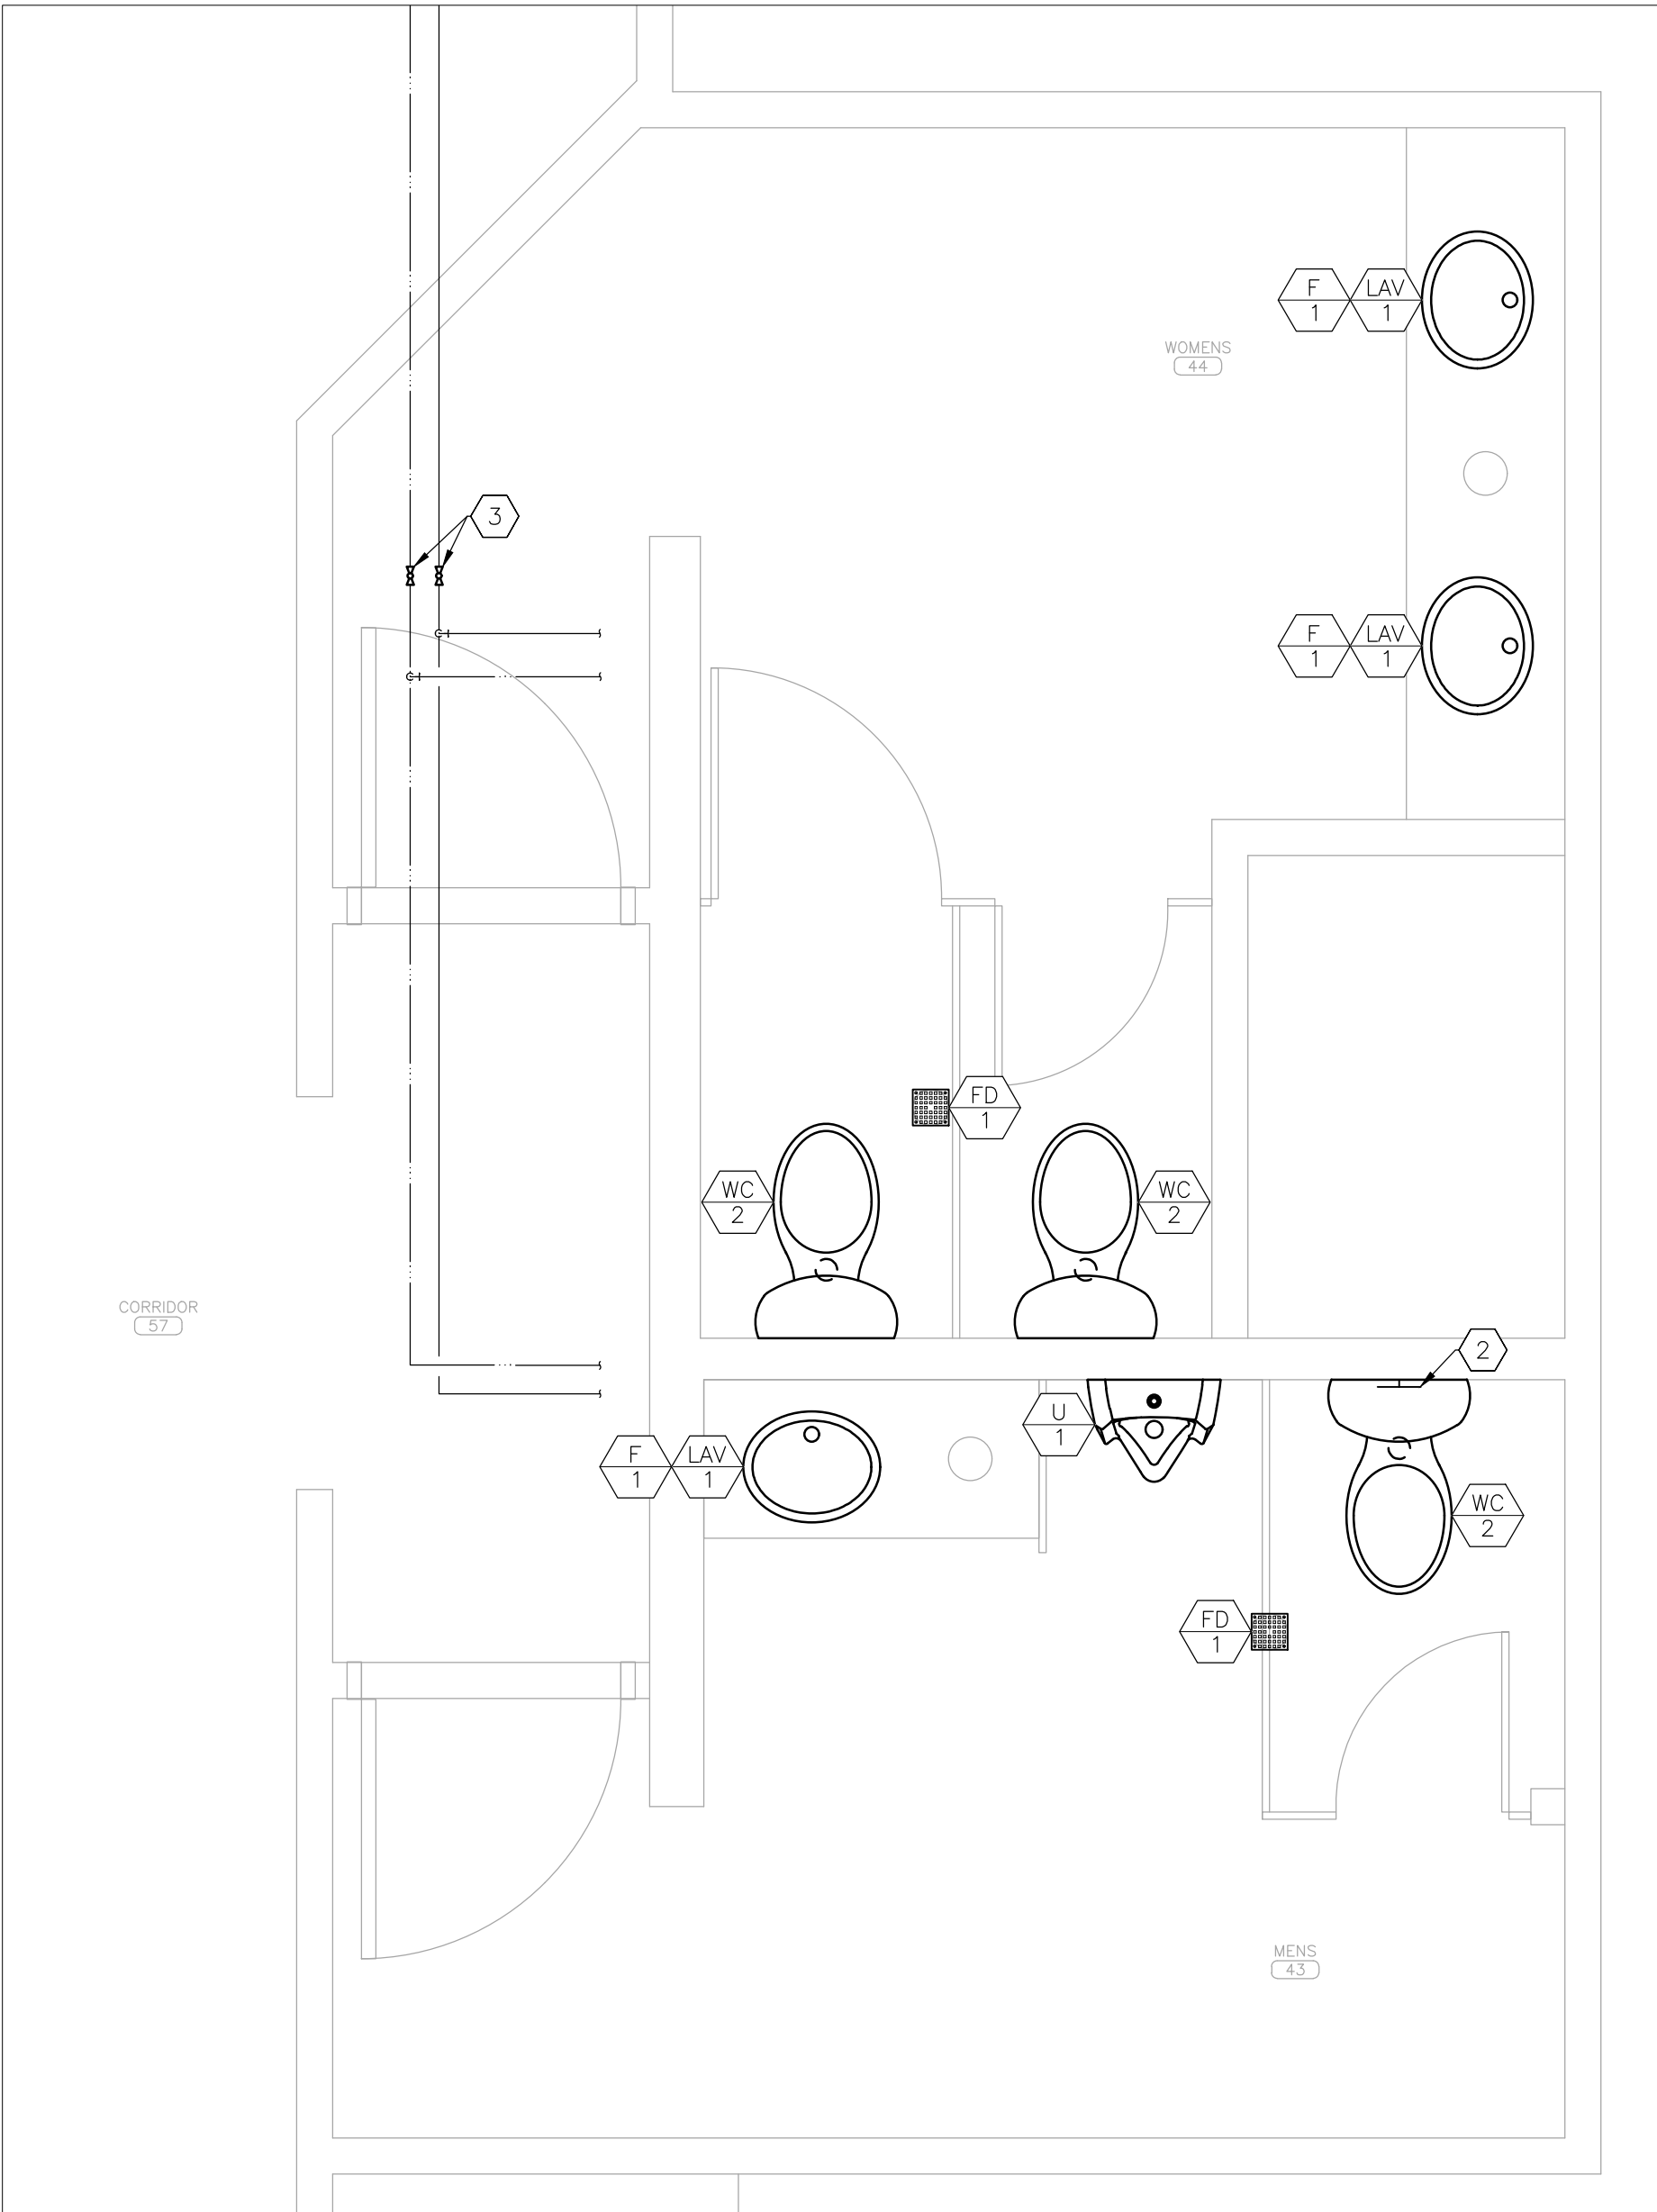

2 ALTERNATE NO. 2 – PLUMBING RENOVATION PLAN – PARTIAL SECOND FLOOR
SCALE: 1/2" = 1'-0"

PLUMBING LEGEND		
AA #	DEVICE	SCHEDULE TAG
—	PLUMBING FIXTURE	— NEW
—	DOMESTIC COLD WATER (C)	— NEW
—	DOMESTIC COLD WATER (C)	— EXISTING
—	DOMESTIC HOT WATER (H)	— NEW
—	DOMESTIC HOT WATER (H)	— EXISTING
—	EXISTING MATERIALS TO BE REMOVED	

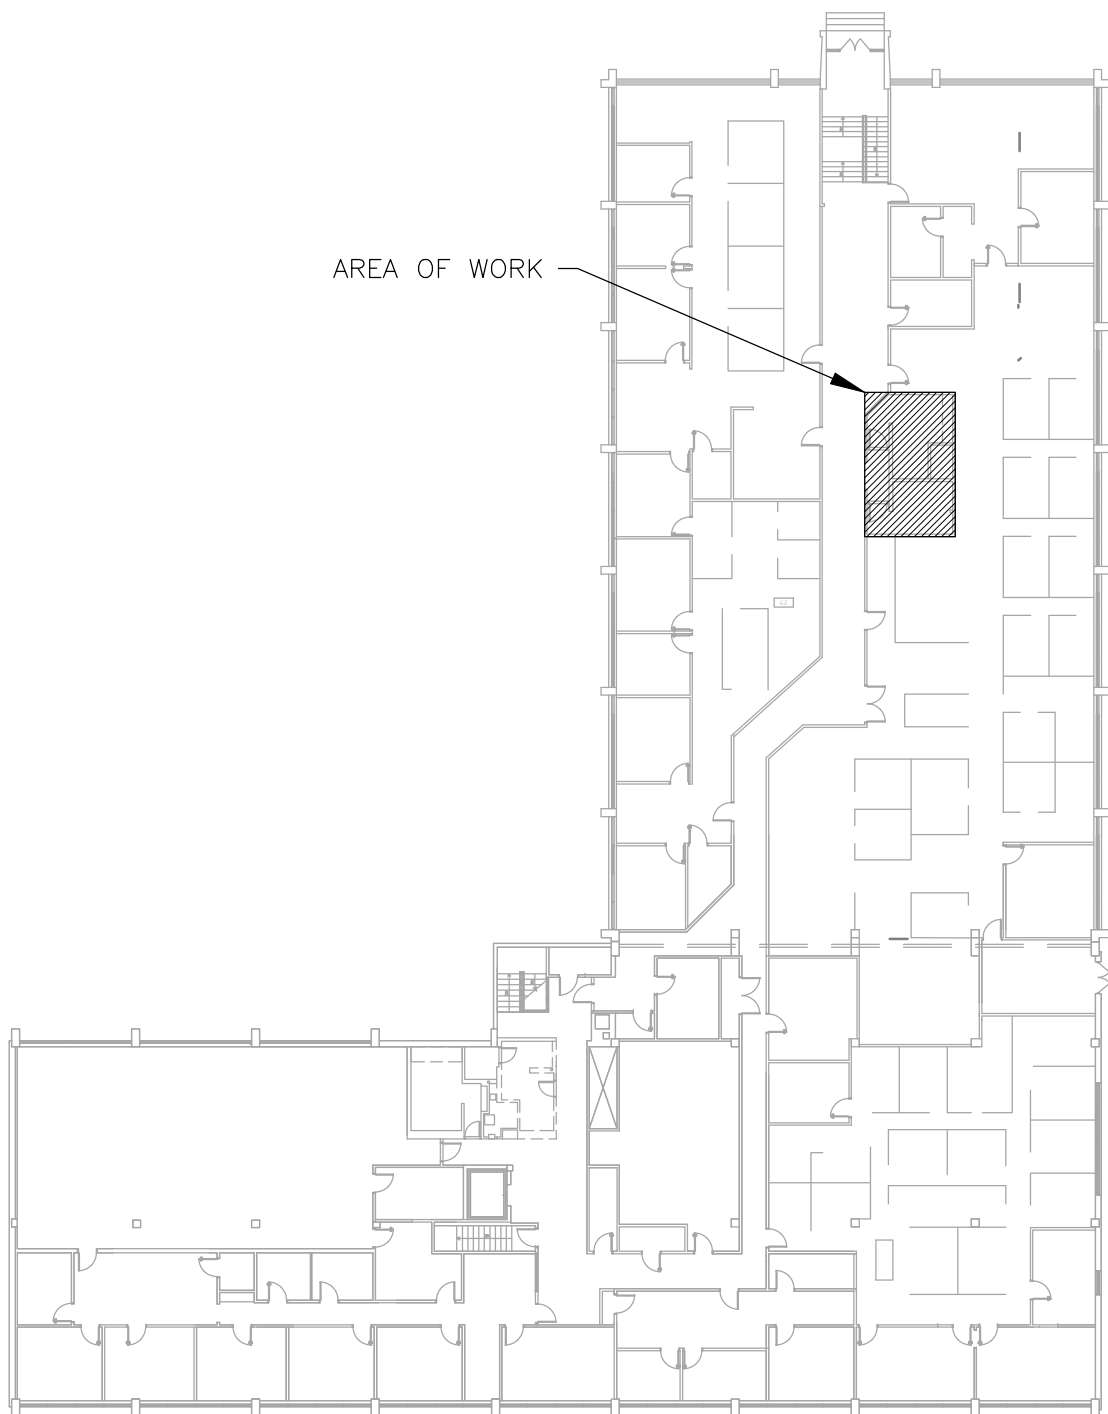

3 AREA MAP – SECOND FLOOR



Tracie L. Siebeneck - Engineer
MO# PE-2013019114

BID
DOCUMENTS

OFFICE OF ADMINISTRATION
DIVISION OF FACILITIES
MANAGEMENT,
DESIGN AND CONSTRUCTION

DEPARTMENT OF
PUBLIC SAFETY
STATE HIGHWAY PATROL

RENOVATE INTERIOR

GENERAL HEADQUARTERS
1510 EAST ELM STREET
JEFFERSON CITY, MO 65101

PROJECT # R2410-01
SITE # 6001
ASSET # 8136001001

REVISION: _____
DATE: _____
REVISION: _____
DATE: _____
REVISION: _____
DATE: _____
ISSUE DATE: 06/18/2026

CAD DWG FILE: P_R2410-01
DRAWN BY: TS/AH
CHECKED BY: TS
DESIGNED BY: TS/AH

SHEET TITLE:
PARTIAL
PLUMBING PLAN
SECOND FLOOR

SHEET NUMBER:

P-106

25 OF 39 SHEETS
06/18/2026



Tracie L. Siebeneck - Engineer
MO# PE-2013019114

BID
DOCUMENTS

OFFICE OF ADMINISTRATION
DIVISION OF FACILITIES
MANAGEMENT,
DESIGN AND CONSTRUCTION

DEPARTMENT OF
PUBLIC SAFETY
STATE HIGHWAY PATROL

RENOVATE INTERIOR

GENERAL HEADQUARTERS
1510 EAST ELM STREET
JEFFERSON CITY, MO 65101

PROJECT # R2410-01
SITE # 6001
ASSET # 8136001001

REVISION: _____
DATE: _____
REVISION: _____
DATE: _____
REVISION: _____
DATE: _____

ISSUE DATE: 06/18/2026

CAD DWG FILE: P_R2410-01
DRAWN BY: TS/AH
CHECKED BY: TS
DESIGNED BY: TS/AH

SHEET TITLE:

PLUMBING
SCHEDULES
AND DETAILS



SHEET NUMBER:

P-601

26 OF 39 SHEETS
06/18/2026

BOTTLE FILLING STATION SCHEDULE						
MARK	MANUFACTURER	MODEL	SIZE (L x W x H)	DESCRIPTION	ELECTRICAL	SPECIFICATION
BF-1	ELKAY	LZ8WSSSMC	17-7/8"x11-7/8" 41-1/4"	BOTTLE FILLER REFRIGERATED SURFACE MOUNT	120V/1Ø 15W	TYPE: WALL MOUNT, FILTERED BOTTLE FILLING STATION; CHILLING CAPACITY: 8.0 GPH; FINISH: STAINLESS STEEL WITH ANTIMICROBIAL PLASTIC COMPONENTS; BOTTLE FILLER ACTIVATION: ELECTRIC SENSOR; ALARMS: LED FILTER STATUS INDICATOR

ACCESS PANEL SCHEDULE						
MARK	MANUFACTURER	MODEL	SIZE	TYPE	SPECIFICATION	
AD-1	ACUDOR	UF-5000	6"x6"	UNIVERSAL ACCESS DOOR	DOOR: 16 GAUGE STEEL FRAME: 18 GAUGE STEEL; CONCEALED HINGE	

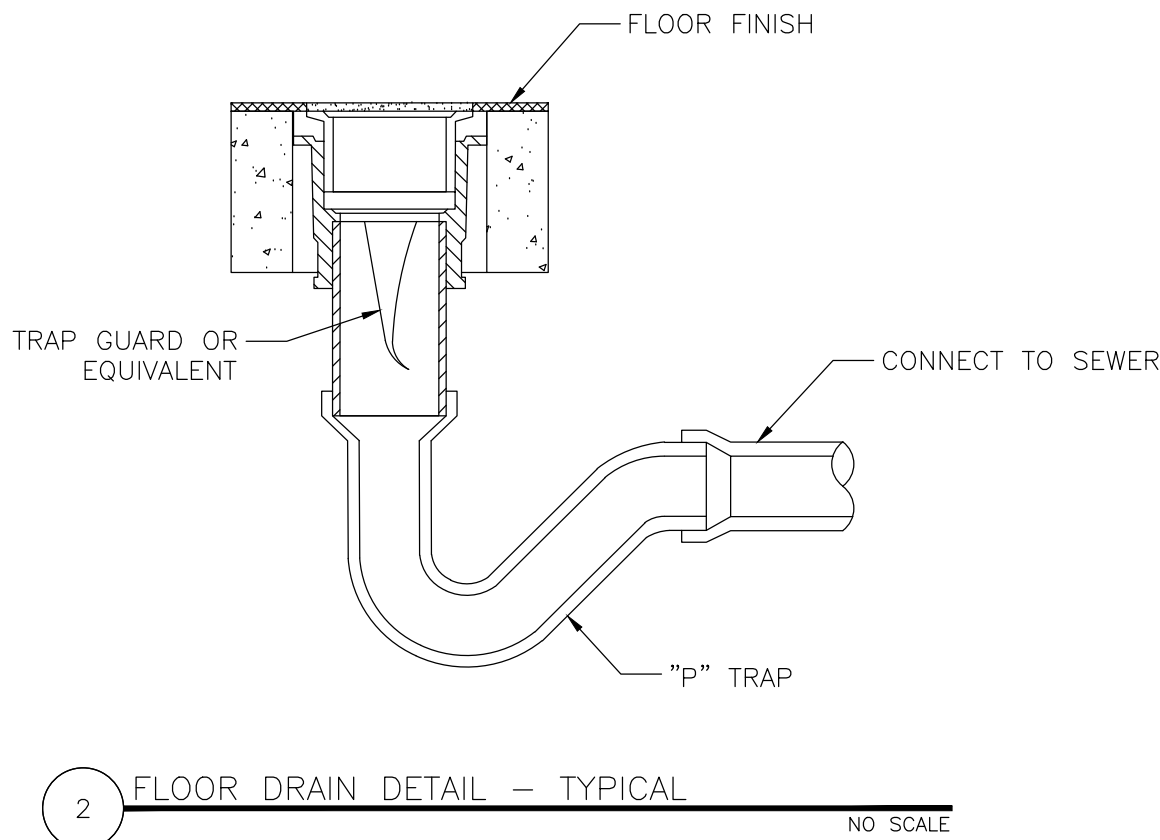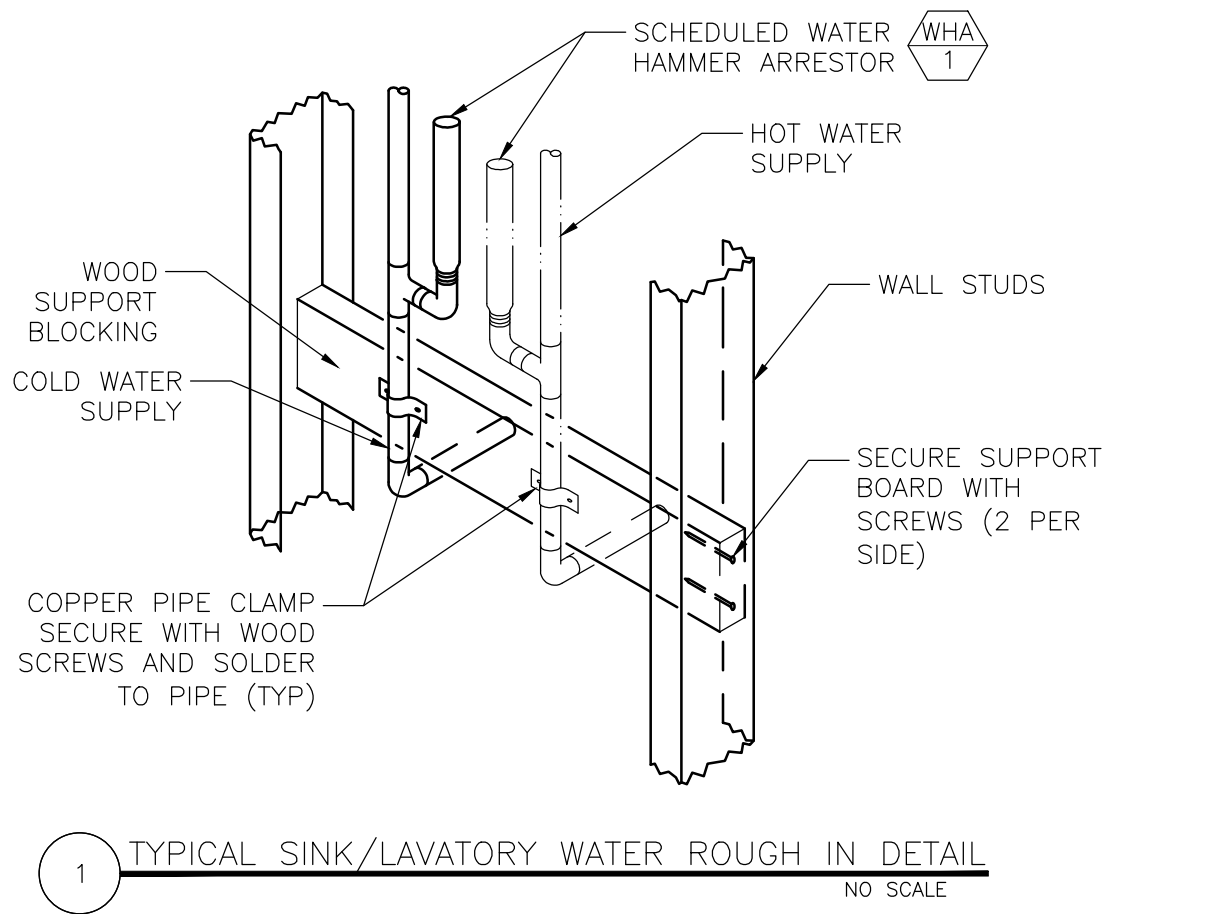

VALVE SCHEDULE						
MARK	MANUFACTURER	MODEL	CONNECTIONS	TYPE	SPECIFICATION	NOTES
WHA-1	SIoux CHIEF	652 SERIES	VARIOUS 1/2"-2" SWEAT	PISTON	BODY: TYPE L COPPER TUBE; PISTON: POLY PISTON WITH TWO EPDM O-RINGS AND DOW-CORNING, 111 FDA APPROVED SILICONE COMPOUND LUBRICANT	1
NOTES						
1	SIZE PER MANUFACTURERS INSTRUCTIONS					

FAUCET SCHEDULE					
MARK	MANUFACTURER	MODEL	CONNECTIONS	DESCRIPTION	NOTES
F-1	KOHLER	TRITON BOWE K-800T20-4ATA	1/2" HOT/COLD	TYPE: WIDE SPREAD LAVATORY FAUCET W/ VANDAL RESISTANT AERATOR; SPOUT: 5-1/2" REACH; FINISH: POLISHED CHROME; CONSTRUCTION: SOLID BRASS; HANDLES: LEVER HANDLES W/ BLUE AND RED COLOR INDEXES; VALVES: 1/4 TURN WASHERLESS CERAMIC DISC; FLOWRATE: 0.35 GPM	1
F-2	KOHLER	TRITON BOWE K-820T20-4AFA	1/2" HOT/COLD	TYPE: WALL MOUNT 8" WIDESPREAD SINK FAUCET W/ VANDAL RESISTANT AERATOR; SPOUT: RIGID W/ 11" REACH; FINISH: POLISHED CHROME; CONSTRUCTION: SOLID BRASS W/ THICK CHROME PLATING; HANDLES: LEVER HANDLES W/ BLUE AND RED COLOR INDEXES; VALVES: 1/4 TURN FULL BRASS CERAMIC; FLOWRATE: 1.8 GPM	1
NOTES					
1	PROVIDE STAINLESS STEEL WATER SUPPLY CONNECTORS AND MULTI-TURN ANGLE STOPS				


LAVATORY SCHEDULE					
MARK	MANUFACTURER	MODEL	BOWL DIMENSIONS	DESCRIPTION	NOTES
LAV-1	KOHLER	CAXTON K-2210	17" x 14" WATER DEPTH: 4"	TYPE: OVAL UNDERCOUNTER MOUNT W/ UNGLAZED RIM; MATERIAL: WHITE VITREOUS CHINA; DRAIN: 1-1/4" W/ OVERFLOW	1,2,3
LAV-2	KOHLER	GREENWICH K-2030	10" x 15" WATER DEPTH: 3-1/4"	TYPE: WALL MOUNT; MATERIAL: WHITE VITREOUS CHINA; DRAIN: 1-1/4" W/ OVERFLOW; DECK HOLES: THREE, 8" CENTER	1,2,3
NOTES					
1	PROVIDE LAV GUARD2 MODEL #102 E-Z: ADA COMPLIANT, MOLDED VINYL WASTE AND SUPPLY PIPE COVERS WITH ANTI-MICROBIAL TREATMENT				
2	PROVIDE KOHLER MODEL K-8998 1-1/4 INCH BRASS TUBULAR P-TRAP WITHOUT CLEANOUT				
3	PROVIDE KOHLER MODEL K-7129-A 1-1/4 INCH SOLID BRASS DRAIN WITH POLISHED CHROME FINISH				

SINK SCHEDULE					
MARK	MANUFACTURER	MODEL	DIMENSIONS	DESCRIPTION	NOTES
S-1	ZURN	Z1996-24-SDL-WG	24" x 24" 10"	TYPE: FLOOR MOUNT MOP SINK; MATERIAL: HIGH DENSITY COMPOSITE; DRAIN: STAINLESS STEEL DOME STRAINER W/ 3" STAINLESS STEEL DRAIN	1
NOTES					
1	PROVIDE TWO STAINLESS STEEL WALL GUARD PANELS MINIMUM SIZE: 24" WIDTH BY 36" HEIGHT				


WATER CLOSET SCHEDULE				
MARK	MANUFACTURER	MODEL	DESCRIPTION	NOTES
WC-1	KOHLER	HIGHCLIFF ULTRA K-96057	TYPE: FLOOR MOUNT; MATERIAL: WHITE VITREOUS CHINA; INLET: 1-1/2" TOP SPUD; OUTLET: 2-1/8" FULLY GLAZED TRAPWAY; BOWL: ELONGATED	1,2
WC-2	KOHLER	KINGSTON K-25077-RA	TYPE: TWO PIECE, TANK TYPE FLOOR MOUNT; MATERIAL: WHITE VITREOUS CHINA: INLET: 3/8" W/ SUPPLY STOP; OUTLET: 2-1/8" FULLY GLAZED TRAPWAY; BOWL: ELONGATED; TANK: GRAVITY FLUSH	1
NOTES				
1	PROVIDE BEMIS MODEL Z155SSCT, HEAVY DUTY SEAT, OPEN FRONT, LESS COVER WITH ANTI-MICROBIAL TREATMENT, AND SELF SUSTAINING CHECK HINGE			
2	PROVIDE SLOAN MANUAL OPERATED FLUSHVALVE MODEL SLOAN 111-1.6-CP; 1.6GPF			

URINAL SCHEDULE				
MARK	MANUFACTURER	MODEL	DESCRIPTION	NOTES
U-1	KOHLER	BARDON K-4991-ET	TYPE: WALL MOUNT; MATERIAL: WHITE VITREOUS CHINA; INLET: 3/4" TOP SPUD; OUTLET: 2" THREADED OUTLET; RIM: 14" EXTENDED	1
U-2	KOHLER	BARDON K-4991-ET	TYPE: WALL MOUNT; MATERIAL: WHITE VITREOUS CHINA; INLET: 3/4" TOP SPUD; OUTLET: 2" THREADED OUTLET; RIM: 14" EXTENDED	1,2
NOTES				
1	PROVIDE SLOAN MANUAL OPERATED FLUSHVALVE MODEL 186-0.5-CP; 0.5GPF			
2	PROVIDE ZURN MODEL Z1222 URINAL CARRIER			

FLOOR DRAIN SCHEDULE						
MARK	MANUFACTURER	MODEL	FACE SIZE	DESCRIPTION	SPECIFICATION	NOTES
FD-1	ZURN	ZN400S	5 INCH x 5 INCH	SANITARY FLOOR DRAIN STRAINER	GRATE: HEEL-PROOF, POLISHED NICKEL BRONZE; FOR INSTALLATION ON EXISTING FLOOR DRAIN	
FD-2	ZURN	ZN415S-DP-AR	5 INCH x 5 INCH	SANITARY FLOOR DRAIN	BODY: DURA-COATED CAST IRON; INTERIOR: ACID RESISTING EPOXY COATED CAST IRON; GRATE: HEEL- PROOF, POLISHED NICKEL BRONZE TOP	1,2
NOTES						
1	PROVIDE 3 INCH NEO-LOC OUTLET					
2	PROVIDE TRAP SEAL PROTECTIVE DEVICE MODEL Z1072 OR EQUAL AND MATCH SIZE TO DRAIN OUTLET					

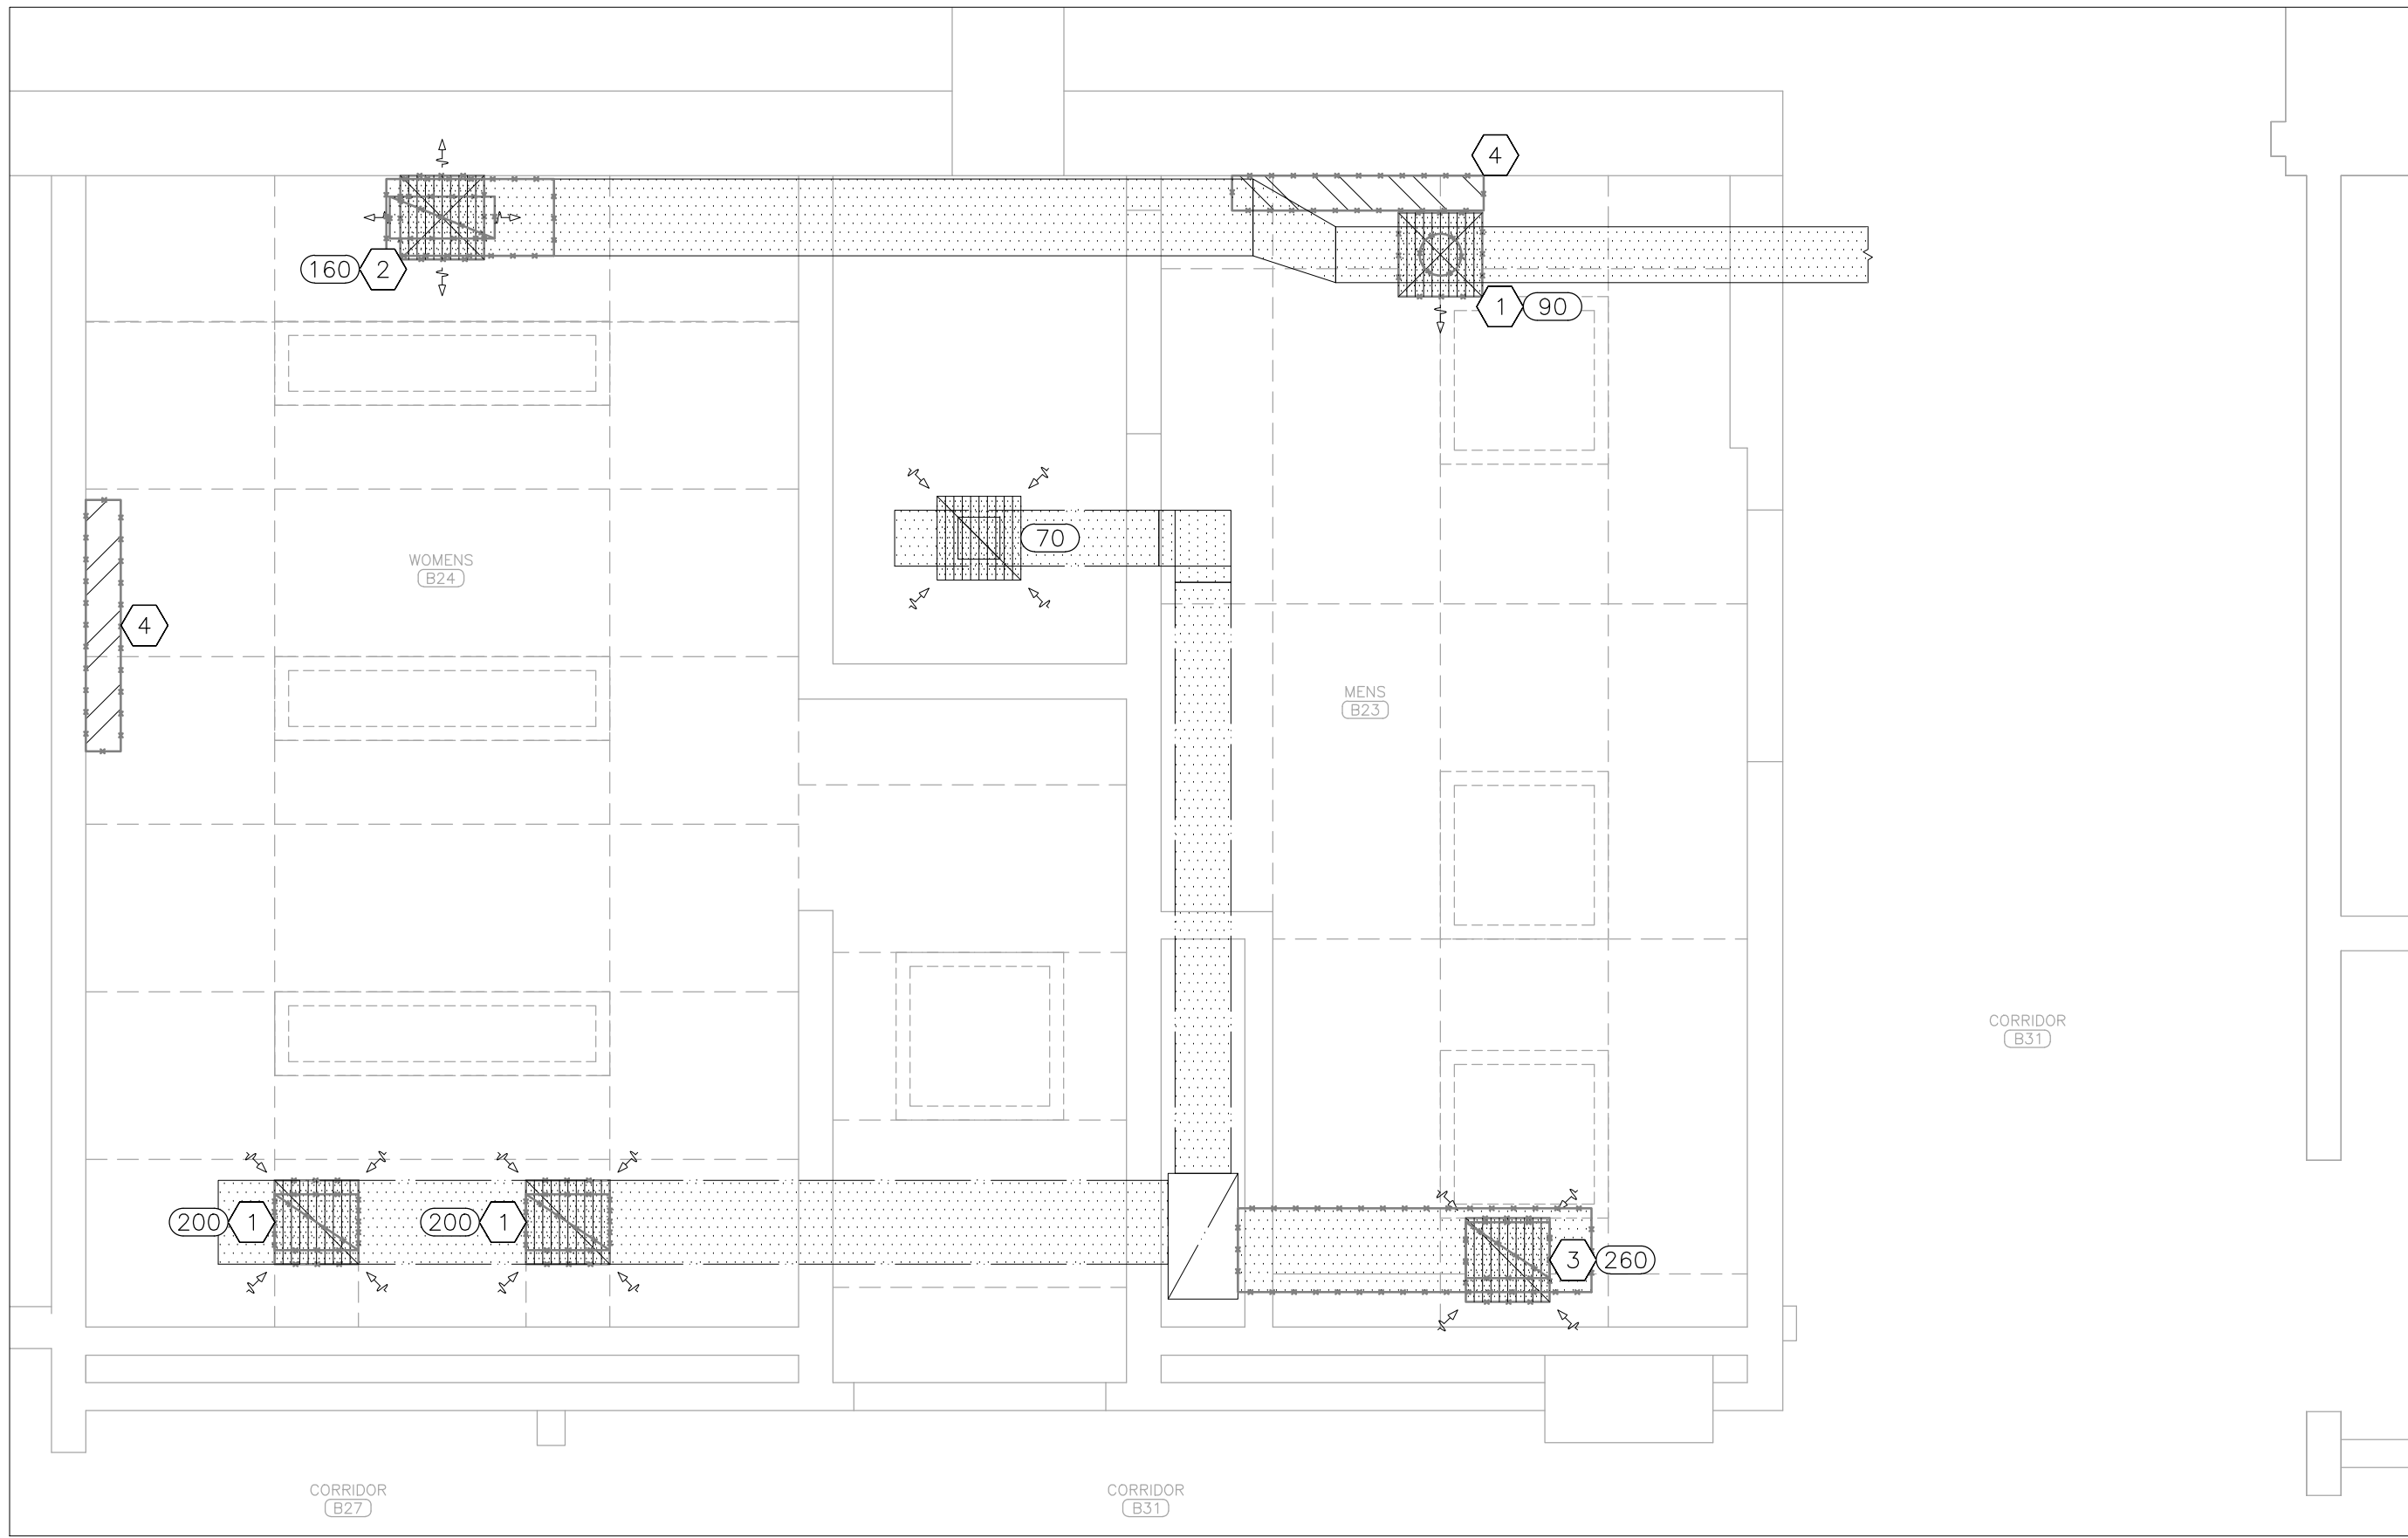

1 ALTERNATE NO. 1 – MECHANICAL DEMOLITION PLAN – BASEMENT
SCALE: 1/2" = 1'-0"

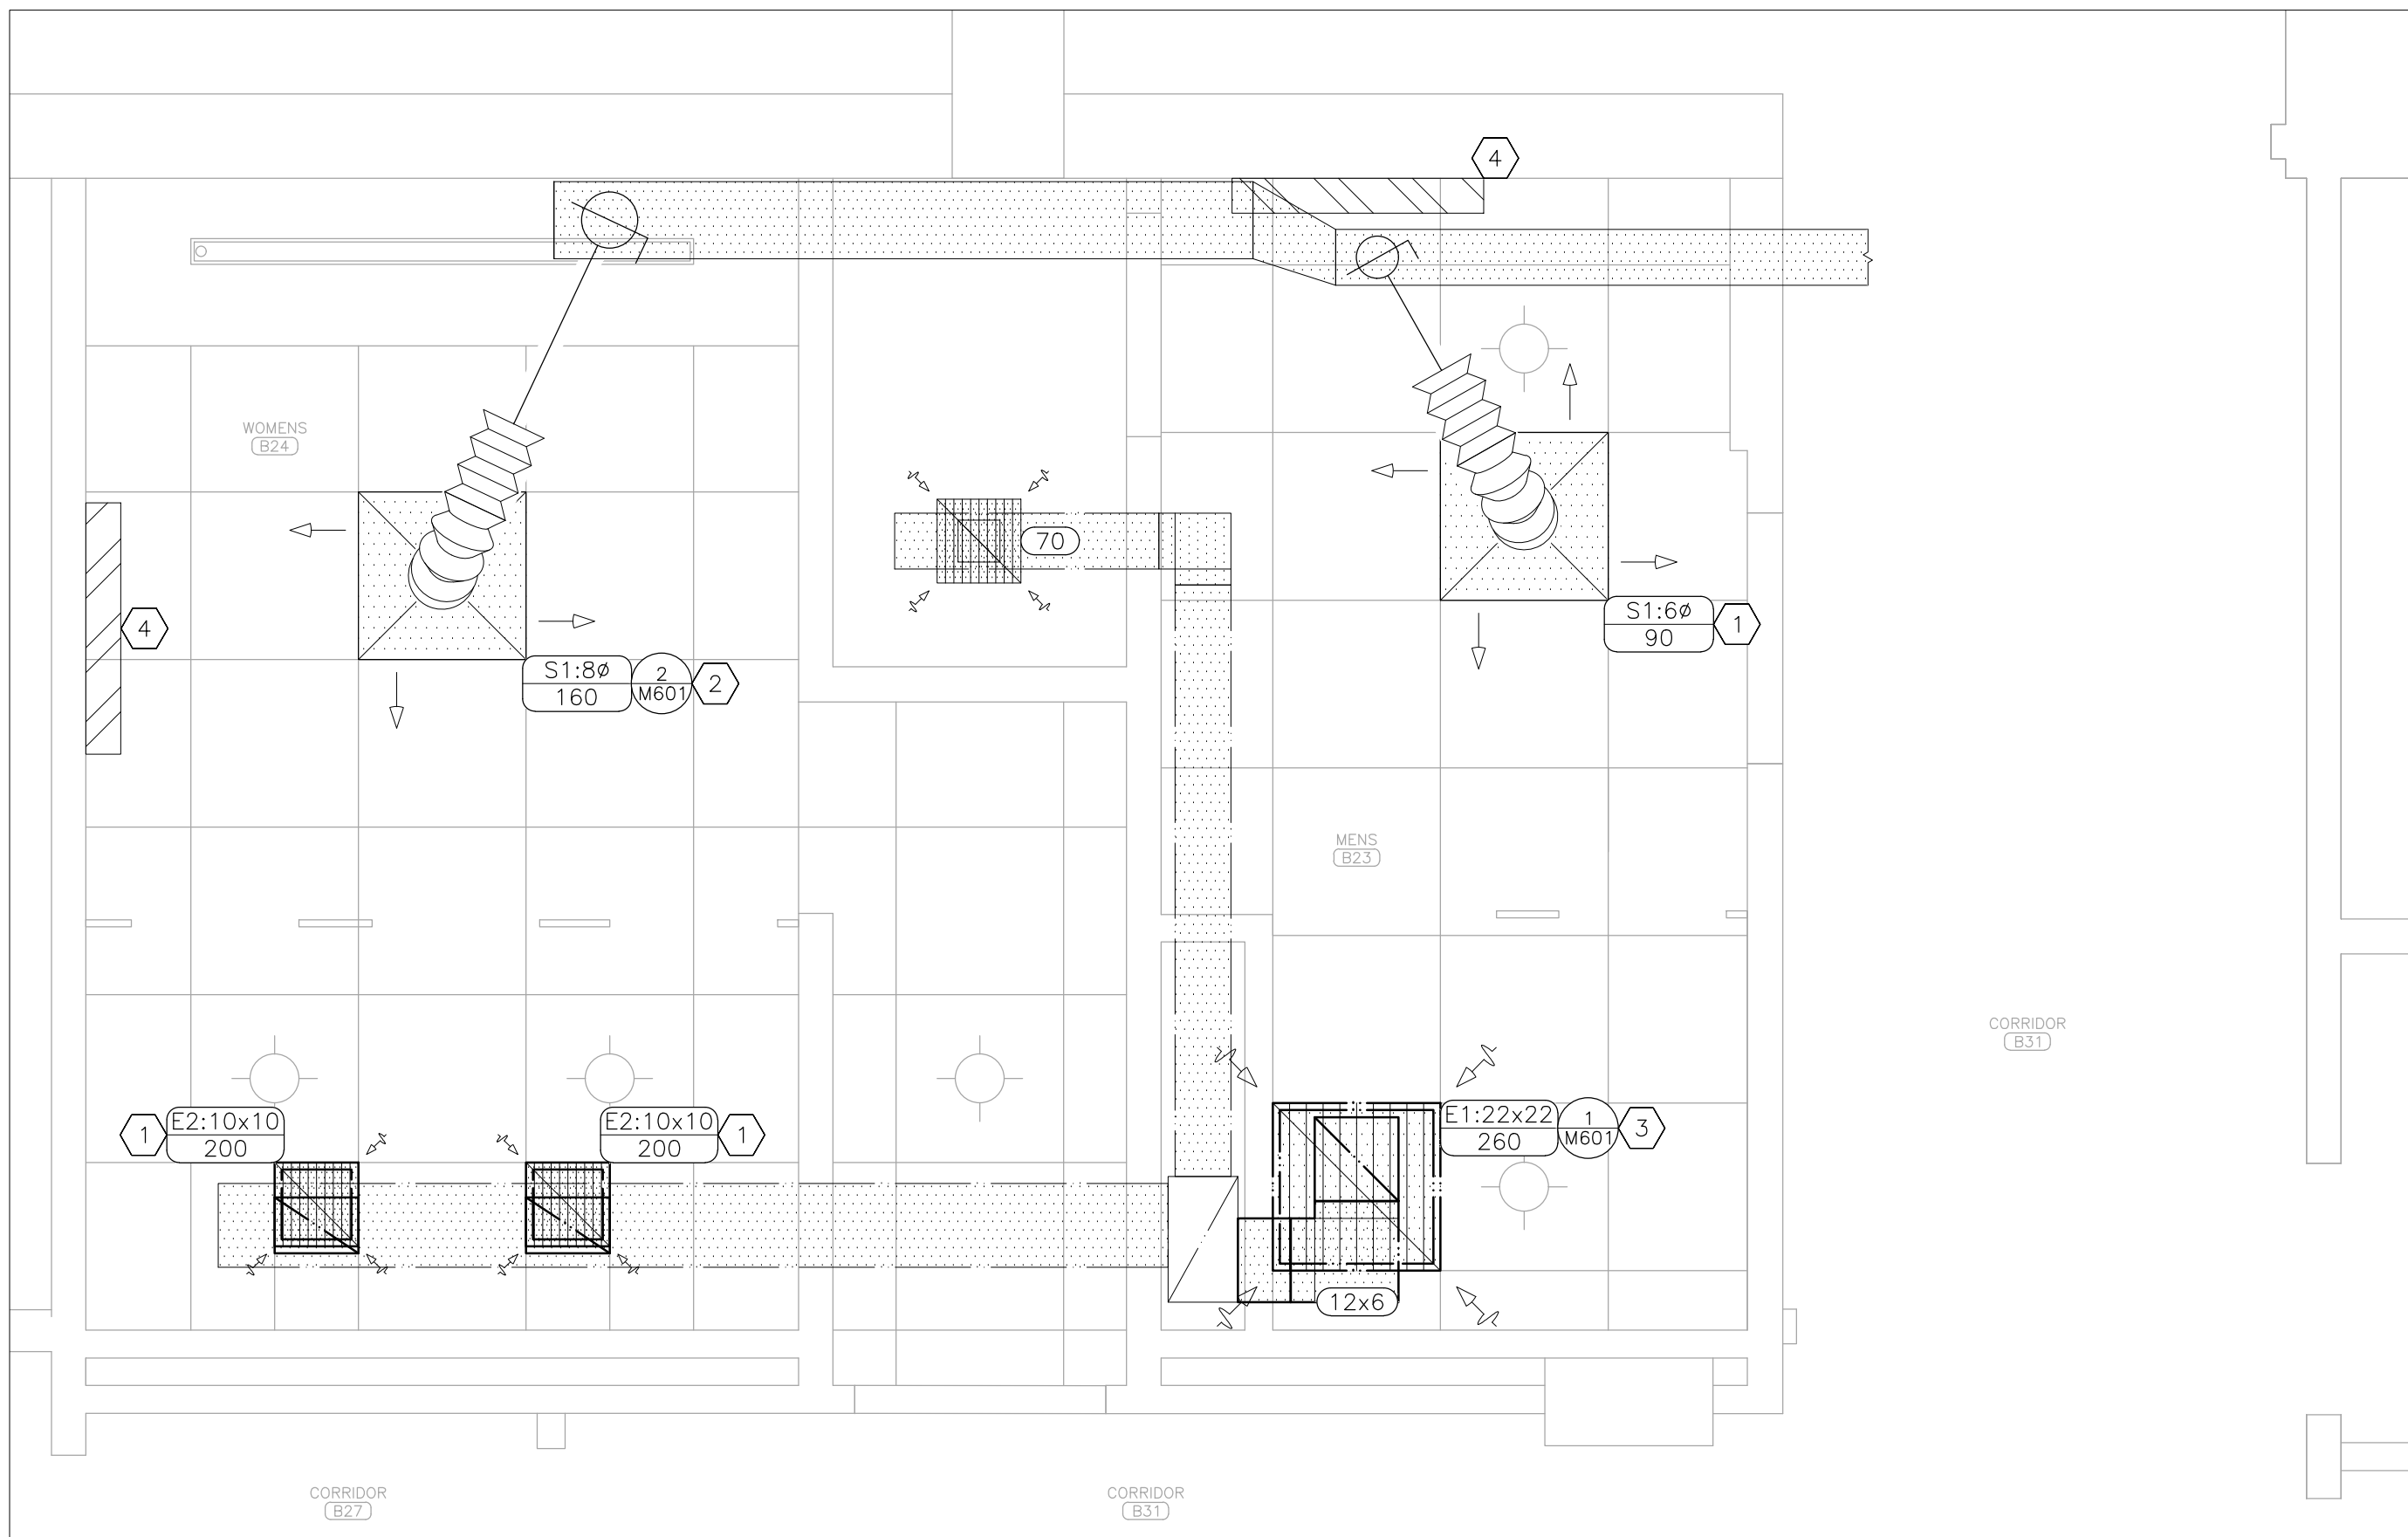

2 ALTERNATE NO. 1 – MECHANICAL RENOVATION PLAN – BASEMENT
SCALE: 1/2" = 1'-0"

GENERAL DEMOLITION NOTES

- 1 REFER TO SHEET G-002 FOR GENERAL CONSTRUCTION NOTES.
- 2 REMOVE ALL UNUSED DUCTWORK AND AIR DEVICES EXCEPT AS NOTED.
- 3 TESTING AND BALANCING CONTRACTOR SHALL TEST ALL EXISTING RESTROOM EXHAUST FANS AND ALL RESTROOM AND JANITOR CLOSET SUPPLY AND EXHAUST AIRFLOWS WITHIN AREA OF WORK PRIOR TO DEMOLITION ACTIVITIES. PREPARE A BALANCE REPORT PER ASHRAE STANDARD 111 OR EQUAL. REPORT SHALL BE SENT TO THE ENGINEER FOR REVIEW PRIOR TO COMPLETION OF DEMOLITION ACTIVITIES. VALUES SHOWN IN DEMOLITION DETAIL ARE FOR REFERENCE ONLY.

GENERAL RENOVATION NOTES

- 1 FABRICATION, INSTALLATION, AND TESTING OF ALL HVAC SYSTEMS SHALL BE IN ACCORDANCE WITH ALL MANUFACTURER INSTALLATION GUIDELINES. REFER TO SHEET G-002 FOR APPLICABLE CODES AND STANDARDS.
- 2 ALL METALLIC AND FLEXIBLE DUCTS SHALL BE CONSTRUCTED AND INSTALLED AS SPECIFIED IN SMACNA (DCS)-HVAC DUCT CONSTRUCTION STANDARDS METAL AND FLEXIBLE; 2020.
- 3 THIRD PARTY, AABC OR NEBB CERTIFIED TESTING, ADJUSTING, AND BALANCING CONTRACTOR SHALL PROVIDE TEST AND BALANCE SERVICES AND PREPARE A BALANCE REPORT PER ASHRAE STANDARD 111 OR EQUAL. REPORT SHALL BE SENT TO THE ENGINEER FOR APPROVAL PRIOR TO FINAL COMPLETION. BALANCE DAMPERS ARE REQUIRED ON ALL SUPPLY AND EXHAUST AIR DEVICES. REFERENCE SPECIFICATIONS FOR ADDITIONAL INFORMATION.
- 4 ALL DUCTWORK WITH TWO DIMENSION <WxD> INDICATES RECTANGULAR DUCT. ALL <Dø> INDICATES ROUND DUCT. DIMENSIONS ARE INCHES MEASURED INSIDE. PROVIDE STANDARD TURNING VANES OR CURVED ELBOW WITH SQUARE THROAT ON RECTANGULAR DUCTS. ROUND DUCT SHALL MAINTAIN A CENTERLINE TURNING RADIUS OF 1.5 X DUCT DIAMETER. FLEXIBLE DUCT SHALL BE 5 FEET MAXIMUM LENGTH AND BE SUPPORTED TO MINIMIZE STATIC PRESSURE DROP.
- 5 PROVIDE SUITABLE SUPPORTS FOR STABILITY OF ALL HVAC DEVICES AND DUCT.

ALTERNATE NO. 1

DEMOLITION NOTES – DETAIL 1

INDICATES KEYED NOTES


- 1 DEMOLISH AIR DEVICE. DEMOLISH ASSOCIATED DUCT BACK TO TAKE-OFF. TAKE-OFF TO REMAIN FOR USE IN NEW CONSTRUCTION.
- 2 DEMOLISH AIR DEVICE. DEMOLISH ASSOCIATED DUCT AS SHOWN. PROVIDE AND INSTALL INSULATED SHEET METAL CAP ON DUCT TO REMAIN.
- 3 DEMOLISH AIR DEVICE. DEMOLISH ASSOCIATED DUCT BACK TO MAIN. PENETRATION TO REMAIN FOR USE IN NEW CONSTRUCTION.
- 4 REMOVE AND RETAIN FLOOR MOUNTED CABINET CONVECTOR. PROVIDE TEMPORARY CAPS ON HEATING SUPPLY AND RETURN PIPE TO REMAIN. ENSURE BYPASS PIPE IS IN PLACE TO ALLOW FLOW TO NEXT CONVECTOR IN THE LOOP. MINIMIZE TIME CONVECTOR IS NOT OPERATIONAL.

RENOVATION NOTES – DETAIL 2

INDICATES KEYED NOTES

- 1 PROVIDE AND INSTALL AIR DEVICE. ROUTE DUCT BACK TO EXISTING TAKE-OFF.
- 2 PROVIDE AND INSTALL AIR DEVICE. ROUTE DUCT BACK TO NEW TAKE-OFF.
- 3 PROVIDE AND INSTALL AIR DEVICE. ROUTE DUCT BACK TO MAIN AND CONNECT TO EXISTING PENETRATION.
- 4 INSTALL RETAINED CABINET CONVECTOR AFTER NEW FLOOR AND WALL TILE ARE INSTALLED.

HVAC LEGEND	
#	DETAIL REFERENCE, NUMBER/SHEET
S1:6ø 50	AIR DEVICE: NECK SIZE (INCHES)/CFM
12x12	DUCT SIZE-RECTANGULAR (INCHES X INCHES)
350	AIR FLOW (CUBIC FEET PER MINUTE)
—	SUPPLY AIR – NEW
---	SUPPLY AIR – EXISTING
---	EXHAUST AIR – NEW
---	EXHAUST AIR – EXISTING
---	EXISTING MATERIALS TO BE REMOVED
□	LIGHT FIXTURE – LINEAR/TROFFER
○	LIGHT FIXTURE – DOWN LIGHT

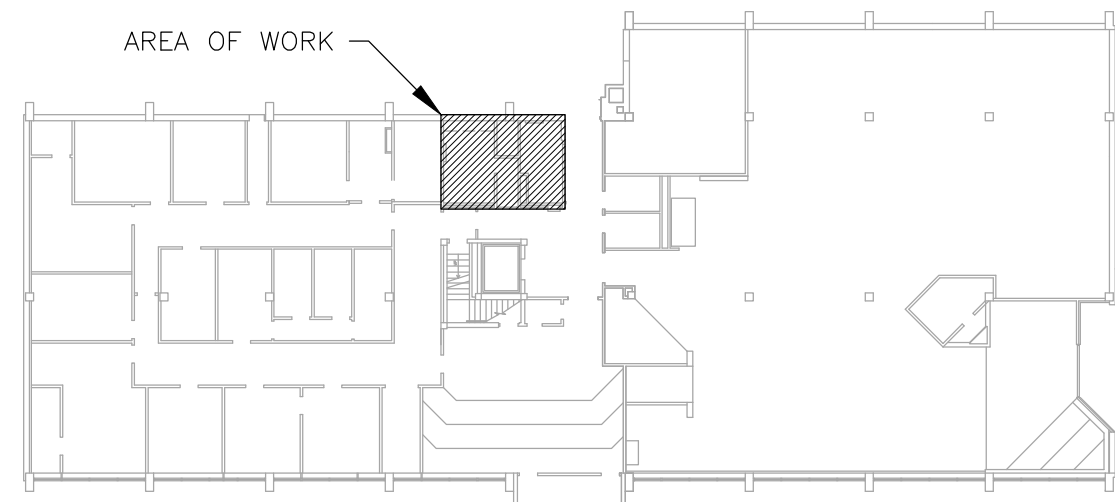

3 AREA MAP – BASEMENT

STATE OF MISSOURI
MIKE KEHOE,
GOVERNOR



Tracie L. Siebeneck - Engineer
MO# PE-2013019114

BID DOCUMENTS

OFFICE OF ADMINISTRATION
DIVISION OF FACILITIES
MANAGEMENT,
DESIGN AND CONSTRUCTION

DEPARTMENT OF
PUBLIC SAFETY
STATE HIGHWAY PATROL

RENOVATE INTERIOR

GENERAL HEADQUARTERS
1510 EAST ELM STREET
JEFFERSON CITY, MO 65101

PROJECT # R2410-01
SITE # 6001
ASSET # 8136001001

REVISION: _____
DATE: _____
REVISION: _____
DATE: _____
REVISION: _____
DATE: _____
ISSUE DATE: 06/18/2026


CAD DWG FILE: M_R2410-01
DRAWN BY: TS/AH
CHECKED BY: TS
DESIGNED BY: TS/AH

SHEET TITLE:
MECHANICAL PLAN
BASEMENT


SHEET NUMBER:

M-101

27 OF 39 SHEETS
06/18/2026

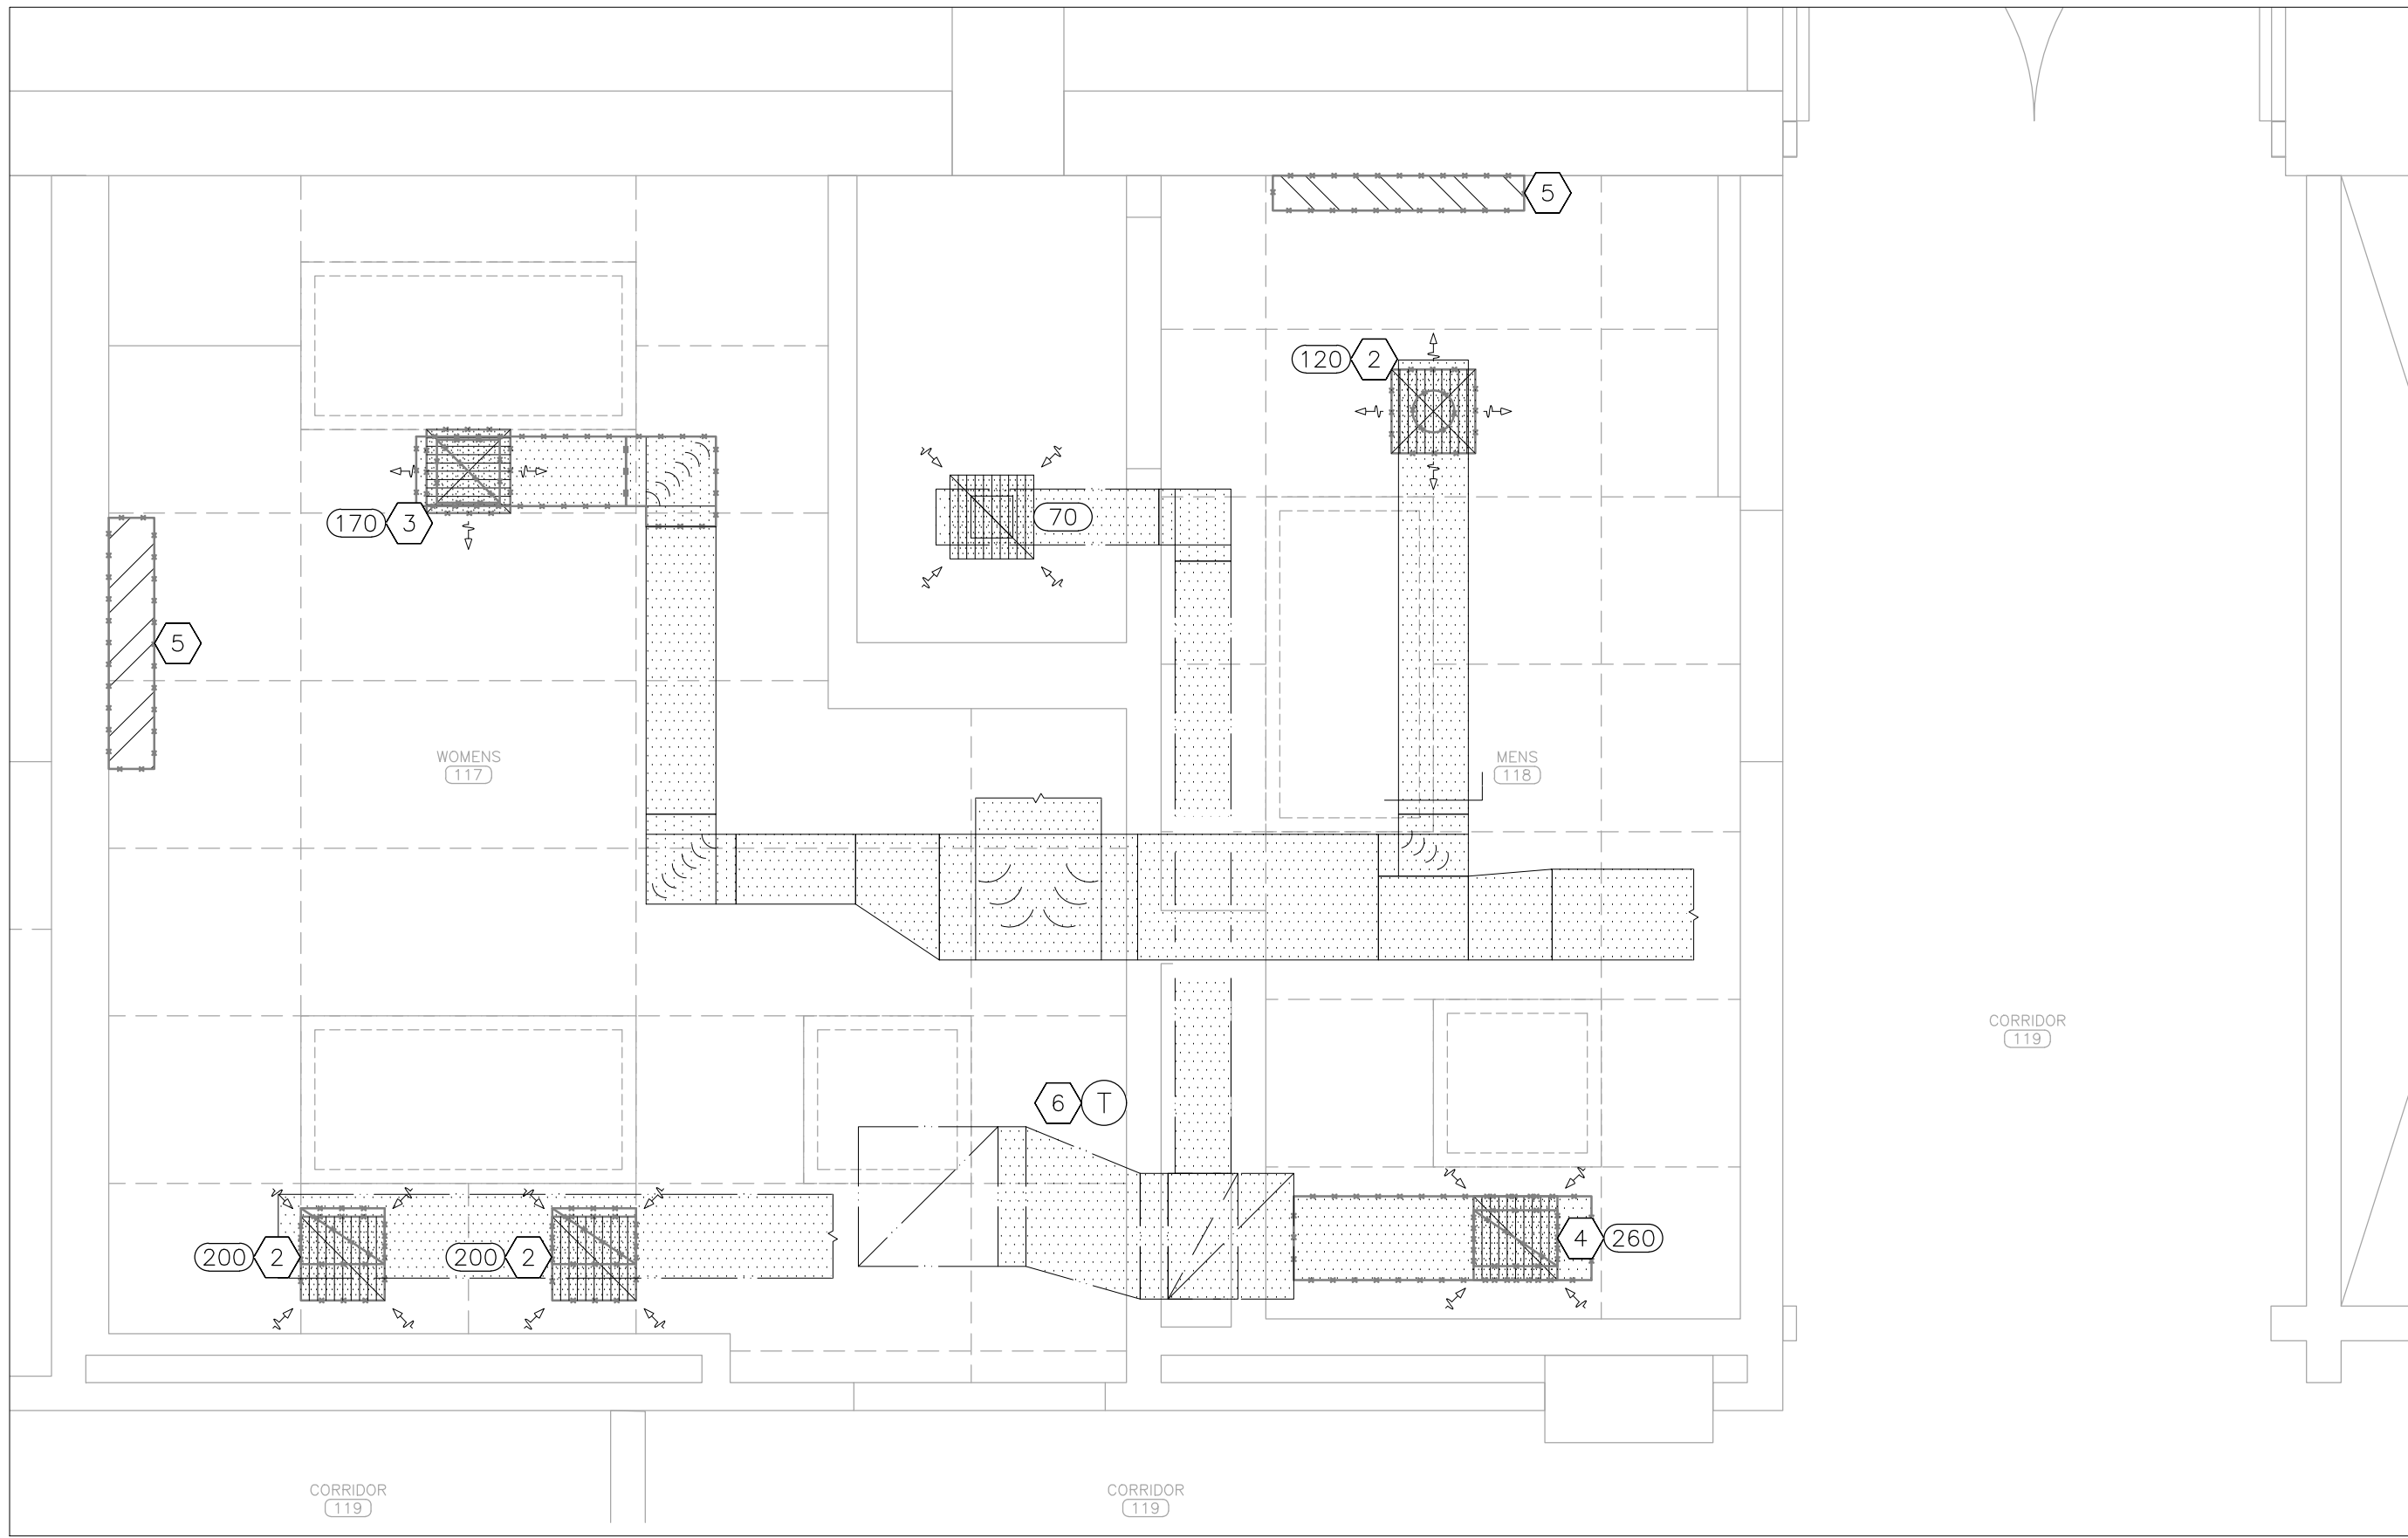

1 MECHANICAL DEMOLITION PLAN – PARTIAL FIRST FLOOR
SCALE: 1/2" = 1'-0"

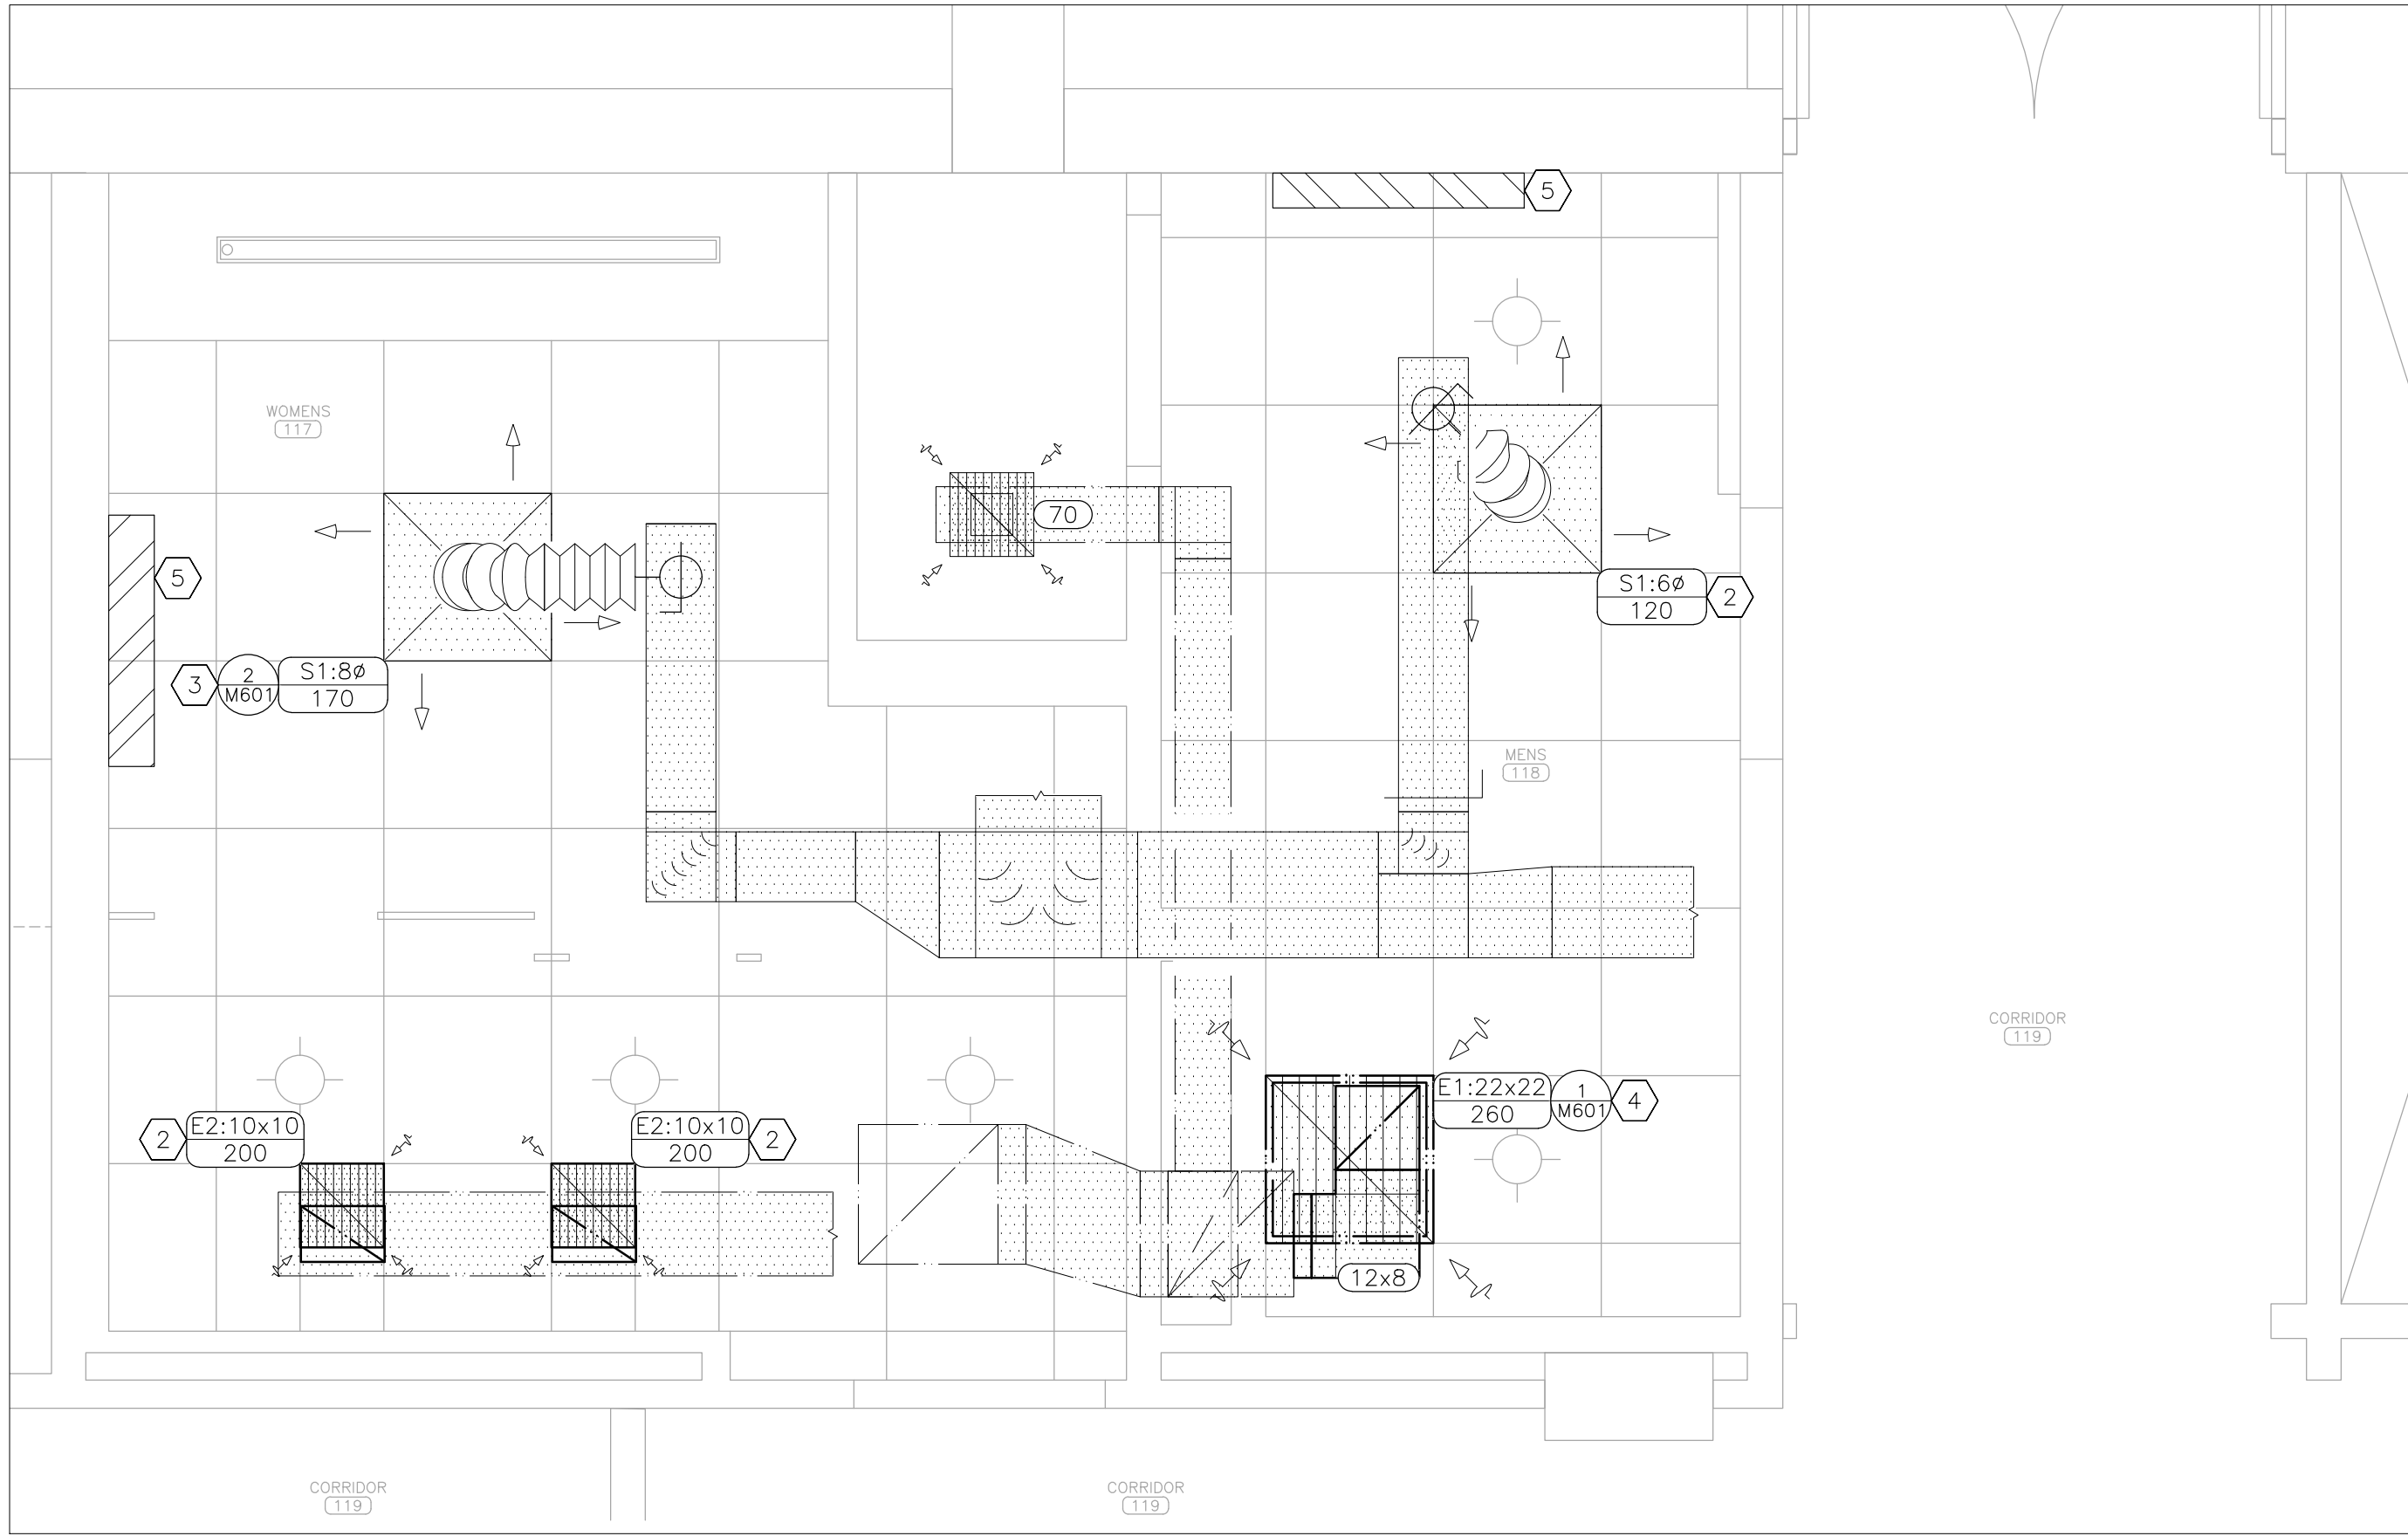

2 MECHANICAL RENOVATION PLAN – PARTIAL FIRST FLOOR
SCALE: 1/2" = 1'-0"

DEMOLITION NOTES – DETAIL 1

INDICATES KEYED NOTES


- 1 REFER TO SHEET M-101 FOR GENERAL DEMOLITION NOTES.
- 2 DEMOLISH AIR DEVICE. DEMOLISH ASSOCIATED DUCT BACK TO TAKE-OFF. TAKE-OFF TO REMAIN FOR USE IN NEW CONSTRUCTION.
- 3 DEMOLISH AIR DEVICE. DEMOLISH ASSOCIATED DUCT AS SHOWN. PROVIDE AND INSTALL INSULATED SHEET METAL CAP ON DUCT TO REMAIN.
- 4 DEMOLISH AIR DEVICE. DEMOLISH ASSOCIATED DUCT BACK TO MAIN. PENETRATION TO REMAIN FOR USE IN NEW CONSTRUCTION.
- 5 REMOVE AND RETAIN FLOOR MOUNTED CABINET CONVECTOR. PROVIDE TEMPORARY CAPS ON HEATING SUPPLY AND RETURN PIPE TO REMAIN. ENSURE BYPASS PIPE IS IN PLACE TO ALLOW FLOW TO NEXT CONVECTOR IN THE LOOP. MINIMIZE TIME CONVECTOR IS NOT OPERATIONAL.
- 6 DEMOLISH THERMOSTAT AND ASSOCIATED WALL BOX AND CONTROL WIRE.

RENOVATION NOTES – DETAIL 2

INDICATES KEYED NOTES

- 1 REFER TO SHEET M-101 FOR GENERAL RENOVATION NOTES.
- 2 PROVIDE AND INSTALL AIR DEVICE. ROUTE DUCT BACK TO EXISTING TAKE-OFF.
- 3 PROVIDE AND INSTALL AIR DEVICE. ROUTE DUCT BACK TO NEW TAKE-OFF.
- 4 PROVIDE AND INSTALL AIR DEVICE. ROUTE DUCT BACK TO MAIN AND CONNECT TO EXISTING PENETRATION.
- 5 INSTALL RETAINED CABINET CONVECTOR AFTER NEW FLOOR AND WALL TILE ARE INSTALLED.

HVAC LEGEND	
	DETAIL REFERENCE, NUMBER/SHEET
	THERMOSTAT – WALL MOUNTED
	AIR DEVICE: NECK SIZE (INCHES)/CFM
	DUCT SIZE–RECTANGULAR (INCHES X INCHES)
	AIR FLOW (CUBIC FEET PER MINUTE)
	SUPPLY AIR – NEW
	SUPPLY AIR – EXISTING
	EXHAUST AIR – NEW
	EXHAUST AIR – EXISTING
	EXISTING MATERIALS TO BE REMOVED
	LIGHT FIXTURE – LINEAR/TROFFER
	LIGHT FIXTURE – DOWN LIGHT

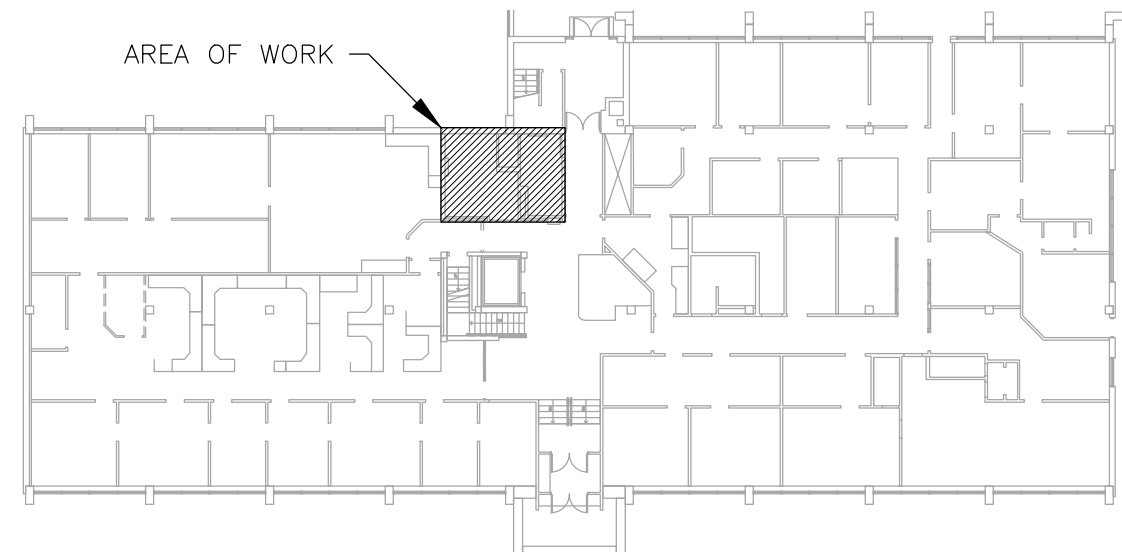

3 AREA MAP – FIRST FLOOR

STATE OF MISSOURI
MIKE KEHOE,
GOVERNOR



Tracie L. Siebeneck - Engineer
MO# PE-2013019114

BID
DOCUMENTS

OFFICE OF ADMINISTRATION
DIVISION OF FACILITIES
MANAGEMENT,
DESIGN AND CONSTRUCTION

DEPARTMENT OF
PUBLIC SAFETY
STATE HIGHWAY PATROL

RENOVATE INTERIOR

GENERAL HEADQUARTERS
1510 EAST ELM STREET
JEFFERSON CITY, MO 65101

PROJECT # R2410-01
SITE # 6001
ASSET # 8136001001

REVISION: _____
DATE: _____
REVISION: _____
DATE: _____
REVISION: _____
DATE: _____
ISSUE DATE: 06/18/2026


CAD DWG FILE: M_R2410-01
DRAWN BY: TS/AH
CHECKED BY: TS
DESIGNED BY: TS/AH

SHEET TITLE:
PARTIAL
MECHANICAL PLAN
FIRST FLOOR


SHEET NUMBER:

M-102

28 OF 39 SHEETS
06/18/2026

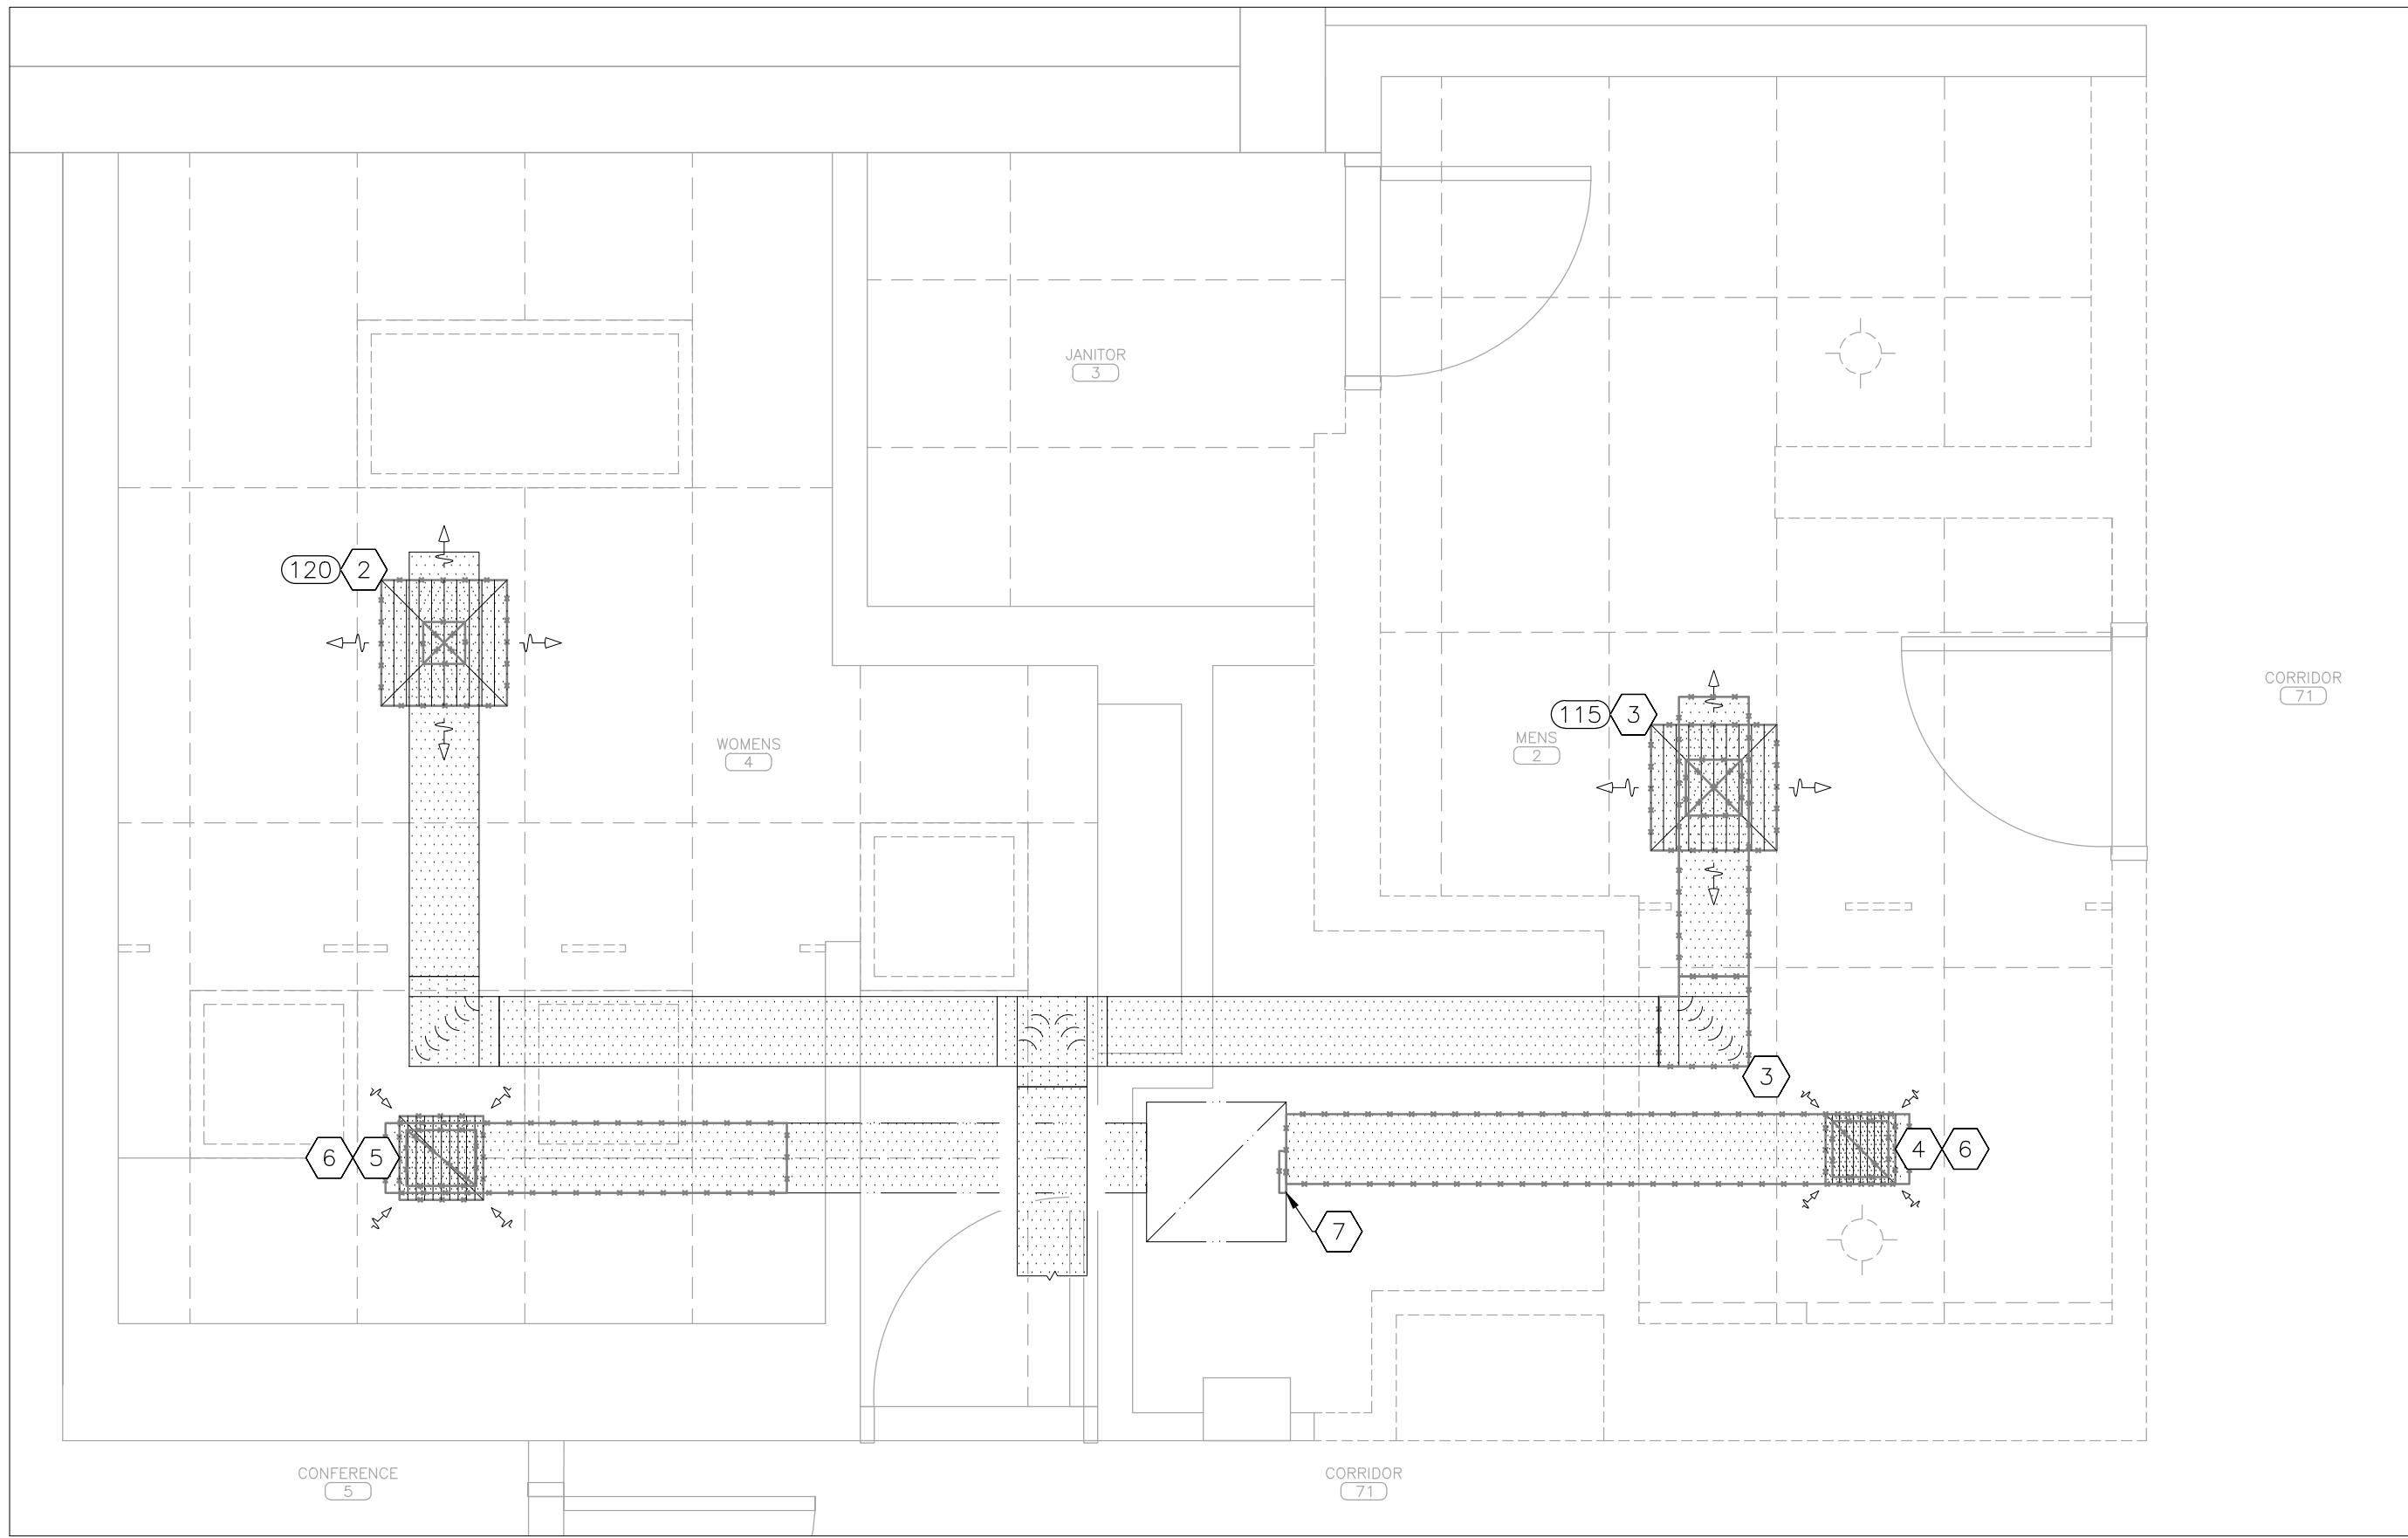

1 MECHANICAL DEMOLITION PLAN – PARTIAL SECOND FLOOR
SCALE: 1/2" = 1'-0"

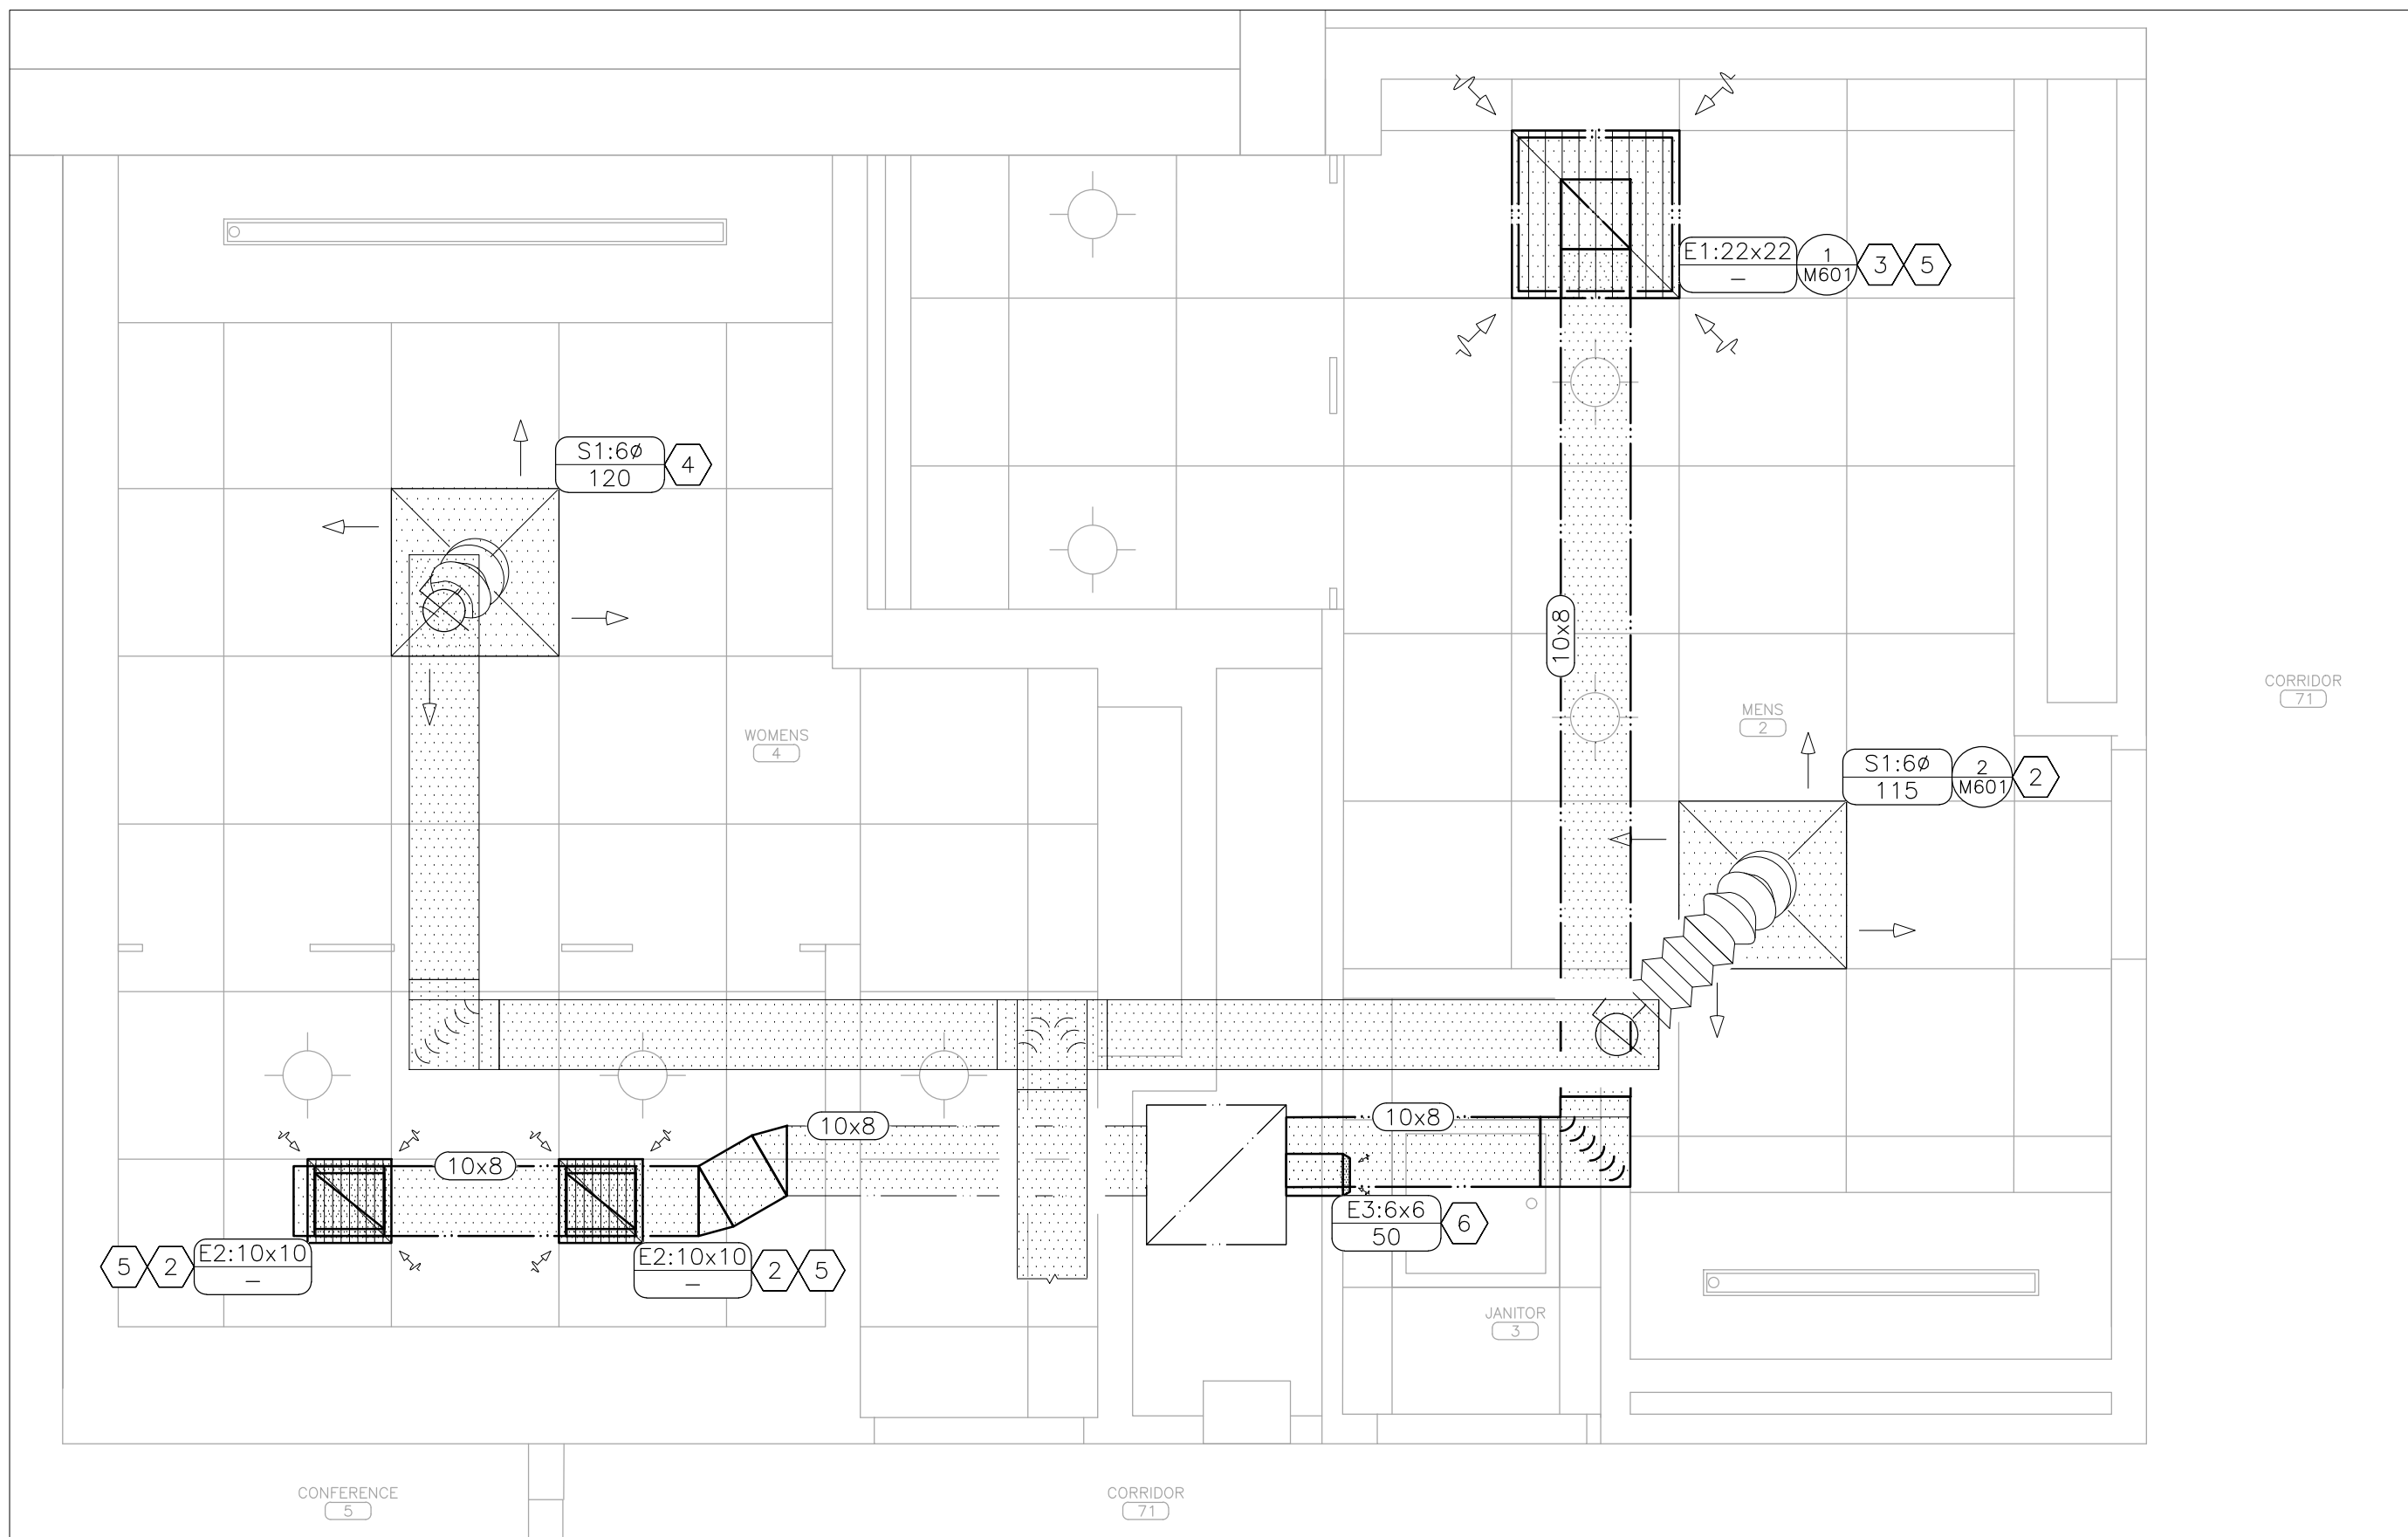

2 MECHANICAL RENOVATION PLAN – PARTIAL SECOND FLOOR
SCALE: 1/2" = 1'-0"

DEMOLITION NOTES – DETAIL 1

INDICATES KEYED NOTES

- 1 REFER TO SHEET M-101 FOR GENERAL DEMOLITION NOTES.
- 2 DEMOLISH AIR DEVICE. DEMOLISH ASSOCIATED DUCT BACK TO TAKE-OFF. PENETRATION TO BE MODIFIED IN NEW CONSTRUCTION.
- 3 DEMOLISH AIR DEVICE. DEMOLISH ASSOCIATED DUCT AS SHOWN. PROVIDE AND INSTALL INSULATED SHEET METAL CAP ON DUCT TO REMAIN.
- 4 DEMOLISH AIR DEVICE. DEMOLISH ASSOCIATED DUCT BACK TO MAIN. PENETRATION TO REMAIN FOR USE IN NEW CONSTRUCTION.
- 5 DEMOLISH AIR DEVICE. DEMOLISH ASSOCIATED DUCT AS SHOWN OR AS NEEDED FOR NEW WORK.
- 6 EXISTING AIRFLOW IS NOT KNOWN. TESTING AND BALANCING CONTRACTOR SHALL PROVIDE MEASURED AIRFLOW TO ENGINEER.
- 7 CREATE PENETRATION IN EXISTING EXHAUST RISER FOR NEW TAKE-OFF. SEE DETAIL 2 FOR DUCT SIZE AND LOCATION.


RENOVATION NOTES – DETAIL 2

INDICATES KEYED NOTES

- 1 REFER TO SHEET M-101 FOR GENERAL RENOVATION NOTES.
- 2 PROVIDE AND INSTALL AIR DEVICE. ROUTE DUCT BACK TO NEW TAKE-OFF.
- 3 PROVIDE AND INSTALL AIR DEVICE. ROUTE DUCT BACK TO MAIN AND CONNECT TO EXISTING PENETRATION.
- 4 PROVIDE AND INSTALL AIR DEVICE. ROUTE DUCT BACK TO EXISTING PENETRATION. MODIFY PENETRATION TO MATCH NECK SIZE AND PROVIDE NEW TAKE-OFF.
- 5 TAB CONTRACTOR SHALL BALANCE TO AIRFLOW DETERMINED BY ENGINEER BASED ON AIRFLOW MEASURED PRIOR TO DEMOLITION.
- 6 PROVIDE AND INSTALL TAKE-OFF IN EXISTING EXHAUST RISER AND ROUTE TO NEW WALL MOUNTED EXHAUST GRILLE. INSTALL AT A HEIGHT OF 6'-6" TO BOTTOM OF GRILLE.

HVAC LEGEND

	DETAIL REFERENCE, NUMBER/SHEET
	AIR DEVICE: NECK SIZE (INCHES)/CFM
	DUCT SIZE-RECTANGULAR (INCHES X INCHES)
	AIR FLOW (CUBIC FEET PER MINUTE)
	SUPPLY AIR – NEW
	SUPPLY AIR – EXISTING
	EXHAUST AIR – NEW
	EXHAUST AIR – EXISTING
	EXISTING MATERIALS TO BE REMOVED
	LIGHT FIXTURE – LINEAR/TROFFER
	LIGHT FIXTURE – DOWN LIGHT

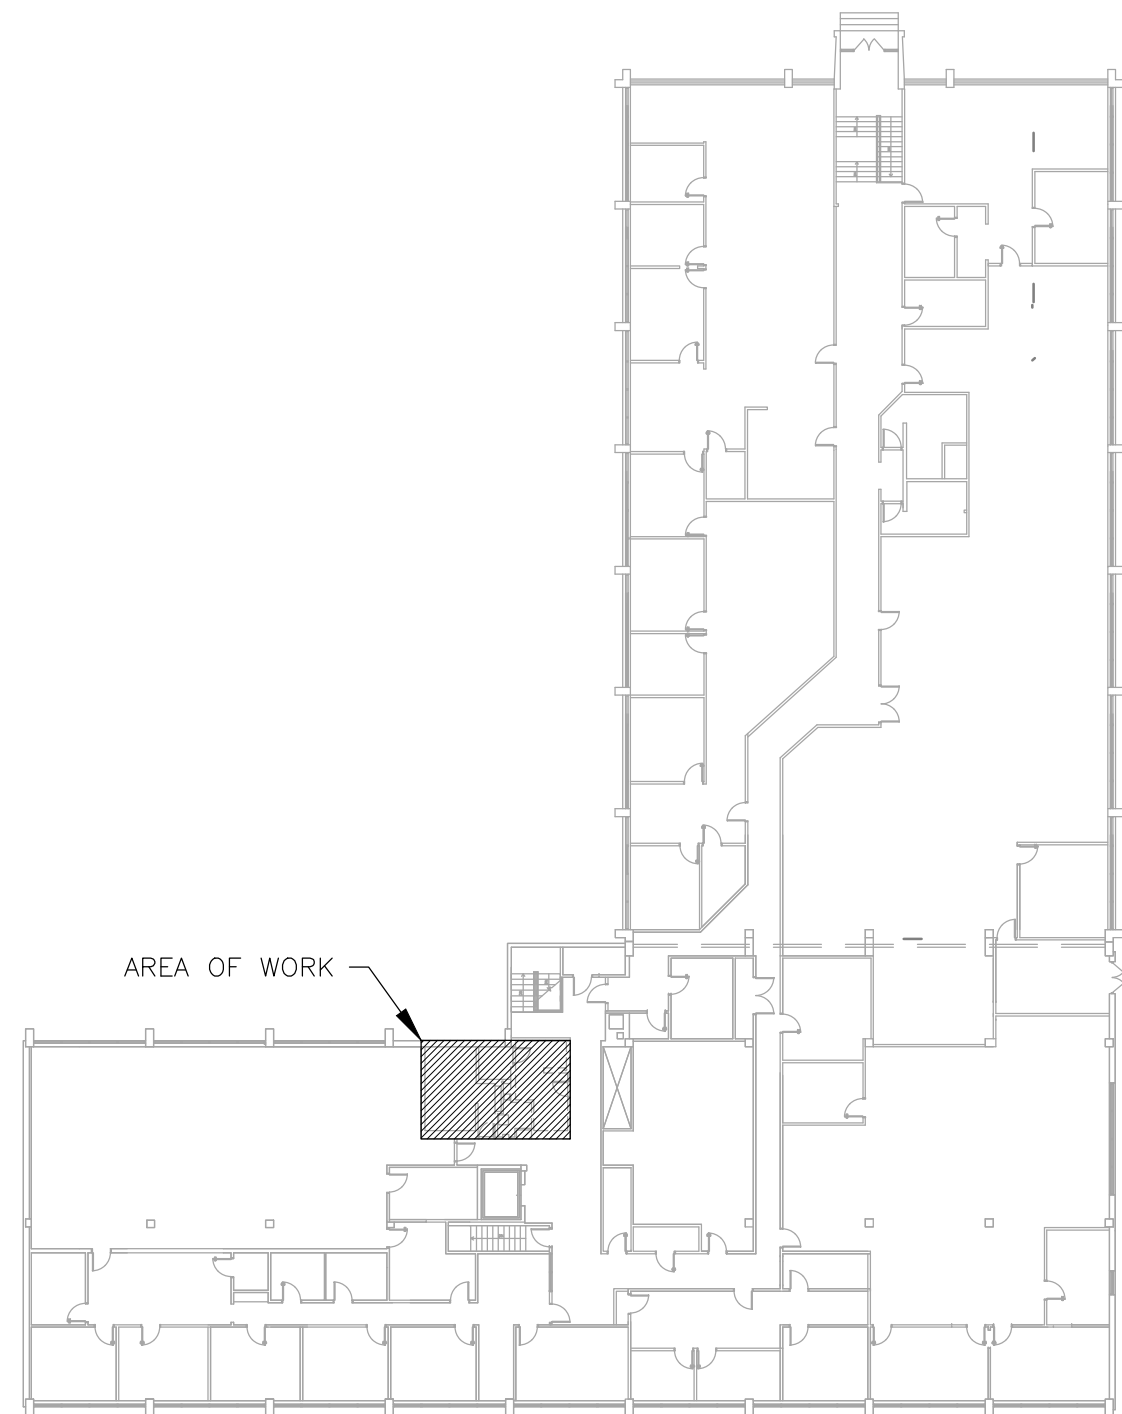

3 AREA MAP – SECOND FLOOR

STATE OF MISSOURI
MIKE KEHOE,
GOVERNOR



Tracie L. Siebencek - Engineer
MO# PE-2013019114

BID
DOCUMENTS

OFFICE OF ADMINISTRATION
DIVISION OF FACILITIES
MANAGEMENT,
DESIGN AND CONSTRUCTION

DEPARTMENT OF
PUBLIC SAFETY
STATE HIGHWAY PATROL

RENOVATE INTERIOR

GENERAL HEADQUARTERS
1510 EAST ELM STREET
JEFFERSON CITY, MO 65101

PROJECT # R2410-01
SITE # 6001
ASSET # 8136001001

REVISION: _____
DATE: _____
REVISION: _____
DATE: _____
REVISION: _____
DATE: _____
ISSUE DATE: 06/18/2026


CAD DWG FILE: M_R2410-01
DRAWN BY: TS/AH
CHECKED BY: TS
DESIGNED BY: TS/AH

SHEET TITLE:
PARTIAL
MECHANICAL PLAN
SECOND FLOOR


SHEET NUMBER:

M-103

29 OF 39 SHEETS
06/18/2026

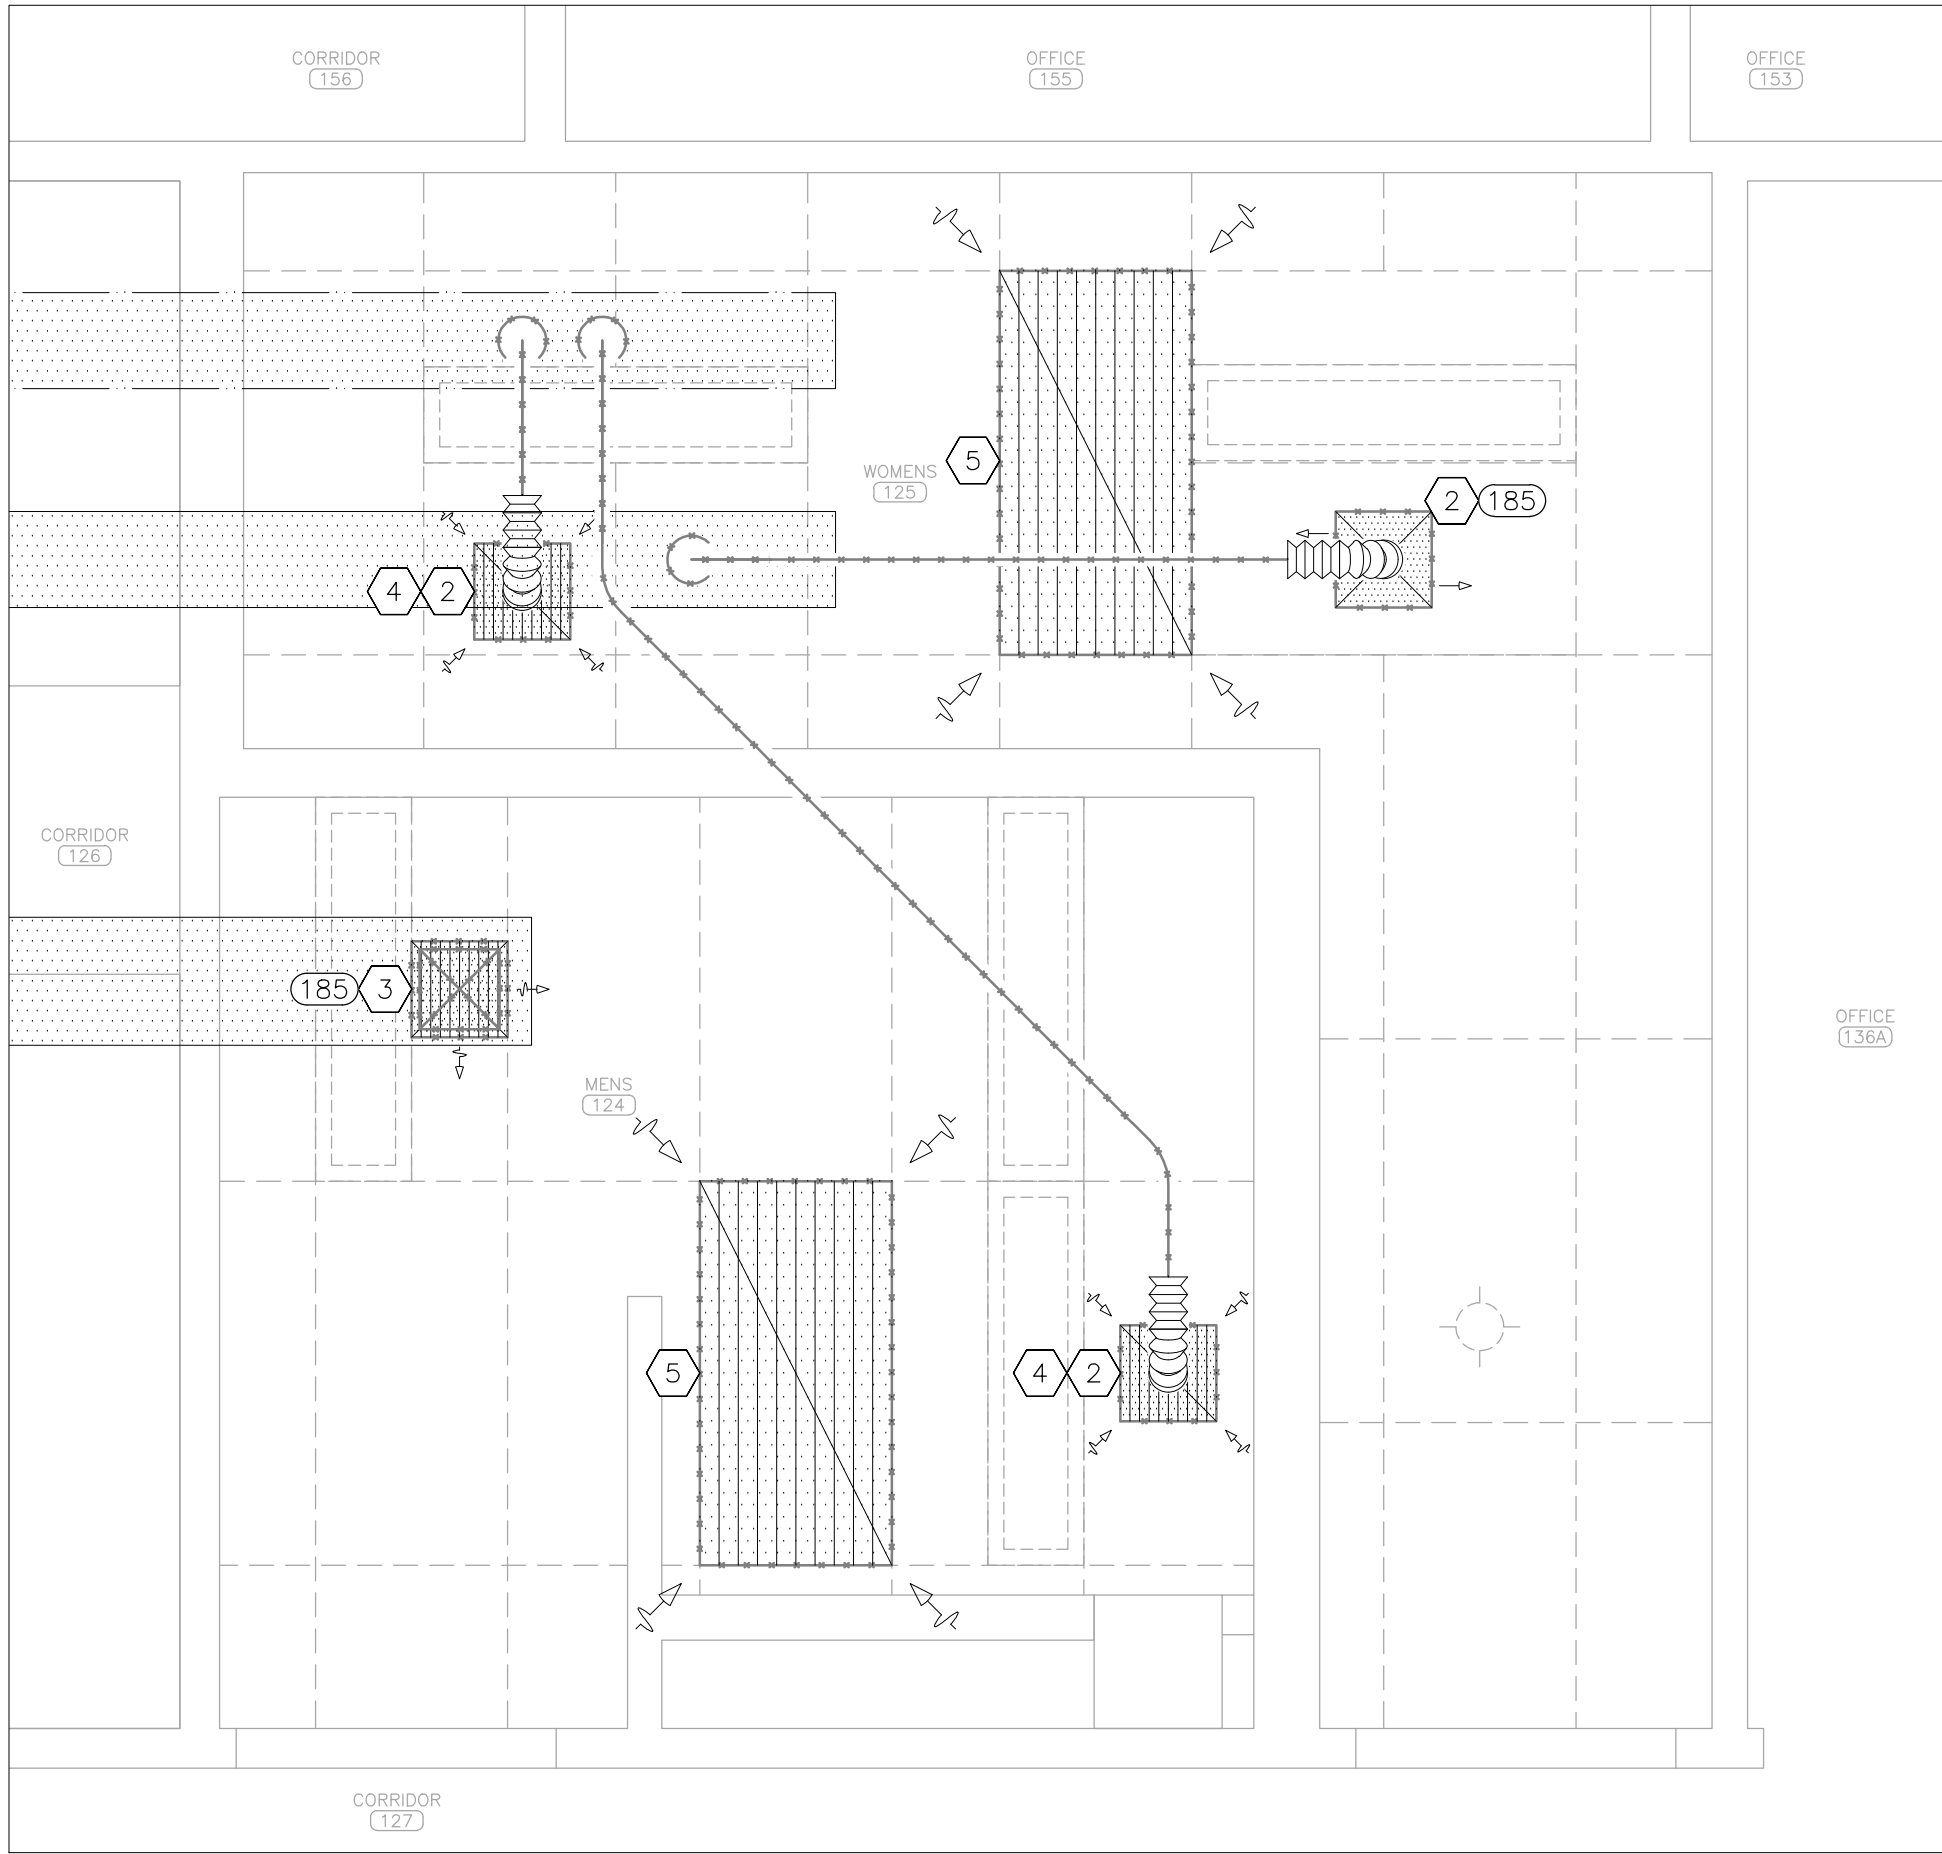

1 MECHANICAL DEMOLITION PLAN – PARTIAL FIRST FLOOR
SCALE: 1/2" = 1'-0"

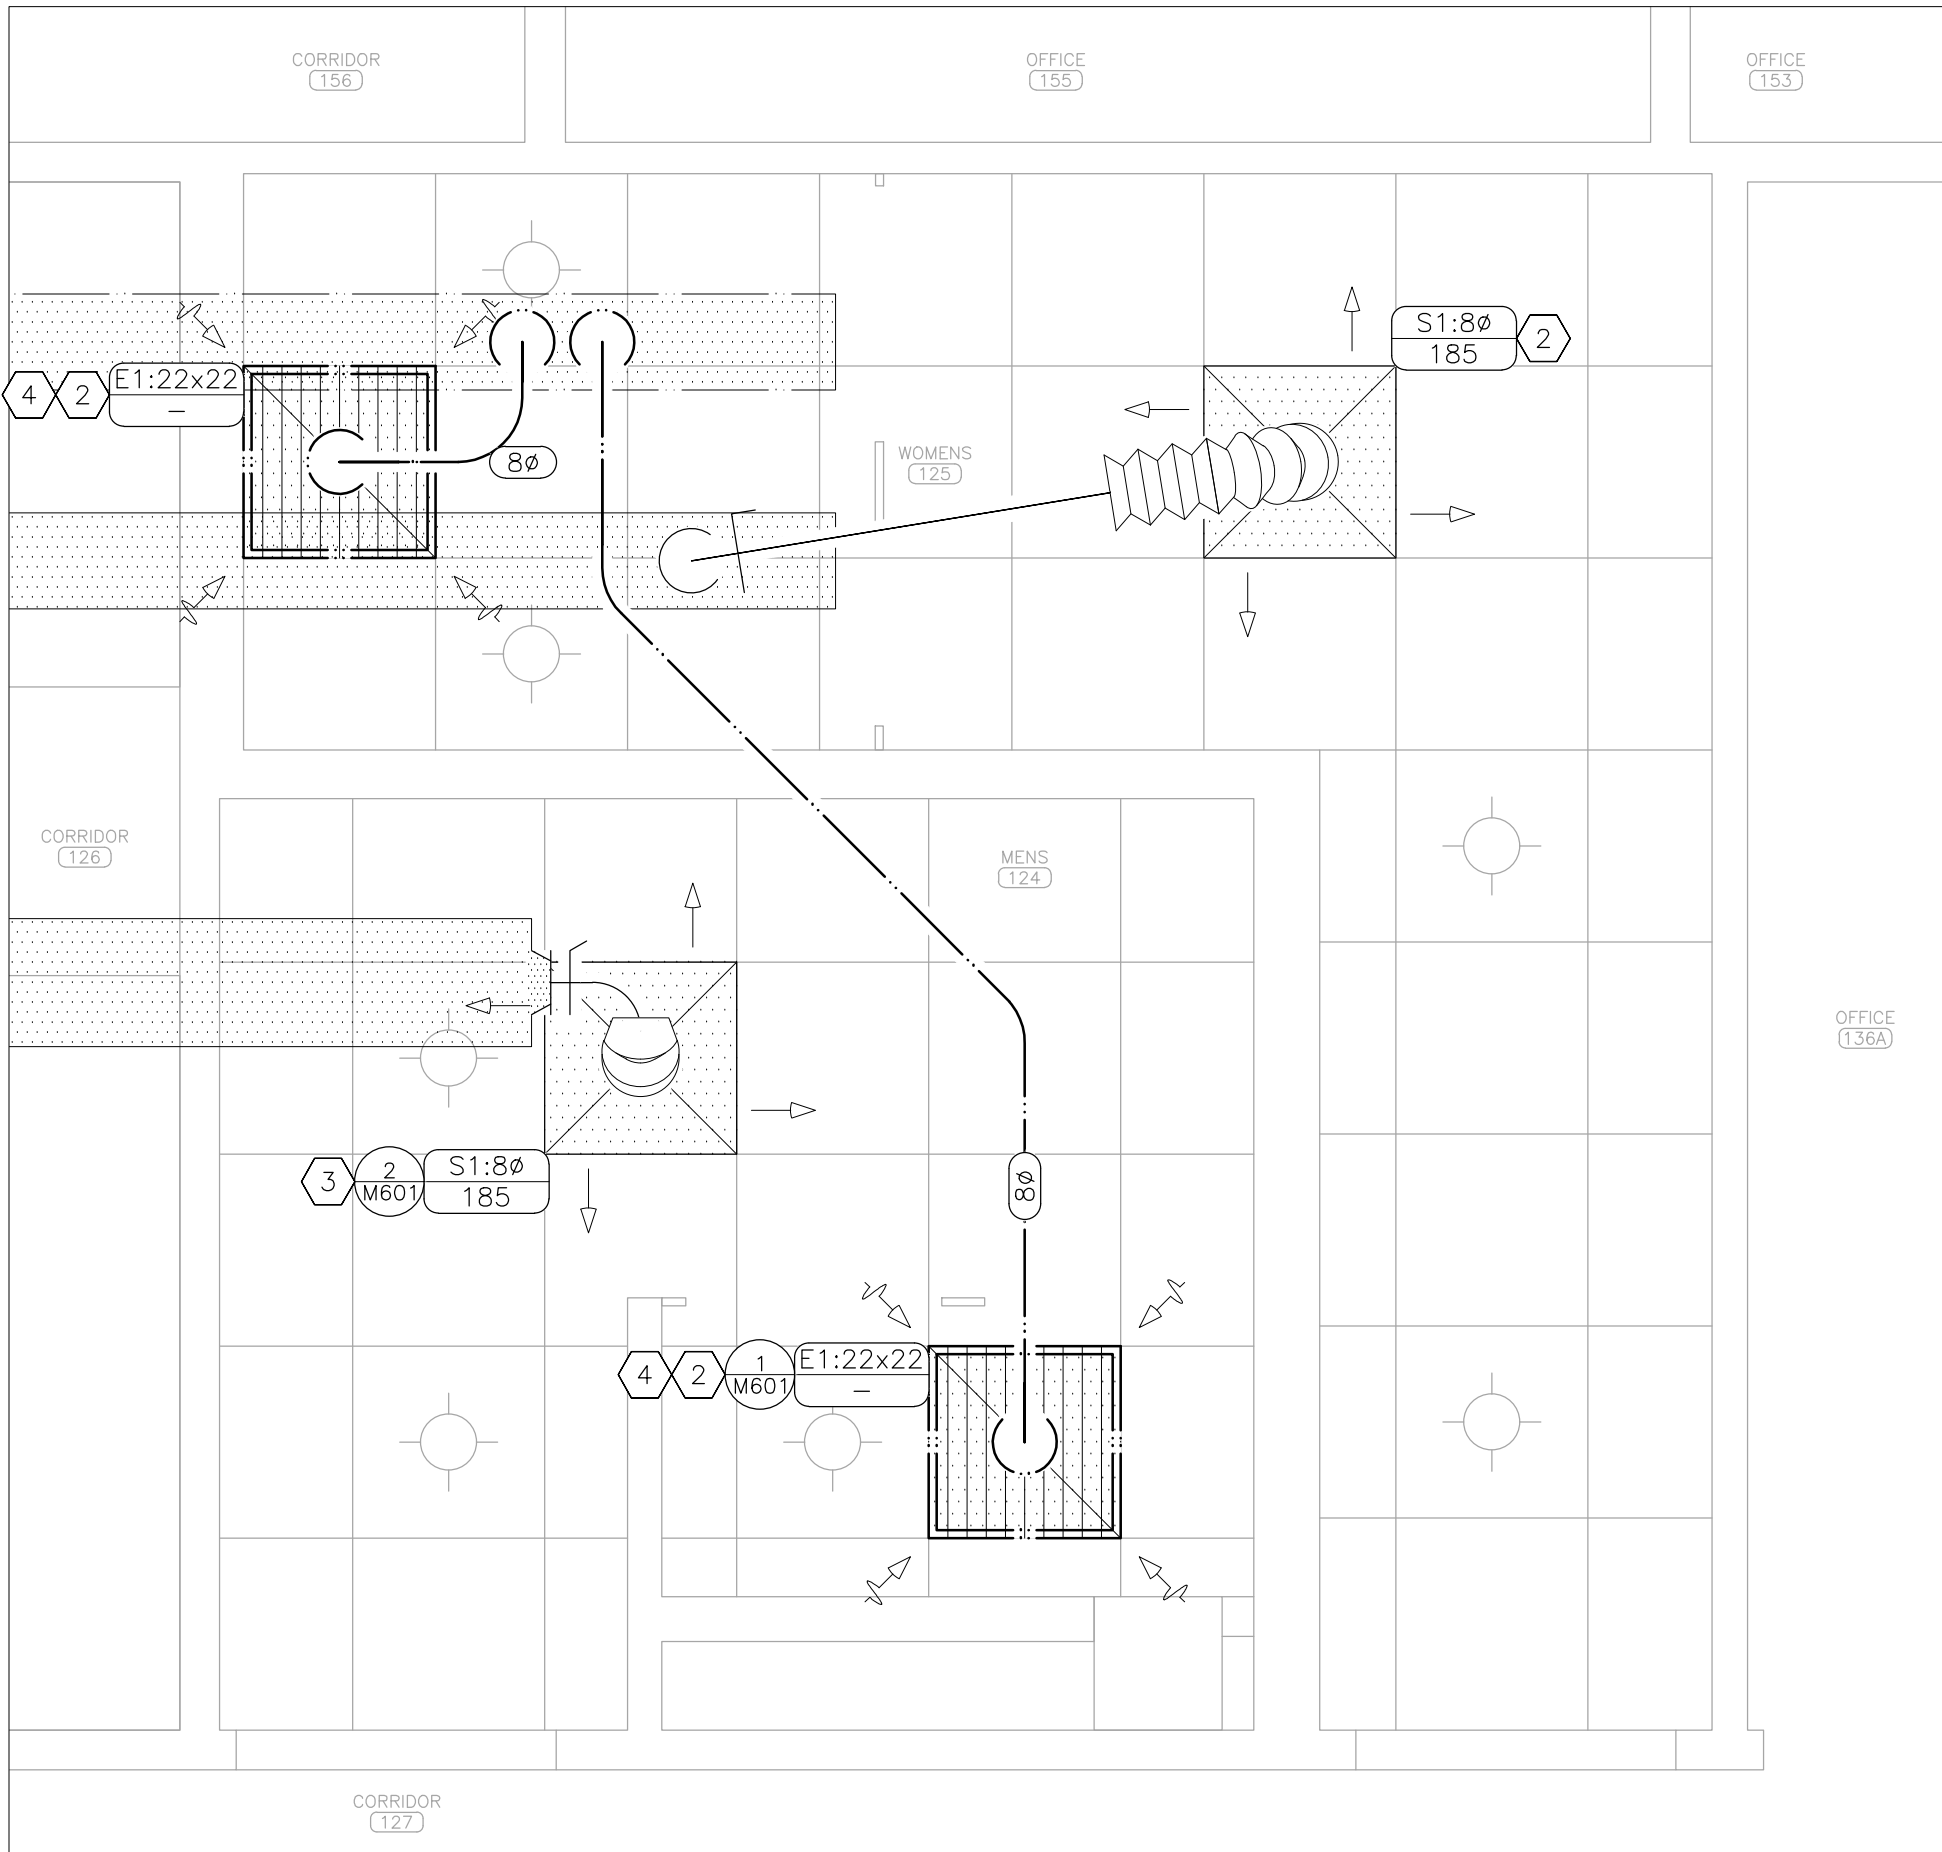

2 MECHANICAL RENOVATION PLAN – PARTIAL FIRST FLOOR
SCALE: 1/2" = 1'-0"

DEMOLITION NOTES – DETAIL 1

INDICATES KEYED NOTES


- 1 REFER TO SHEET M-101 FOR GENERAL DEMOLITION NOTES.
- 2 DEMOLISH AIR DEVICE. DEMOLISH ASSOCIATED DUCT BACK TO TAKE-OFF. TAKE-OFF TO REMAIN FOR USE IN NEW CONSTRUCTION.
- 3 DEMOLISH AIR DEVICE. DEMOLISH ASSOCIATED DUCT BACK TO TAKE-OFF AND INSTALL SHEET METAL CAP. INSULATE CAP TO MATCH EXISTING DUCT.
- 4 EXISTING AIRFLOW IS NOT KNOWN. TESTING AND BALANCING CONTRACTOR SHALL PROVIDE MEASURED AIRFLOW TO ENGINEER.
- 5 DEMOLISH AIR DEVICE.

RENOVATION NOTES – DETAIL 2

INDICATES KEYED NOTES

- 1 REFER TO SHEET M-101 FOR GENERAL RENOVATION NOTES.
- 2 PROVIDE AND INSTALL AIR DEVICE. ROUTE DUCT BACK TO EXISTING TAKE-OFF.
- 3 PROVIDE AND INSTALL AIR DEVICE. ROUTE DUCT BACK TO NEW TAKE-OFF.
- 4 TAB CONTRACTOR SHALL BALANCE TO AIRFLOW DETERMINED BY ENGINEER BASED ON AIRFLOW MEASURED PRIOR TO DEMOLITION.

HVAC LEGEND	
#	DETAIL REFERENCE, NUMBER/SHEET
S1:6ø 50	AIR DEVICE: NECK SIZE (INCHES)/CFM
350	AIR FLOW (CUBIC FEET PER MINUTE)
8ø	DUCT SIZE-ROUND (INCHES DIAMETER)
---	SUPPLY AIR – NEW
---	SUPPLY AIR – EXISTING
---	EXHAUST AIR – NEW
---	EXHAUST AIR – EXISTING
---	EXISTING MATERIALS TO BE REMOVED
---	LIGHT FIXTURE – LINEAR/TROFFER
---	LIGHT FIXTURE – DOWN LIGHT

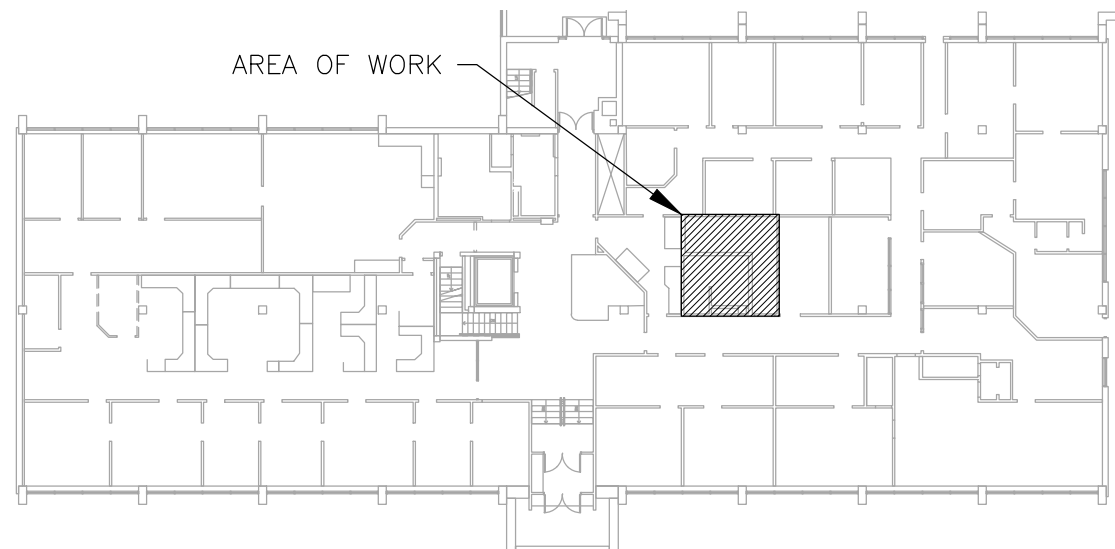

3 AREA MAP – FIRST FLOOR

STATE OF MISSOURI
MIKE KEHOE,
GOVERNOR



Tracie L. Siebeneck - Engineer
MO# PE-2013019114

BID
DOCUMENTS

OFFICE OF ADMINISTRATION
DIVISION OF FACILITIES
MANAGEMENT,
DESIGN AND CONSTRUCTION

DEPARTMENT OF
PUBLIC SAFETY
STATE HIGHWAY PATROL

RENOVATE INTERIOR

GENERAL HEADQUARTERS
1510 EAST ELM STREET
JEFFERSON CITY, MO 65101

PROJECT # R2410-01
SITE # 6001
ASSET # 8136001001

REVISION: _____
DATE: _____
REVISION: _____
DATE: _____
REVISION: _____
DATE: _____
ISSUE DATE: 06/18/2026

CAD DWG FILE: M_R2410-01
DRAWN BY: TS/AH
CHECKED BY: TS
DESIGNED BY: TS/AH

SHEET TITLE:
PARTIAL
MECHANICAL PLAN
FIRST FLOOR

SHEET NUMBER:

M-104

30 OF 39 SHEETS
06/18/2026



Tracie L. Siebeneck - Engineer
MO# PE-2013019114

BID
DOCUMENTS

OFFICE OF ADMINISTRATION
DIVISION OF FACILITIES
MANAGEMENT,
DESIGN AND CONSTRUCTION

DEPARTMENT OF
PUBLIC SAFETY
STATE HIGHWAY PATROL

RENOVATE INTERIOR

GENERAL HEADQUARTERS
1510 EAST ELM STREET
JEFFERSON CITY, MO 65101

PROJECT # R2410-01
SITE # 6001
ASSET # 8136001001

REVISION: _____
DATE: _____
REVISION: _____
DATE: _____
REVISION: _____
DATE: _____
ISSUE DATE: 06/18/2026

CAD DWG FILE: M_R2410-01
DRAWN BY: TS/AH
CHECKED BY: TS
DESIGNED BY: TS/AH

SHEET TITLE:
PARTIAL
MECHANICAL PLAN
FIRST FLOOR

SHEET NUMBER:

M-105

31 OF 39 SHEETS
06/18/2026



DEMOLITION NOTES – DETAILS 1 & 2 # INDICATES KEYED NOTES

- 1 REFER TO SHEET M-101 FOR GENERAL DEMOLITION NOTES.
- 2 DEMOLISH AIR DEVICE. DEMOLISH ASSOCIATED DUCT BACK TO TAKE-OFF. TAKE-OFF TO REMAIN FOR USE IN NEW CONSTRUCTION.
- 3 EXISTING AIRFLOW IS NOT KNOWN. TESTING AND BALANCING CONTRACTOR SHALL PROVIDE MEASURED AIRFLOW TO ENGINEER.


RENOVATION NOTES – DETAILS 3 & 4 # INDICATES KEYED NOTES

- 1 REFER TO SHEET M-101 FOR GENERAL RENOVATION NOTES.
- 2 PROVIDE AND INSTALL AIR DEVICE. ROUTE DUCT BACK TO EXISTING TAKE-OFF.
- 3 TAB CONTRACTOR SHALL BALANCE TO AIRFLOW DETERMINED BY ENGINEER BASED ON AIRFLOW MEASURED PRIOR TO DEMOLITION.


HVAC LEGEND	
	DETAIL REFERENCE, NUMBER/SHEET
	AIR DEVICE: NECK SIZE (INCHES)/CFM
	SUPPLY AIR – NEW
	SUPPLY AIR – EXISTING
	EXHAUST AIR – NEW
	EXHAUST AIR – EXISTING
	EXISTING MATERIALS TO BE REMOVED
	LIGHT FIXTURE – LINEAR/TROFFER
	LIGHT FIXTURE – DOWN LIGHT

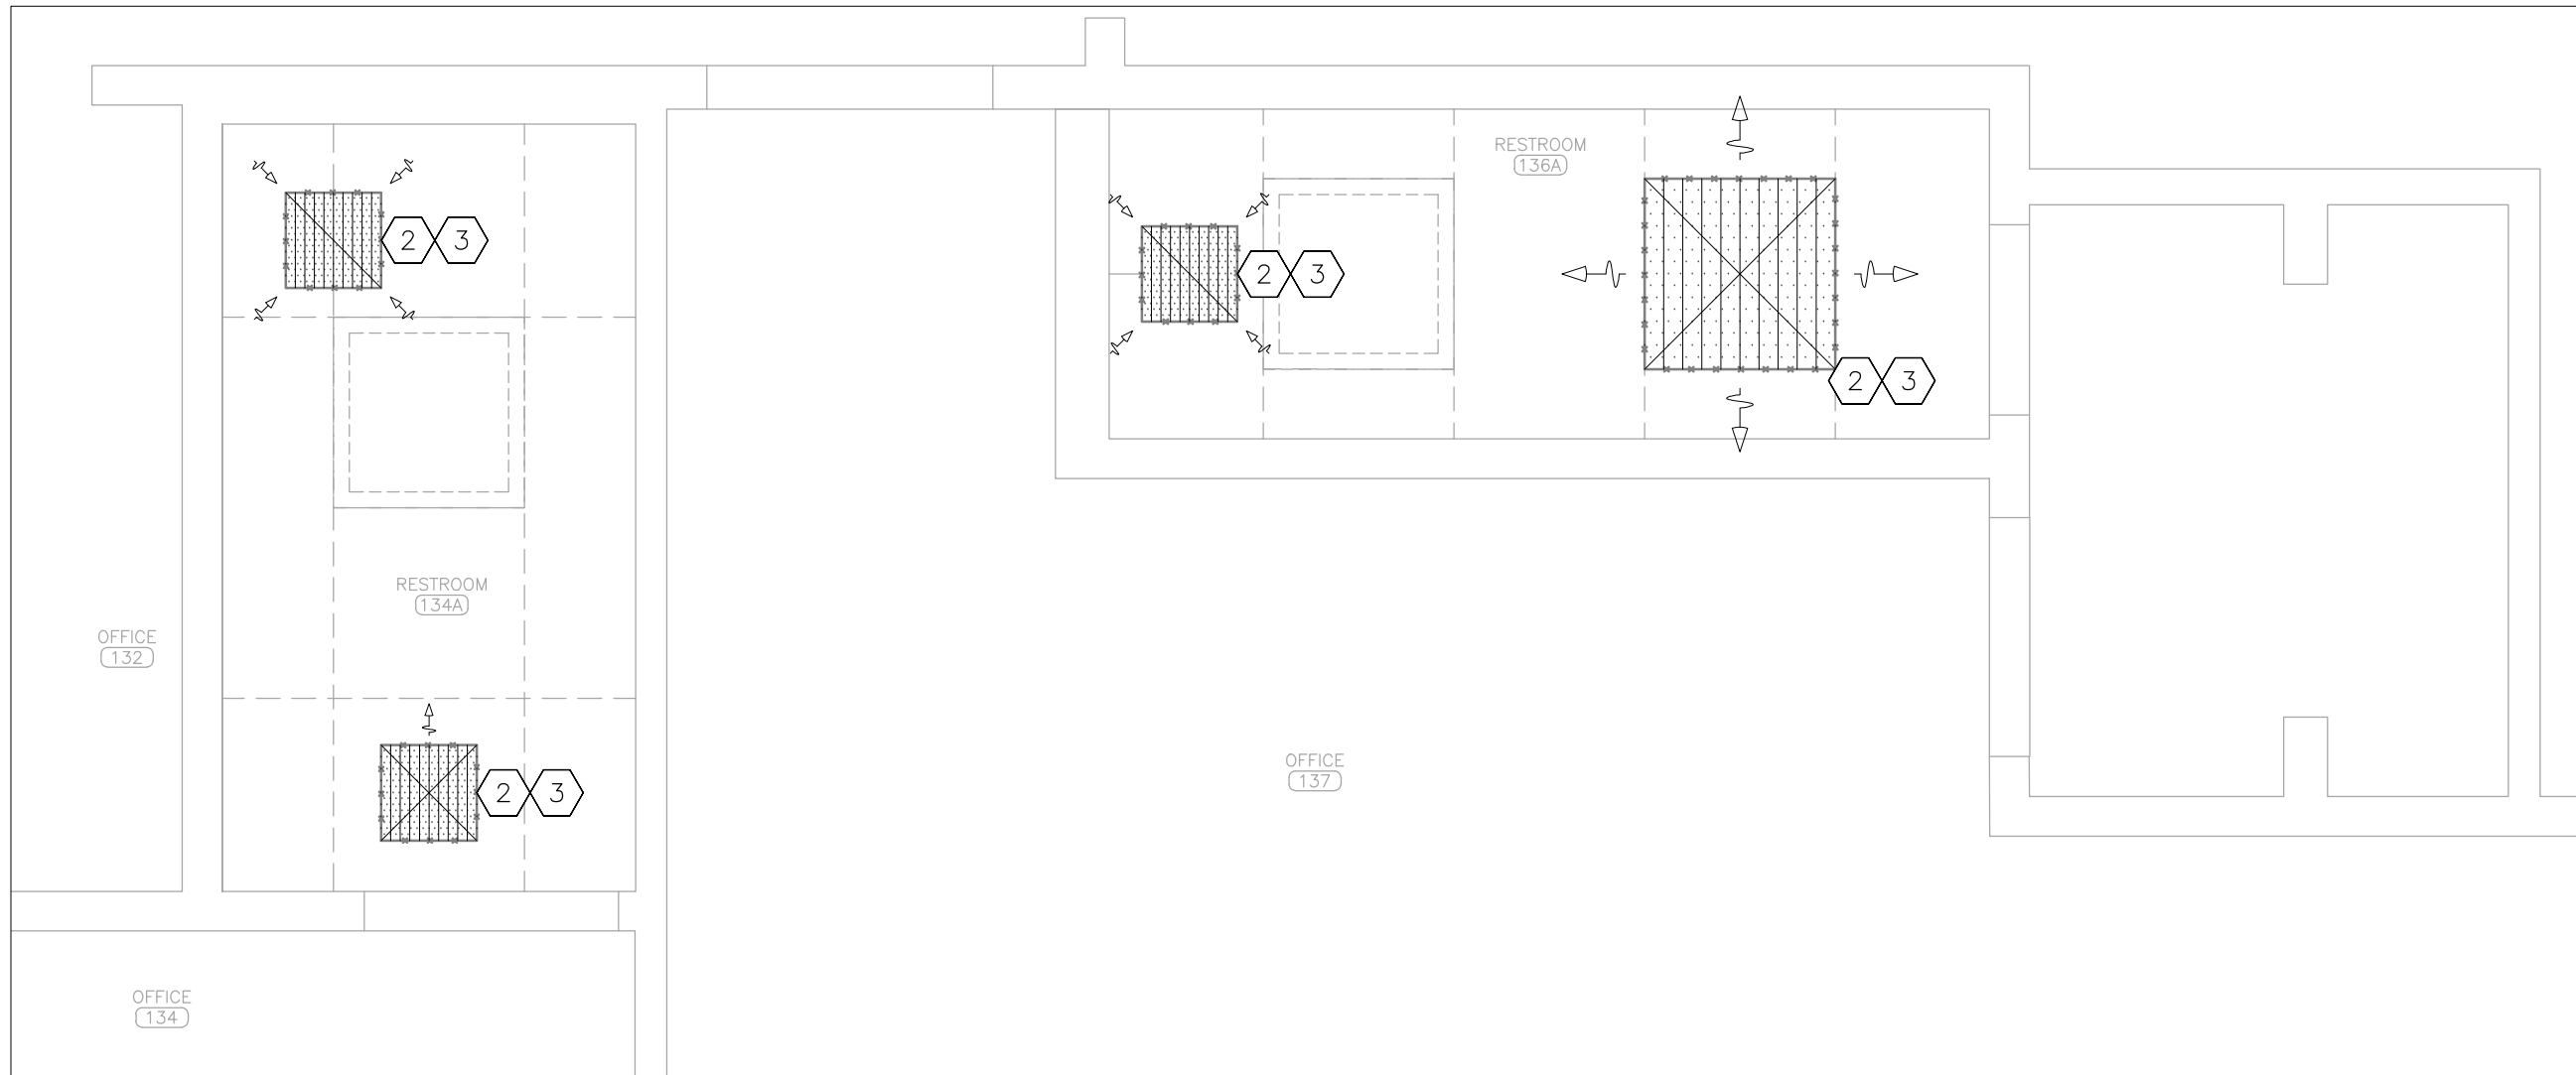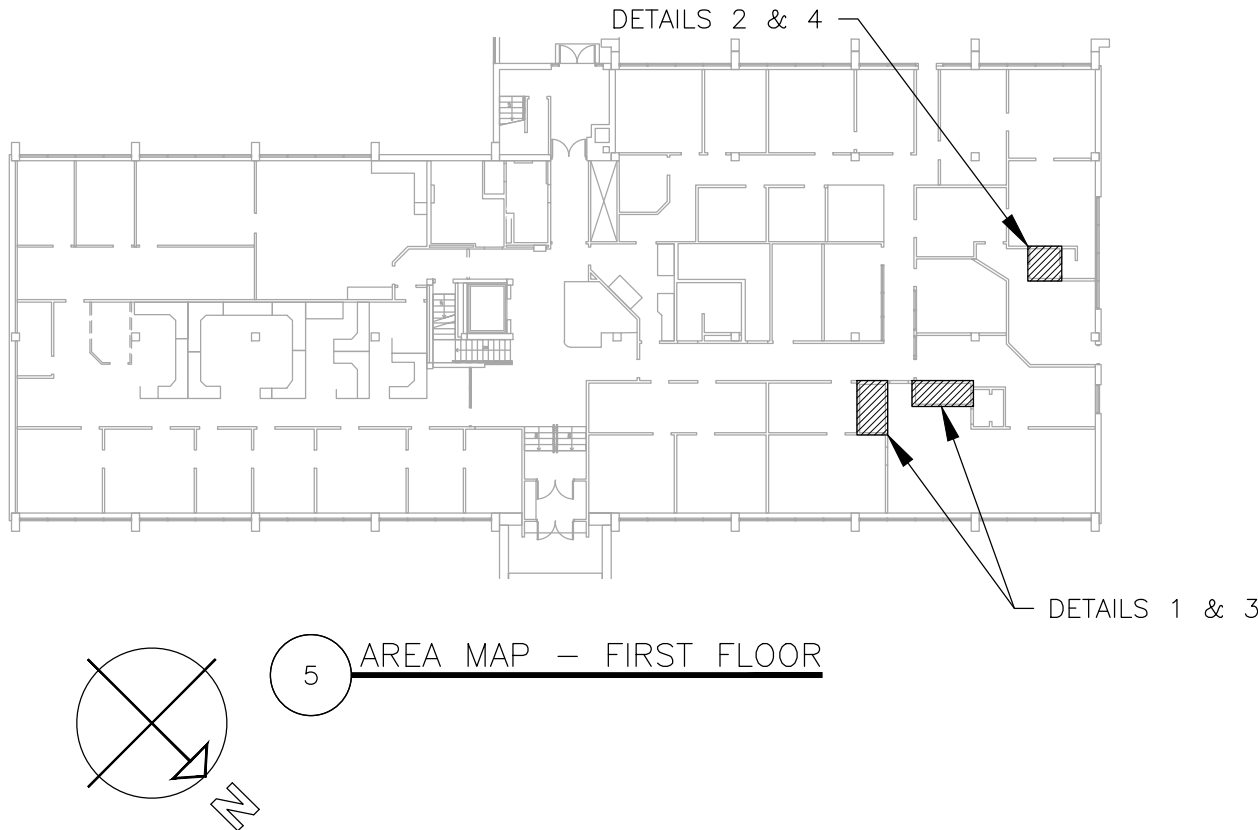


1 MECHANICAL DEMOLITION PLAN – PARTIAL FIRST FLOOR
SCALE: 1/2" = 1'-0"

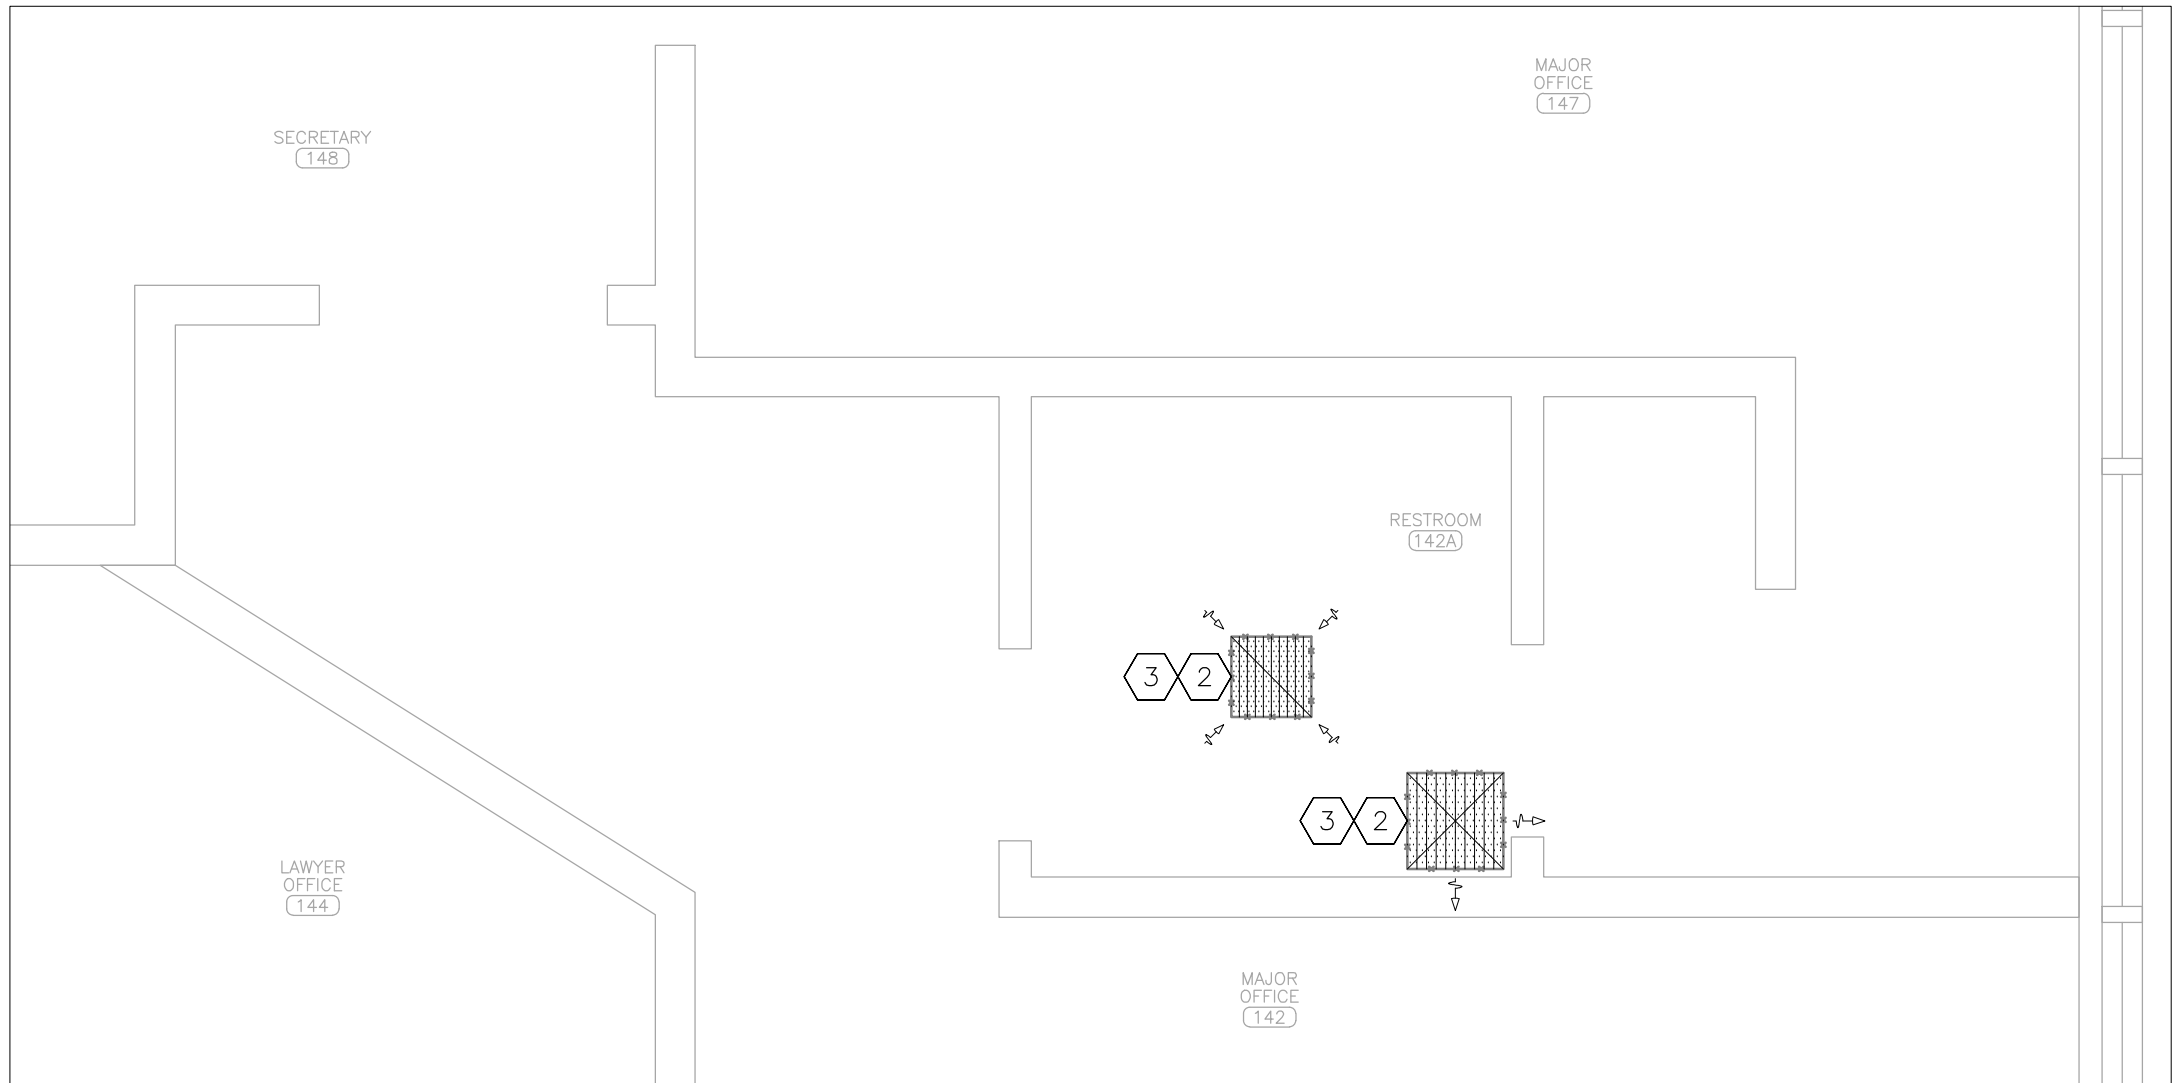

2 MECHANICAL DEMOLITION PLAN – PARTIAL FIRST FLOOR
SCALE: 1/2" = 1'-0"

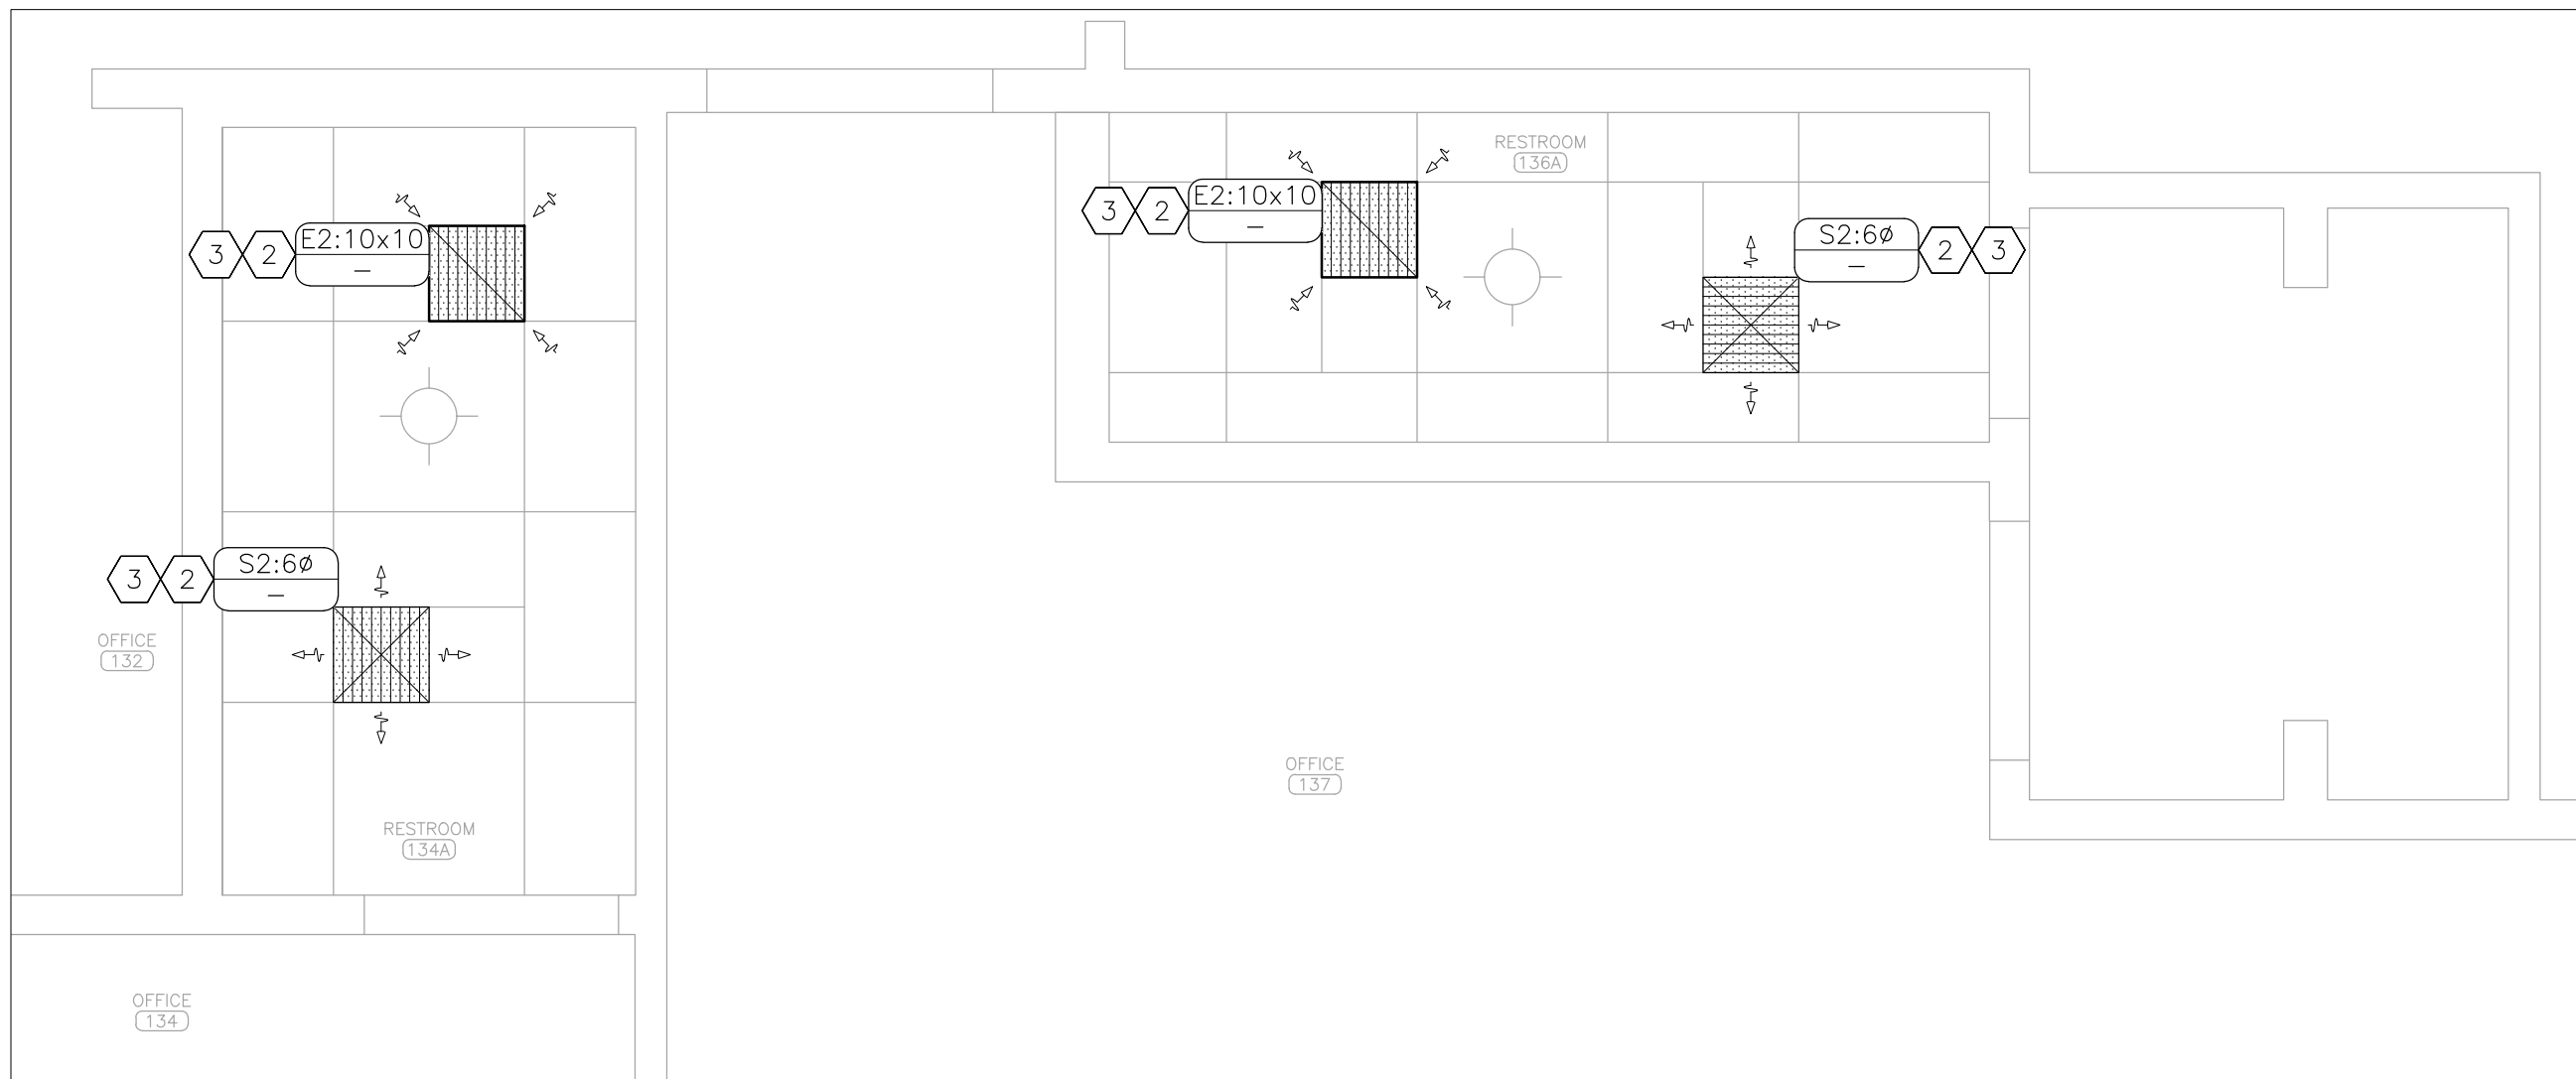

3 MECHANICAL RENOVATION PLAN – PARTIAL FIRST FLOOR
SCALE: 1/2" = 1'-0"

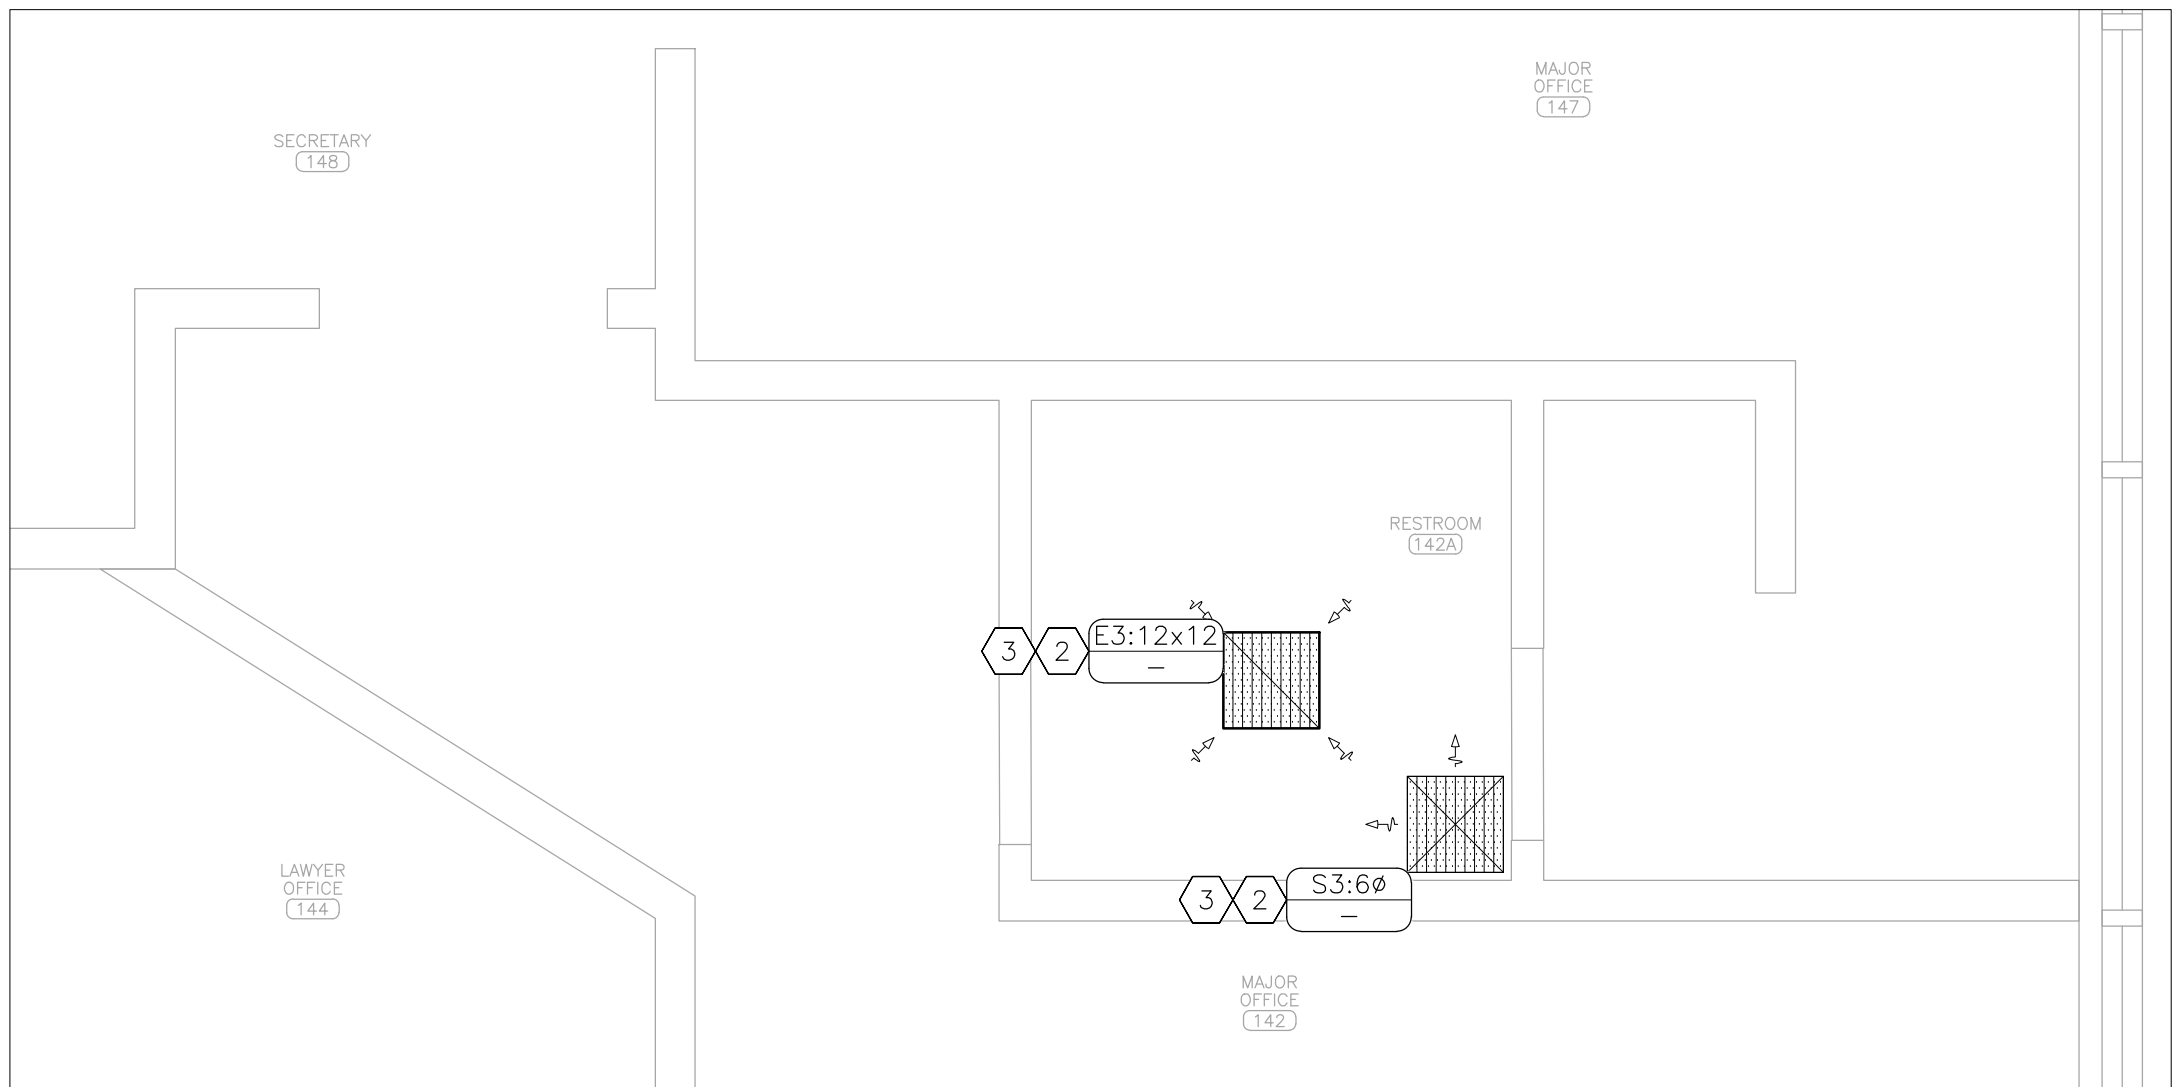

4 MECHANICAL RENOVATION PLAN – PARTIAL FIRST FLOOR
SCALE: 1/2" = 1'-0"

DEMOLITION NOTES – DETAIL 1

- 1
- REFER TO SHEET M-101 FOR GENERAL DEMOLITION NOTES.
- 2
- DEMOLISH AIR DEVICE. DEMOLISH ASSOCIATED DUCT BACK TO TAKE-OFF. TAKE-OFF TO REMAIN FOR USE IN NEW CONSTRUCTION.
- 3
- DEMOLISH AIR DEVICE. DEMOLISH ASSOCIATED DUCT AS SHOWN OR AS NEEDED FOR NEW WORK.
- 4
- EXISTING AIRFLOW IS NOT KNOWN, TESTING AND BALANCING CONTRACTOR SHALL PROVIDE MEASURED AIRFLOW TO ENGINEER.

RENOVATION NOTES – DETAIL 2

- 1
- REFER TO SHEET M-101 FOR GENERAL RENOVATION NOTES.
- 2
- PROVIDE AND INSTALL AIR DEVICE. ROUTE DUCT BACK TO EXISTING TAKE-OFF.
- 3
- PROVIDE AND INSTALL AIR DEVICE. ROUTE DUCT BACK TO MAIN.
- 4
- TAB CONTRACTOR SHALL BALANCE TO AIRFLOW DETERMINED BY ENGINEER BASED ON AIRFLOW MEASURED PRIOR TO DEMOLITION.



Tracie L. Siebeneck - Engineer
MO# PE-2013019114

BID
DOCUMENTS

OFFICE OF ADMINISTRATION
DIVISION OF FACILITIES
MANAGEMENT,
DESIGN AND CONSTRUCTION

DEPARTMENT OF
PUBLIC SAFETY
STATE HIGHWAY PATROL

RENOVATE INTERIOR

GENERAL HEADQUARTERS
1510 EAST ELM STREET
JEFFERSON CITY, MO 65101

PROJECT # R2410-01
SITE # 6001
ASSET # 8136001001

REVISION: _____
DATE: _____
REVISION: _____
DATE: _____
REVISION: _____
DATE: _____
ISSUE DATE: 06/18/2026


CAD DWG FILE:M_R2410-01
DRAWN BY: TS/AH
CHECKED BY: TS
DESIGNED BY: TS/AH

SHEET TITLE:
PARTIAL
MECHANICAL PLAN
SECOND FLOOR


SHEET NUMBER:

M-106

32 OF 39 SHEETS
06/18/2026

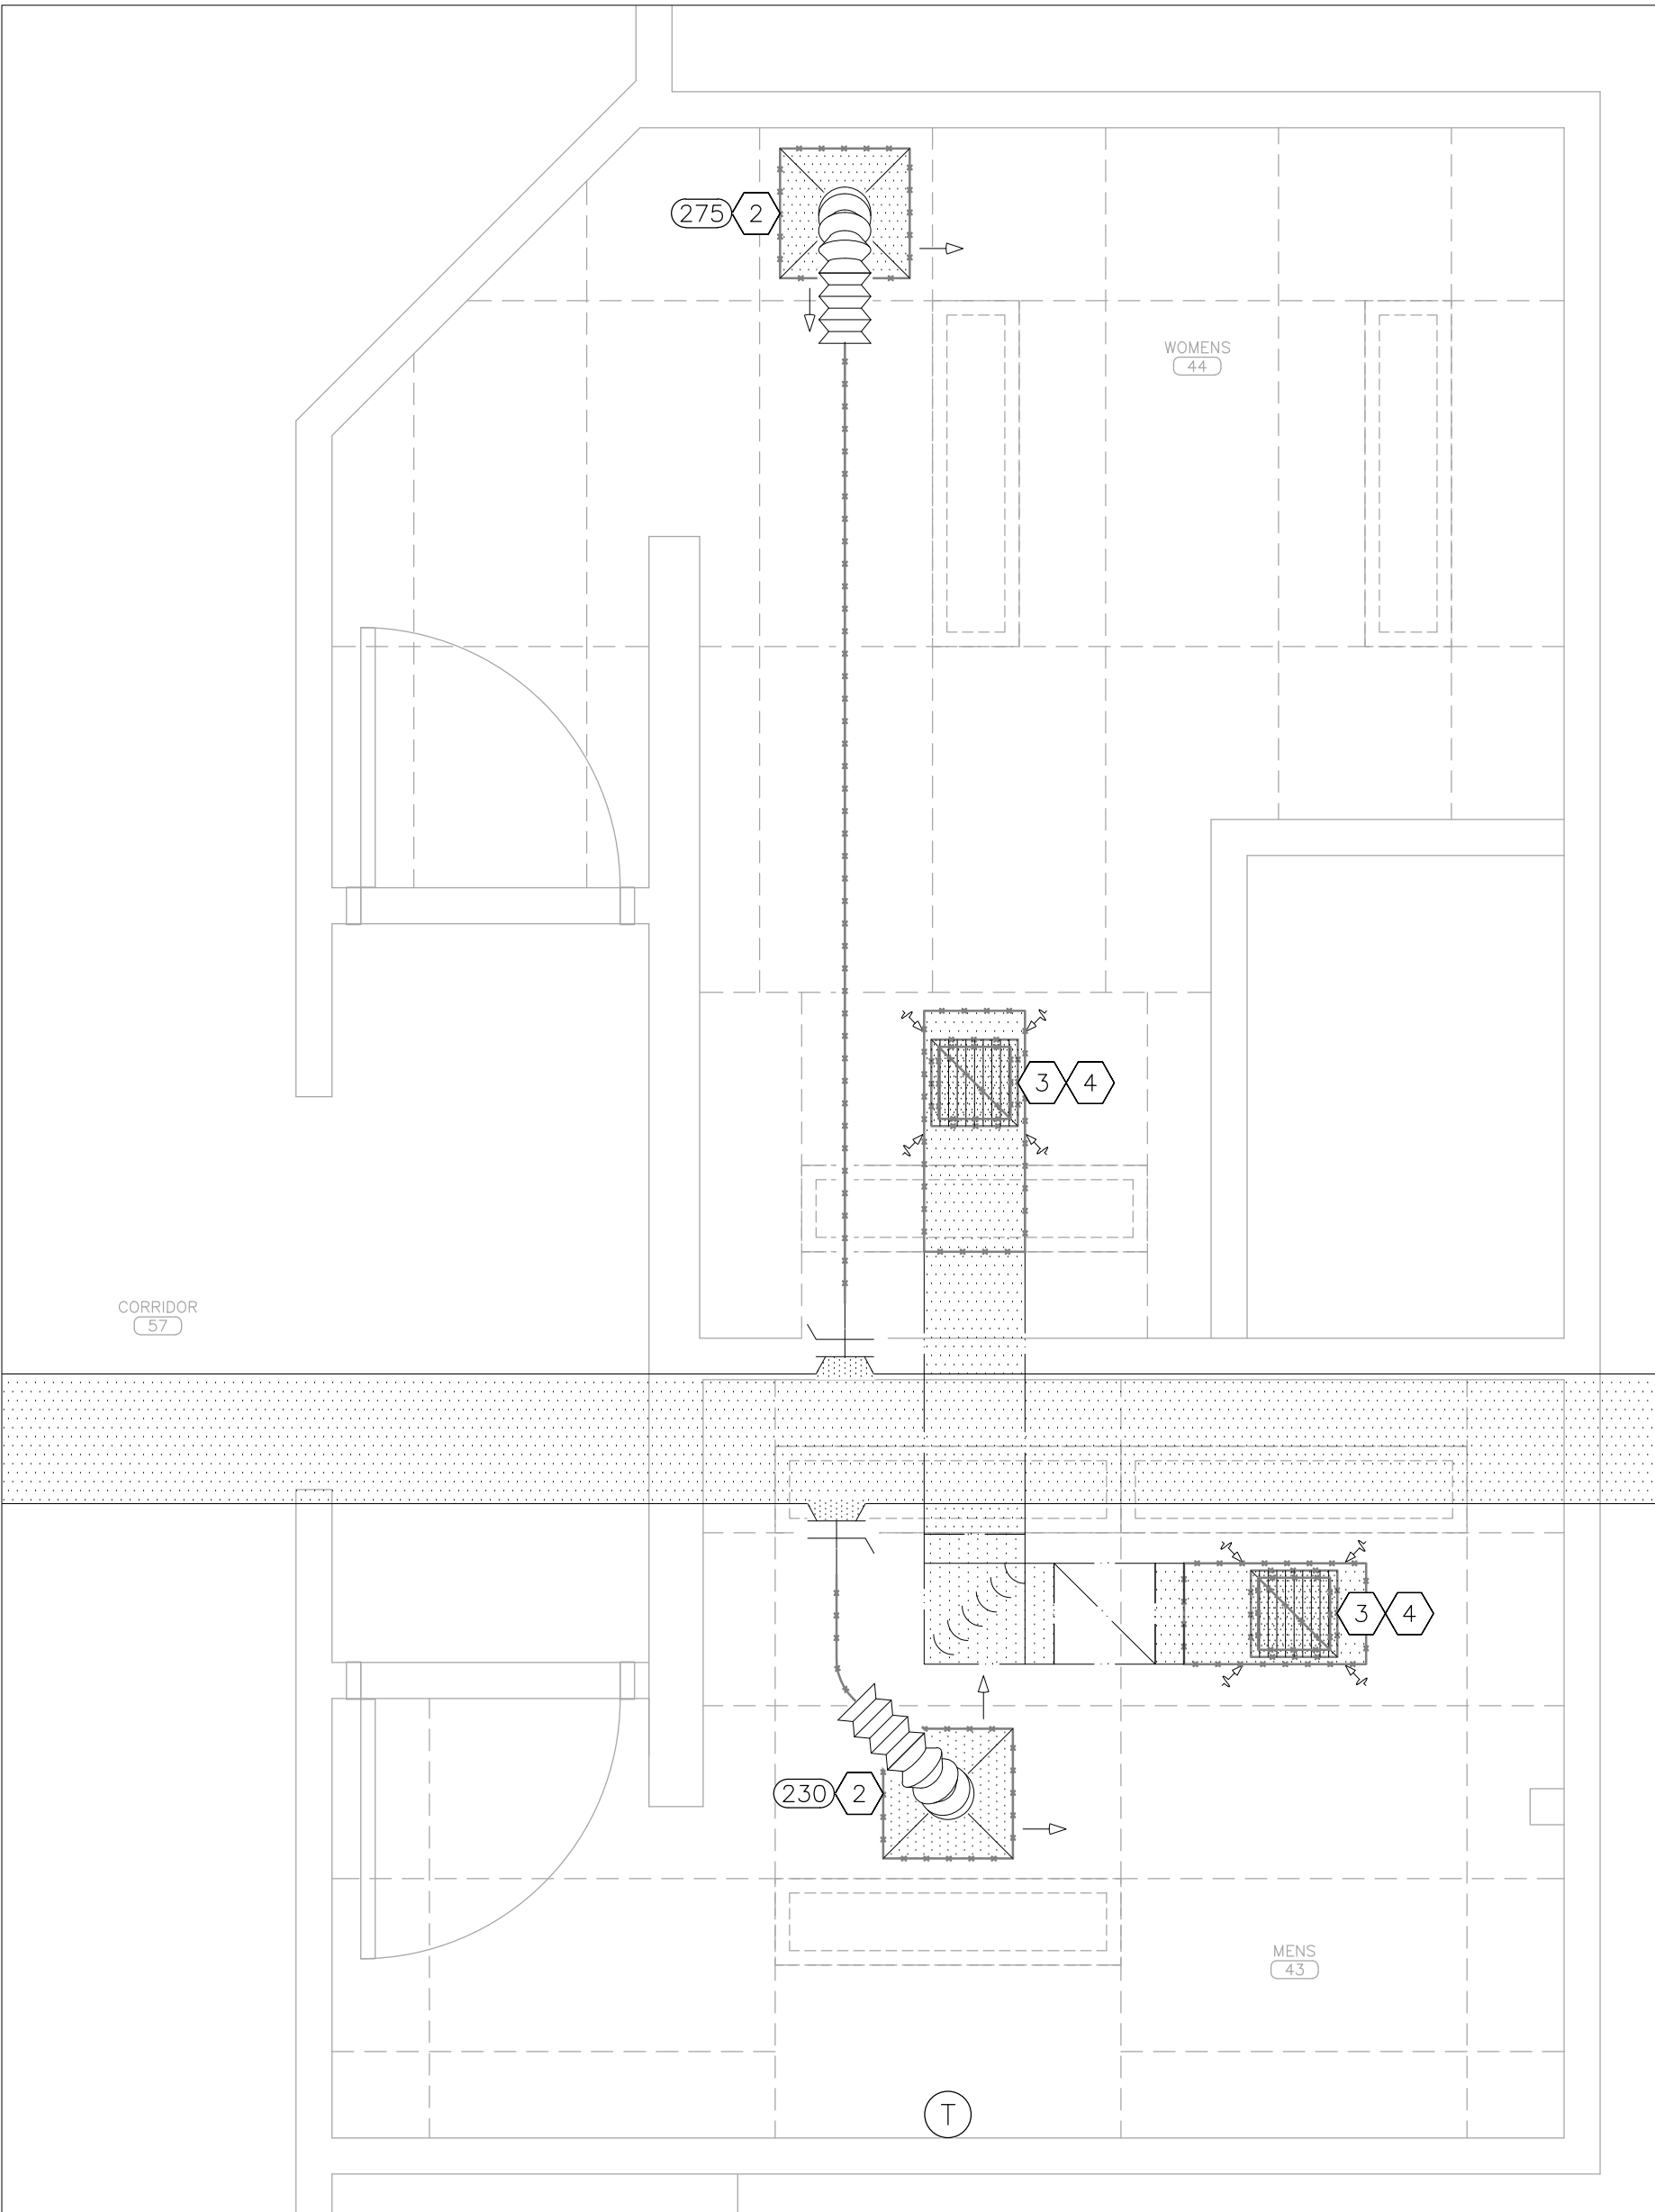


1 ALTERNATE NO. 2 – MECHANICAL DEMOLITION PLAN – PARTIAL SECOND FLOOR
SCALE: 1/2" = 1'-0"

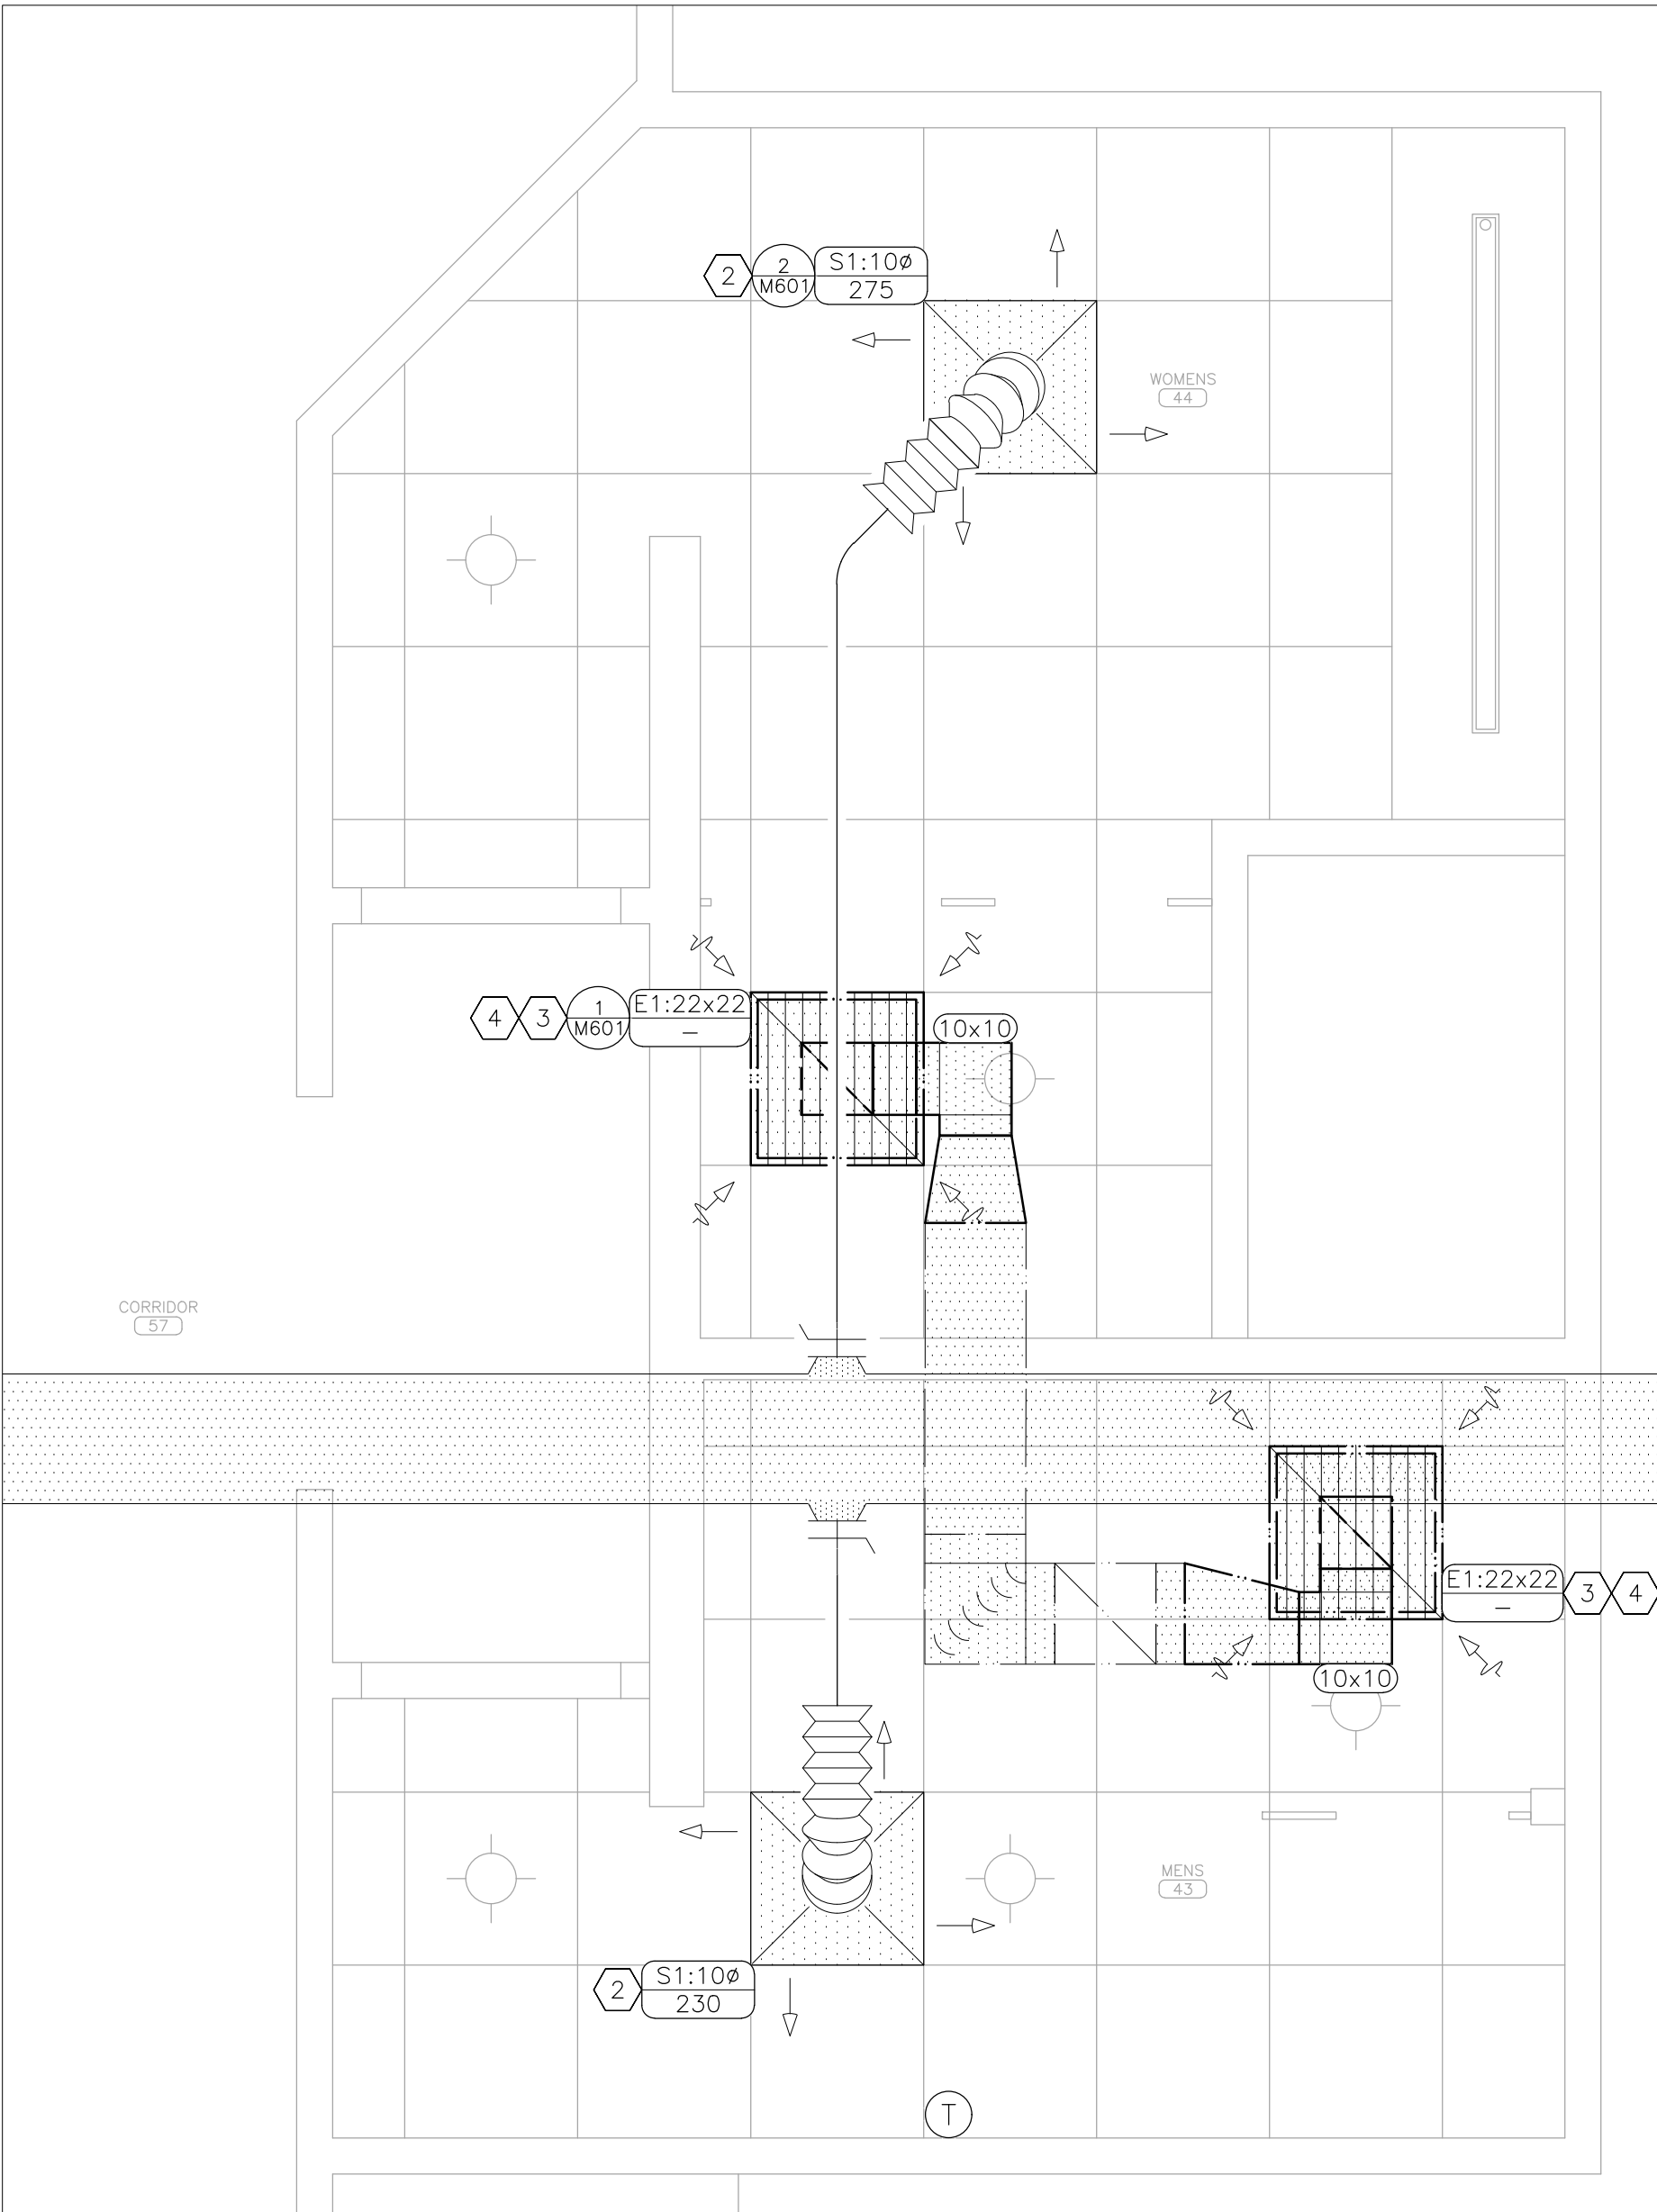

2 ALTERNATE NO. 2 – MECHANICAL RENOVATION PLAN – PARTIAL SECOND FLOOR
SCALE: 1/2" = 1'-0"

HVAC LEGEND	
	DETAIL REFERENCE, NUMBER/SHEET
	THERMOSTAT – WALL MOUNTED
	AIR DEVICE: NECK SIZE (INCHES)/CFM
	DUCT SIZE–RECTANGULAR (INCHES X INCHES)
	AIR FLOW (CUBIC FEET PER MINUTE)
	SUPPLY AIR – NEW
	SUPPLY AIR – EXISTING
	EXHAUST AIR – NEW
	EXHAUST AIR – EXISTING
	EXISTING MATERIALS TO BE REMOVED
	LIGHT FIXTURE – LINEAR/TROFFER
	LIGHT FIXTURE – DOWN LIGHT

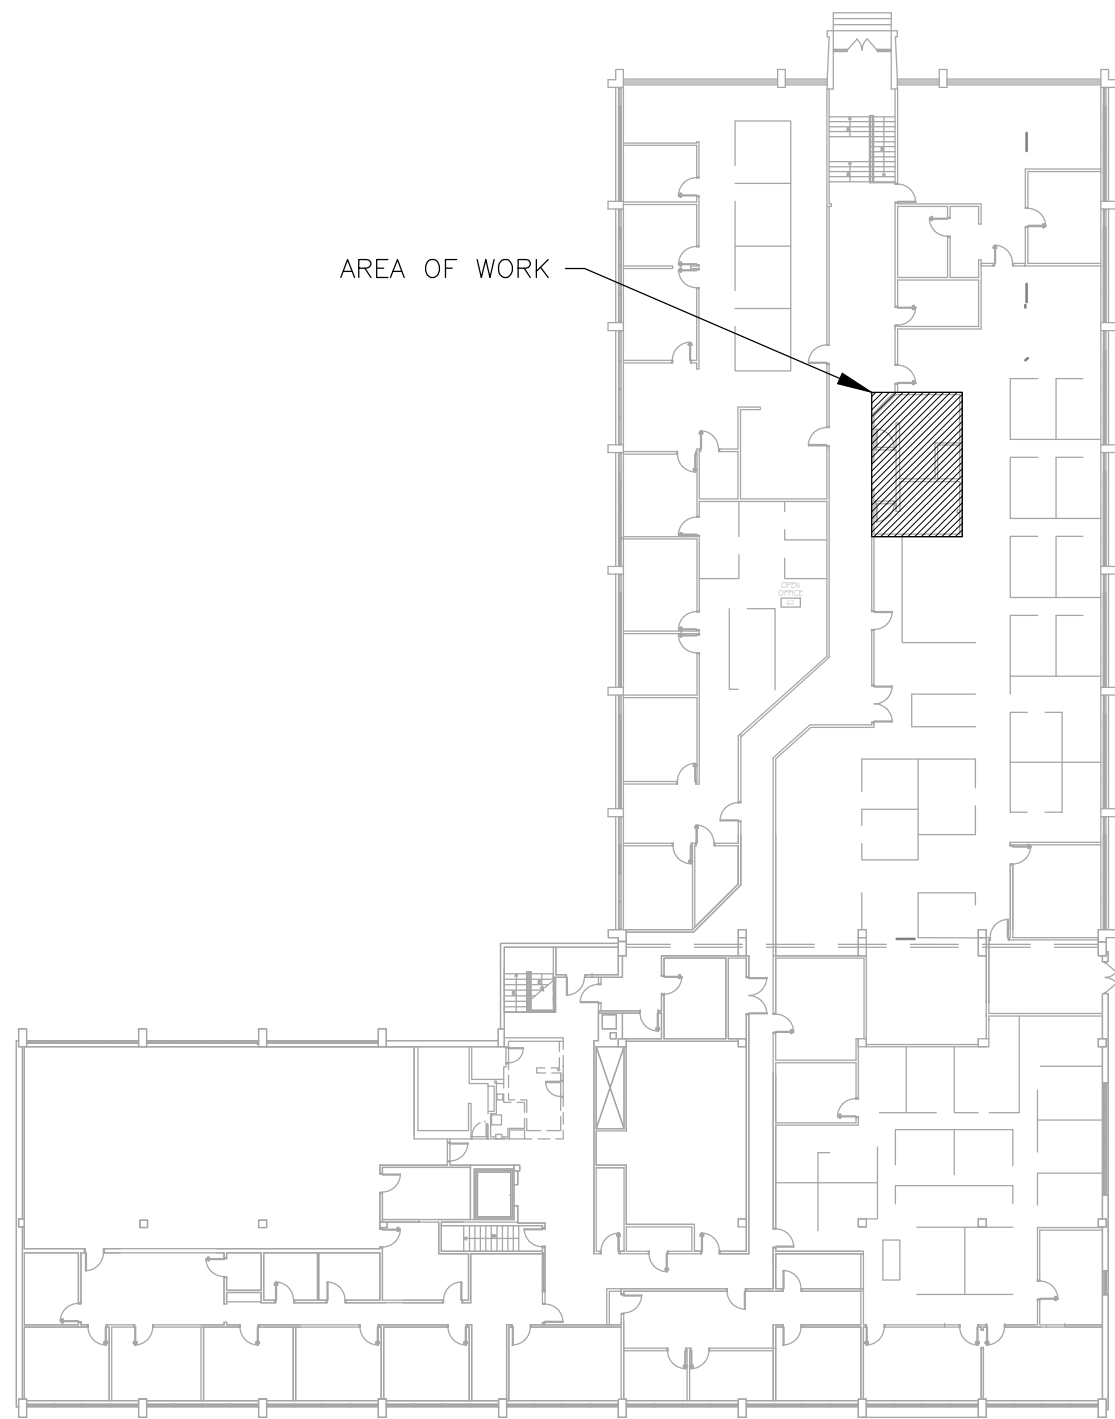

3 AREA MAP – SECOND FLOOR



Tracie L. Siebeneck - Engineer
MO# PE-2013019114

BID
DOCUMENTS

OFFICE OF ADMINISTRATION
DIVISION OF FACILITIES
MANAGEMENT,
DESIGN AND CONSTRUCTION

DEPARTMENT OF
PUBLIC SAFETY
STATE HIGHWAY PATROL

RENOVATE INTERIOR

GENERAL HEADQUARTERS
1510 EAST ELM STREET
JEFFERSON CITY, MO 65101

PROJECT # R2410-01
SITE # 6001
ASSET # 8136001001

REVISION: _____
DATE: _____
REVISION: _____
DATE: _____
REVISION: _____
DATE: _____

ISSUE DATE: 06/18/2026

CAD DWG FILE:M R2410-01
DRAWN BY: TS/AH
CHECKED BY: TS
DESIGNED BY: TS/AH

SHEET TITLE:



MECHANICAL
SCHEDULES
AND DETAILS


SHEET NUMBER:

M-601


33 OF 39 SHEETS
06/18/2026

AIR DEVICE SCHEDULE						
MARK	MANUFACTURER	MODEL	FACE SIZE (INCHxINCH)	TYPE	SPECIFICATION	NOTES
S1	PRICE	SPD	24x24	SUPPLY LAY-IN MOUNT PLAQUE	MATERIAL: STEEL; FINISH: WHITE; FACE: REMOVABLE SMOOTH FACED PLAQUE	
S2	PRICE	SPD	12x12	SUPPLY LAY-IN MOUNT PLAQUE	MATERIAL: STEEL; FINISH: WHITE; FACE: REMOVABLE SMOOTH FACED PLAQUE	
S3	PRICE	SMD	12x12	SUPPLY SURFACE MOUNT LOUVERED	MATERIAL: STEEL; FINISH: WHITE; CORE: "2G", TWO WAY THROW; FRAME: SURFACE MOUNT TYPE 6 BEVELLED	1
E1	PRICE	PDDR	24x24	EXHAUST LAY-IN MOUNT PERFORATED FACE	MATERIAL: STEEL; FINISH: WHITE	2
E2	PRICE	PDDR	12x12	EXHAUST LAY-IN MOUNT PERFORATED FACE	MATERIAL: STEEL; FINISH: WHITE	2
E3	PRICE	535	SEE PLANS	EXHAUST SURFACE MOUNT LOUVERED GRILLE	MATERIAL: STEEL; FINISH: WHITE; BLADES: SINGLE 45° DEFLECTION W/ 1/2 INCH BLADE SPACING; DAMPER: INTEGRAL	2
BD-1	POTTORFF	CD-10R	SEE PLANS	ROUND MANUAL CONTROL DAMPER SINGLE BLADE	FRAME: 6"x22 GAUGE GALVANIZED STEEL; BLADES: 22 GAUGE GALVANIZED STEEL ROUND; AXLES: 3/4" SQUARE PLATED STEEL; BEARINGS: SYNTHETIC; CONTROL SHAFT: 3/8"x3" SQUARE DRIVE AXLE WITH MANUAL FACTORY INSTALLED LOCKING QUADRANT.	3
NOTES						
1	PROVIDE SQUARE TO ROUND ADAPTOR WITH FACE OPERABLE STEEL DAMPER MODEL SR3L					
2	PROVIDE INTEGRAL OPPOSED BLADE BALANCE DAMPER MODEL VCS3					
3	PROVIDE 1-1/2" QUADRANT STANDOFF BRACKET FOR INSULATED DUCT					

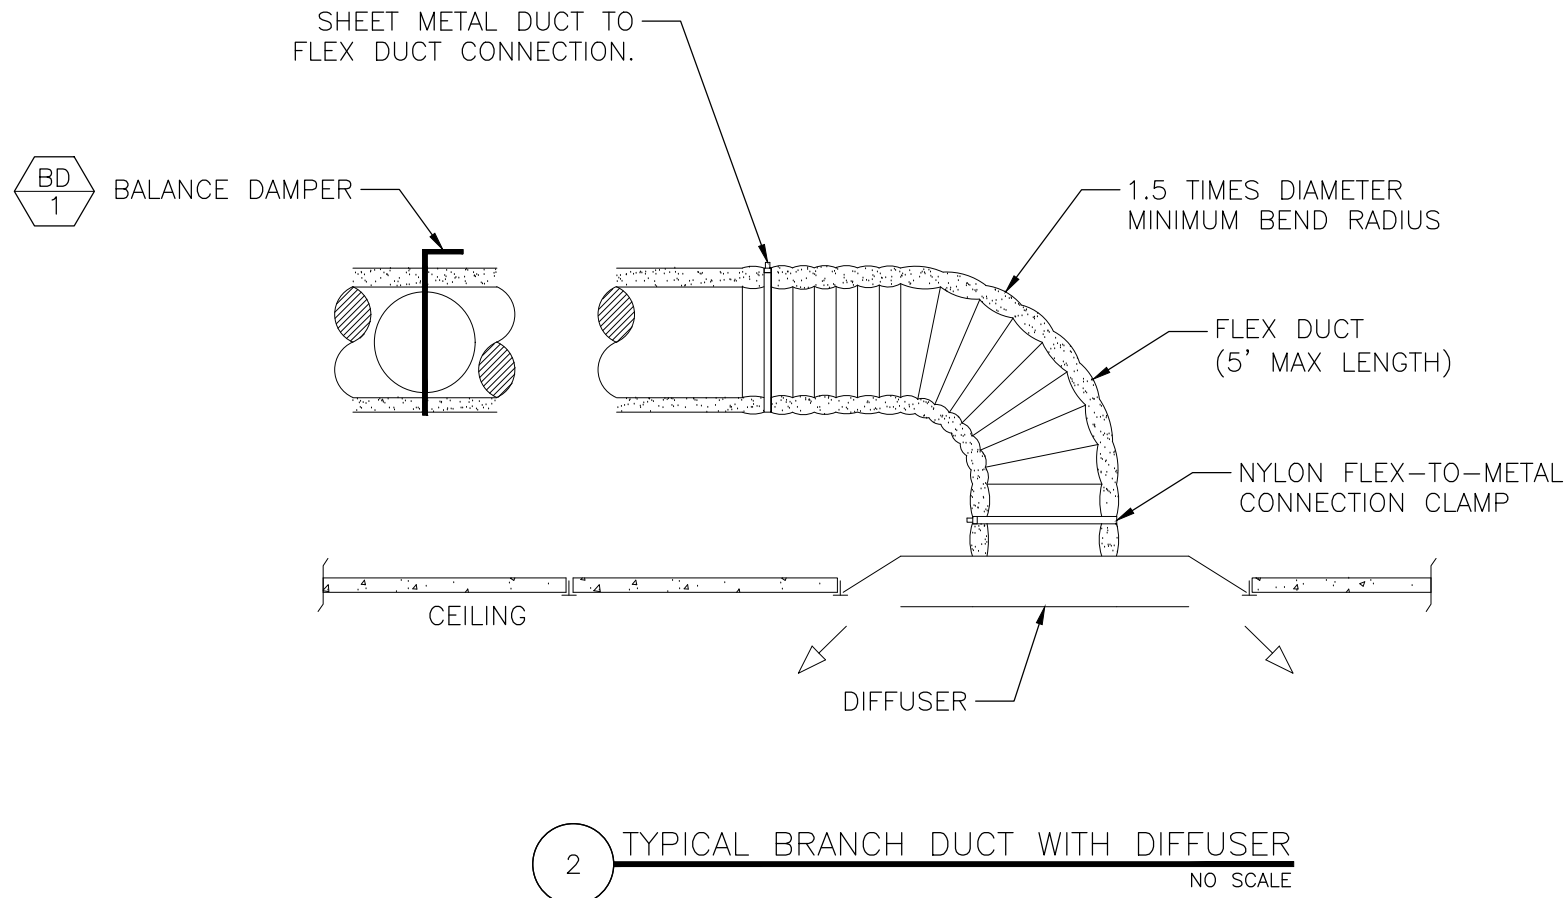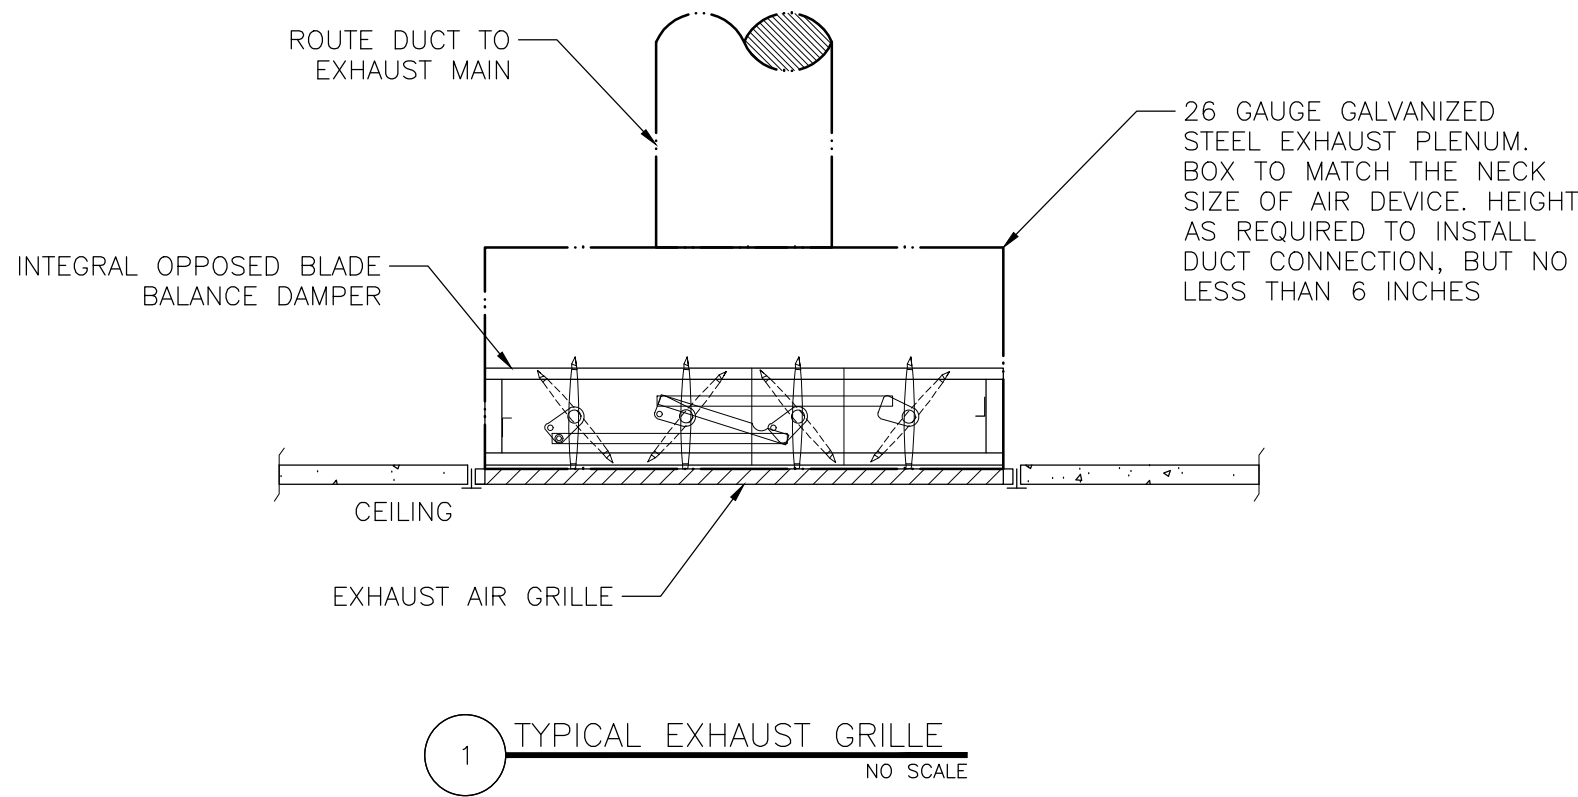

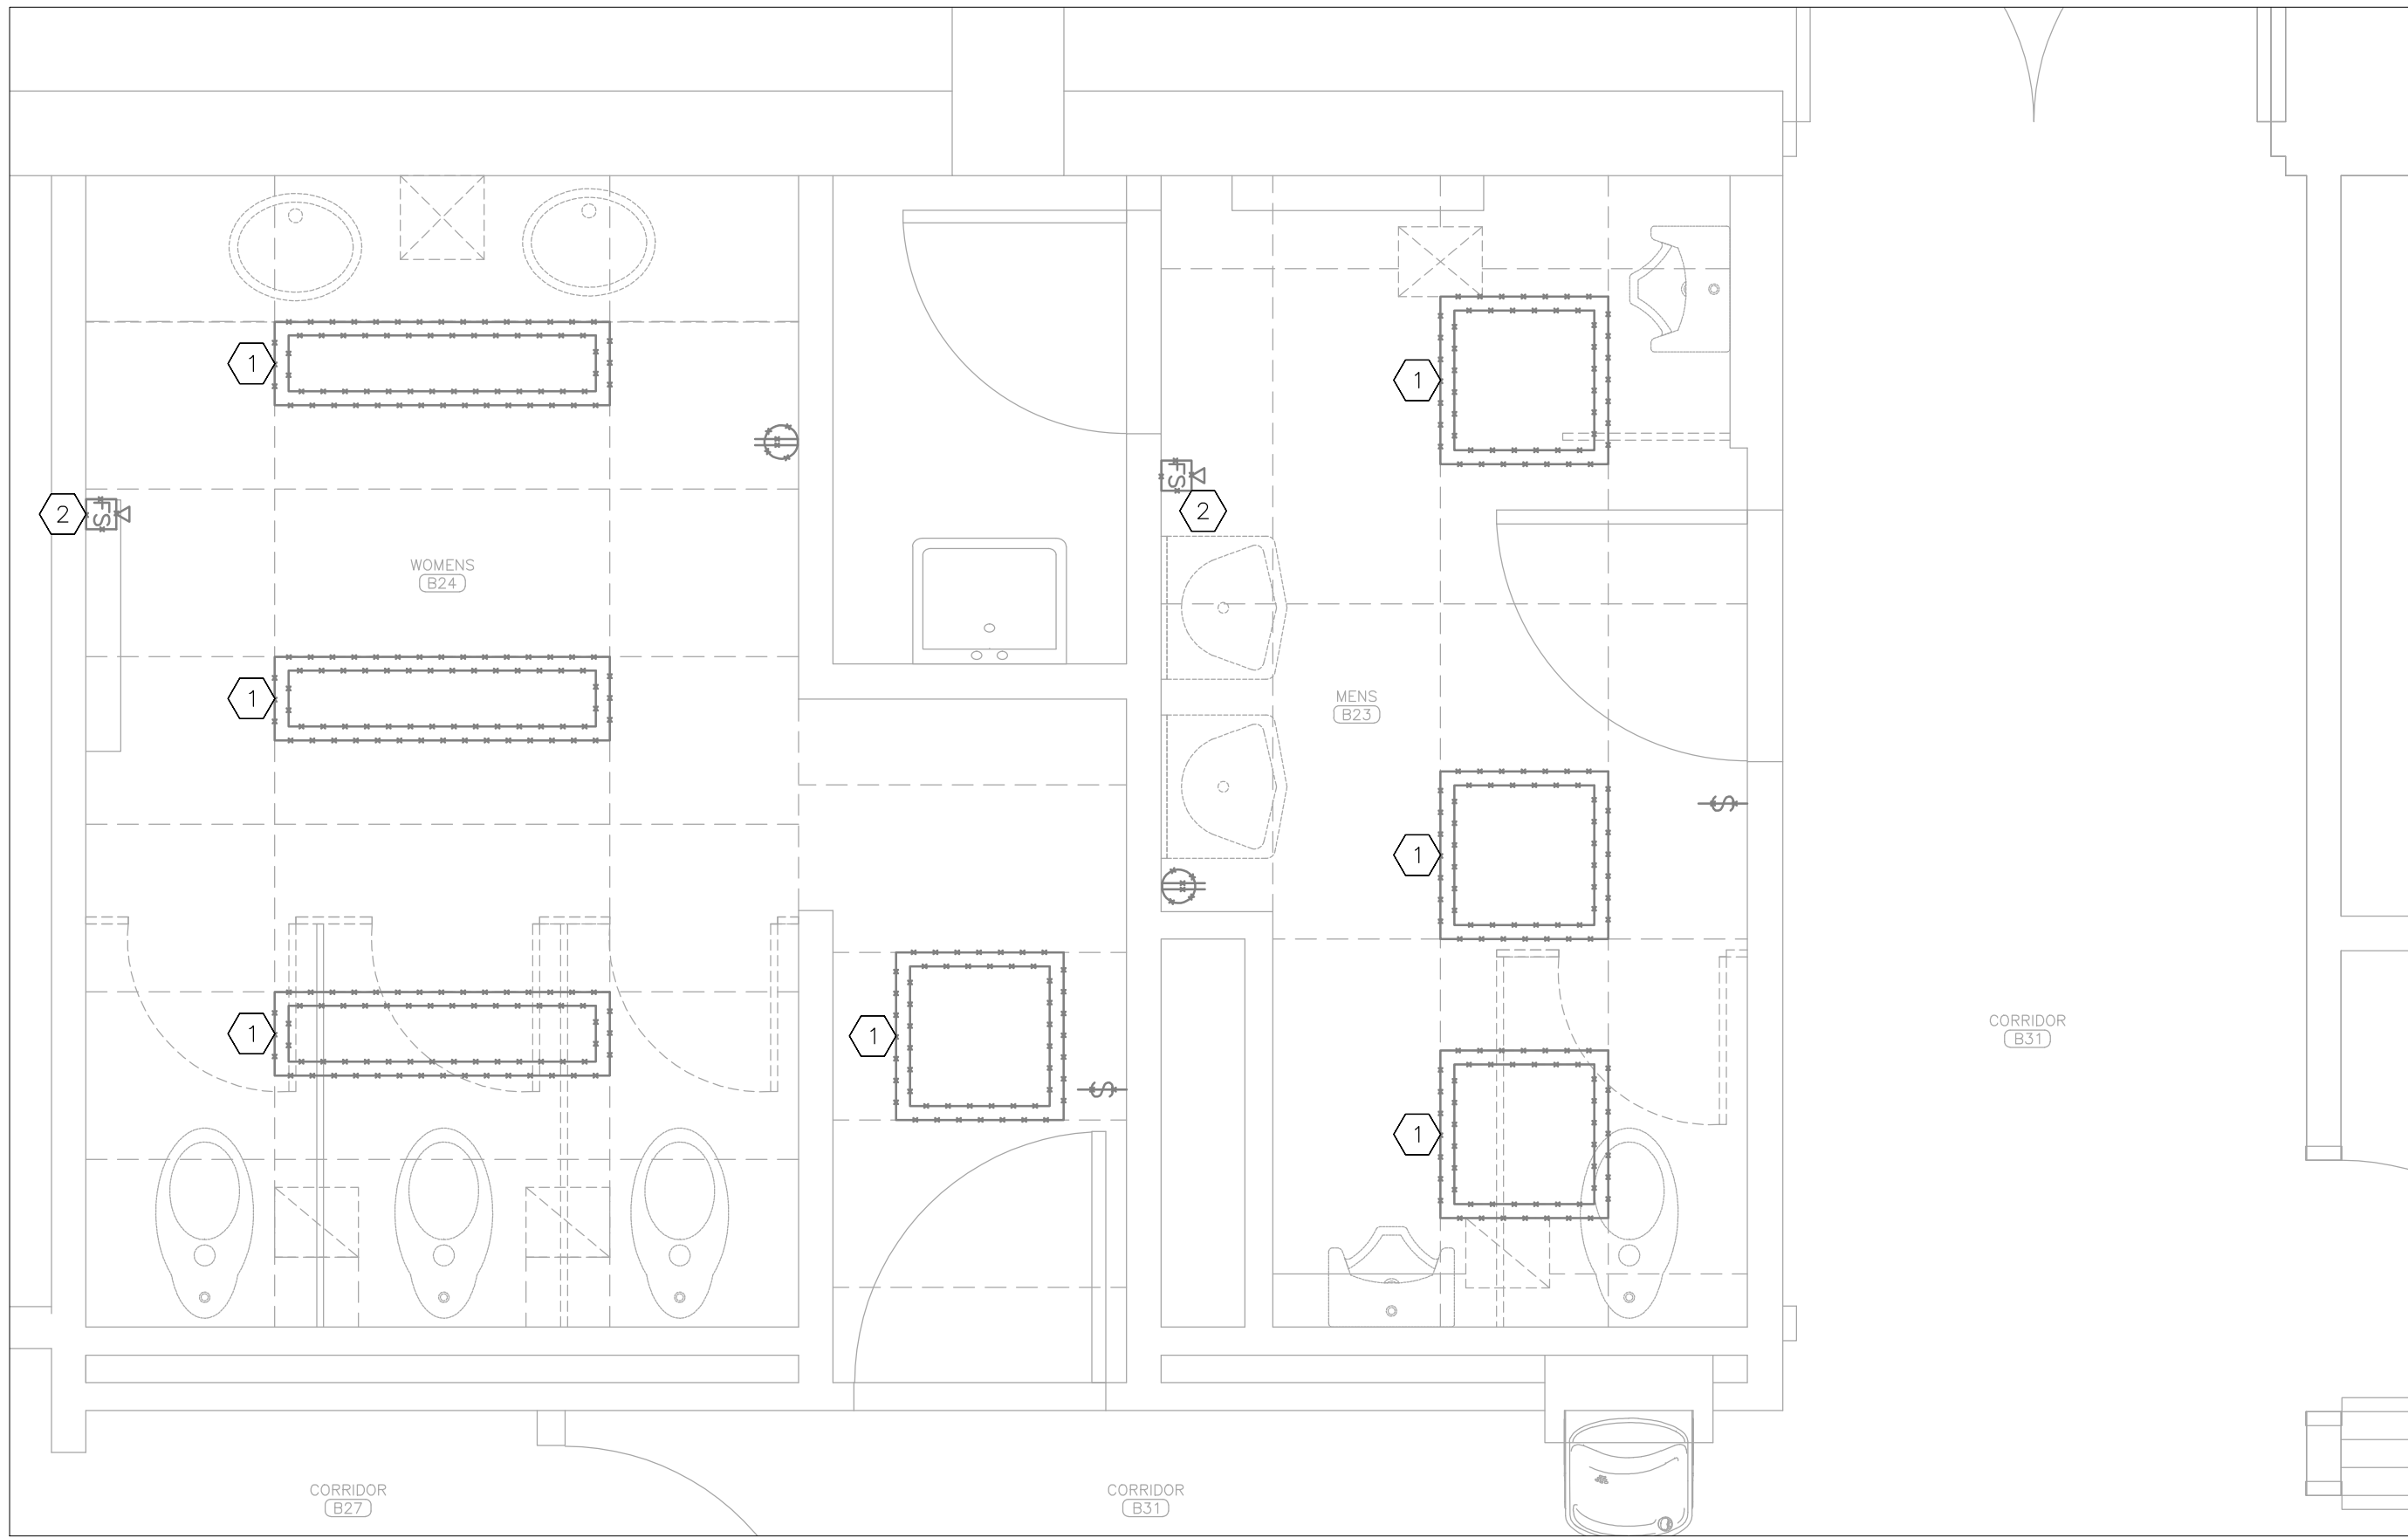

1 ALTERNATE NO. 1 – ELECTRICAL DEMOLITION PLAN – BASEMENT
SCALE: 1/2" = 1'-0"

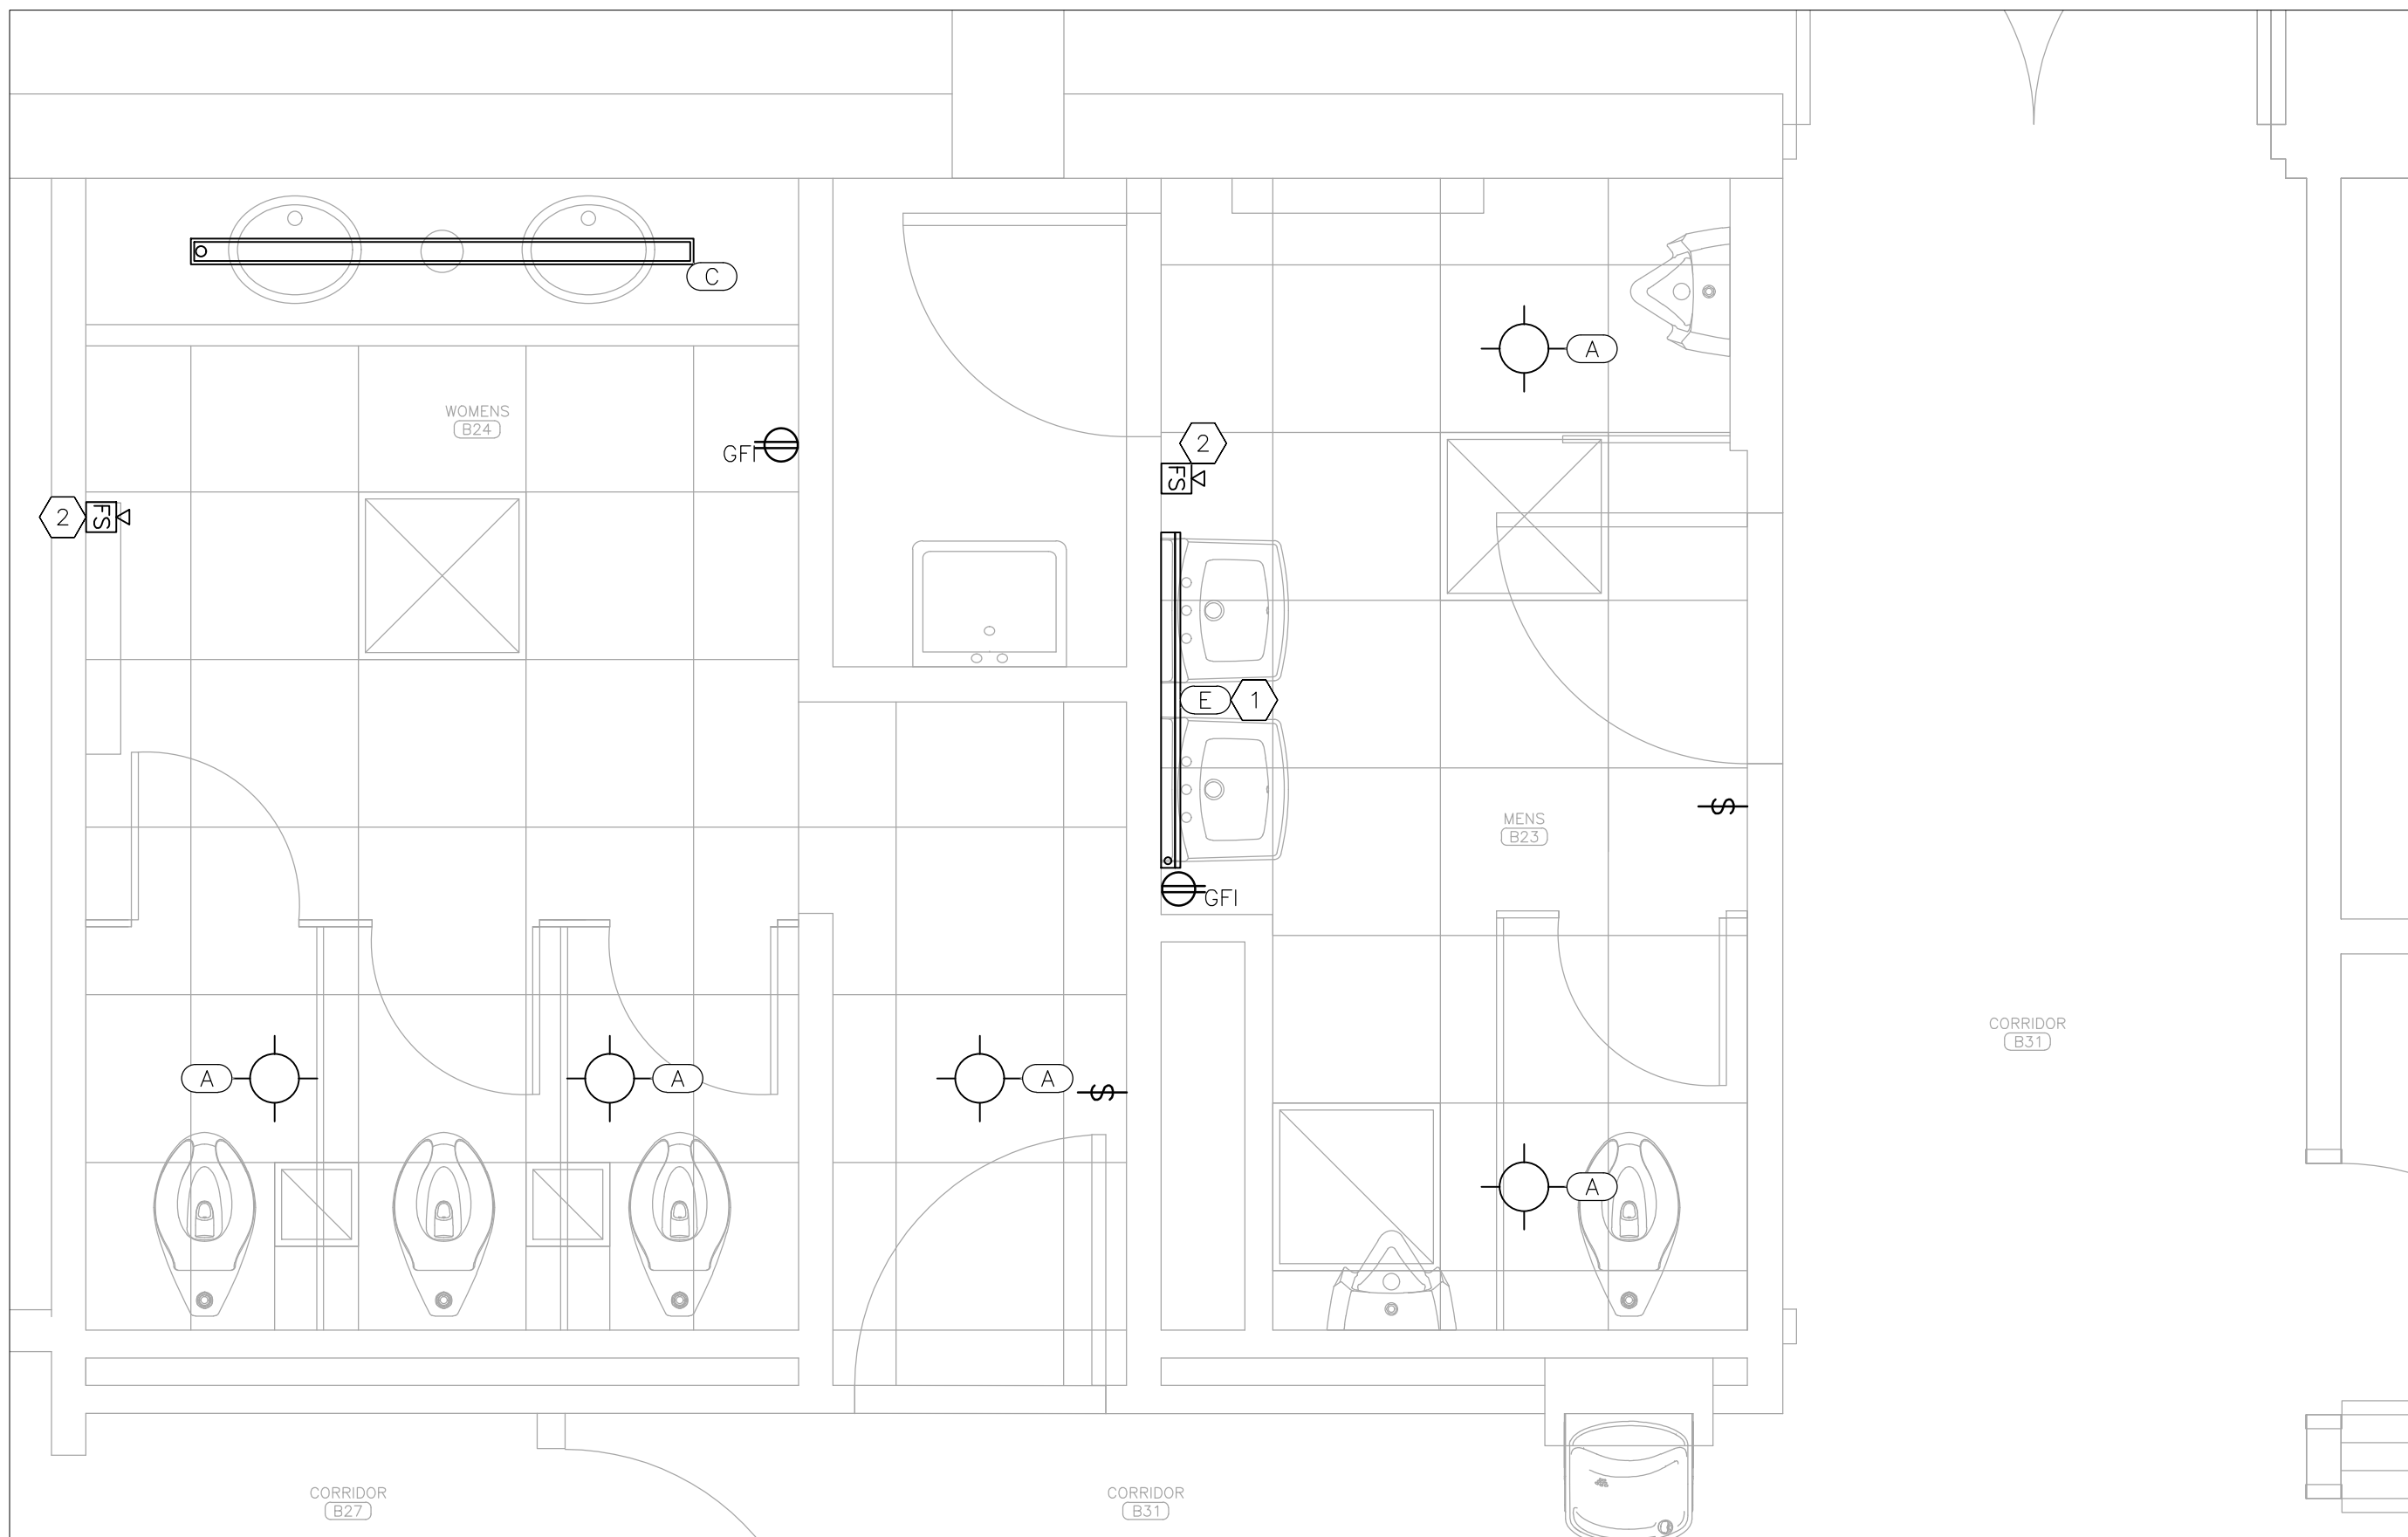

2 ALTERNATE NO. 1 – ELECTRICAL RENOVATION PLAN – BASEMENT
SCALE: 1/2" = 1'-0"

GENERAL DEMOLITION NOTES

- 1 REFER TO SHEET G-002 FOR GENERAL CONSTRUCTION NOTES.
- 2 CONTRACTOR MAY REUSE CONDUIT AND CONDUCTORS INSTALLED PER THE NATIONAL ELECTRIC CODE (NEC). CONTRACTOR SHALL DEMOLISH ANY UNUSED CONDUIT AND CONDUCTORS.
- 3 UNLESS OTHERWISE NOTED, DEMOLISH ALL RECEPTACLES, WALL SWITCHES, AND WALL PLATES LOCATED IN RESTROOMS. DEVICE BOX, CONDUIT AND CONDUCTORS TO REMAIN FOR USE IN NEW CONSTRUCTION.

GENERAL RENOVATION NOTES

- 1 FABRICATION, INSTALLATION, AND TESTING OF ALL SYSTEMS SHALL BE IN ACCORDANCE WITH ALL MANUFACTURER INSTALLATION GUIDELINES. REFER TO SHEET G-002 FOR APPLICABLE CODES AND STANDARDS.
- 2 ELECTRICAL CONTRACTOR SHALL BE RESPONSIBLE FOR PROVIDING ALL MATERIALS REQUIRED TO COMPLETE THE WORK. ALL LINE VOLTAGE WIRING SHALL BE PULLED IN PROPERLY SIZED CONDUIT WITH APPROVED FITTINGS. SURFACE RACEWAYS SHALL BE PROVIDED FOR INSTALLATION ON EXISTING WALLS.
- 3 WALL SWITCHES SHALL CONTROL ALL LIGHT FIXTURES LOCATED WITHIN THE ROOM.
- 4 CONTRACTOR SHALL PROVIDE COMPLETE AS-BUILT PLANS WITH NEW CIRCUITS LABELED AND GENERAL ROUTING SHOWN.
- 5 UNLESS OTHERWISE NOTED, PROVIDE NEW RECEPTACLES, WALL SWITCHES, AND WALL PLATES LOCATED IN RESTROOMS.

ALTERNATE NO. 1

DEMOLITION NOTES – DETAIL 1

INDICATES KEYED NOTES

- 1 DEMOLISH LIGHT FIXTURE. DEMOLISH ASSOCIATED CONDUIT AND CONDUCTORS TO NEAREST JUNCTION BOX FOR USE IN NEW CONSTRUCTION.
- 2 REMOVE AND RETAIN WALL MOUNTED FIRE STROBE. DEMOLISH SURFACE MOUNT JUNCTION BOX AND ASSOCIATED SURFACE MOUNT RACEWAY. DEMOLISH CONDUCTORS TO ABOVE CEILING FOR USE IN NEW CONSTRUCTION.


RENOVATION NOTES – DETAIL 2

INDICATES KEYED NOTES

- 1 PROVIDE AND INSTALL WALL MOUNTED LIGHT FIXTURE ON EXISTING WALL. EXTEND CONDUIT AND CONDUCTORS FROM ROOM LIGHTING CIRCUIT TO LIGHT FIXTURE. REFER TO ARCHITECTURAL ELEVATIONS FOR FINAL LOCATION.
- 2 INSTALL RETAINED WALL MOUNT FIRE STROBE. PROVIDE NEW SURFACE RACEWAY AND JUNCTION BOX.

ELECTRICAL LEGEND

AA	LIGHT FIXTURE MARK
GFI	RECEPTACLE – TYPE: DUPLEX – GROUND FAULT INTERRUPTING
	RECEPTACLE – TYPE: DUPLEX
	BLANK WALL PLATE
\$	WALL SWITCH
FS	FIRE ALARM STROBE – WALL MOUNTED
	ELECTRICAL DEVICE – NEW
	ELECTRICAL DEVICE – EXISTING
	LIGHT FIXTURE – NEW
	EXISTING MATERIALS TO BE REMOVED
	SUPPLY AIR GRILLE
	EXHAUST AIR GRILLE

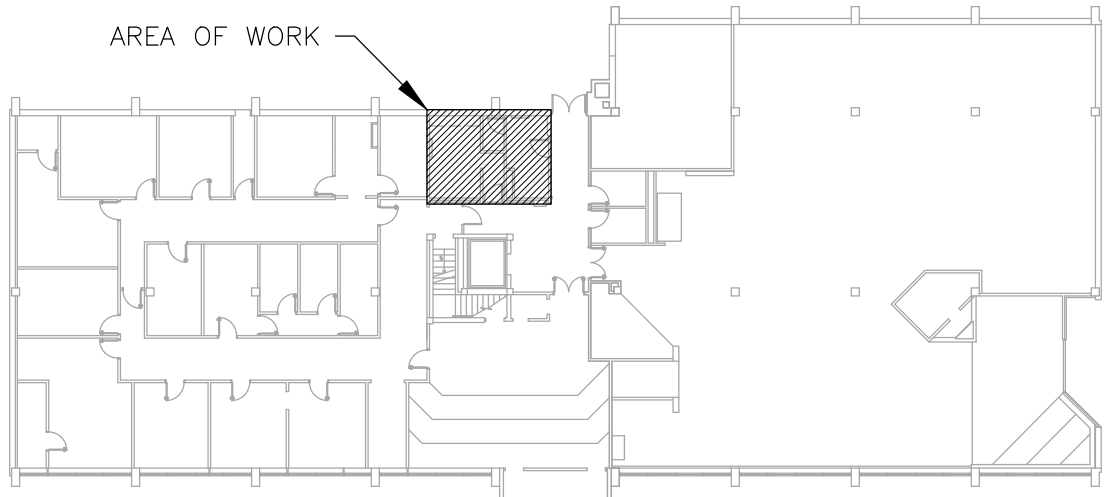

3 AREA MAP – BASEMENT

STATE OF MISSOURI
MIKE KEHOE,
GOVERNOR



Tracie L. Siebeneck - Engineer
MO# PE-2013019114

BID DOCUMENTS

OFFICE OF ADMINISTRATION
DIVISION OF FACILITIES
MANAGEMENT,
DESIGN AND CONSTRUCTION

DEPARTMENT OF
PUBLIC SAFETY
STATE HIGHWAY PATROL

RENOVATE INTERIOR

GENERAL HEADQUARTERS
1510 EAST ELM STREET
JEFFERSON CITY, MO 65101

PROJECT # R2410-01
SITE # 6001
ASSET # 8136001001

REVISION: _____
DATE: _____
REVISION: _____
DATE: _____
REVISION: _____
DATE: _____
ISSUE DATE: 06/18/2026


CAD DWG FILE: E_R2410-01
DRAWN BY: TS/AH
CHECKED BY: TS
DESIGNED BY: TS/AH

SHEET TITLE:
ELECTRICAL PLAN
BASEMENT


SHEET NUMBER:

E-101

34 OF 39 SHEETS
06/18/2026

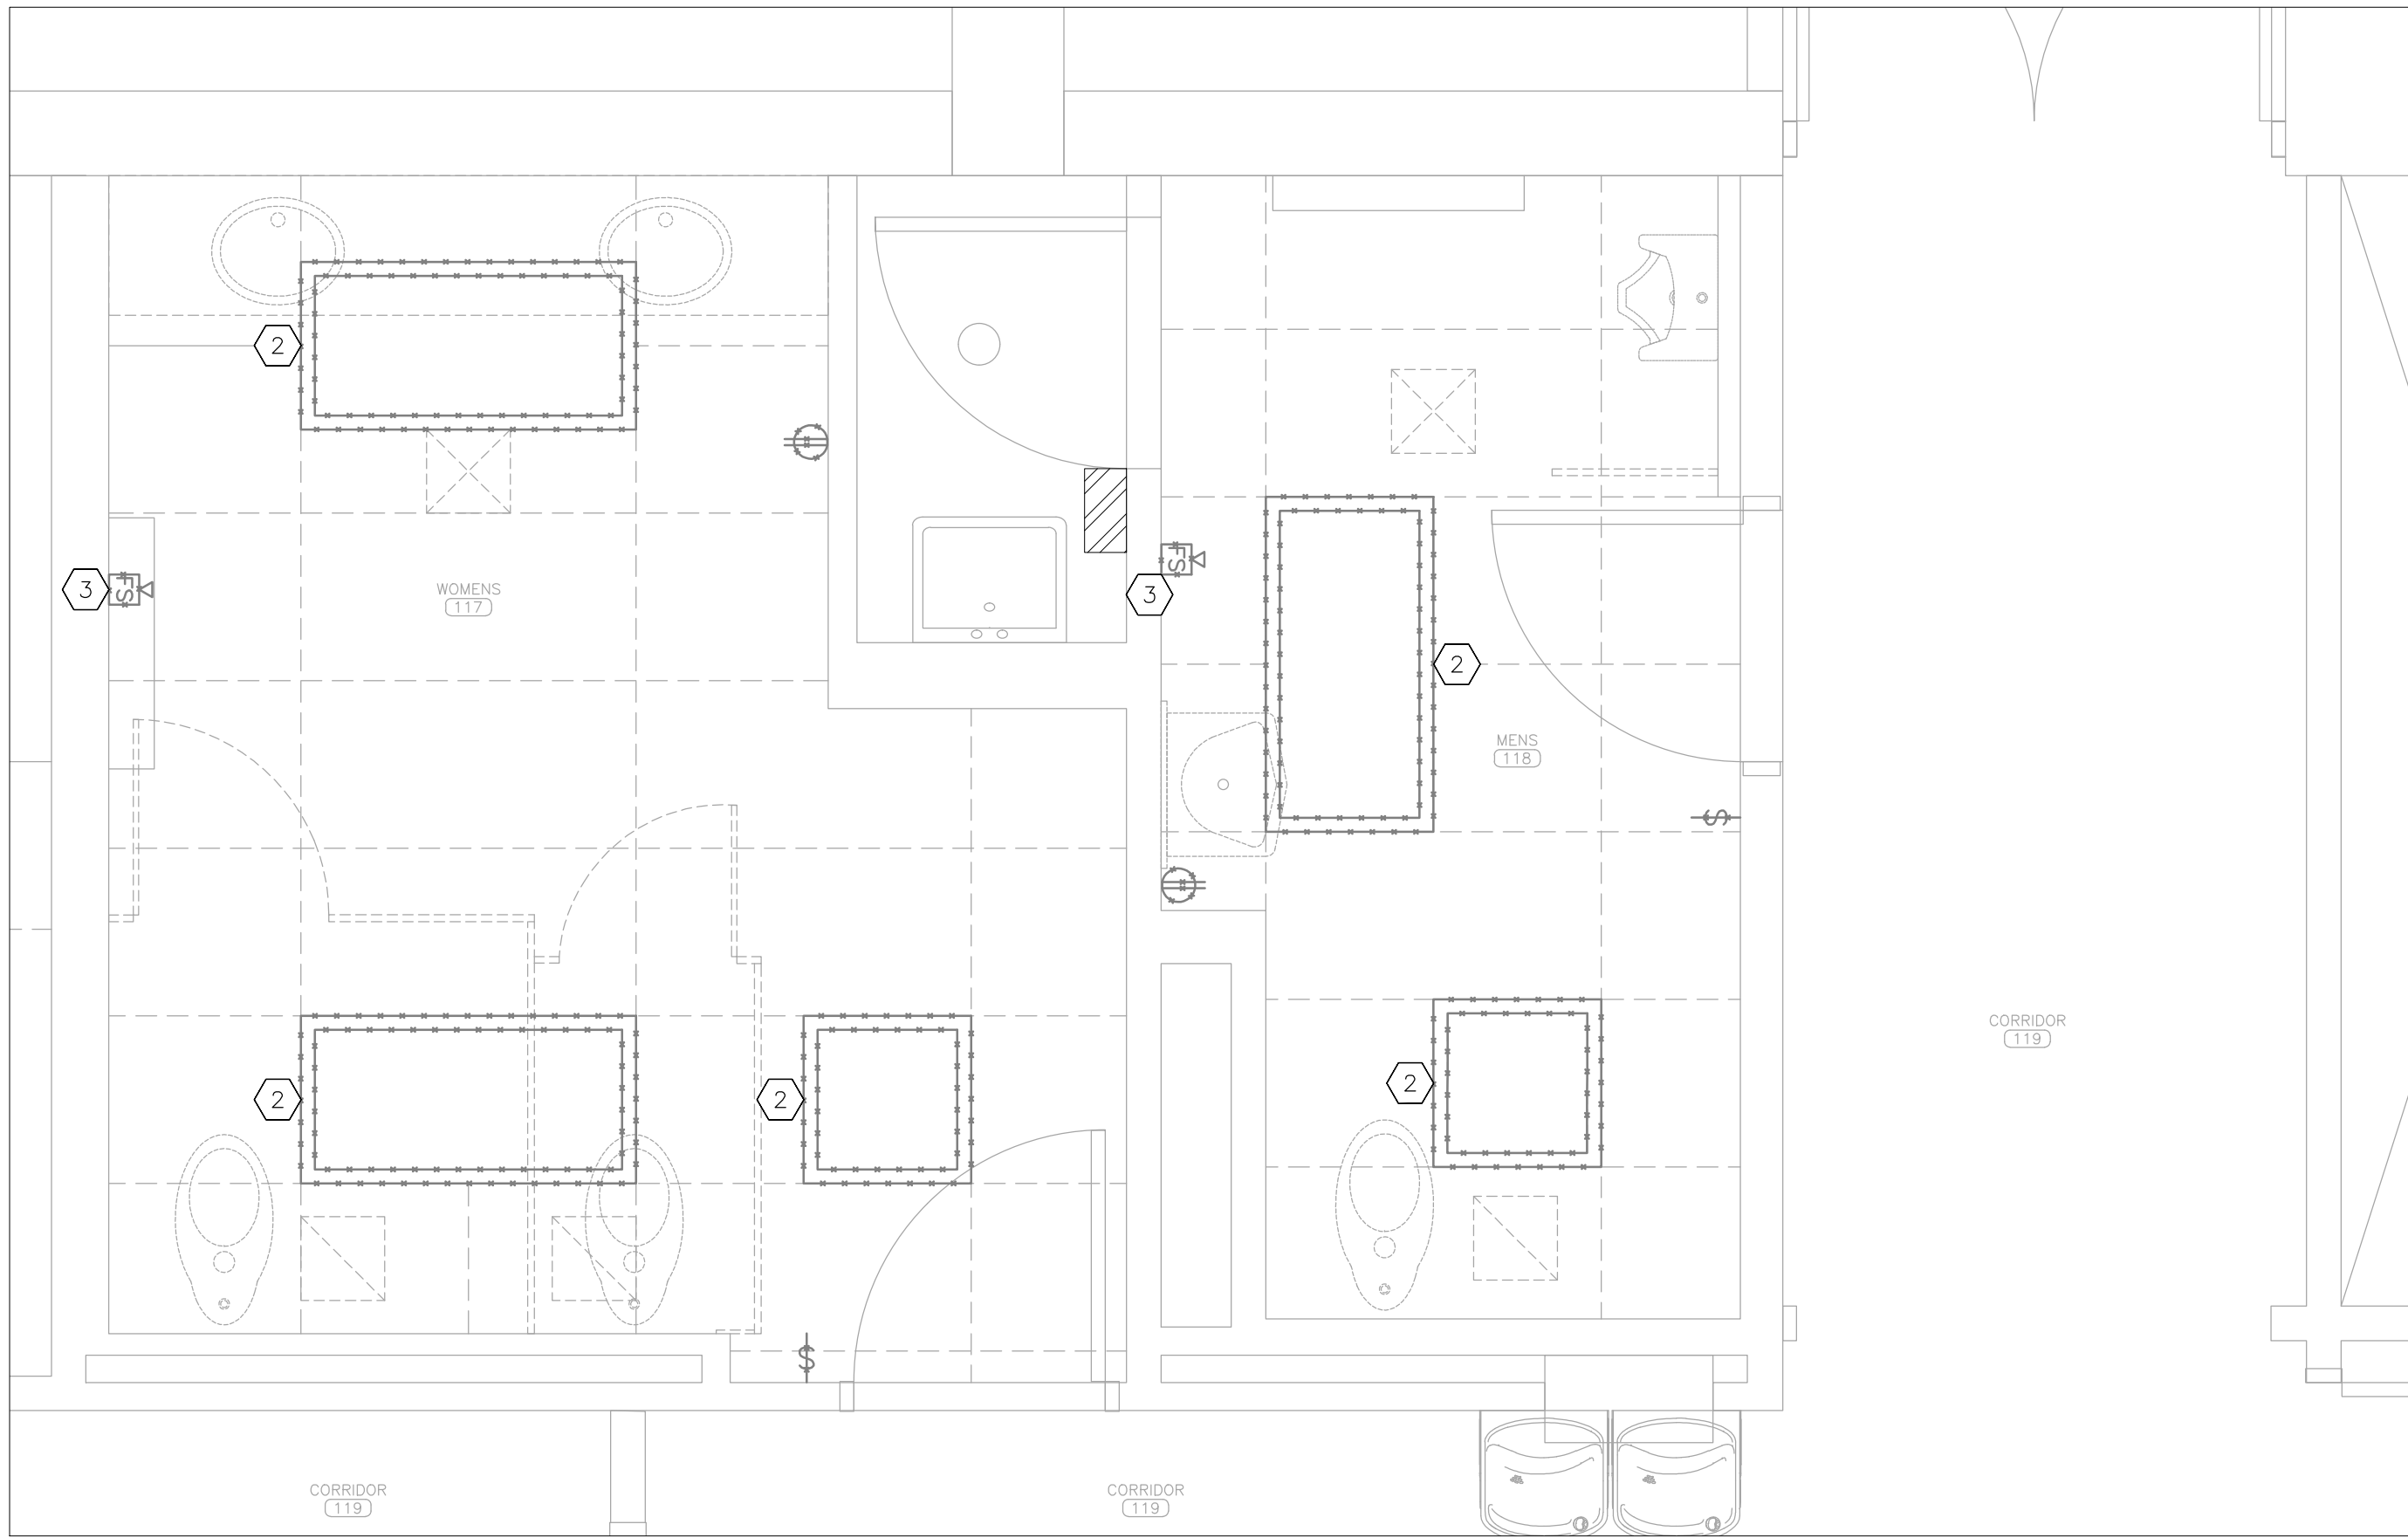

1 ELECTRICAL DEMOLITION PLAN – PARTIAL FIRST FLOOR
SCALE: 1/2" = 1'-0"

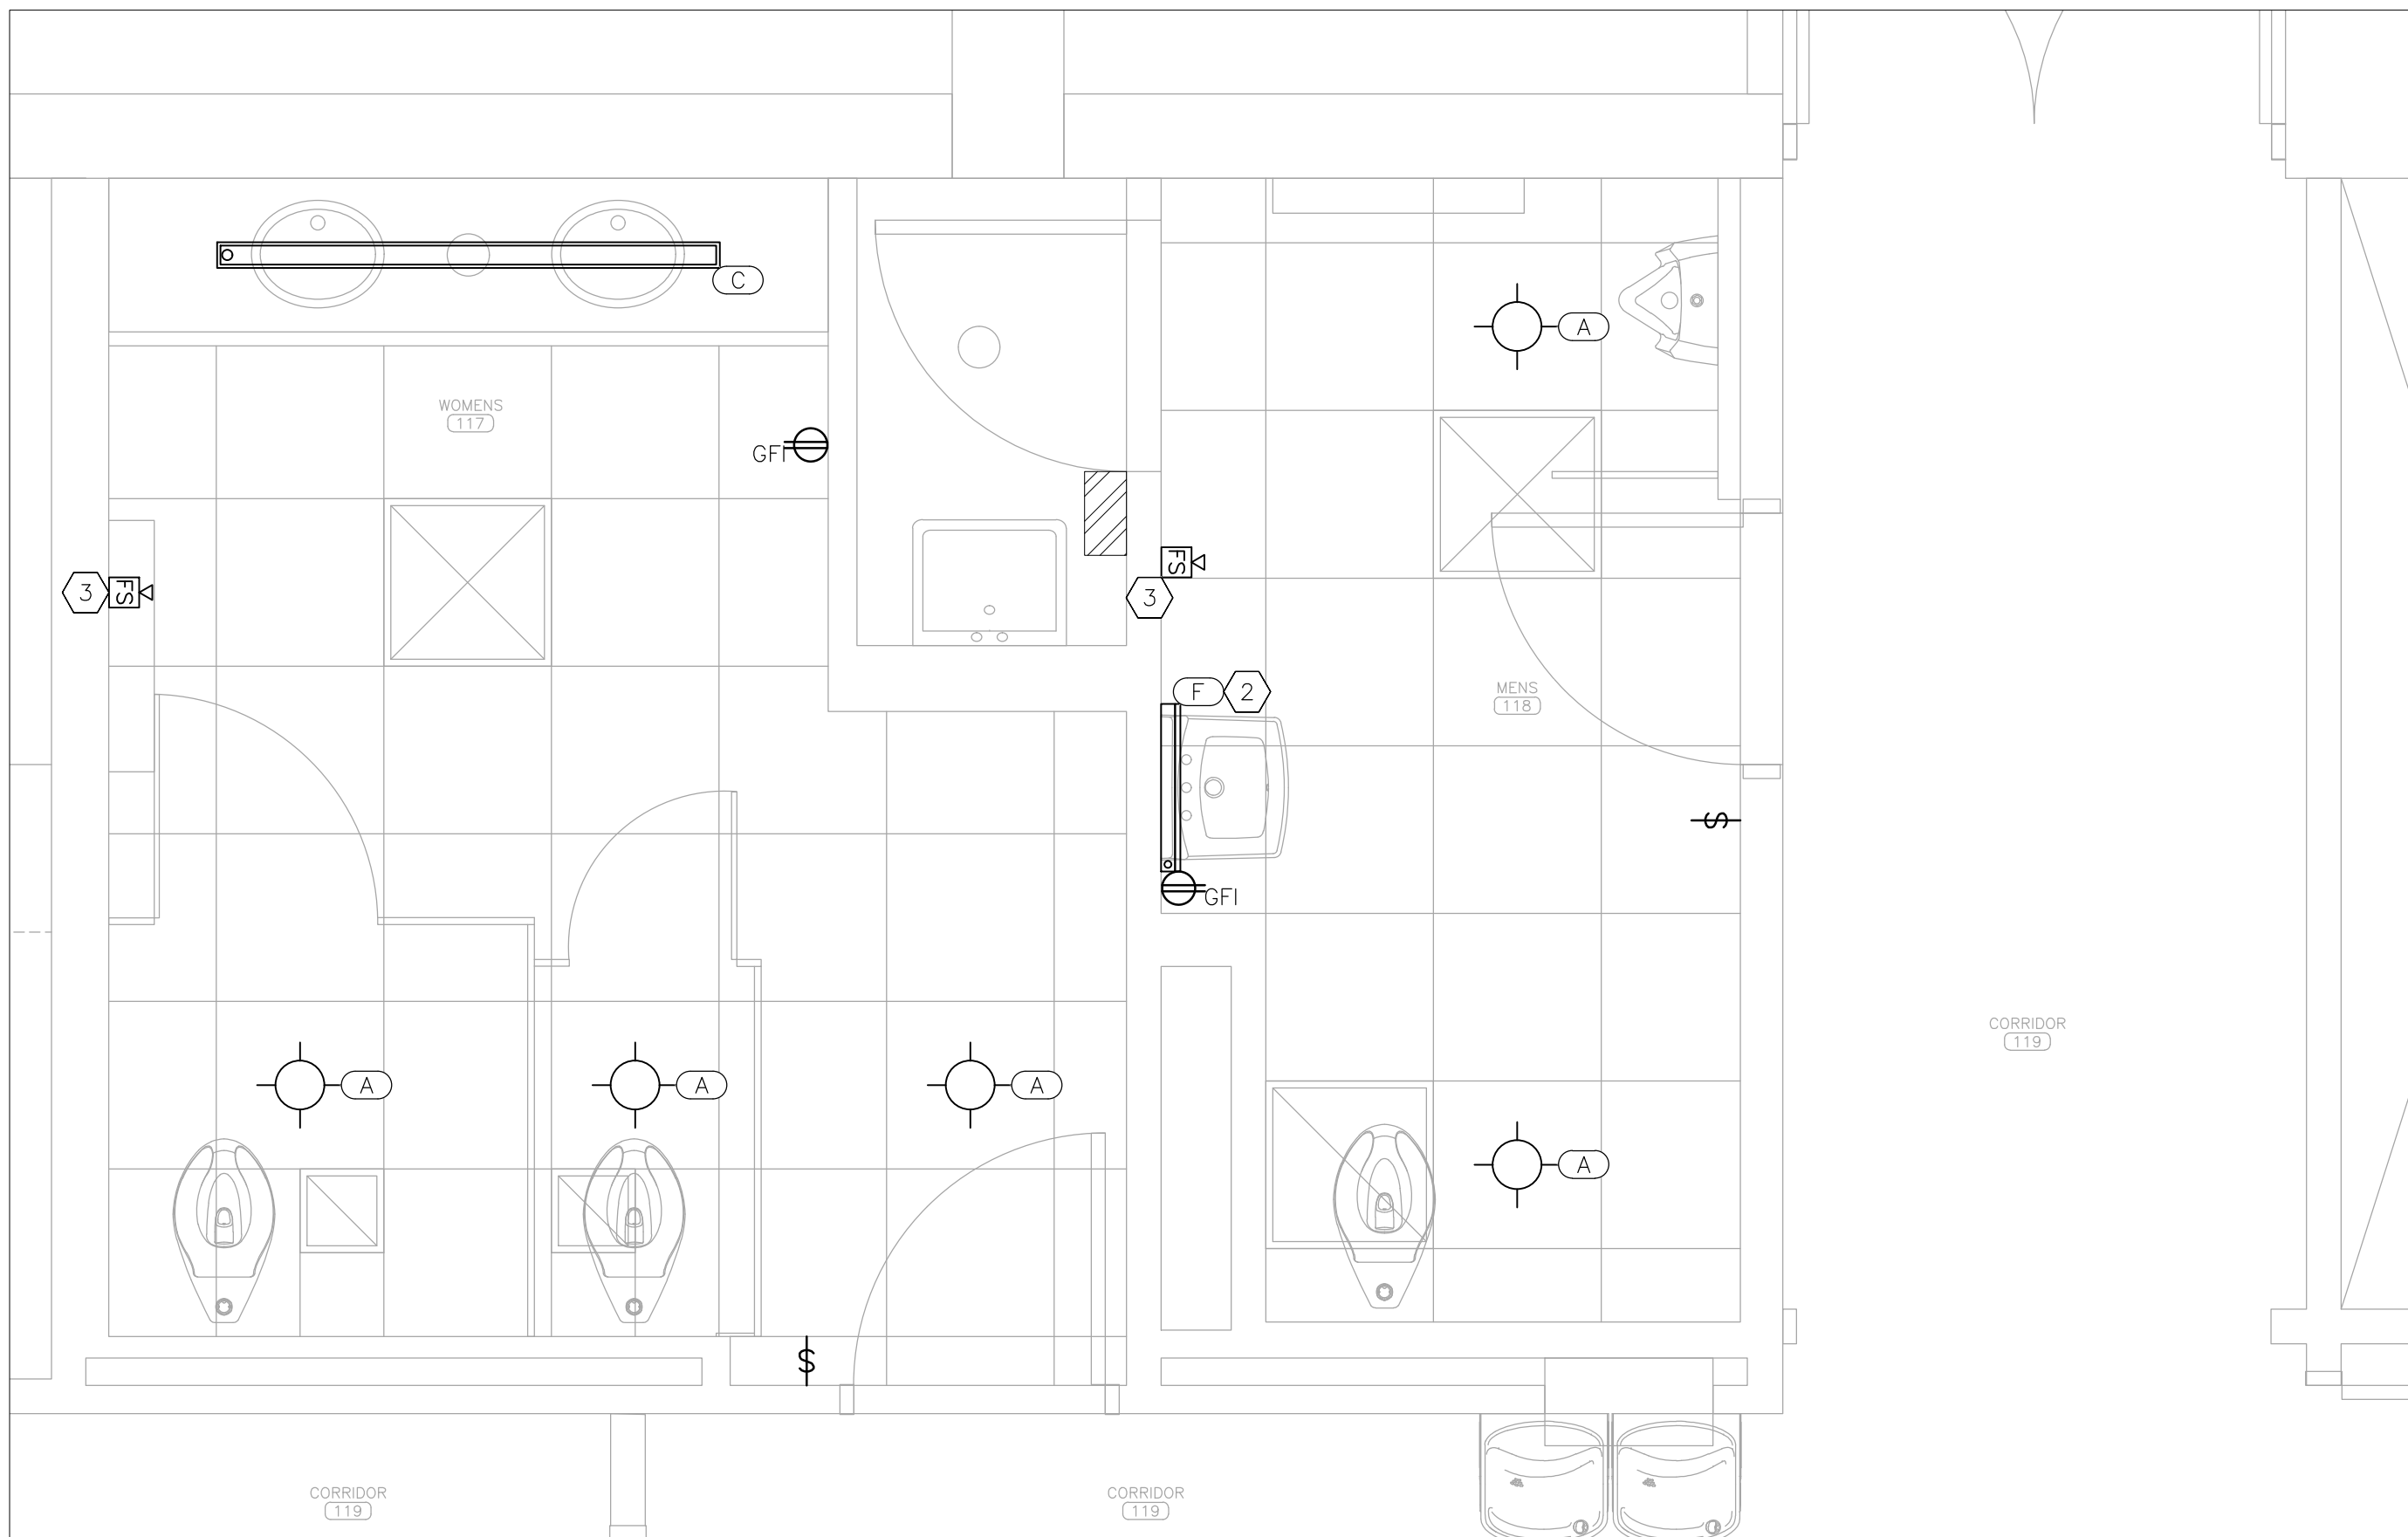

2 ELECTRICAL RENOVATION PLAN – PARTIAL FIRST FLOOR
SCALE: 1/2" = 1'-0"

DEMOLITION NOTES – DETAIL 1

INDICATES KEYED NOTES

- 1 REFER TO SHEET E-101 FOR GENERAL DEMOLITION NOTES.
- 2 DEMOLISH LIGHT FIXTURE, DEMOLISH ASSOCIATED CONDUIT AND CONDUCTORS TO NEAREST JUNCTION BOX FOR USE IN NEW CONSTRUCTION.
- 3 REMOVE AND RETAIN WALL MOUNTED FIRE STROBE, DEMOLISH SURFACE MOUNT JUNCTION BOX AND ASSOCIATED SURFACE MOUNT RACEWAY. DEMOLISH CONDUCTORS TO ABOVE CEILING FOR USE IN NEW CONSTRUCTION.


RENOVATION NOTES – DETAIL 2

INDICATES KEYED NOTES

- 1 REFER TO SHEET E-101 FOR GENERAL RENOVATION NOTES.
- 2 PROVIDE AND INSTALL WALL MOUNTED LIGHT FIXTURE ON EXISTING WALL, EXTEND CONDUIT AND CONDUCTORS FROM ROOM LIGHTING CIRCUIT TO LIGHT FIXTURE, REFER TO ARCHITECTURAL ELEVATIONS FOR FINAL LOCATION.
- 3 INSTALL RETAINED WALL MOUNT FIRE STROBE, PROVIDE NEW SURFACE RACEWAY AND JUNCTION BOX.

ELECTRICAL LEGEND

(AA)	LIGHT FIXTURE MARK
⊖ GFI	RECEPTACLE – TYPE: DUPLEX – GROUND FAULT INTERRUPTING
⊖	RECEPTACLE – TYPE: DUPLEX
\$	WALL SWITCH
FS	FIRE ALARM STROBE – WALL MOUNTED
—	ELECTRICAL DEVICE – NEW
---	ELECTRICAL DEVICE – EXISTING
---	LIGHT FIXTURE – NEW
----	EXISTING MATERIALS TO BE REMOVED
⊗	SUPPLY AIR GRILLE
⊘	EXHAUST AIR GRILLE

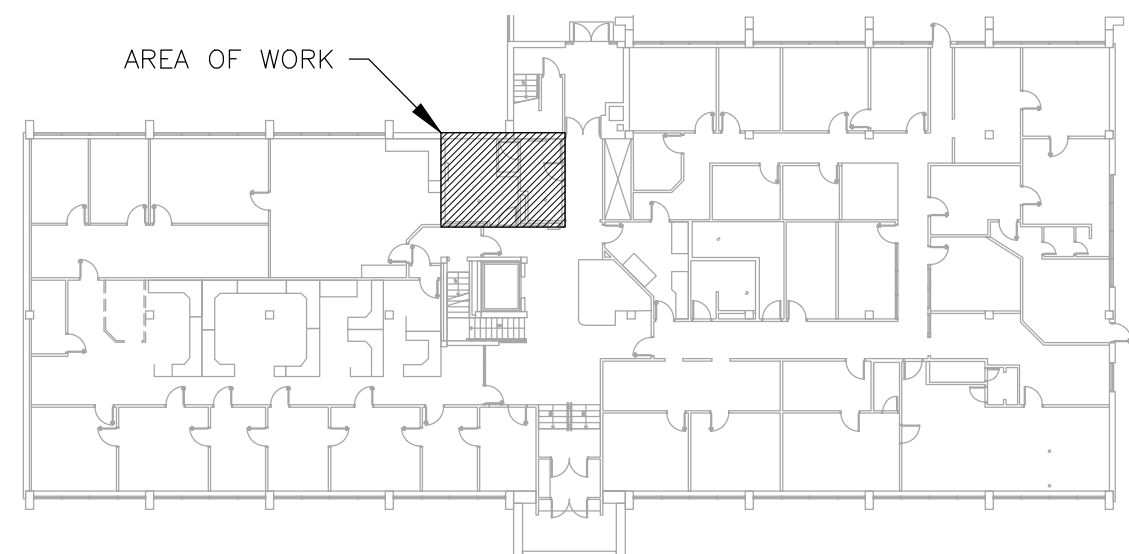

3 AREA MAP – FIRST FLOOR

STATE OF MISSOURI
MIKE KEHOE,
GOVERNOR



Tracie L. Siebeneck - Engineer
MO# PE-2013019114

BID DOCUMENTS

OFFICE OF ADMINISTRATION
DIVISION OF FACILITIES
MANAGEMENT,
DESIGN AND CONSTRUCTION

DEPARTMENT OF
PUBLIC SAFETY
STATE HIGHWAY PATROL

RENOVATE INTERIOR

GENERAL HEADQUARTERS
1510 EAST ELM STREET
JEFFERSON CITY, MO 65101

PROJECT # R2410-01
SITE # 6001
ASSET # 8136001001

REVISION: _____
DATE: _____
REVISION: _____
DATE: _____
REVISION: _____
DATE: _____
ISSUE DATE: 06/18/2026


CAD DWG FILE: E R2410-01
DRAWN BY: TS/AH
CHECKED BY: TS
DESIGNED BY: TS/AH

SHEET TITLE:
PARTIAL
ELECTRICAL PLAN
FIRST FLOOR


SHEET NUMBER:

E-102

35 OF 39 SHEETS
06/18/2026

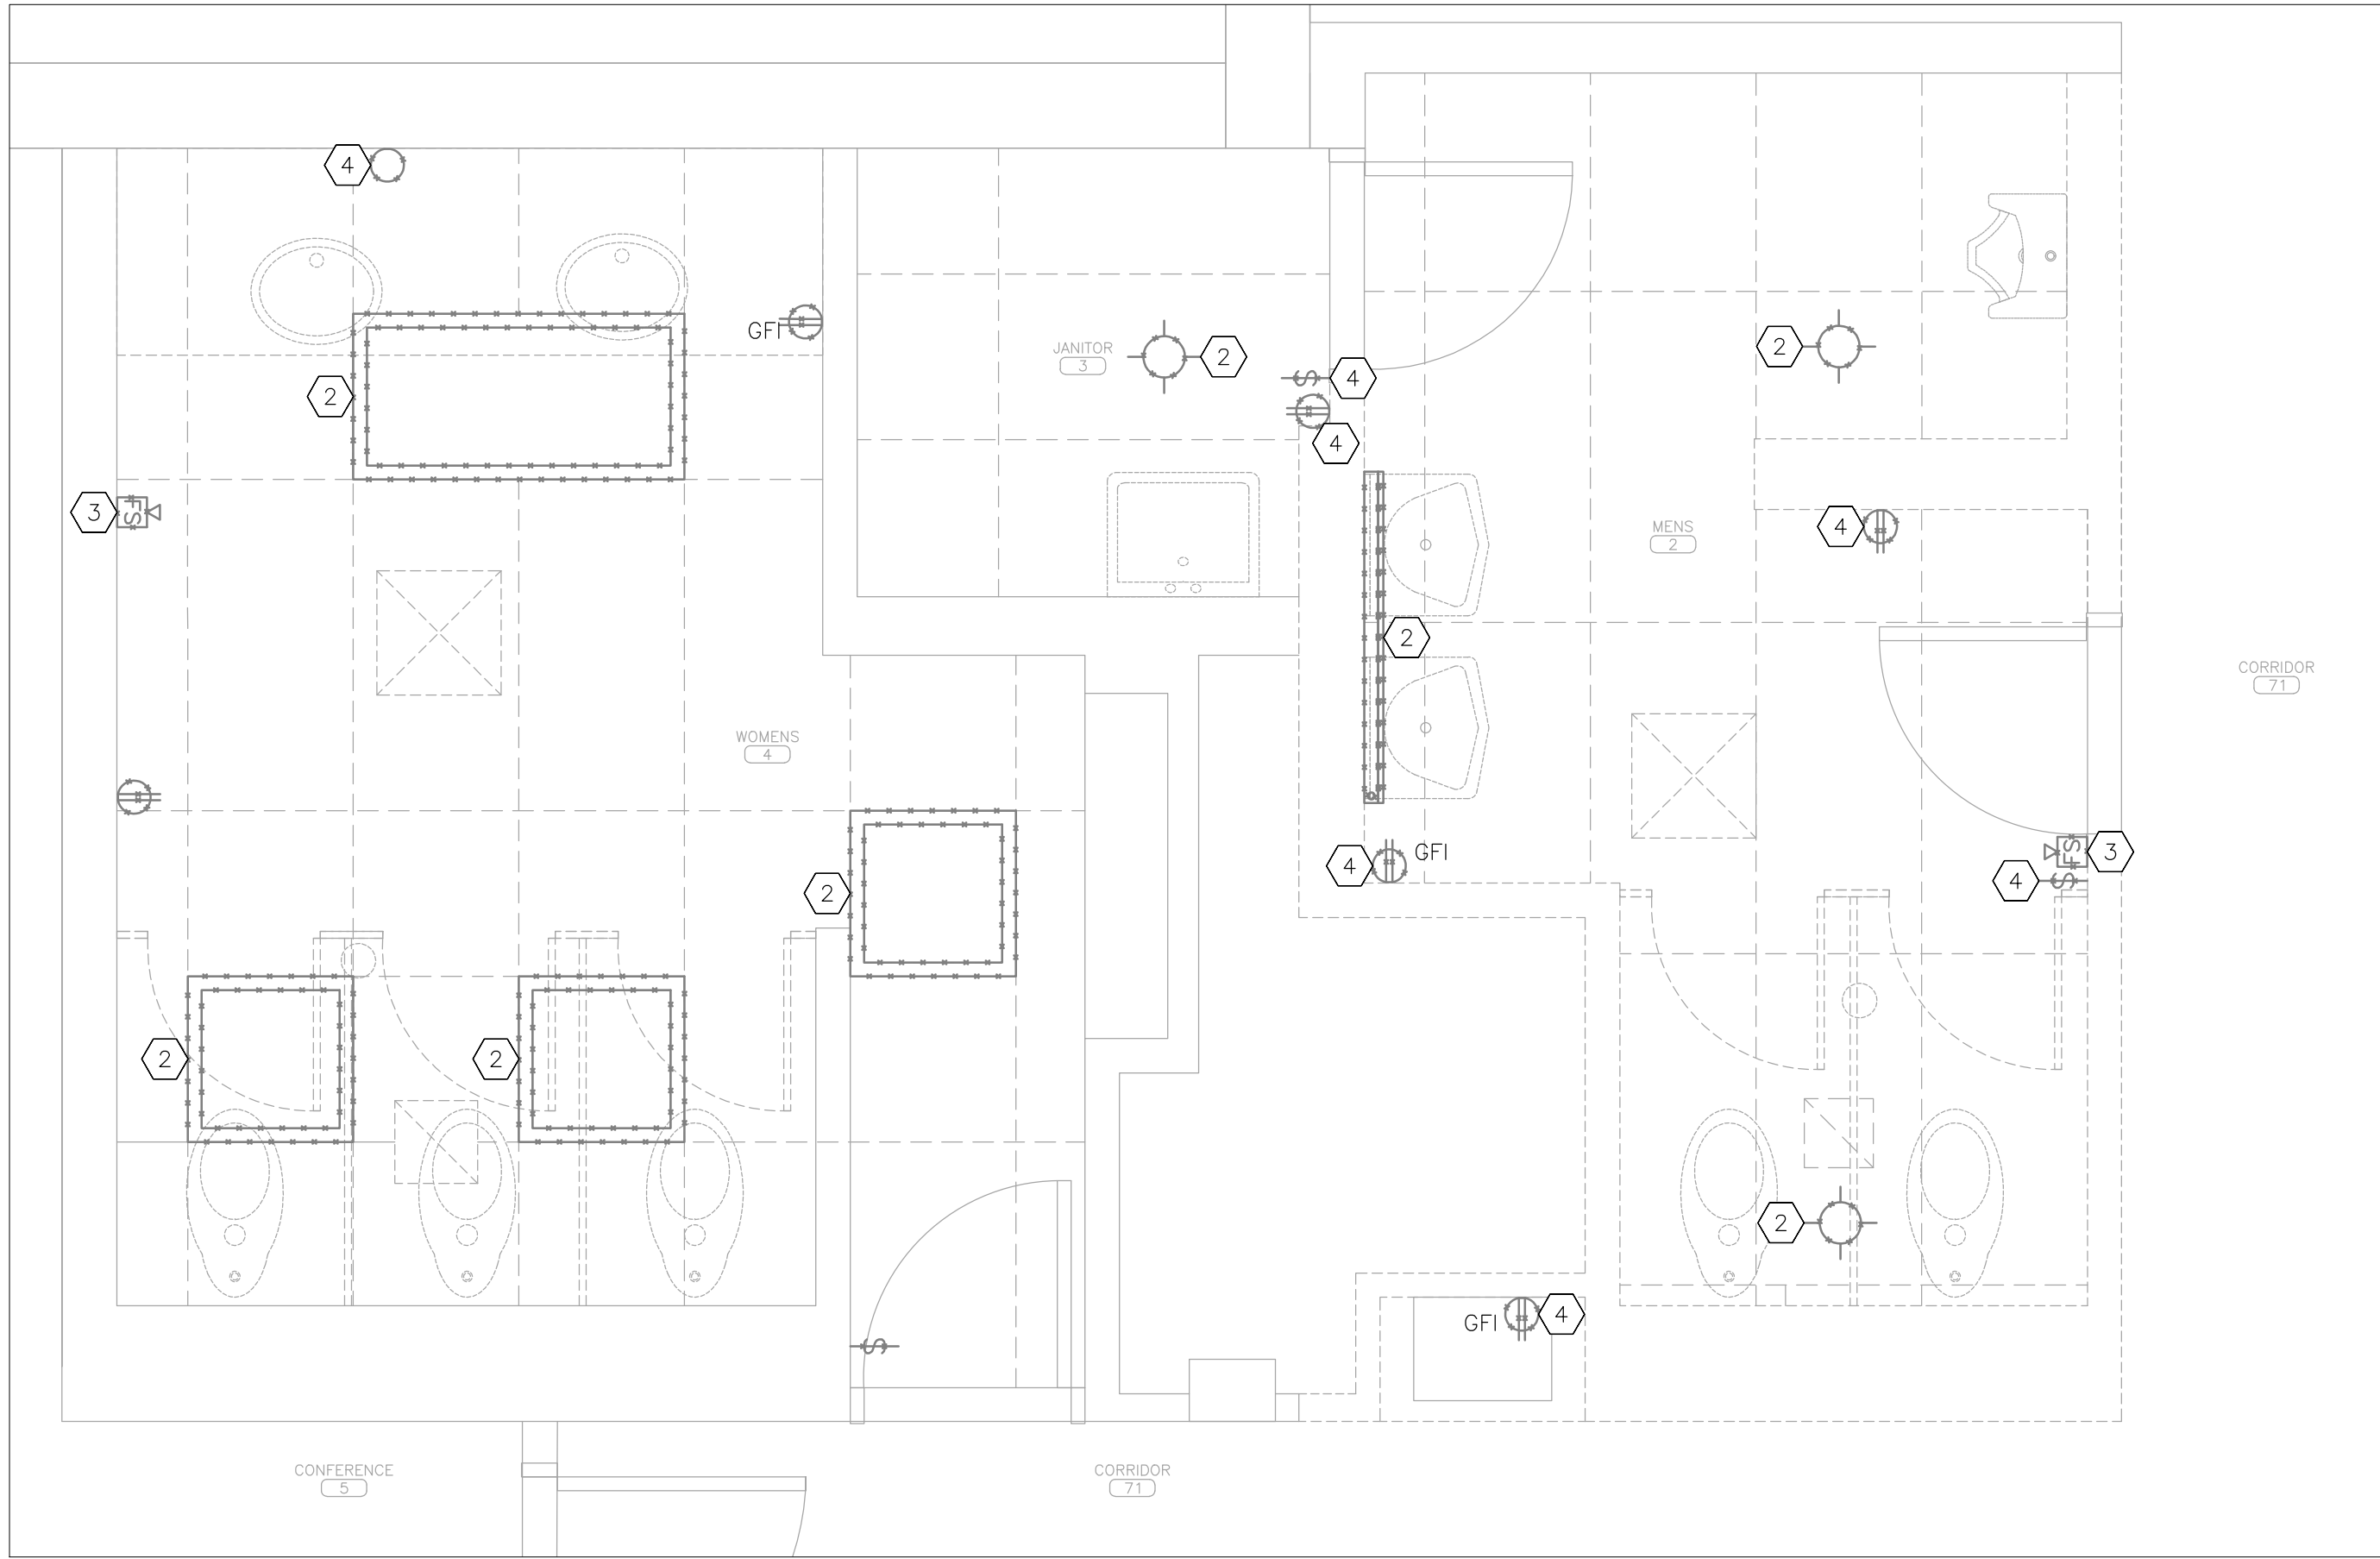

1 ELECTRICAL DEMOLITION PLAN – PARTIAL SECOND FLOOR
SCALE: 1/2" = 1'-0"

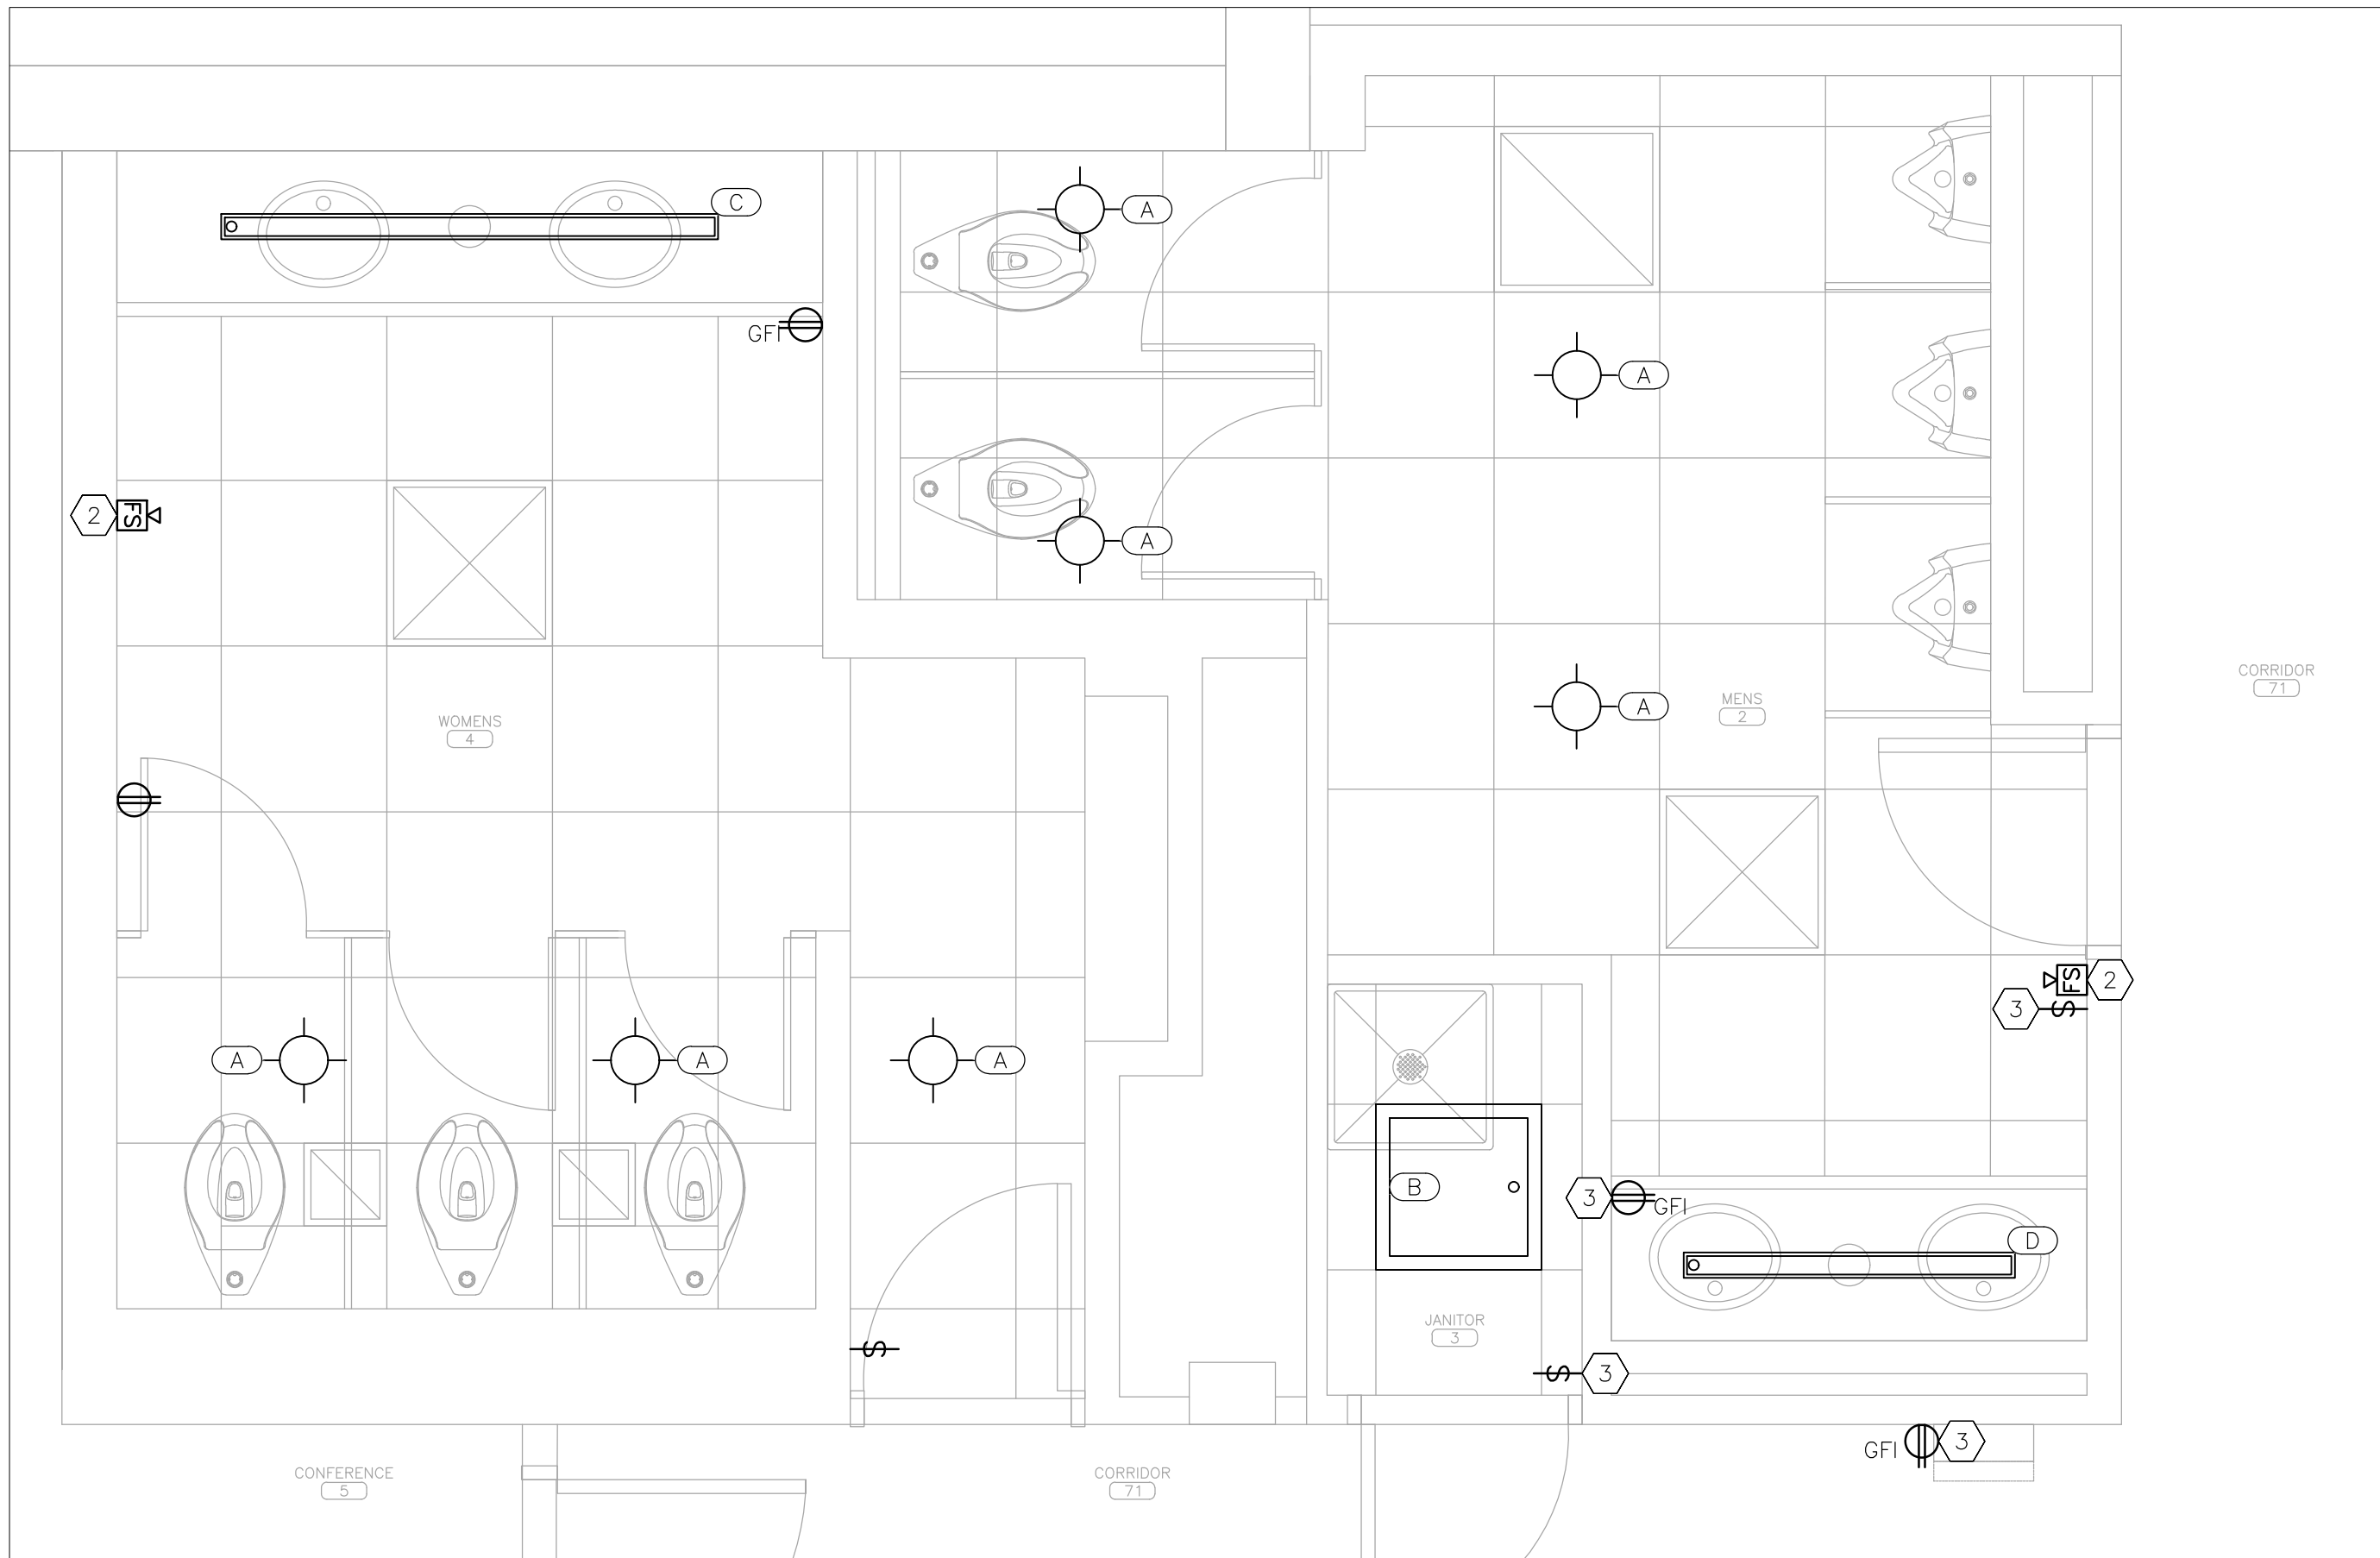

2 ELECTRICAL RENOVATION PLAN – PARTIAL SECOND FLOOR
SCALE: 1/2" = 1'-0"

DEMOLITION NOTES – DETAIL 1

INDICATES KEYED NOTES

- 1 REFER TO SHEET E-101 FOR GENERAL DEMOLITION NOTES.
- 2 DEMOLISH LIGHT FIXTURE, DEMOLISH ASSOCIATED CONDUIT AND CONDUCTORS TO NEAREST JUNCTION BOX FOR USE IN NEW CONSTRUCTION.
- 3 REMOVE AND RETAIN WALL MOUNTED FIRE STROBE, DEMOLISH SURFACE MOUNT JUNCTION BOX AND ASSOCIATED SURFACE MOUNT RACEWAY, DEMOLISH CONDUCTORS TO ABOVE CEILING FOR USE IN NEW CONSTRUCTION.
- 4 DEMOLISH RECEPTACLE/WALL SWITCH, DEVICE BOX, AND WALL PLATE, DEMOLISH ASSOCIATED CONDUIT AND CONDUCTORS TO ABOVE CEILING FOR USE IN NEW CONSTRUCTION.


RENOVATION NOTES – DETAIL 2

INDICATES KEYED NOTES

- 1 REFER TO SHEET E-101 FOR GENERAL RENOVATION NOTES.
- 2 INSTALL RETAINED WALL MOUNT FIRE STROBE, PROVIDE NEW SURFACE RACEWAY AND JUNCTION BOX.
- 3 PROVIDE AND INSTALL RECEPTACLE/WALL SWITCH, DEVICE BOX, AND WALL PLATE, EXTEND CONDUIT AND CONDUCTORS FROM DEMOLITION TO NEW LOCATION.

ELECTRICAL LEGEND

AA	LIGHT FIXTURE MARK
GFI	RECEPTACLE – TYPE: DUPLEX – GROUND FAULT INTERRUPTING
	RECEPTACLE – TYPE: DUPLEX
	BLANK WALL PLATE
\$	WALL SWITCH
FS	FIRE ALARM STROBE – WALL MOUNTED
	ELECTRICAL DEVICE – NEW
	LIGHT FIXTURE – NEW
	EXISTING MATERIALS TO BE REMOVED
	SUPPLY AIR GRILLE
	EXHAUST AIR GRILLE

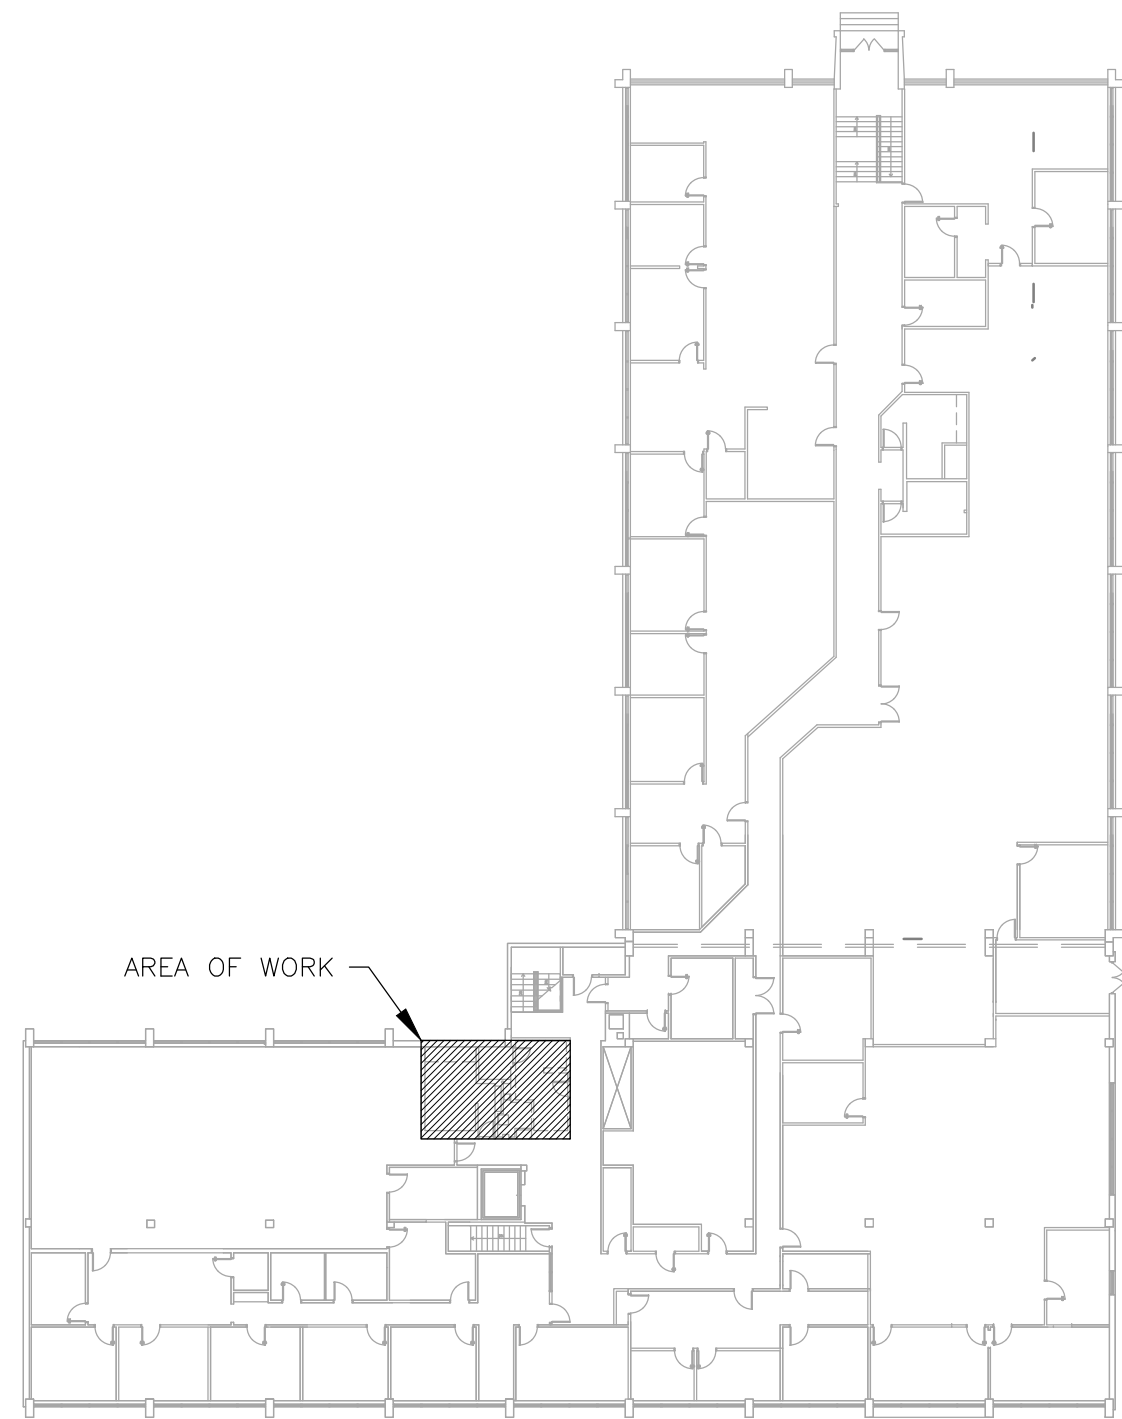

3 AREA MAP – SECOND FLOOR

STATE OF MISSOURI
MIKE KEHOE,
GOVERNOR



Tracie L. Siebeneck - Engineer
MO# PE-2013019114

BID
DOCUMENTS

OFFICE OF ADMINISTRATION
DIVISION OF FACILITIES
MANAGEMENT,
DESIGN AND CONSTRUCTION

DEPARTMENT OF
PUBLIC SAFETY
STATE HIGHWAY PATROL

RENOVATE INTERIOR

GENERAL HEADQUARTERS
1510 EAST ELM STREET
JEFFERSON CITY, MO 65101

PROJECT # R2410-01
SITE # 6001
ASSET # 8136001001

REVISION: _____
DATE: _____
REVISION: _____
DATE: _____
REVISION: _____
DATE: _____
ISSUE DATE: 06/18/2026


CAD DWG FILE: E_R2410-01
DRAWN BY: TS/AH
CHECKED BY: TS
DESIGNED BY: TS/AH

SHEET TITLE:
PARTIAL
ELECTRICAL PLAN
SECOND FLOOR


SHEET NUMBER:

E-103

36 OF 39 SHEETS
06/18/2026

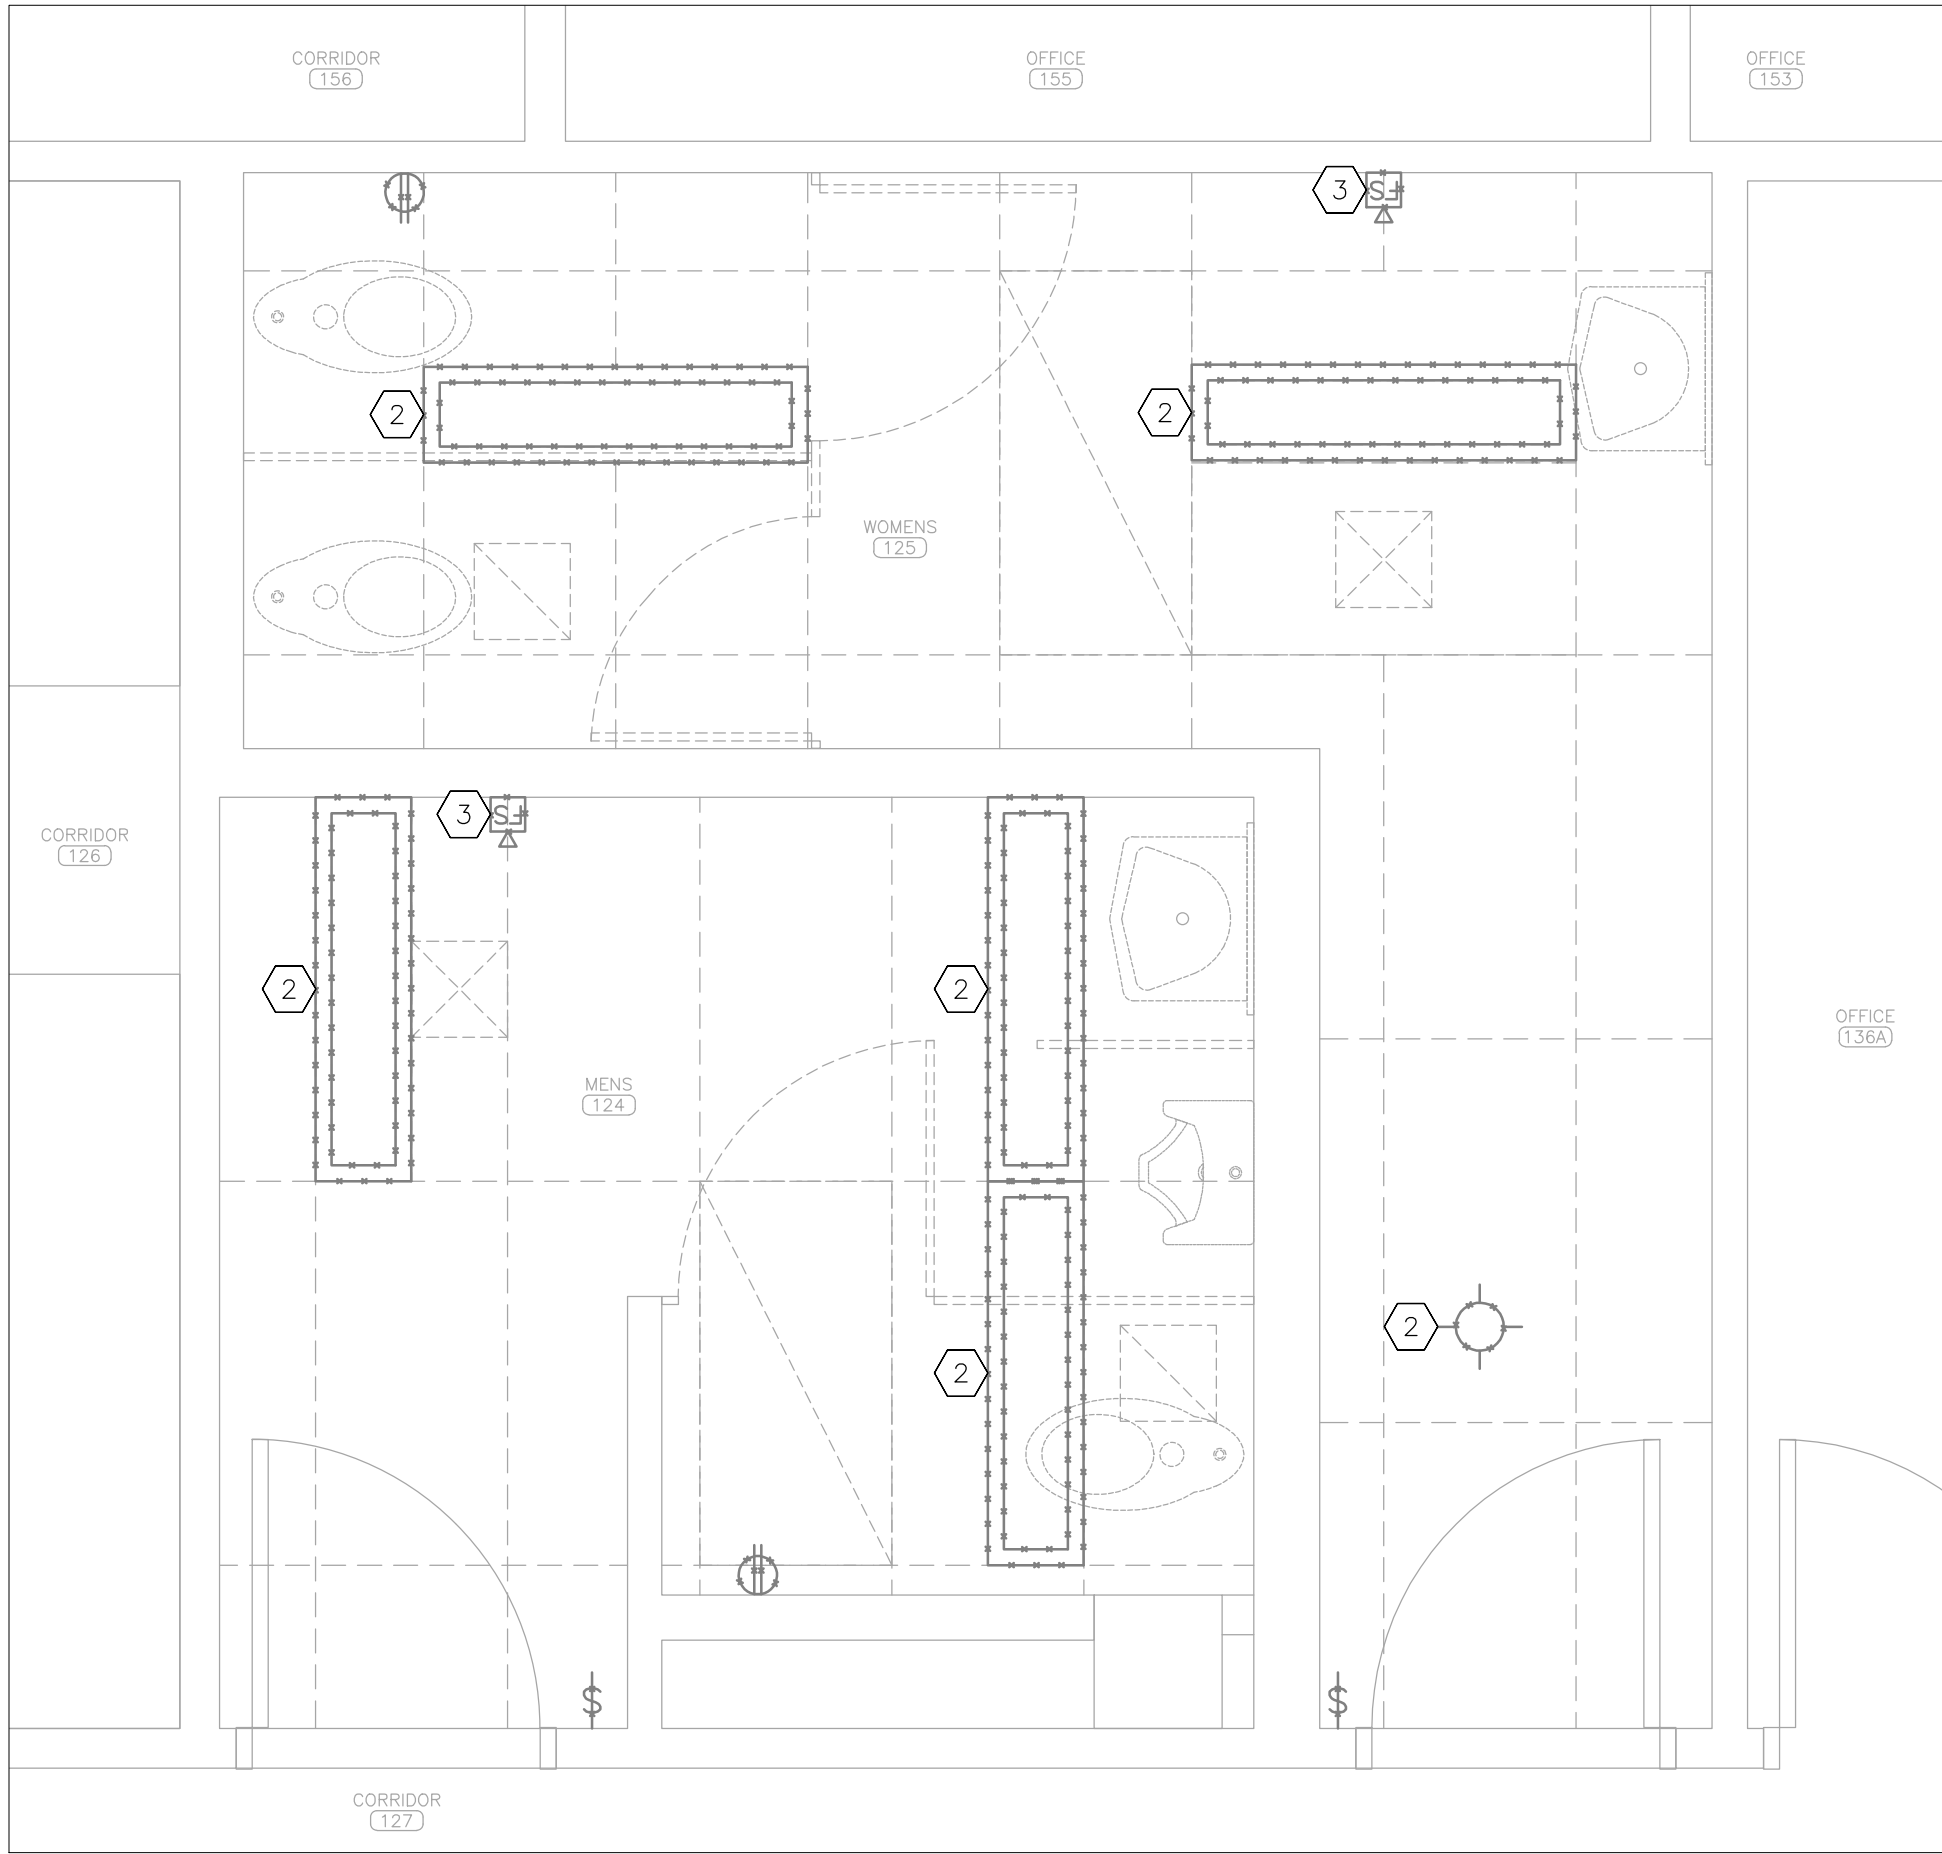

1 ELECTRICAL DEMOLITION PLAN – PARTIAL FIRST FLOOR
SCALE: 1/2" = 1'-0"

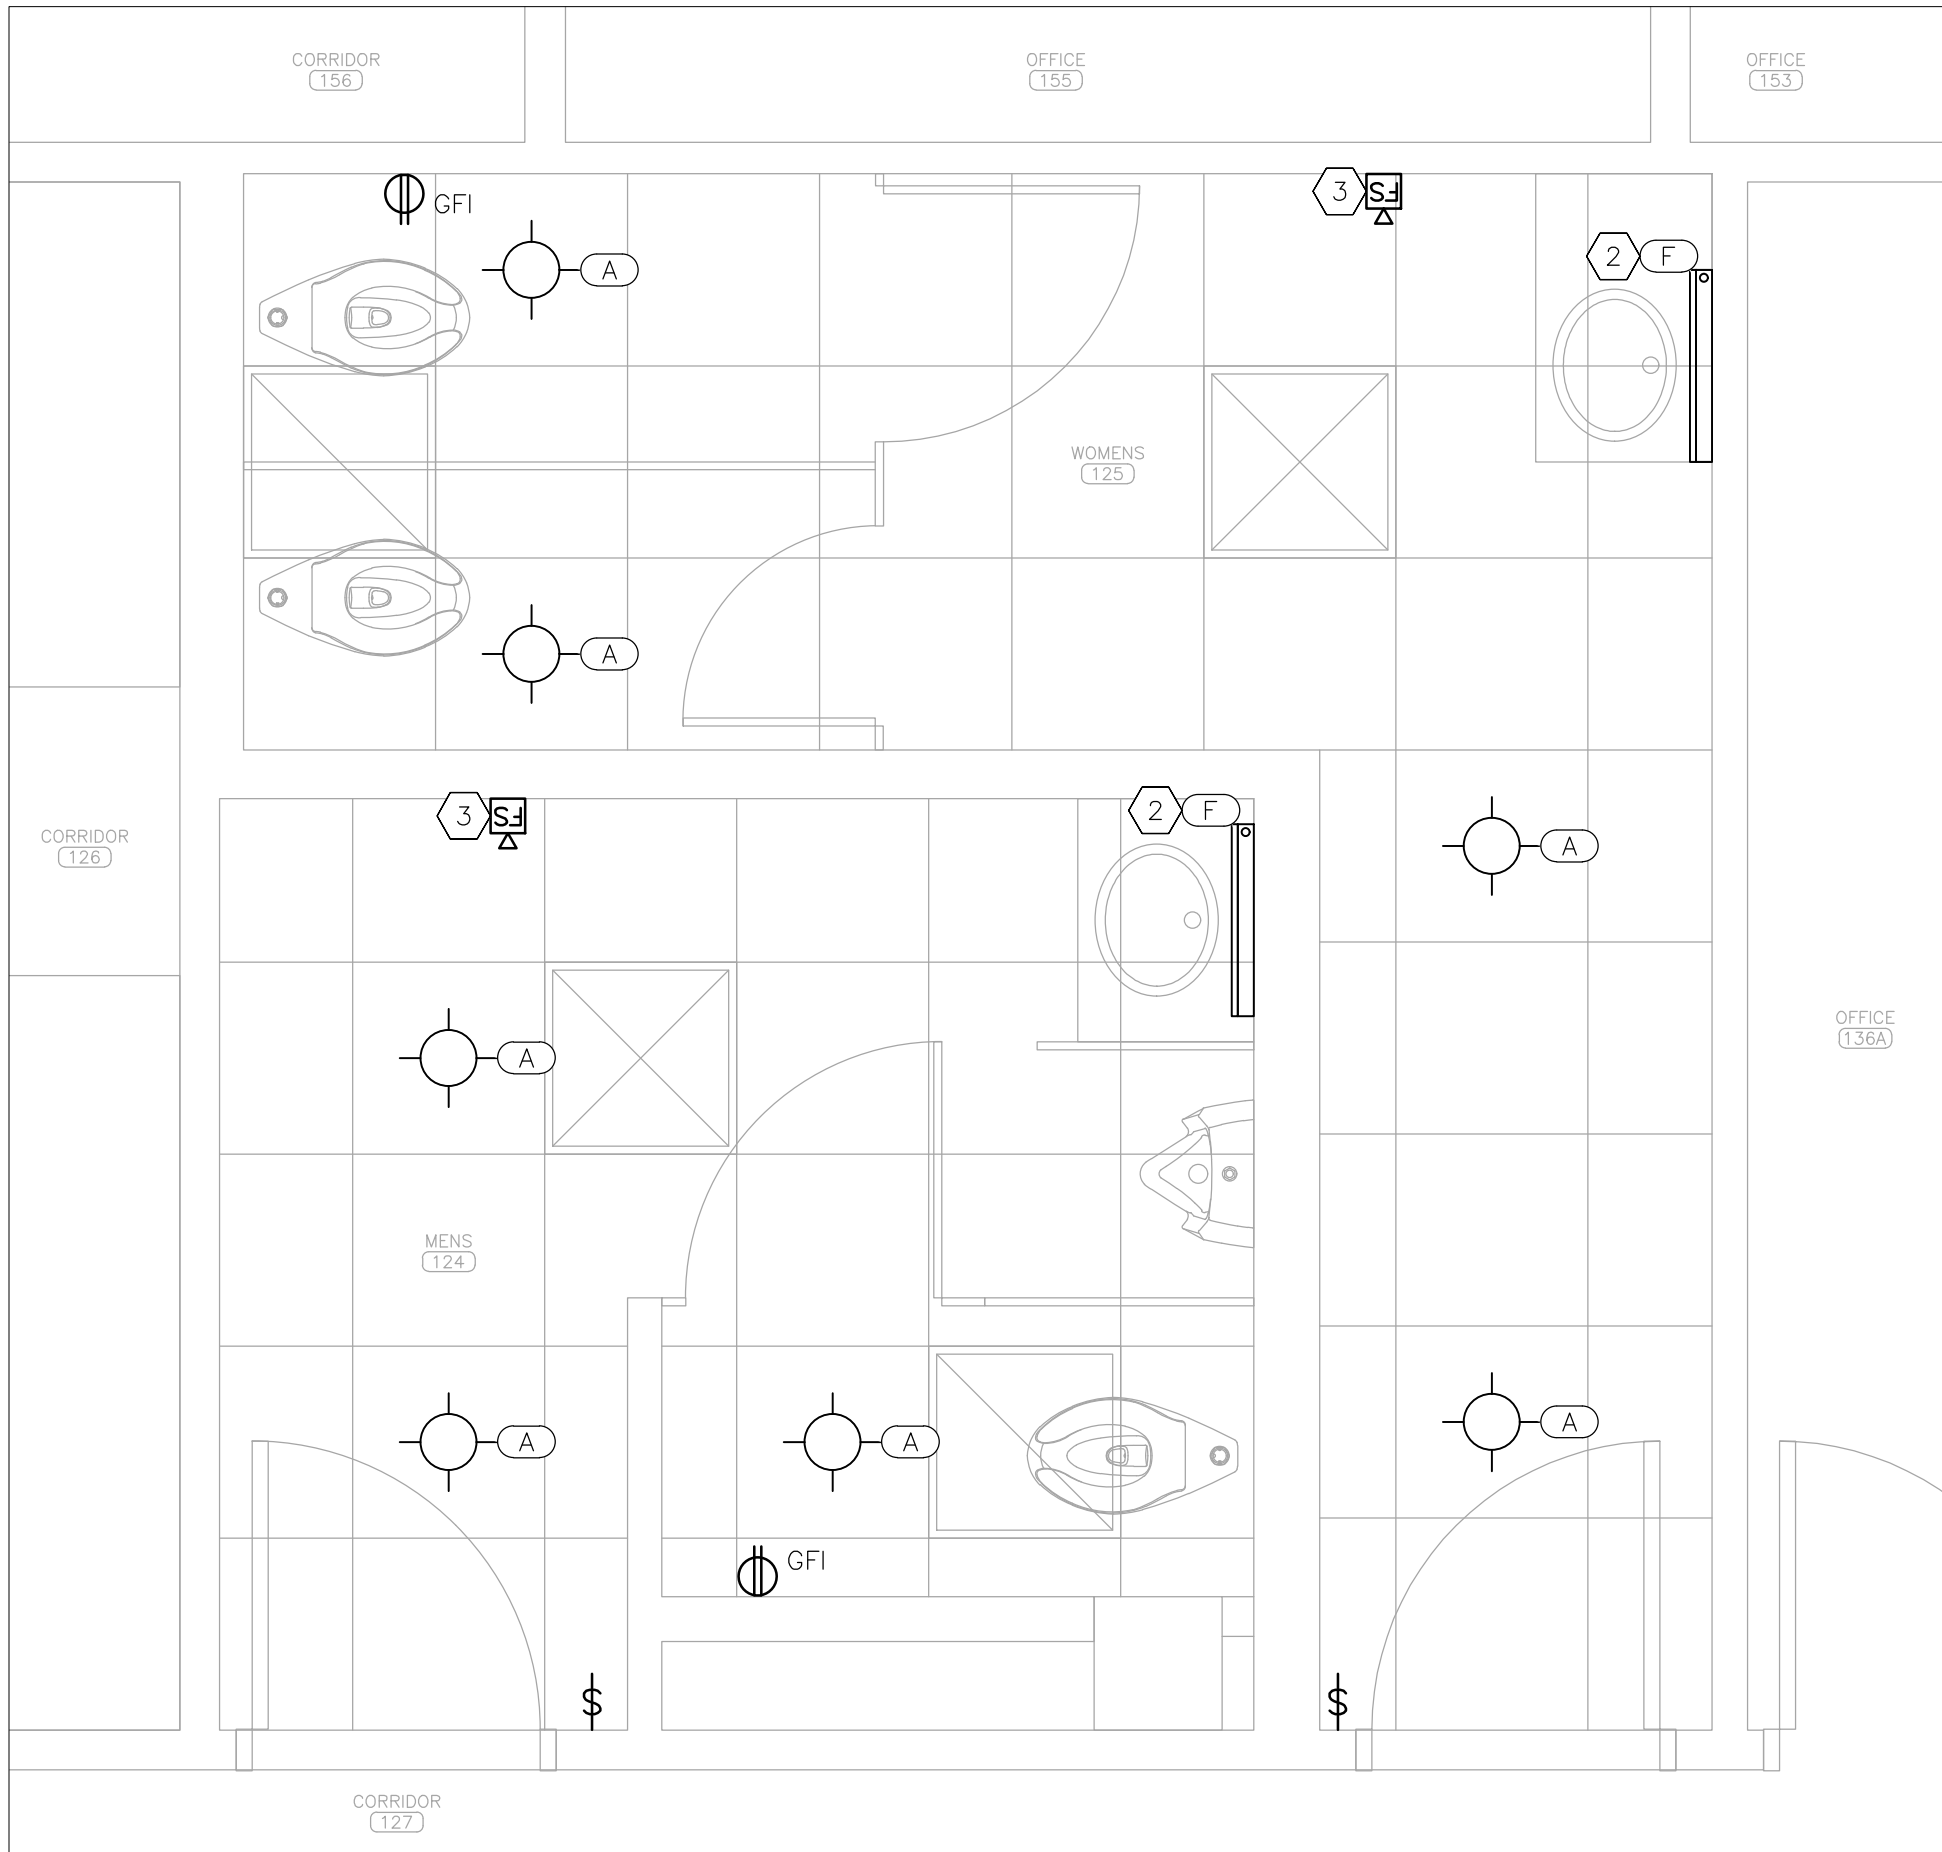

2 ELECTRICAL RENOVATION PLAN – PARTIAL FIRST FLOOR
SCALE: 1/2" = 1'-0"

DEMOLITION NOTES – DETAIL 1

INDICATES KEYED NOTES

- 1 REFER TO SHEET E-101 FOR GENERAL DEMOLITION NOTES.
- 2 DEMOLISH LIGHT FIXTURE, DEMOLISH ASSOCIATED CONDUIT AND CONDUCTORS TO NEAREST JUNCTION BOX FOR USE IN NEW CONSTRUCTION.
- 3 REMOVE AND RETAIN WALL MOUNTED FIRE STROBE, CONDUCTORS AND JUNCTION BOX TO REMAIN FOR USE IN NEW CONSTRUCTION.


RENOVATION NOTES – DETAIL 2

INDICATES KEYED NOTES

- 1 REFER TO SHEET E-101 FOR GENERAL RENOVATION NOTES.
- 2 PROVIDE AND INSTALL WALL MOUNTED LIGHT FIXTURE ON EXISTING WALL, EXTEND CONDUIT AND CONDUCTORS FROM ROOM LIGHTING CIRCUIT TO LIGHT FIXTURE, REFER TO ARCHITECTURAL ELEVATIONS FOR FINAL LOCATION.
- 3 INSTALL RETAINED WALL MOUNT FIRE STROBE IN EXISTING JUNCTION BOX.

ELECTRICAL LEGEND

AA	LIGHT FIXTURE MARK
GFI	RECEPTACLE – TYPE: DUPLEX – GROUND FAULT INTERRUPTING
	RECEPTACLE – TYPE: DUPLEX
\$	WALL SWITCH
FS	FIRE ALARM STROBE – WALL MOUNTED
—	ELECTRICAL DEVICE – NEW
—	LIGHT FIXTURE – NEW
----	EXISTING MATERIALS TO BE REMOVED
X	SUPPLY AIR GRILLE
□	EXHAUST AIR GRILLE

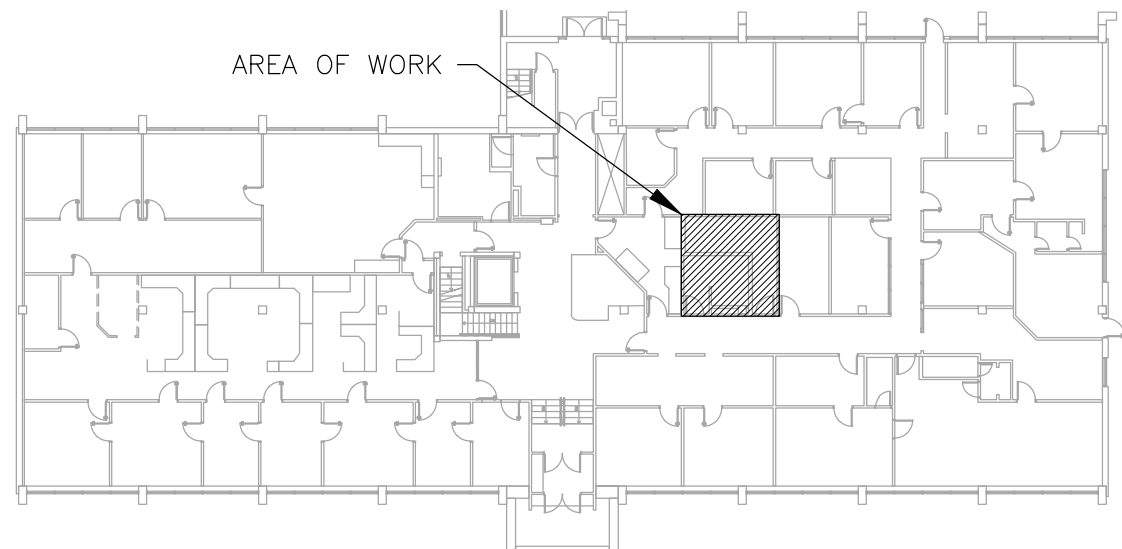

3 AREA MAP – FIRST FLOOR

STATE OF MISSOURI
MIKE KEHOE,
GOVERNOR



Tracie L. Siebeneck - Engineer
MO# PE-2013019114

BID
DOCUMENTS

OFFICE OF ADMINISTRATION
DIVISION OF FACILITIES
MANAGEMENT,
DESIGN AND CONSTRUCTION

DEPARTMENT OF
PUBLIC SAFETY
STATE HIGHWAY PATROL

RENOVATE INTERIOR

GENERAL HEADQUARTERS
1510 EAST ELM STREET
JEFFERSON CITY, MO 65101

PROJECT # R2410-01
SITE # 6001
ASSET # 8136001001

REVISION: _____
DATE: _____
REVISION: _____
DATE: _____
REVISION: _____
DATE: _____
ISSUE DATE: 06/18/2026

CAD DWG FILE: E_R2410-01
DRAWN BY: TS/AH
CHECKED BY: TS
DESIGNED BY: TS/AH

SHEET TITLE:
PARTIAL
ELECTRICAL PLAN
FIRST FLOOR

SHEET NUMBER:

E-104

37 OF 39 SHEETS
06/18/2026



Tracie L. Siebeneck - Engineer
MO# PE-2013019114

BID
DOCUMENTS

OFFICE OF ADMINISTRATION
DIVISION OF FACILITIES
MANAGEMENT,
DESIGN AND CONSTRUCTION

DEPARTMENT OF
PUBLIC SAFETY
STATE HIGHWAY PATROL

RENOVATE INTERIOR

GENERAL HEADQUARTERS
1510 EAST ELM STREET
JEFFERSON CITY, MO 65101

PROJECT # R2410-01
SITE # 6001
ASSET # 8136001001

REVISION: _____
DATE: _____
REVISION: _____
DATE: _____
REVISION: _____
DATE: _____
ISSUE DATE: 06/18/2026

CAD DWG FILE: E_R2410-01
DRAWN BY: TS/AH
CHECKED BY: TS
DESIGNED BY: TS/AH

SHEET TITLE:
PARTIAL
ELECTRICAL PLAN
FIRST FLOOR

SHEET NUMBER:

E-105


38 OF 39 SHEETS
06/18/2026

DEMOLITION NOTES – DETAILS 1 & 2 # INDICATES KEYED NOTES


- 1 REFER TO SHEET E-101 FOR GENERAL DEMOLITION NOTES.
- 2 DEMOLISH LIGHT FIXTURE, DEMOLISH ASSOCIATED CONDUIT AND CONDUCTORS TO NEAREST JUNCTION BOX FOR USE IN NEW CONSTRUCTION.
- 3 REMOVE AND RETAIN WALL MOUNTED FIRE STROBE, DEMOLISH SURFACE MOUNT JUNCTION BOX AND ASSOCIATED SURFACE MOUNT RACEWAY, DEMOLISH CONDUCTORS TO ABOVE CEILING FOR USE IN NEW CONSTRUCTION.
- 4 REMOVE AND RETAIN WALL MOUNTED FIRE STROBE, CONDUCTORS AND JUNCTION BOX TO REMAIN FOR USE IN NEW CONSTRUCTION.
- 5 WALL SWITCH TO REMAIN.

RENOVATION NOTES – DETAILS 3 & 4 # INDICATES KEYED NOTES


- 1 REFER TO SHEET E-101 FOR GENERAL RENOVATION NOTES.
- 2 PROVIDE AND INSTALL WALL MOUNTED LIGHT FIXTURE ON EXISTING WALL, EXTEND CONDUIT AND CONDUCTORS FROM ROOM LIGHTING CIRCUIT TO LIGHT FIXTURE, REFER TO ARCHITECTURAL ELEVATIONS FOR FINAL LOCATION.
- 3 INSTALL RETAINED WALL MOUNT FIRE STROBE, PROVIDE NEW SURFACE RACEWAY AND JUNCTION BOX.
- 4 INSTALL RETAINED WALL MOUNT FIRE STROBE IN EXISTING JUNCTION BOX.

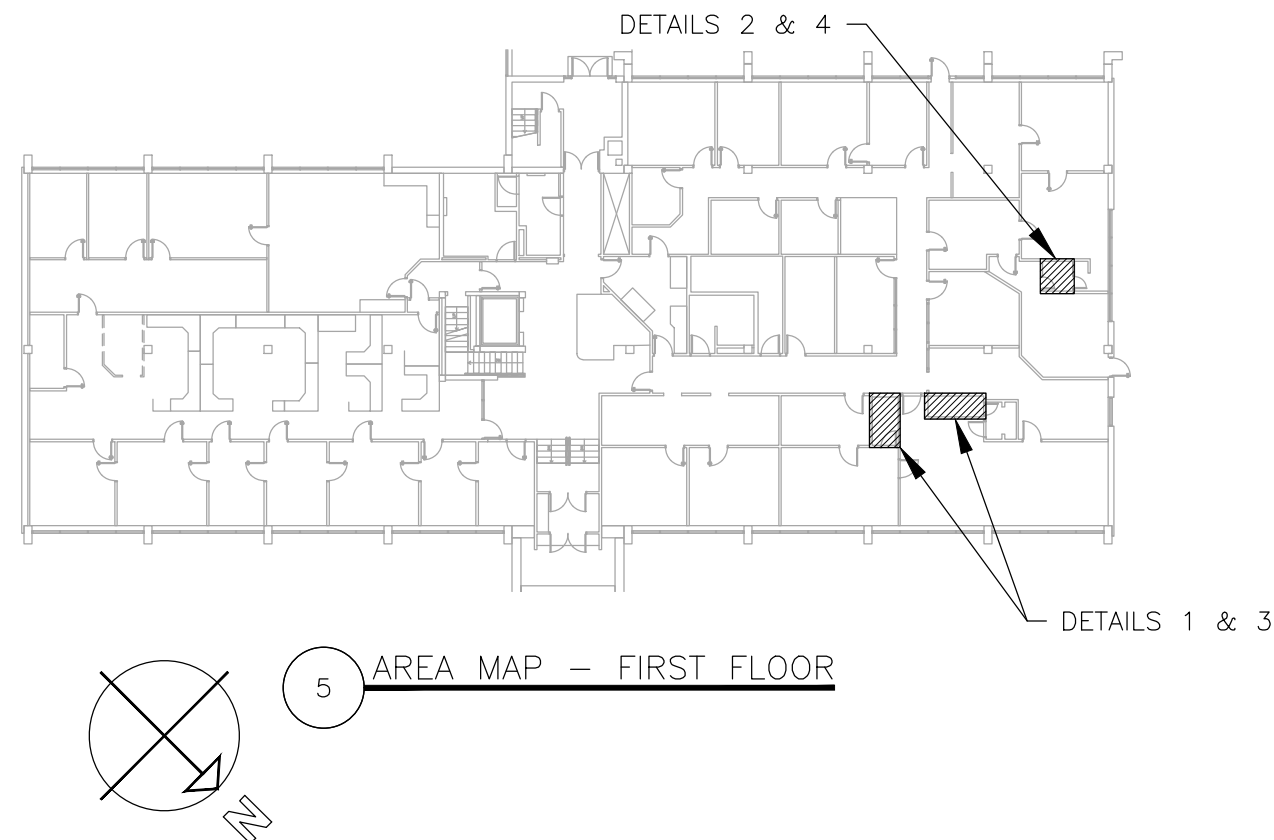


ELECTRICAL LEGEND			
(AA)	LIGHT FIXTURE MARK	▽ FS	FIRE ALARM STROBE – WALL MOUNTED
⊖ GFI	RECEPTACLE – TYPE: DUPLEX – GROUND FAULT INTERRUPTING	—	ELECTRICAL DEVICE – NEW
⊖	RECEPTACLE – TYPE: DUPLEX	—	LIGHT FIXTURE – NEW
\$	WALL SWITCH	----	EXISTING MATERIALS TO BE REMOVED
		⊠	SUPPLY AIR GRILLE
		⊡	EXHAUST AIR GRILLE

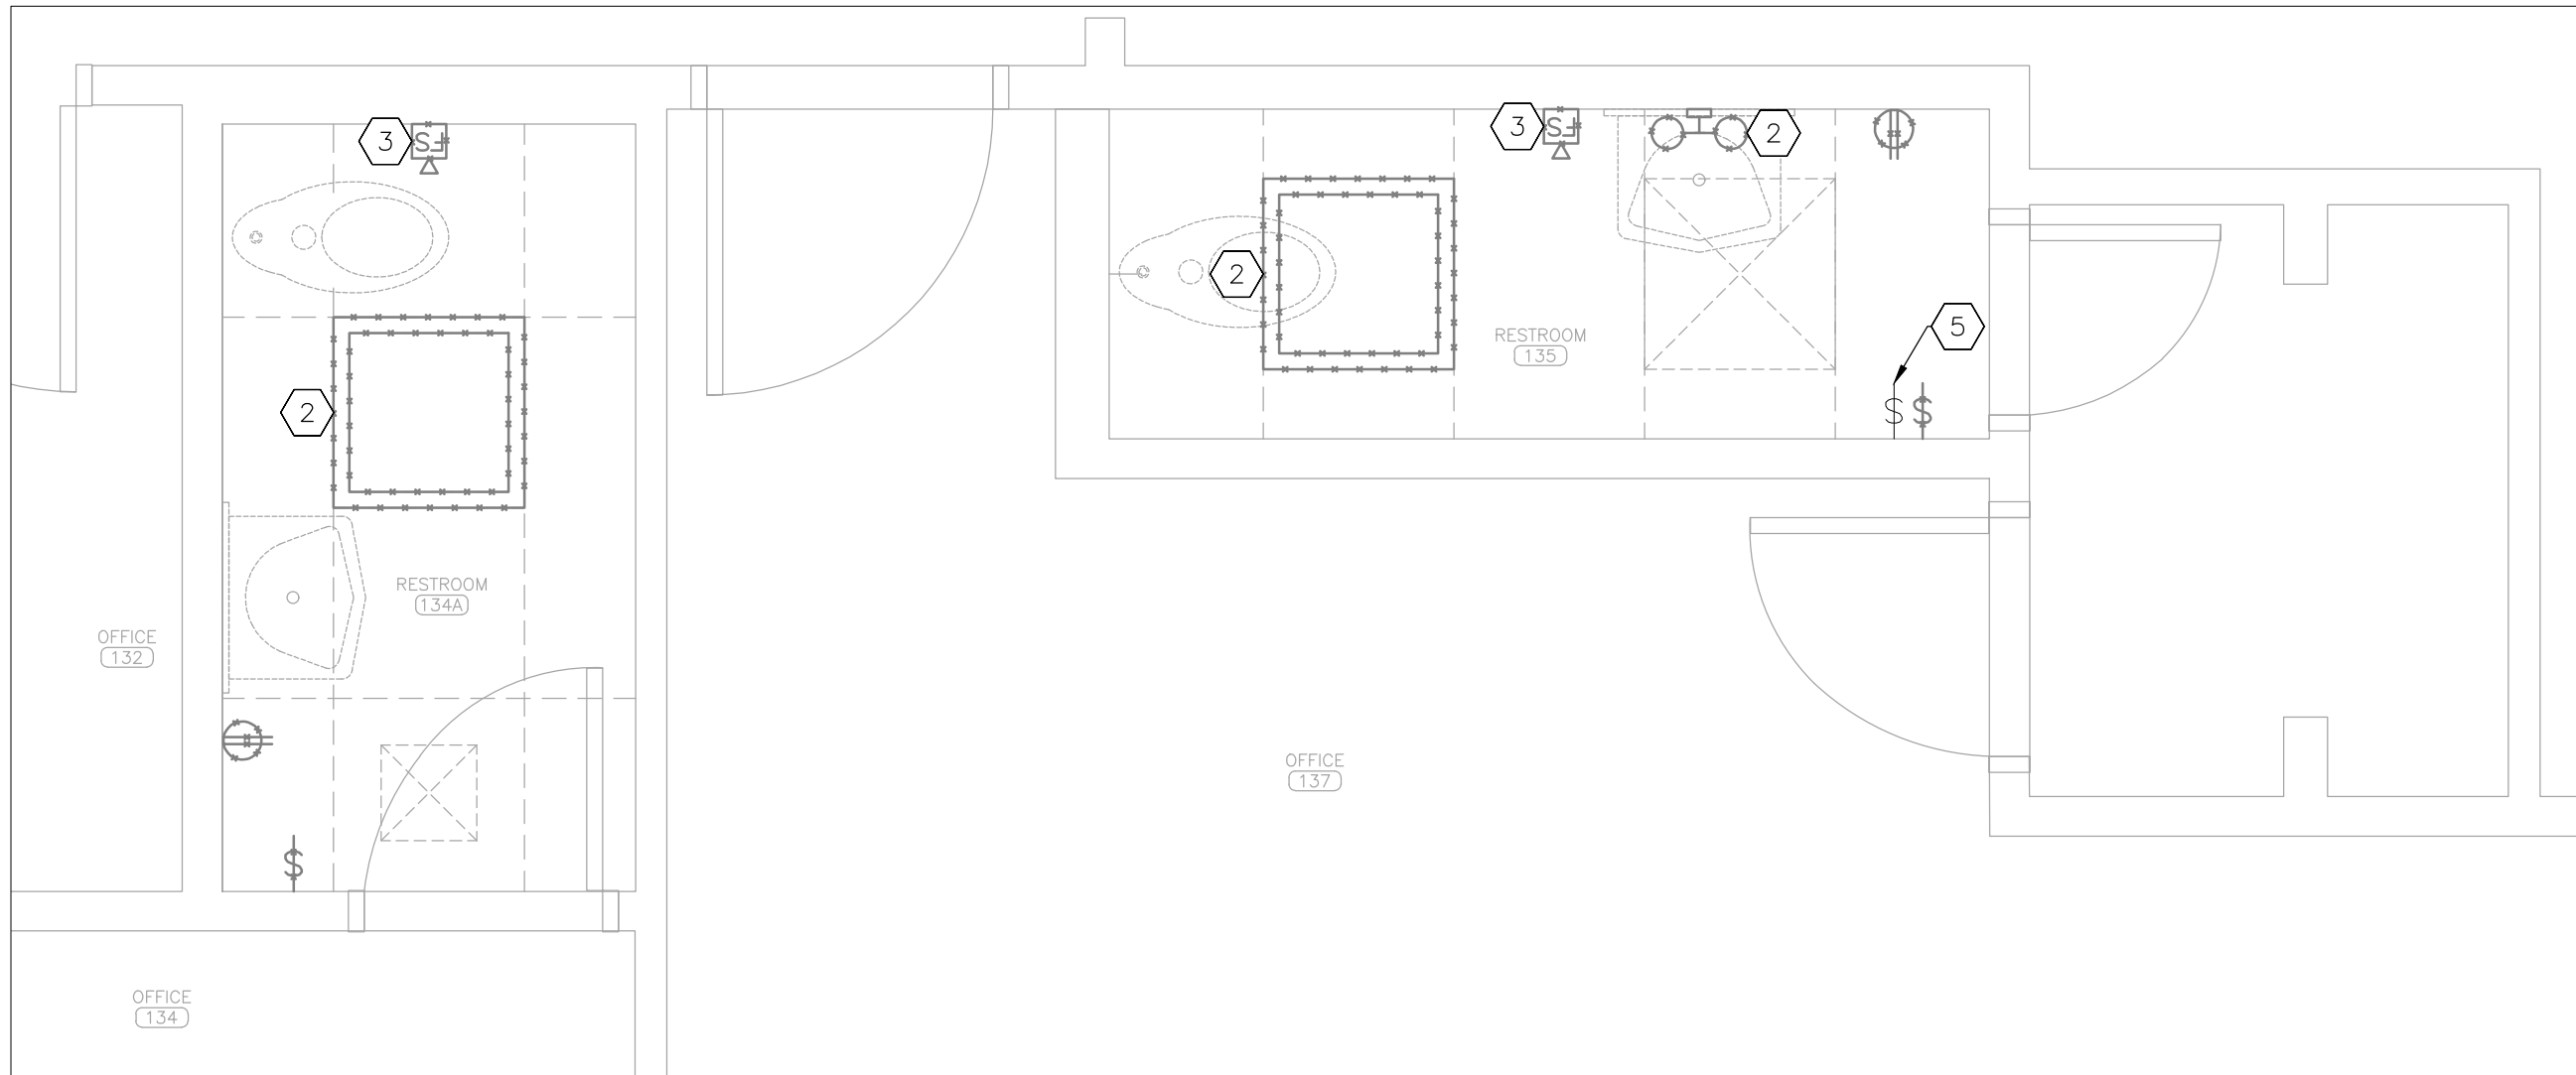


1 ELECTRICAL DEMOLITION PLAN – PARTIAL FIRST FLOOR
SCALE: 1/2" = 1'-0"

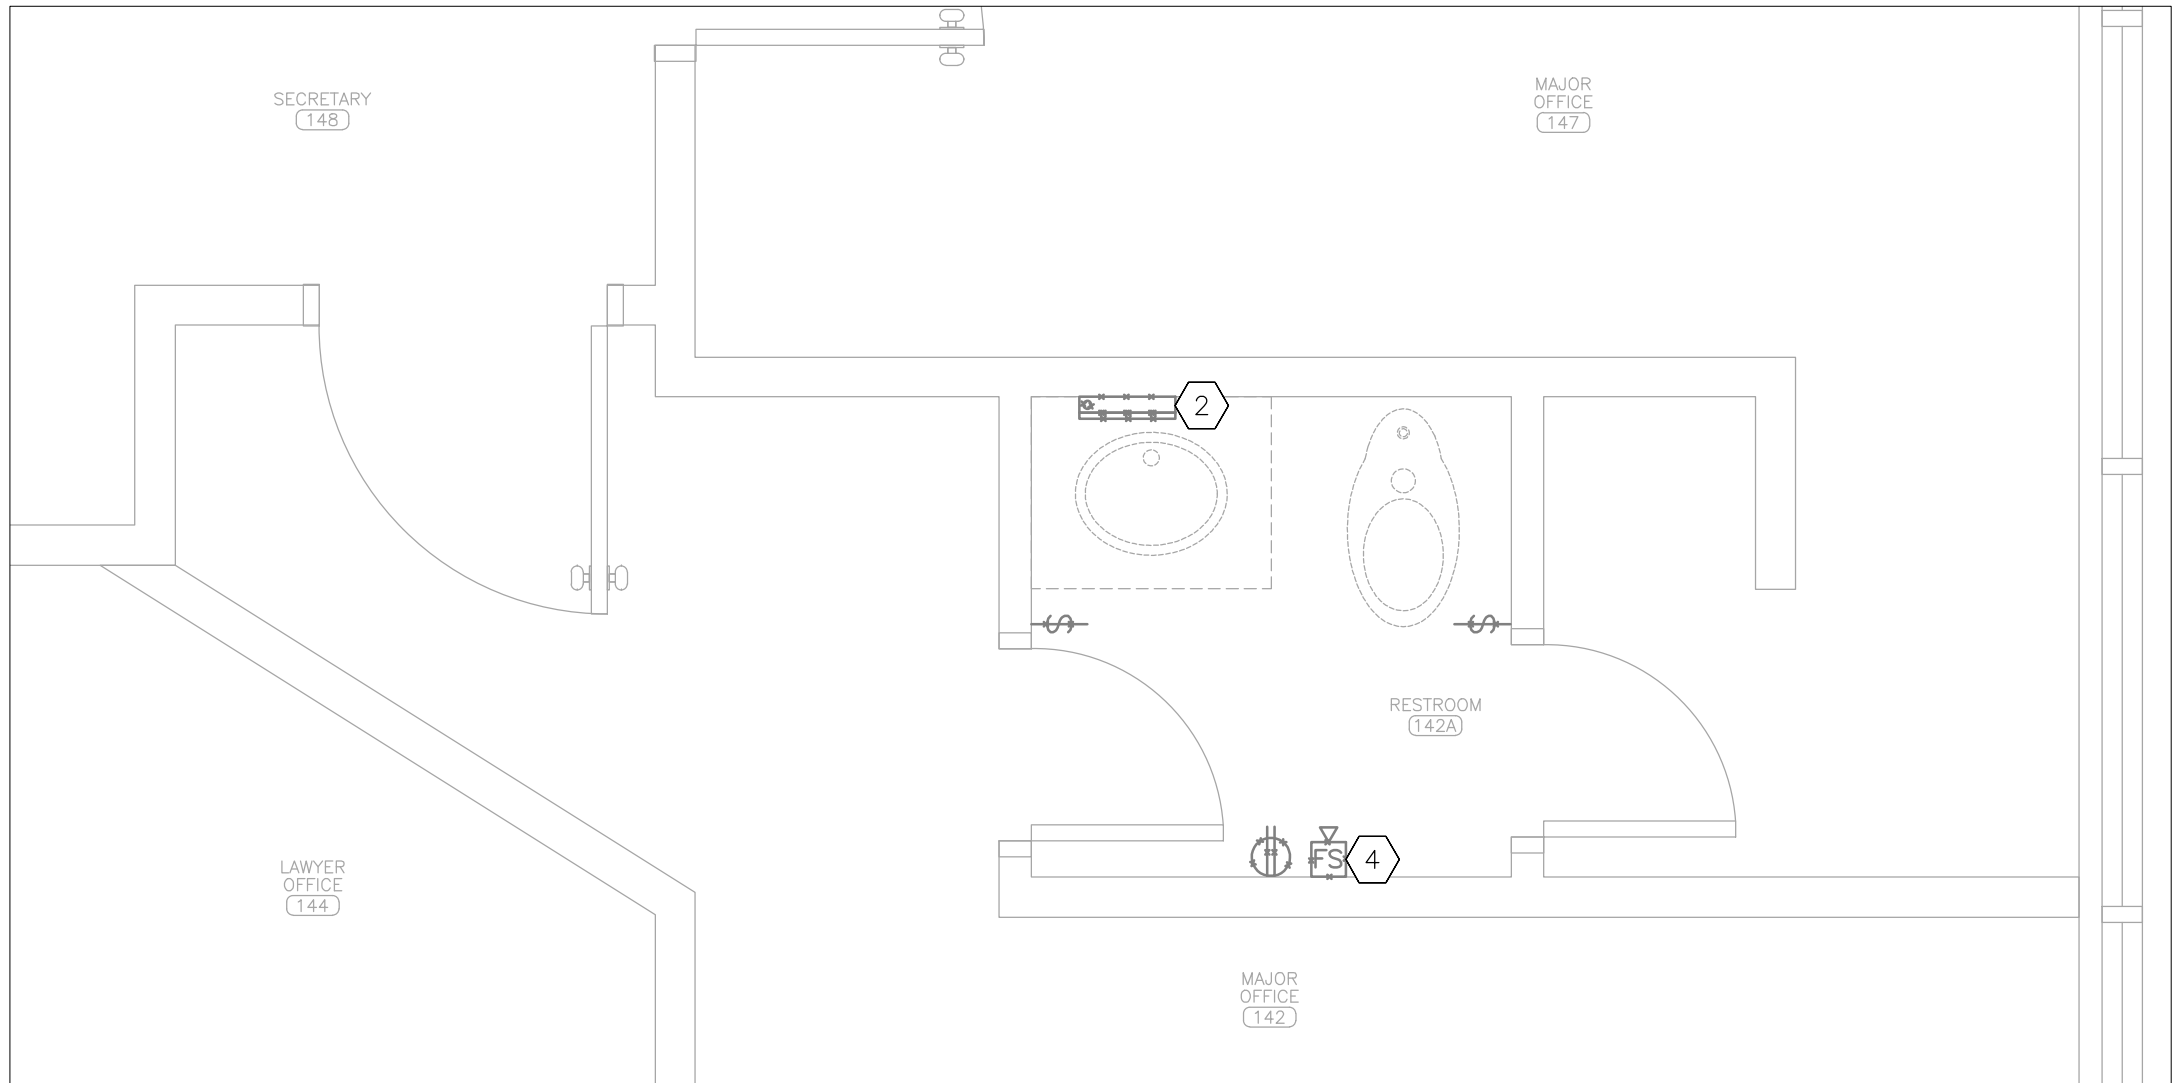

2 ELECTRICAL DEMOLITION PLAN – PARTIAL FIRST FLOOR
SCALE: 1/2" = 1'-0"

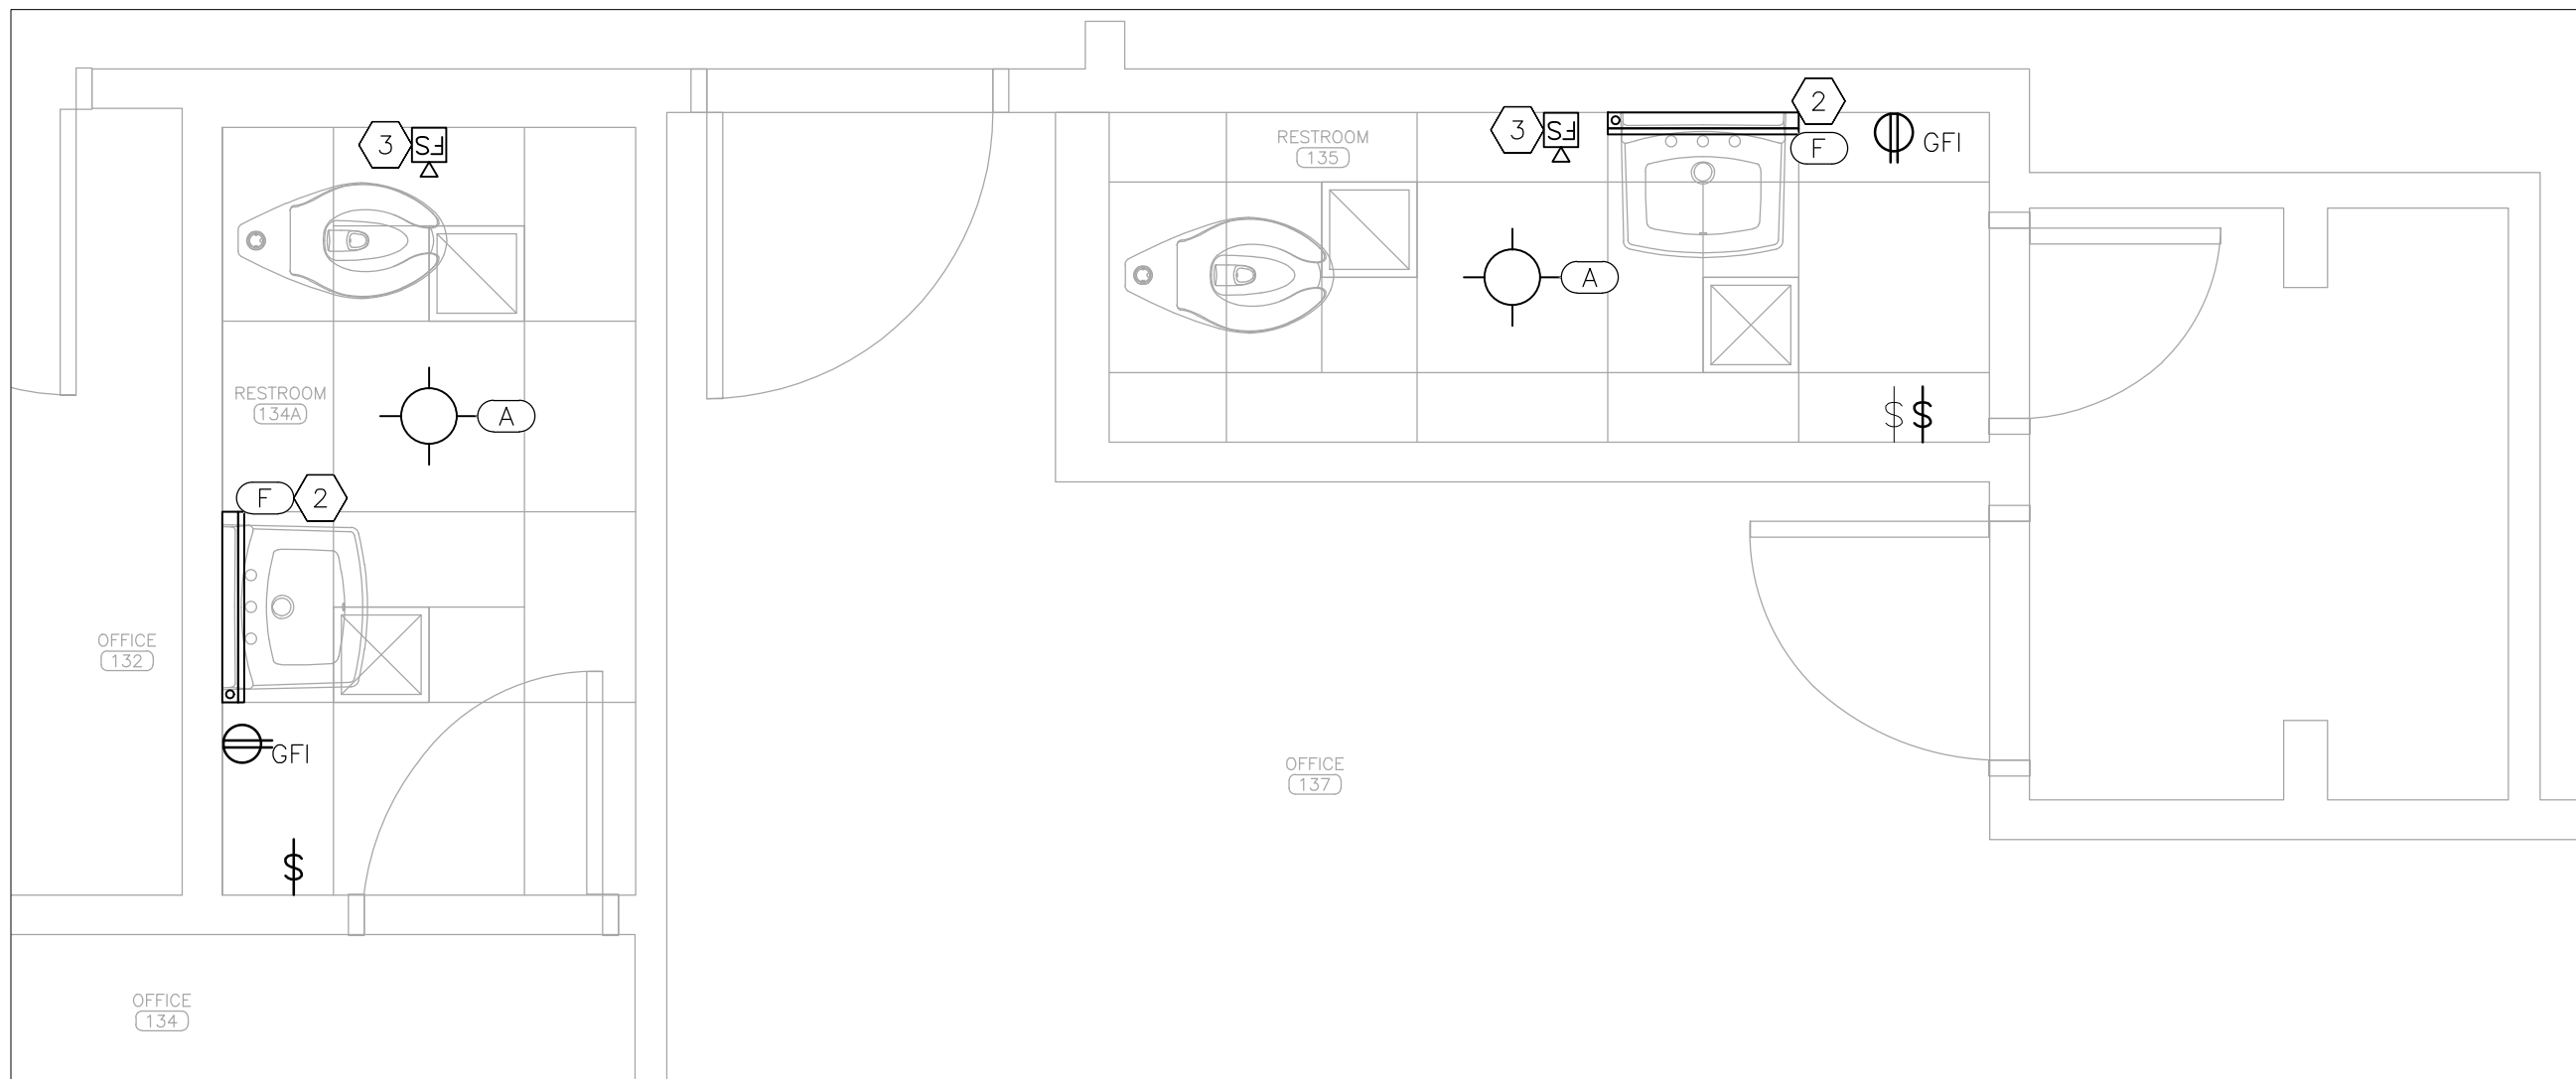

3 ELECTRICAL RENOVATION PLAN – PARTIAL FIRST FLOOR
SCALE: 1/2" = 1'-0"

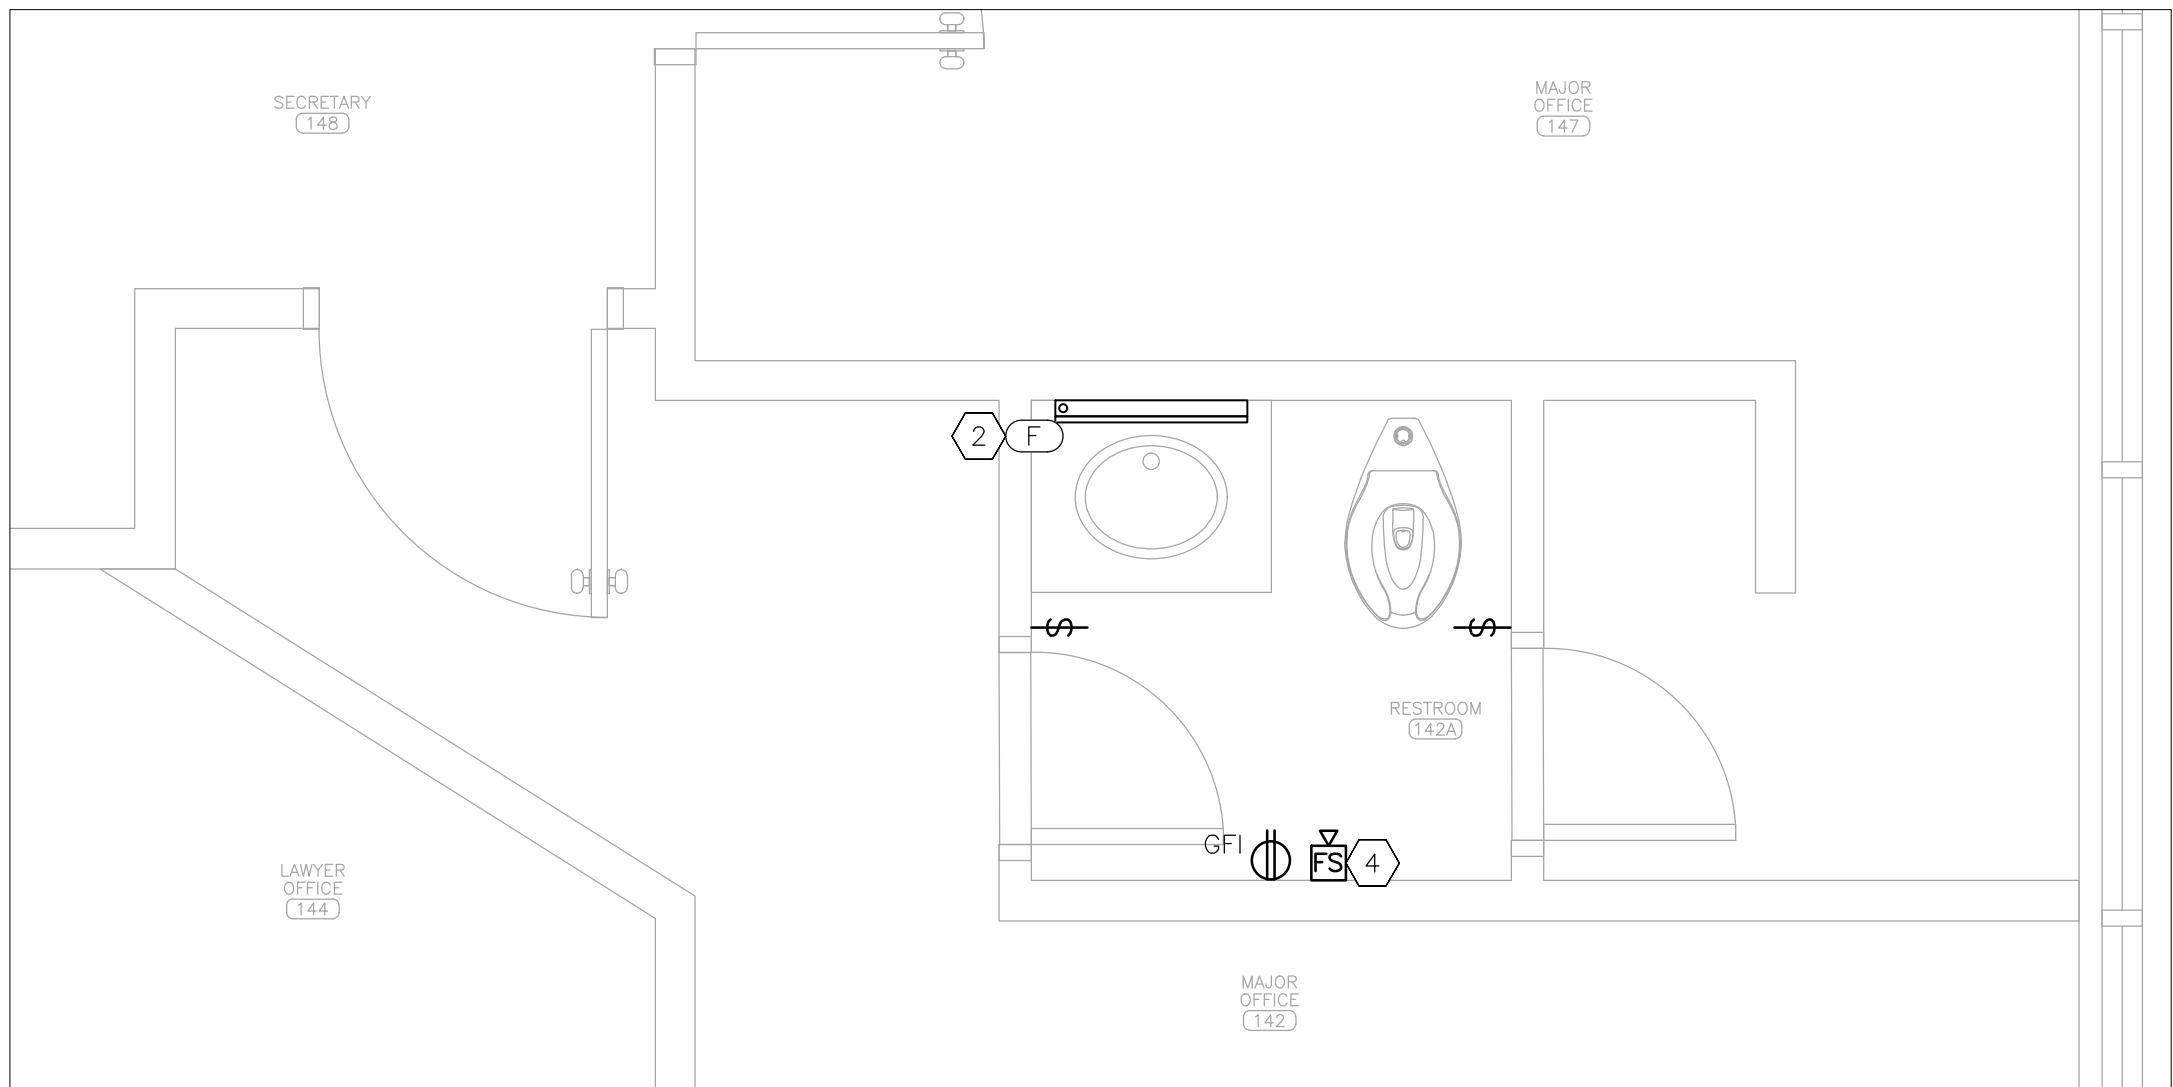

4 ELECTRICAL RENOVATION PLAN – PARTIAL FIRST FLOOR
SCALE: 1/2" = 1'-0"

LIGHTING FIXTURE SCHEDULE							
MARK	MANUFACTURER	MODEL	DESCRIPTION	SIZE	LUMENS TYPE/CRI	WATTS VOLTAGE	NOTES
A	HE WILLIAMS	6FDR-LS/8CS-CS-DIM-UNV	ROUND DOWNLIGHT LED	6"Ø	1055 3500°K, LED/80	9.1 120/277	1,2
B	HE WILLIAMS	BP-22-LS/8CS-DIM-UNV	BACKLIT FLAT PANEL LED	2'x2'	2443 3500°K, LED/80	20.1 120/277	1,3
C	HE WILLIAMS	LRX3F-6-L4/835-DMA-DIM-UNV	LINEAR RECESSED LED	6'	2556 3500°K, LED/80	22.2 120/277	3
D	HE WILLIAMS	LRX3F-4-L4/835-DMA-DIM-UNV	LINEAR RECESSED LED	4'	1704 3500°K, LED/80	14.8 120/277	3
E	HE WILLIAMS	AX2WD-4-L33/835-S-DIM-UNV	WALL MOUNT ARCHITECTURAL LED	4'	3248 3500°K, LED/80	41.6 120/277	4
F	HE WILLIAMS	AX2WD-2-L16/835-S-DIM-UNV	WALL MOUNT ARCHITECTURAL LED	2'	1600 3500°K, LED/80	20.5 120/277	4
NOTES							
1	PROVIDE SWITCHABLE LUMENS AND CCT						
2	PROVIDE NEW CONSTRUCTION MOUNTING PAN MODEL 6FDR-N-F1						
3	PROVIDE WHITE FINISH						
4	FINISH TO BE SELECTED BY ARCHITECT						


ALTERNATE NO. 2

DEMOLITION NOTES – DETAIL 1


- 1
- 2
- 3
- INDICATES KEYED NOTES
- REFER TO SHEET E-101 FOR GENERAL DEMOLITION NOTES.
- DEMOLISH LIGHT FIXTURE. DEMOLISH ASSOCIATED CONDUIT AND CONDUCTORS TO NEAREST JUNCTION BOX FOR USE IN NEW CONSTRUCTION.
- REMOVE AND RETAIN WALL MOUNTED FIRE STROBE. DEMOLISH SURFACE MOUNT JUNCTION BOX AND ASSOCIATED SURFACE MOUNT RACEWAY. DEMOLISH CONDUCTORS TO ABOVE CEILING FOR USE IN NEW CONSTRUCTION.

RENOVATION NOTES – DETAIL 2

- 1
- 2
- 3
- INDICATES KEYED NOTES
- REFER TO SHEET E-101 FOR GENERAL RENOVATION NOTES.
- PROVIDE AND INSTALL WALL MOUNTED LIGHT FIXTURE ON EXISTING WALL. EXTEND CONDUIT AND CONDUCTORS FROM ROOM LIGHTING CIRCUIT TO LIGHT FIXTURE. REFER TO ARCHITECTURAL ELEVATIONS FOR FINAL LOCATION.
- INSTALL RETAINED WALL MOUNT FIRE STROBE. PROVIDE NEW SURFACE RACEWAY AND JUNCTION BOX.

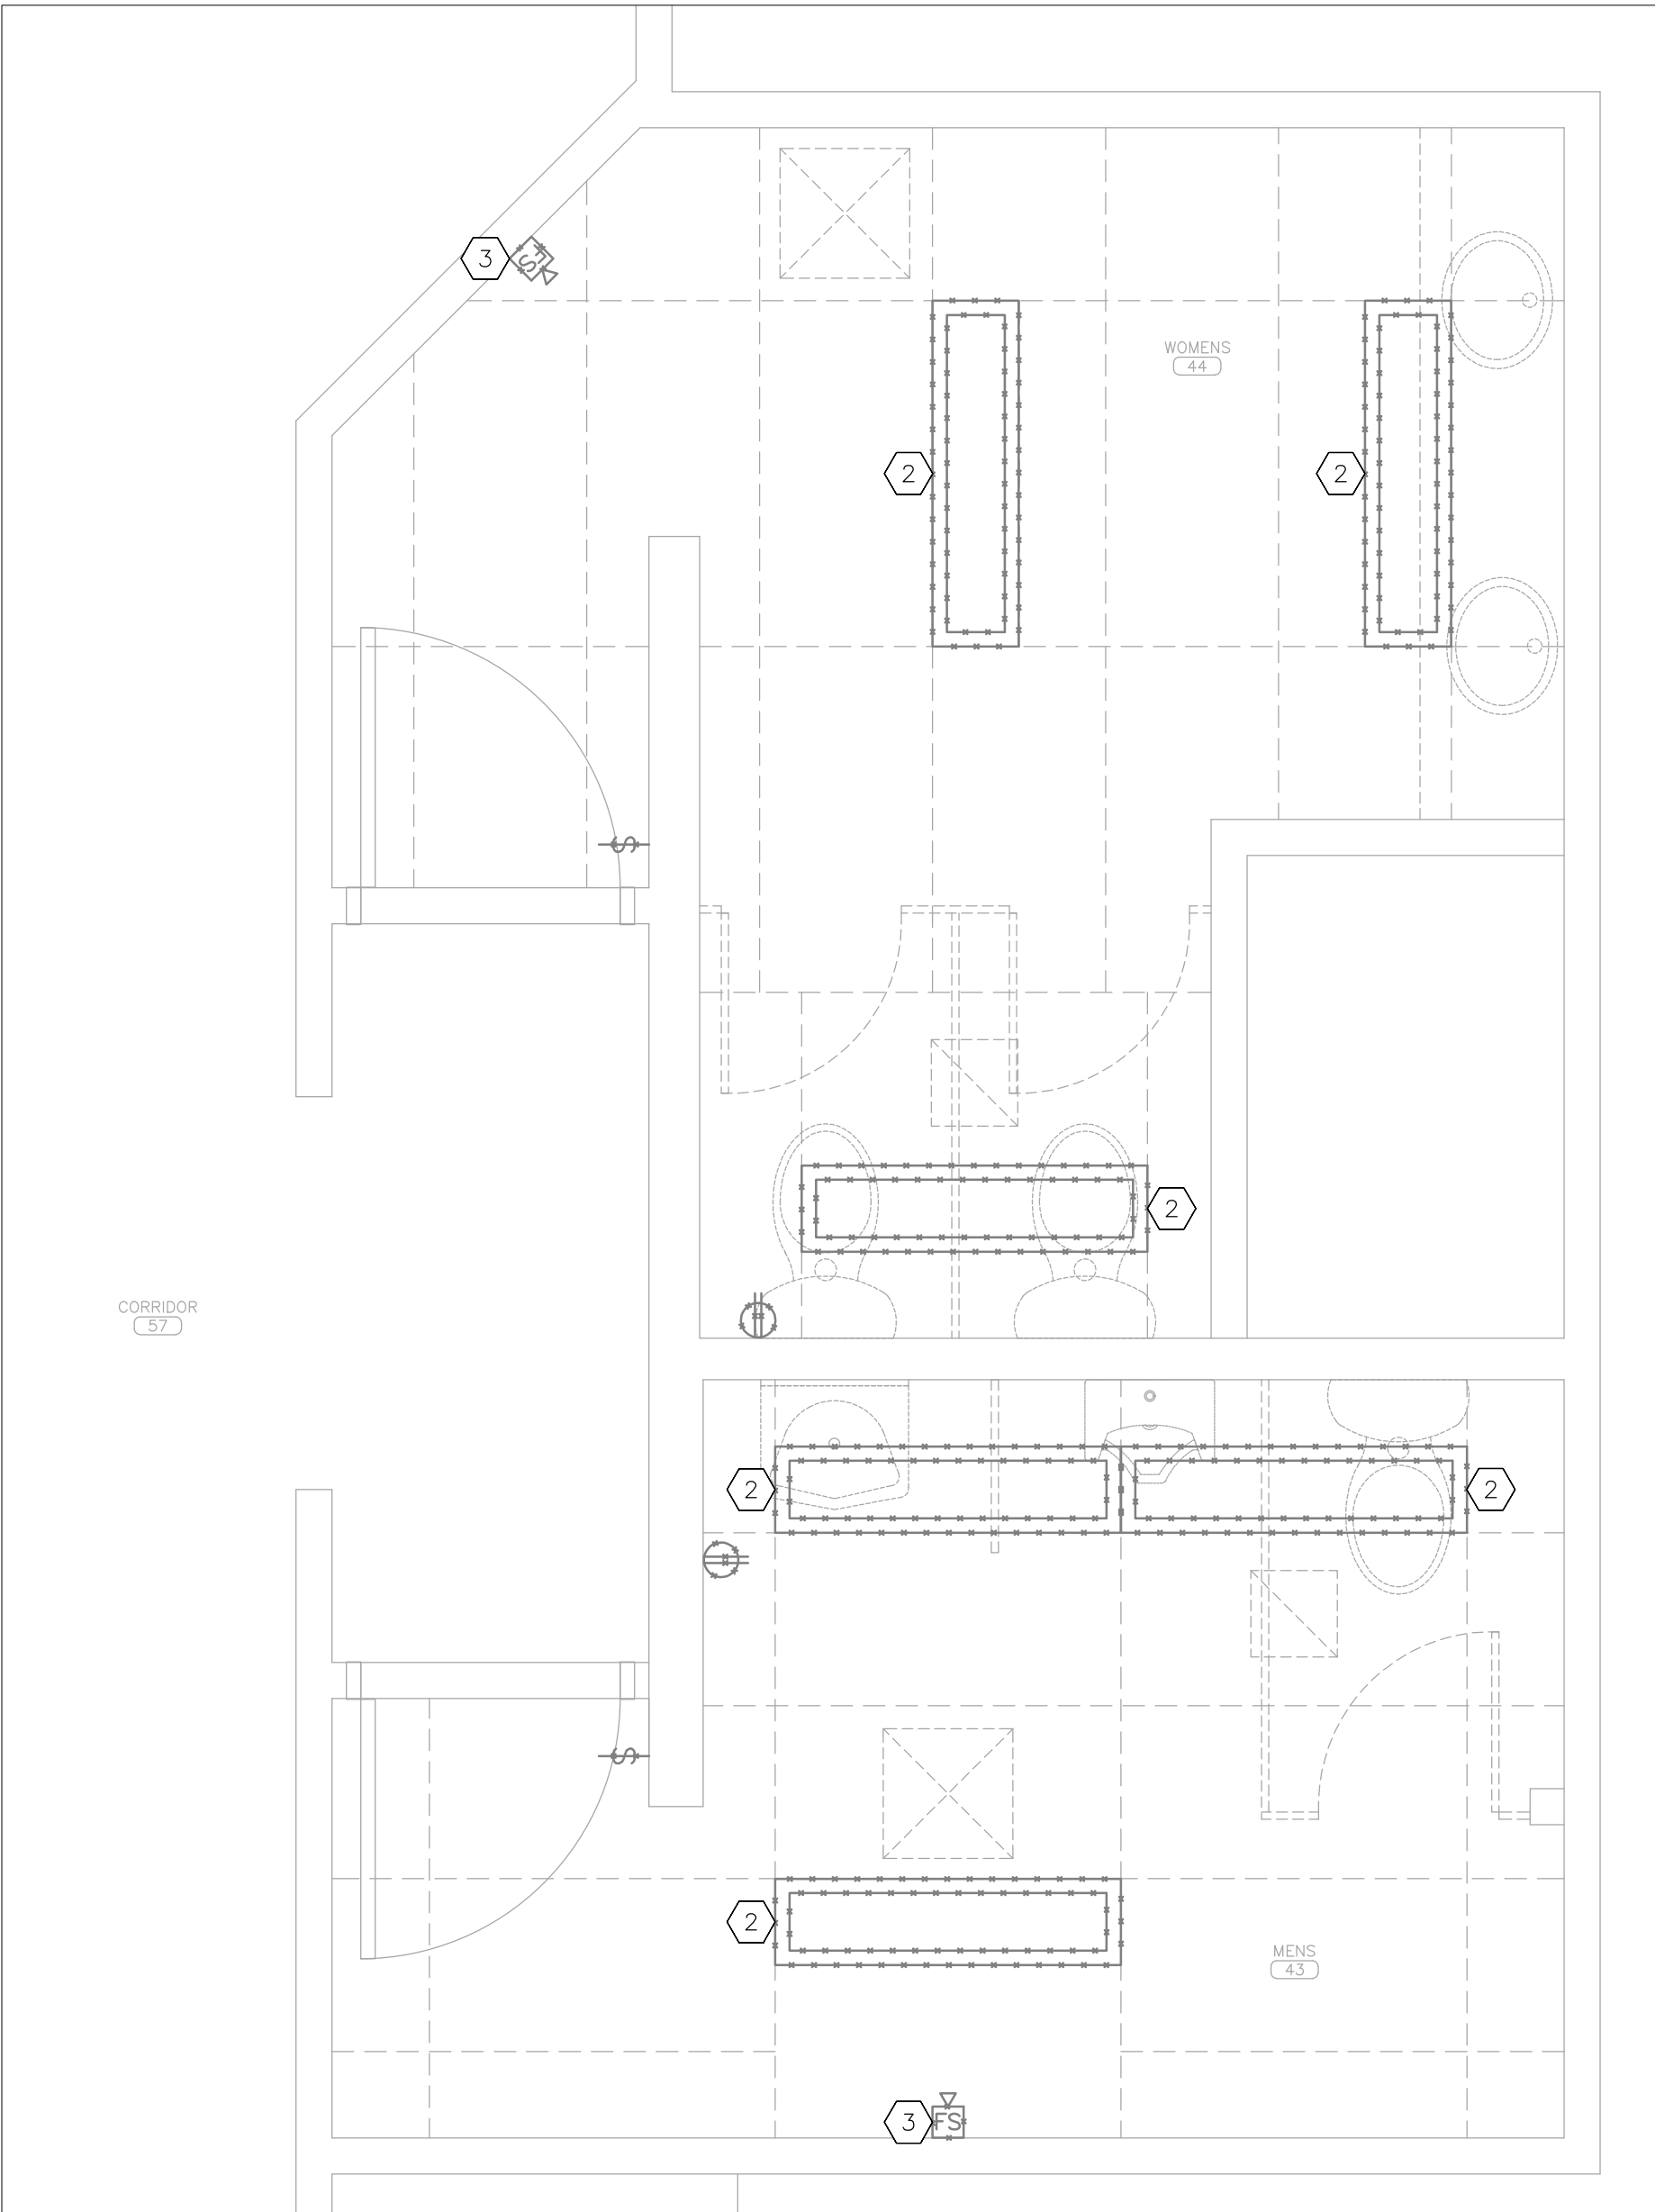


1 ALTERNATE NO. 2 – ELECTRICAL DEMOLITION PLAN – PARTIAL SECOND FLOOR
SCALE: 1/2" = 1'-0"

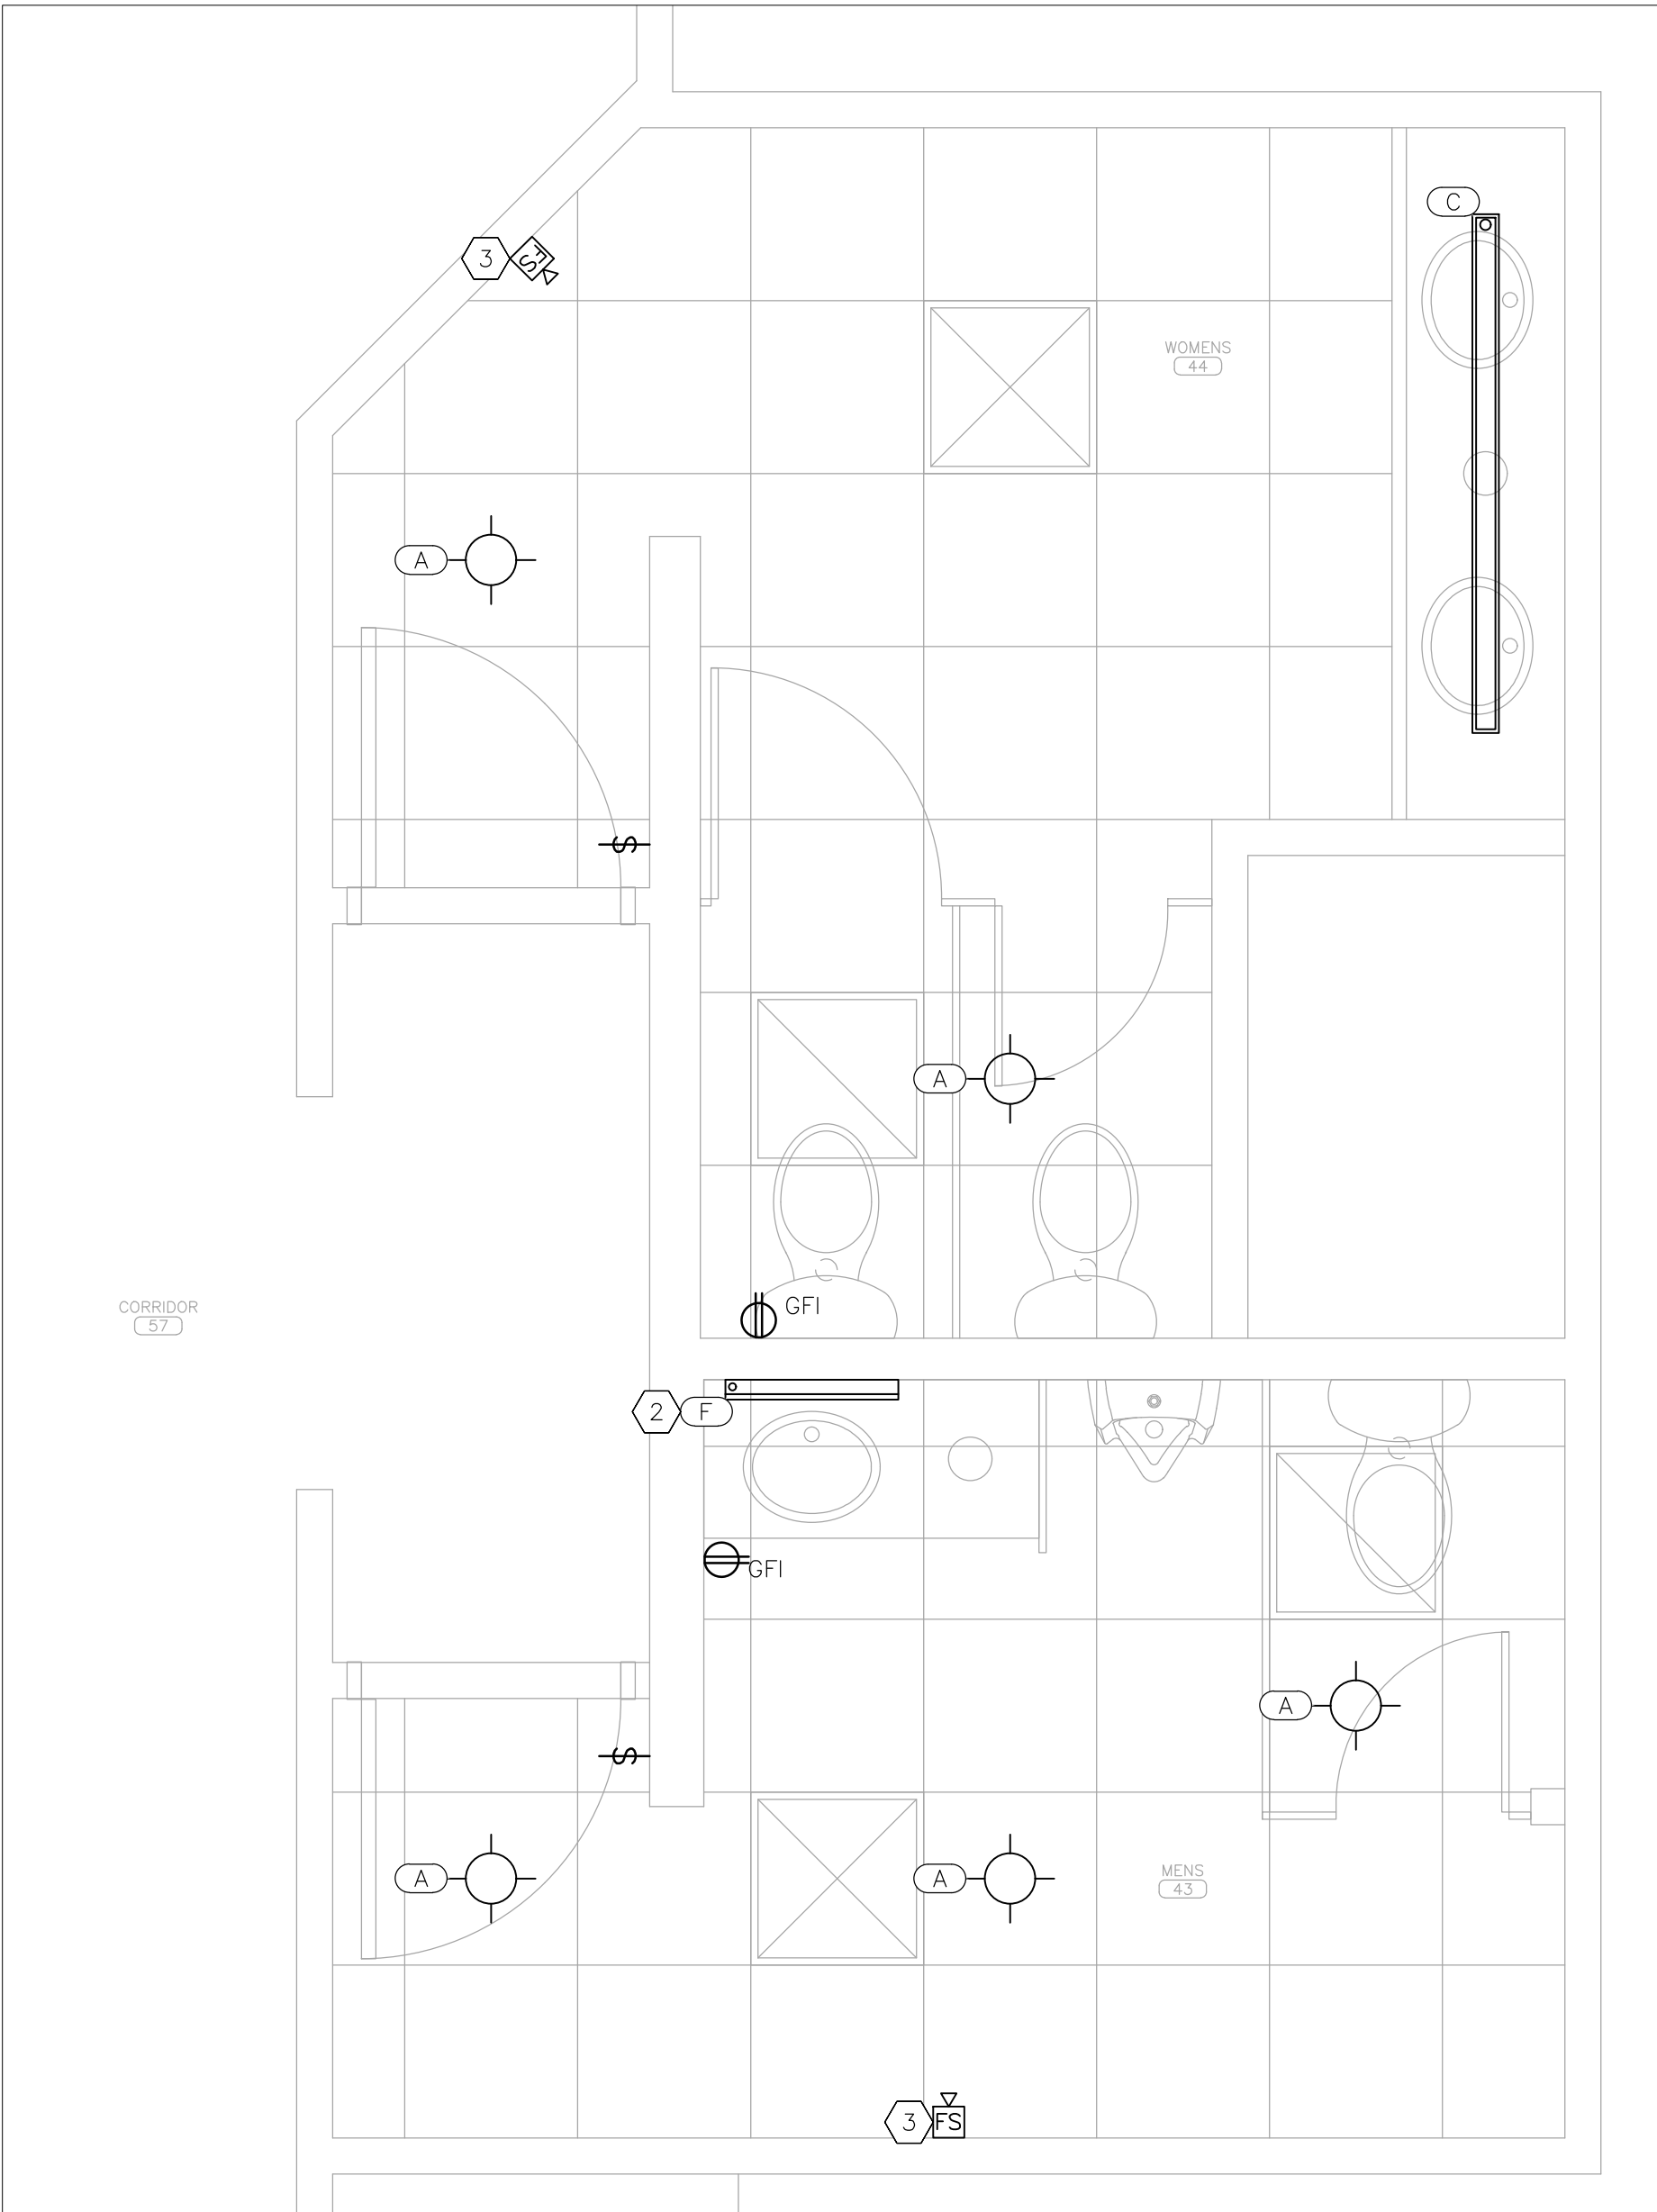

2 ALTERNATE NO. 2 – ELECTRICAL RENOVATION PLAN – PARTIAL SECOND FLOOR
SCALE: 1/2" = 1'-0"

ELECTRICAL LEGEND	
AA	LIGHT FIXTURE MARK
GFI	RECEPTACLE – TYPE: DUPLEX – GROUND FAULT INTERRUPTING
	RECEPTACLE – TYPE: DUPLEX
\$	WALL SWITCH
FS	FIRE ALARM STROBE – WALL MOUNTED
—	ELECTRICAL DEVICE – NEW
---	ELECTRICAL DEVICE – EXISTING
---	LIGHT FIXTURE – NEW
----	EXISTING MATERIALS TO BE REMOVED
⊠	SUPPLY AIR GRILLE
⊞	EXHAUST AIR GRILLE

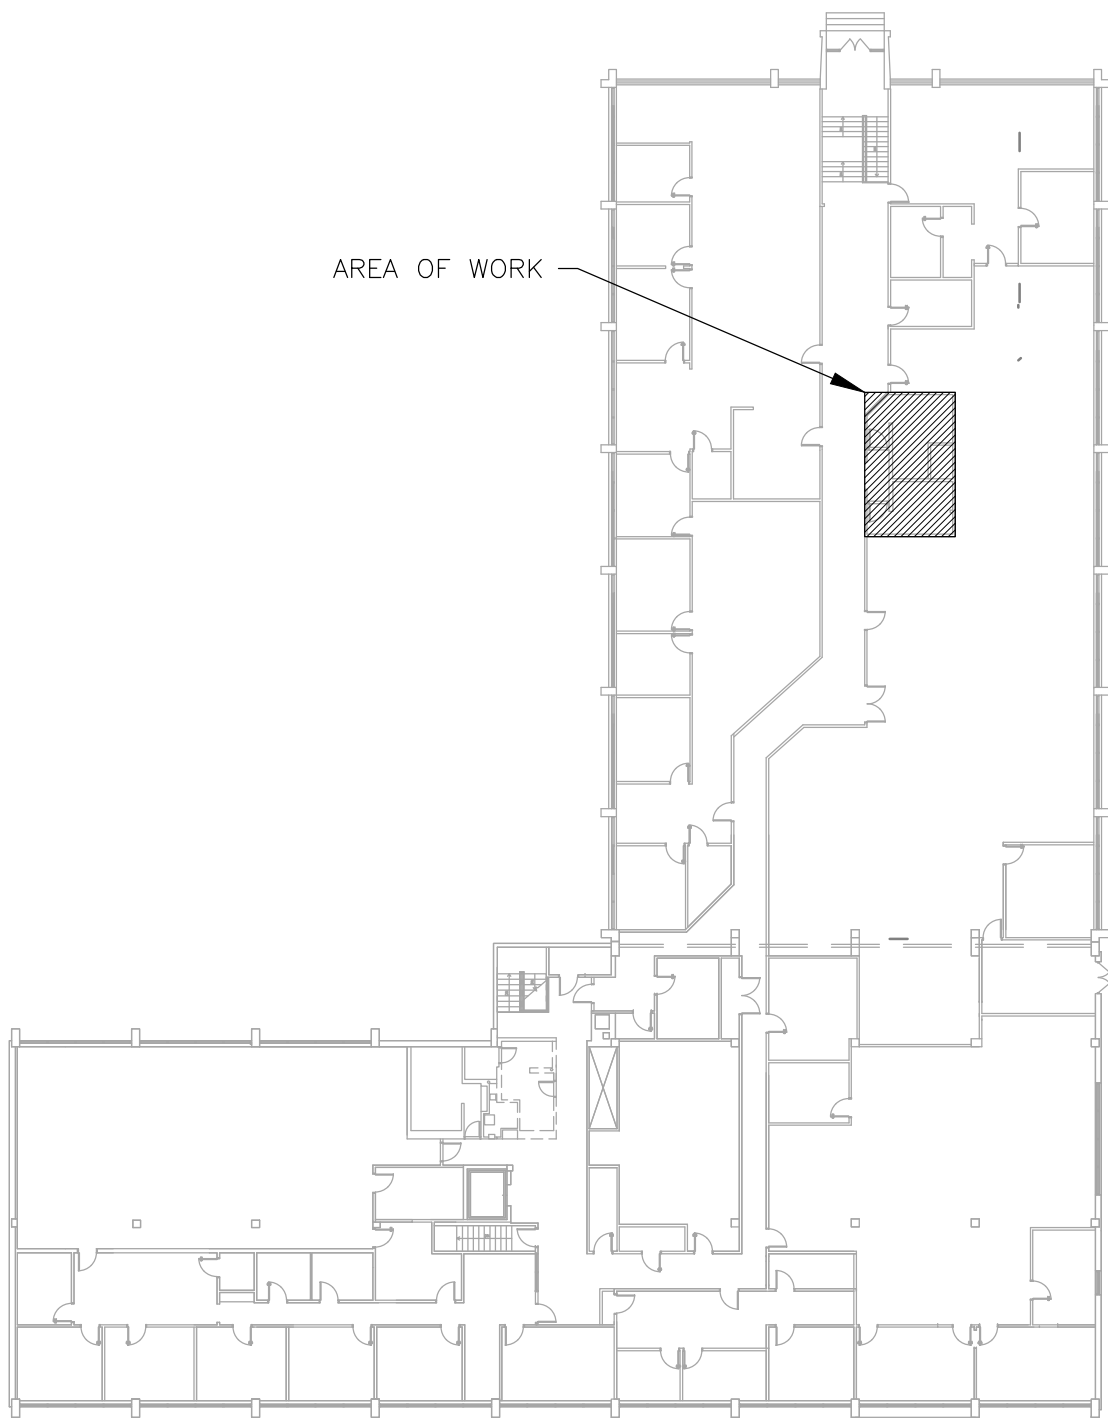

3 AREA MAP – SECOND FLOOR

STATE OF MISSOURI
MIKE KEHOE,
GOVERNOR



Tracie L. Siebeneck - Engineer
MO# PE-2013019114

BID
DOCUMENTS

OFFICE OF ADMINISTRATION
DIVISION OF FACILITIES
MANAGEMENT,
DESIGN AND CONSTRUCTION

DEPARTMENT OF
PUBLIC SAFETY
STATE HIGHWAY PATROL

RENOVATE INTERIOR

GENERAL HEADQUARTERS
1510 EAST ELM STREET
JEFFERSON CITY, MO 65101

PROJECT # R2410-01
SITE # 6001
ASSET # 8136001001

REVISION: _____
DATE: _____
REVISION: _____
DATE: _____
REVISION: _____
DATE: _____
ISSUE DATE: 06/18/2026

CAD DWG FILE: E_R2410-01
DRAWN BY: TS/AH
CHECKED BY: TS
DESIGNED BY: TS/AH

SHEET TITLE:
PARTIAL
ELECTRICAL PLAN
SECOND FLOOR

SHEET NUMBER:

E-106

39 OF 39 SHEETS
06/18/2026